



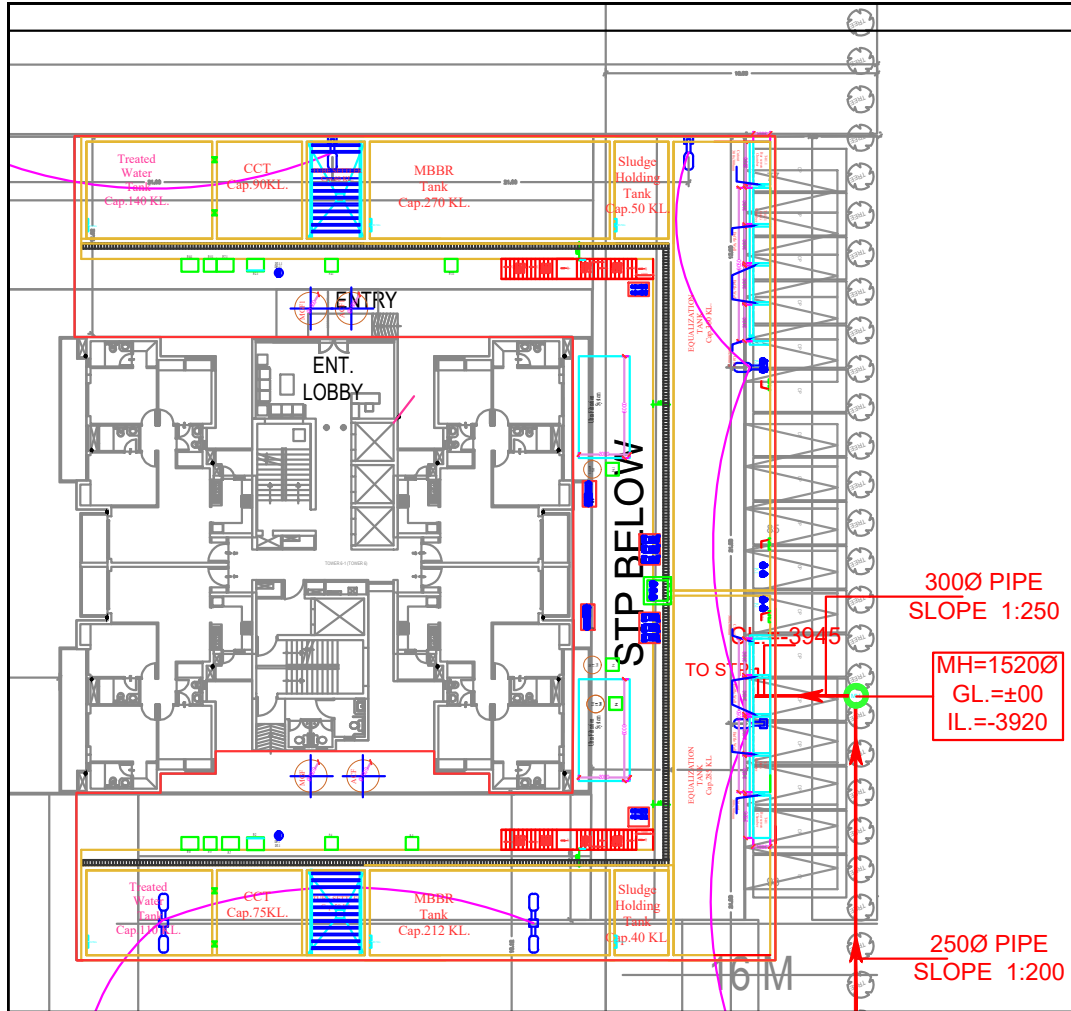

STP LAYOUT

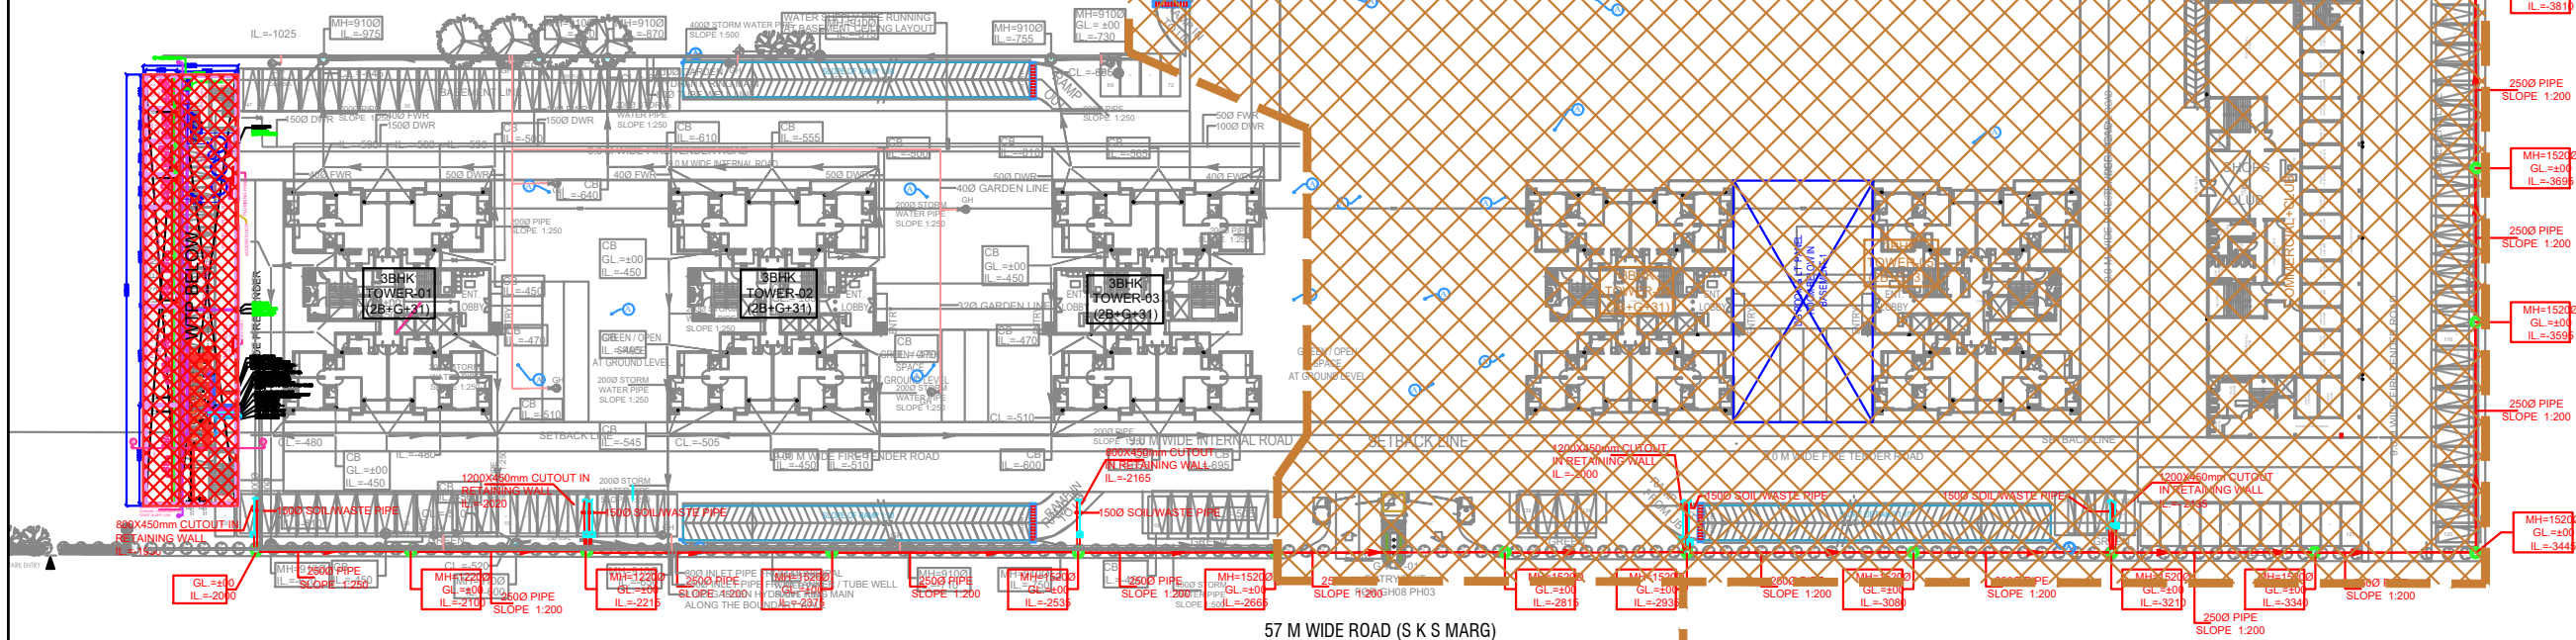

LEGEND


- GARDEN HYDRANT
- GARDEN HYDRANT PIPE
- TUBE WELL
- MUNICIPAL LINE
- TUBEWELL LINE
- FLUSHING WATER RISER
- DOMESTIC WATER RISER

Architect :
Wave Infratech Pvt. Ltd.
C-1, Sector-3
Noida, U.P. 201301
TEL: +91 120 4180500



Structure Consultant
OPTIMIZATION CONSULTANTS
202 & 203, HIMLAND HOUSE,
KARAMPURA COMMERCIAL COMPLEX,
NEW DELHI-110015
E-mail: optpro34@yahoo.co.in

MEP Consultant
ELECTRO CONSULTANTS
A-222, Shivalik, Malviya Nagar,
New Delhi- 110017
PH: (011)26684140, 26688712
email: electroconsultants@gmail.com

Landscape Consultant
AECOM

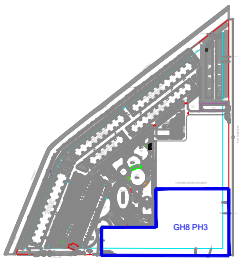

OWNER UPPAL CHADHA HITECH DEVELOPERS PVT. LTD.			
PROJECT EDEN (GH08-PH03, WAVE CITY)			
REV NO			
DESCRIPTION			
DATE			
TITLE SITE PLAN SEWERAGE SYSTEM LAYOUT			
DRAWN CDS	REV BHWANK	PURPOSE SUBMISSION	REV. NO. R0
SCALE 1:500/8A1	DATE 24.05.2024	DRAWING NO. EDEN/GH08-PH03/SITE/PL/SW-03	

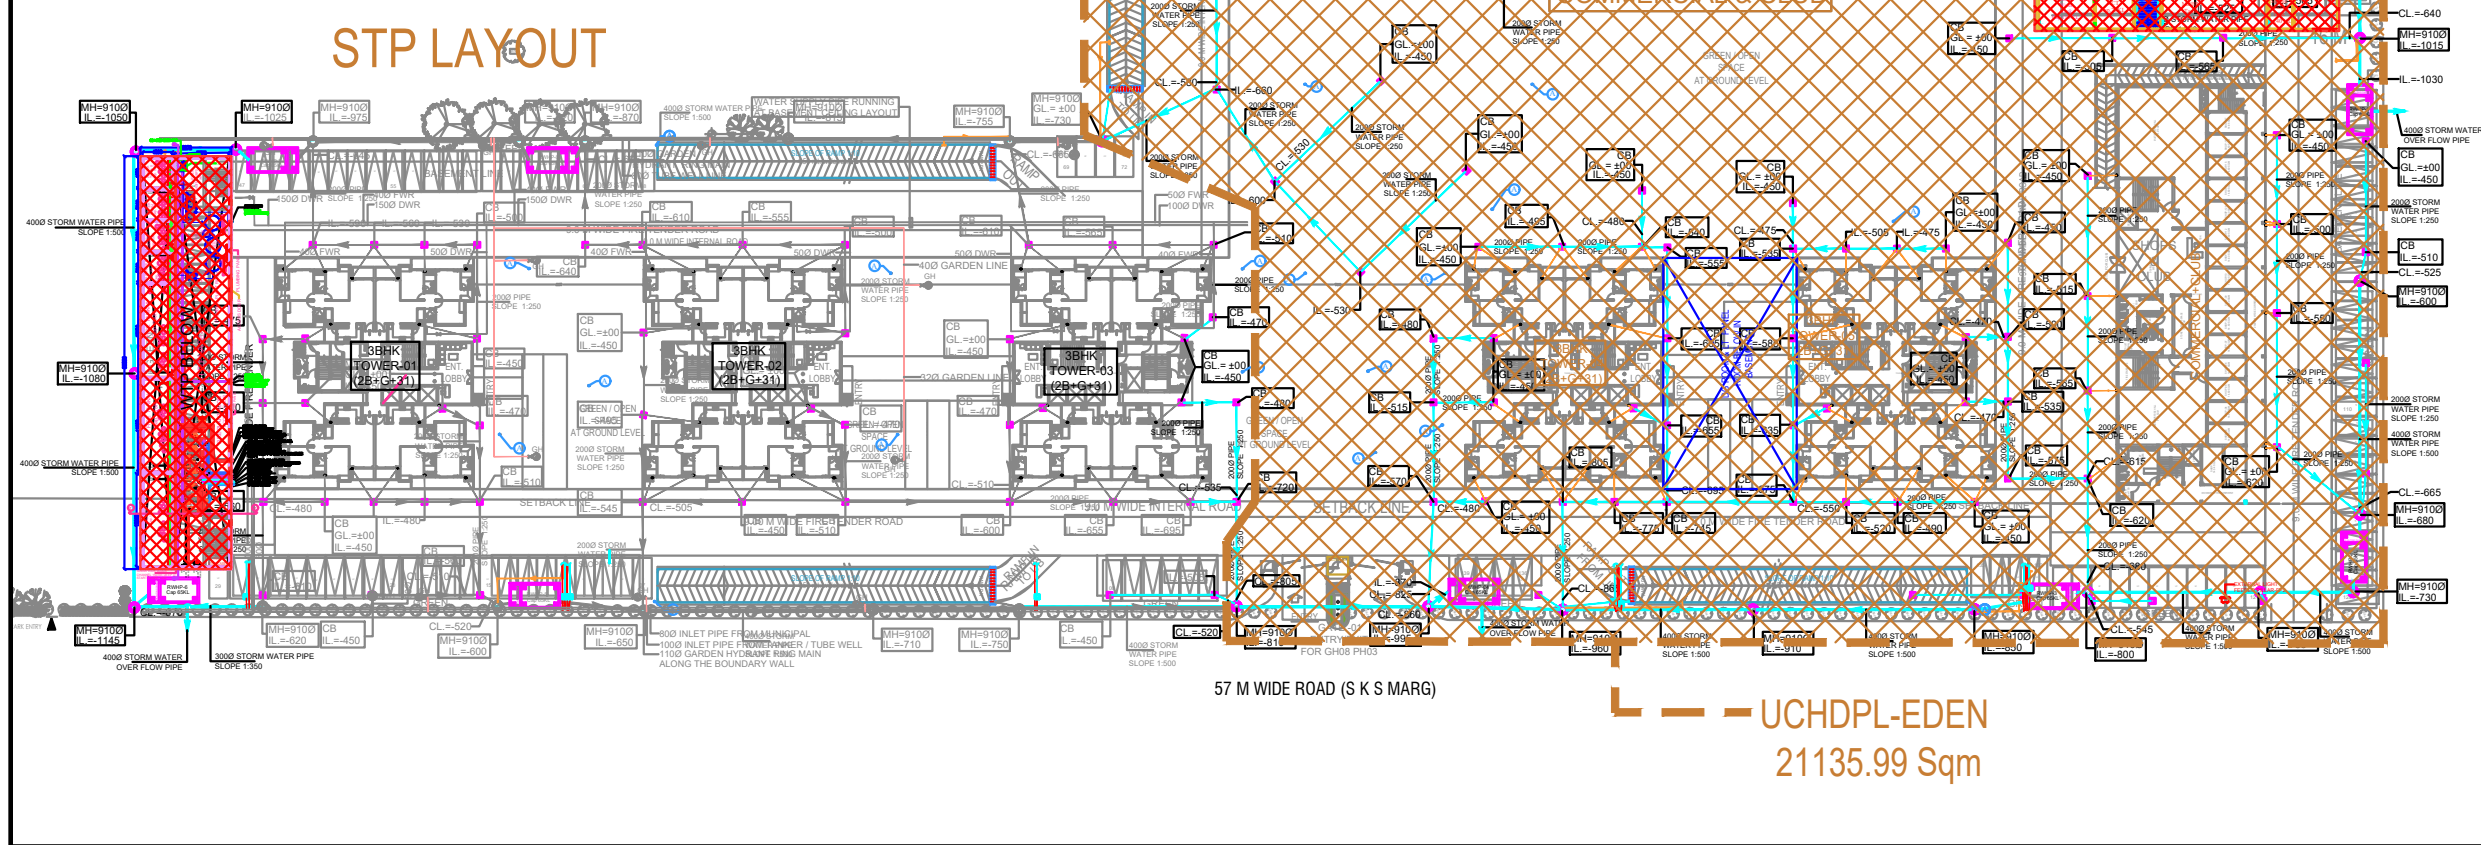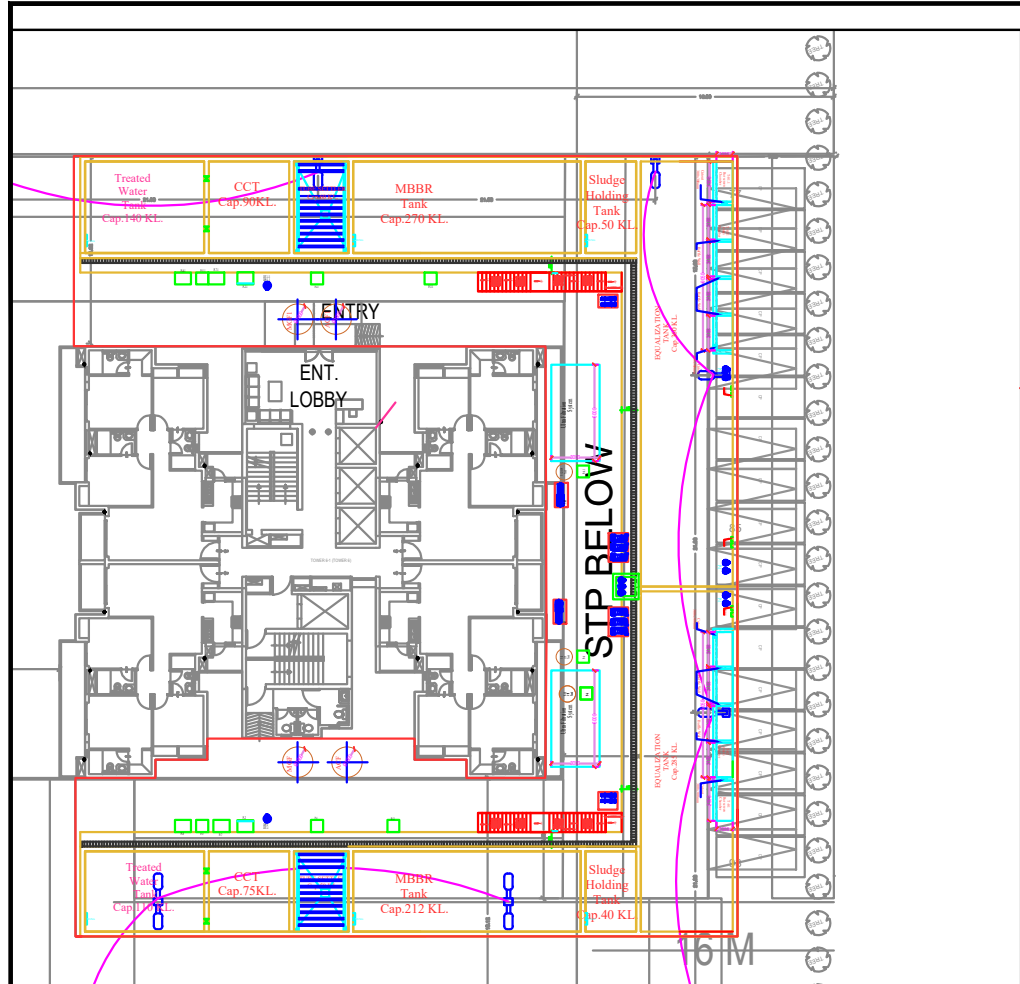

LEGEND

GARDEN HYDRANT		GH
GARDEN HYDRANT PIPE		
TUBE WELL		TW-1
MUNICIPAL LINE		
TUBEWELL LINE		
FLUSHING WATER RISER		
DOMESTIC WATER RISER		

Architect :

Wave Infratech Pvt. Ltd.
C-1, Sector-3
Noida, U.P. 201301
TEL: +91 120 4180500

Structure Consultant


OPTIMIZATION CONSULTANTS
202 & 203, HIMLAND HOUSE,
KARAMPURA COMMERCIAL COMPLEX,
NEW DELHI-110015
E-mail: optpro34@yahoo.com

MEP Consultant

ELECTRO CONSULTANTS
A-222, Shivalik, Malviya Nagar,
New Delhi-110017
PH: (011)26684140, 26688712
email: electroconsultants@gmail.com

Landscape Consultant

AECOM

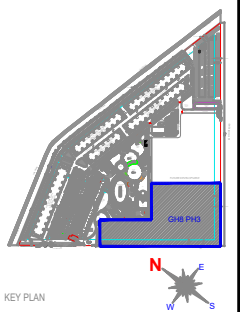

KEY PLAN

OWNER
UPPAL CHADHA HITECH DEVELOPERS
PVT. LTD.

PROJECT
EDEN (GH08-PH03, WAVE CITY)

REV. NO. DESCRIPTION DATE

TITLE
SITE PLAN
STORM WATER SYSTEM LAYOUT

DRAWN DEV PURPOSE REV. NO.

DATE 24.05.2024 SUBMISSION R0

DWG. NO.
EDEN/GH08-PH03/SITE/PL-ST-03