
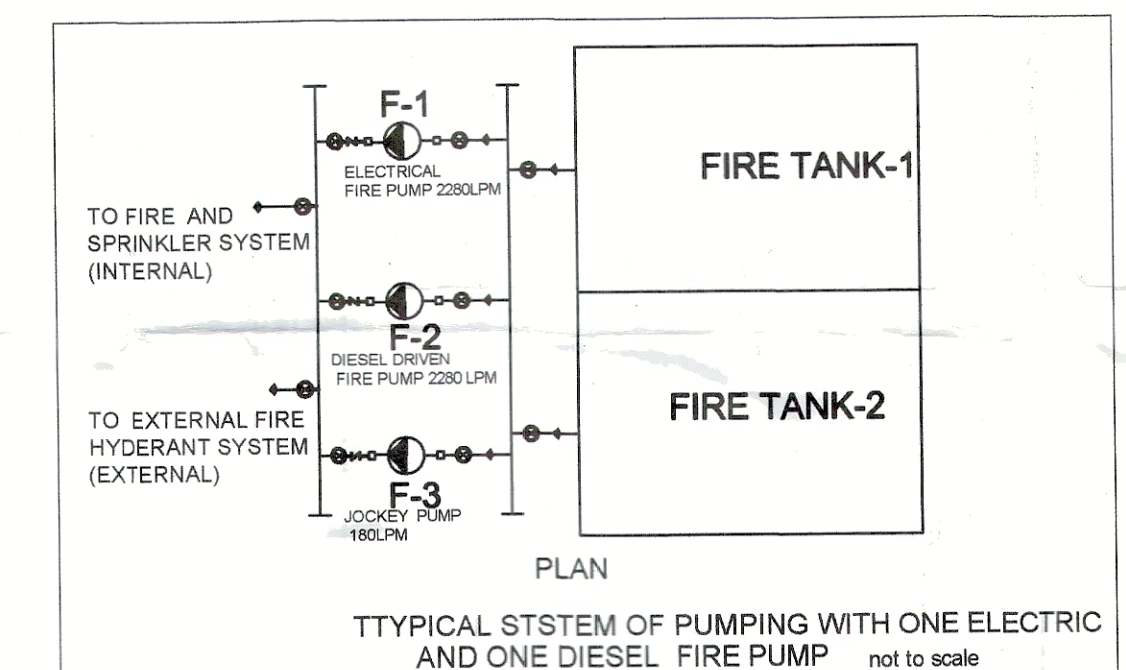
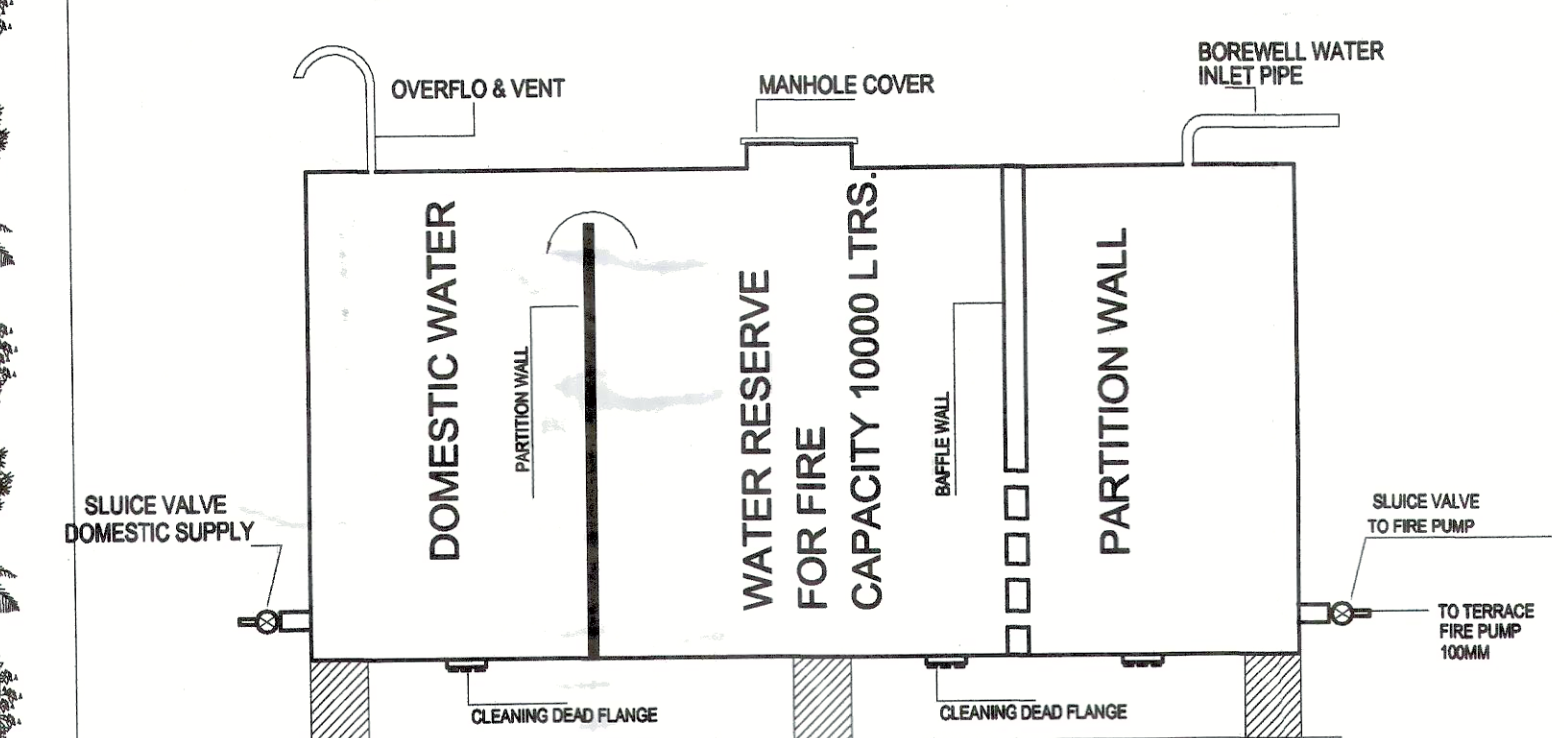


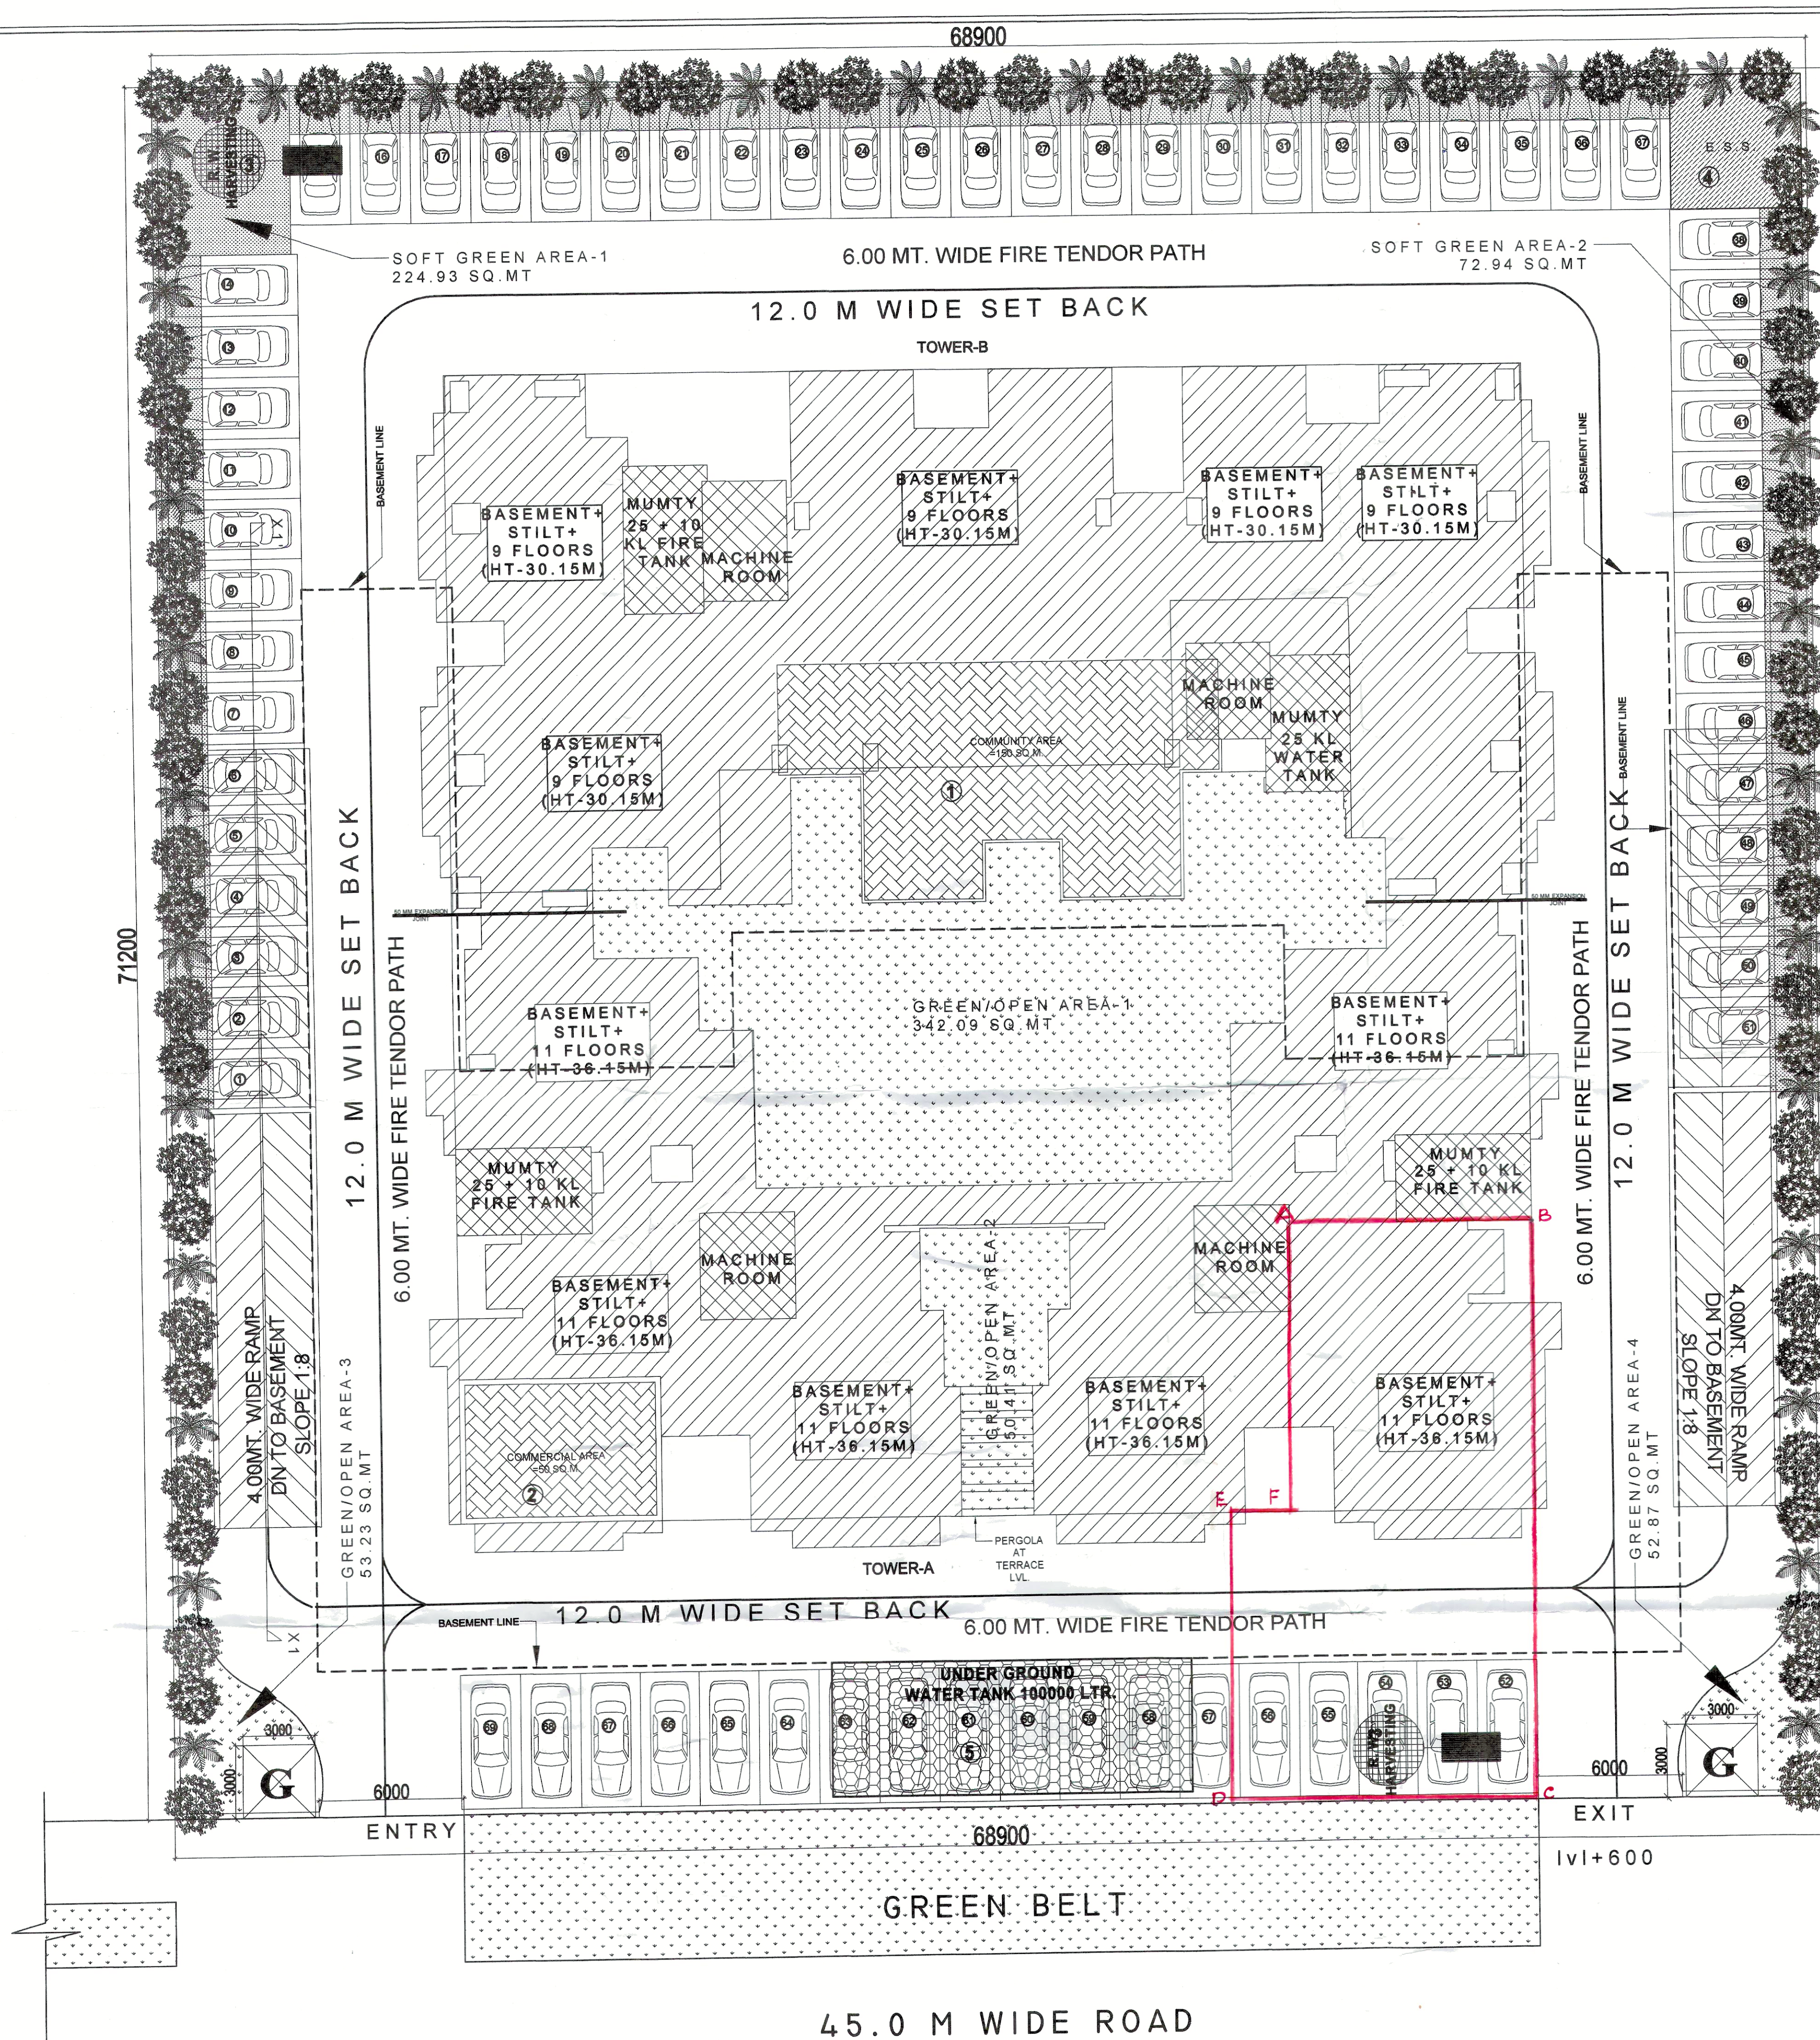

FIRE LEGEND

NO	SYMBOL	DESCRIPTION
1.		FIRE EXTINGUISHER AS PER I.S.-2190-2010
2.		SPRINKLER IN BASEMENT
3.		HOSE REEL 30 METERS
4.		BUTTERFLY VALVE SLUICE VALVE
5.		SURFACE SPRINKLER
6.		DIESEL DRIVEN FIRE PUMP 2280 LPM
7.		ELECTRIC FIRE PUMP 2280 LPM
8.		JOCKEY PUMP 180 LPM
9.	U/G TANK	UNDER GROUND WATER TANK-1, 00,000 LIT CAP RESERVE IN TERRACE
10.	O/H TANK	OVER HEAD (TERRACE) TANK-1, 00,000 LIT CAP RESERVE IN TERRACE wet riser main
11.		
12.	FCD	FIRE CHECK DOOR /2H FIRE RATING
13.		MECHANICAL VENTILATION IN BASEMENT
14.		MCP

**PROPOSED GROUP HOUSING
FOR M/S - SURAT INFRATECH PVT. LTD.
AT PLOT 11/G.H - 4, SECTOR 11,
VRINDAVAN YOJNA NO- 3 LUCKNOW**

- NOTES**
- 1) ALL DIMENSIONS ARE IN MILLIMETRES
 - 2) NO DIMENSION TO BE SCALED FROM THE DRAWINGS
(WRITTEN DIMENSIONS TO BE FOLLOWED)
 - 3) IN CASE OF DISCREPANCIES LARGED SCALE & DETAILED DRAWINGS SHALL SUPERCEDE SMALLER SCALE DRAWINGS & DISCREPANCIES IN THE DRAWINGS ARE TO BE BRINGWENT OUT TO THE NOTICE OF THE ARCHITECT, IT IS GOOT TO BE RECTIFIED BEFORE TENDERING
 - 4) ALL SERVICES DWGS TO BE REFERRED ONLY FOR THE TECHNICAL CONTENTS CO-ORDINATED WORKING DRAWINGS TO BE FOLLOWED FOR ALL WORK AT SITE
 - 5) ALL STRUCTURAL SIZES AND STRUCTURAL DETAILS TO BE REFERRED FROM DRAWINGS OF STRUCTURAL CONSULTANTS.

Spl.notes
All dimensions are in mm.

Legend		
①		PLAM
②		CYCAS REVOLUTA
③		GULMOHAR

TOTAL NO. OF PLANTS REQUIRED =24.52~25
50 PLANTS /HET.(10000 SQ.MT.)
TOTAL NO. OF PLANTS PROPOSED =40

S.NO.	LEGEND-	
①	COMMUNITY SPACE	
②	COMMERCIAL SPACE	
③	RAIN WATER HARVESTING	
④	ELECTRIC SUB STATION	
⑤	UNDER GROUND WATER TANK	

GREEN/OPEN AREA		
S.NO.	PARTICULARS	AREA IN (SQ.MT.)
1	GREEN/OPEN AREA-1	342.09
2	GREEN/OPEN AREA-2	50.41
3	GREEN/OPEN AREA-3	53.23
4	GREEN/OPEN AREA-4	52.87
	TOTAL	498.6

THIS IS TO CERTIFY THAT PROPOSED
BUILDING HAS BEEN PREPARED
ACCORDING TO THE INFORMATION
GIVEN BY THE OWNER AND BUILDING
BYE LAWS & MASTER PLAN 2021.

SITE PLAN	
ARCHITECT	NORTH

REPUNJAY PATEL AVANISH GANGWAR	
-----------------------------------	---

SCALE:	DRAWN BY:	REVISED	DWG. NO.
1 : 150	PRADEEP	R0	01
DATE:	CHKD. BY:	SHEET SIZE:	
	AVANISH	A1	

ARCHITECT :
architect's avenue
D-2/122,Sambhav Tower,Vibhuti Khand,
Gomti Nagar,Lucknow,U.P.

For Surat Infratech Pvt. Ltd.

Validity of Map extended upto 19 May 2025.
The rules, conditions and restrictions stated earlier in map and letter will be same