
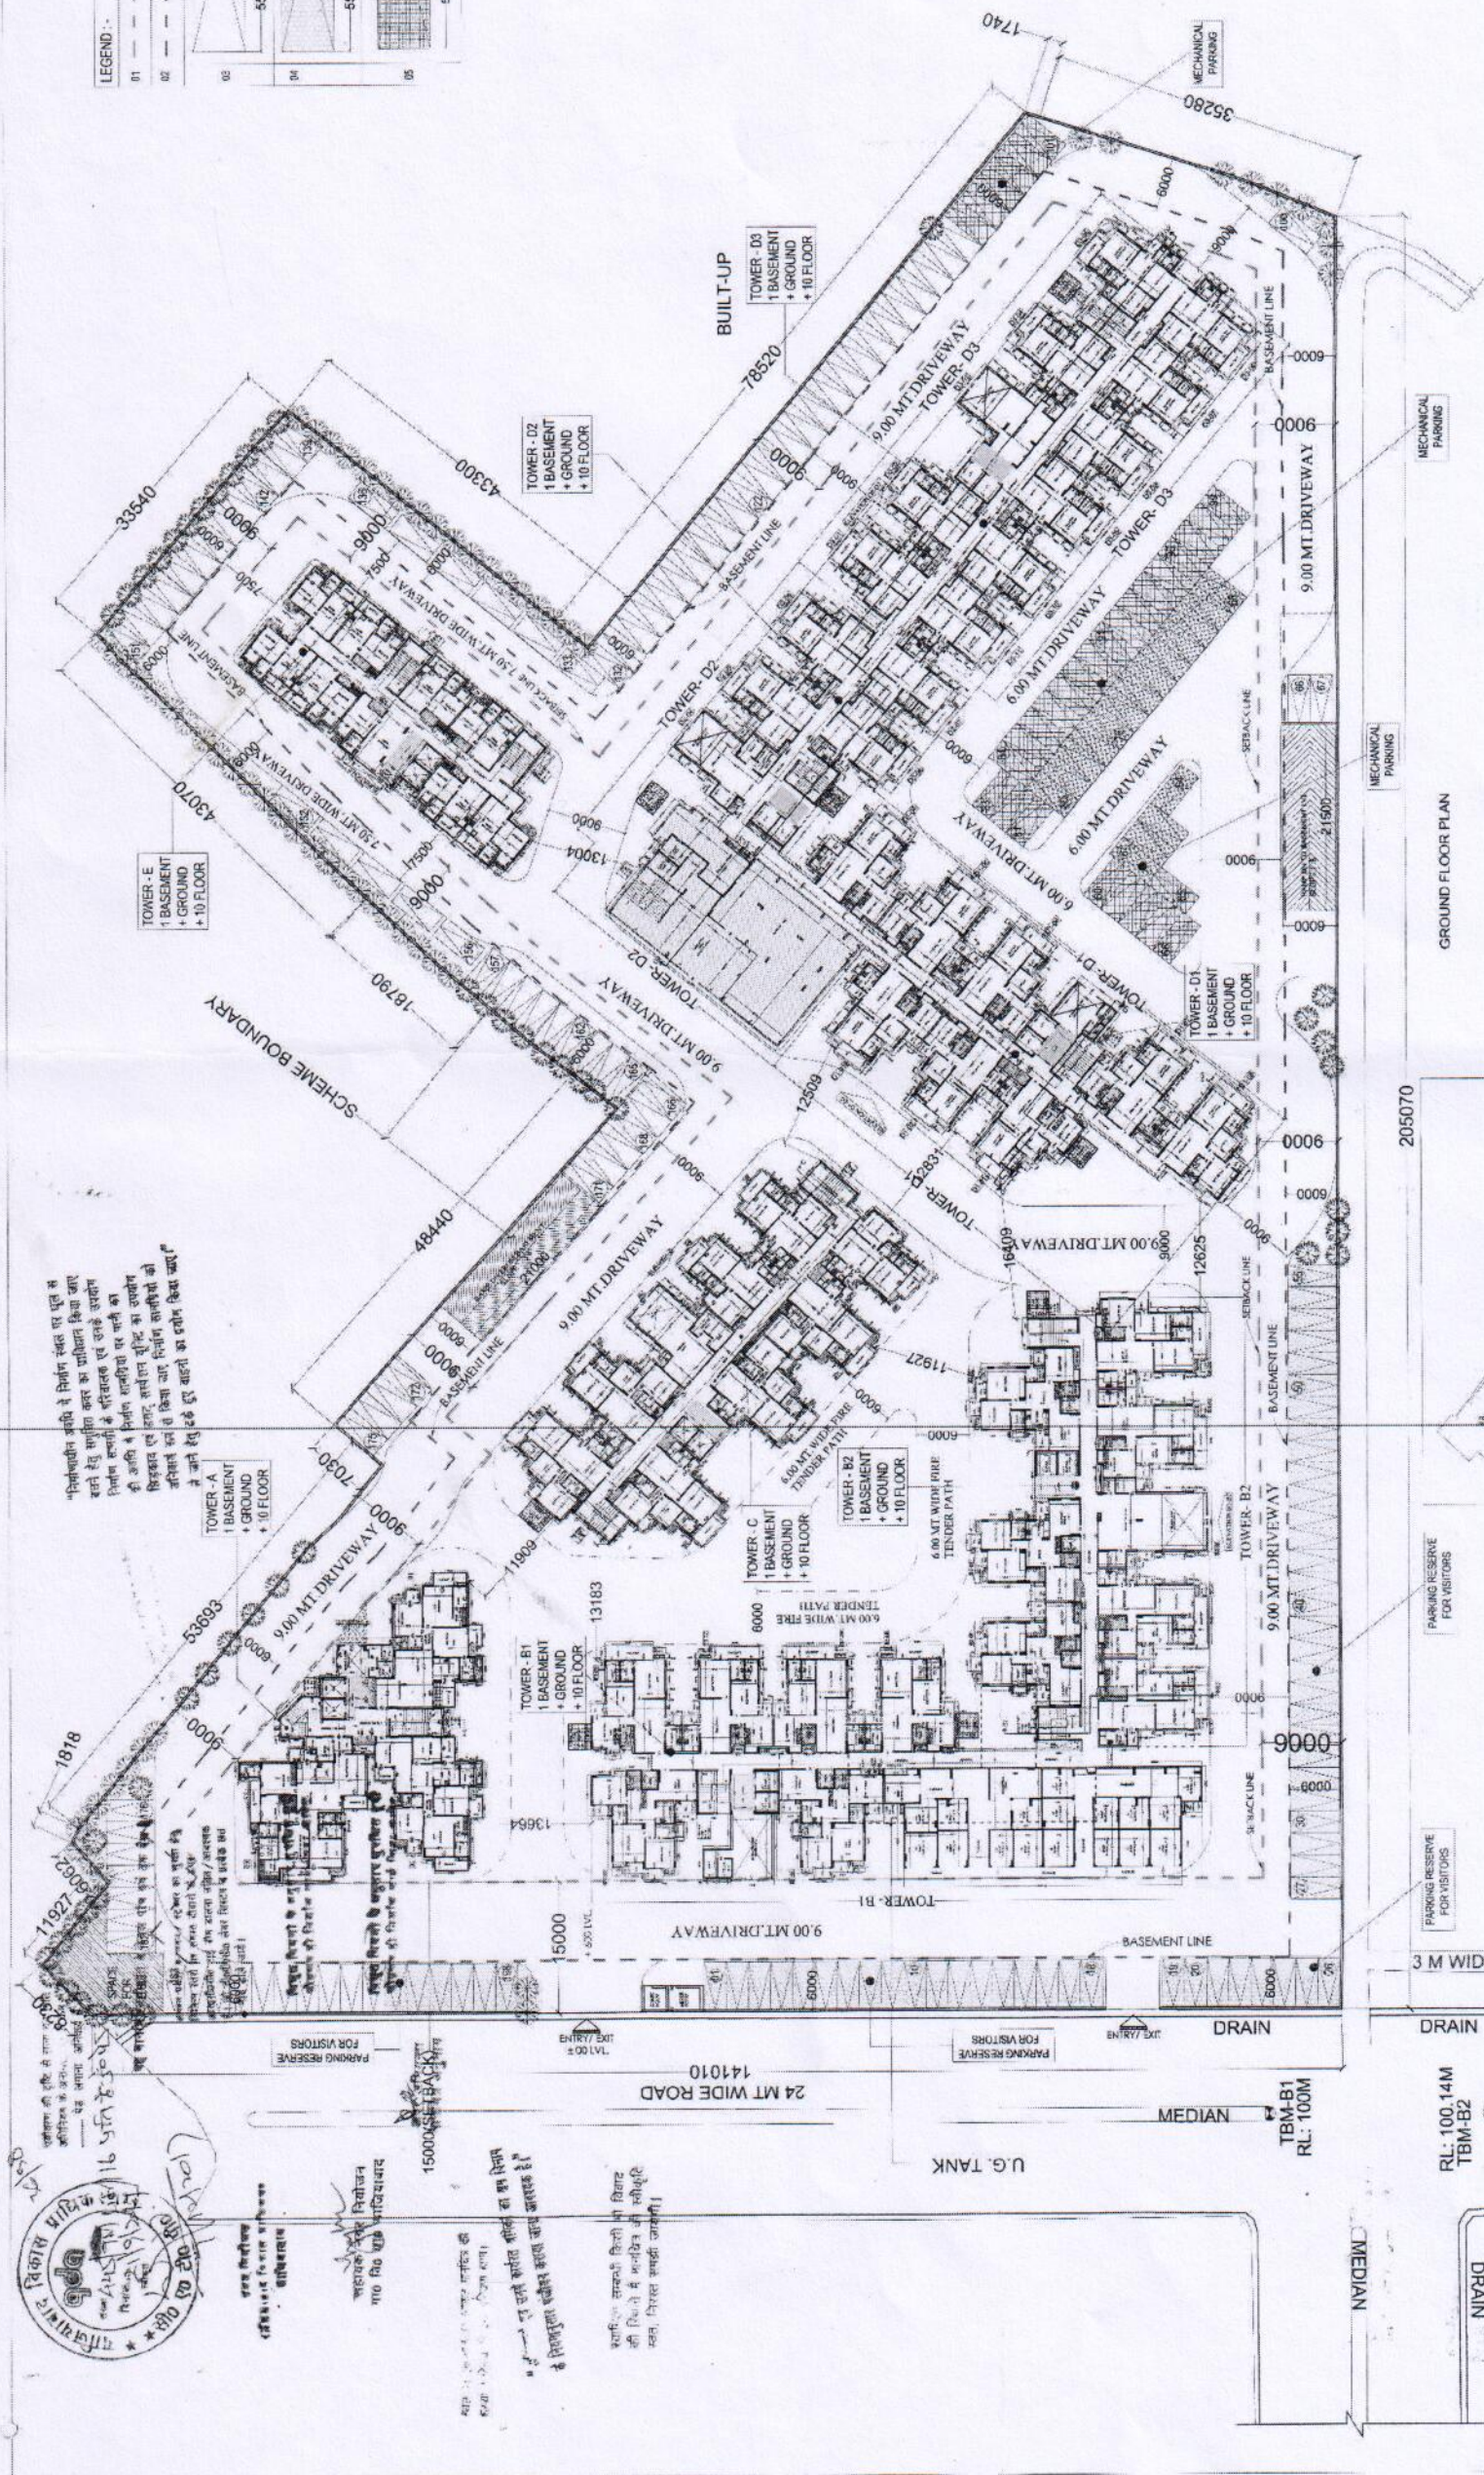


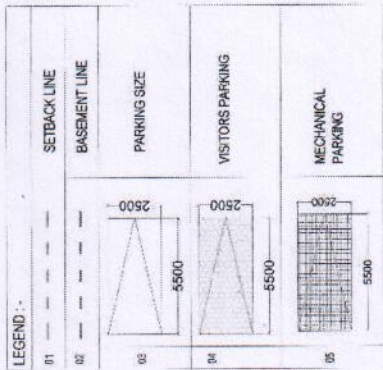

PROJECT :-
PROPOSED RESIDENTIAL COMPLEX
FOR DELHI METRO WELFARE ORGANIZATION
AT PLOT NO - GH-13 KOYAL ENCLAVE
GHAZIABAD


DRAWING TITLE :-

GROUND FLOOR PLAN

ARCHITECTS
Spectra Designers International
B-34, SECTOR 67, NOIDA
PH: +91 9718337175, 9718337176
WWW.SPECTRADESIGNERS.COM

DATE :-
SCALE :-

ARCHITECT'S SIGN
OWNER'S SIGN
DRAWING NO. 03

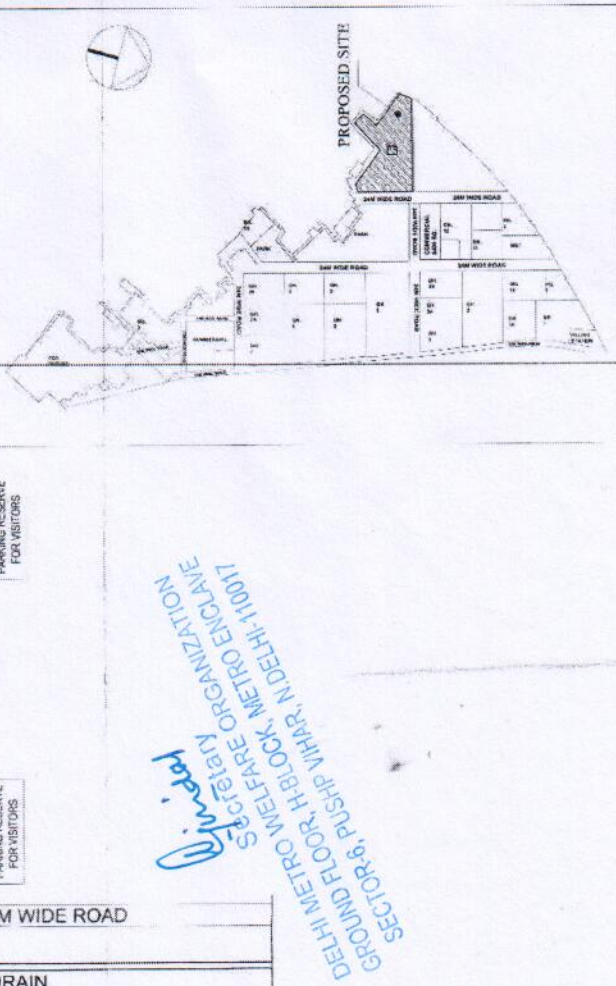

DEHI METRO WELFARE ORGANIZATION
SECRETARY
SECTOR-67, PUSHP VIHAR, NOIDA-201307

