
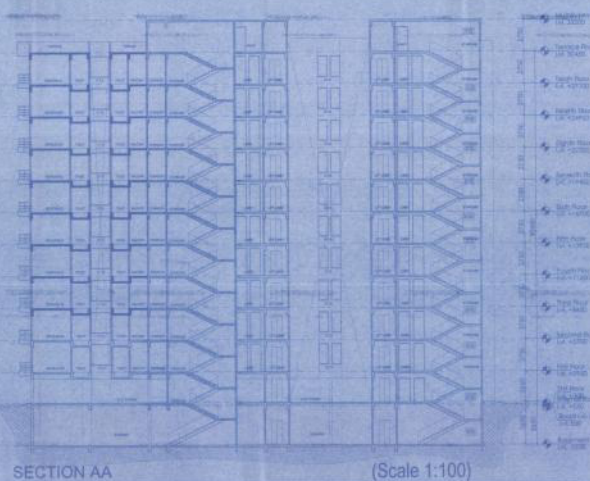
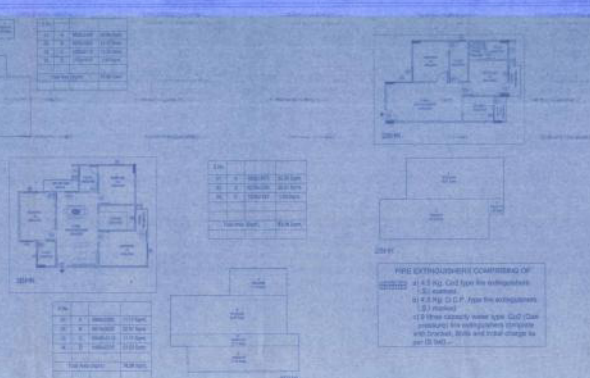


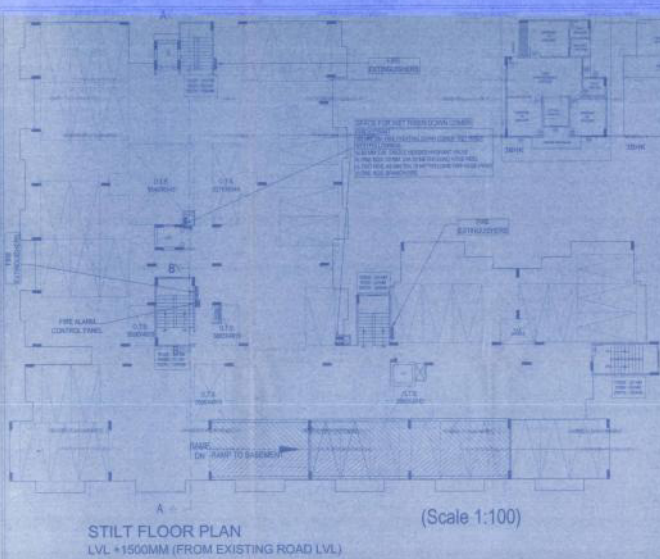

PROJECT

STILT FLOOR PLAN AND SECTION FOR PARKKALP BUILDING AT PANDORA ALBUQUERQUE HILL, BANGALORE, KARNATAKA, INDIA

DOOR & WINDOW SCHEDULE

NO.	TYPE	QTY	LOCATION
1	1.5 Kg. CO2 type fire extinguisher	1	Room 101
2	1.5 Kg. CO2 type fire extinguisher	1	Room 102
3	1.5 Kg. CO2 type fire extinguisher	1	Room 103
4	1.5 Kg. CO2 type fire extinguisher	1	Room 104
5	1.5 Kg. CO2 type fire extinguisher	1	Room 105
6	1.5 Kg. CO2 type fire extinguisher	1	Room 106
7	1.5 Kg. CO2 type fire extinguisher	1	Room 107
8	1.5 Kg. CO2 type fire extinguisher	1	Room 108
9	1.5 Kg. CO2 type fire extinguisher	1	Room 109
10	1.5 Kg. CO2 type fire extinguisher	1	Room 110

OWNER'S SIGNATURE

ARCHITECT'S SIGNATURE

02

SCALE

DATE

STILT FLOOR & SECTION

SUB TITLE

SUBMISSION DRAWING

SCALE

CHECKED BY


ARCHITECTS

PARKKALP

Ar. Pragna Singh

architects, interior designers, landscape consultants & project consultants

3021 apu khind pond nagar ludhiana dist-1520421144

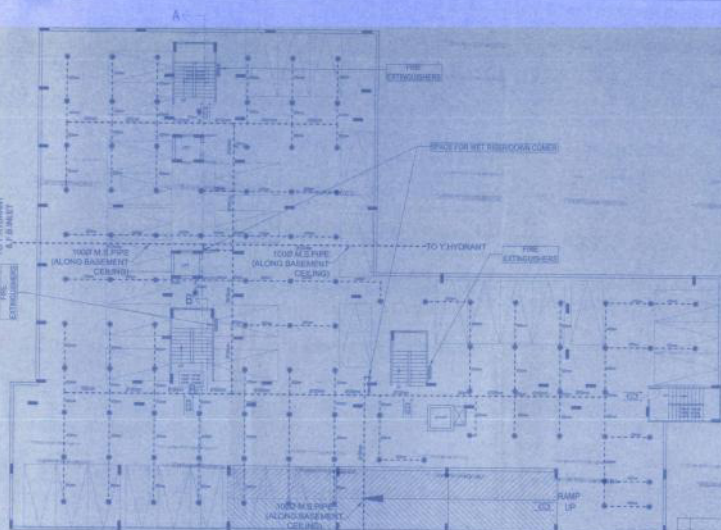


BASEMENT FLOOR PLAN
LVL - 1850 MM (DOWN FROM EXISTING ROAD LVL)

LEGEND (FIRE SPRINKLER SYSTEM)

S.N.	SYMBOL	DESCRIPTION	POSITION
1.		SPRINKLER HEAD	
2.		BUTTERFLY VALVE	
3.		FLOW SWITCH	
4.		VALVE	
5.		ISOLATION VALVE	


FIRE EXTINGUISHERS COMPRISING OF

- 4.5 Kg. Co2 type fire extinguishers I.S.I marked.
- 4.5 Kg. D.C.P. type fire extinguishers I.S.I marked.
- 9 litres capacity water type Co2 (Gas pressure) fire extinguishers complete with bracket, Batts and initial charge as per IS 940.

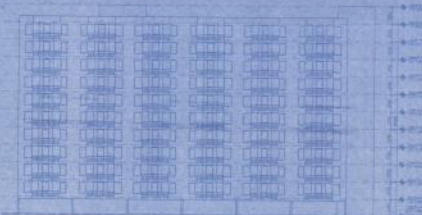

FRONT ELEVATION

SCALE - 1:200

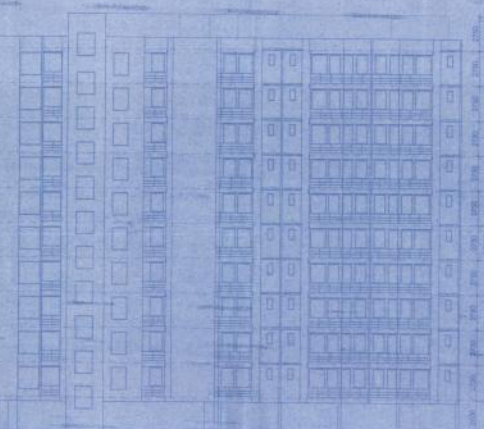

RIGHT SIDE ELEVATION

(Scale 1:100)

PROJECT :
PROPOSED GROUP HOUSING PLAN FOR
VARANASI DISTRICT PART-1 TO DIRECTOR SHW ANAND
KUMAR ADDRESS: 47 WARDEN RD ENCL 27/28/29
VILL. SARANATH, DIST. VARANASI, UTTAR PRADESH

DOOR & WINDOW SCHEDULE

S. NO.	DOOR	WIND	WIND	WIND	WIND
1.	24	100	100	100	100
2.	24	100	100	100	100
3.	24	100	100	100	100
4.	24	100	100	100	100
5.	24	100	100	100	100
6.	24	100	100	100	100
7.	24	100	100	100	100
8.	24	100	100	100	100
9.	24	100	100	100	100
10.	24	100	100	100	100

FIRE FIGHTING DRAWING

OWNER'S SIGNATURE

ARCHITECT'S SIGNATURE

DWG. SHEET NO. - NORTH

03

SCALE:-

DWG. TITLE

BASEMENT FLOOR & ELEVATIONS

DWG. TITLE

SUBMISSION DRAWING

JOB NO.

AS SPECIFIED

SCALE

AS SPECIFIED

CHECKED BY


ARCHITECT'S

PARIKALP

An. Pragy Singh

architects, interior designers,
landscape consultants
& project consultants

3081 vipul khand gomti nagar lucknow
tel- 05224011443

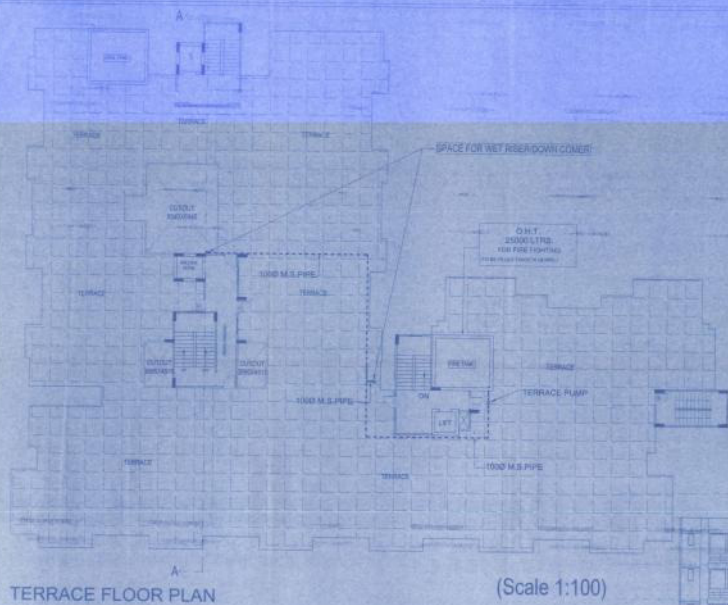


TERRACE FLOOR PLAN

(Scale 1:100)

LEGEND:- (FIRE)

S.NO.	SYMBOL	DESCRIPTION
1.		BUTTERFLY VALVE
2.		NON-RETURN VALVE
3.		TERRACE PUMP
4.		M.S. PIPE

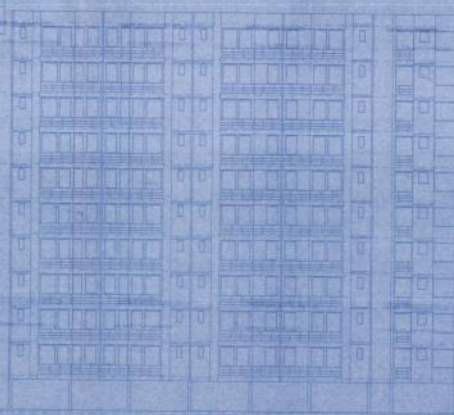

LEFT SIDE ELEVATION

SCALE :-1:100

PROJECT :

PROPOSED GROUP HOUSING PLAN FOR
VANDY BLUE TECH PVT LTD. DIRECTION: SUDHAKAR
CHANDRASEKAR, TOWERS IN AIR POLS ROAD,
VILL. SURESHWAR, BELTAMPUR ROAD, CHENNAI

DOOR & WINDOW SCHEDULE

S.NO.	DOOR	WIND.	WIND.	WIND.	WIND.
1.	D1	1000	1000	1000	1000
2.	D2	1000	1000	1000	1000
3.	D3	1000	1000	1000	1000
4.	D4	1000	1000	1000	1000
5.	D5	1000	1000	1000	1000
6.	D6	1000	1000	1000	1000
7.	D7	1000	1000	1000	1000
8.	D8	1000	1000	1000	1000
9.	D9	1000	1000	1000	1000
10.	D10	1000	1000	1000	1000

FIRE FIGHTING DRAWING

OWNER'S SIGNATURE

ARCHITECT'S SIGNATURE

DRG. SHEET NO. -

04

SCALE :-

DRG. TITLE

TERRACE FLOOR & ELEVATION

SUB TITLE

SUBMISSION DRAWING

JOB NO.


SCALE

CHECKED BY /


ARCHITECTS

PARIKALP
Ar. Pragy Singh


architects, interior designers,
landscape consultants
& project consultants
3051 Vipul Hand Ganga Nagar, Ludhiana
Distt:- (141001) 1443

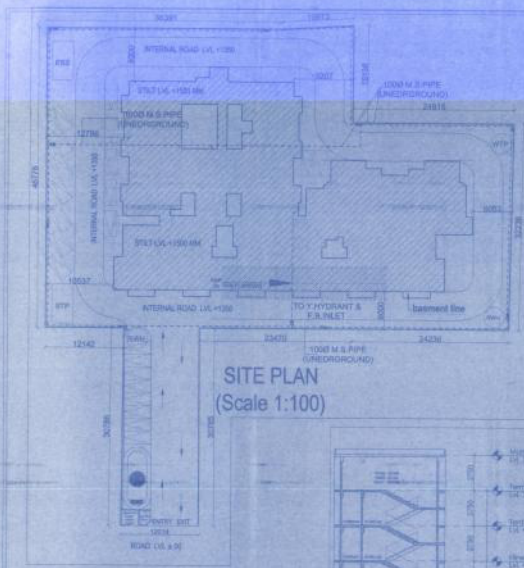

SITE PLAN
(Scale 1:100)

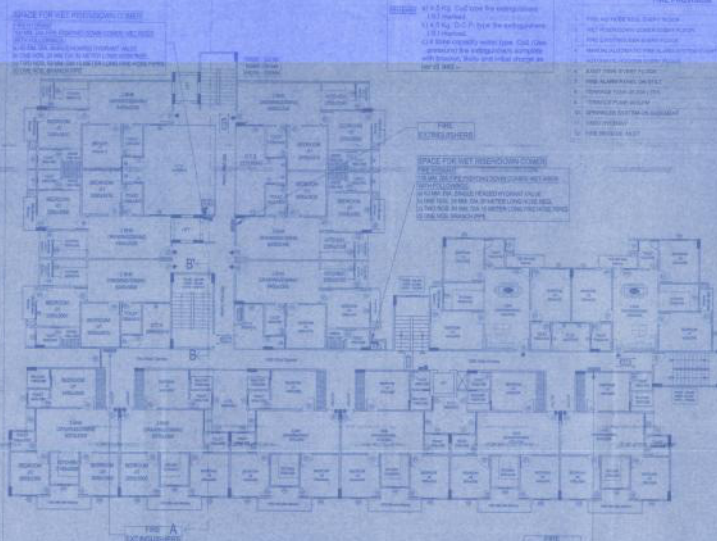


TYPICAL FLOOR
(FIRST TO TENTH FLOOR)

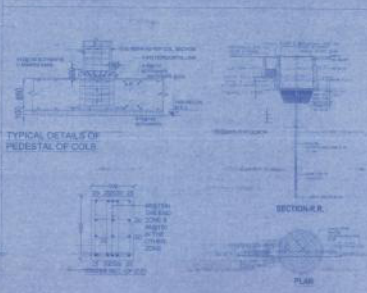

TYPICAL DETAILS OF PEDESTAL OF COLUMN



LOCATION PLAN
(Not to Scale)

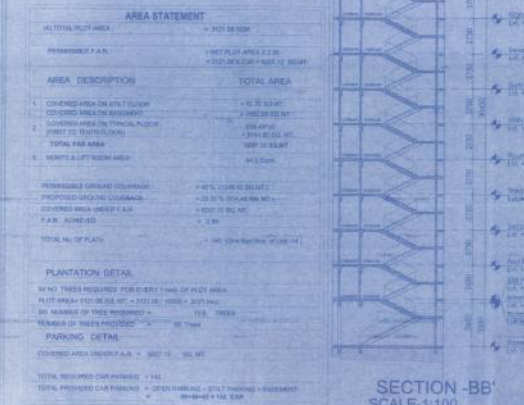

SECTION-BB'
(Scale 1:100)

PROJECT :
PROPOSED GROUP HOUSING PLAN FOR
ARJUN GANJ SITE, PLOT NO. 1000, DURGAM CHOWK, HYDRABAD
MIL. SARGHANA, BULTEPUR ROAD, HYDRABAD

DOOR & WINDOW SCHEDULE

Sl. No.	Door	Window	Remarks
1	1000	1000	1000
2	1000	1000	1000
3	1000	1000	1000
4	1000	1000	1000
5	1000	1000	1000
6	1000	1000	1000
7	1000	1000	1000
8	1000	1000	1000
9	1000	1000	1000
10	1000	1000	1000

Sl. No.	Door	Window	Remarks
1	1000	1000	1000
2	1000	1000	1000
3	1000	1000	1000
4	1000	1000	1000
5	1000	1000	1000
6	1000	1000	1000
7	1000	1000	1000
8	1000	1000	1000
9	1000	1000	1000
10	1000	1000	1000

FIRE FIGHTING DRAWING

OWNER'S SIGNATURE

ARCHITECT'S SIGNATURE

DWG. SHEET NO. - NORTH

01

SCALE

DWG. TITLE

SITE FLOOR & TYPICAL FLOOR PLAN

SUB. TITLE

SUBMISSION DRAWING

NO. OF SHEETS - 10

CHECKED BY:

ARCHITECTS

PARIKALP

Ar. Pragya Singh

architects, interior designers,

landscape consultants

& project consultants

3021 vihar khand gani nagar lucknow

dist. 05224011443