


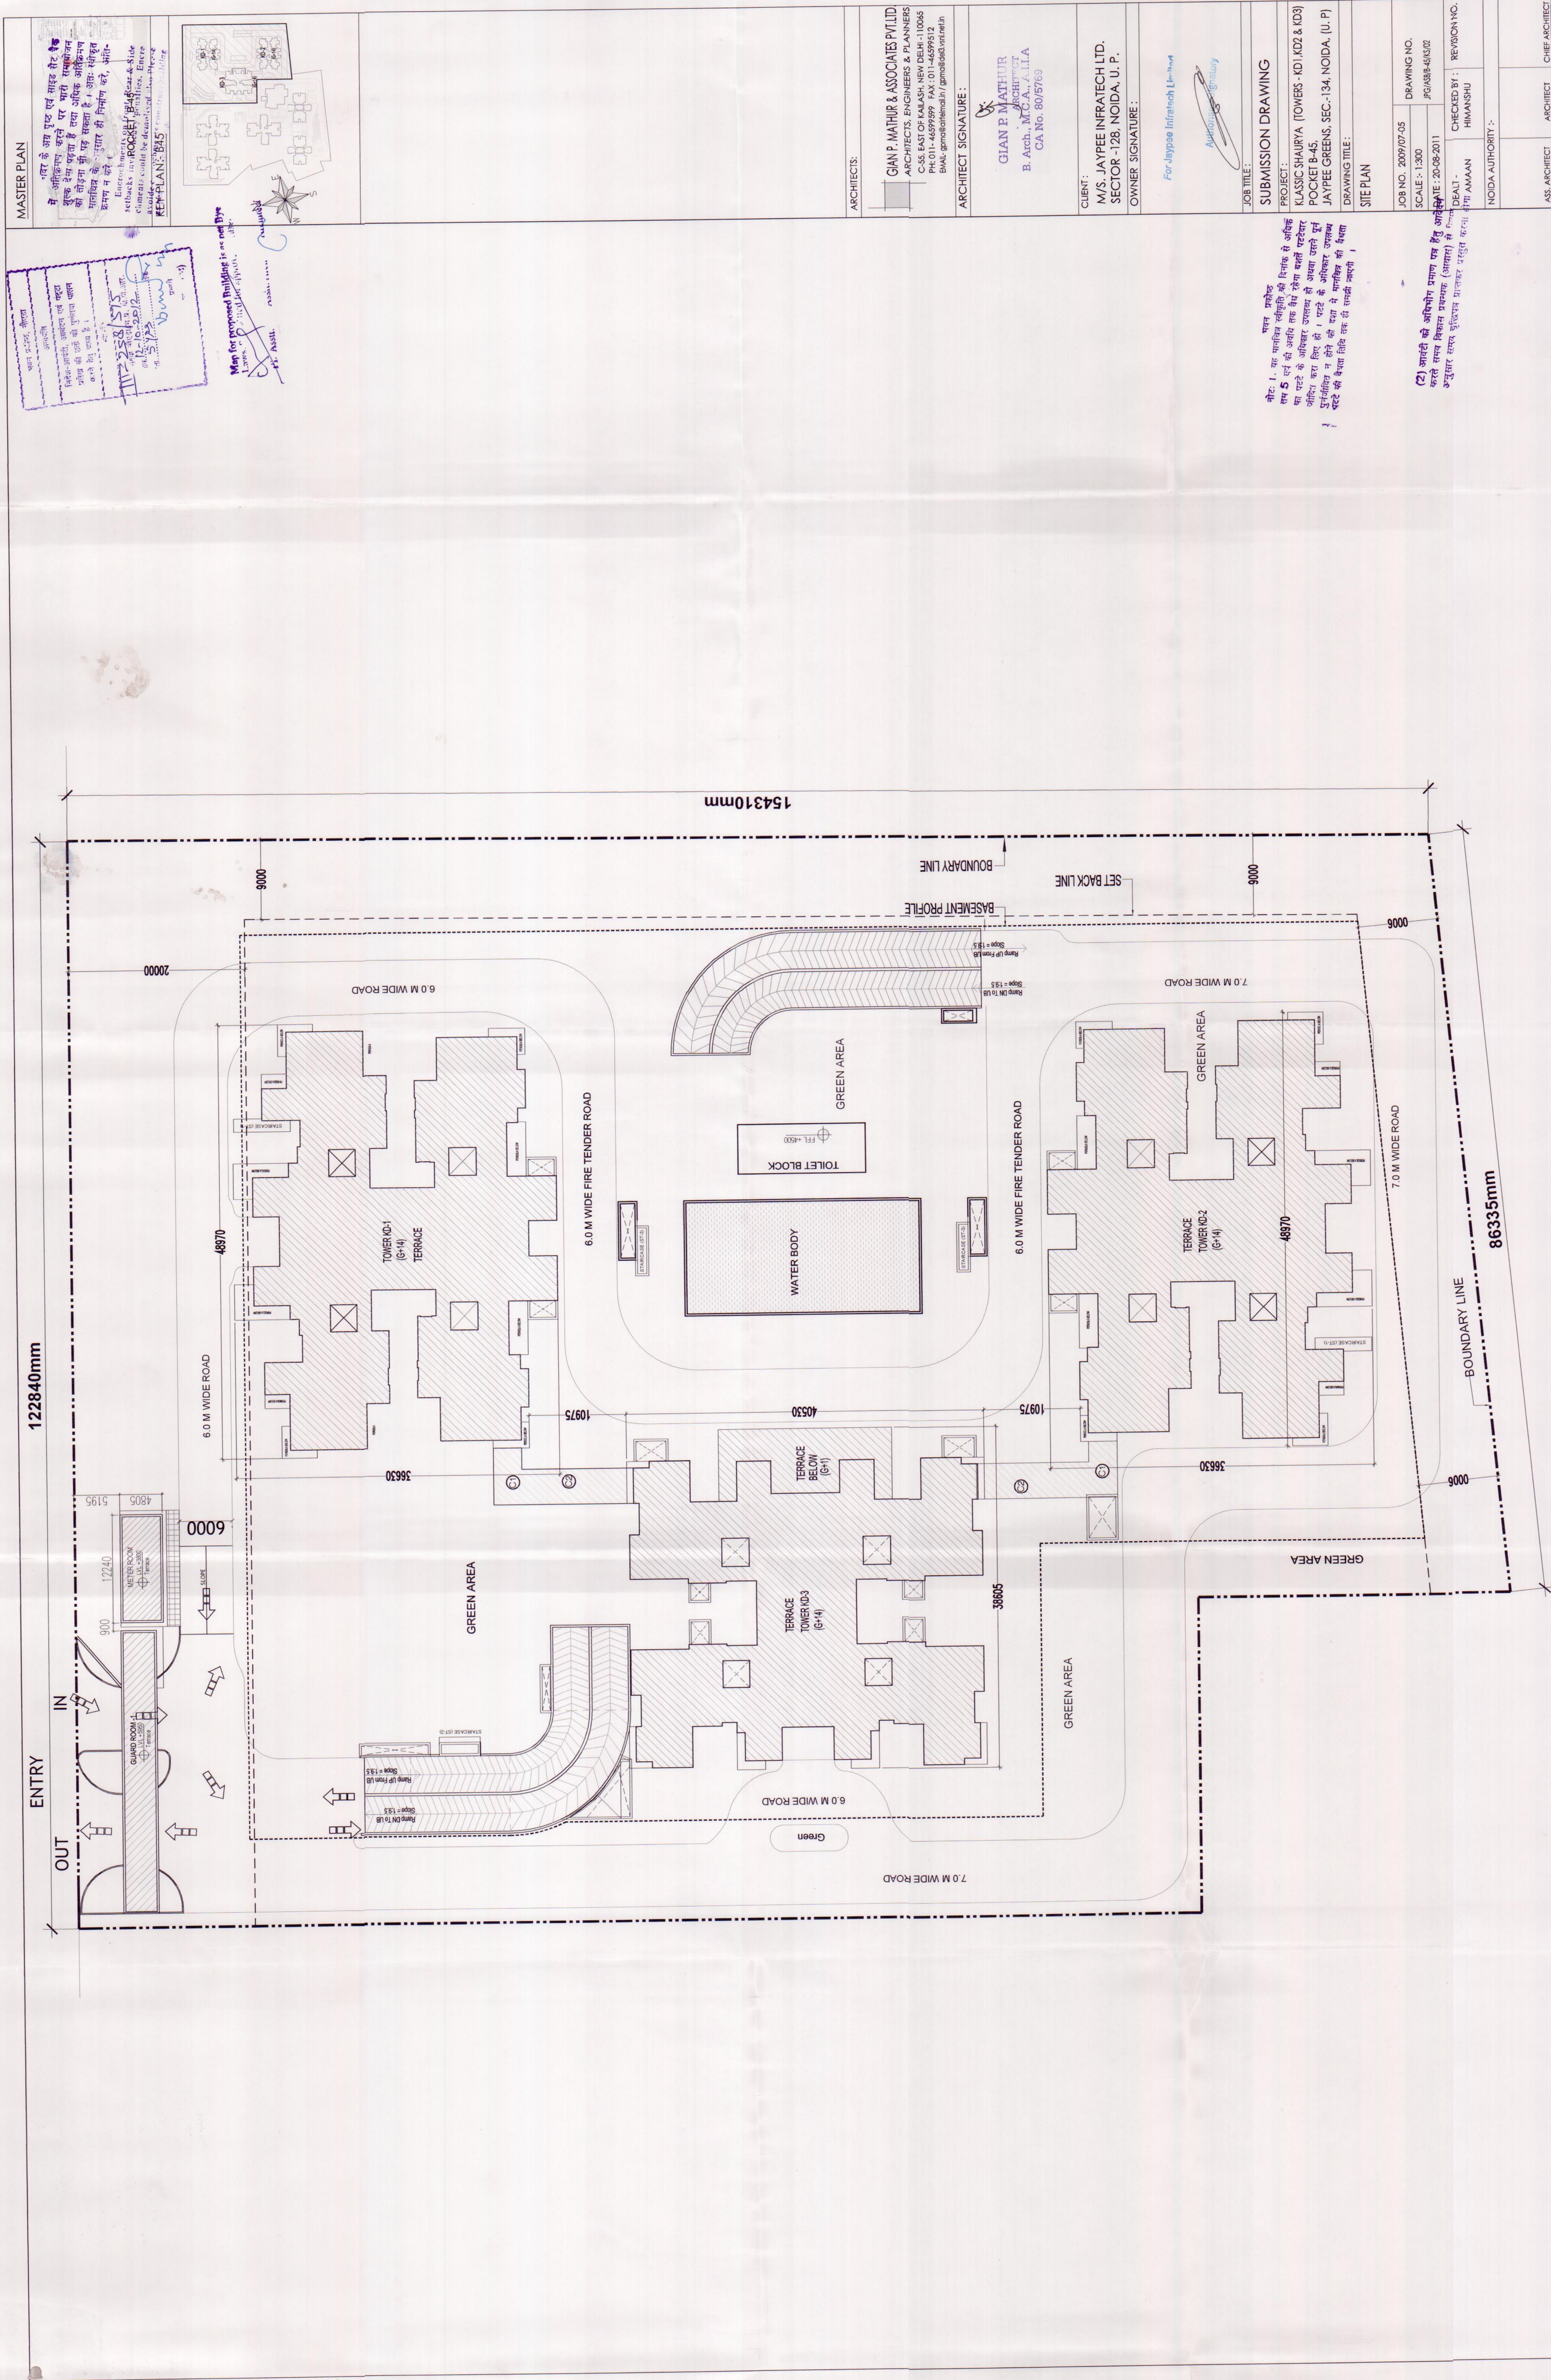


NOTE:-



1. THIS DRAWING REPRESENTS ONLY A FIRE FIGHTING DETAIL, FOR ARCHITECTURAL, STRUCTURAL AND OTHER SERVICES REFER RELEVANT DRAWINGS.
2. PLEASE CO-ORDINATE THIS DRAWING WITH ALL OTHER RELEVANT DRAWINGS OF ALL THE SERVICES.
3. ALL DIMENSIONS SHOWN IN DRAWINGS ARE IN MM AND MUST BE CO-ORDINATED WITH THE ARCHITECTURAL DRAWINGS.

24.0 m wide ROAD

LEVEL -200.00

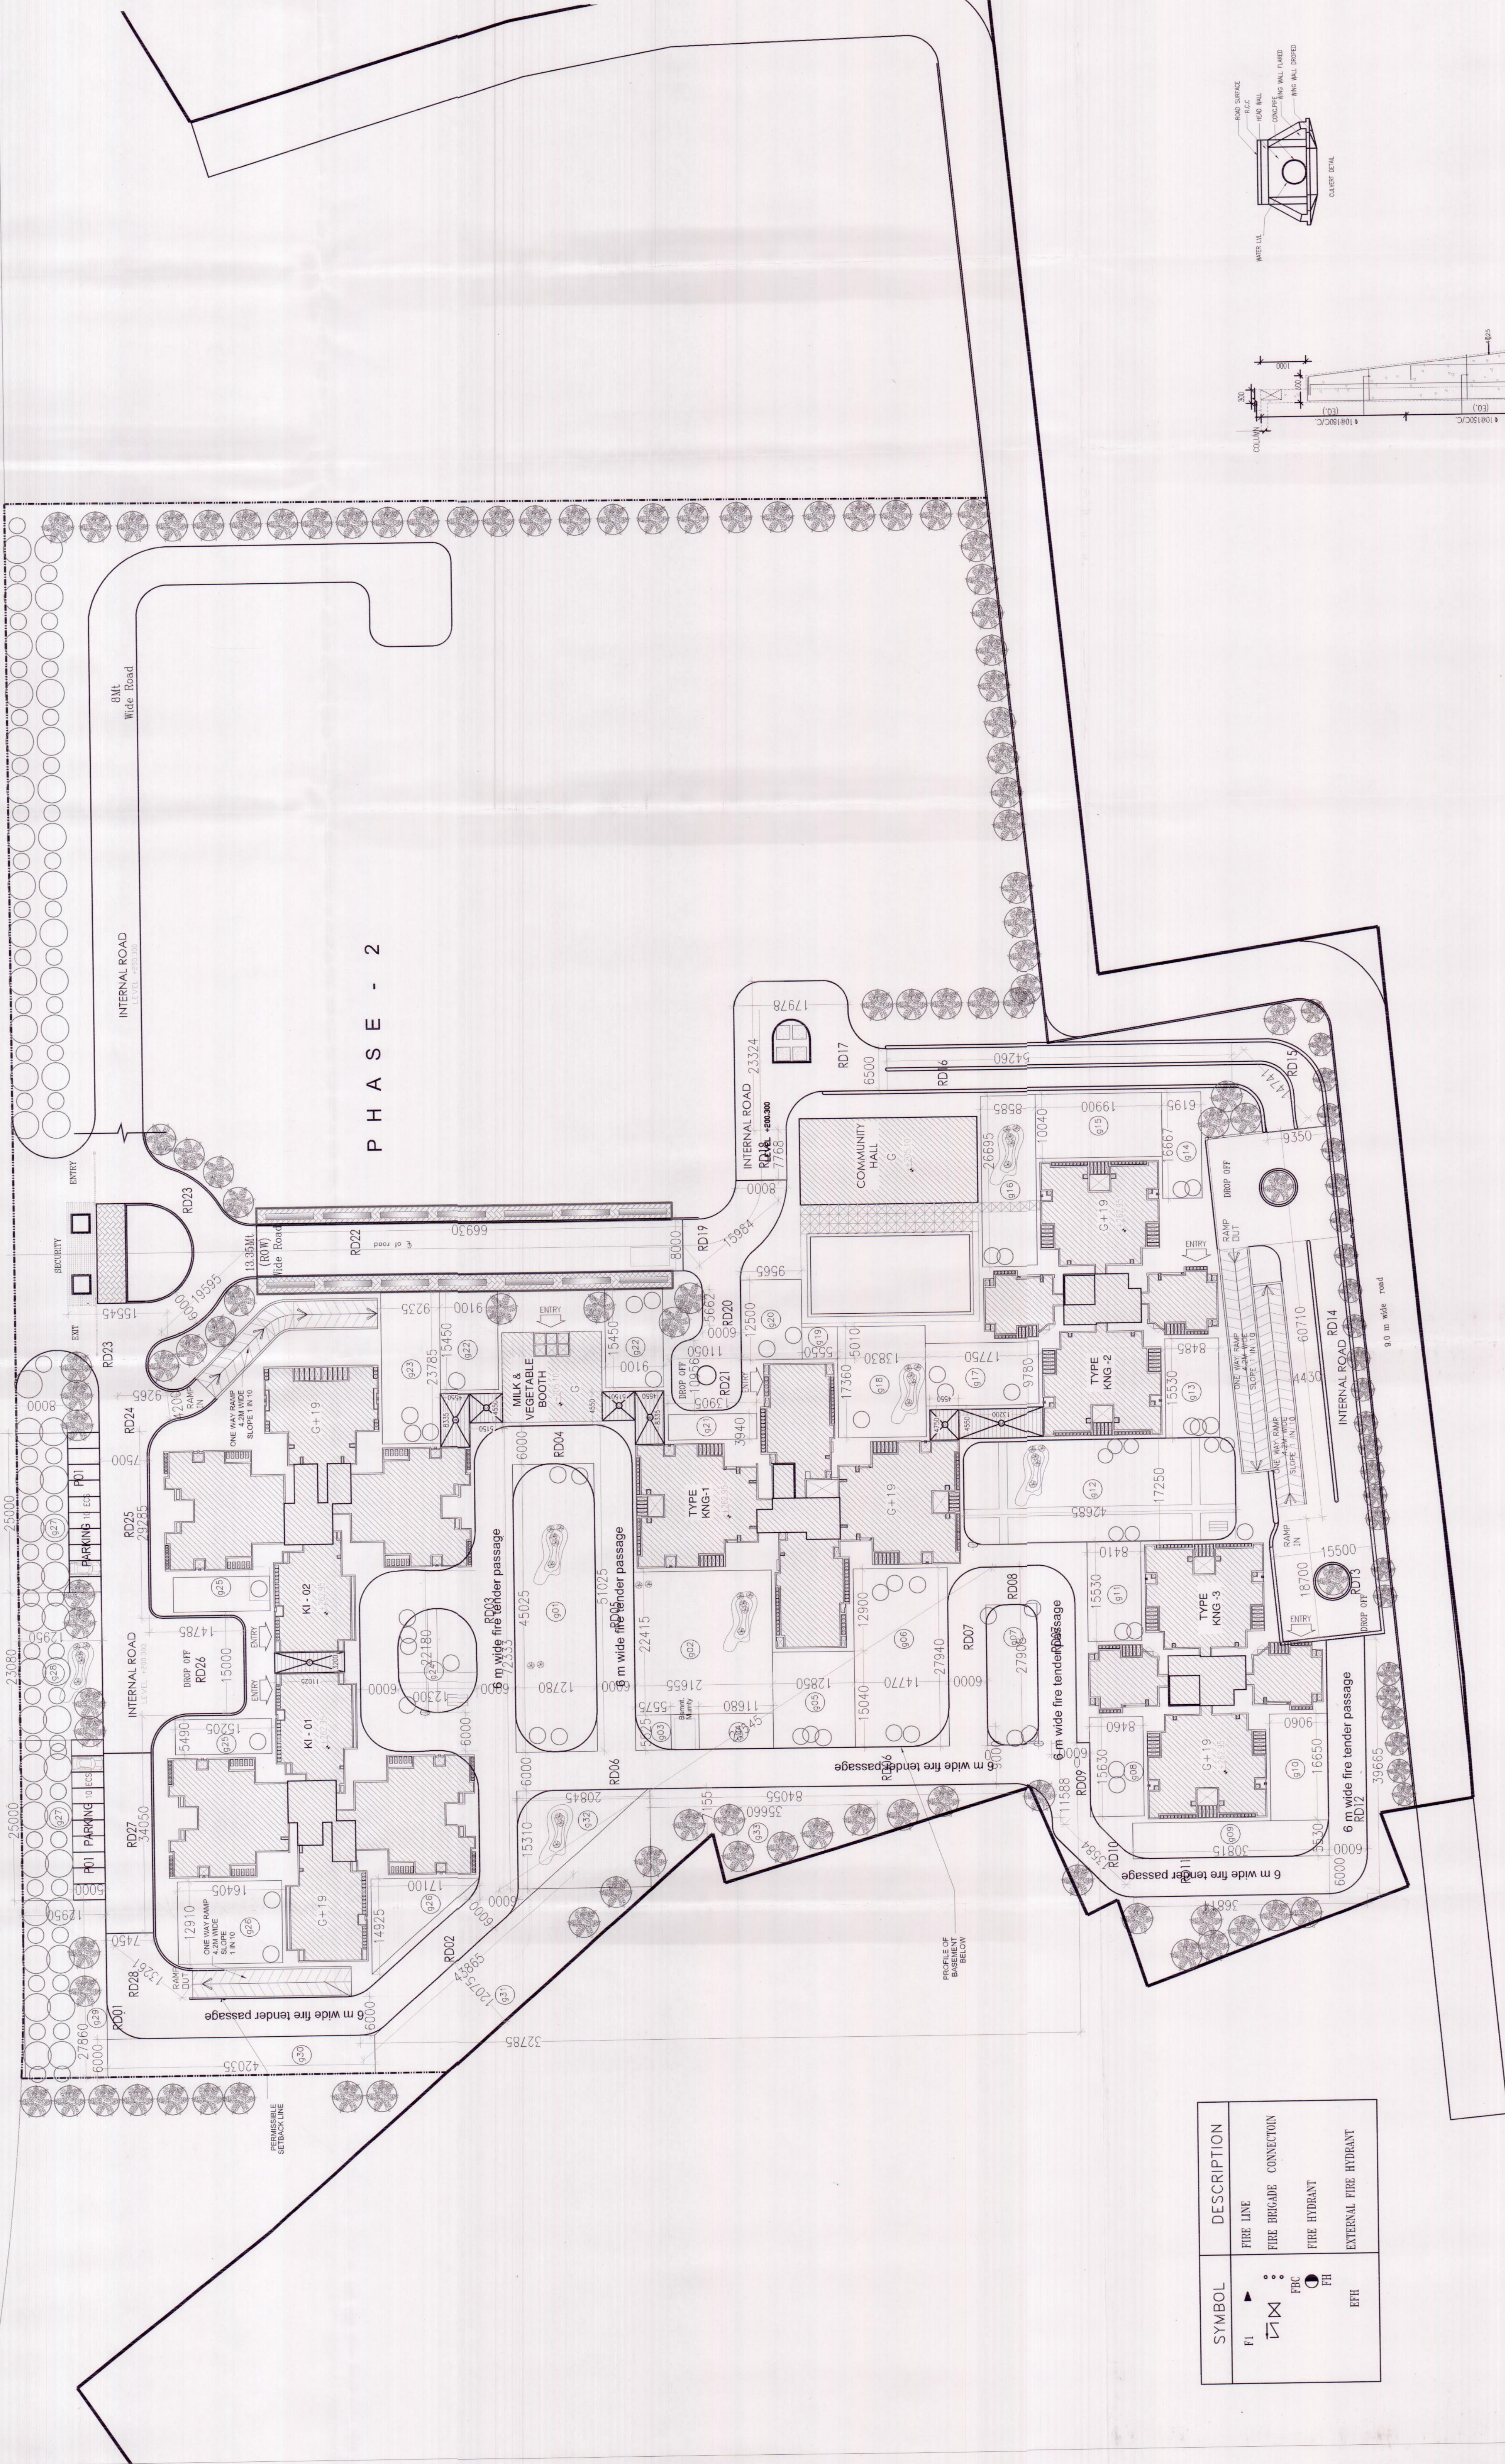

SYMBOL	DESCRIPTION
F1	FIRE LINE
FB	FIRE BRIGADE CONNECTION
FH	FIRE HYDRANT
FT	EXTERNAL FIRE TENDANT

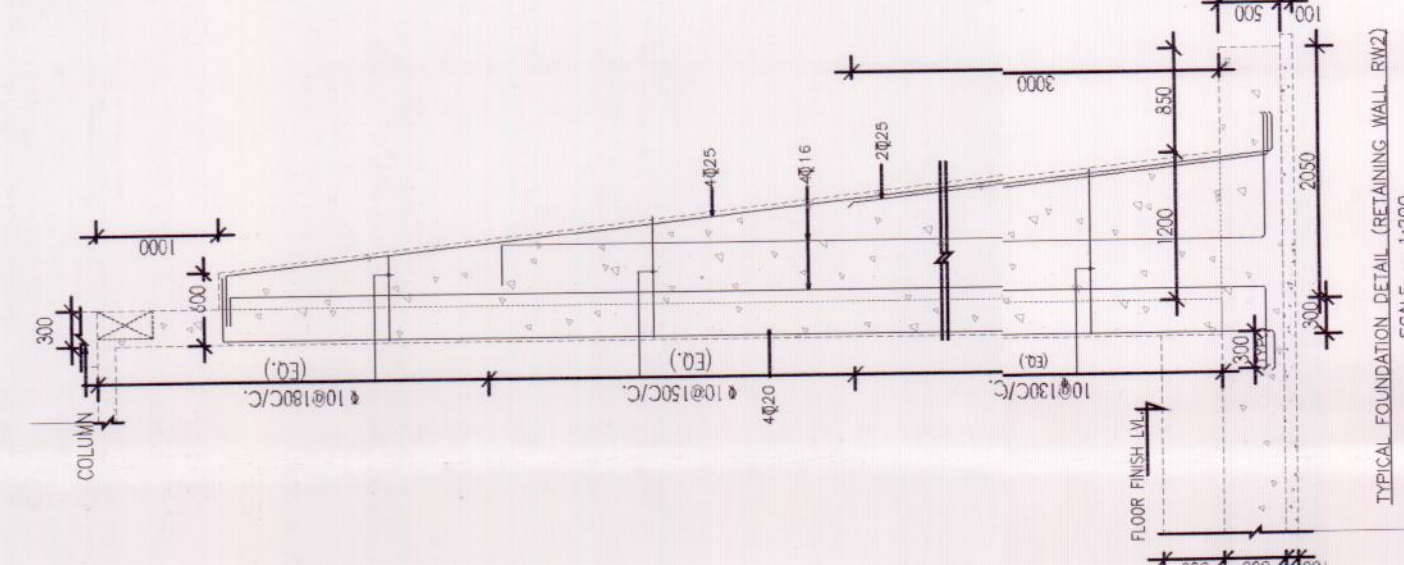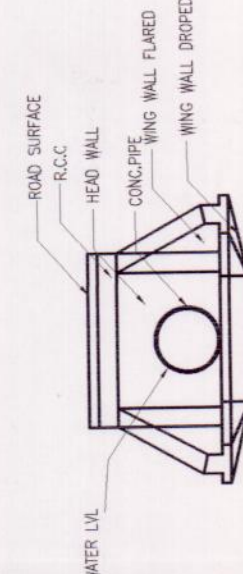

Key Plan

Notes

LEGEND

SYMBOL	DESCRIPTION	SYMBOL	DESCRIPTION	SYMBOL	DESCRIPTION
1	10000 GPM WATER PUMP	1	10000 GPM WATER PUMP	1	10000 GPM WATER PUMP
2	10000 GPM WATER PUMP	2	10000 GPM WATER PUMP	2	10000 GPM WATER PUMP
3	10000 GPM WATER PUMP	3	10000 GPM WATER PUMP	3	10000 GPM WATER PUMP
4	10000 GPM WATER PUMP	4	10000 GPM WATER PUMP	4	10000 GPM WATER PUMP
5	10000 GPM WATER PUMP	5	10000 GPM WATER PUMP	5	10000 GPM WATER PUMP
6	10000 GPM WATER PUMP	6	10000 GPM WATER PUMP	6	10000 GPM WATER PUMP
7	10000 GPM WATER PUMP	7	10000 GPM WATER PUMP	7	10000 GPM WATER PUMP
8	10000 GPM WATER PUMP	8	10000 GPM WATER PUMP	8	10000 GPM WATER PUMP
9	10000 GPM WATER PUMP	9	10000 GPM WATER PUMP	9	10000 GPM WATER PUMP
10	10000 GPM WATER PUMP	10	10000 GPM WATER PUMP	10	10000 GPM WATER PUMP

Drawing Title
CLUSTER B - 45, PH1
SITE PLAN

Job Title
Submission - Cluster B - 45 , PH1

Project
JAYPEE GREENS NOIDA

PART SECTOR-129
NOIDA, U. P.

Architects & Town Planners

ARCOP ASSOCIATES Pvt. Ltd.
E-106, G.K. ENCLAVE Part-I
New Delhi-110 049

Ph. : 011-26242050

Fax : 011-26238035

Architect's Signature

Sandesh Sharma, Architect
Contact No. 011-26242050
Registration No. 04/2005/193

Owners' Signature

For Jaypee Infratech Limited
Authorized Signatory

Clients
JAYPEE INFRA TECH LTD.

Job No.

2006/17

Scale

1:100, 1:150, 1:500

Date

May 2011

Deal by

Shivika Singh

Revision No.

1

NOIDA AUTHORITY:

Associate Architect

Architect

Chief Architect