


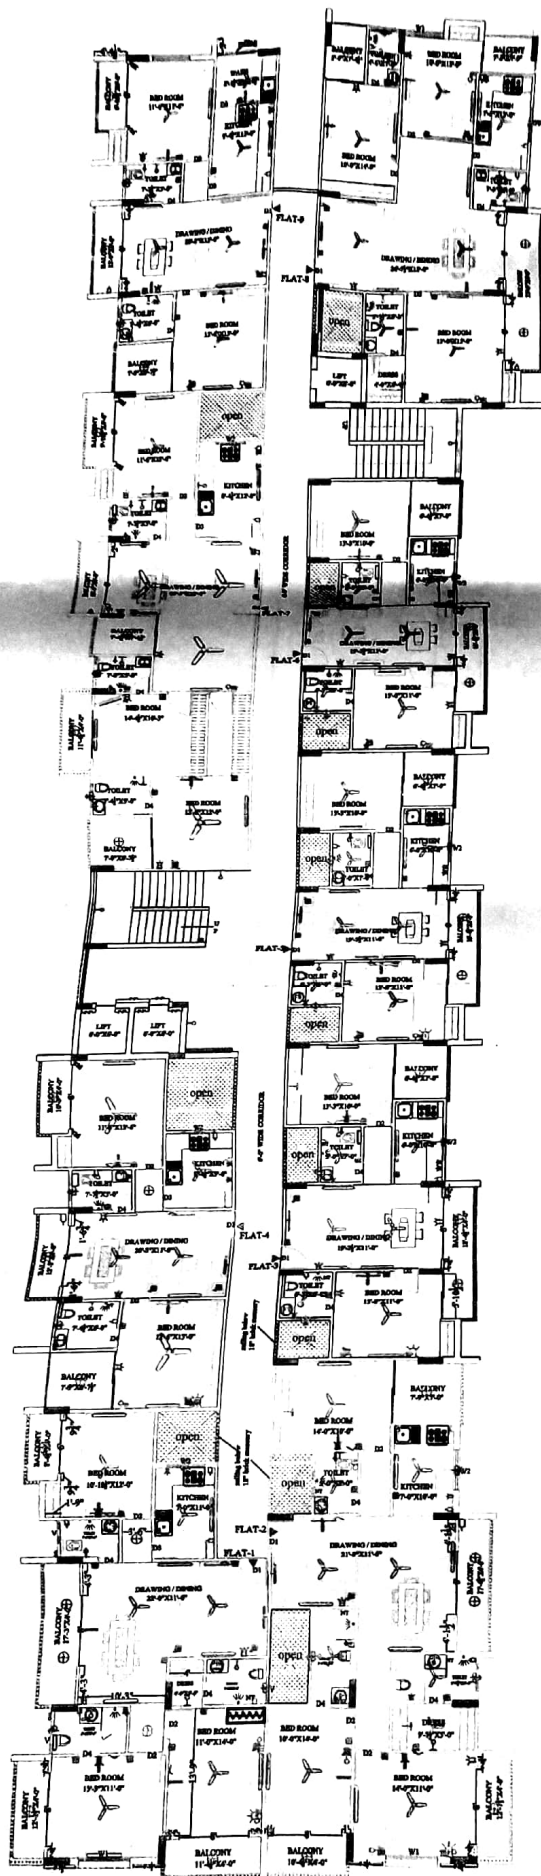

TYPICAL FLOR ELECTRICAL LAYOUT

ELECTRICAL POINT		
S.NO.	NAME OF POINT	SYMBOL
1.	CHILLING FAN	
2.	CHILLING LIGHT	
3.	CHILLING L&D LIGHT	
4.	5 AMP SWITCH BOARD HT-0.5' & 4-0'	
5.	5 AMP POWER POINT HT-0.5' & 4-0'	
6.	10 AMP POWER POINT HT-0.5' & 4-0'	
7.	BOLD HT-0.5' & 4-0'	
8.	CHILLING HT-0.5' & 4-0'	
9.	TELEPHONE POINT HT-0.5' & 4-0'	
10.	MONITOR	
11.	COMPUTER Power Point LAN WORKING HT-0.5' & 4-0'	
12.	L.C.D. HT-0.5' & 4-0'	
13.	TUBE LIGHT HT-0.5' & 4-0'	
14.	EXHAUST FAN HT-0.5' & 4-0'	
15.	M.C.B.	
16.	A.C. POINT HT-0.5' & 4-0'	
17.	CAMERA HT-0.5' & 4-0'	
18.	SPEAKER (FALLS CHILLING)	
19.	WALL FAN	
20.	WALL	
21.	WALL LIGHT HT-0.5' & 4-0'	
22.	WALL LIGHT HT-0.5' & 4-0'	
23.	WALL LIGHT HT-0.5' & 4-0'	
24.	GATE LIGHT	

PROPOSED GROUP HOUSING
BUILDING PLAN FOR
HISPAN DEVELOPERS
PRIVATE LIMITED,
OFFICE AT C27/274-A-A1,
101 FIRST FLOOR
JAYSHING BUILDING 2ND,
MALDARITYA
DISTRICT - VARANASI (U.P.)

DATE 18-11-2013

SCALE 1"=4'-0"

SHEET NO. 01

DRAWN BY VIDHI

ARCHITECT

CHECKED BY

TITLE
ELECTRICAL LAYOUT



DESIGN CENTRE

ARCHITECT ENGINEER INTERIOR
DESIGNER, VALLUR
OFFICE NO. 11 II FLOOR P.C.P.
PLAZA MHT HOUSE MADHAR
VARANASI
PHONE NO. 0542, 2502211

PRODUCED BY AN AUTODESK EDUCATIONAL PRODUCT