 





Technical drawings of the car lift showing front and side views with dimensions:

- Front View:** Shows the lift's footprint. The total width is 3000 mm. The width of the central platform is 2500 mm. The height of the lift structure is 4100 mm.
- Side View:** Shows the lift's profile. The total width is 1500 mm. The width of the central platform is 2800 mm. The height of the lift structure is 4100 mm.





architectural consultant pvt. ltd.
architects, engineers, planner
landscape design, interior design, & more
Office - 11nd & 11rd floor laxmi varden commercial complex at
petraker puram crossing gontingar, lucknow.
Dial - +91-522-2399123, 2394123, 4044123
Email id - skyline@usahco.com
ARCHITECTS :- SANJAY & VIJAY SINHA

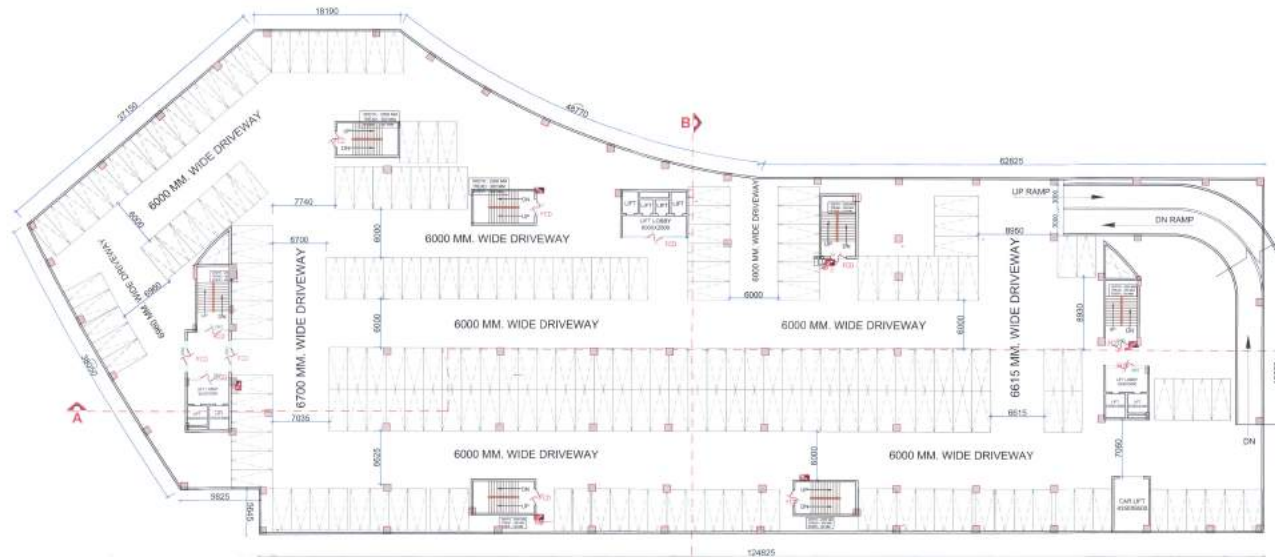

THREE LEVEL CAR PARKING
NO. OF PARKING = 224 NOS.
TOTAL CAR PARKING
IN FIRST BASEMENT = 224X3 = 672 NOS.

FIRST BASEMENT PLAN
SCALE: 1:150

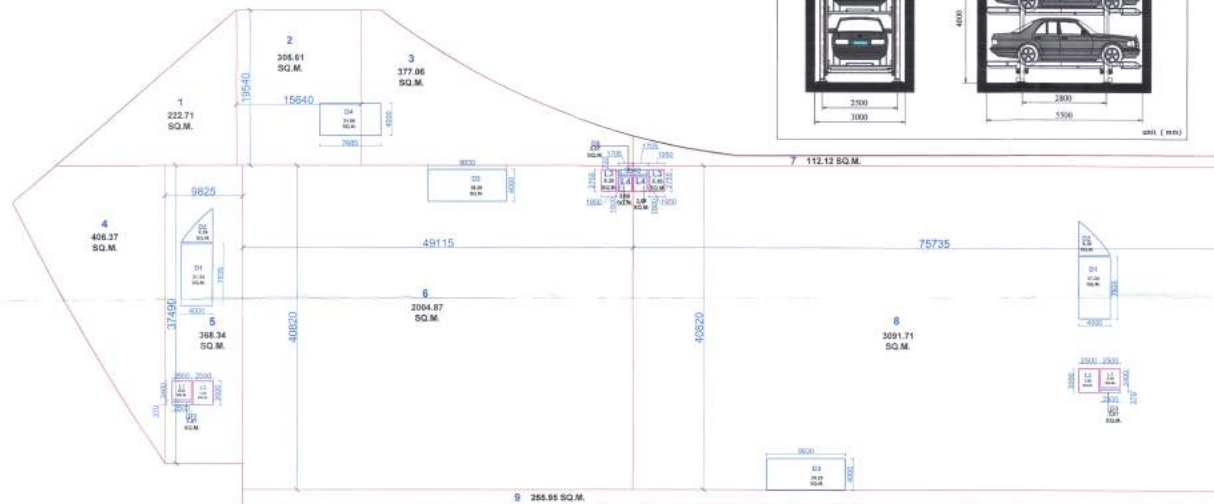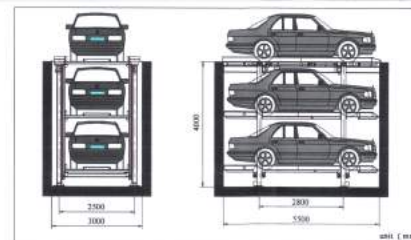

ENVELOPE PLAN OF FIRST BASEMENT
SCALE: 1:150

असहयोगिता का अर्थ है - अलग-अलग
और अलग-अलग अर्थों में एक ही
शब्द का प्रयोग करना।
यह बात ध्यान में रखनी चाहिए।
असहयोगिता का अर्थ है - अलग-अलग
और अलग-अलग अर्थों में एक ही
शब्द का प्रयोग करना।



SUBMISSION DRAWING

NORTH

SHEET NO.

3/17

FIRST BASEMENT FLOOR AREA						
S.NO.	DESCRIPTION	SIZE IN MT	SIZE IN MT	AREA	QUANTITY	AREA IN SQ.MT
1.0	1	X	X	222.71	1	222.71
2.0	2	15.64	15.54	365.81	1	365.81
3.0	3	X	X	377.08	1	377.08
4.0	4	X	X	448.37	1	448.37
5.0	5	6.03	37.49	248.34	1	248.34
6.0	6	24.12	44.82	299.87	1	299.87
7.0	7	X	X	112.12	1	112.12
8.0	8	75.74	40.82	3091.71	1	3091.71
9.0	9	X	X	255.95	1	255.95
TOTAL AREA						7144.74
TOTAL FIRST BASEMENT FLOOR AREA						672 NOS.

DOOR / WINDOW SCHEDULE						
S.NO.	TYPE	SIZE	SHL. LEVEL	DOOR SIZE	WINDOW UNITS LEVEL	REMARKS
1.	D	3000X2500	-	-	2500	DOORWAY DOOR
2.	D1	2000X2500	-	-	2500	DOORWAY DOOR
3.	D2	1500X2500	-	-	2500	DOORWAY DOOR
4.	D3	1200X2500	-	-	2500	DOORWAY DOOR
5.	D4	1000X2500	-	-	2500	DOORWAY DOOR
6.	D5	800X2500	-	-	2500	DOORWAY DOOR
7.	D6	600X2500	-	-	2500	DOORWAY DOOR
8.	D7	400X2500	-	-	2500	DOORWAY DOOR
9.	DW1	800X2500	100	2000	3000X2	DOORWAY DOOR
10.	DW2	500X2500	100	2000	1000X2	DOORWAY DOOR
11.	DW3	400X2500	100	2000	1000X2	DOORWAY DOOR
12.	DW4	300X2500	100	2000	1000X2	DOORWAY DOOR
13.	DW5	200X2500	100	1500	2000X2	DOORWAY DOOR
14.	DW6	1750X2500	100	1500	750X1	DOORWAY DOOR
15.	GD1	2000X2500	-	-	2500	DOORWAY DOOR
16.	GDW1	1800X2500	-	2000	4000X2	DOORWAY DOOR
17.	GDW2	8000X2500	-	2000	3000X2	DOORWAY DOOR
18.	GDW3	6000X2500	-	2000	2400X2	DOORWAY DOOR
19.	GDW4	6000X2500	-	2000	4000X1	DOORWAY DOOR
20.	GDW5	4000X2500	-	1500	1000X2	DOORWAY DOOR
21.	SPD1	2000X2500	-	-	2500	DOORWAY DOOR
22.	V1	750X1500	1500	-	2500	DOORWAY DOOR

PROJECT TITLE:

EKANA MALL AT
EKANA SPORTZ CITY, LUCKNOW

THIS IS TO CERTIFY THAT THIS BUILDING IS PROPOSED
AS PER THE RULES & REGULATIONS OF MAHAYOGANA 2021.


SIGN OF LAND LORD.

SIGN OF ARCHITECT.



DATE: 06-07-2018

Skyline
architectural consultant pvt. ltd.
architects, engineers, planner
interior design, exterior design, & more
Office :- 1st & 2nd floor, laxmi vardan commercial complex at
patrakar puram crossing gomtinagar, lucknow,
Dist :- +91-522-2393123, 2394123, 4044123
Email ID :- skyline@usahcc.com
ARCHITECTS :- SANJAY & VIJAY SINHA

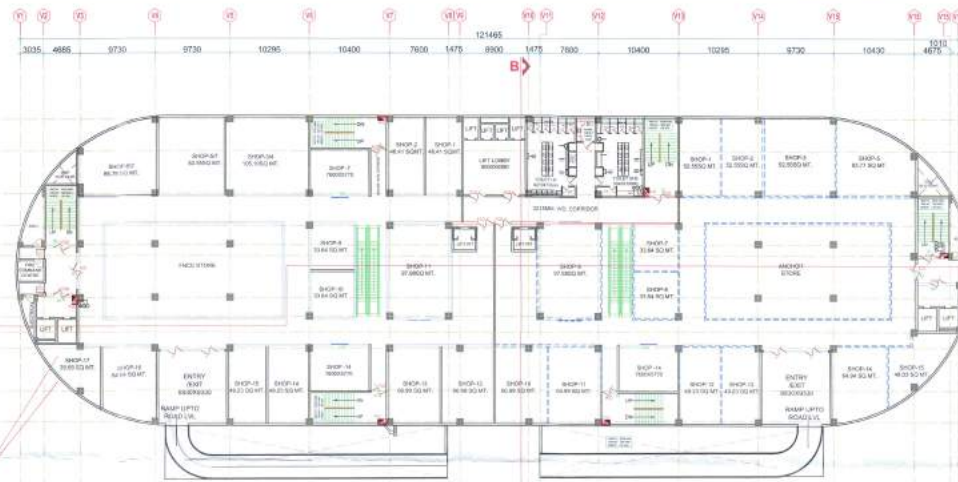

LOWER GROUND PLAN
SCALE-1:150



ENVELOPE PLAN OF LOWER GROUND PLAN
SCALE-1:150

LOWER GROUND FLOOR AREA					
S.NO	DISCRPTION	SIZE IN MT	SIZE IN MT	AREA	QUANTITY
PROPOSED BUILDING					
1.0	1	X	X	628.00	2
2.0	2	84.085	40.050	3367.60	1
3.0	3	X	X	25.49	2
4.0	4	30.490	3.230	98.48	2
AREA -A1					4871.55
DUCT & LIFT AREA					
1.0	D1	4.00	8.25	33.00	2
2.0	D2	X	X	9.20	2
3.0	S1	9.83	4.00	39.32	2
TOTAL AREA					163.04
AREA A1 - DUCT					(4871.55 - 163.04)
TOTAL LOWER GROUND FLOOR AREA					4708.51 SQ.MT.

जय गान्धिवर चक्र- नगर वाहन
और विमान परिवहन विभाग की
द्वारा १९ के नक़्शेय इस अधिकार
के द्वारा स्वीकृत किया जाता है कि
यिक्त प्रकल्पन भूमि विमान
व्यावसायिक के लिए अधिकृत मान्य नहीं
है।



SUBMISSION DRAWING

NORTH

SHEET NO.

4/17

DOOR / WINDOW SCHEDULE						
S.NO	TYPE	SIZE	DOOR LEVEL	WINDOW LEVEL	REMARKS	
1.	D	3000X2550	-	-	2550	MAIN ENTRANCE DOOR
2.	D1	2000X2550	-	-	2550	SHOPS ENTRANCE DOOR
3.	D2	1500X2550	-	-	2550	SHOPS ENTRANCE DOOR
4.	D3	1200X2550	-	-	2550	SHOPS ENTRANCE DOOR
5.	D4	1000X2550	-	-	2550	SHOPS ENTRANCE DOOR
6.	D5	800X2550	-	-	2550	SHOPS ENTRANCE DOOR
7.	D6	600X2550	-	-	2550	SHOPS ENTRANCE DOOR
8.	D7	400X2550	-	-	2550	SHOPS ENTRANCE DOOR
9.	DW1	3000X2550	800	2000	3000X2	SHOPS ENTRANCE WINDOW
10.	DW2	3000X2550	800	2000	3000X2	SHOPS ENTRANCE WINDOW
11.	DW3	4000X2550	800	2000	4000X2	SHOPS ENTRANCE WINDOW
12.	DW4	3000X2550	800	2000	3000X2	SHOPS ENTRANCE WINDOW
13.	DW5	3000X2550	800	1900	3000X1	SHOPS ENTRANCE WINDOW
14.	DW6	1700X2550	800	1900	1700X1	SHOPS ENTRANCE WINDOW
15.	DW7	2000X2550	-	-	2000X1	SHOPS ENTRANCE WINDOW
16.	DW8	1500X2550	-	-	1500X1	SHOPS ENTRANCE WINDOW
17.	DW9	1000X2550	-	-	1000X1	SHOPS ENTRANCE WINDOW
18.	DW10	800X2550	-	-	800X1	SHOPS ENTRANCE WINDOW
19.	DW11	600X2550	-	-	600X1	SHOPS ENTRANCE WINDOW
20.	DW12	400X2550	-	-	400X1	SHOPS ENTRANCE WINDOW
21.	DW13	300X2550	-	-	300X1	SHOPS ENTRANCE WINDOW
22.	V1	750X1500	1500	-	2550	SHOPS ENTRANCE WINDOW

LEGEND : (FIRE ALARM SYSTEM)		
S.NO	SYMBOL	DESCRIPTION
1.	1	SMOKE DETECTOR SYSTEM
2.	2	SMOKE DETECTOR ALARM PANEL
3.	3	SMOKE DETECTOR ALARM PANEL
4.	4	HEAT DETECTOR
5.	5	HEAT DETECTOR
6.	6	HEAT DETECTOR
7.	7	HEAT DETECTOR
8.	8	HEAT DETECTOR
9.	9	HEAT DETECTOR
10.	10	HEAT DETECTOR

PROJECT TITLE:

Ekana Mall at
Ekana Sportz City, Lucknow


THIS IS TO CERTIFY THAT THIS BUILDING IS PROPOSED
AS PER THE RULES & REGULATIONS OF U.P. BUILDING ACT, 1961.



SCALE: 1:200 DATE: 06-07-2018



architectural consultant pvt. ltd.
architects, engineers, planner
landscape design, interior design, & urban
Office: 1st & 2nd floor, Laxmi Vardan commercial complex at
patrakar puram crossing gomti nagar, Lucknow.
Dist. : +91-522-2393123, 2394123, 4044123
Email: id - skyline@usa.net
ARCHITECTS :- SANJAY & VIJAY SINHA

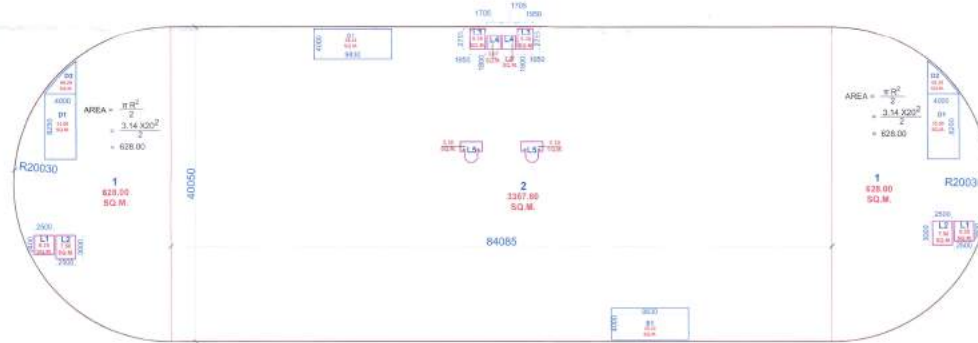

GROUND FLOOR AREA						
S.NO	DISCRIPTION	SIZE IN MT	SIZE IN MT	AREA	QUANTITY	AREA IN SQMT
PROPOSED BUILDING						
1.0	1	X	X	628.00	2	1256.00
2.0	2	84.085	40.050	3367.60	1	3367.60
AREA A1						4623.60
DUCT & LIFT AREA						
1.0	L1	2.50	2.50	6.25	2	12.50
2.0	L2	2.50	3.00	7.50	2	15.00
3.0	L3	1.95	2.75	5.36	2	10.73
4.0	L4	1.71	1.80	3.07	2	6.14
5.0	L5	X	X	5.30	2	10.60
6.0	D1	4.00	8.25	33.00	2	66.00
7.0	D2	X	X	9.20	2	18.40
8.0	S1	9.83	4.00	39.32	2	78.64
TOTAL AREA						218.00
AREA A1 - DUCT & LIFT AREA						4405.60
TOTAL GROUND FLOOR AREA						4405.60 SQ.MT.

नगर पालिका कार्यालय, लखनऊ
नगर विकास विभाग (नगर) को
बारा १५ के अनुसार नगर विकास-१
के नगर विस्तार विचार बारा है कि
नगर विकास विभाग नगर विकास
विभाग के लिए विचार बारा करे
है।



SUBMISSION DRAWING

NORTH

SHEET NO.

5/17

DOOR / WINDOW SCHEDULE							
S. NO	TYPE	SIZE	ALL LEVEL	DOOR SIZE	WINDOW / LINTEL LEVEL	REMARKS	
1.	D	2000X2500	-	-	2550	WALL WINDOW SCHEDULE	
2.	D1	2000X2500	-	-	2550	WALL WINDOW SCHEDULE	
3.	D2	1000X2500	-	-	2550	WALL WINDOW SCHEDULE	
4.	D3	1000X2500	-	-	2550	WALL WINDOW SCHEDULE	
5.	D4	1000X2500	-	-	2550	WALL WINDOW SCHEDULE	
6.	D5	800X2500	-	-	2550	WALL WINDOW SCHEDULE	
7.	D6	800X2500	-	-	2550	WALL WINDOW SCHEDULE	
8.	D7	800X2500	-	-	2550	WALL WINDOW SCHEDULE	
9.	DW1	800X2500	000	2000	3000X2	2550	LIFT SHAFT
10.	DW2	800X2500	000	2000	1000X2	2550	LIFT SHAFT
11.	DW3	4000X2500	000	2000	1000X2	2550	LIFT SHAFT
12.	DW4	3000X2500	000	2000	300X2	2550	LIFT SHAFT
13.	DW5	3000X2500	000	1000	200X1	2550	LIFT SHAFT
14.	DW6	1750X2500	000	1000	750X1	2550	LIFT SHAFT
15.	GD1	2000X2500	-	-	-	2550	WALL WINDOW SCHEDULE
16.	GDW1	1000X2500	-	2000	400X2	2550	WALL
17.	GDW2	800X2500	-	2000	300X2	2550	WALL
18.	GDW3	600X2500	-	2000	240X2	2550	WALL
19.	GDW4	600X2500	-	2000	400X1	2550	WALL
20.	GDW5	4500X2500	-	1500	1500X2	2550	WALL
21.	BDP1	2000X2500	-	-	-	2550	WALL
22.	V1	750X1500	1500	-	-	2550	WALL

PROJECT TITLE:

EKANA MALL AT
EKANA SPORTZ CITY, LUCKNOW

THIS IS TO CERTIFY THAT THIS BUILDING IS PROPOSED
AS PER THE RULES & REGULATIONS OF U.P. NAGARAJANA 2021.





SCALE: 1:200

DATE: 06-07-2018



architectural consultants pvt. ltd.
architects, engineers, planners
landscape design, interior design, & value
Office - 1st & 2nd floor, Lucknow commercial complex at
patrakar puram crossing gomtinagar, lucknow.
Dial - +91-522-2394123, 2394123, 4044123
Email id - skyline@usaahcc.com
ARCHITECTS - SANJAY & VIJAY SINHA

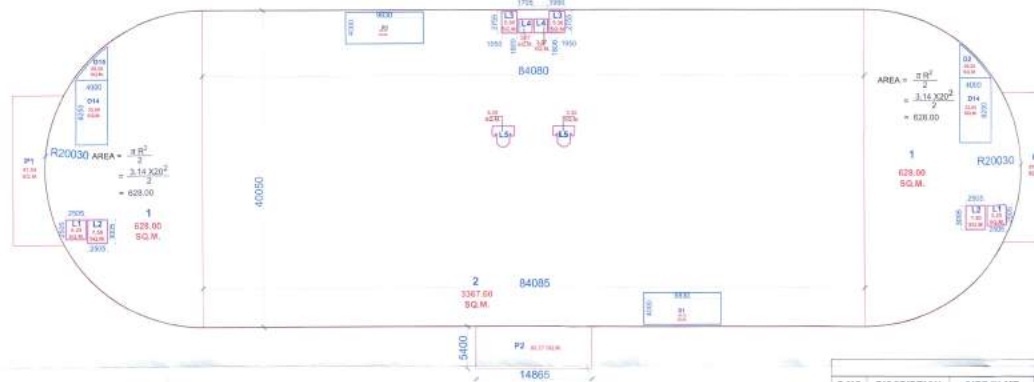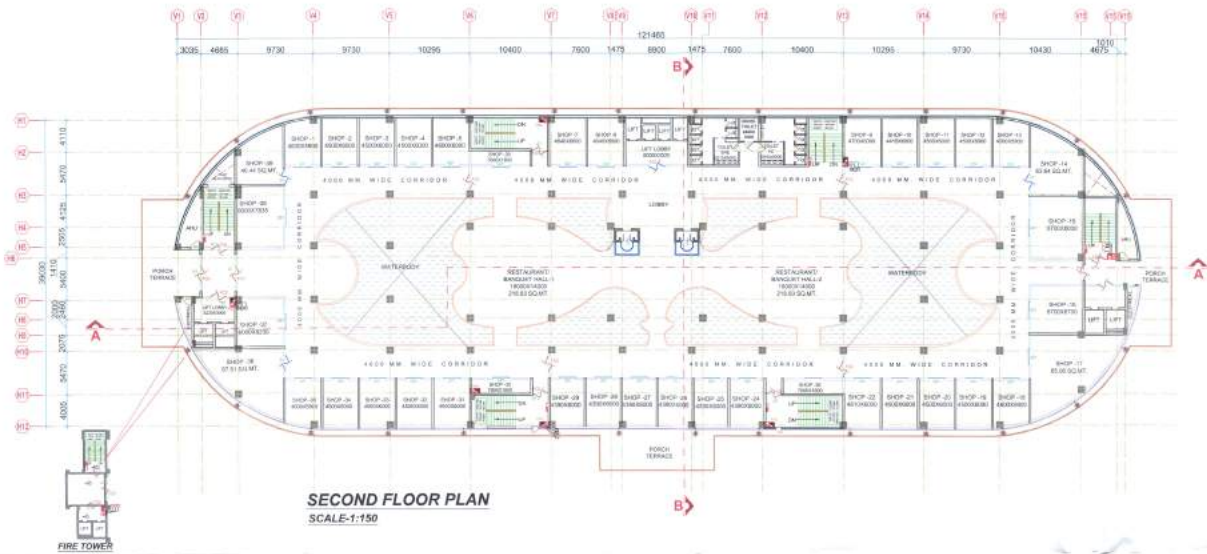

SECOND FLOOR AREA					
S.NO	DISCRIPTION	SIZE IN MT	AREA	QUANTITY	AREA IN SQMT
PROPOSED BUILDING					
1.0	1	X	X	2	1256.06
2.0	2	84.085	40.050	1	3367.60
	PORCH P1	X	X	2	153.08
	PORCH P2	14.855	5.400	1	80.27
	AREA A1				4806.68
DUCT & LIFT AREA					
1.0	L1	2.50	2.50	2	12.50
2.0	L2	2.50	3.00	2	15.00
3.0	L3	1.85	2.75	2	10.73
4.0	L4	1.71	1.80	2	6.14
5.0	L5	X	X	2	10.60
6.0	D14	4.00	8.25	2	66.00
7.0	D15	X	X	2	16.40
8.0	S1	9.83	4.00	2	78.84
	TOTAL AREA				218.00
	AREA A1 - DUCT & LIFT AREA			(4806.68 + 218.00)	5024.68
	TOTAL SECOND FLOOR AREA				4588.68 SQ.MT.

एकना मॉल परियोजना का नक्शा
जो कि एकना स्पोर्ट्स सिटी में बनाया गया है
उसके अनुसार बनाया गया है।
यह नक्शा एकाधिकार के तहत बनाया गया है।



SUBMISSION DRAWING

NORTH

SHEET NO.

8/17

DOOR / WINDOW SCHEDULE

S.NO	TYPE	SIZE	DOOR LEVEL	WINDOW LEVEL	REMARKS
1.	D	3000X2500	-	-	DOOR FRAME
2.	D1	2000X2500	-	-	DOOR FRAME
3.	D2	1500X2500	-	-	DOOR FRAME
4.	D3	1200X2500	-	-	DOOR FRAME
5.	D4	1000X2500	-	-	DOOR FRAME
6.	D5	800X2500	-	-	DOOR FRAME
7.	D6	600X2500	-	-	DOOR FRAME
8.	D7	400X2500	-	-	DOOR FRAME
9.	DW1	3000X2500	900	2000	DOOR FRAME
10.	DW2	2000X2500	900	2000	DOOR FRAME
11.	DW3	1500X2500	900	2000	DOOR FRAME
12.	DW4	1000X2500	900	2000	DOOR FRAME
13.	DW5	800X2500	900	2000	DOOR FRAME
14.	DW6	600X2500	900	2000	DOOR FRAME
15.	DW7	400X2500	900	2000	DOOR FRAME
16.	DW8	3000X2500	900	2000	DOOR FRAME
17.	DW9	2000X2500	900	2000	DOOR FRAME
18.	DW10	1500X2500	900	2000	DOOR FRAME
19.	DW11	1000X2500	900	2000	DOOR FRAME
20.	DW12	800X2500	900	2000	DOOR FRAME
21.	DW13	600X2500	900	2000	DOOR FRAME
22.	DW14	400X2500	900	2000	DOOR FRAME

PROJECT TITLE:

EKANA MALL AT
EKANA SPORTS CITY, LUCKNOW

THIS IS TO CERTIFY THAT THIS BUILDING IS PROPOSED
AS PER THE RULES & REGULATIONS OF U.P. ARCHITECTURE ACT, 1962.



SCALE:



1:200

DATE:

06-07-2018

Skyline

architectural consultant pvt. ltd.
architects, engineers, planner
landscape design, interior design, & more
Office - 1st & 2nd floor, Lucknow
patrakar puram crossing gomti nagar, lucknow,
Distt :- 91-822-2393123, 2394123, 4944123
Email id :- skyline@usabcc.com
ARCHITECTS :- SANJAY & VIJAY SINHA

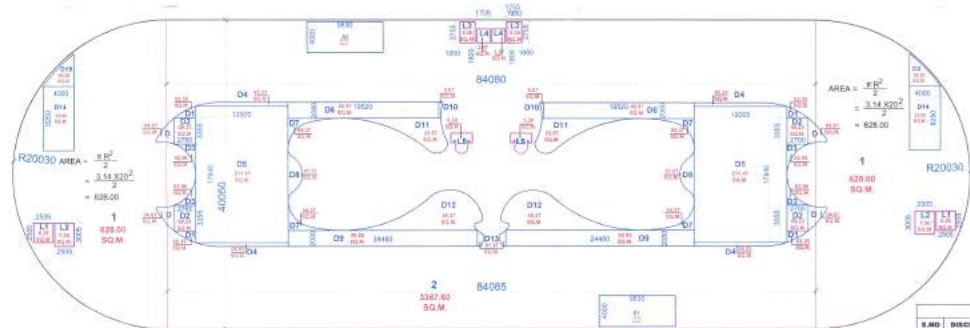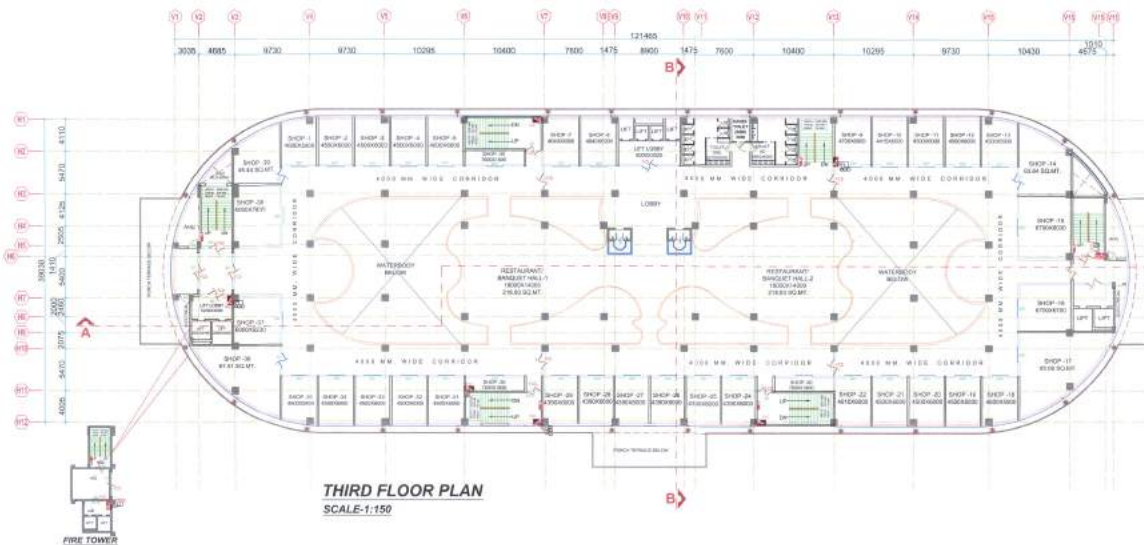

THIRD FLOOR AREA					
S.NO	DESCRIPTION	SIZE IN MT	SIZE IN MT	AREA	QUANTITY
1.0	1	X	X	628.00	2
2.0	2	94.00X	49.00X	3367.00	1
AREA A1				4000.00	
DUCT & LIFT AREA					
1.0	L1	2.50	2.50	6.25	2
2.0	L2	2.50	2.50	6.25	2
3.0	L3	1.00	1.00	1.00	2
4.0	L4	1.71	1.69	3.07	2
5.0	L5	X	X	6.25	2
6.0	D1	X	X	4.01	4
7.0	D2	X	X	2.25	4
8.0	D3	2.74	3.39	9.23	4
9.0	D4	X	X	2.25	4
10.0	D5	12.00	17.63	211.41	2
11.0	D6	10.01	2.00	40.02	2
12.0	D7	X	X	4.01	4
13.0	D8	X	X	7.01	2
14.0	D9	35.48	2.00	70.96	2
15.0	D10	X	X	0.67	2
16.0	D11	X	X	39.67	2
17.0	D12	X	X	40.02	2
18.0	D13	X	X	1.01	2
19.0	D14	4.00	8.39	33.56	2
20.0	D15	X	X	9.00	2
21.0	D16	8.83	6.90	60.93	2
22.0	D17				
TOTAL AREA				4000.00	
AREA A1 - DUCT & LIFT AREA				4000.00	
TOTAL THIRD FLOOR AREA				8000.00	

यह योजना प्रमाणित करने के लिए प्रस्तुत की गई है।
यदि इस योजना में कोई भी त्रुटि पाई जाएगी तो यह त्रुटि स्वयं की होगी।
इस योजना में कोई भी त्रुटि पाई जाएगी तो यह त्रुटि स्वयं की होगी।



SUBMISSION DRAWING

NORTH

SHEET NO.

9/17

DOOR / WINDOW SCHEDULE

S. NO	TYPE	SIZE	DOOR LEVEL	WINDOW LEVEL	UNITS	REMARKS
1.	D1	3000X2500	-	-	2500	DOOR (DOOR CASE)
2.	D2	2000X2500	-	-	2500	DOOR (DOOR CASE)
3.	D3	1500X2500	-	-	2500	DOOR (DOOR CASE)
4.	D4	1000X2500	-	-	2500	DOOR (DOOR CASE)
5.	D5	800X2500	-	-	2500	DOOR (DOOR CASE)
6.	D6	600X2500	-	-	2500	DOOR (DOOR CASE)
7.	D7	400X2500	-	-	2500	DOOR (DOOR CASE)
8.	D8	300X2500	-	-	2500	DOOR (DOOR CASE)
9.	D9	200X2500	-	-	2500	DOOR (DOOR CASE)
10.	D10	150X2500	-	-	2500	DOOR (DOOR CASE)
11.	D11	100X2500	-	-	2500	DOOR (DOOR CASE)
12.	D12	50X2500	-	-	2500	DOOR (DOOR CASE)
13.	D13	30X2500	-	-	2500	DOOR (DOOR CASE)
14.	D14	15X2500	-	-	2500	DOOR (DOOR CASE)
15.	D15	10X2500	-	-	2500	DOOR (DOOR CASE)
16.	D16	5X2500	-	-	2500	DOOR (DOOR CASE)
17.	D17	3X2500	-	-	2500	DOOR (DOOR CASE)
18.	D18	2X2500	-	-	2500	DOOR (DOOR CASE)
19.	D19	1X2500	-	-	2500	DOOR (DOOR CASE)
20.	D20	0.5X2500	-	-	2500	DOOR (DOOR CASE)
21.	D21	0.25X2500	-	-	2500	DOOR (DOOR CASE)
22.	D22	0.125X2500	-	-	2500	DOOR (DOOR CASE)

PROJECT TITLE:

EKANA MALL AT
EKANA SPORTZ CITY, LUCKNOW

THIS IS TO CERTIFY THAT THIS BUILDING IS PROPOSED
AS PER THE RULES & REGULATIONS OF MAHARAJA SARFARAZ KHAN




SCALE: 1:500



DATE: 06-07-2018

Skyline

architectural consultant pvt. ltd.
architects, engineers, planner
interior design, exterior design & urban
Office - 1st & 2nd floor, 1st main commercial complex at
patrakar puram crossing gamtinagar, lucknow,
Dist - +91-522-2393123, 2394123, 4044123
Email id: skyline@skyline.co.in
ARCHITECTS :- SANJAY & VIJAY SINHA

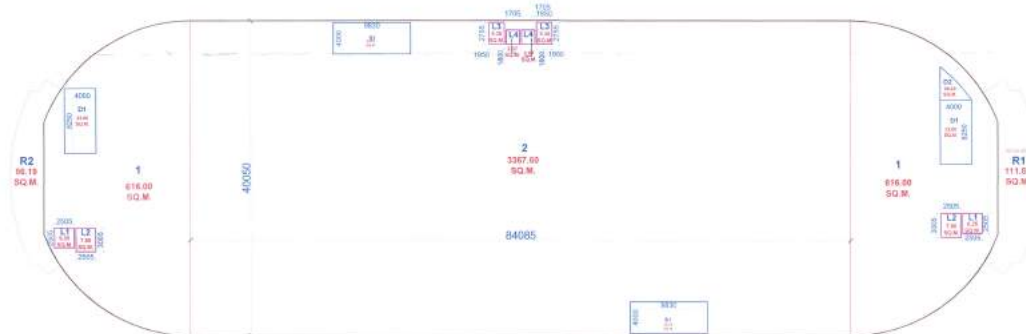

FOURTH FLOOR AREA						
S.NO	DISCRIPTION	SIZE IN MT	SIZE IN MT	AREA	QUANTITY	AREA IN SQMT
PROPOSED BUILDING						
1.0	1	X	X	616.00	2	1232.00
2.0	2	84.085	40.050	3367.60	1	3367.60
3.0	R1	X	X	111.89	1	111.89
4.0	R2	X	X	86.19	1	86.19
AREA A1						4797.68
DUCT & LIFT AREA						
1.0	L1	2.50	2.50	6.25	2	12.50
2.0	L2	2.50	3.00	7.50	2	15.00
3.0	L3	1.95	2.75	5.36	2	10.73
4.0	L4	1.71	1.80	3.07	2	6.14
5.0	D1	4.00	8.25	33.00	2	66.00
6.0	D2	X	X	9.20	1	9.20
7.0	S1	9.83	4.00	39.32	2	78.64
TOTAL AREA						198.20
AREA A1 - DUCT & LIFT AREA					(4797.68 - 198.20)	4599.48
TOTAL FOURTH FLOOR AREA						4599.48 SQ.MT.

यह योजना केवल दस्तावेज के रूप में है।
यदि इस योजना के आधार पर कोई भी कार्य
कराया जाता है तो इसके लिए जिम्मेदार
होगा।
आपका आभार



SUBMISSION DRAWING

NORTH SHEET NO.

10/17

DOOR / WINDOW SCHEDULE						
S. NO	TYPE	SIZE	DOOR LEVEL	WINDOW LEVEL	REMARKS	
1.	D	3000X2500	-	-	2500	MAIN DOOR
2.	D1	2000X2500	-	-	2500	MAIN DOOR
3.	D2	1500X2500	-	-	2500	MAIN DOOR
4.	D3	1200X2500	-	-	2500	MAIN DOOR
5.	D4	1000X2500	-	-	2500	MAIN DOOR
6.	D5	800X2500	-	-	2500	MAIN DOOR
7.	D6	600X2500	-	-	2500	MAIN DOOR
8.	D7	600X2500	-	-	2500	MAIN DOOR
9.	DW1	800X2500	800	2500	2500	MAIN DOOR
10.	DW2	500X2500	800	2500	2500	MAIN DOOR
11.	DW3	400X2500	800	2500	2500	MAIN DOOR
12.	DW4	300X2500	800	2500	2500	MAIN DOOR
13.	DW5	200X2500	800	2500	2500	MAIN DOOR
14.	DW6	1750X2500	800	2500	2500	MAIN DOOR
15.	DW7	1500X2500	-	-	2500	MAIN DOOR
16.	DW8	1000X2500	-	-	2500	MAIN DOOR
17.	DW9	800X2500	-	-	2500	MAIN DOOR
18.	DW10	600X2500	-	-	2500	MAIN DOOR
19.	DW11	400X2500	-	-	2500	MAIN DOOR
20.	DW12	300X2500	-	-	2500	MAIN DOOR
21.	DW13	200X2500	-	-	2500	MAIN DOOR
22.	DW14	1500X2500	-	-	2500	MAIN DOOR

PROJECT TITLE:

EKANA MALL AT
EKANA SPORTZ CITY, LUCKNOW



THIS IS TO CERTIFY THAT THIS BUILDING IS PROPOSED
AS PER THE RULES & REGULATIONS OF U.P. ARCHITECTURE ACT, 1962.

SIGN OF ARCHITECT
SCALE: 1:200

SIGN OF ARCHITECT
DATE: 06-07-2018



architectural consultant pvt. ltd.
architects, engineers, planners
interior design, landscape design, & value
Office - 10th & 11th floor, main varden commercial complex at
patrakar puram crossing gomtinagar, lucknow.
Dist - +91-522-2393123, 2394123, 4041123
Email id - skyline@usabhc.com
ARCHITECTS - SANJAY & VIJAY SINHA

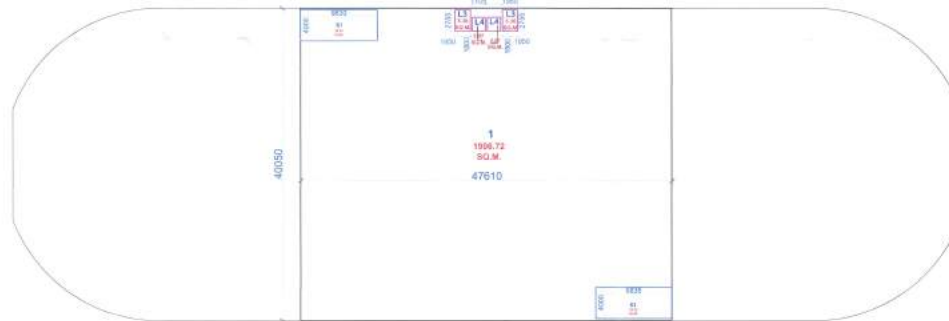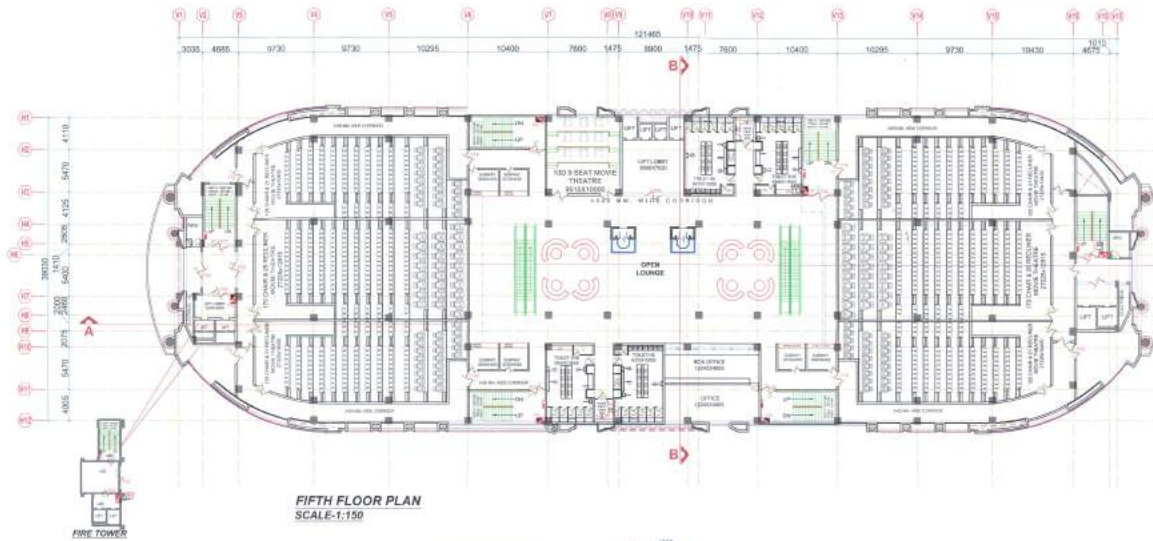

ENVELOPE PLAN OF FIFTH FLOOR
SCALE: 1:150

FIFTH FLOOR AREA						
S.NO	DISCRIPTION	SIZE IN MT	SIZE IN MT	AREA	QUANTITY	AREA IN SQMT
PROPOSED BUILDING						
1.0	1	47.61	40.05	1906.78	1	1906.78
	AREA A1					1906.78
DUCT & LIFT AREA						
1.0	L3	1.95	2.75	5.36	2	10.73
2.0	L4	1.71	1.80	3.07	2	6.14
3.0	S1	9.83	4.00	39.32	2	78.64
	TOTAL AREA					95.50
	AREA A1 - DUCT & LIFT AREA				(1906.78-95.50)	1811.28
	TOTAL FIFTH FLOOR AREA					1811.28 SQ.MT.

एक एकात्मक प्रकल्प के तहत
एक विस्तृत वाणिज्यिक इमारत की
राफ्त (P) के माध्यम से इमारत
के बाह्य स्वीकृत किया जाता है कि
विकास को नियंत्रित करने के लिए
नियमित किया जायेगा।



SUBMISSION DRAWING

NORTH

SHEET NO.

12/17

DOOR / WINDOW SCHEDULE

S. NO.	TYPE	SIZE	ALL LEVEL	DOOR SIZE	WINDOW SIZE	LEVEL	REMARKS
1.	D	2000X1500	-	-	-	2550	DOORWAY DOOR
2.	D1	2000X1500	-	-	-	2550	DOORWAY DOOR
3.	D2	1500X1250	-	-	-	2550	DOORWAY DOOR
4.	D3	1200X1500	-	-	-	2550	DOORWAY DOOR
5.	D4	1000X1250	-	-	-	2550	DOORWAY DOOR
6.	D5	800X1250	-	-	-	2550	DOORWAY DOOR
7.	D6	800X1100	-	-	-	2150	DOORWAY DOOR
8.	D7	600X1250	-	-	-	2550	DOORWAY DOOR
9.	DW1	800X1250	800	2000	1000X2	2550	DOORWAY DOOR
10.	DW2	800X1250	800	2000	1000X2	2550	DOORWAY DOOR
11.	DW3	400X1250	800	2000	1000X2	2550	DOORWAY DOOR
12.	DW4	300X1250	800	2000	1000X2	2550	DOORWAY DOOR
13.	DW5	300X1250	800	1000	2000X1	2550	DOORWAY DOOR
14.	DW6	1700X1250	800	1000	1700X1	2550	DOORWAY DOOR
15.	GD1	2000X1250	-	-	-	2550	DOORWAY DOOR
16.	GDW1	1000X1250	-	2000	4000X2	2550	DOORWAY DOOR
17.	GDW2	800X1250	-	2000	3000X2	2550	DOORWAY DOOR
18.	GDW3	800X1250	-	2000	2400X2	2550	DOORWAY DOOR
19.	GDW4	800X1250	-	2000	4000X1	2550	DOORWAY DOOR
20.	GDW5	400X1250	-	1500	1500X2	2550	DOORWAY DOOR
21.	W1	2000X1250	-	-	-	2550	DOORWAY DOOR
22.	V1	700X1500	1800	-	-	2550	DOORWAY DOOR

PROJECT TITLE:

EKANA MALL AT
EKANA SPORTZ CITY, LUCKNOW

THIS IS TO CERTIFY THAT THE BUILDING IS PROPOSED
AS PER THE RULES & REGULATIONS OF MAYAPURANA 2017.



SIGN OF LANDLORD:



SIGN OF ARCHITECT:



Skyline
architectural consultant pvt. ltd.
architects, engineers, planner
interior design, landscape design, & survey
Office - Ind & 11th floor, main verandah commercial complex at
patrakar puram crossing gomtinagar, lucknow,
Dist - +91-522-2393123, 2394123, 4044123
Email id - skyline@usehot.com
ARCHITECTS :- SANJAY & VIJAY SINHA

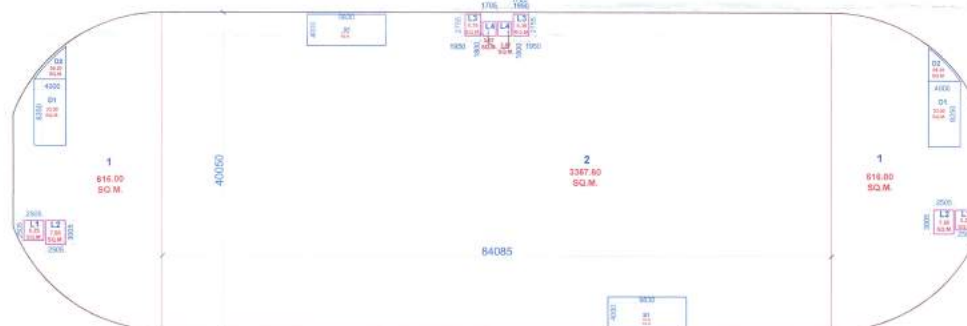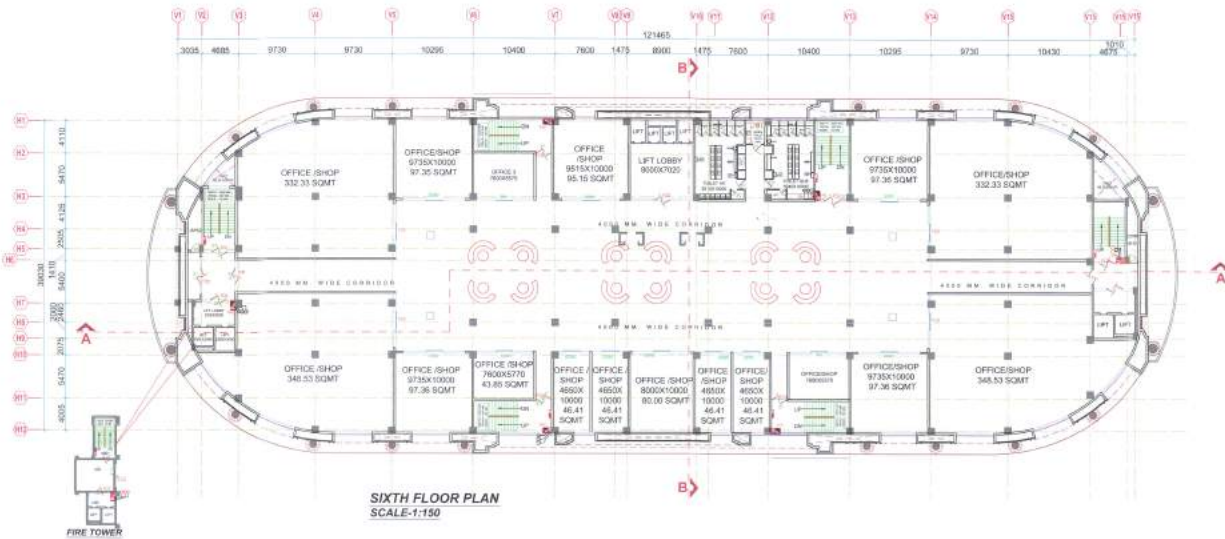

SIXTH FLOOR AREA						
S.NO	DISCRIPTION	SIZE IN MT	SIZE IN MT	AREA	QUANTITY	AREA IN SQMT
PROPOSED BUILDING						
1.0	1	X	X	616.00	2	1232.00
2.0	2	84.085	40.050	3367.60	1	3367.60
AREA A1						4599.60
DUCT & LIFT AREA						
1.0	L1	2.50	2.50	6.25	2	12.50
2.0	L2	2.50	3.00	7.50	2	15.00
3.0	L3	1.95	2.75	5.36	2	10.73
4.0	L4	1.71	1.80	3.07	2	6.14
5.0	D1	4.00	8.25	33.00	2	66.00
6.0	D2	X	X	9.20	2	18.40
7.0	S1	9.83	4.00	39.35	2.00	78.70
TOTAL AREA						207.46
AREA A1 - DUCT & LIFT AREA						4392.14
TOTAL SIXTH FLOOR AREA						4392.14 SQ.MT.

एक मॉल/शॉप इमारत बनाए जायेगा जो कि भारत के सर्वोत्तम शॉप मॉल के साथ स्पर्धा करेगा। इस मॉल का डिजाइन और निर्माण भारत के सर्वोत्तम आर्किटेक्ट और इंजीनियरों के द्वारा किया जायेगा।



SUBMISSION DRAWING

NORTH
SHEET NO. 13/17

DOOR / WINDOW SCHEDULE						
S. NO	TYPE	SIZE	SILL LEVEL	DOOR SIZE	WINDOW SIZE	REMARKS
1.	D	2000X2500	-	-	-	DOOR TO STAIR CASE
2.	D1	2000X2500	-	-	-	DOOR TO STAIR CASE
3.	D2	1500X2500	-	-	-	DOOR TO STAIR CASE
4.	D3	1200X2500	-	-	-	DOOR TO STAIR CASE
5.	D4	1000X2500	-	-	-	DOOR TO STAIR CASE
6.	D5	900X2500	-	-	-	DOOR TO STAIR CASE
7.	D6	800X2500	-	-	-	DOOR TO STAIR CASE
8.	D7	600X2500	-	-	-	DOOR TO STAIR CASE
9.	DW1	1000X1500	900	1000	1000X1500	LIFT LOBBY
10.	DW2	1000X1500	900	1000	1000X1500	LIFT LOBBY
11.	DW3	1000X1500	900	1000	1000X1500	LIFT LOBBY
12.	DW4	1000X1500	900	1000	1000X1500	LIFT LOBBY
13.	DW5	1000X1500	900	1000	1000X1500	LIFT LOBBY
14.	DW6	1000X1500	900	1000	1000X1500	LIFT LOBBY
15.	DW7	1000X1500	900	1000	1000X1500	LIFT LOBBY
16.	DW8	1000X1500	900	1000	1000X1500	LIFT LOBBY
17.	DW9	1000X1500	900	1000	1000X1500	LIFT LOBBY
18.	DW10	1000X1500	900	1000	1000X1500	LIFT LOBBY
19.	DW11	1000X1500	900	1000	1000X1500	LIFT LOBBY
20.	DW12	1000X1500	900	1000	1000X1500	LIFT LOBBY
21.	DW13	1000X1500	900	1000	1000X1500	LIFT LOBBY
22.	WT	750X1500	1500	-	-	WALL

PROJECT TITLE:

EKANA MALL AT
EKANA SPORTZ CITY, LUCKNOW

THIS IS TO CERTIFY THAT THIS BUILDING IS PROPOSED
AS PER THE RULES & REGULATIONS OF U.P. ARCHITECTURE ACT, 1962.

SIGN OF LANDSCAPER
SCALE: 1:200

SIGN OF ARCHITECT
DATE: 06-07-2018

Skyline
architectural consultant pvt. ltd.
architects, engineers, planner
interior design, landscape design & survey
Office - 1st & 2nd floor, Varanasi Commercial Complex at
patrakar puram crossing gomti nagar, lucknow.
Dist :- +91-522-2393123, 2394123, 4044123
Email id - skyline@usahcc.com
ARCHITECTS :- SANJAY & VIJAY SINHA



architectural consultant pvt. ltd.
architects, engineers, planner
landscape design, interior design, & value
Office - 11nd & 11rd floor 11xmi varden commercial complex at
patrakar puram crossing gomtinagar, lucknow,
Dist - +91-522-2393123, 2394123, 4044123
Email Id - skyline@usahcc.com
ARCHITECTS - JI SANJAY & VIJAY SINHA

SUBMISSION DRAWING

NORTH

SHEET NO.

15/17


DOOR / WINDOW SCHEDULE

S. NO.	TYPE	SIZE	ILL. LEVEL	DOOR SIZE	WINDOW SIZE	UNIT/L. LEVEL	REMARKS
1.	D1	3000X2550	-	-	-	2550	MAIN ENTRANCE DOOR
2.	D1	2000X2550	-	-	-	2550	IF MAIN ENTRANCE
3.	D2	1500X2550	-	-	-	2550	PROPERTY DOOR
4.	D3	1500X2550	-	-	-	2550	STAIRS TO SUBTERRANEAN
5.	D4	1500X2550	-	-	-	2550	STAIRS TO ROOF
6.	D5	1800X2550	-	-	-	2550	TOOTH MACHINE ROOM
7.	D6	1800X2100	-	-	-	2100	W.C. DOOR
8.	D7	600X2550	-	-	-	2550	W.C.
9.	DW1	800X2550	800	2000	2400X2	2550	TOOTH MACHINE ROOM
10.	DW2	500X2550	800	2000	1000X2	2550	TOOTH MACHINE ROOM
11.	DW3	400X2550	800	2000	1000X2	2550	TOOTH MACHINE ROOM
12.	DW4	300X2550	800	2000	900X2	2550	TOOTH MACHINE ROOM
13.	DW5	200X2550	800	1000	2000X1	2550	STAIRS TO SUBTERRANEAN
14.	DW6	1700X2550	800	1500	700X1	2550	STAIRS TO SUBTERRANEAN
15.	GD1	2000X2550	-	-	-	2550	STAIRS TO SUBTERRANEAN
16.	GDW1	1000X2550	-	3000	4000X2	2550	STAIRS
17.	GDW2	800X2550	-	2000	3000X2	2550	STAIRS
18.	GDW3	600X2550	-	2000	2400X2	2550	STAIRS
19.	GDW4	600X2550	-	2000	4000X1	2550	STAIRS
20.	GDW5	400X2550	-	1500	1000X2	2550	STAIRS
21.	SPD1	2000X2550	-	-	-	2550	STAIRS
22.	V1	750X1900	1500	-	-	2550	W.C.

नगर विकास विभाग के माध्यम से
नगर विकास विभाग के माध्यम से
नगर विकास विभाग के माध्यम से
नगर विकास विभाग के माध्यम से
नगर विकास विभाग के माध्यम से



TERRACE FLOOR PLAN
SCALE-1:150

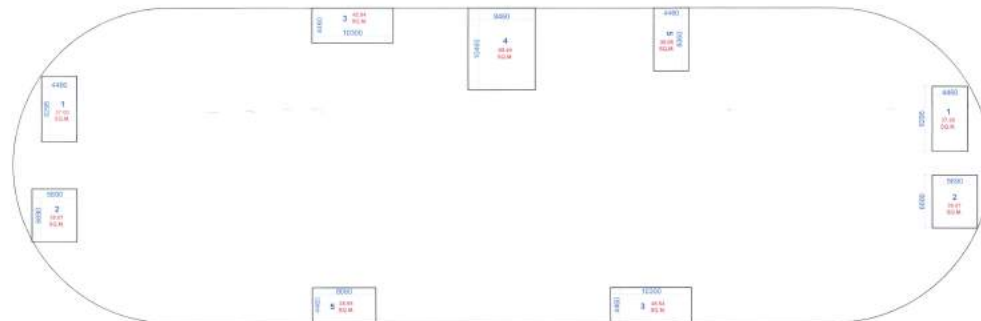

ENVELOPE PLAN OF TERRACE FLOOR MUMTY & MACHINE ROOM
SCALE-1:150

TERRACE FLOOR AREA MUMTY & MACHINE ROOM					
S.NO.	DISCRIPTION	SIZE IN MT	SIZE IN MT	AREA	QUANTITY
1.0	1	4.46	8.30	37.00	2
2.0	2	5.89	6.69	38.07	2
3.0	3	10.30	4.46	45.94	2
4.0	4	8.46	10.46	88.49	1
5.0	5	8.06	4.46	35.95	2
TOTAL AREA					402.39
TOTAL TERRACE FLOOR AREA					402.39 SQ.MT.



ENVELOPE PLAN OF TERRACE FLOOR ROOF TOP RESTAURANT (SKY BAR)
SCALE-1:150

ROOF TOP RESTAURANT (SKY BAR)					
S.NO.	DISCRIPTION	SIZE IN MT	SIZE IN MT	AREA	QUANTITY
1.0	1	22.155	14.325	317.37	2
2.0	2	59.610	8.154	486.06	1
TOTAL AREA					1120.80
TOTAL SKY BAR AREA					1120.80

PROJECT TITLE:

EKANA MALL AT
EKANA SPORTS CITY, LUCKNOW

THIS IS TO CERTIFY THAT THIS BUILDING IS PROPOSED
AS PER THE RULES & REGULATIONS OF U.P. BUILDING ACT, 1961.

SIGN OF LANDLORD

SIGN OF ARCHITECT




SCALE:-
1:200

DATE:-
06-07-2018

Skyline

architectural consultant pvt. ltd.
architects, engineers, planner
interior design, exterior design, & value
Office :- 1st & 2nd floor, Laxmi Vardan Commercial Complex of
patrakar puram crossing gomtinagar, lucknow,
Dist :- +91-622-2393123, 2394123, 4044123
Email id :- skyline@vsnl.com
ARCHITECTS :- SANJAY & VIJAY SINHA

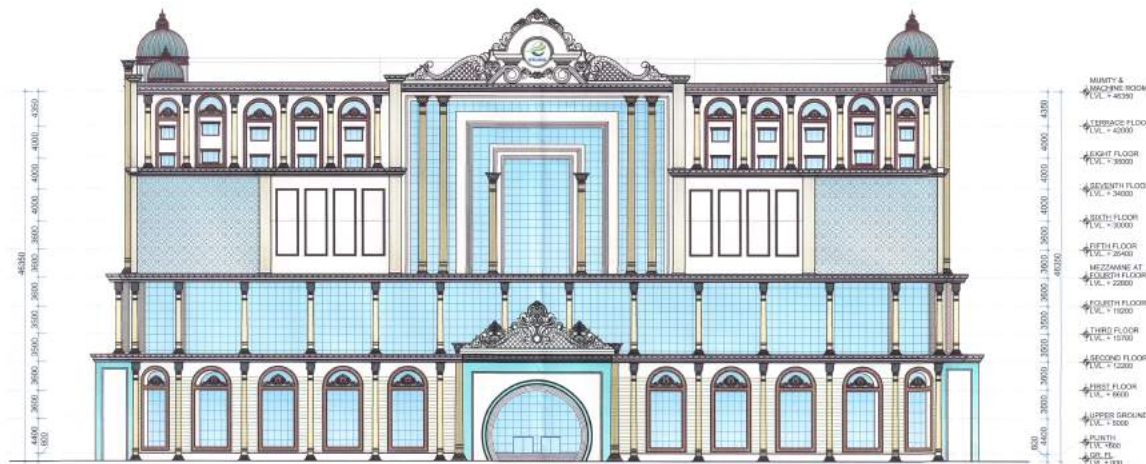

FRONT ELEVATION
SCALE: 1/100



SIDE ELEVATION
SCALE: 1/100

SUBMISSION DRAWING

NORTH

SHEET NO.

16/17

महानगरपालिका क्षेत्र विकास
और विकास विभाग (सिटी) को
कार्यालय भवनको लागि प्रस्तावित
समावेशी विकास योजनाको
आवक्यता अध्ययन प्रतिवेदनको
आधारमा तयार पारिएको छ।



DOOR / WINDOW SCHEDULE

S. NO.	TYPE	SIZE	SHILL LEVEL	DOOR SIZE	WINDOW SIZE	INTEL LEVEL	REMARKS
1.	D1	2000X2500	-	-	-	2550	MAIN ENTRANCE DOOR
2.	D1	2000X2500	-	-	-	2550	MAIN ENTRANCE DOOR
3.	D2	1500X2500	-	-	-	2550	MAIN ENTRANCE DOOR
4.	D3	1500X2500	-	-	-	2550	MAIN ENTRANCE DOOR
5.	D4	1000X2500	-	-	-	2550	MAIN ENTRANCE DOOR
6.	D5	900X2500	-	-	-	2550	MAIN ENTRANCE DOOR
7.	D6	800X2500	-	-	-	2550	MAIN ENTRANCE DOOR
8.	D7	800X2500	-	-	-	2550	MAIN ENTRANCE DOOR
9.	DW1	1500X2500	800	2000	3000X2500	2550	MAIN ENTRANCE DOOR
10.	DW2	1500X2500	800	2000	3000X2500	2550	MAIN ENTRANCE DOOR
11.	DW3	1500X2500	800	2000	3000X2500	2550	MAIN ENTRANCE DOOR
12.	DW4	1500X2500	800	2000	3000X2500	2550	MAIN ENTRANCE DOOR
13.	DW5	1500X2500	800	2000	3000X2500	2550	MAIN ENTRANCE DOOR
14.	DW6	1500X2500	800	2000	3000X2500	2550	MAIN ENTRANCE DOOR
15.	GD1	2000X2500	-	-	-	2550	MAIN ENTRANCE DOOR
16.	GDW1	1500X2500	-	2000	4000X2500	2550	MAIN ENTRANCE DOOR
17.	GDW2	1500X2500	-	2000	4000X2500	2550	MAIN ENTRANCE DOOR
18.	GDW3	1500X2500	-	2000	4000X2500	2550	MAIN ENTRANCE DOOR
19.	GDW4	1500X2500	-	2000	4000X2500	2550	MAIN ENTRANCE DOOR
20.	GDW5	1500X2500	-	2000	4000X2500	2550	MAIN ENTRANCE DOOR
21.	GDW6	1500X2500	-	2000	4000X2500	2550	MAIN ENTRANCE DOOR
22.	V1	1500X2500	-	-	-	2550	MAIN ENTRANCE DOOR

PROJECT TITLE:

EKANA MALL AT
EKANA SPORTZ CITY, LUCKNOW

THIS IS TO CERTIFY THAT THIS BUILDING IS PROPOSED
AS PER THE RULES & REGULATIONS OF MHA/UDANA 2021.



SCALE: 1/200

DATE: 06-07-2018

Skyline

architectural consultant pvt. ltd.
architects, engineers, planner
interior design, landscape design, & urban design
Office - 1st & 2nd floor, Laxmi Vardan Commercial Complex at
patrakar, puram crossing gemtinaagar, lucknow,
Dist - +91-522-2393123, 2394123, 4844123
Email id - skyline@usahoc.com
ARCHITECTS -- SANJAY & VIJAY SINHA

SUBMISSION DRAWING

NORTH

SHEET NO.

17/17

यह दस्तावेज तभी ही लागू होगा जबकि
यदि किसी भी कारणवश इसे किसी भी
कारण से बदलने की आवश्यकता पड़ेगी तो
इस दस्तावेज के बिना कार्य नहीं किया जायेगा
किसी भी कारणवश यदि किसी भी
कारण से इसे किसी भी कारणवश
नहीं किया जायेगा



DOOR / WINDOW SCHEDULE

S. NO	TYPE	SIZE	DOOR LEVEL	WINDOW LEVEL	REMARKS
1.	D	3000X2550	-	-	MAIN ENTRANCE
2.	D1	2000X2550	-	-	MAIN ENTRANCE
3.	D2	1800X2550	-	-	MAIN ENTRANCE
4.	D3	1200X2550	-	-	MAIN ENTRANCE
5.	D4	1000X2550	-	-	MAIN ENTRANCE
6.	D5	800X2550	-	-	MAIN ENTRANCE
7.	D6	600X2550	-	-	MAIN ENTRANCE
8.	D7	400X2550	-	-	MAIN ENTRANCE
9.	DW1	800X1250	900	2600	STAIR CASE
10.	DW2	800X1250	900	2600	STAIR CASE
11.	DW3	800X1250	900	2600	STAIR CASE
12.	DW4	800X1250	900	2600	STAIR CASE
13.	DW5	800X1250	900	2600	STAIR CASE
14.	DW6	800X1250	900	2600	STAIR CASE
15.	DW7	800X1250	900	2600	STAIR CASE
16.	DW8	800X1250	900	2600	STAIR CASE
17.	DW9	800X1250	900	2600	STAIR CASE
18.	DW10	800X1250	900	2600	STAIR CASE
19.	DW11	800X1250	900	2600	STAIR CASE
20.	DW12	800X1250	900	2600	STAIR CASE
21.	DW13	800X1250	900	2600	STAIR CASE
22.	DW14	800X1250	900	2600	STAIR CASE

PROJECT TITLE:

EKANA MALL AT
EKANA SPORTS CITY, LUCKNOW

THIS IS TO CERTIFY THAT THIS BUILDING IS PROPOSED
AS PER THE RULES & REGULATIONS OF MAHARAJA 2021.

SIGN OF LANDLORD:



SIGN OF ARCHITECT:




SCALE ISO-A1

DATE: 06-07-2018




architectural consultant pvt. ltd.
architects, engineers, planner
landscape architect, interior design, & services
Office : 1st & 2nd floor, main road, commercial complex at
patel nagar puram crossing gomti nagar, lucknow,
Distt - +91-522-2393123, 2394123, 4044123
Email id - skyline@ushce.com
ARCHITECTS - SANJAY & VIJAY SINHA

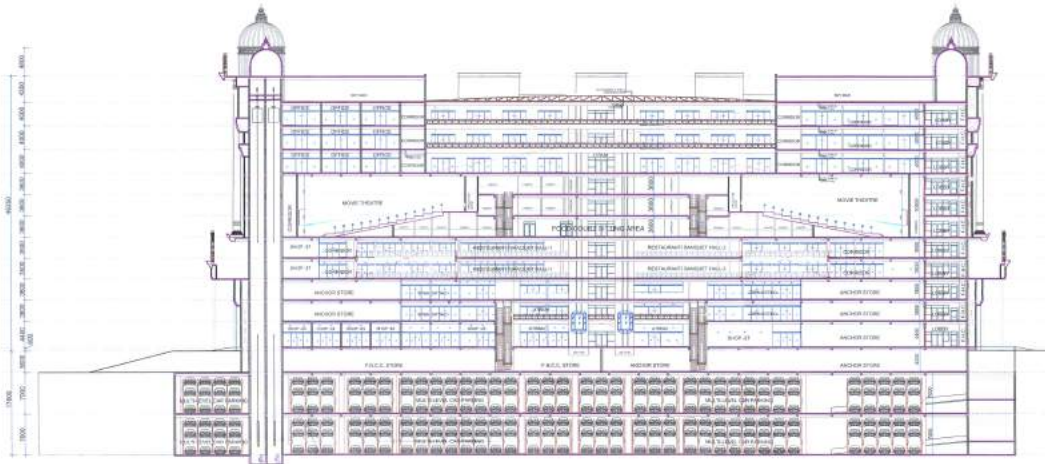

SECTION A-A'
SCALE: 1/250



SECTION B-B'
SCALE: 1/200

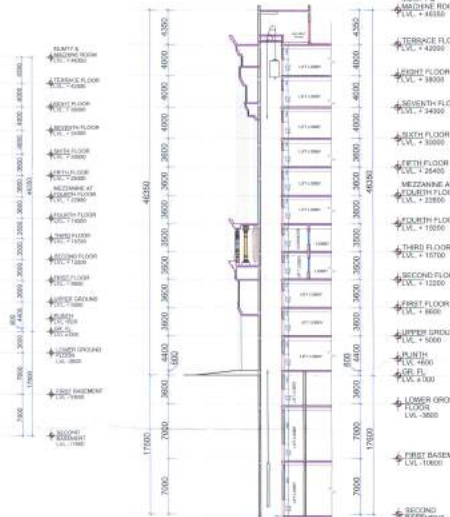

DETAIL OF LIFT
SCALE: 1/100



PLAN OF LIFT
SCALE: 1/250

