
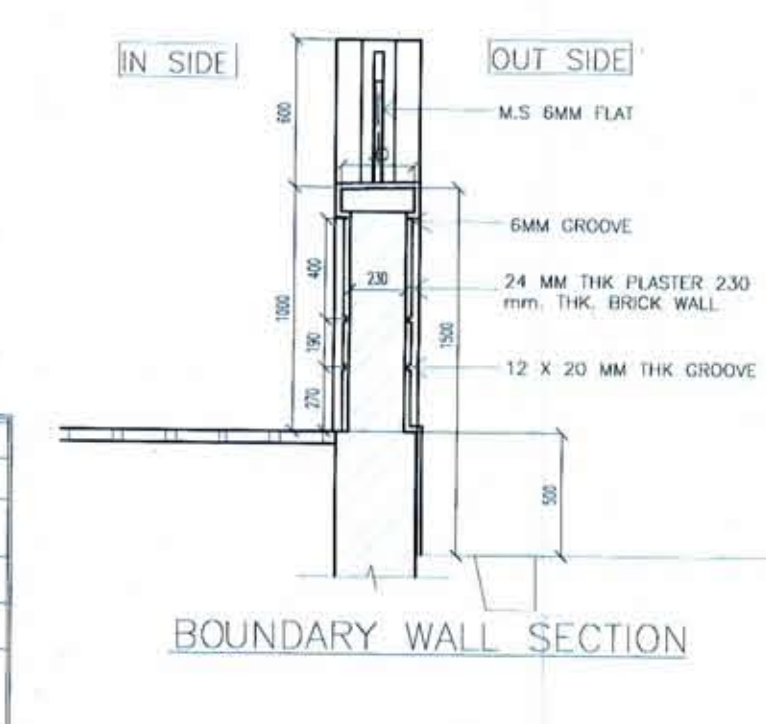
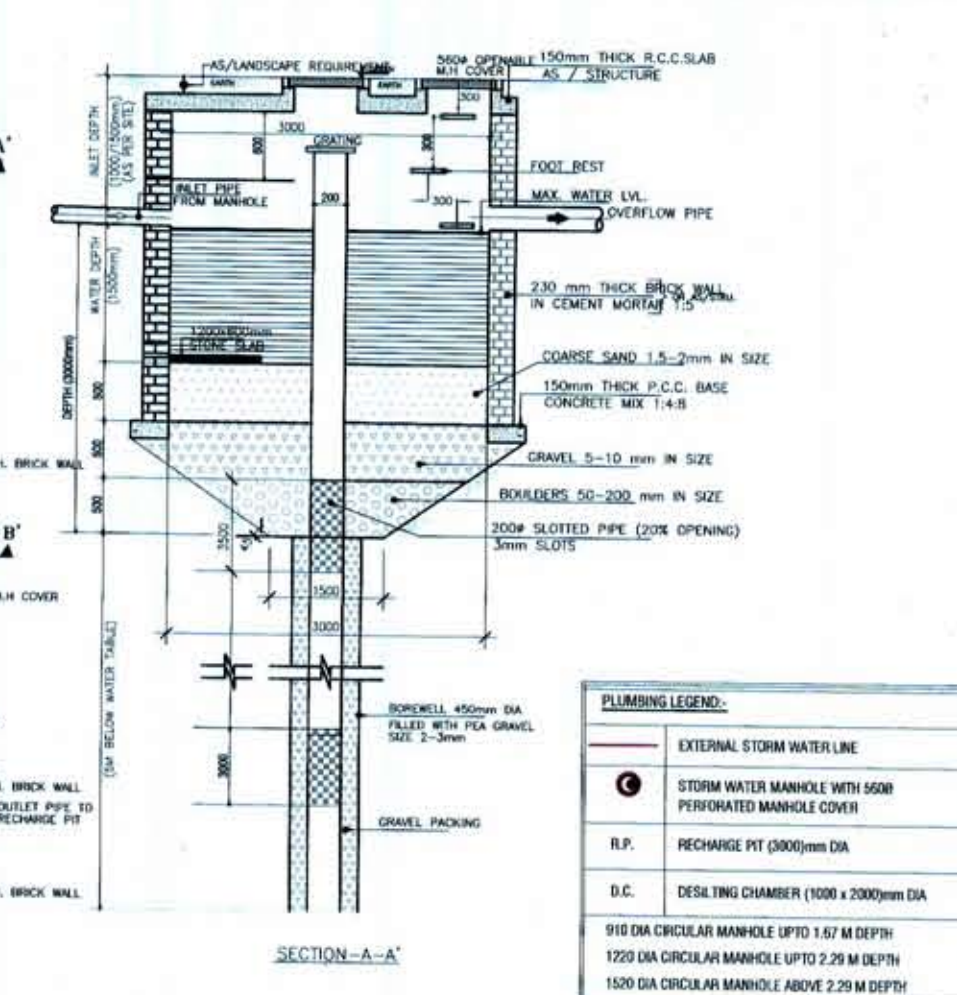
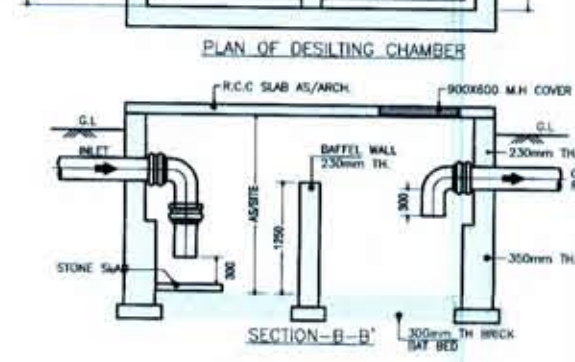
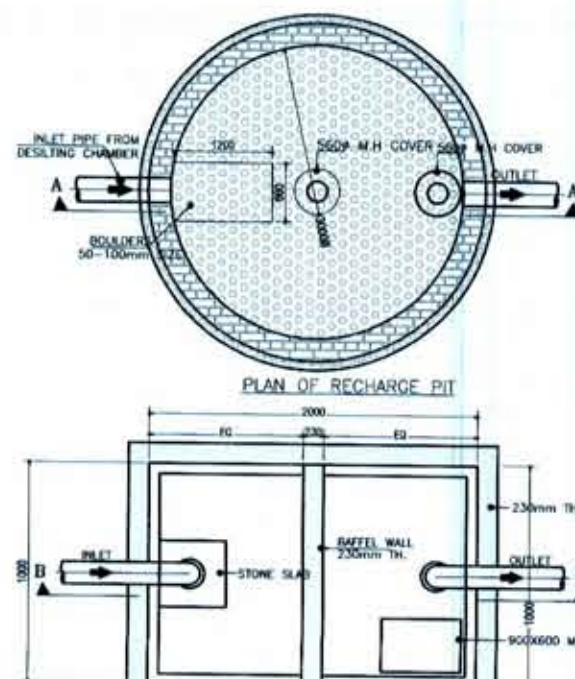


S.NO	DESCRIPTION	NO.	SYMBOL
1.	Ficus religiosa	78	
2.	Cassia siamea	78	
3.	Roystonea regia	79	



LEGEND
— SET BACK LINE
— BASEMENT LINE

60.0 M Wide Road

24.0 M Wide Road

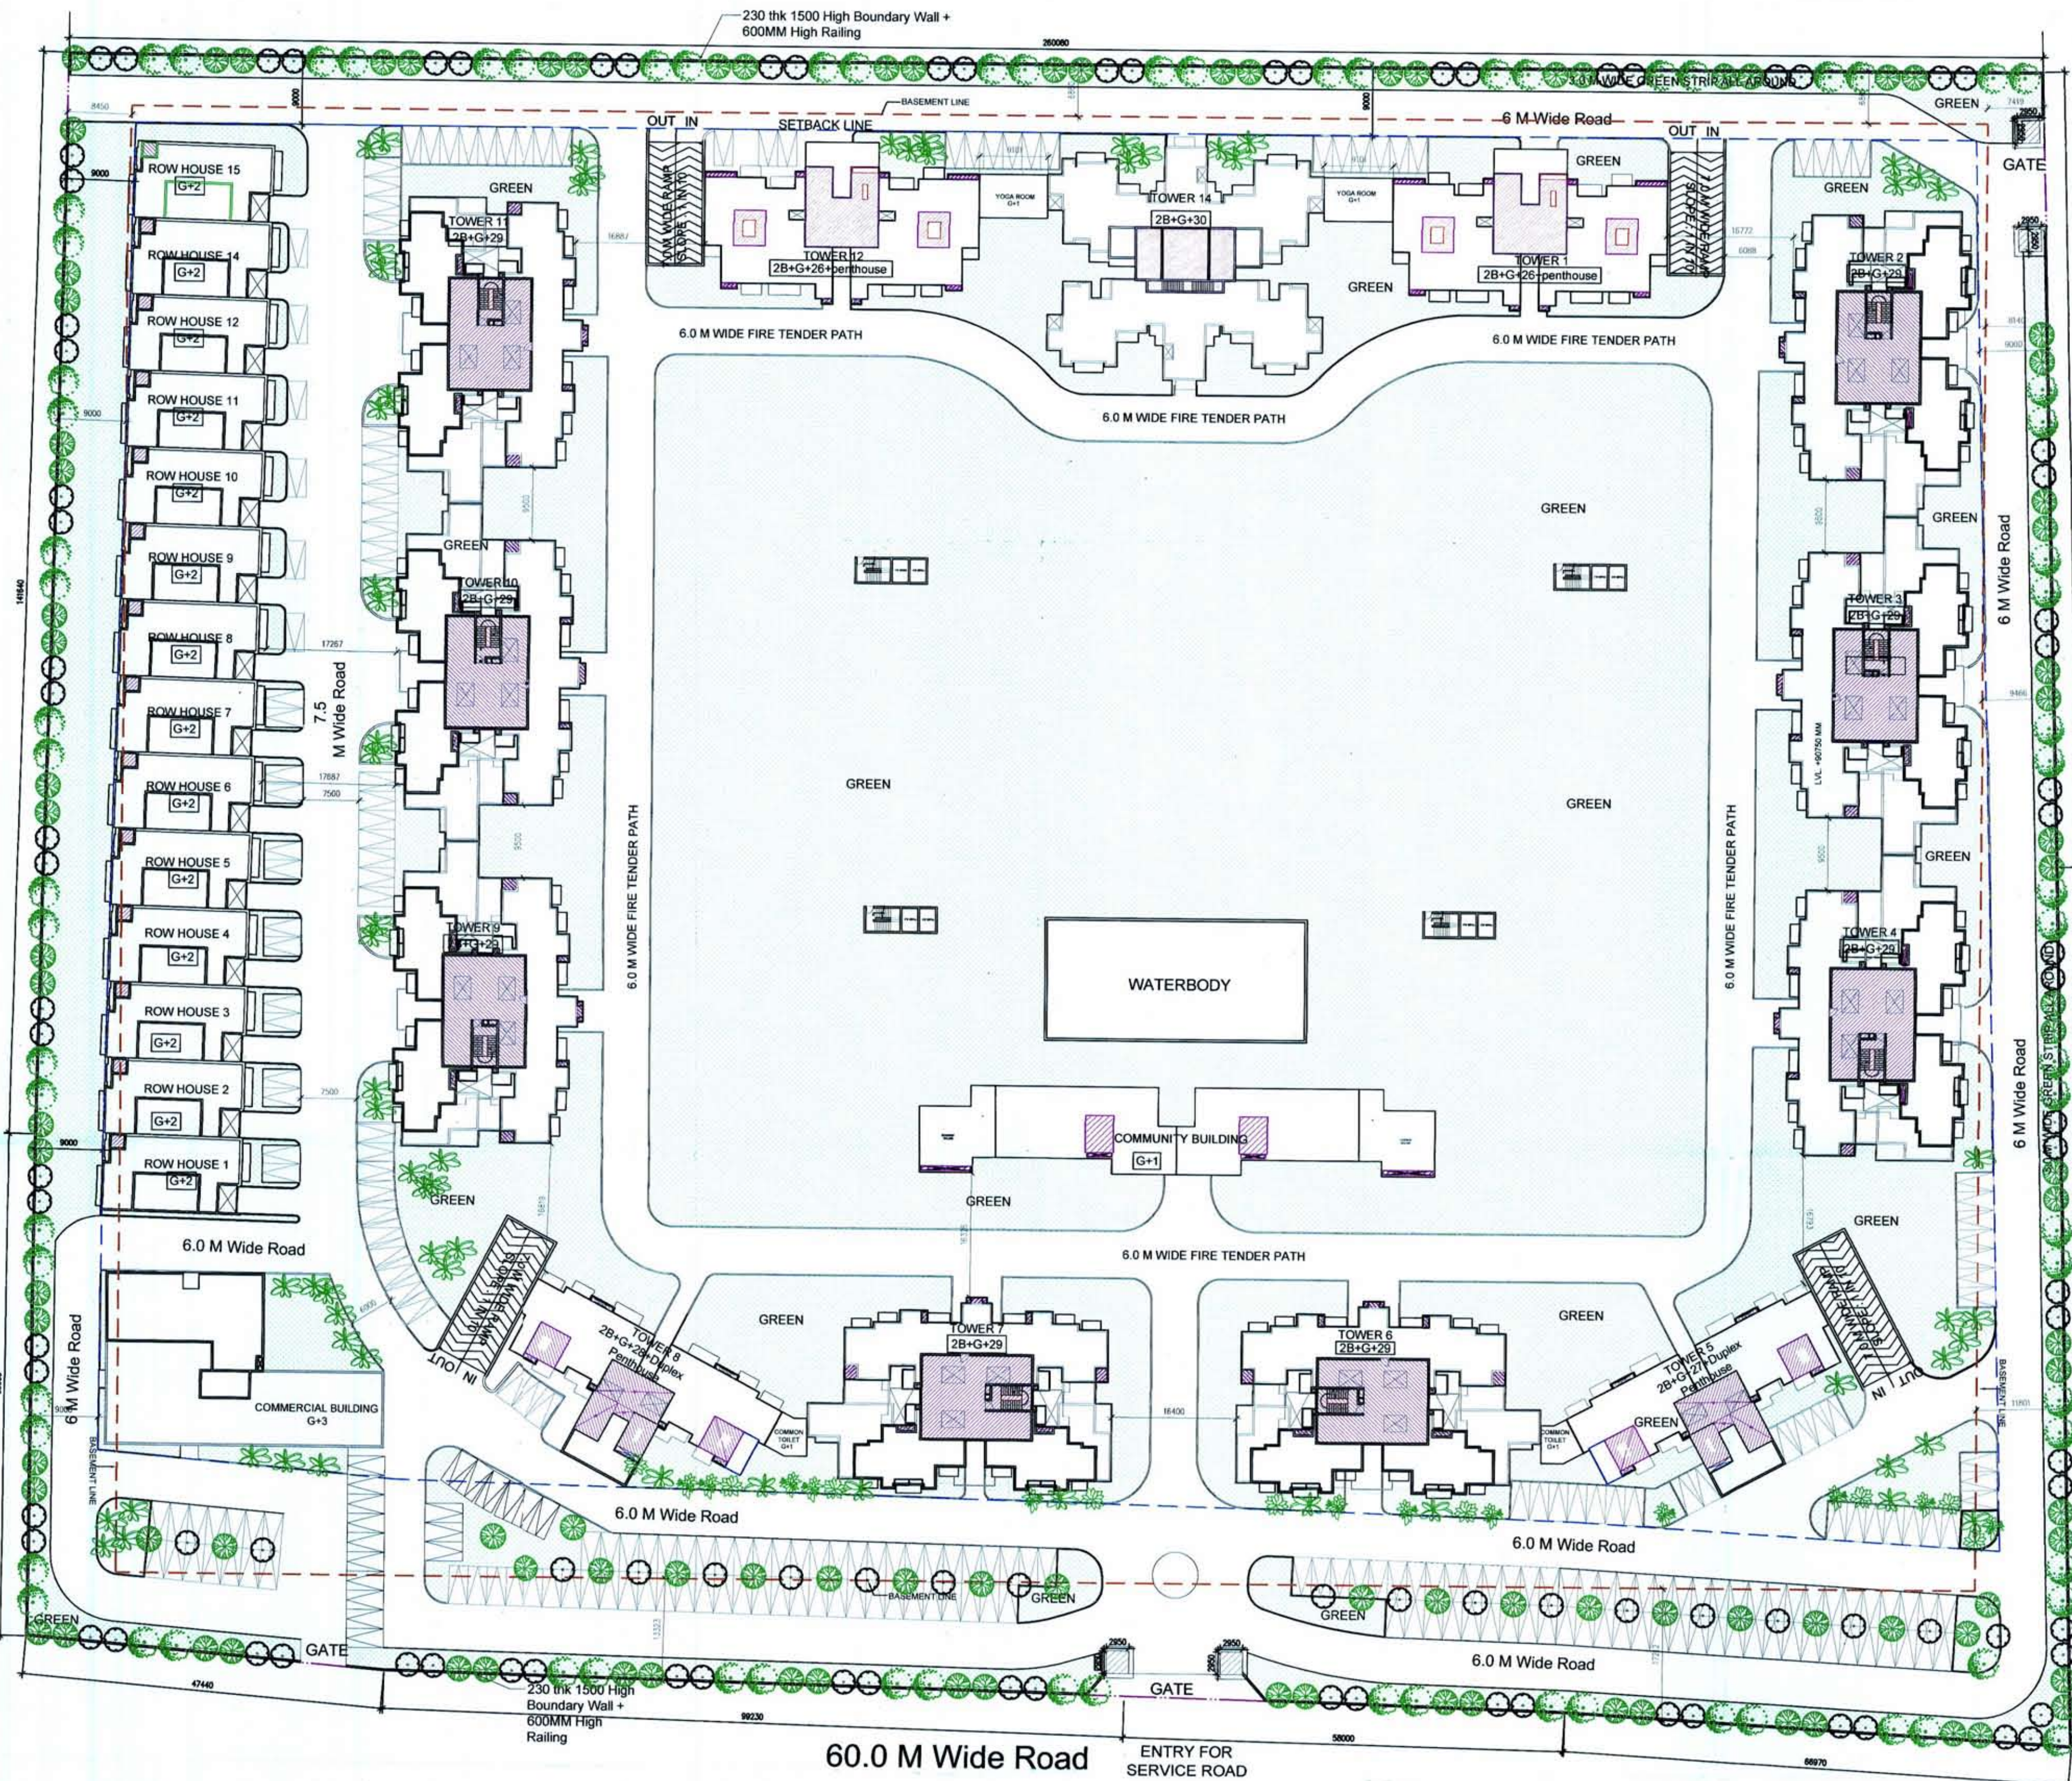

PLUMBING LEGEND:
EXTERNAL STORM WATER LINE
STORM WATER MANHOLE WITH NON PERFORATED MANHOLE COVER
R.P. RECHARGE PIT (2000mm DIA)
D.C. DETAILING CHAMBER (1000 x 2000mm DIA)
910 DIA CIRCULAR MANHOLE (UP TO 1.50 M DEPTH)
1200 DIA CIRCULAR MANHOLE (UP TO 2.25 M DEPTH)
1500 DIA CIRCULAR MANHOLE (ABOVE 2.25 M DEPTH)

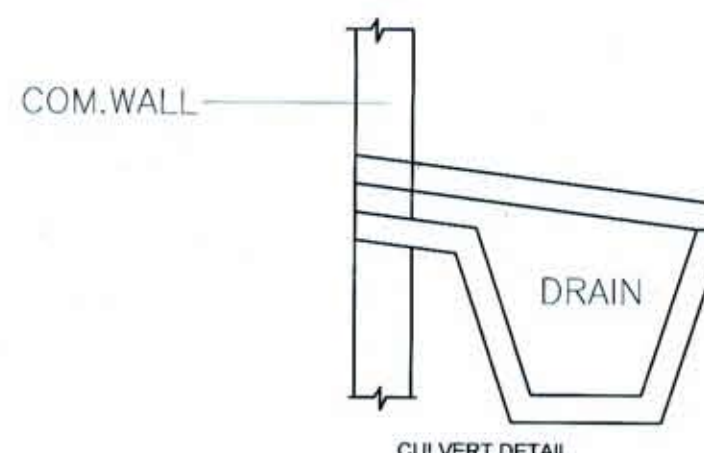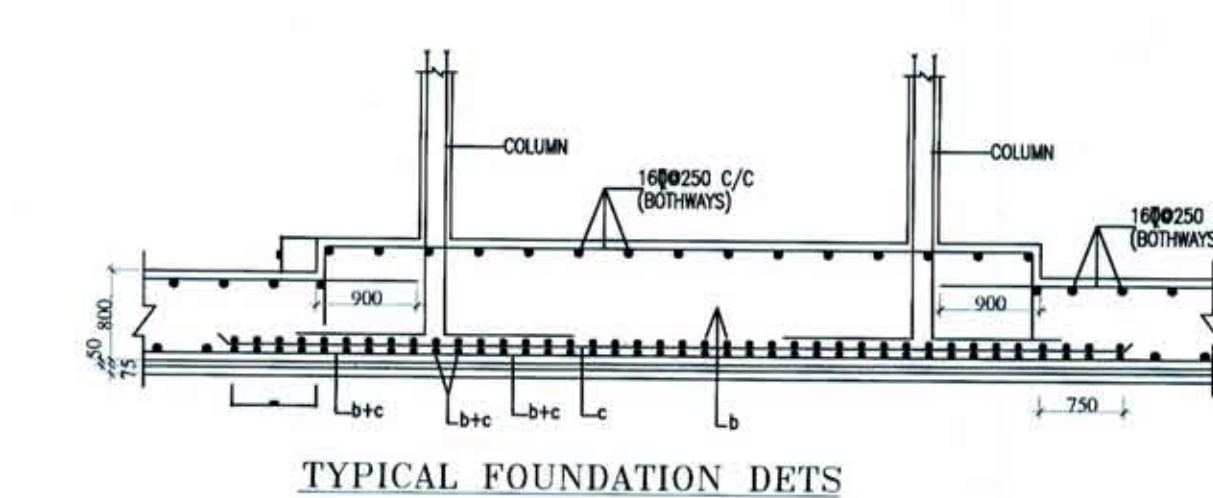

NO.	DESCRIPTION	UNIT	QTY
1	PERMISSIBLE 15% FOR FACILITY OF TOTAL F.A.R. AREA	15.00%	29748.815
2	PERMISSIBLE 15% FOR FACILITY OF TOTAL F.A.R. AREA	15.00%	29748.815
3	PERMISSIBLE 15% FOR FACILITY OF TOTAL F.A.R. AREA	15.00%	29748.815
4	PERMISSIBLE 15% FOR FACILITY OF TOTAL F.A.R. AREA	15.00%	29748.815
5	PERMISSIBLE 15% FOR FACILITY OF TOTAL F.A.R. AREA	15.00%	29748.815
6	PERMISSIBLE 15% FOR FACILITY OF TOTAL F.A.R. AREA	15.00%	29748.815
7	PERMISSIBLE 15% FOR FACILITY OF TOTAL F.A.R. AREA	15.00%	29748.815
8	PERMISSIBLE 15% FOR FACILITY OF TOTAL F.A.R. AREA	15.00%	29748.815
9	PERMISSIBLE 15% FOR FACILITY OF TOTAL F.A.R. AREA	15.00%	29748.815
10	PERMISSIBLE 15% FOR FACILITY OF TOTAL F.A.R. AREA	15.00%	29748.815
11	PERMISSIBLE 15% FOR FACILITY OF TOTAL F.A.R. AREA	15.00%	29748.815
12	PERMISSIBLE 15% FOR FACILITY OF TOTAL F.A.R. AREA	15.00%	29748.815
13	PERMISSIBLE 15% FOR FACILITY OF TOTAL F.A.R. AREA	15.00%	29748.815
14	PERMISSIBLE 15% FOR FACILITY OF TOTAL F.A.R. AREA	15.00%	29748.815
15	PERMISSIBLE 15% FOR FACILITY OF TOTAL F.A.R. AREA	15.00%	29748.815
16	PERMISSIBLE 15% FOR FACILITY OF TOTAL F.A.R. AREA	15.00%	29748.815
17	PERMISSIBLE 15% FOR FACILITY OF TOTAL F.A.R. AREA	15.00%	29748.815
18	PERMISSIBLE 15% FOR FACILITY OF TOTAL F.A.R. AREA	15.00%	29748.815
19	PERMISSIBLE 15% FOR FACILITY OF TOTAL F.A.R. AREA	15.00%	29748.815
20	PERMISSIBLE 15% FOR FACILITY OF TOTAL F.A.R. AREA	15.00%	29748.815
21	PERMISSIBLE 15% FOR FACILITY OF TOTAL F.A.R. AREA	15.00%	29748.815
22	PERMISSIBLE 15% FOR FACILITY OF TOTAL F.A.R. AREA	15.00%	29748.815

REVISED SUBMISSION DRAWING

OWNER:

M/s DOMUS GREENS PVT. LTD.
711/92, Deepali, Nehru Place,
New Delhi - 110019

PROJECT:

PROPOSED GROUP HOUSING AT
PLOT NO. 12A, SECTOR - ZETA -01
GREATER NOIDA

SHEET TITLE

SITE PLAN

ARCHITECT'S SIGNATURE

MANISH KUMAR GUPTA
CA/2008/43599

TOWN PLANNER'S SIGNATURE

PRABHLEEN SINGH SAGGU
CA/2008/43599, AITP-2013-009

OWNER'S SIGNATURE

For Domus Greens Pvt. Ltd.
[Signature]
Authorised Signatory

DEALT BY

CHECKED BY

SCALE -

1:500 @ A1

DATE - 13/02/2014

NORTH

N

N