

PROJECT :- PROPOSED I.T. PARK AT PLOT No. - 17 SECTOR K.P. - V GREATER NOIDA

BUILDERS & PROMOTER :- M/S S.K.V. INFOTECH PVT. LTD. NEW DELHI - 110048

DRAWING TITLE :- TOWER A,B & C 2nd FLOOR PLAN

ADVERTISERS :- Space Designers International Architects Pvt. Ltd. 5/1366, VASANT VIHAR, NEW DELHI - 110028

SCALE :- 1/200

DATE :- 12/05/2011



FOR SKV Infotech Private Limited
Authorised Signatory

OWNERS SIGN

ARCHITECTS SIGN

DRG. NO. - 12

LEGEND

INSTITUTIONAL F.A.R.	
I.T. F.A.R.	

NOTE :-

- ANY HABITABLE ROOM, TOILET, KITCHEN NOT MECHANICALLY VENTILATED ARE MECHANICALLY VENTILATED
- FIRE ESCAPE STAIR CASE IS PRESSURIZED
- TYPE AS PER N.B.C.

POPULATION & PERSONAL LOAD :-
 - 25 PERSONS PER SUITE / 15 PERSONS PER TOILET / 10 PERSONS PER RESTAURANT / 10 PERSONS PER KITCHEN / 10 PERSONS PER LIFT LOBBY


REFUGER AREA

SE (Planning)

Drawings Checked & Validated By (Planner)


By (Manager)

12/05/2011

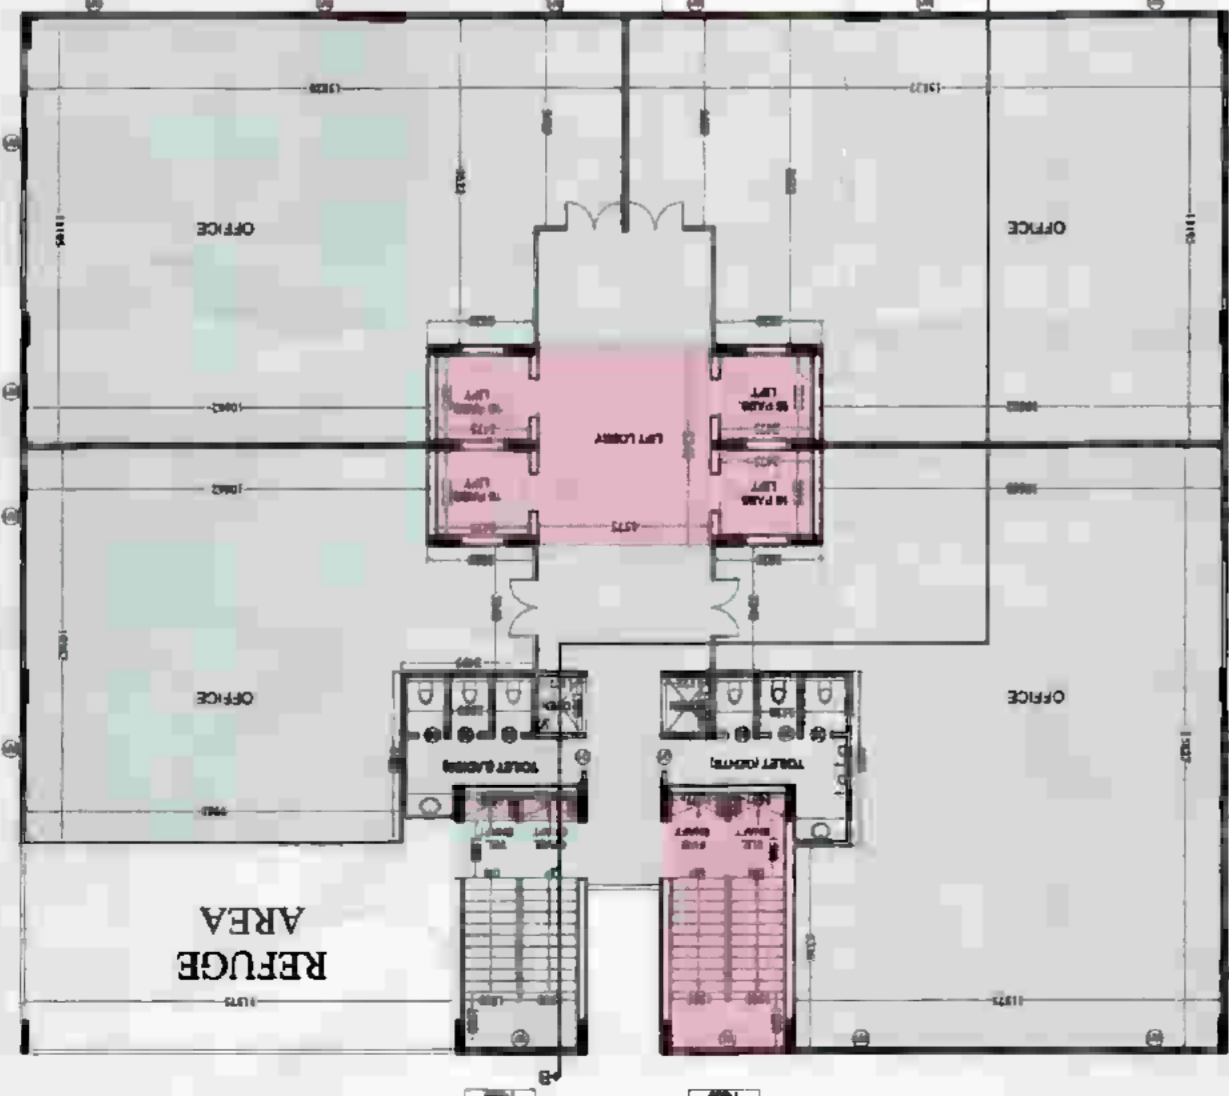


TOWER-B
2nd FLOOR PLAN

ELEVATION B

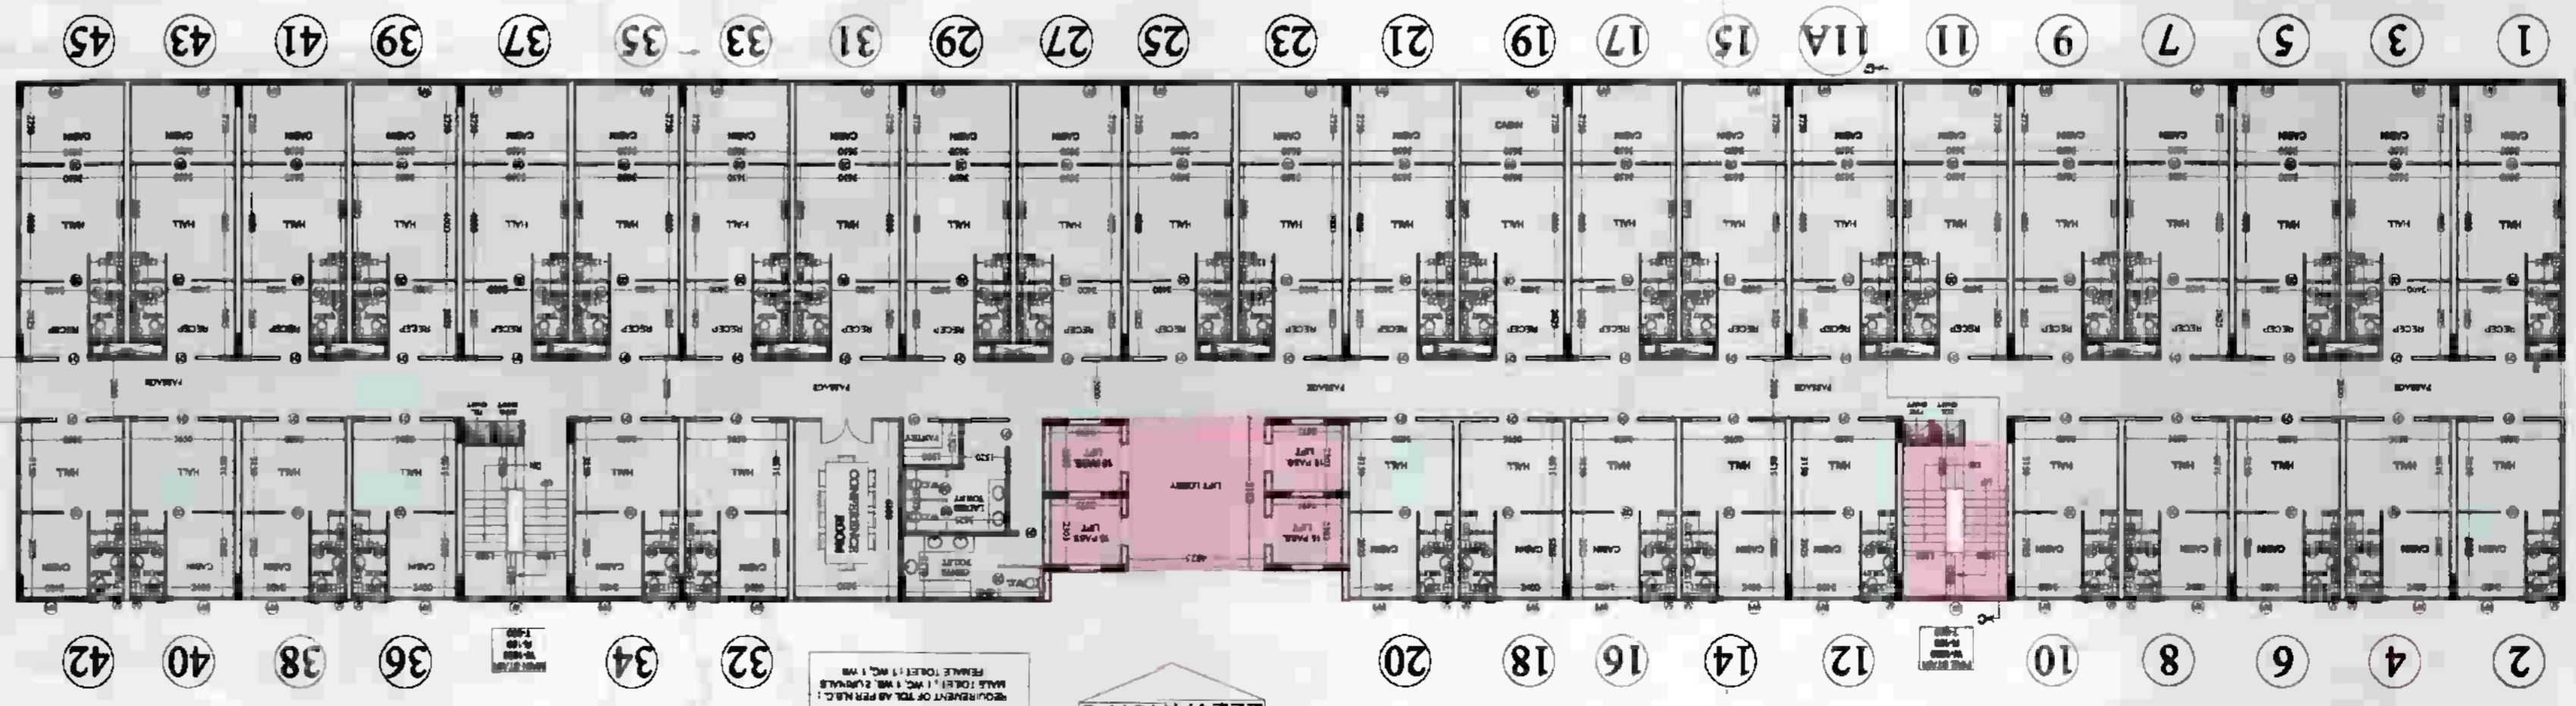

TOWER-C
2nd FLOOR PLAN


ELEVATION C

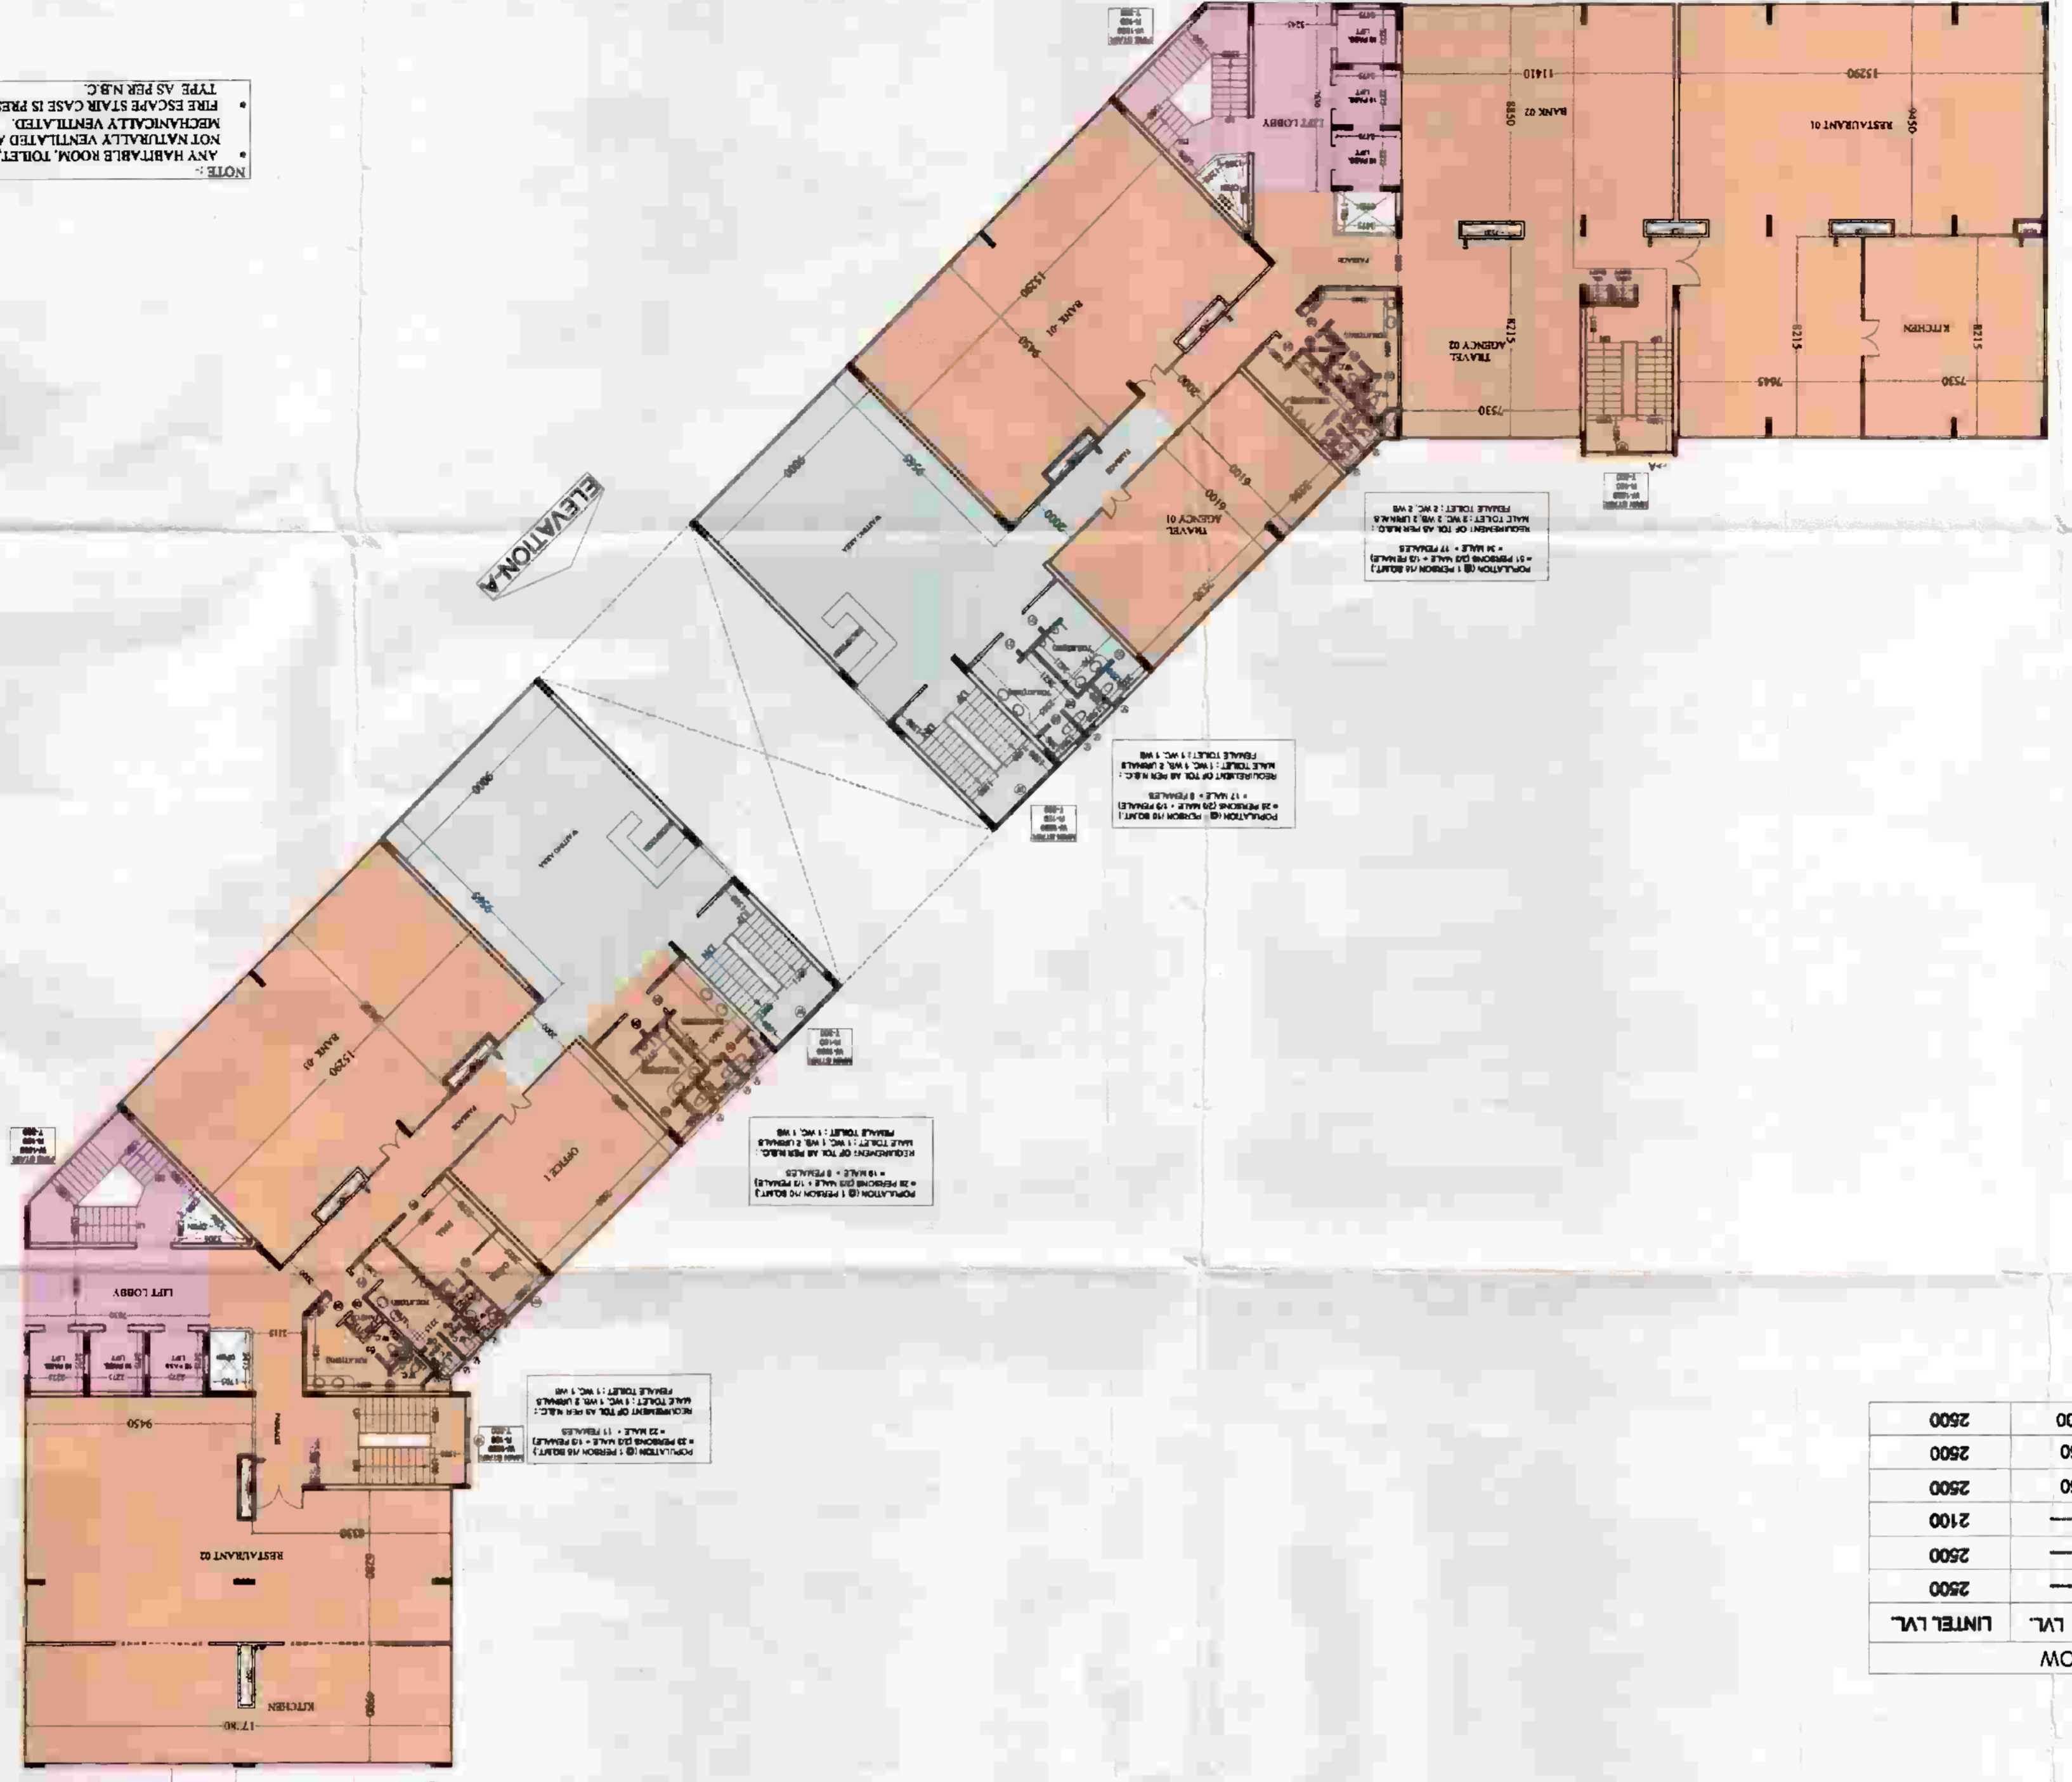


TOWER-A
2nd FLOOR PLAN

SCHEDULE OF DOOR & WINDOW


TYPE	SIZE	QTY	AREA
D1	1050 X 2500	2500	2500
D2	900 X 2500	2500	2500
D3	750 X 2100	2100	2100
W	2000 X 2050	450	2500
W1	2200 X 2050	450	2500
V	450 X 1000	1500	2500

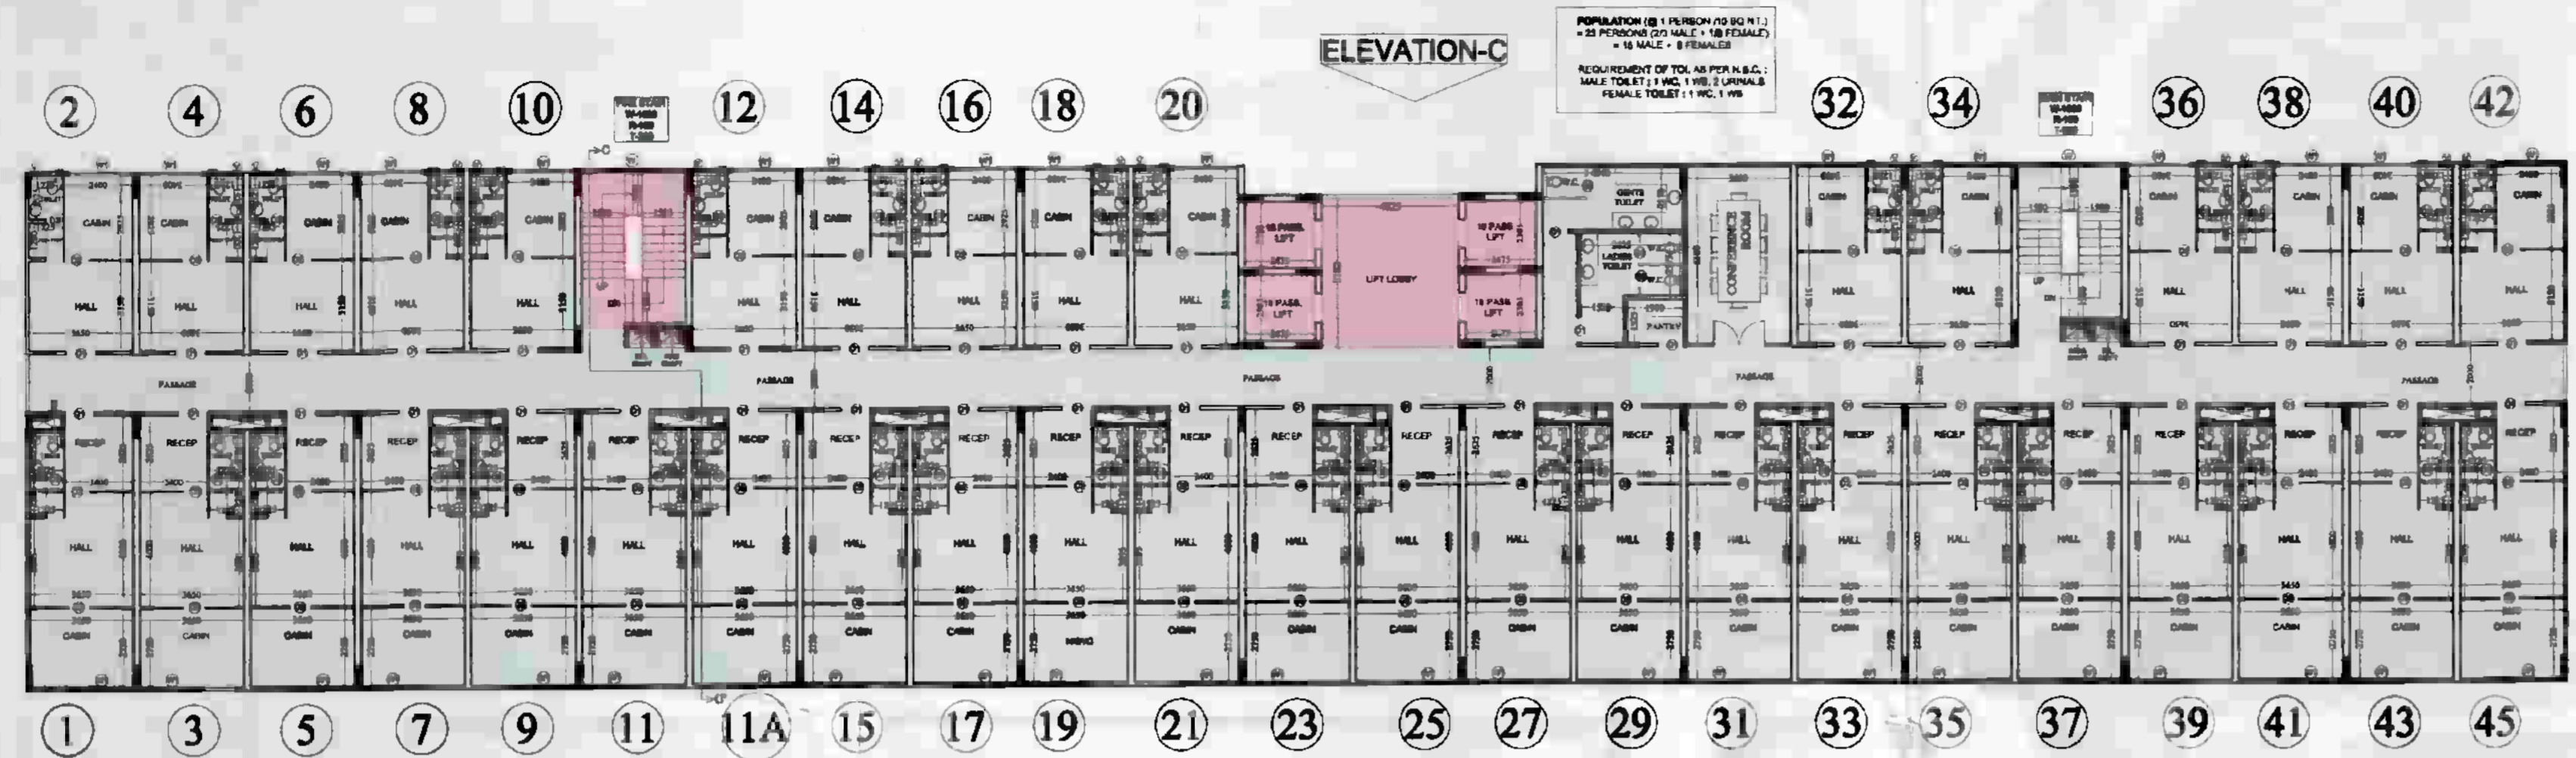

TOWER -C
3rd. FLOOR PLAN

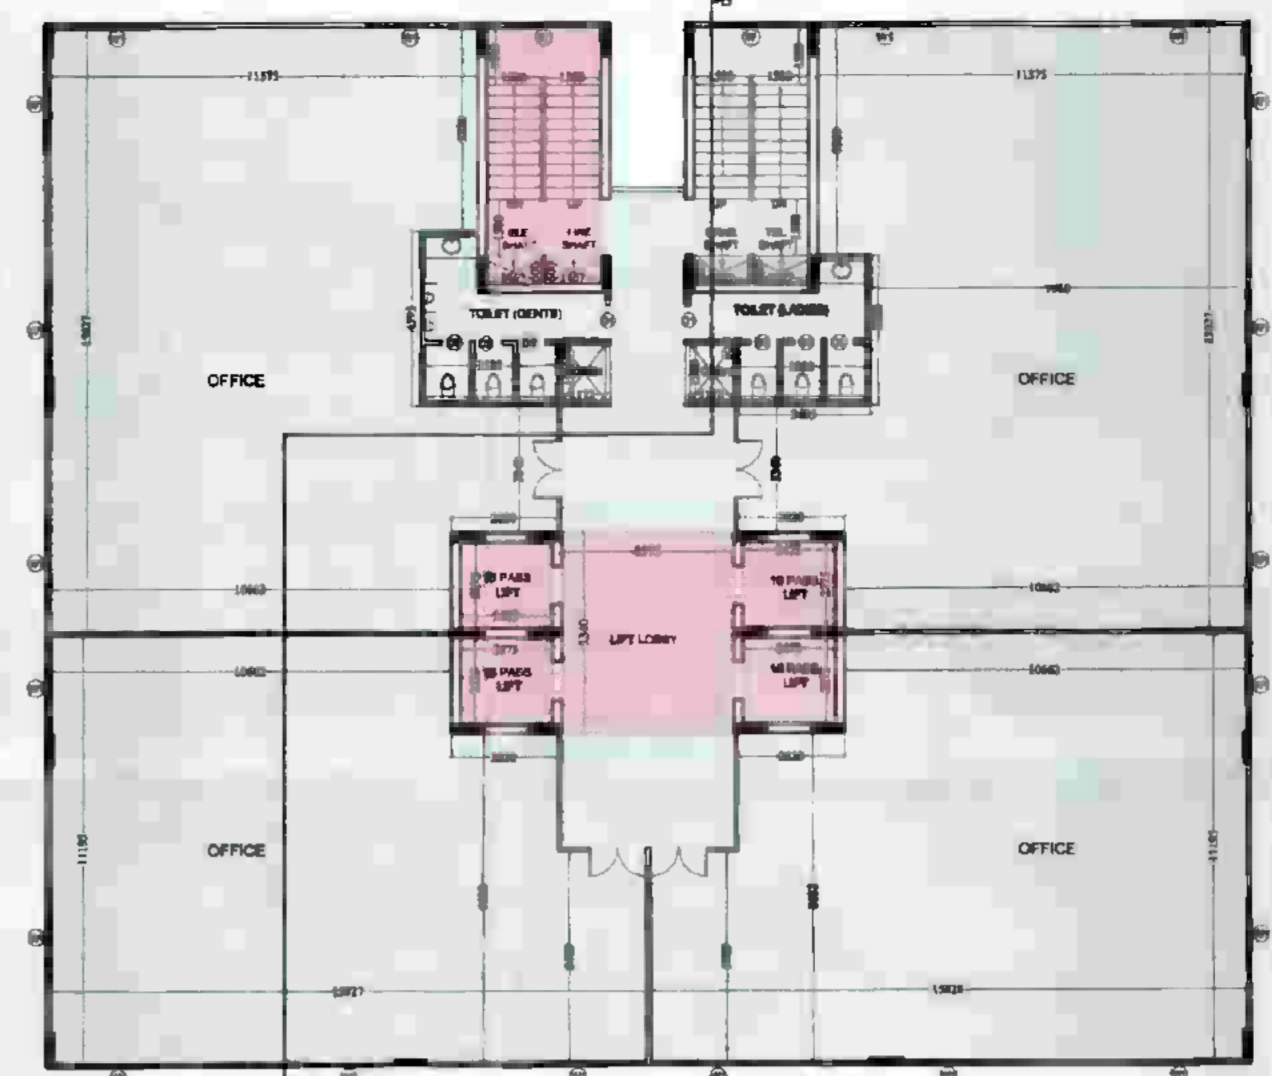

03/07/2019/19/5878/01-2019
 Name: ...
 Design: ...

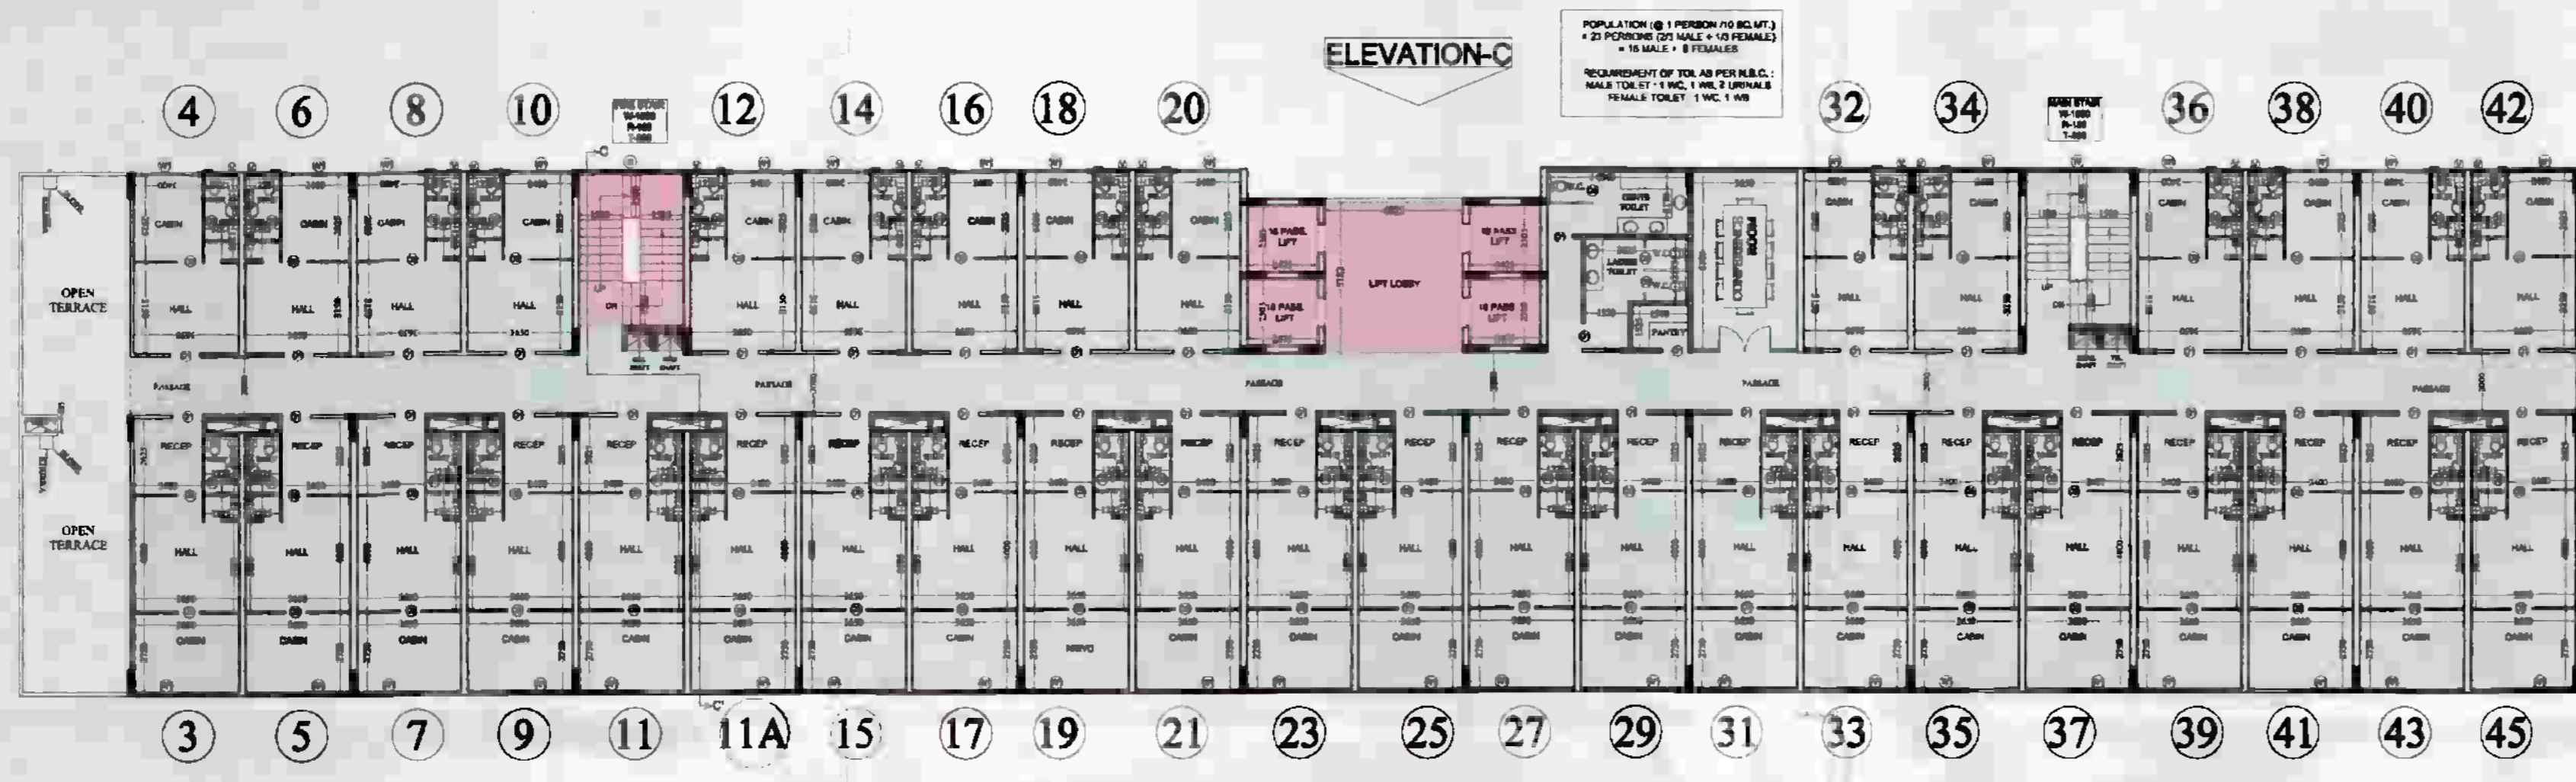


TOWER -C
4th. FLOOR PLAN



TOWER -B
4th. FLOOR PLAN

SCHEDULE OF DOOR & WINDOW

TYPE	SIZE	CILL. LVL.	LINTEL LVL.
D1	1060 X 2500	-----	2500
D2	900 X 2500	-----	2500
D3	750 X 2100	-----	2100
W	2000 X 2060	480	2500
W1	2200 X 2060	480	2500
V	450 X 1000	1500	2500

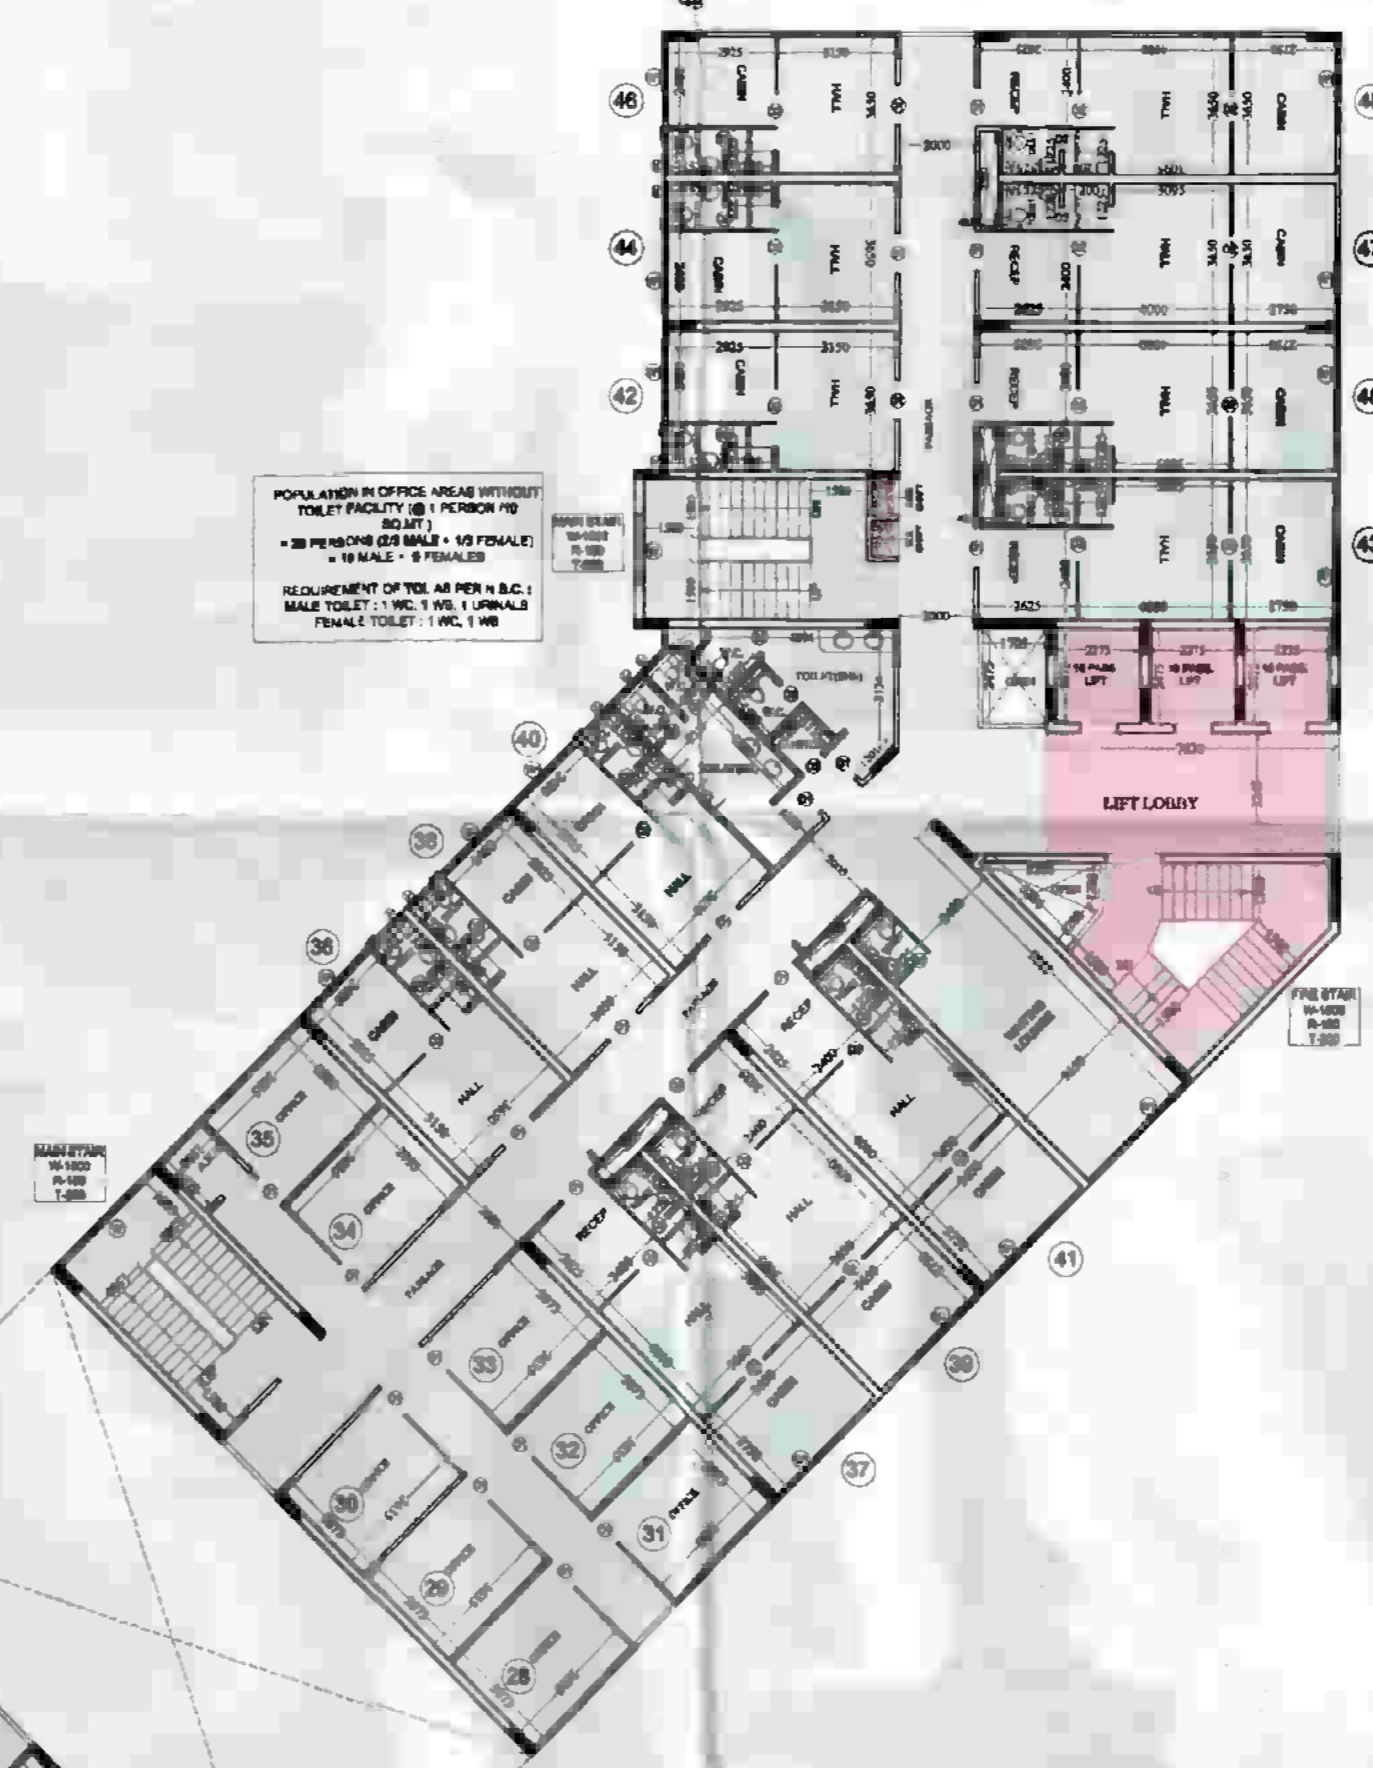

LEGEND

	I.T. F.A.R.
	INSTITUTIONAL F.A.R.



TOWER -A
4th. FLOOR PLAN

NOTE :-
 • ANY HABITABLE ROOM, TOILET, KITCHEN NOT NATURALLY VENTILATED ARE MECHANICALLY VENTILATED.
 • FIRE ESCAPE STAIR CASE IS PRESSURIZED TYPE AS PER N.B.C.

PROJECT :-
 PROPOSED I.T. PARK
 AT PLOT No. - 17 SECTOR K.P. - V
 GREATER NOIDA

BUILDERS & PROMOTER :-
 M/S S.K.V. INFOTECH Pvt. Ltd.
 M-AB GREATER KAILASH PART-II
 NEW DELHI -110048

DRAWING TITLE :- TOWER -AB & C
 4th. FLOOR PLAN


ARCHITECTS :-
 Space Designers International
 Architects Pvt. Ltd.
 5 / 1308, VASUNDHARA, GHAZIABAD
 PH : 0120-425744, FAX : 0120-425743
 email : spdesign@gmail.com, www.spdesign.com

DRAWN BY :- SANJAY CHECKED BY :- VISHAL SCALE: 1/200 DATED :-


For SKV Infotech Private Limited

 Authorised Signatory

ARCHITECT'S SIGN
 DRG. NO. - 14

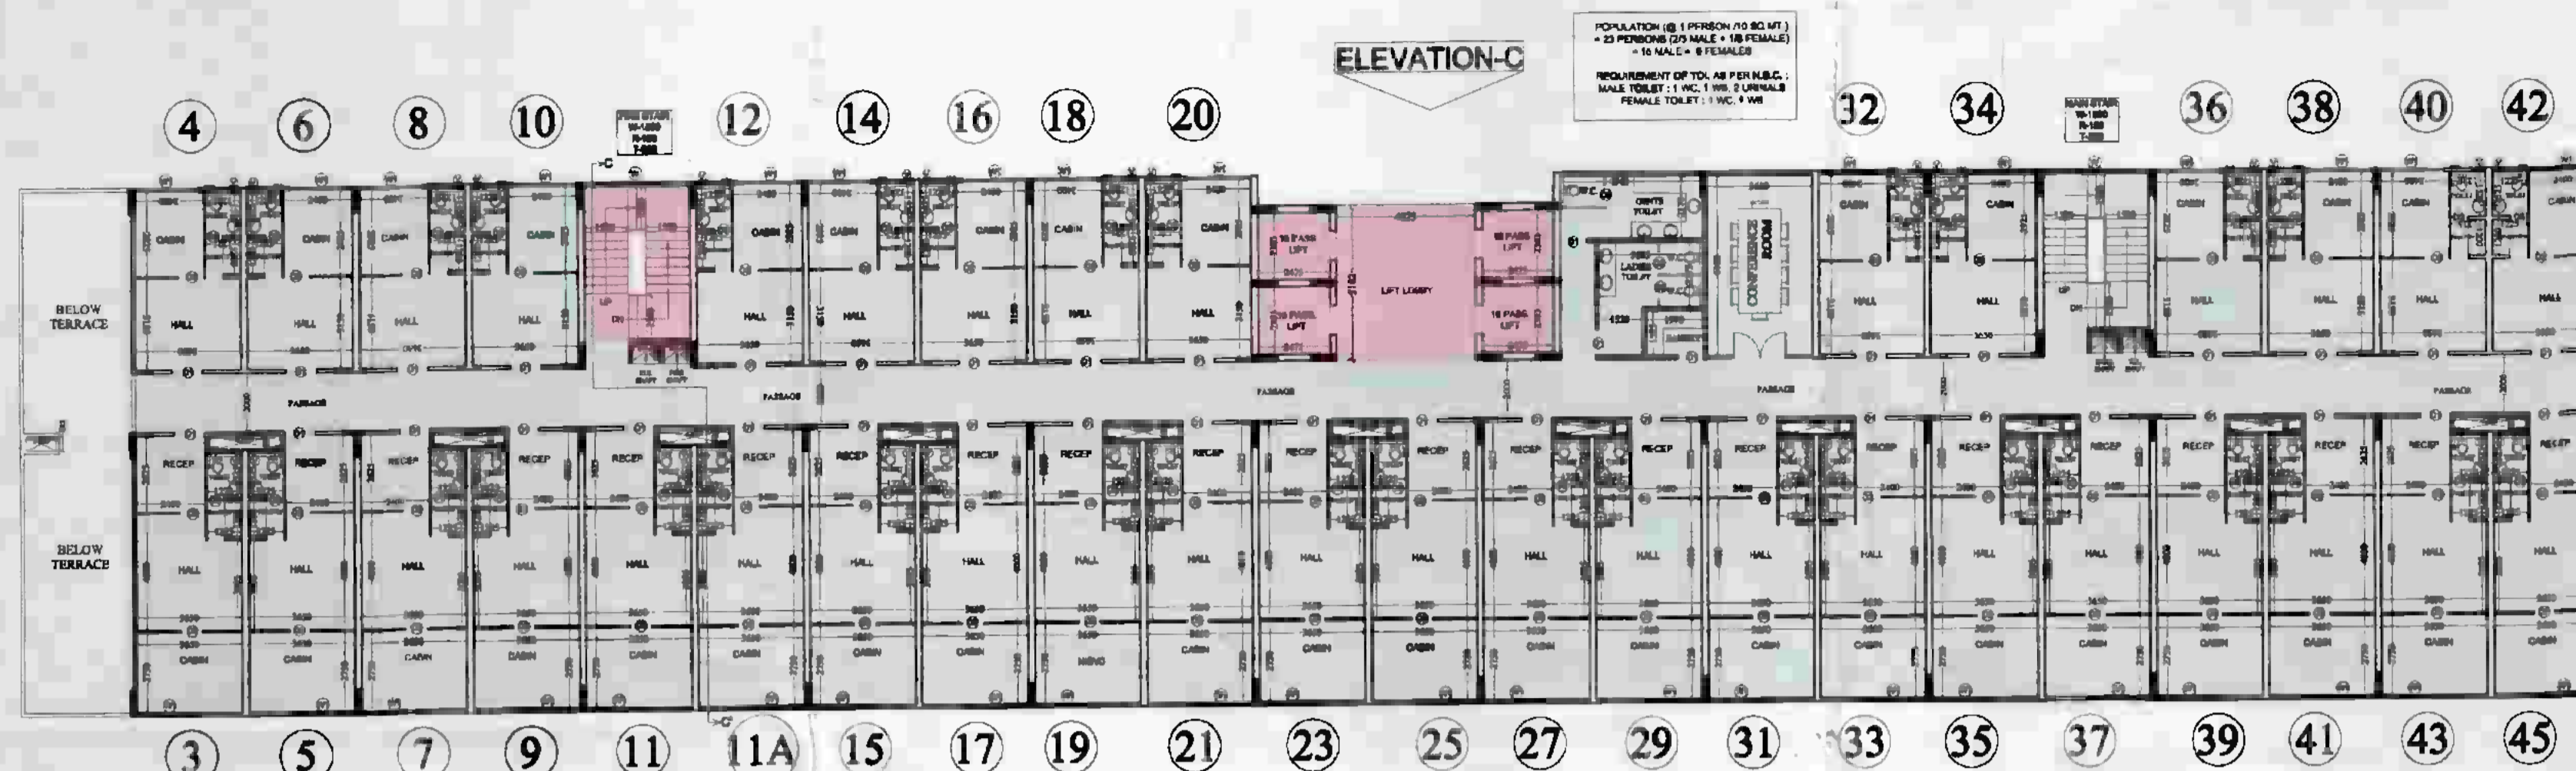


TOWER -C
5th. FLOOR PLAN

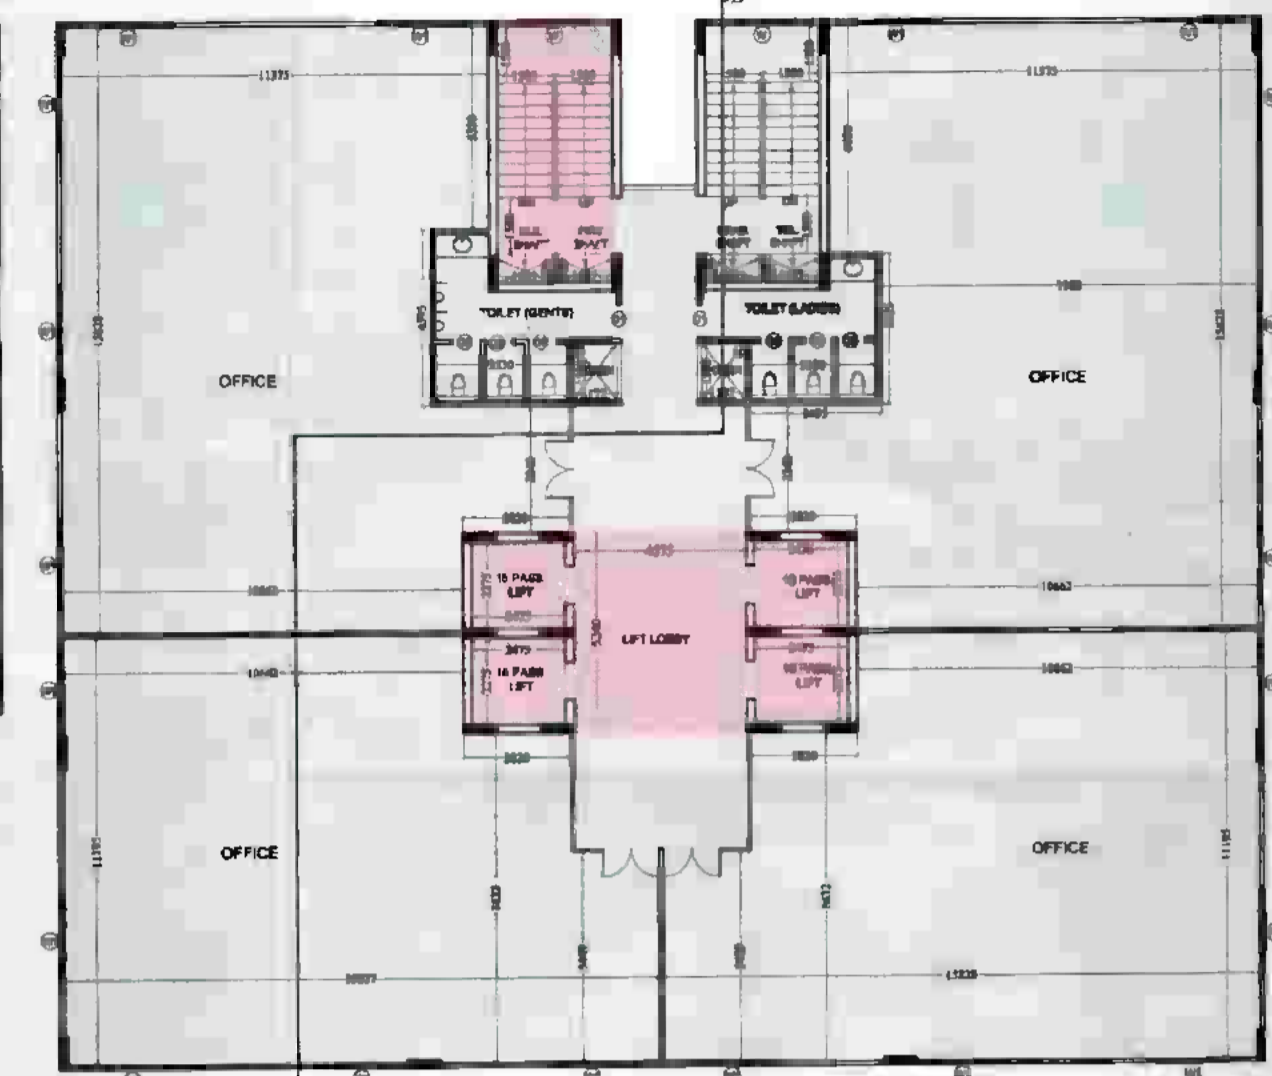

TOWER -B
5th. FLOOR PLAN

SCHEDULE OF DOOR & WINDOW

TYPE	SIZE	CILL LVL.	LINTEL LVL.
D1	1060 X 2500	---	2500
D2	900 X 2500	---	2500
D3	760 X 2100	---	2100
W	2000 X 2050	450	2500
W1	2200 X 2050	450	2500
V	450 X 1000	1500	2500

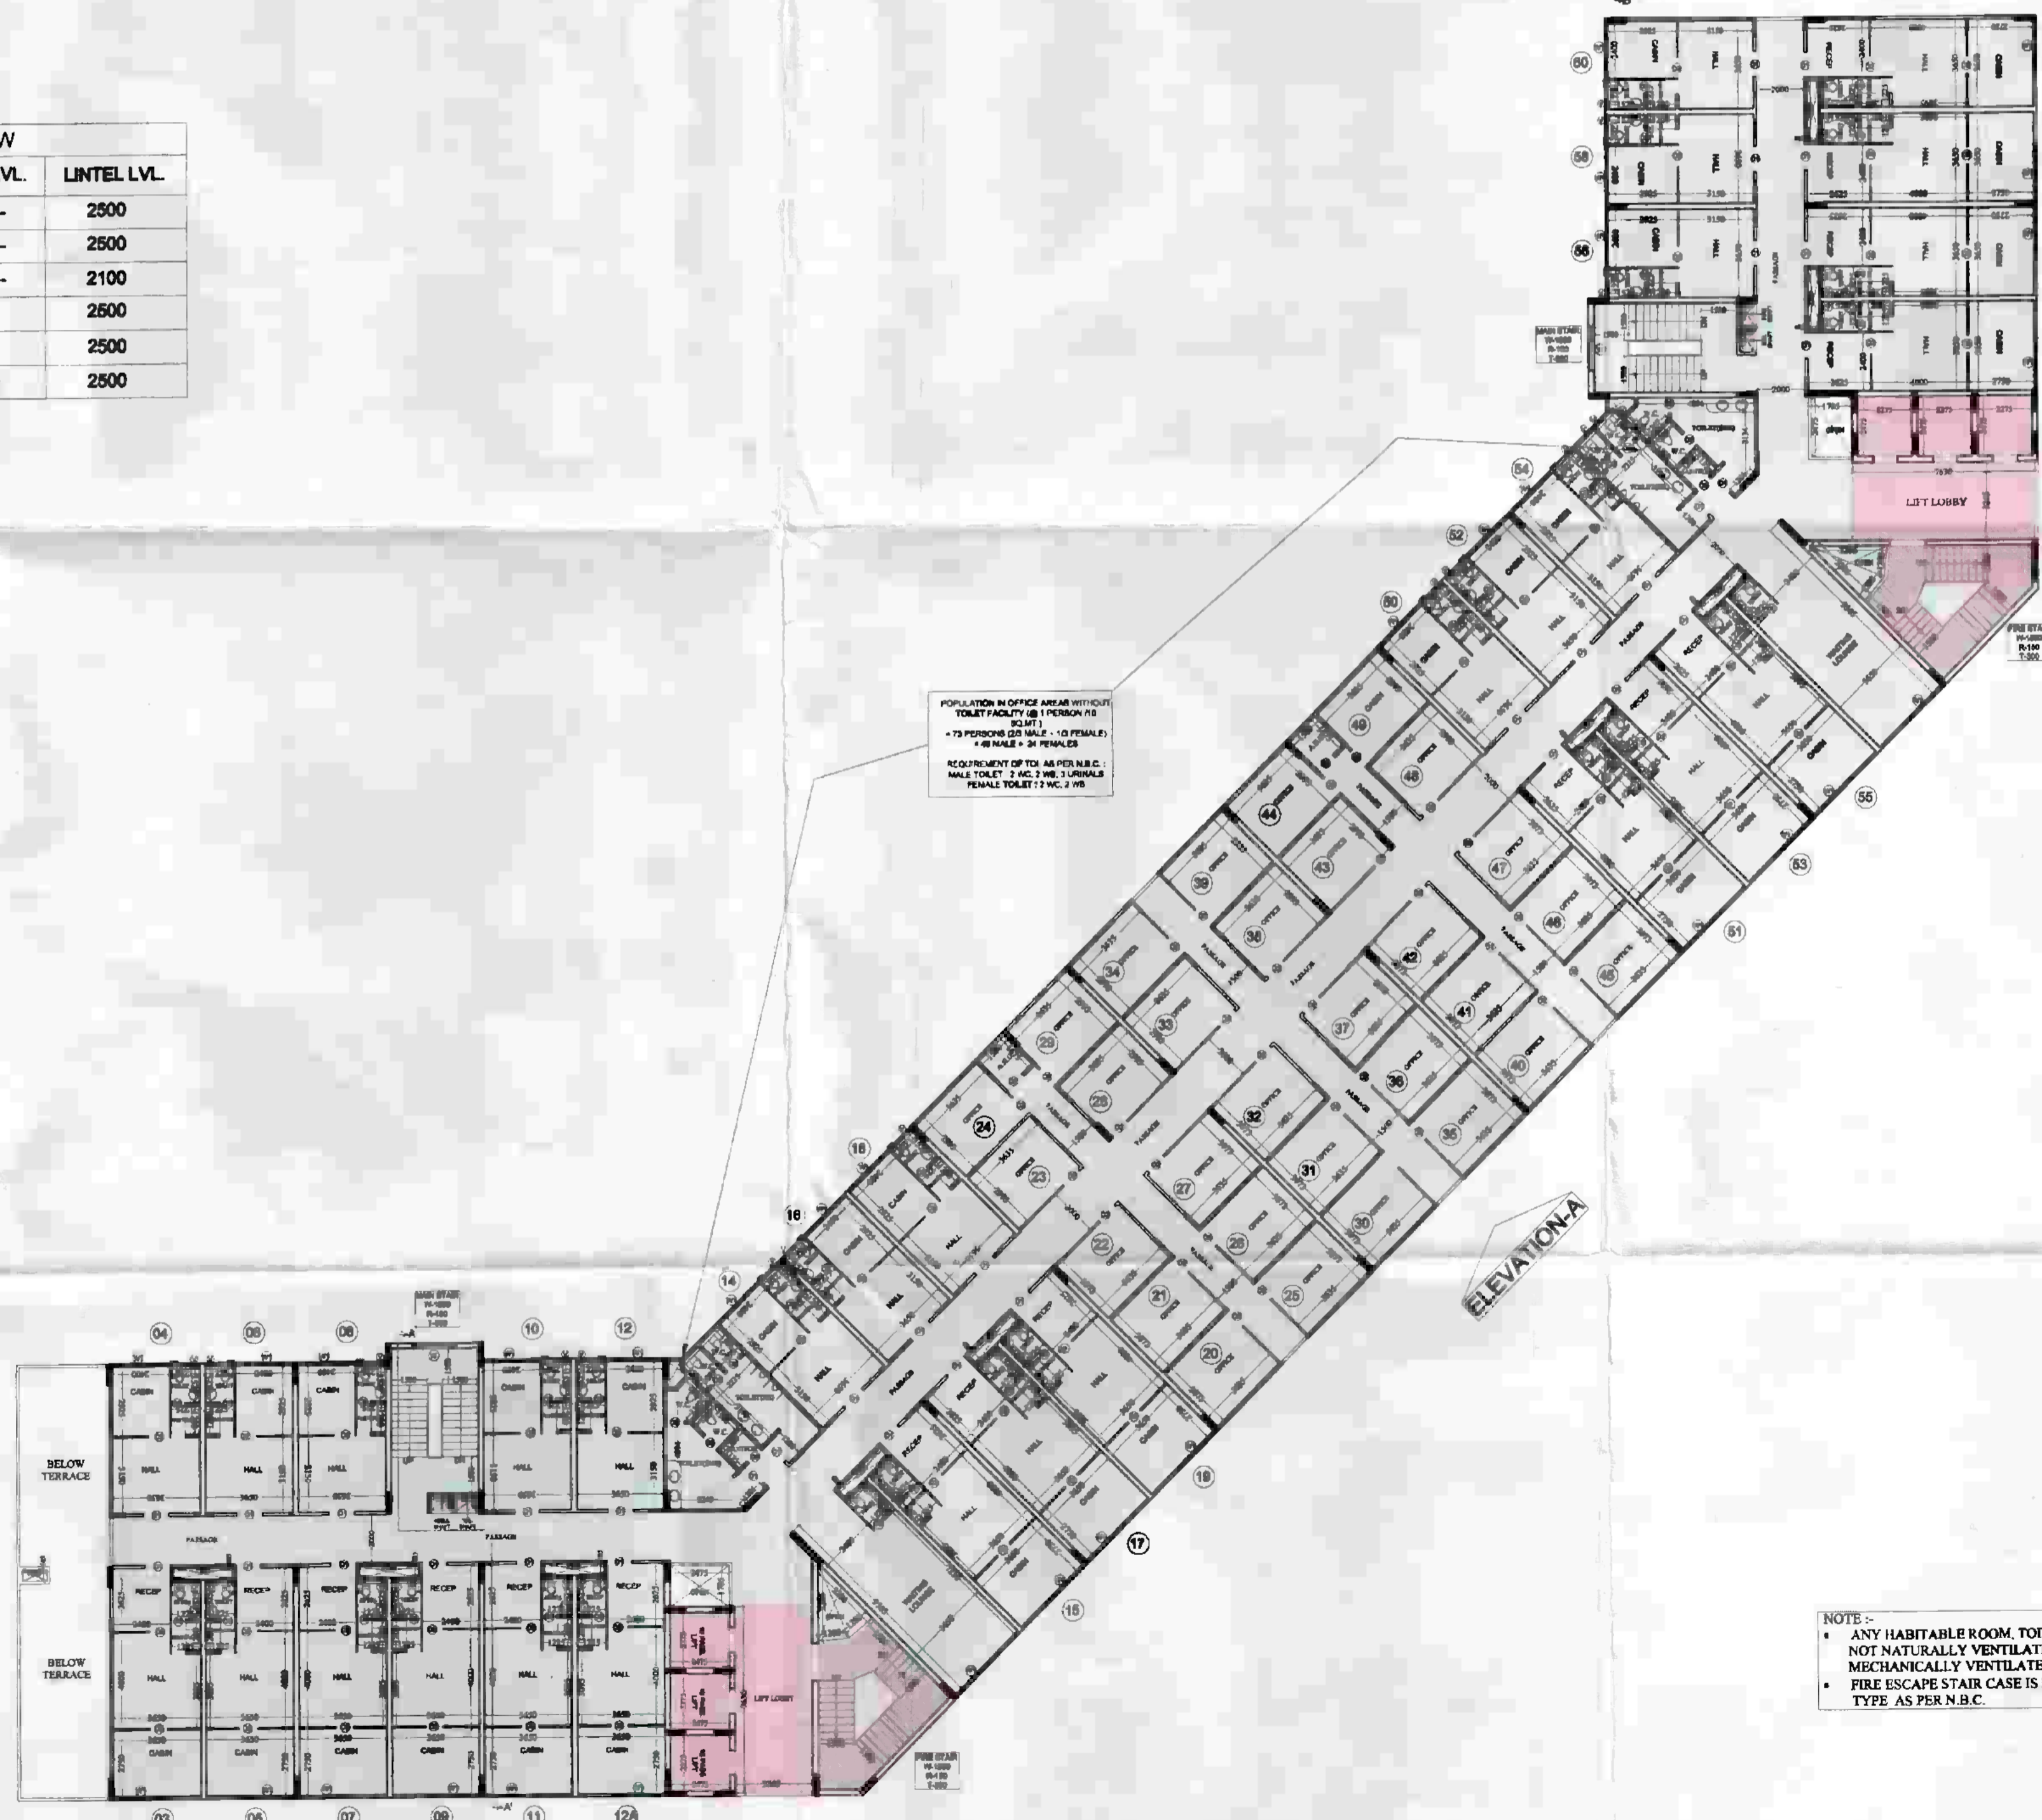

TOWER -A
5th. FLOOR PLAN

LEGEND

	I.T. F.A.R.
	INSTITUTIONAL F.A.R.

NOTE :-
 • ANY HABITABLE ROOM, TOILET, KITCHEN NOT NATURALLY VENTILATED ARE MECHANICALLY VENTILATED.
 • FIRE ESCAPE STAIR CASE IS PRESSURIZED TYPE AS PER N.B.C.

PROJECT :-
 PROPOSED I.T. PARK
 AT PLOT No. - 17 SECTOR K.P. - V
 GREATER NOIDA
 BUILDERS & PROMOTER :-
 M/S S.K.V. INFOTECH Pvt. Ltd.
 M - 48 GREATER KAILASH PART-II
 NEW DELHI - 110048
 DRAWING TITLE :- TOWER -A,B & C
 5th. FLOOR PLAN

ARCHITECTS :-
 Space Designers International
 Architects Pvt. Ltd.
 5 / 1306, VASUNDHARA, GHAZIABAD
 PH : 0120442576, 0120442577, 0120442578
 e-mail : spdesi@rediffmail.com, www.spdesi.com

DRAWN BY :- SANJAY
 CHECKED BY :- VISHAL
 SCALE :- 1:1000
 DATED :-

For SKV Infotech Private Limited

 Authorised Signatory




ARCHITECT'S SIGN.
 DRG. NO. - 15


DR. YERS SIGN

DRG. NO. - 15

DRG. NO. - 15

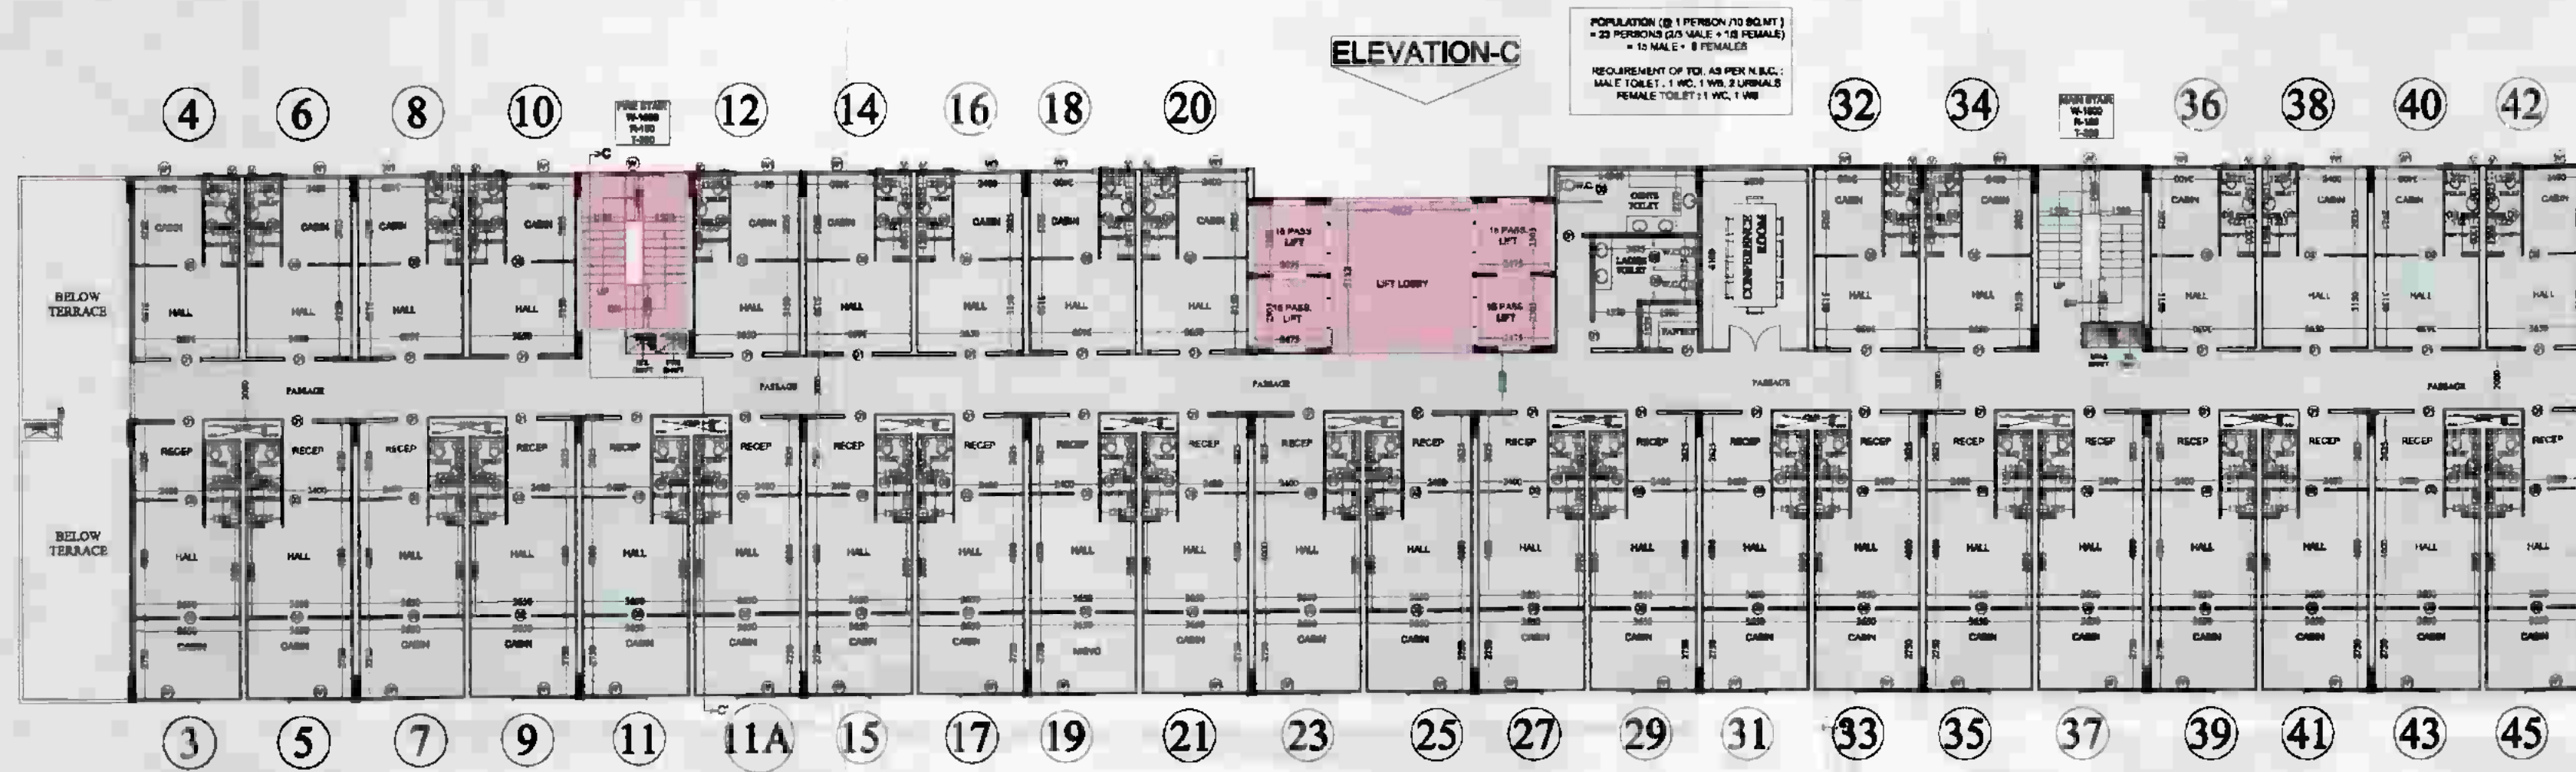

TOWER -C
6th. FLOOR PLAN

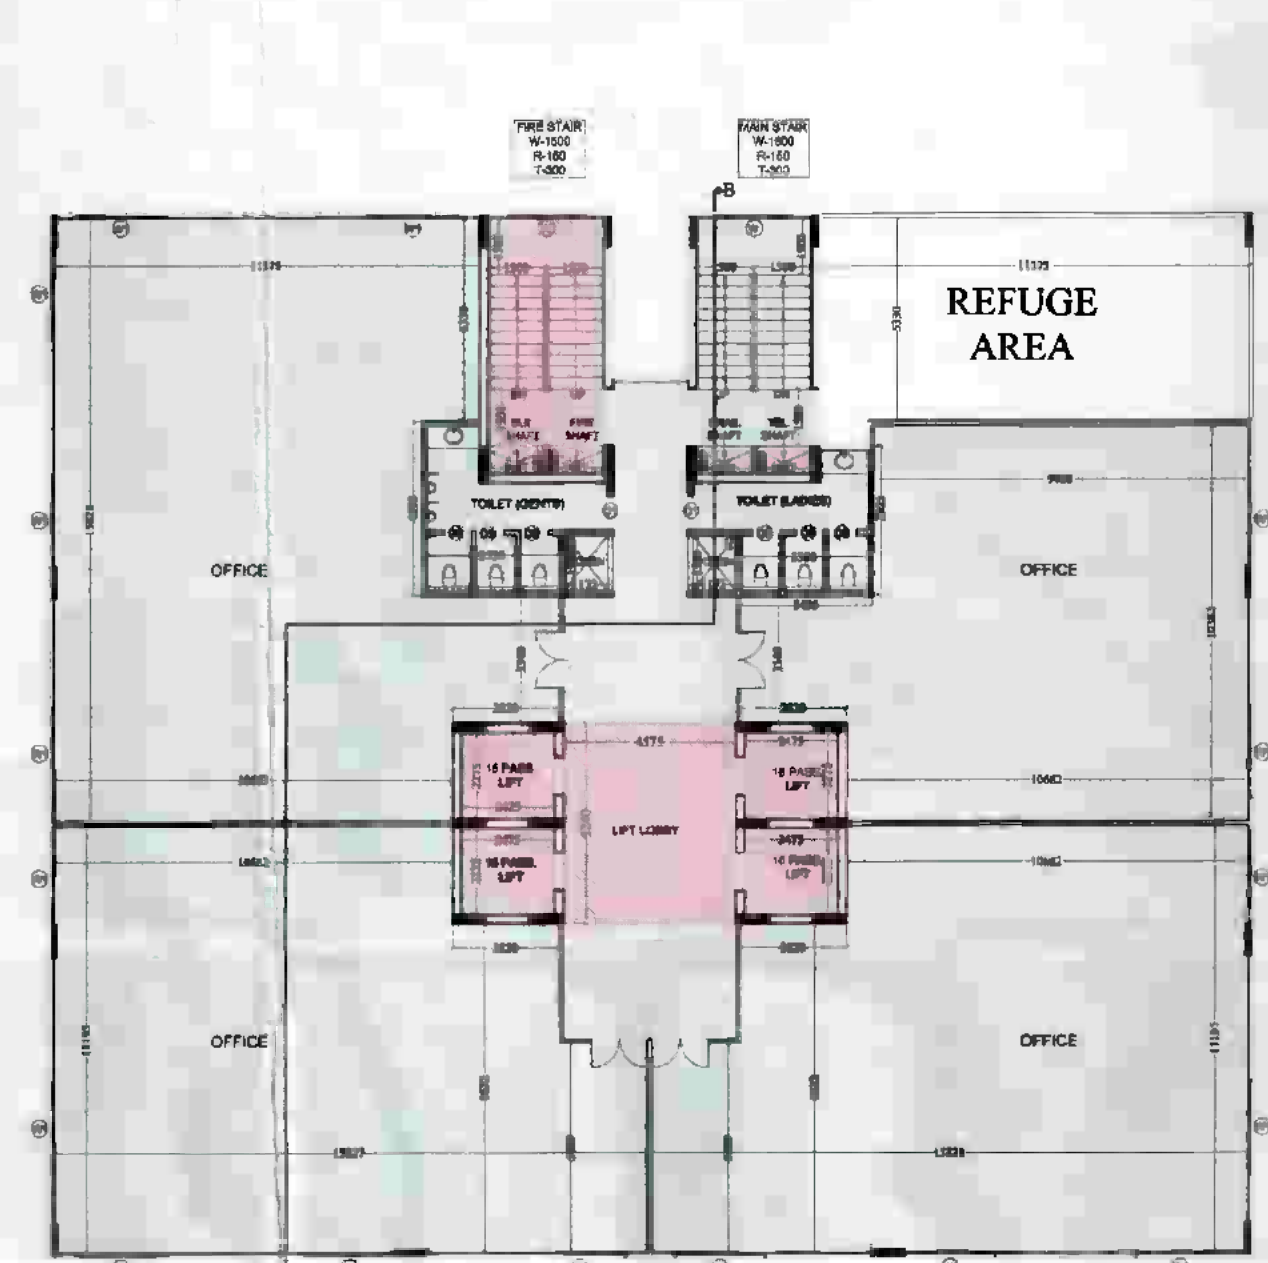

TOWER -B
6th. FLOOR PLAN

SCHEDULE OF DOOR & WINDOW

TYPE	SIZE	CHILL LVL.	LINTEL LVL.
D1	1050 X 2500		2500
D2	900 X 2500		2500
D3	750 X 2100		2100
W	2000 X 2050	450	2500
W1	2200 X 2050	450	2500
V	450 X 1000	1500	2500



TOWER -A
6th FLOOR PLAN

LEGEND

	I.T. F.A.R.
	INSTITUTIONAL F.A.R.

30/3/2011/1174
 Approved By
 Gen. Manager
 (Planner)

PROJECT :-
 PROPOSED I.T. PARK
 AT PLOT No. - 17 SECTOR K.P. - V
 GREATER NOIDA
 BUILDERS & PROMOTER :-
 M/S S.K.V. INFOTECH PVT. LTD.
 M - AB GREATER KALLASH PART - II
 NEW DELHI - 110048
 DRAWING TITLE :- TOWER -A, B & C
 6th. FLOOR PLAN


ARCHITECTS:
 Space Designers International
 Architects Pvt. Ltd.
 5 / 1308, VASUNDHARA, GHAZIABAD
 PH: 0120-42226, Mob: 981013399, 981013221
 e-mail: spsdi@spair.com, www.spair.com

DRAWN BY: SANJAY
 CHECKED BY: VISHAL
 SCALE: 1:250
 DATED: -

For SKV Infotech Private Limited
 Authorised Signatory




NOTE :-
 ANY HABITABLE ROOM, TOILET, KITCHEN
 NOT NATURALLY VENTILATED ARE
 MECHANICALLY VENTILATED.
 FIRE ESCAPE STAIR CASE IS PRESSURIZED
 TYPE AS PER N.B.C.

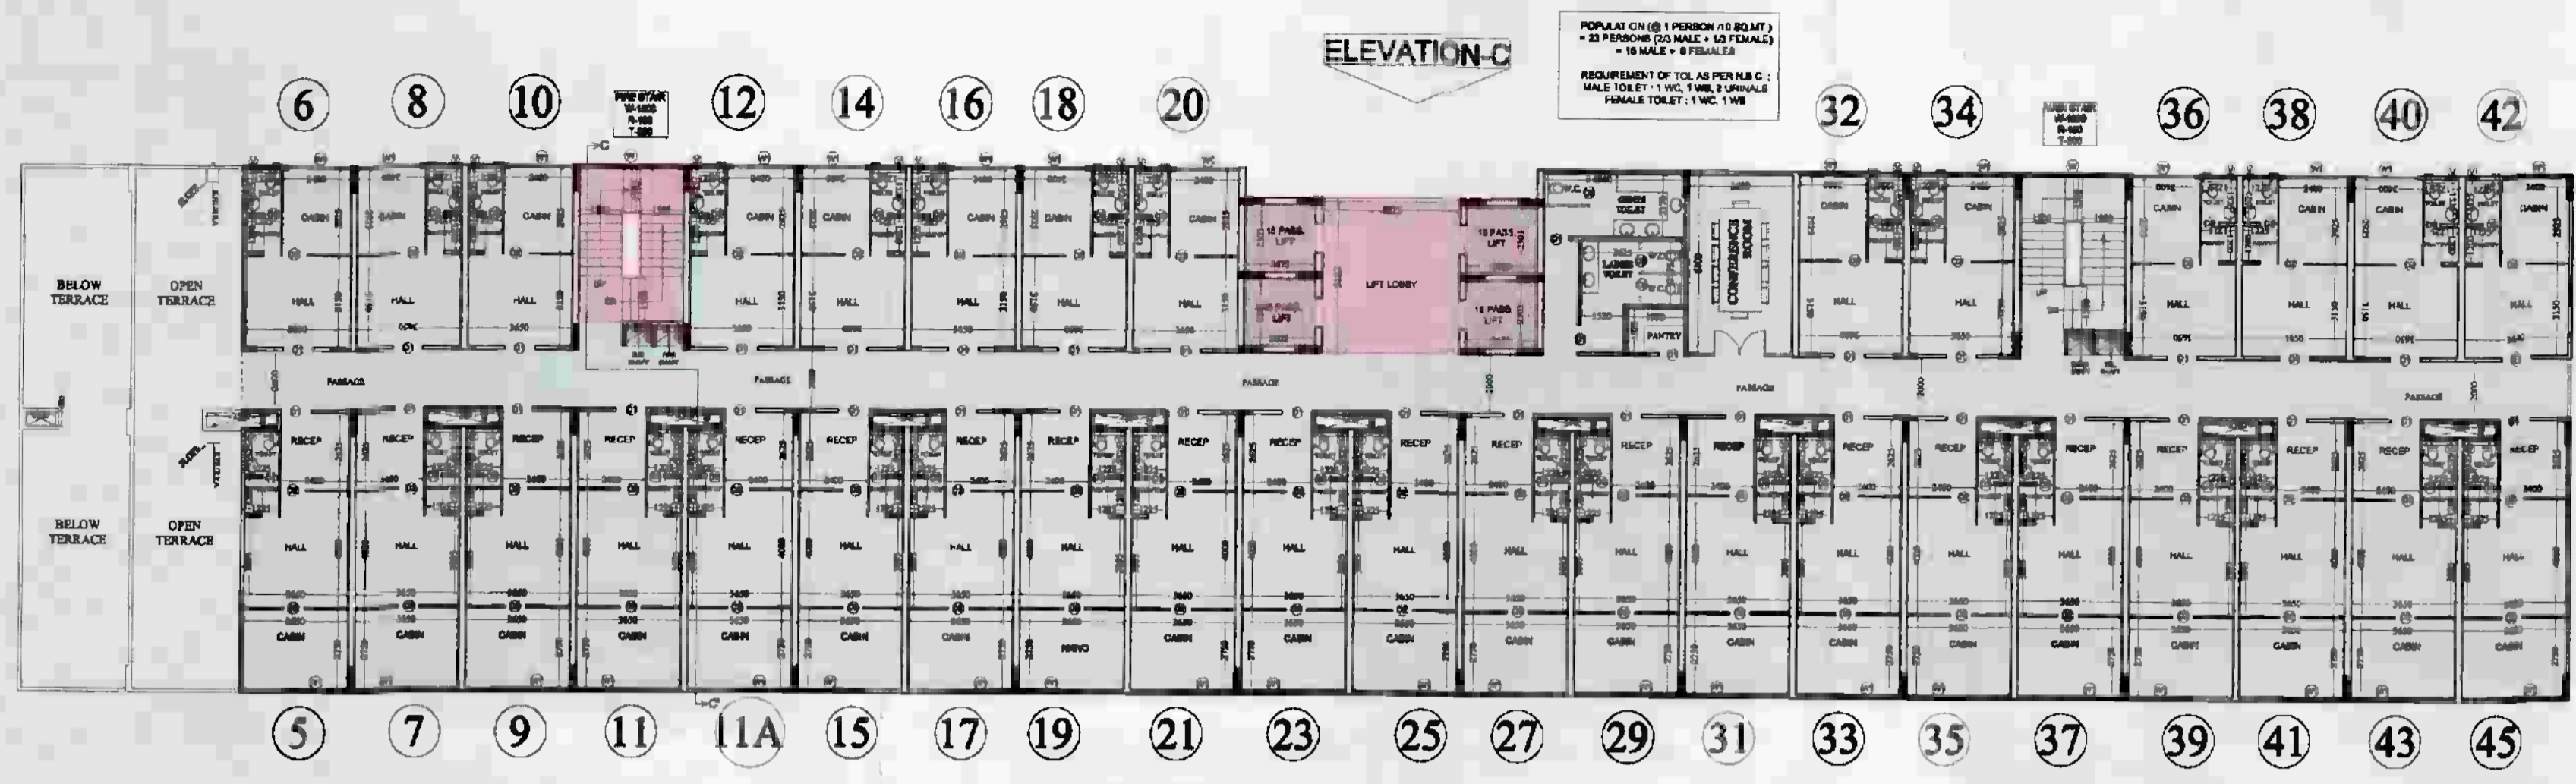

TOWER -C
7th. FLOOR PLAN

SCHEDULE OF DOOR & WINDOW

TYPE	SIZE	CILL. LVL.	LINTEL LVL.
D1	1050 X 2500	---	2500
D2	900 X 2500	---	2500
D3	750 X 2100	---	2100
W	2000 X 2050	450	2500
W1	2200 X 2050	450	2500
V	450 X 1000	1500	2500

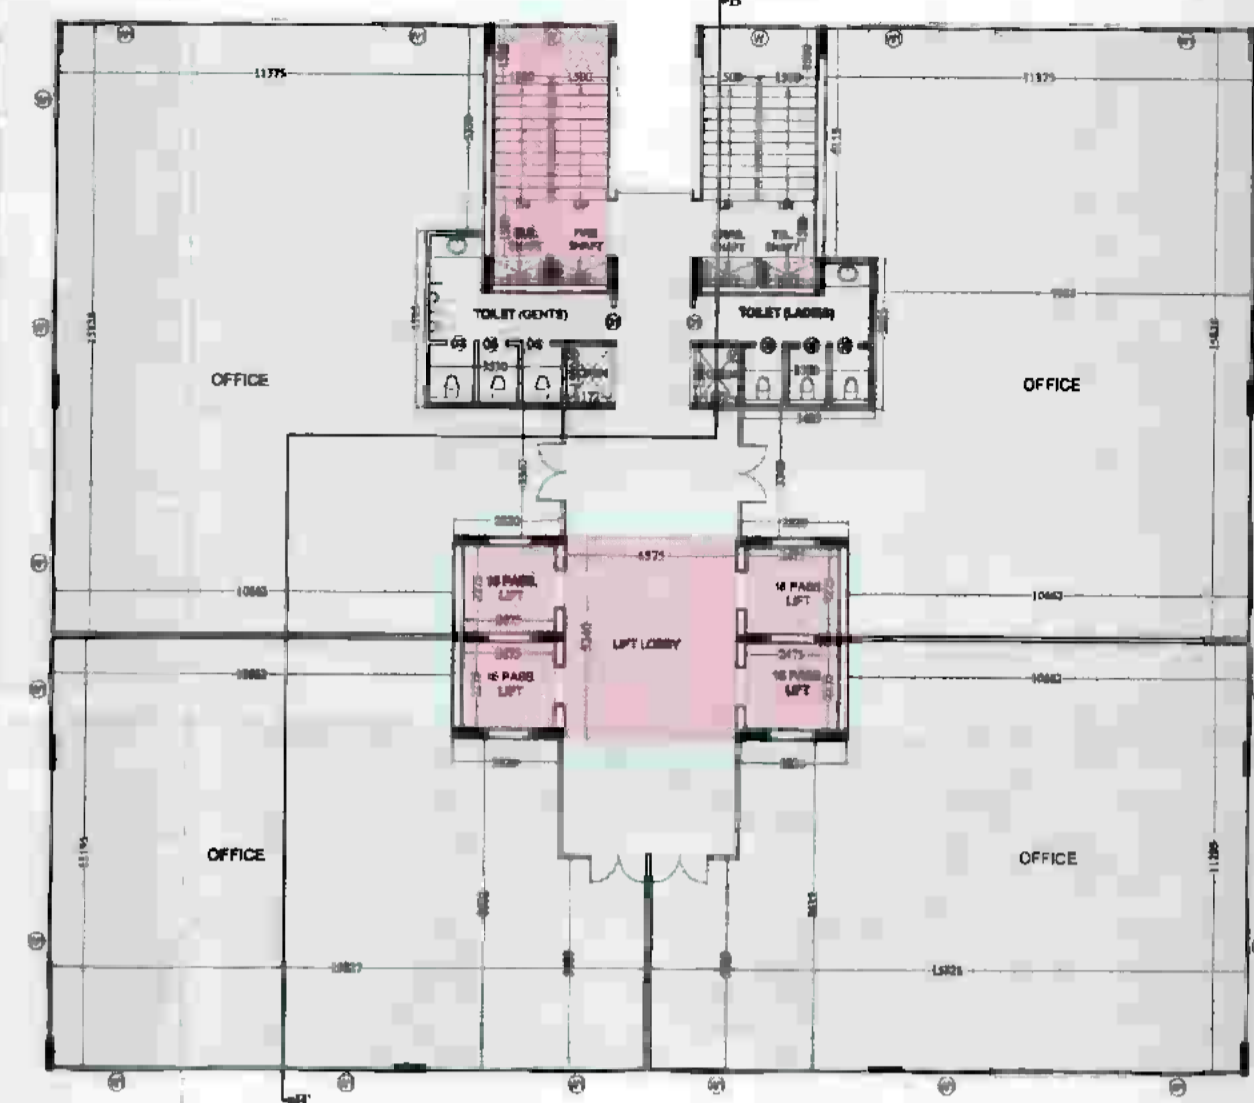

TOWER -B
7th. FLOOR PLAN



TOWER -A
7th. FLOOR PLAN

Authority
No. 3317/19
Date 12/11/19
Manager SE (Planner)

LEGEND

	I.T. F.A.R.
	INSTITUTIONAL F.A.R.

PROJECT :-
PROPOSED I.T. PARK
AT PLOT No. - 17 SECTOR K.P. - V
GREATER NOIDA

BUILDERS & PROMOTER :-
M/S SKV INFOTECH PVT. LTD.
M - 8 GREATER KALASH PART - II
NEW DELHI - 110048


DRAWING TITLE :- TOWER -A, B & C
7th. FLOOR PLAN

ARCHITECTS:
Space Designers International
Architects Pvt. Ltd.
5 / 1306, VASUNDHARA, GHAZIABAD
PH : 0120-428224, 98-013079, 98-135623
e-mail: spades@gmail.com, www.spades.com


DRAWN BY :- CHECKED BY :- SCALE DATED :-
SANJAY VIS-AL 1:100

For SKV Infotech Private Limited
Authorised Signatory
CA9823185
ARCHITECT

NOTE:-
• ANY HABITABLE ROOM, TOILET, KITCHEN NOT NATURALLY VENTILATED ARE MECHANICALLY VENTILATED.
• FIRE ESCAPE STAIR CASE IS PRESURIZED TYPE AS PER N.B.C.

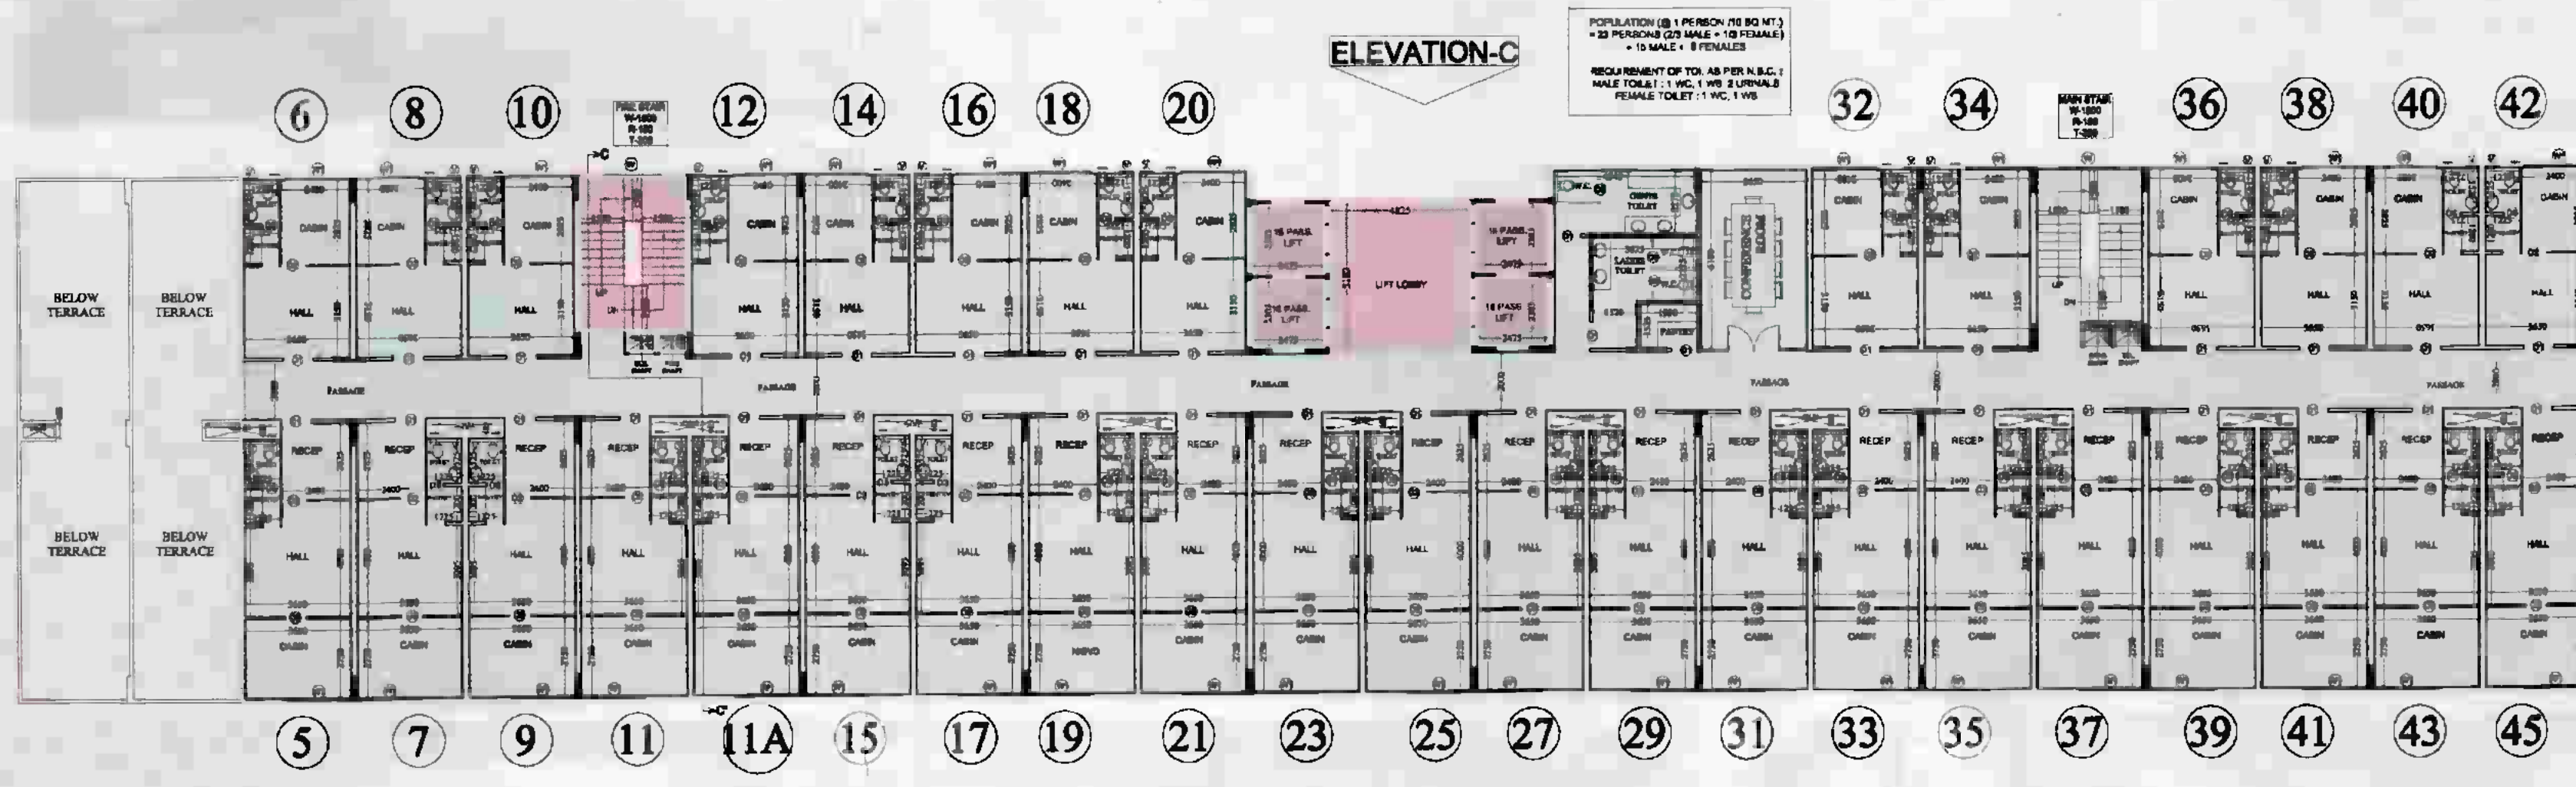


TOWER -C
8th. & 9th. FLOOR PLAN

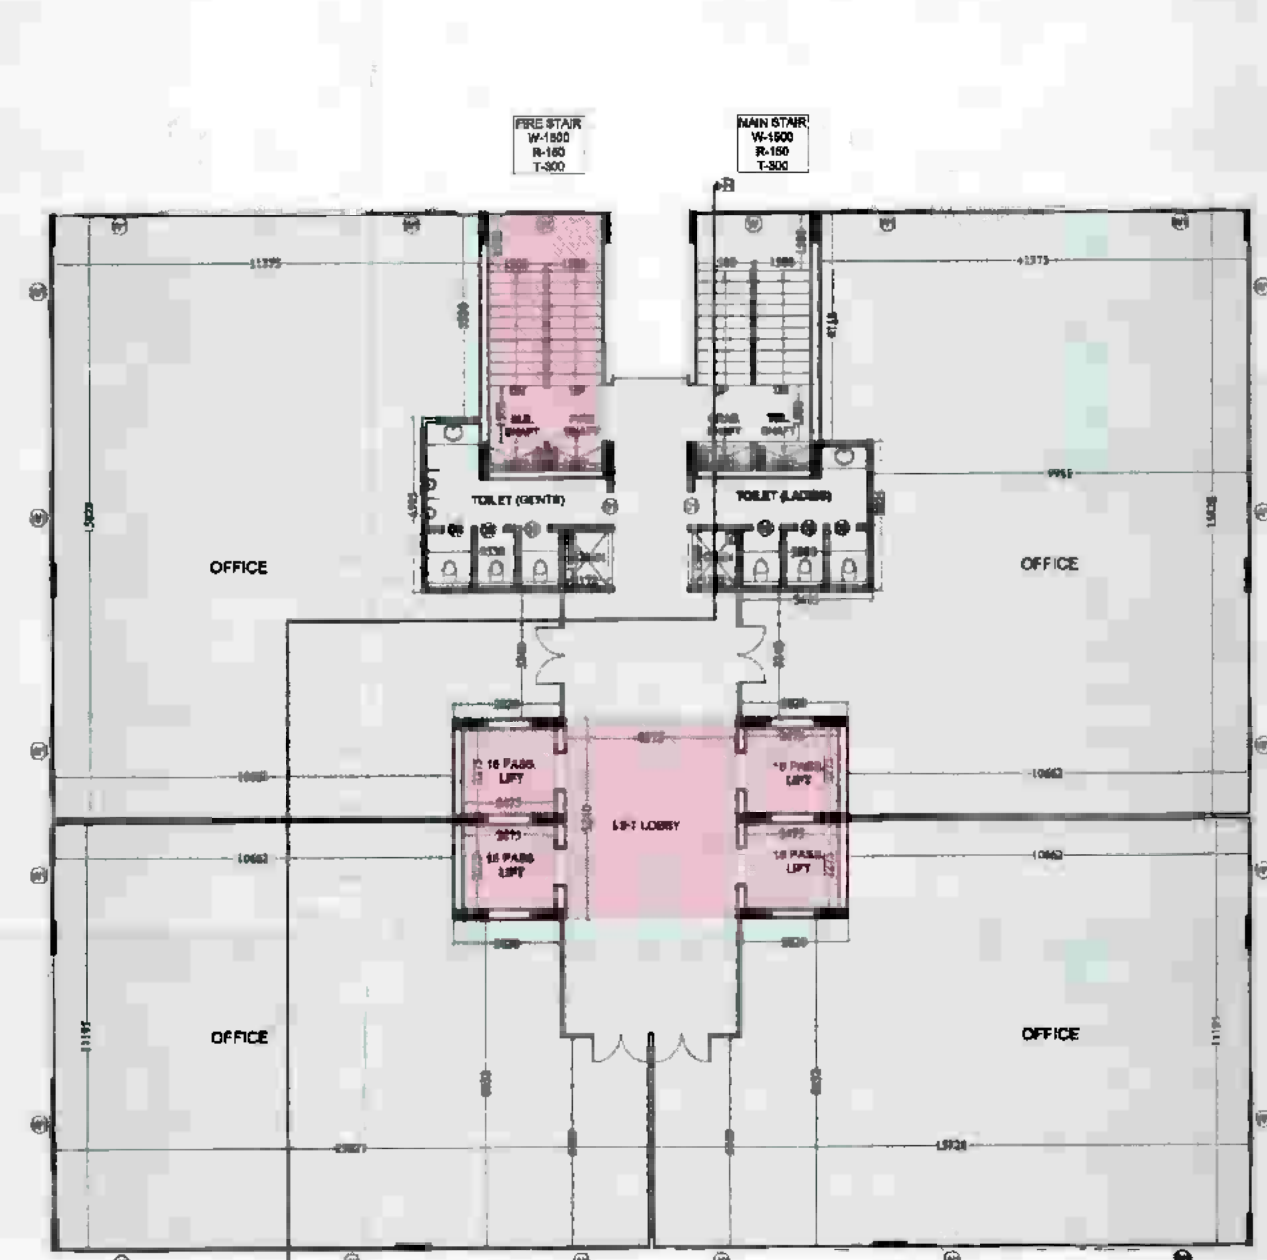

TOWER -B
8th. & 9th. FLOOR PLAN

SCHEDULE OF DOOR & WINDOW

TYPE	SIZE	CILL LVL.	LINTEL LVL.
D1	1050 X 2500	-----	2500
D2	900 X 2500	-----	2500
D3	750 X 2100	-----	2100
W	2000 X 2050	450	2500
W1	2200 X 2050	450	2500
V	450 X 1000	1500	2500

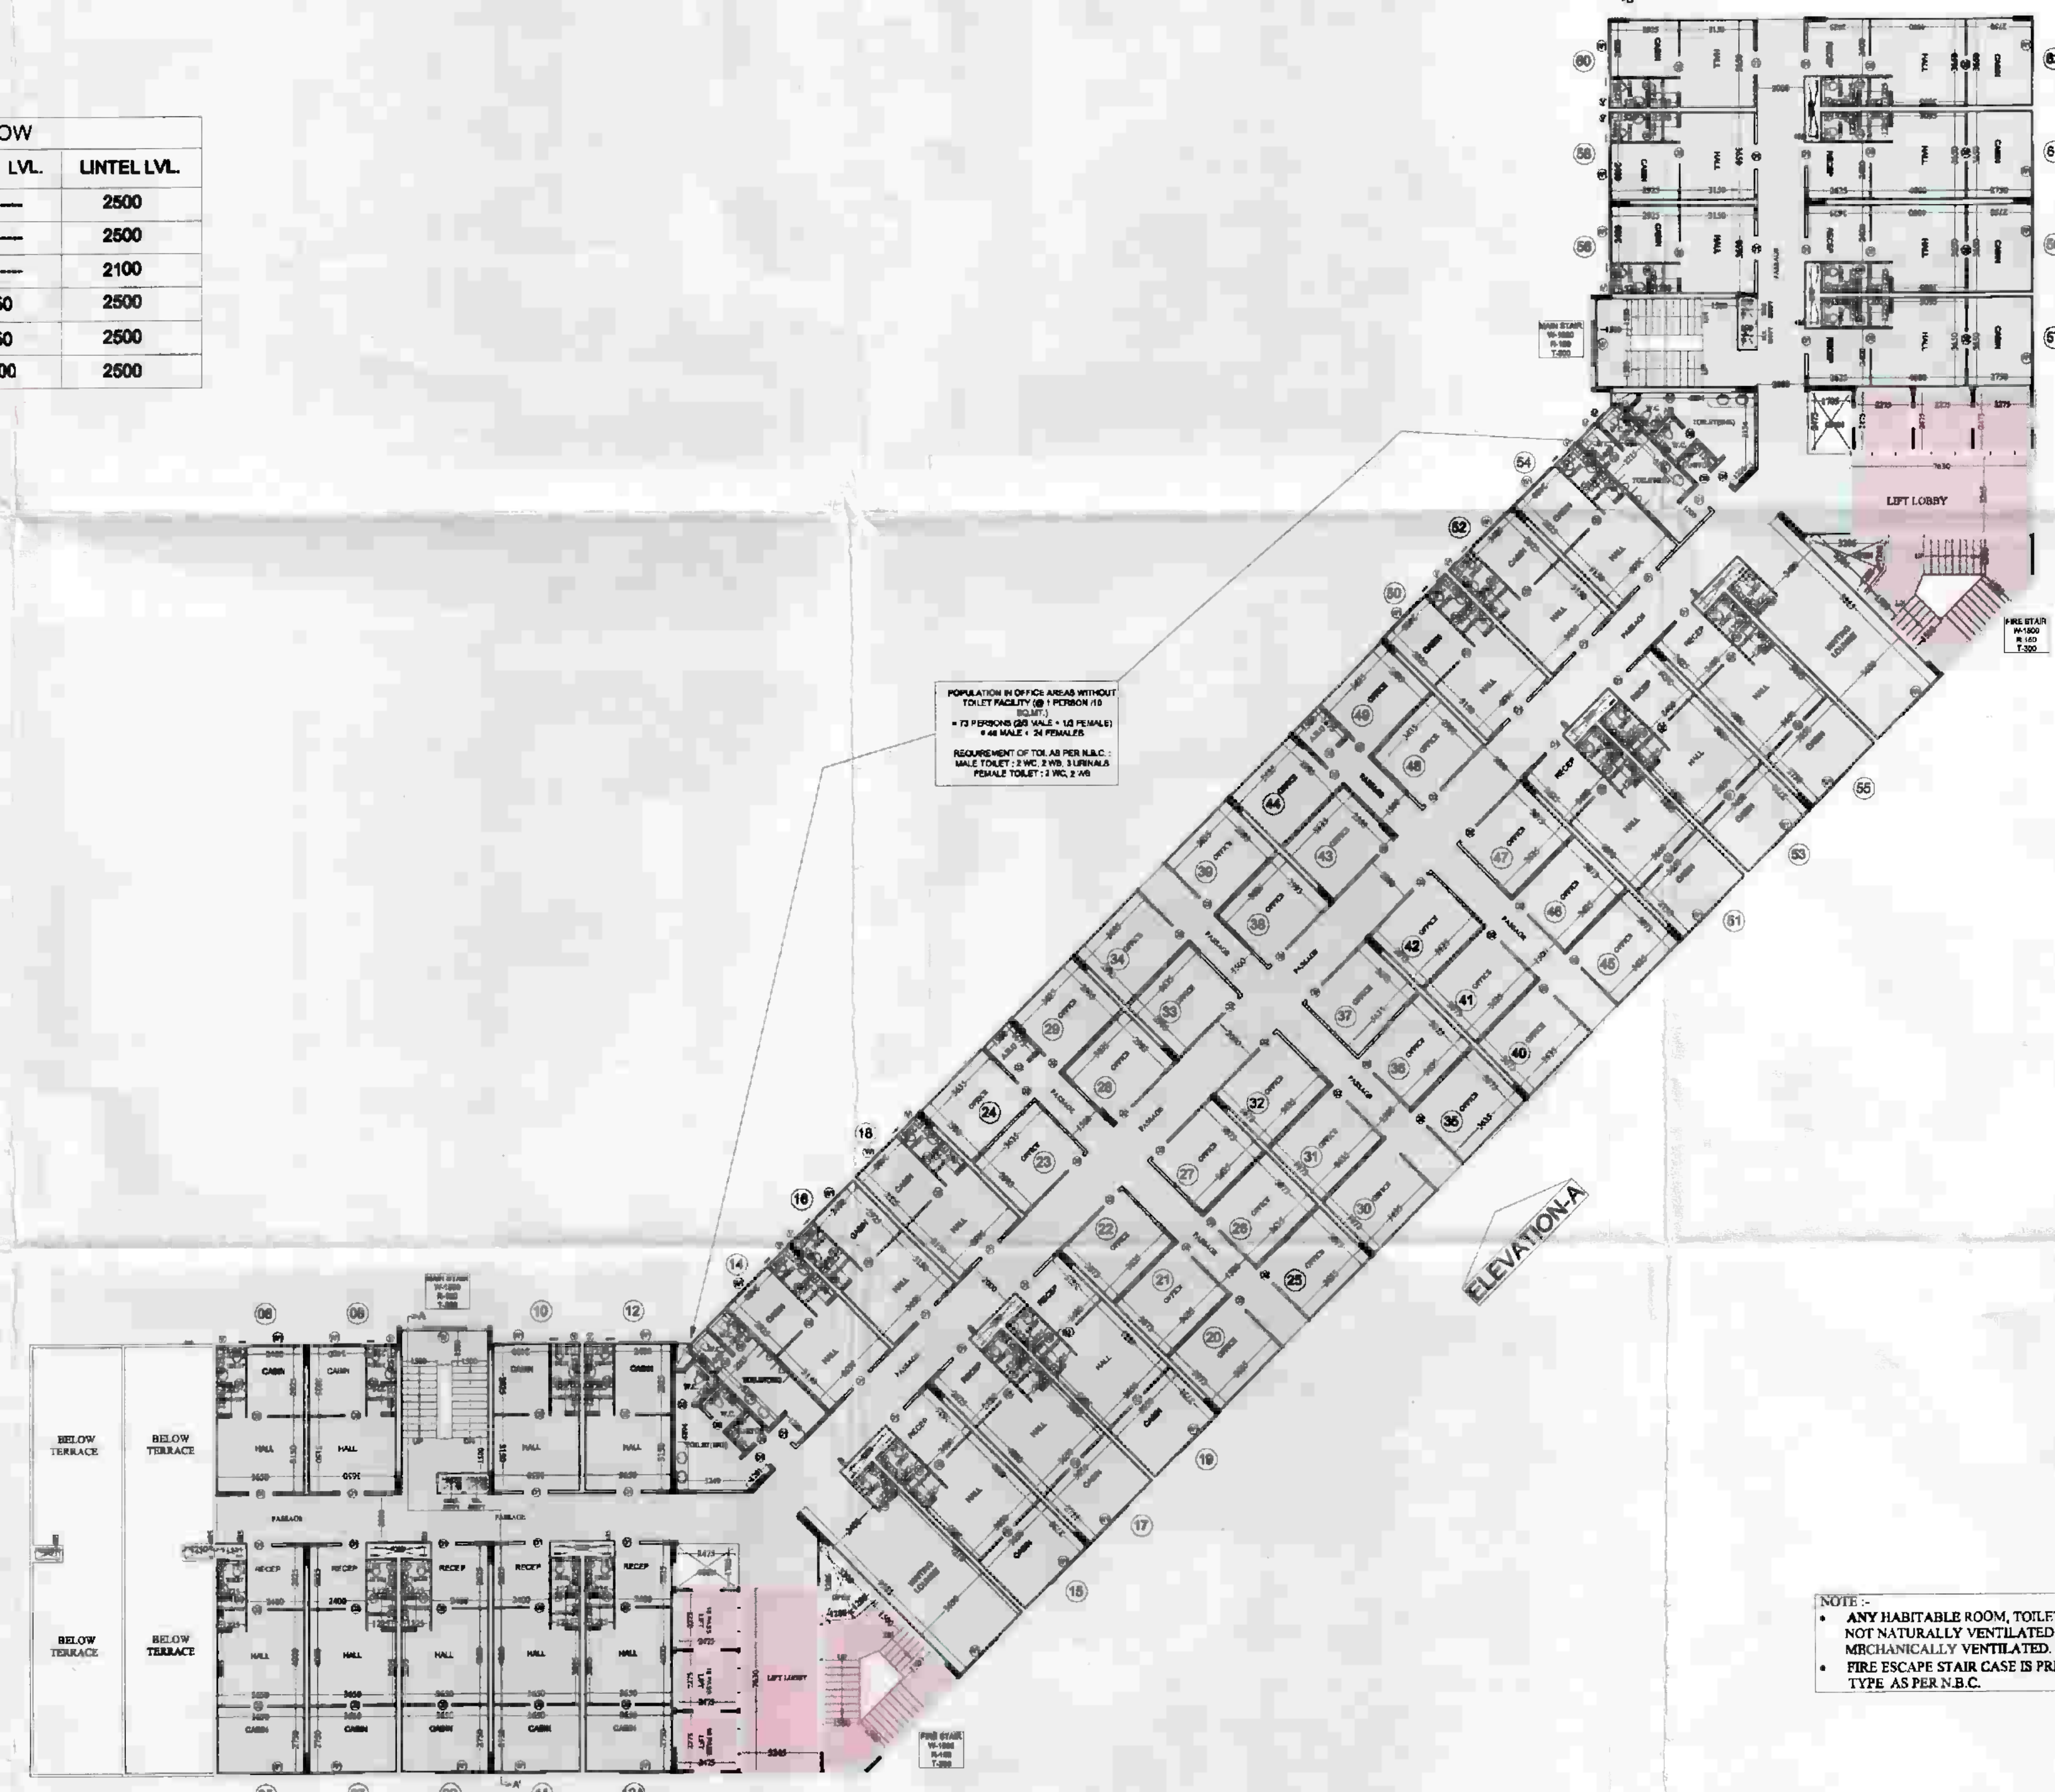

TOWER -A
8th. & 9th. FLOOR PLAN

LEGEND

	I.T. F.A.R.
	INSTITUTIONAL F.A.R.

- NOTE :-
- ANY HABITABLE ROOM, TOILET, KITCHEN NOT NATURALLY VENTILATED ARE MECHANICALLY VENTILATED.
 - FIRE ESCAPE STAIR CASE IS PRESSURIZED TYPE AS PER N.B.C.

PROJECT :-
 PROPOSED I.T. PARK
 AT PLOT No. - 17 SECTOR K.P. - V
 GREATER NOIDA

BUILDERS & PROMOTER :-
 M/S S.K.V. INFOTECH Pvt. Ltd.
 M - 48 GREATER KAILASH PART - II
 NEW DELHI - 110048


DRAWING TITLE :- TOWER -A, B & C
 8th. & 9th. FLOOR PLAN

ARCHITECTS:
 Space Designers International
 Architects Pvt. Ltd.
 5 / 1308, VASUNDHARA, GHAZIABAD
 Ph: 052-42574, 708-9810199, 98133023
 e-mail: spdesign@rediffmail.com, www.spdesign.com


DRAWN BY :- SANJAY
 CHECKED BY :- VISHAL
 SCALE: 1/200
 DATED: 11/07/2011

For SKV Infotech Private Limited
 Authorised Signatory

ARCHITECT'S SIGN

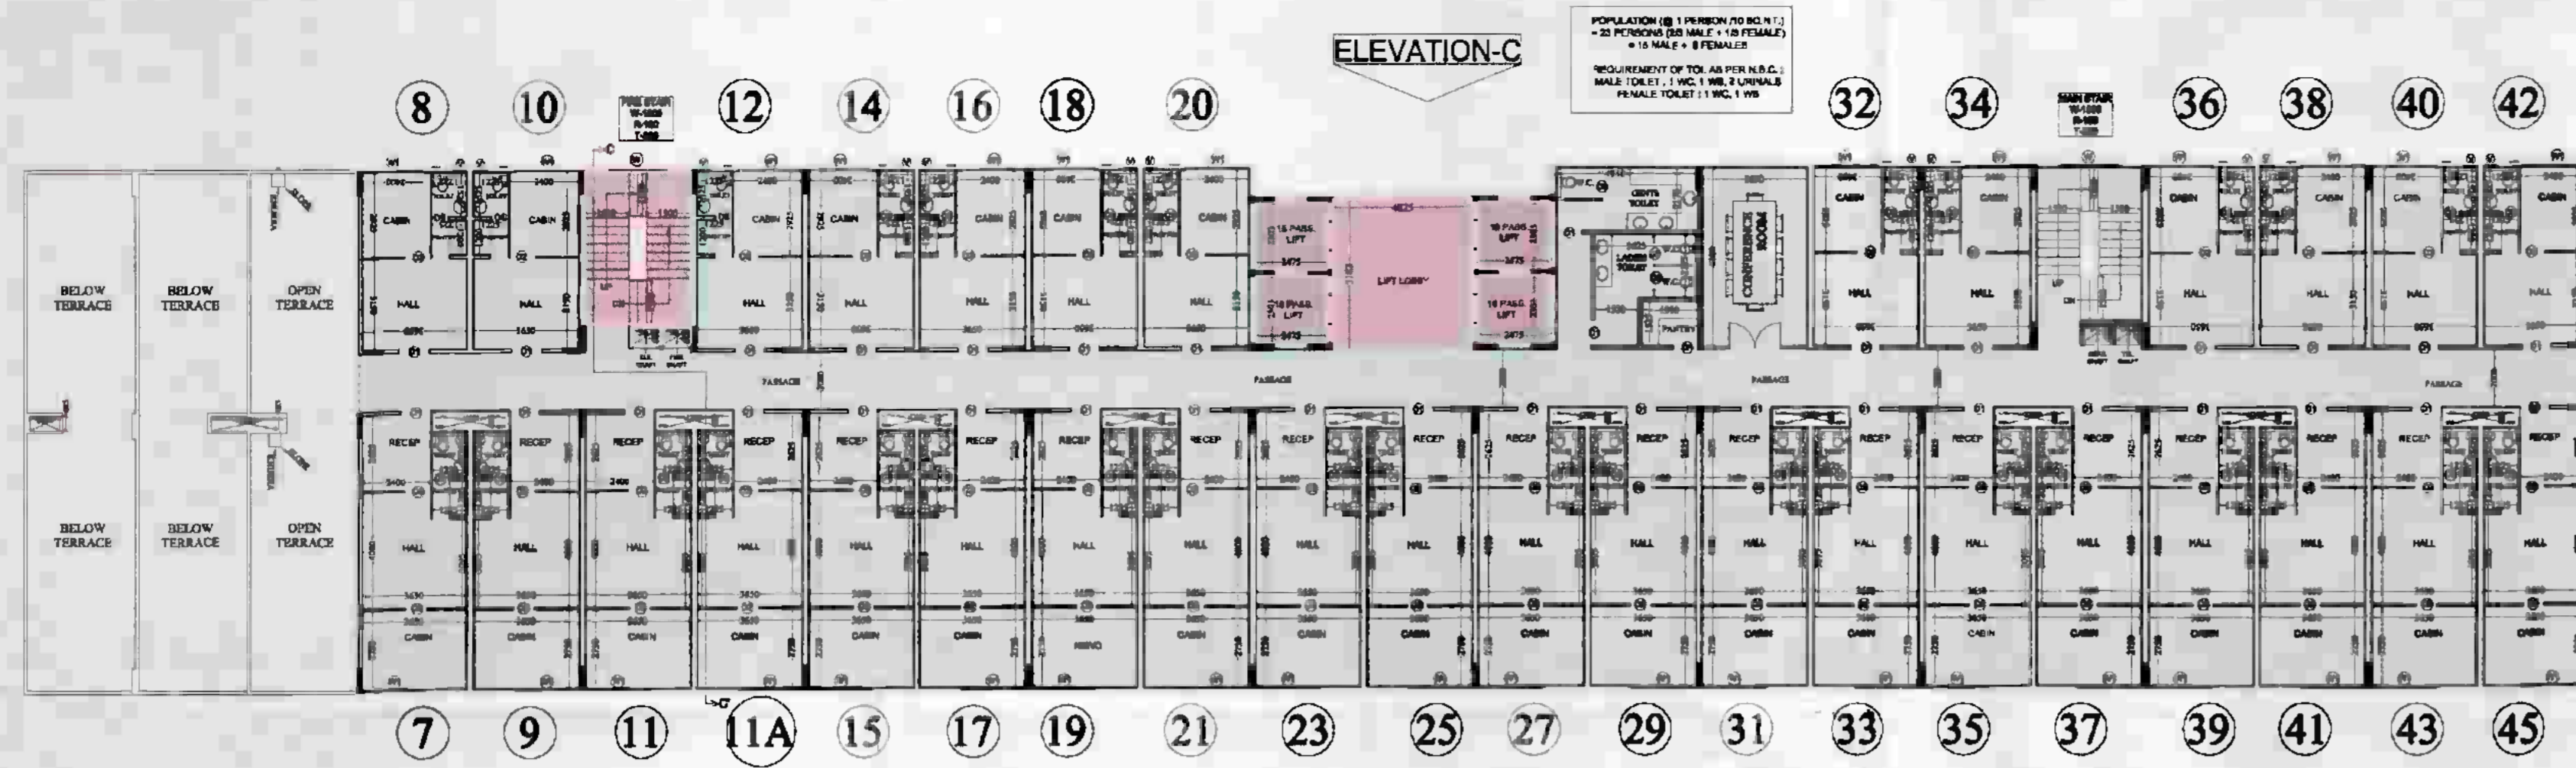

TOWER -C
10th. FLOOR PLAN

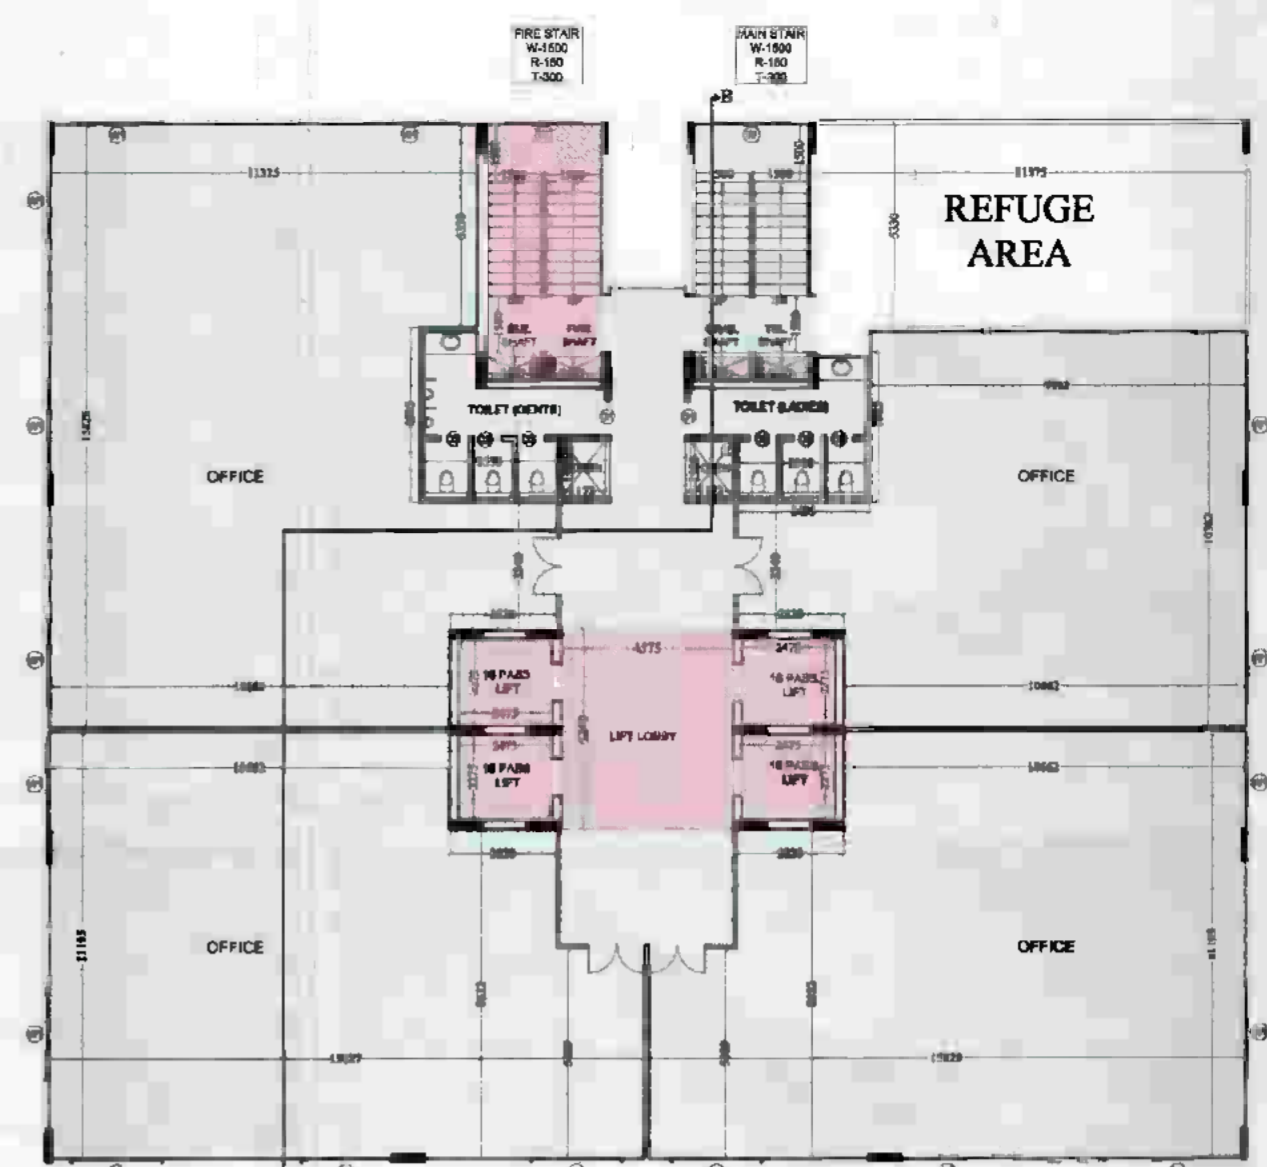

TOWER -B
10th. FLOOR PLAN

SCHEDULE OF DOOR & WINDOW

TYPE	SIZE	CILL. LVL.	LINTEL LVL.
D1	1050 X 2500		2500
D2	900 X 2500		2500
D3	750 X 2100		2100
W	2000 X 2050	450	2500
W1	2200 X 2050	430	2500
V	450 X 1000	1500	2500



TOWER -A
10th. FLOOR PLAN

LEGEND

	I.T. F.A.R.
	INSTITUTIONAL F.A.R.

107-3317/5/5875/14-7-14
 Checked & Verified By
 Manager SS (Planning)

PROJECT :-
 PROPOSED I.T. PARK
 AT PLOT No. - 17 SECTOR K.P. - V
 GREATER NOIDA

BUILDERS & PROMOTER :-
 M/S S.K.V. INFOTECH Pvt. Ltd.
 M - 48 GREATER KAILASH PART-II
 NEW DELHI - 110048

DRAWING TITLE :- TOWER -A,B & C
 10th. FLOOR PLAN

ARCHITECTS:
 Space Designers International
 Architects Pvt. Ltd.
 5 / 1306, VASUNDHARA, GHAZIABAD
 Ph : 0120-4123141, Fax: 0120-23991, 0120-336231
 e-mail: spacedi@rediffmail.com, www.spacedi.com


DRAWN BY :- SANJAY
CHECKED BY :- VISHAL
SCALE :- 1:200
DATED :-

For SKV Infotech Private Limited
 Authorised Signatory




NOTE :-
 * ANY HABITABLE ROOM, TOILET, KITCHEN NOT NATURALLY VENTILATED ARE MECHANICALLY VENTILATED.
 * FIRE ESCAPE STAIR CASE IS PRESSURIZED TYPE AS PER N.B.C.

Authority
 08/32/17/507/117-19
 G.M.
 Noida
 D. Gen. Manager
 & Verified By
 Manager SE (Planning)

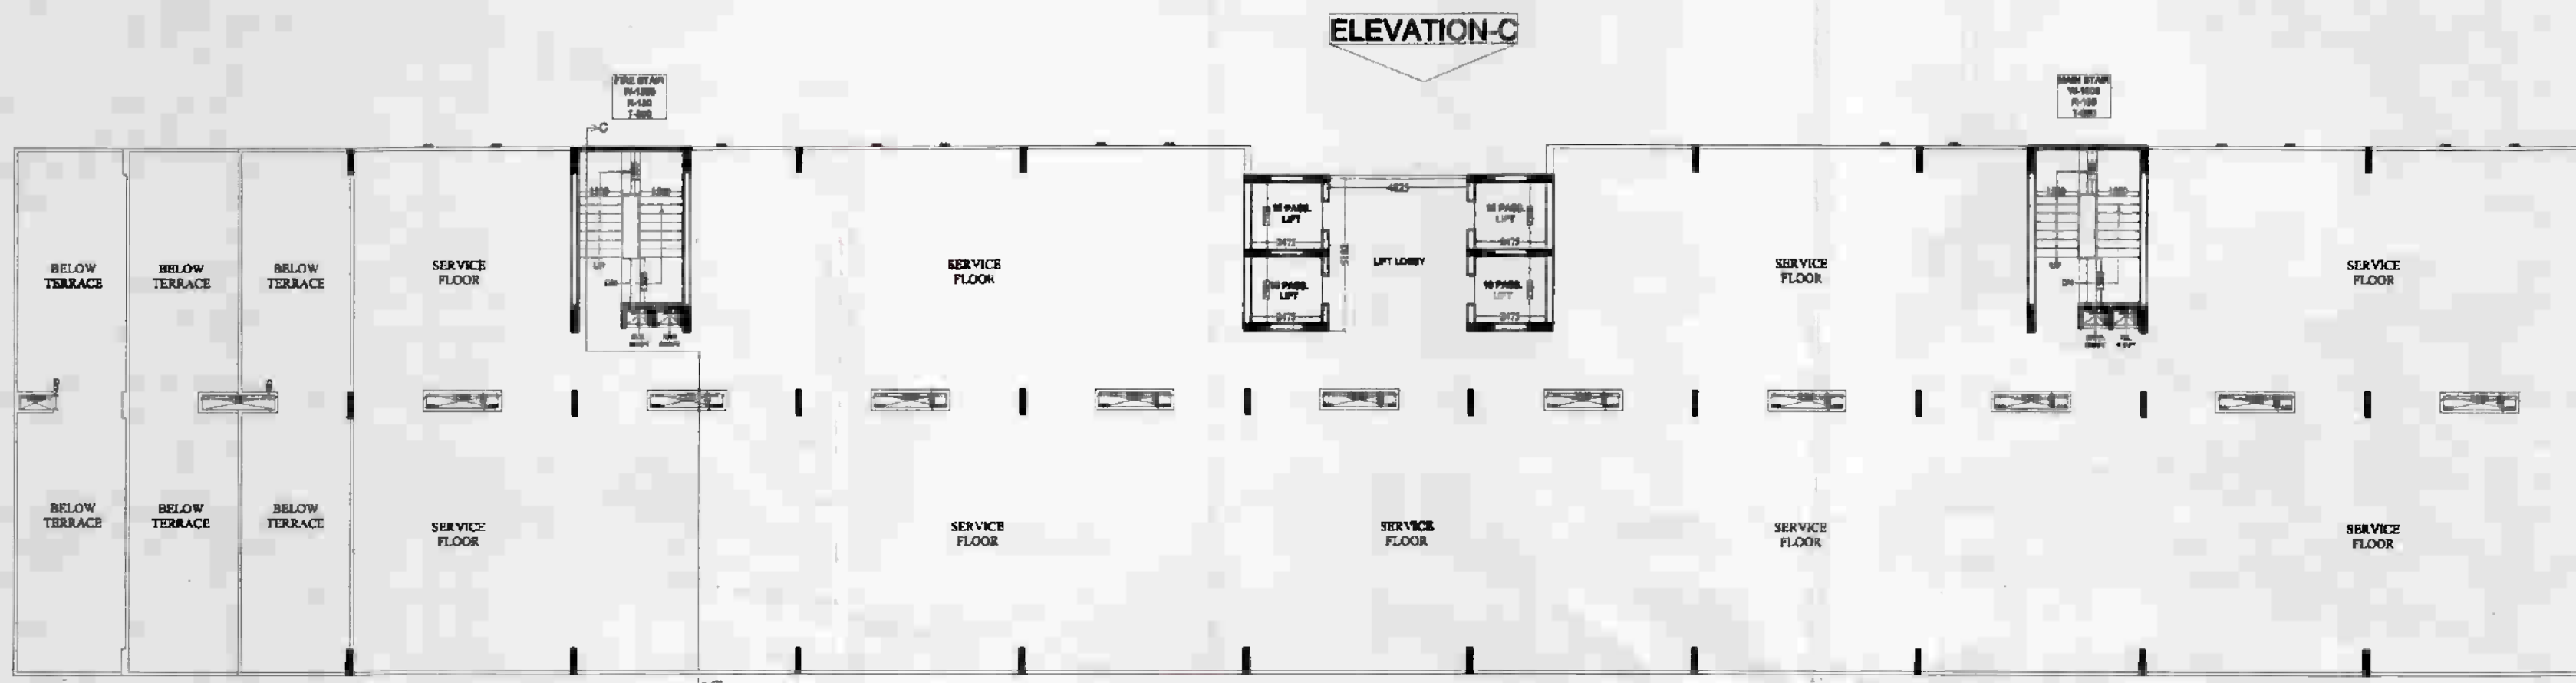

**TOWER -C
 (SERVICE FLOOR)
 11th. FLOOR PLAN**

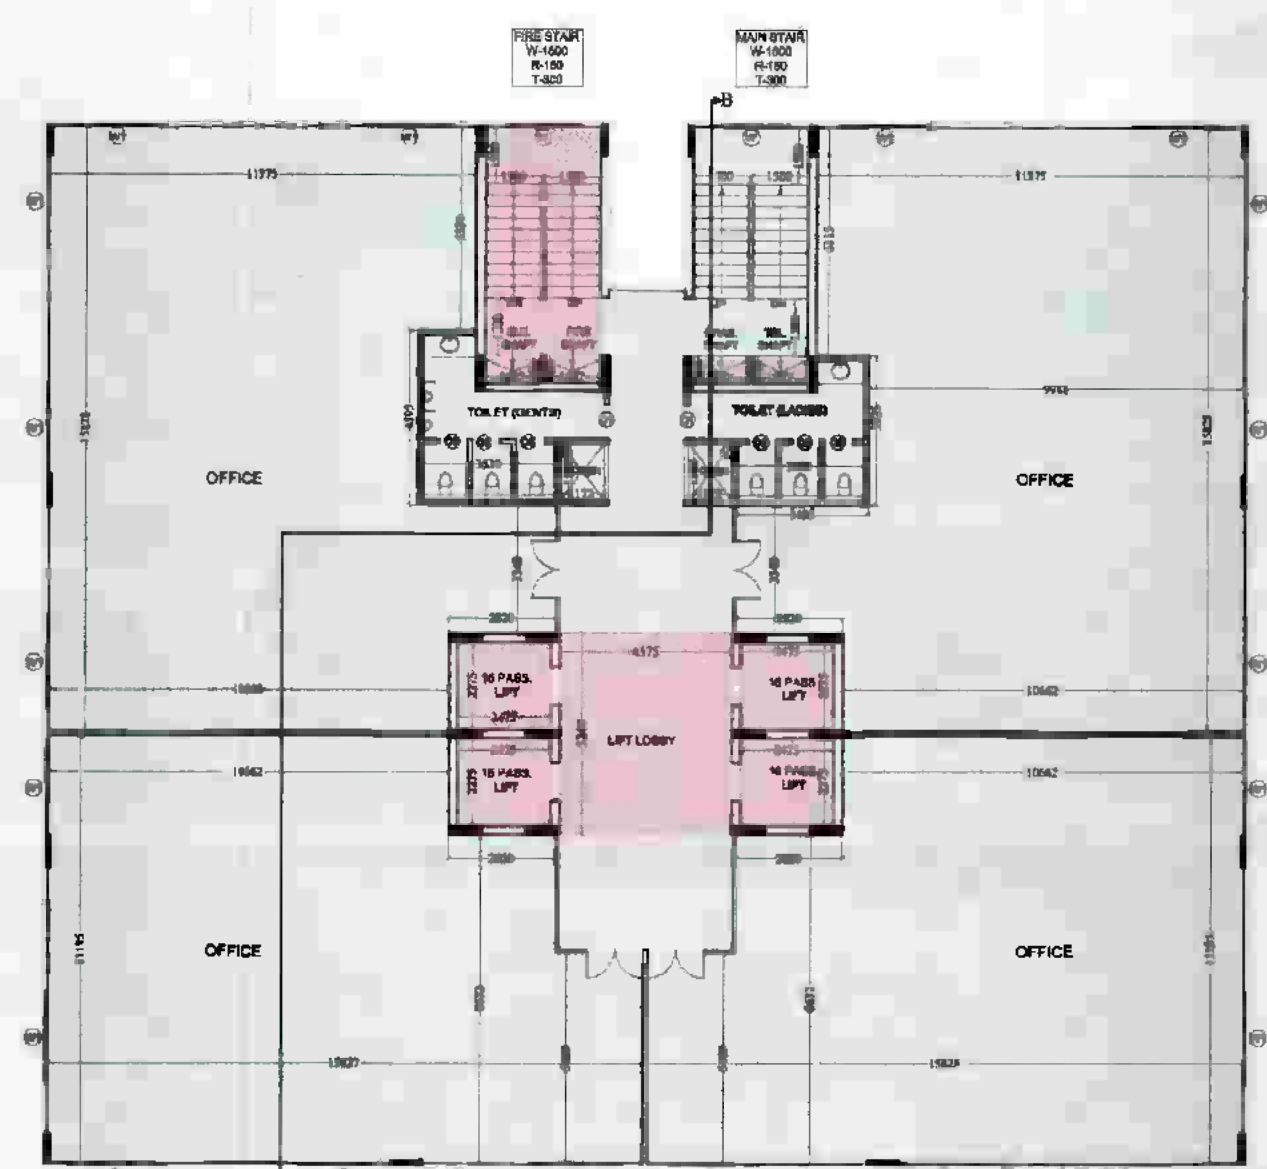

**TOWER -B
 11th. FLOOR PLAN**

SCHEDULE OF DOOR & WINDOW

TYPE	SIZE	CILL. LVL.	LINTEL LVL.
D1	1050 X 2500	---	2500
D2	900 X 2500	---	2500
D3	750 X 2100	---	2100
W	2000 X 2050	450	2500
W1	2200 X 2050	450	2500
V	450 X 1000	1500	2500



**TOWER -A
 11th. FLOOR PLAN**

LEGEND

	I.T. F.A.R.
	INSTITUTIONAL F.A.R.

NOTE :-
 • ANY HABITABLE ROOM, TOILET, KITCHEN NOT NATURALLY VENTILATED ARE MECHANICALLY VENTILATED.
 • FIRE ESCAPE STAIR CASE IS PRESURIZED TYPE AS PER N.B.C.


PROJECT :-
 PROPOSED I.T. PARK
 AT PLOT No. - 17 SECTOR K.P. - V
 GREATER NOIDA
 BUILDERS & PROMOTER :-
 M/S S.K.V. INFOTECH Pvt. Ltd.
 M - AB GREATER KAILASH PART - II
 NEW DELHI - 110048
 DRAWING TITLE :- TOWER -A,B & C
 11th. FLOOR PLAN

ARCHITECTS:
 Space Designers International
 Architects Pvt. Ltd.
 5 / 1308, VASUNDHARA, GHAZIABAD
 Ph: 9054-2574, Fax: 90-07039, 9803625
 email: spacesd@gmail.com, www.spacesd.com


DRAWN BY :- SANJAY
 CHECKED BY :- VISHAL
 SCALE :- 1:200
 DATED :-

For SKV Infotech Private Limited
 Authorised Signatory



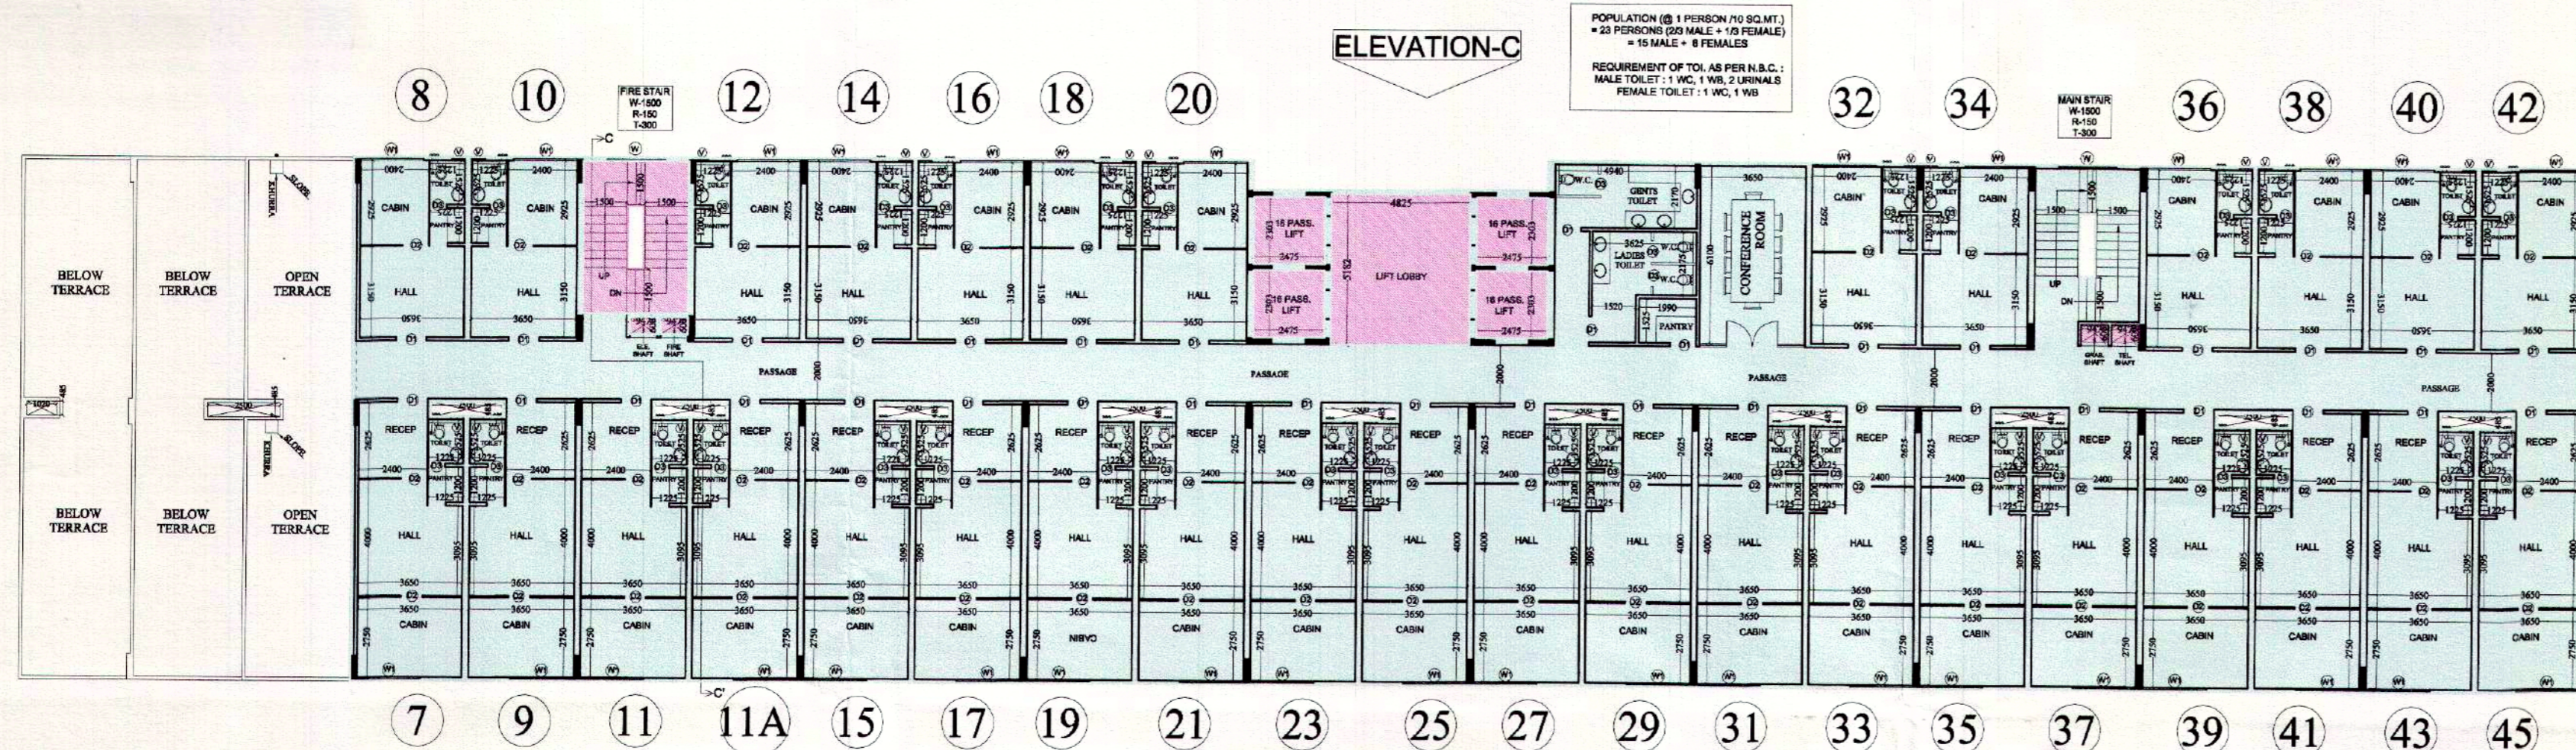


TOWER - C
12th. FLOOR PLAN

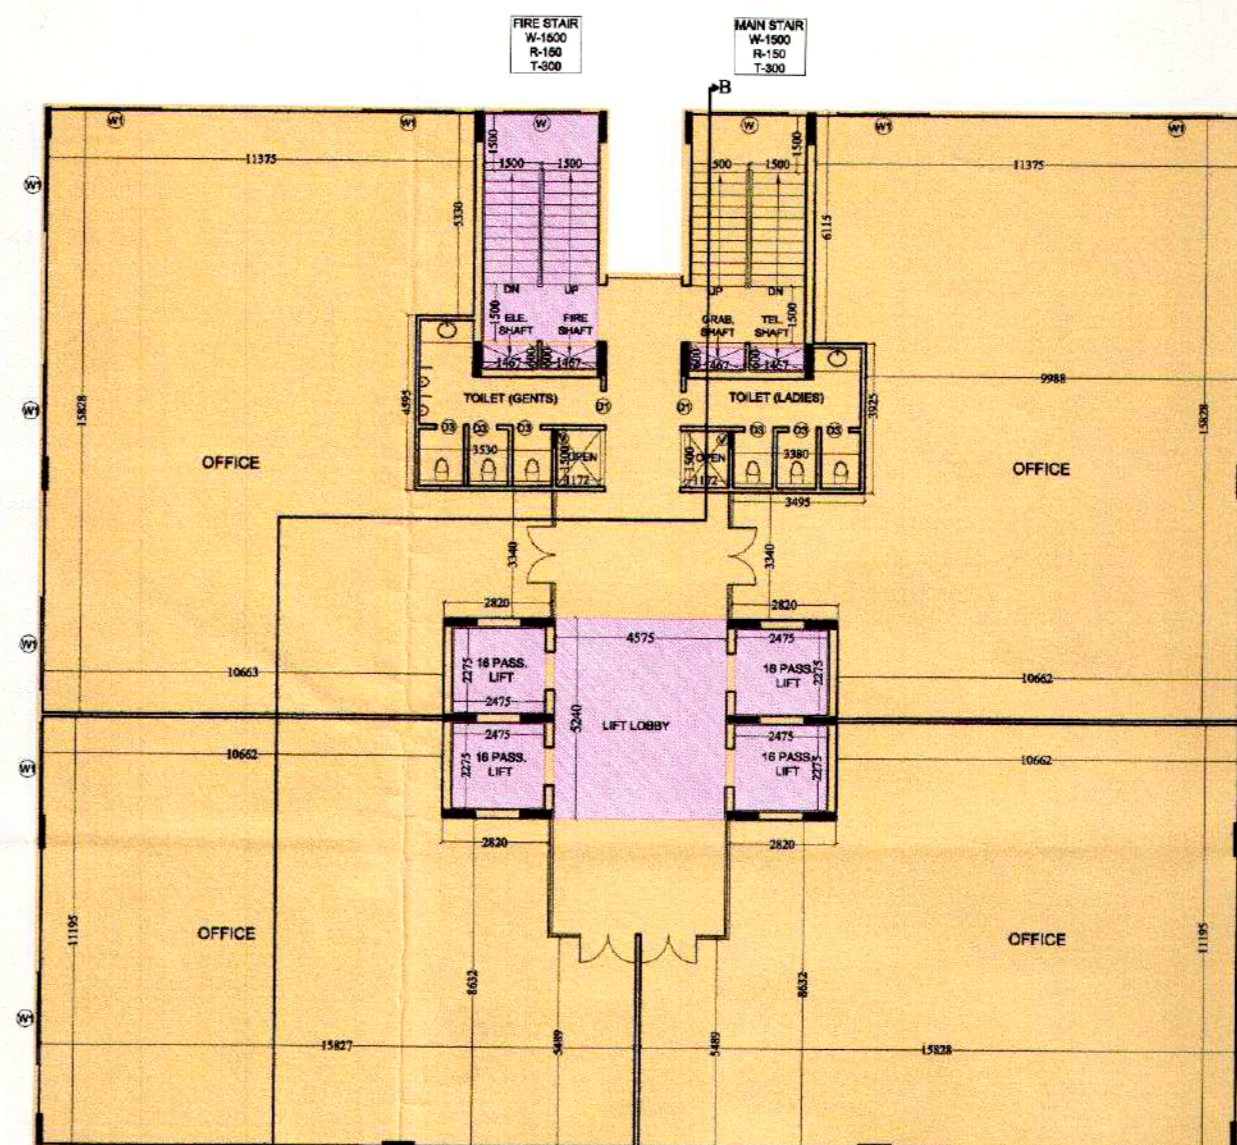

TOWER - B
12th. FLOOR PLAN

SCHEDULE OF DOOR & WINDOW

TYPE	SIZE	CILL LVL.	LINTEL LVL.
D1	1050 X 2500	-----	2500
D2	900 X 2500	-----	2500
D3	750 X 2100	-----	2100
W	2000 X 2050	450	2500
W1	2200 X 2050	450	2500
V	450 X 1000	1500	2500

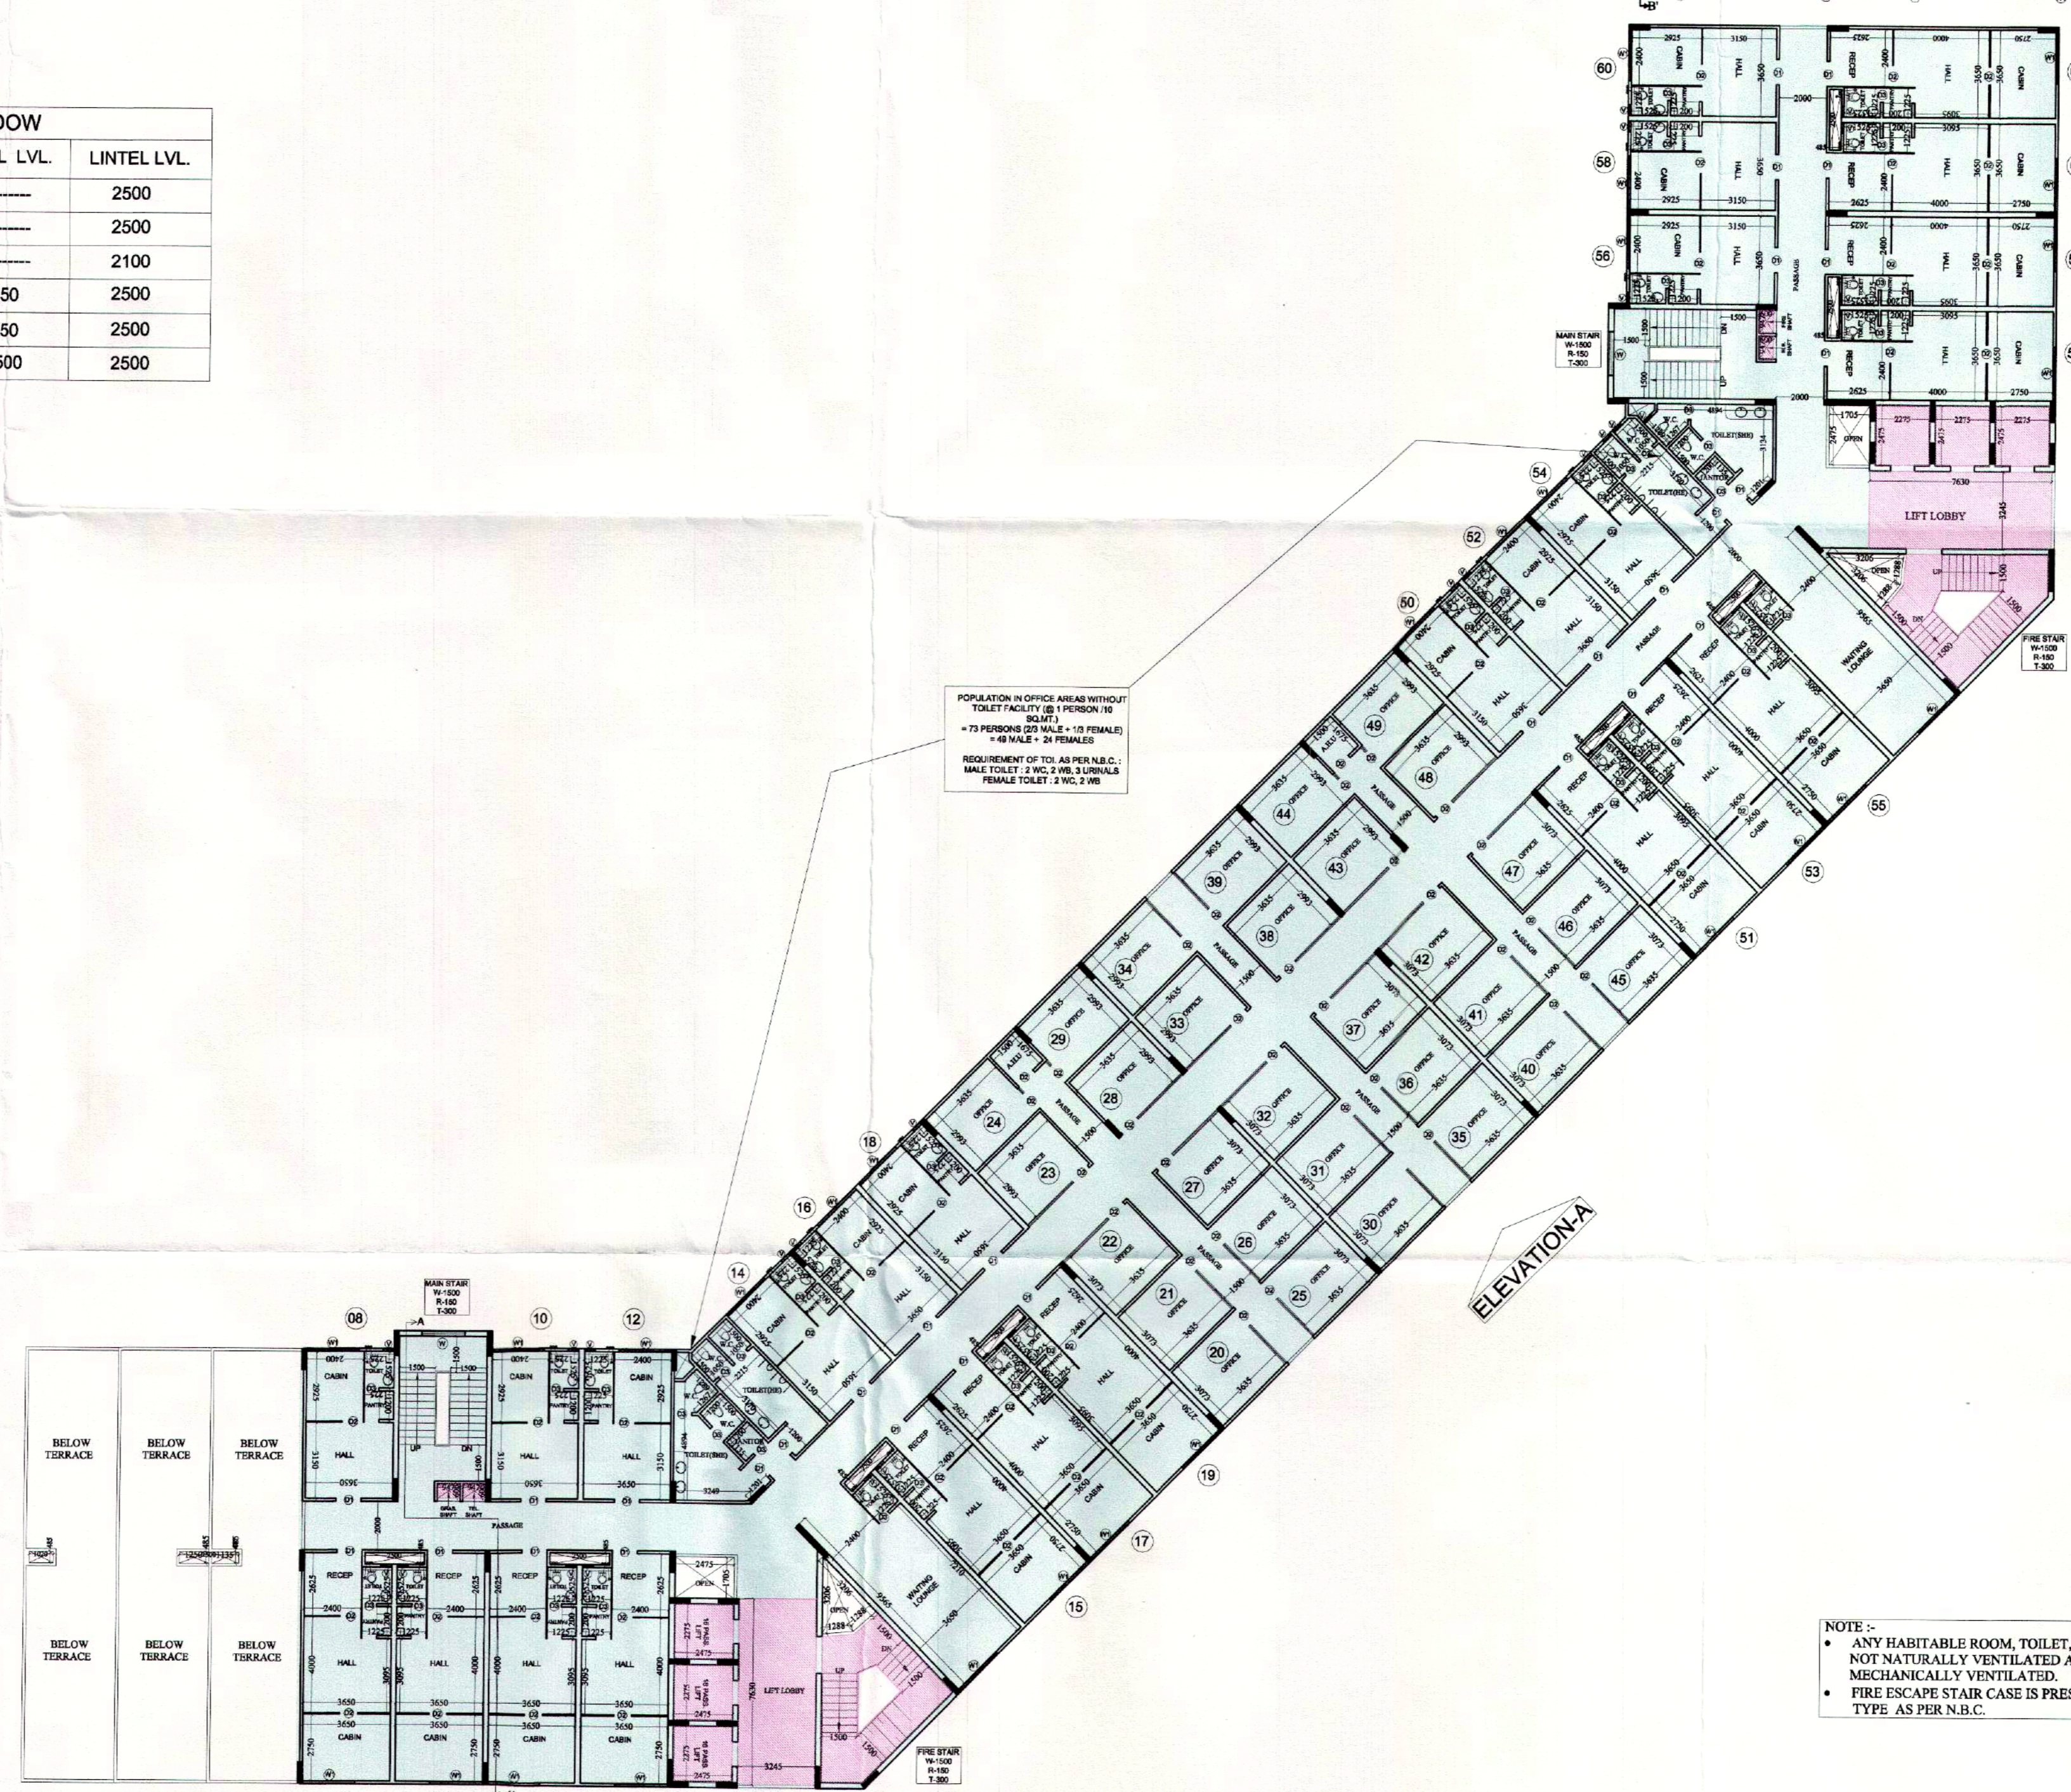

TOWER - A
12th. FLOOR PLAN

Greater Noida Industrial Dev. Authority
 10/13/14/15/17/19
 V. Ed. uti. Date
 Manager
 SE (Planner)

LEGEND

	I.T. F.A.R.
	INSTITUTIONAL F.A.R.

NOTE :-
 • ANY HABITABLE ROOM, TOILET, KITCHEN NOT NATURALLY VENTILATED ARE MECHANICALLY VENTILATED.
 • FIRE ESCAPE STAIR CASE IS PRESURIZED TYPE AS PER N.B.C.

PROJECT :-
 PROPOSED I.T. PARK
 AT PLOT No. - 17 SECTOR K.P. - V
 GREATER NOIDA

BUILDERS & PROMOTER :-
 M/S S.K.V. INFOTECH Pvt. Ltd.
 M - A8 GREATER KAILASH PART - II
 NEW DELHI - 110048


DRAWING TITLE :- TOWER - A, B & C
 12th. FLOOR PLAN

ARCHITECTS:
 Space Designers International
 Architects Pvt. Ltd.
 5 / 1306, VASUNDHARA, GHAZIABAD
 Ph : 01294-025214, Mob : 9810703991, 9813362523
 email : spsdi@gmail.com, www.spsdi.com

DRAWN BY :- CHECKED BY :- SCALE DATED :-
 SANJAY WISHAL 1:200

For SKV Infotech Private Limited
 Authorised Signatory


ARCHITECT'S SIGN
 DRG. NO. - 21

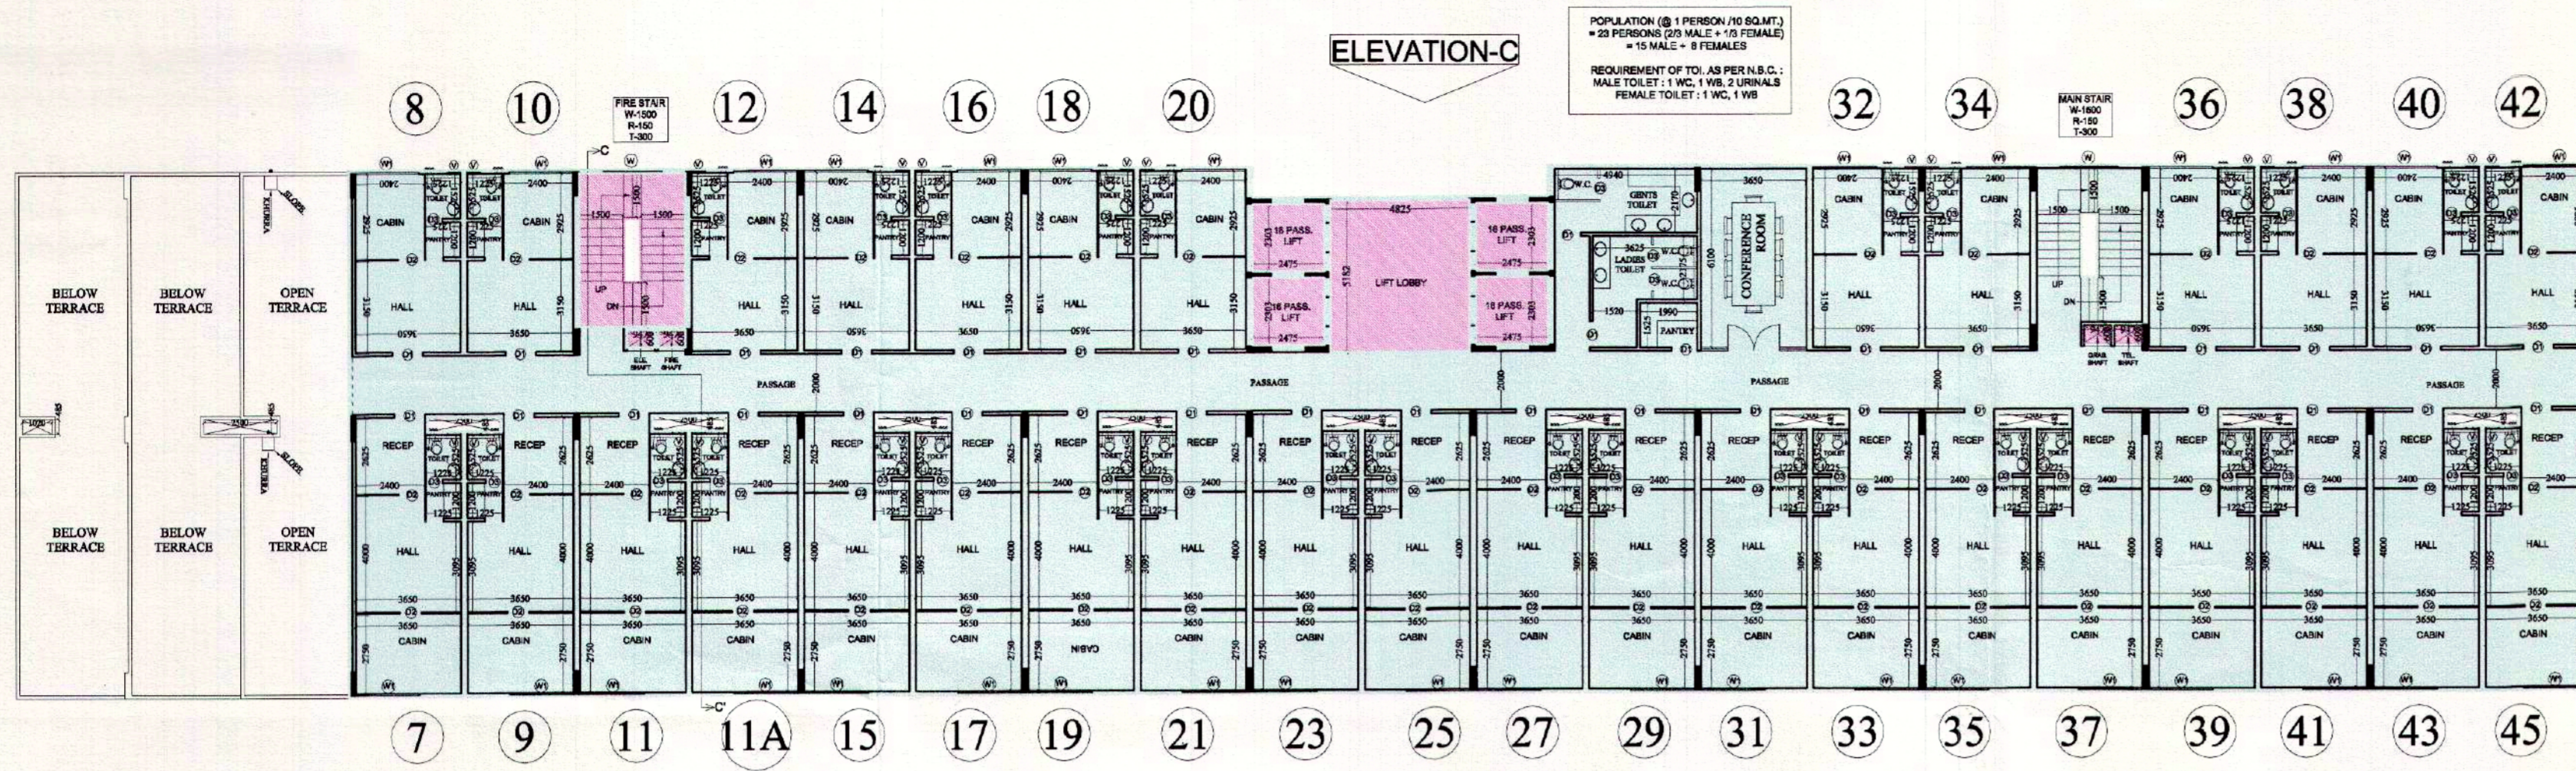


TOWER -C
13th. FLOOR PLAN

SCHEDULE OF DOOR & WINDOW

TYPE	SIZE	CILL LVL.	LINTEL LVL.
D1	1050 X 2500	-----	2500
D2	900 X 2500	-----	2500
D3	750 X 2100	-----	2100
W	2000 X 2050	450	2500
W1	2200 X 2050	450	2500
V	450 X 1000	1500	2500

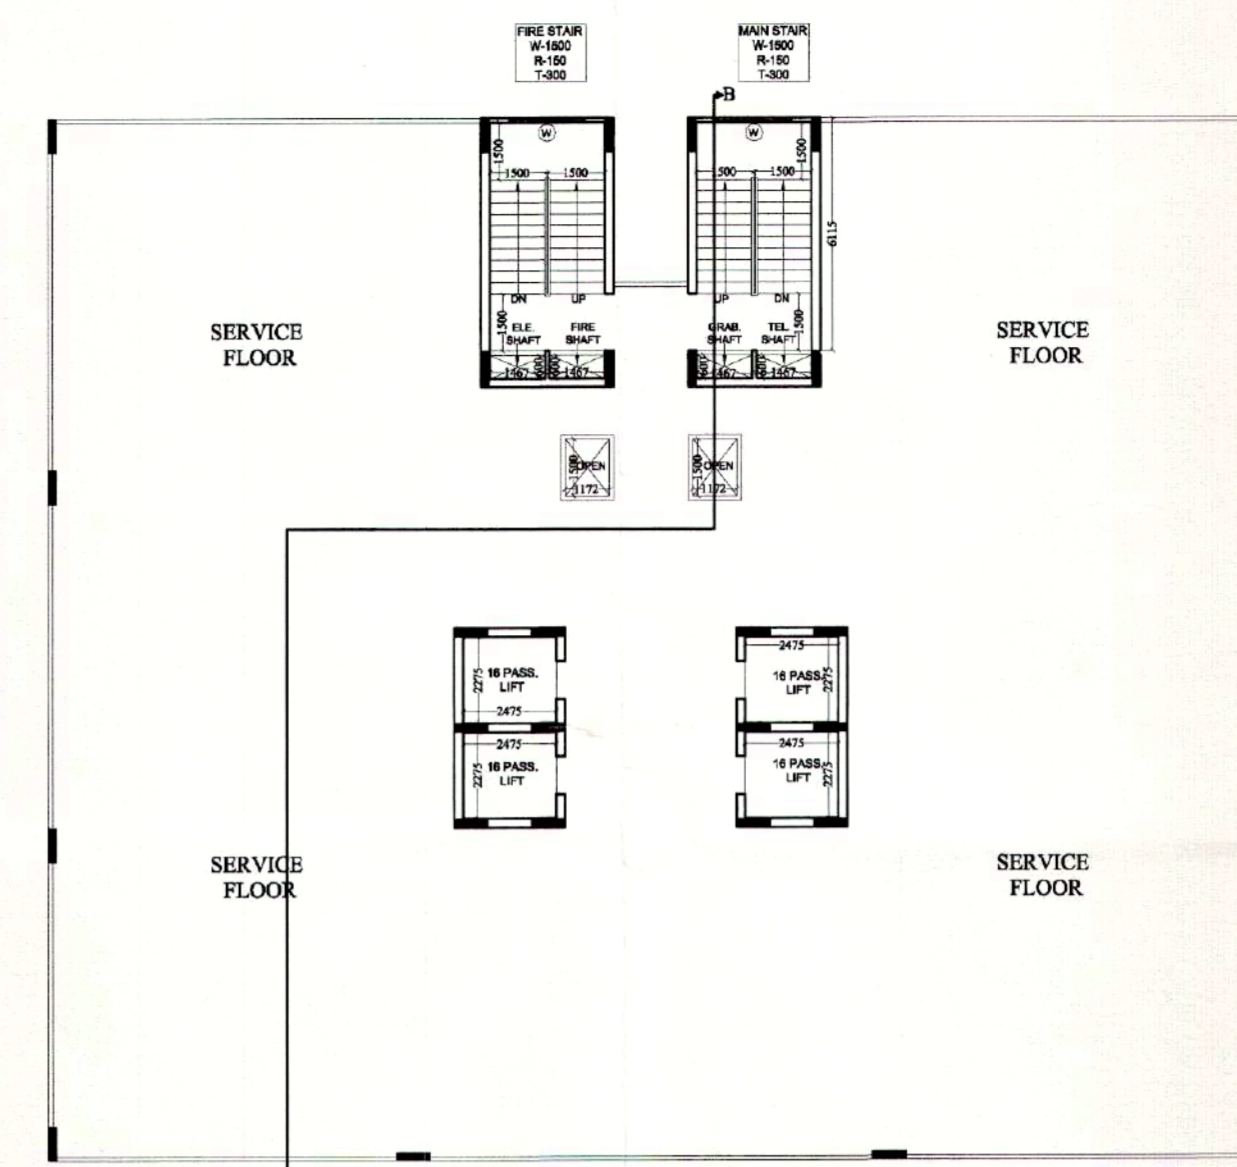

TOWER -B
(SERVICE FLOOR)
13th. FLOOR PLAN

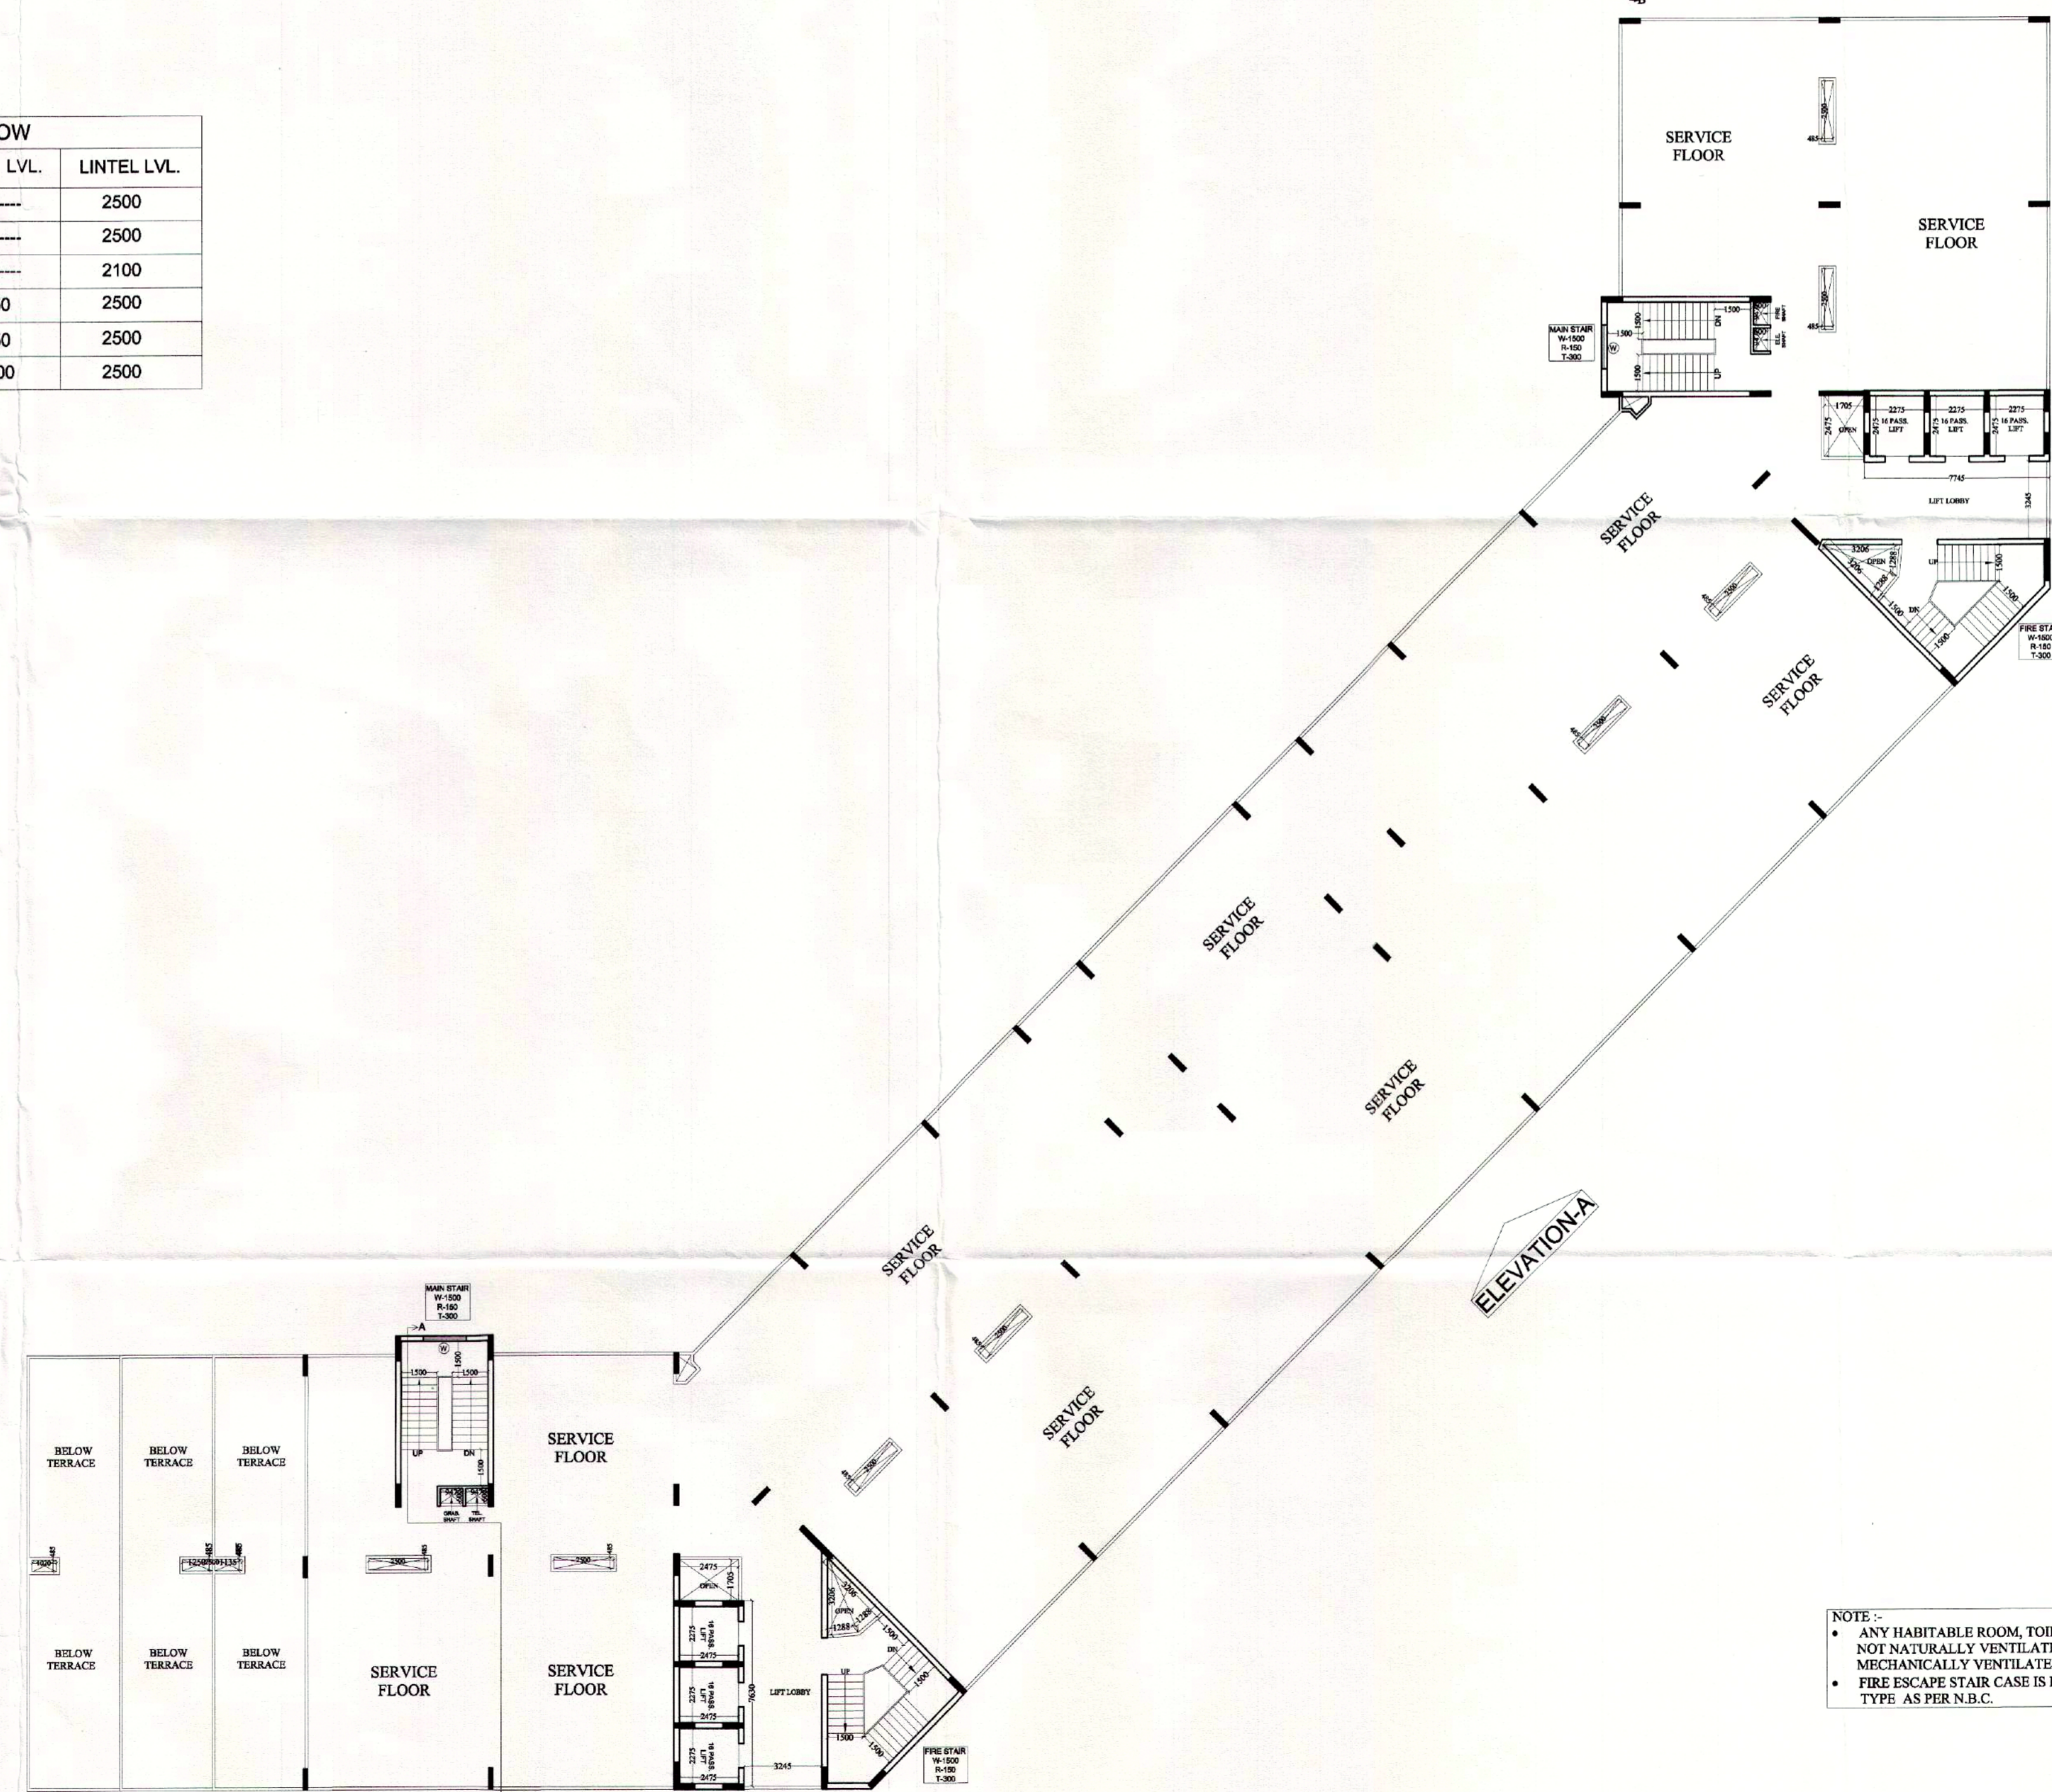

TOWER -A
(SERVICE FLOOR)
13th. FLOOR PLAN

02/03/2019 5:30 PM / 21/7/19
Valid till
G.M. (Planning)
Dr. Gen. Manager (Planning)
Drawing Checked & Verified By
Manager SE (Planning)

POPULATION (B) 1 PERSON/10 ROOMS
= 87 PERSONS (50 MALE + 10 FEMALES)
REQUIREMENT OF T.O. AS PER N.B.C.:
MALE TOILET : 3 W.C. 1 URINALS
FEMALE TOILET : 3 W.C. 1 W.B.

LEGEND

	I.T. F.A.R.
	INSTITUTIONAL F.A.R.

NOTE :-
• ANY HABITABLE ROOM, TOILET, KITCHEN NOT NATURALLY VENTILATED ARE MECHANICALLY VENTILATED.
• FIRE ESCAPE STAIR CASE IS PRESSURIZED TYPE AS PER N.B.C.

PROJECT :-
PROPOSED I.T. PARK
AT PLOT No. - 17 SECTOR K.P. - V
GREATER NOIDA


BUILDERS & PROMOTER :-
M/S S.K.V. INFOTECH Pvt. Ltd.
M - A8 GREATER KAILASH PART - II
NEW DELHI - 110048

DRAWING TITLE :- TOWER -A, B & C
13th. FLOOR PLAN

ARCHITECTS:
Space Designers International
Architects Pvt. Ltd.
5 / 1306, VASUNDHARA, GHAZIABAD
PH : 0120-42224, MOB: 981072099, 981035223
e-mail : space@spaid.com, www.spaid.com

DRAWN BY :- SANJAY
CHECKED BY :- VISHAL
SCALE :- 1/200
DATED :-

For SKV Infotech Private Limited
Authorised Signatory

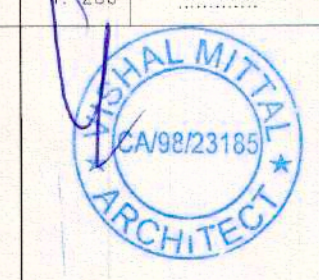

ARCHITECT'S SIGN.
DRG.NO. - 22