


PLUMBING LEGEND:-	
④	110 OD uPVC TERRACE RAIN WATER PIPE
④s	160 OD uPVC TERRACE RAIN WATER PIPE
⑤	90 OD uPVC BALCONY RAIN WATER PIPE
---	EXTERNAL SEWER LINE
---	EXTERNAL STORM WATER LINE
---	DOMESTIC WATER SUPPLY FILLING LINE FROM MUNICIPAL / TANKER LINE.
---	IRRIGATION WATER SUPPLY LINE
---	TUBE WELL WATER SUPPLY LINE
---	EXTERNAL FIRE HYDRANT LINE
R.P.	RECHARGE PIT (3000 MM DIA)
D.C.	DESILTING CHAMBER (1000 x 2000 MM DIA)
⊠	VALVE WITH CHAMBER
⊠	NON RETURN VALVE WITH CHAMBER

PLUMBING LEGEND:-	
⊙	SEWER MANHOLE WITH 5600 MANHOLE COVER.
(I)	910 DIA MANHOLE UPTO 1.67 M DEPTH
(II)	1220 DIA MANHOLE UPTO 2.29 M DEPTH
(III)	1520 DIA MANHOLE ABOVE 2.29 M DEPTH
⊙	STORM WATER MANHOLE WITH 5600 PERFORATED MANHOLE COVER.
(I)	910 DIA MANHOLE UPTO 1.67 M DEPTH
(II)	1220 DIA MANHOLE UPTO 2.29 M DEPTH
(III)	1520 DIA MANHOLE ABOVE 2.29 M DEPTH
⊠	STORM WATER CATCH BASIN SIZE=(600x600)mm
⊠	EXTERNAL FIRE HYDRANT
⊠	2-WAY FIRE BRIGADE WITHDRAWAL CONNECTION.
⊠	3-WAY FIRE BRIGADE INLET CONNECTION.
⊠	GARDEN HYDRANT
G.L.	GROUND LEVEL
I.L.	INVERT LEVEL
C.L.	CONNECTION LEVEL

PLUMBING LEGEND:-	
⊠	RAIN WATER HARVESTING

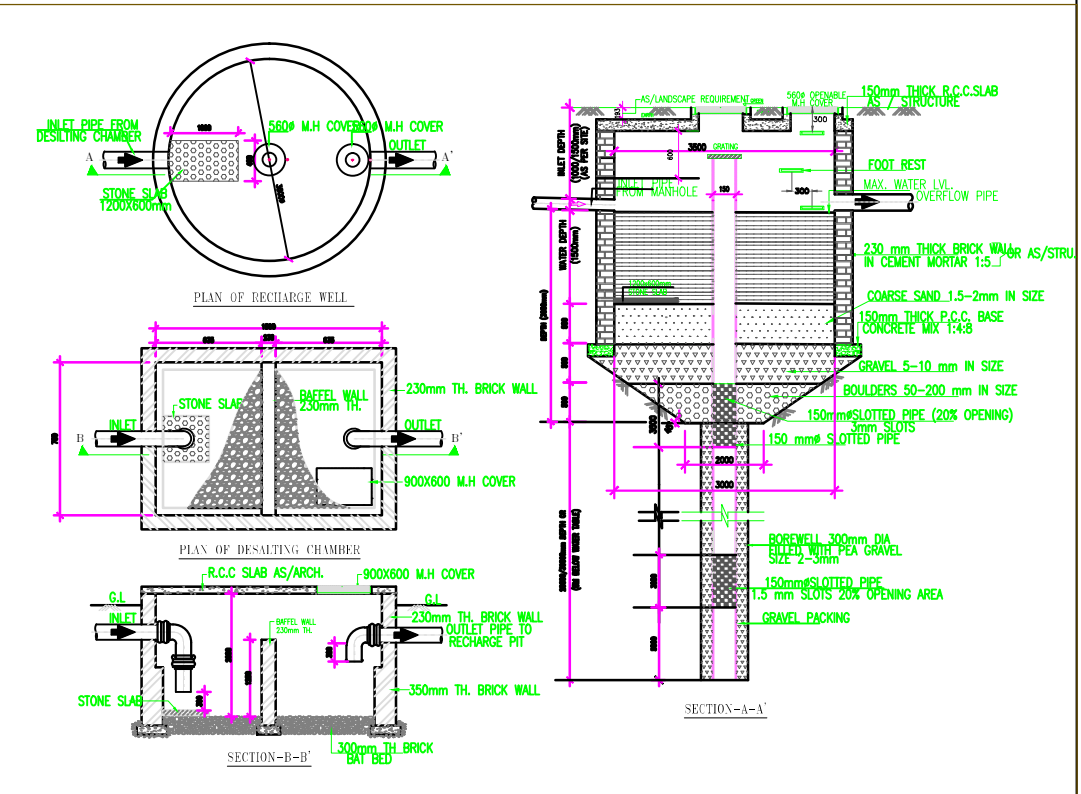

⊠	WATER TANK BELOW
⊠	STP BELOW

PROJECT:
DRAWING FOR THE PROPOSED GROUP HOUSING PROJECT " PLANET - I AT PLOT NO. - GH-07 KOYAL ENCLAVE LONI ROAD GHAZIABAD (U.P.)

OWNER:
MS ANDROMIDA REAL ESTATE CONSORTIUM PVT. LTD.


DRAWING TITLE:
PLAN OF DEVELOPMENT OF WORK

OWNERS SIGN	ARCHITECTS SIGN
-------------	-----------------

Design Studio
ANUJ AGARWAL ARCHITECTS
OFFICE- A-244 KAUSHAMBI GHAZIABAD (U.P.)
PH-0120- 6454182 / 84, 4165716. TEL. FAX - 2773592
e-mail : anuj.agarwal@gmail.com

SCALE	DEALT BY A. CHAUHAN	DATE
DESIGN BY	CHECKED BY	DRG. No. DG-02

SITE PLAN

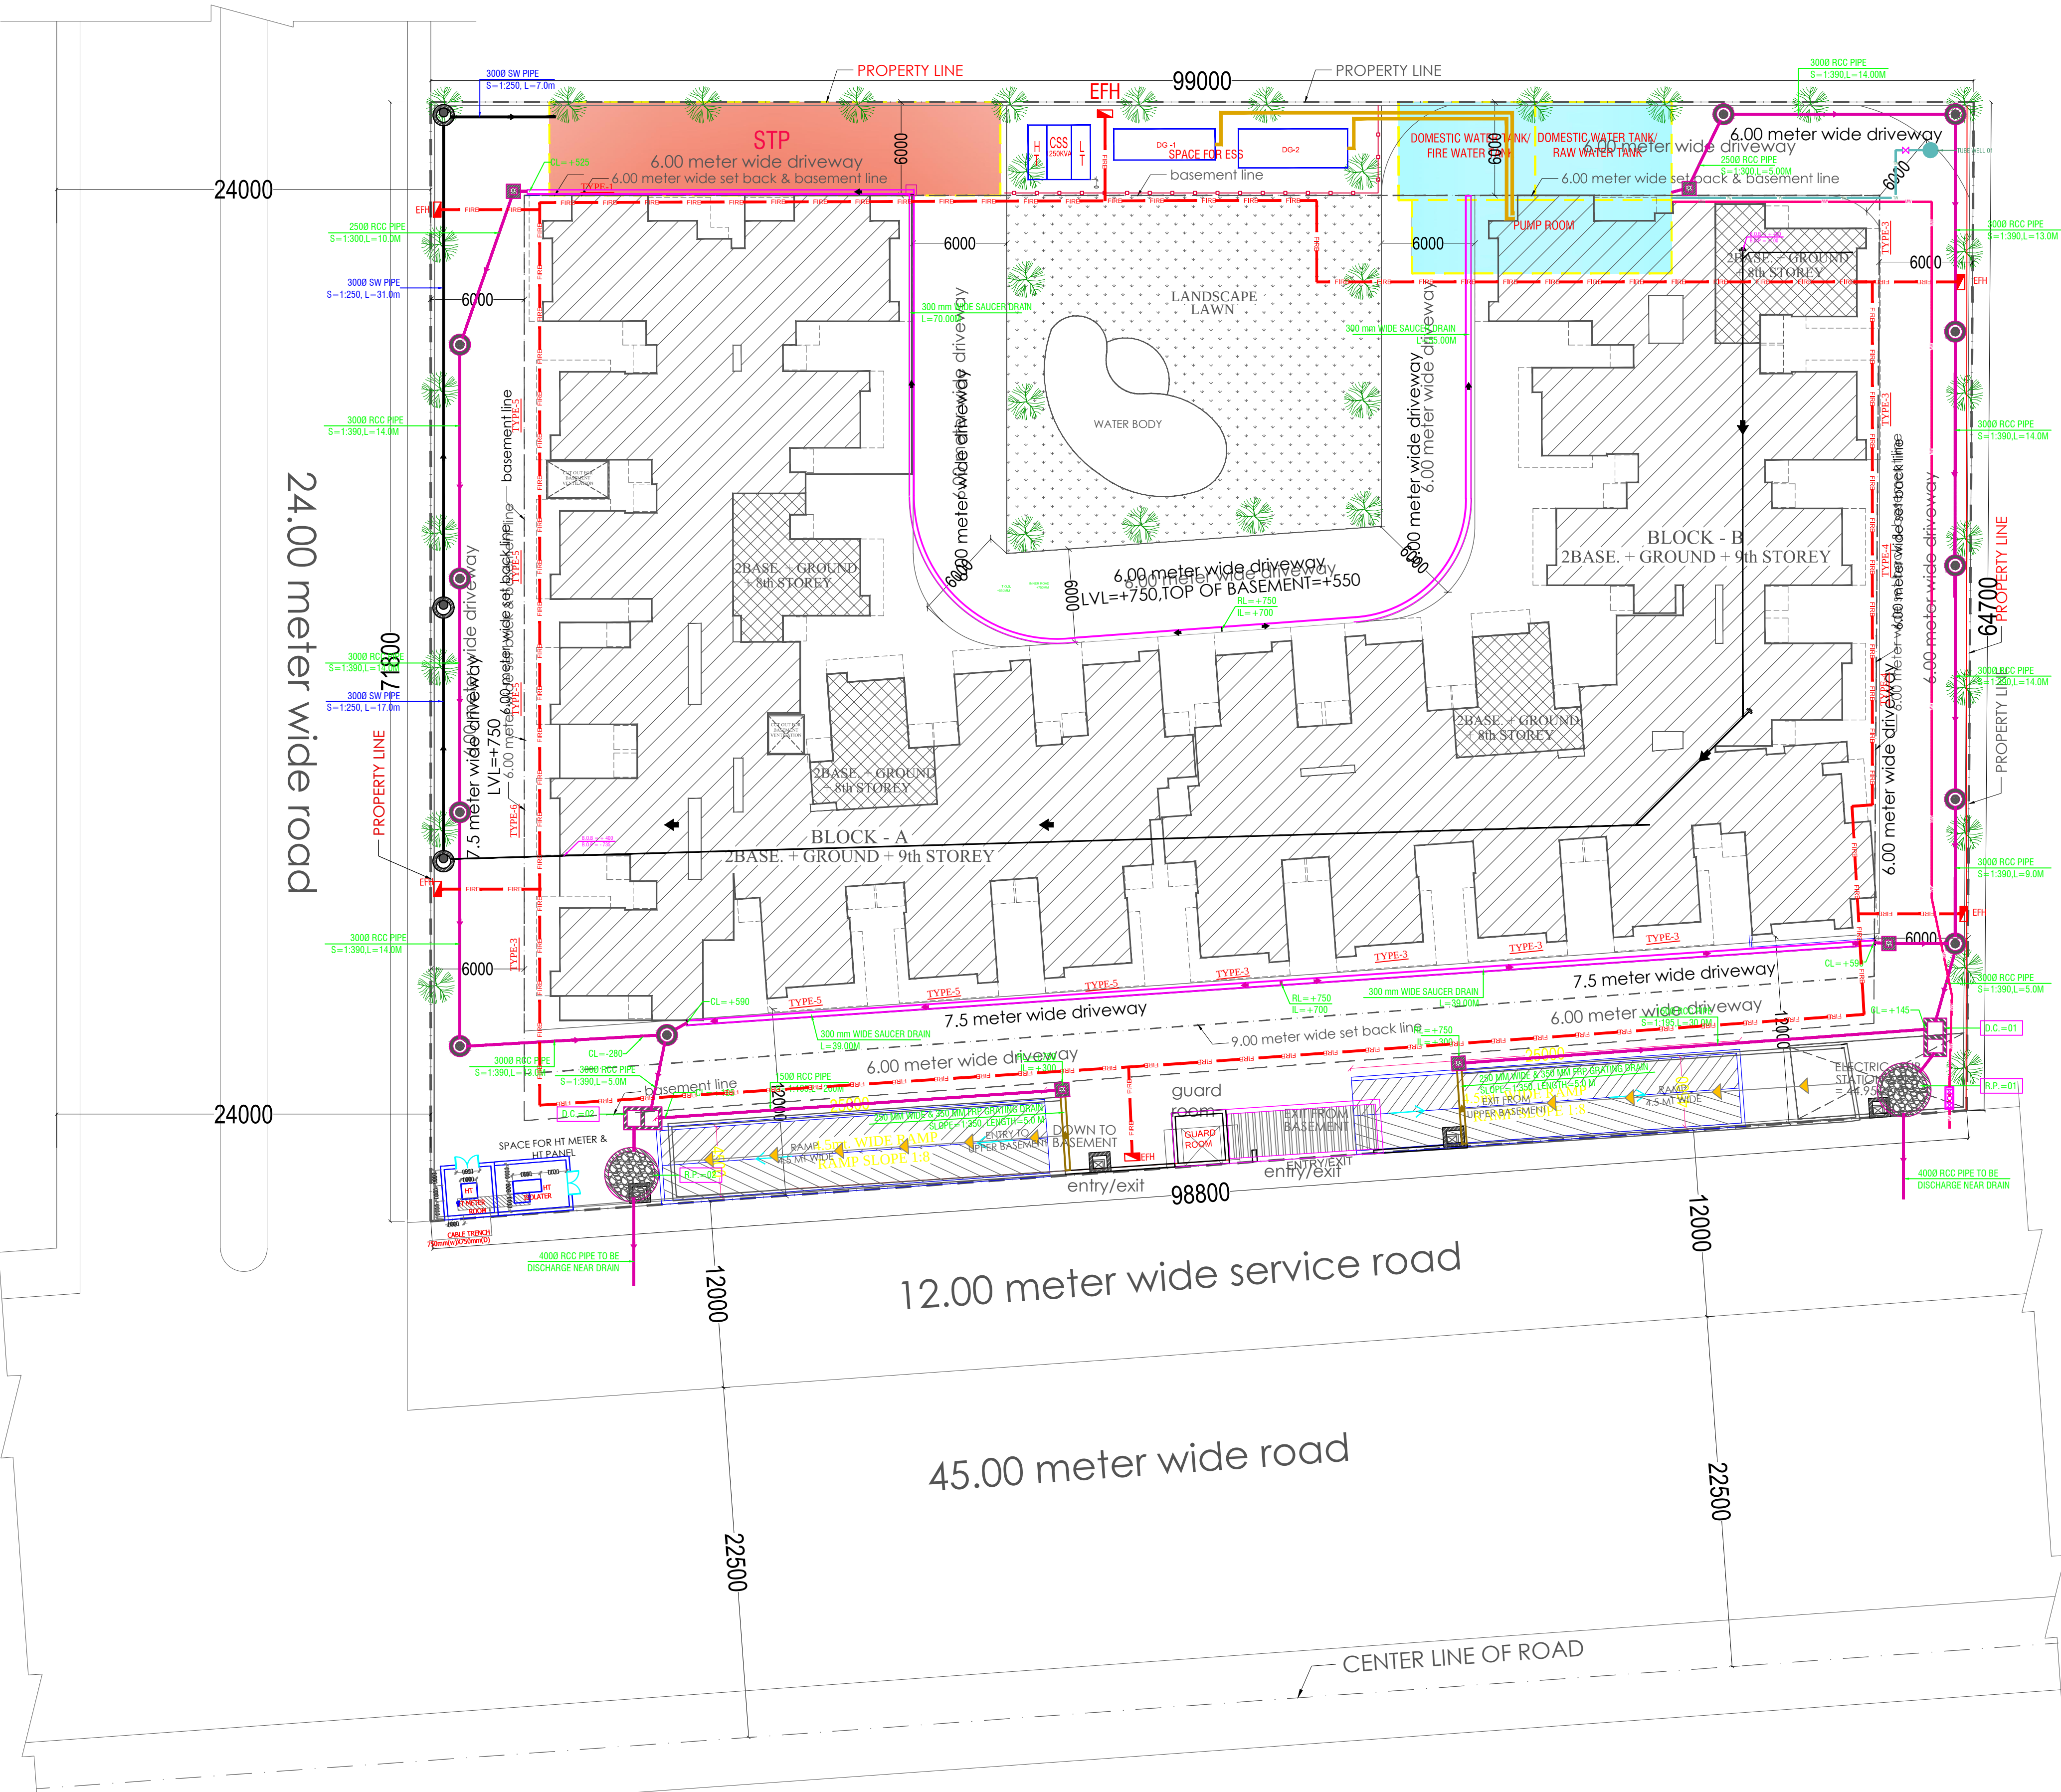

SITE PLAN