



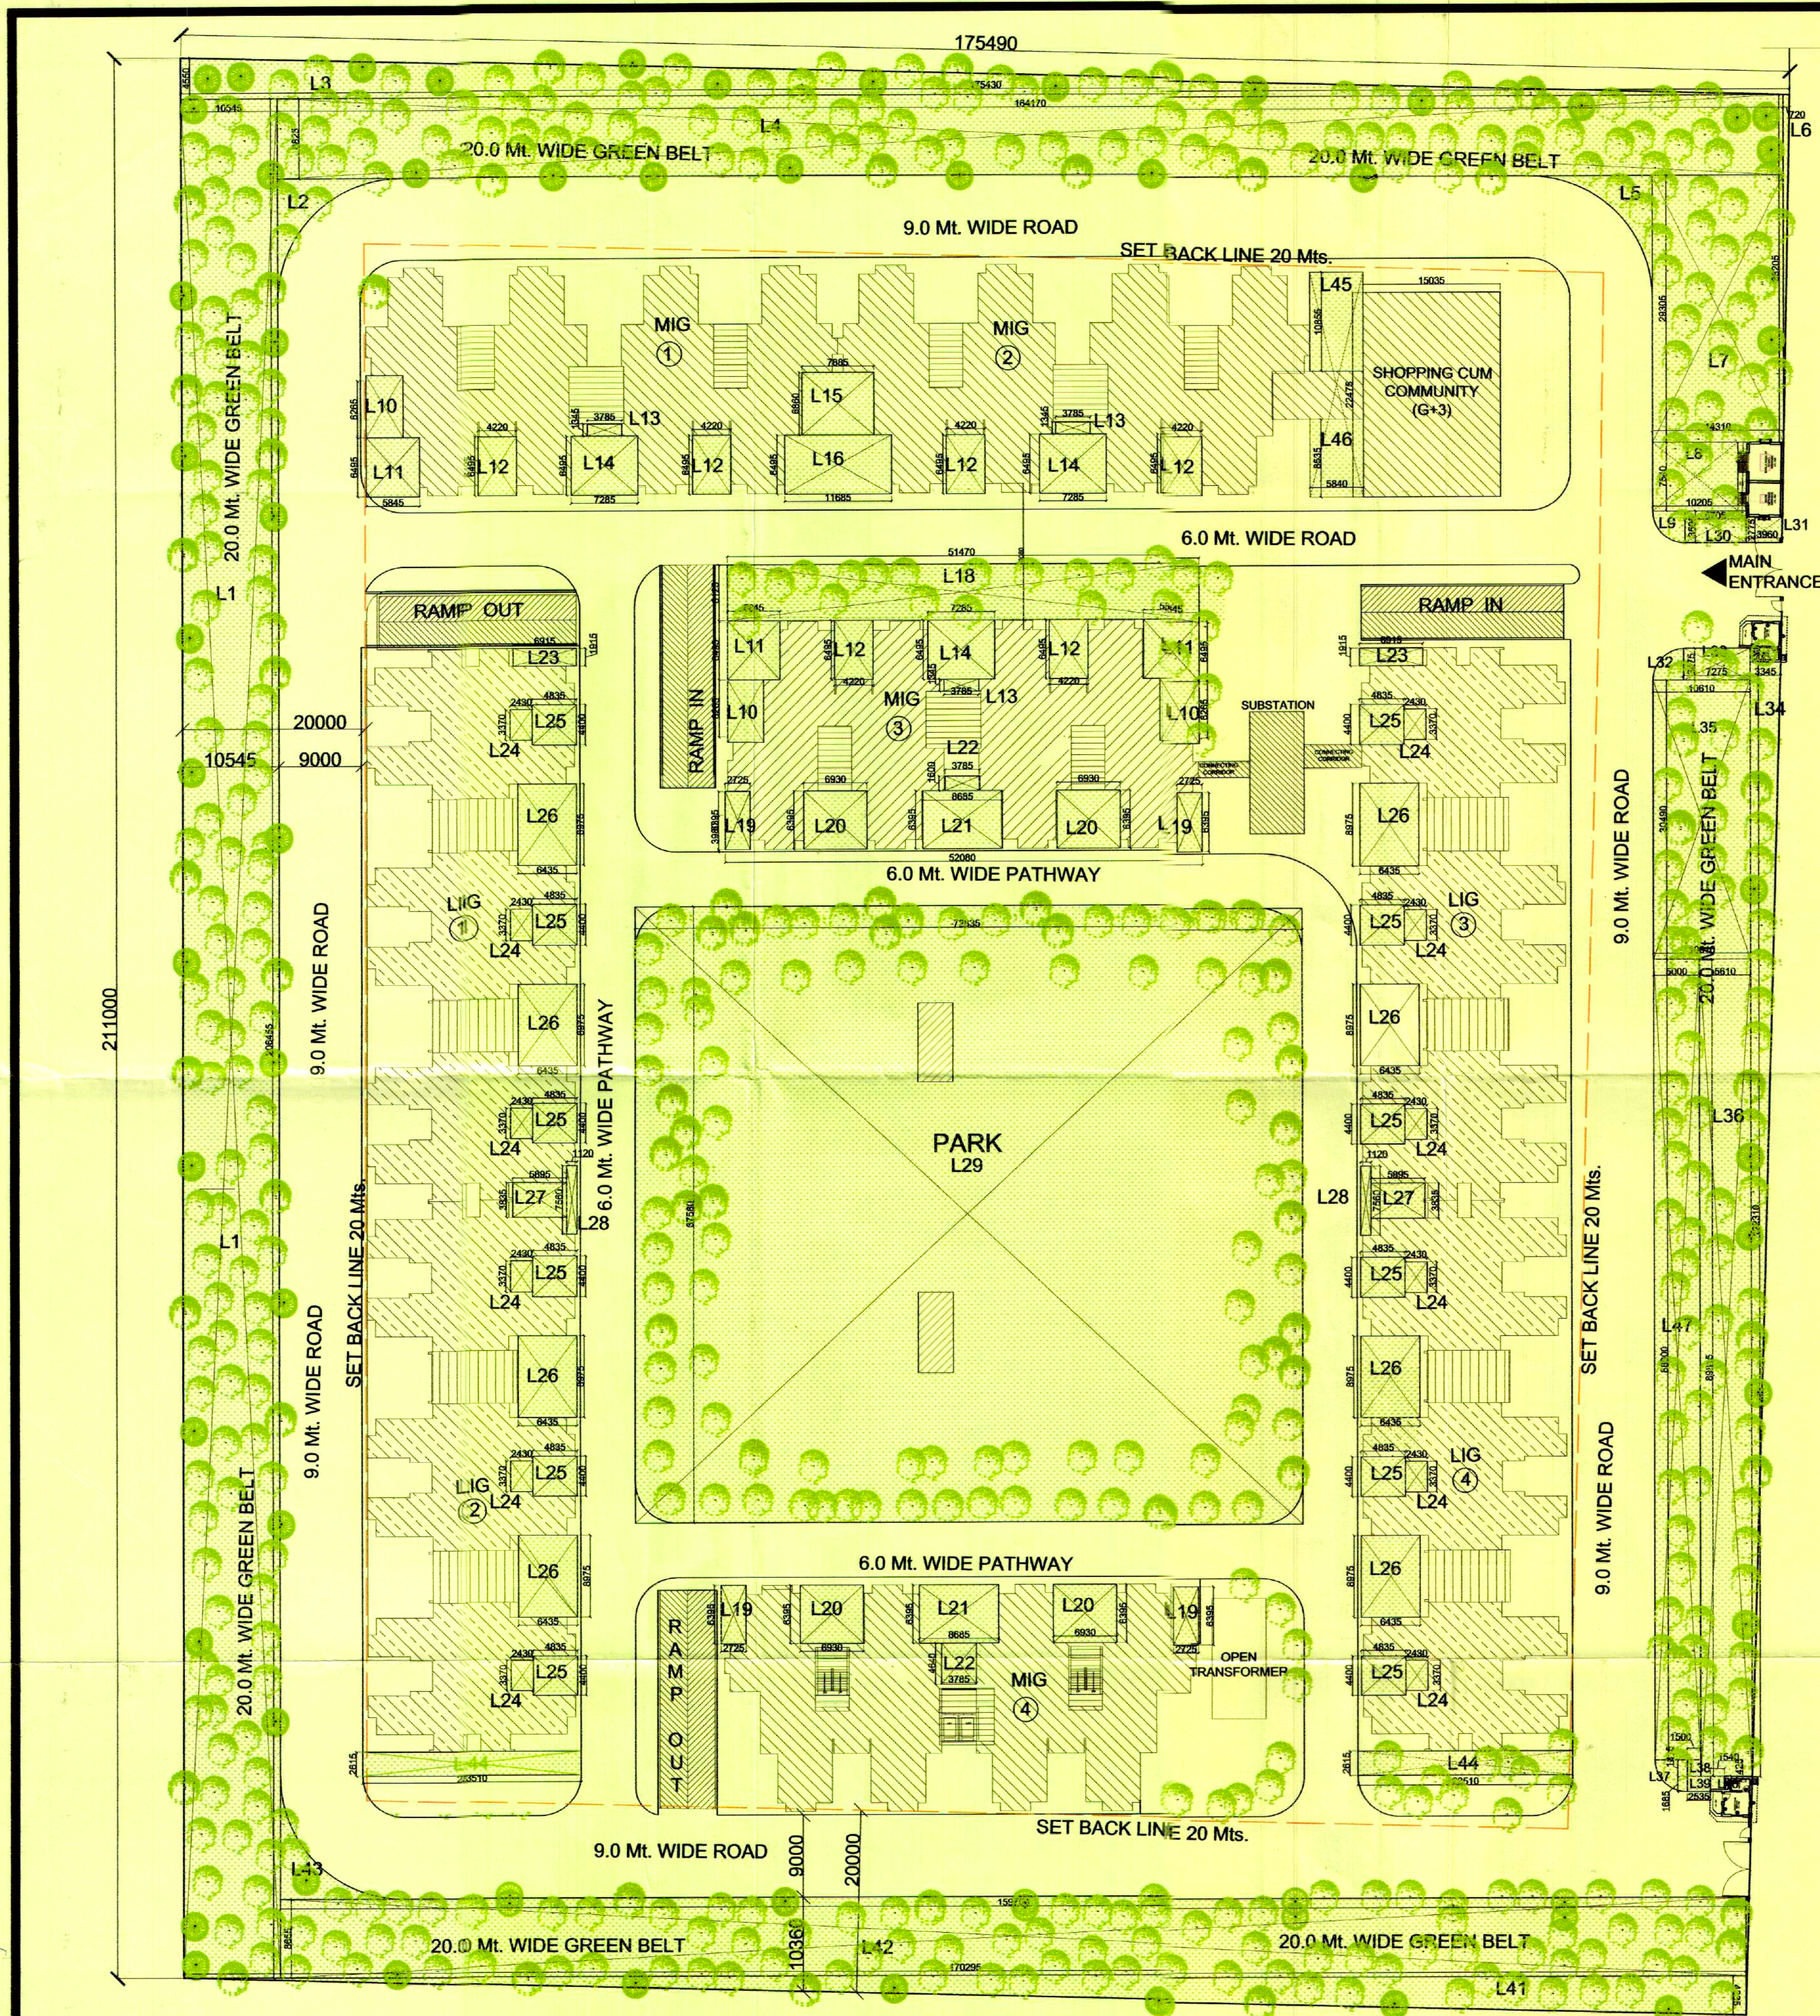

LANDSCAPE AREA STATEMENT						
S.No.	Item	Length	Width	No	Area	Units
TOTAL SITE AREA (A)		175680	211000	1	37068.48	SQM
TOTAL LANDSCAPE AREA						
1	L1	10545	206455	1	2177.07	SqMt.
2	L2	curvilinear		1	39.11	SqMt.
3	L3	175430	4550	0.05	39.91	SqMt.
4	L4	164170	8825	1	1448.80	SqMt.
5	L5	curvilinear		1	39.11	SqMt.
6	L6	720	38205	1	27.51	SqMt.
7	L7	14310	29305	1	419.35	SqMt.
8	L8	10205	7540	1	76.95	SqMt.
9	L9	curvilinear		1	9.62	SqMt.
10	L10	4045	6265	3	76.03	SqMt.
11	L11	6495	5845	3	113.89	SqMt.
12	L12	6495	4220	6	164.45	SqMt.
13	L13	1345	3785	3	15.27	SqMt.
14	L14	6495	7285	3	141.95	SqMt.
15	L15	6860	7885	1	54.09	SqMt.
16	L16	6495	11685	1	75.89	SqMt.
17	L17	33905	8330	1	282.43	SqMt.
18	L18	51470	6125	1	315.25	SqMt.
19	L19	6395	2725	4	69.71	SqMt.
20	L20	6395	6930	4	177.27	SqMt.
21	L21	6395	8685	2	111.08	SqMt.
22	L22	4640	3780	2	35.08	SqMt.
23	L23	1915	6915	2	26.48	SqMt.
24	L24	2430	3370	12	98.27	SqMt.
25	L25	4835	4400	12	255.29	SqMt.
26	L26	8975	6435	8	462.03	SqMt.
27	L27	5895	3835	2	45.21	SqMt.
28	L28	1120	7560	2	16.93	SqMt.
29	L29	72835	67580	1	4922.19	SqMt.
30	L30	6705	3500	1	23.47	SqMt.
31	L31	3960	2775	1	10.99	SqMt.
32	L32	curvilinear		1	9.62	SqMt.
33	L33	7275	3475	1	25.28	SqMt.
34	L34	3345	122310	0.5	204.56	SqMt.
35	L35	10610	30490	1	323.50	SqMt.
36	L36	5610	89815	1	503.86	SqMt.
37	L37	curvilinear		1	9.62	SqMt.
38	L38	1500	1815	1	2.72	SqMt.
39	L39	2535	1685	1	4.27	SqMt.
40	L40	1540	1425	1	2.19	SqMt.
41	L41	170295	4235	0.5	360.60	SqMt.
42	L42	159750	8655	1	1382.64	SqMt.
43	L43	curvilinear		1	39.11	SqMt.
44	L44	23510	2615	2	122.96	SqMt.
45	L45	5840	10855	1	63.39	SqMt.
46	L46	5840	8535	1	49.84	SqMt.
47	L47	5000	88000	1	440.00	SqMt.
TOTAL LANDSCAPE AREA (B)					15314.86	SqMt.
TOTAL LANDSCAPE AREA (C=B% OF A)					41.32	%

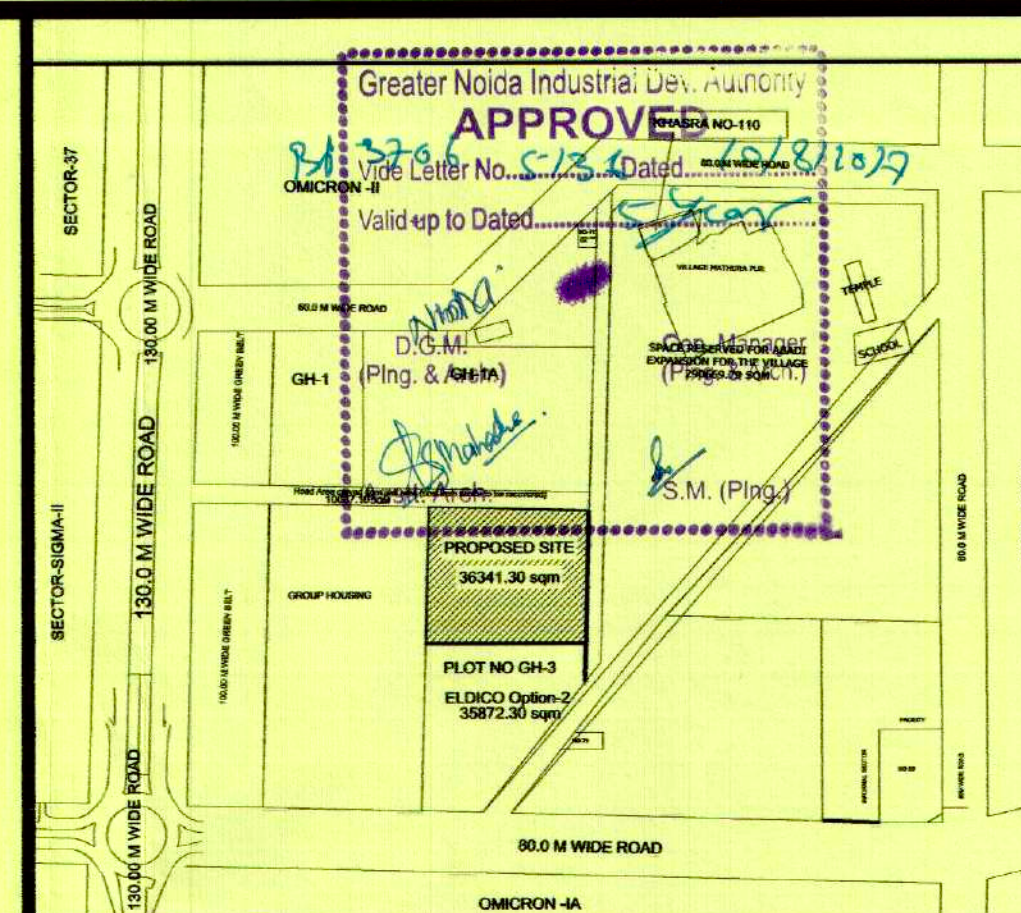

KEY PLAN (NTS)

SUBMISSION DRAWING

PROJECT:

**GROUP HOUSING, PLOT NO GH-03A
OMICRON -1 AT GREATER NOIDA .**

CONSTRUCTION AGENCY :

**GREATER NOIDA INDUSTRIAL DEVELOPMENT
AUTHORITY,
169 CHITVAN ESTATE SECTOR
GAMMA - II GREATER NOIDA, GAUTAM BUDH
NAGAR, UTTAR PRADESH 201308**

DRG. TITLE:

LANDSCAPE PLAN

REVISIONS :

S.N.	REVISION	DATE	DESCRIPTION

DATE:	SCALE :	NORTH :	DRG NO. :
JULY-2017	1:400		AR-02




**CONSULTING ARCHITECTS:
ARCH-EN DESIGN**

Architect **ASHOK KUMMAR**


DELHI OFF.: B-17, HAUZ KHAS, NEW DELHI-16.
011-45188222, Fax:- 011-45188288

LUCKNOW OFF.: 4/5, VISHAL KHAND, GOMTI NAGAR, LUCKNOW
0522-4088222, Fax :- 0522- 4088288

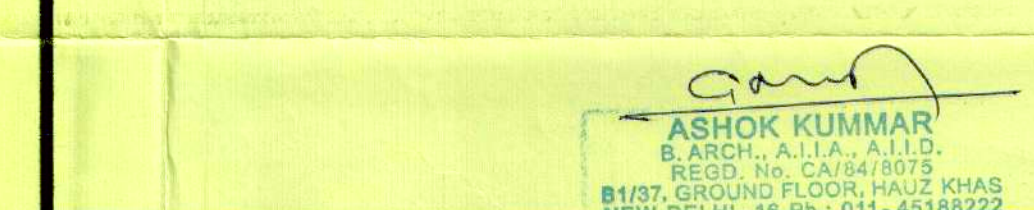

AC.E.O.	CE.O.
SURESH KUMAR SR. DRAFT MAN	W. SUKHBIR SR. EXE.(PLNG.)
NIMISHA SHARMA D.G.M. (PLNG.)	G.M. (PLNG.)

**GREATER NOIDA INDUSTRIAL
DEVELOPMENT AUTHORITY**

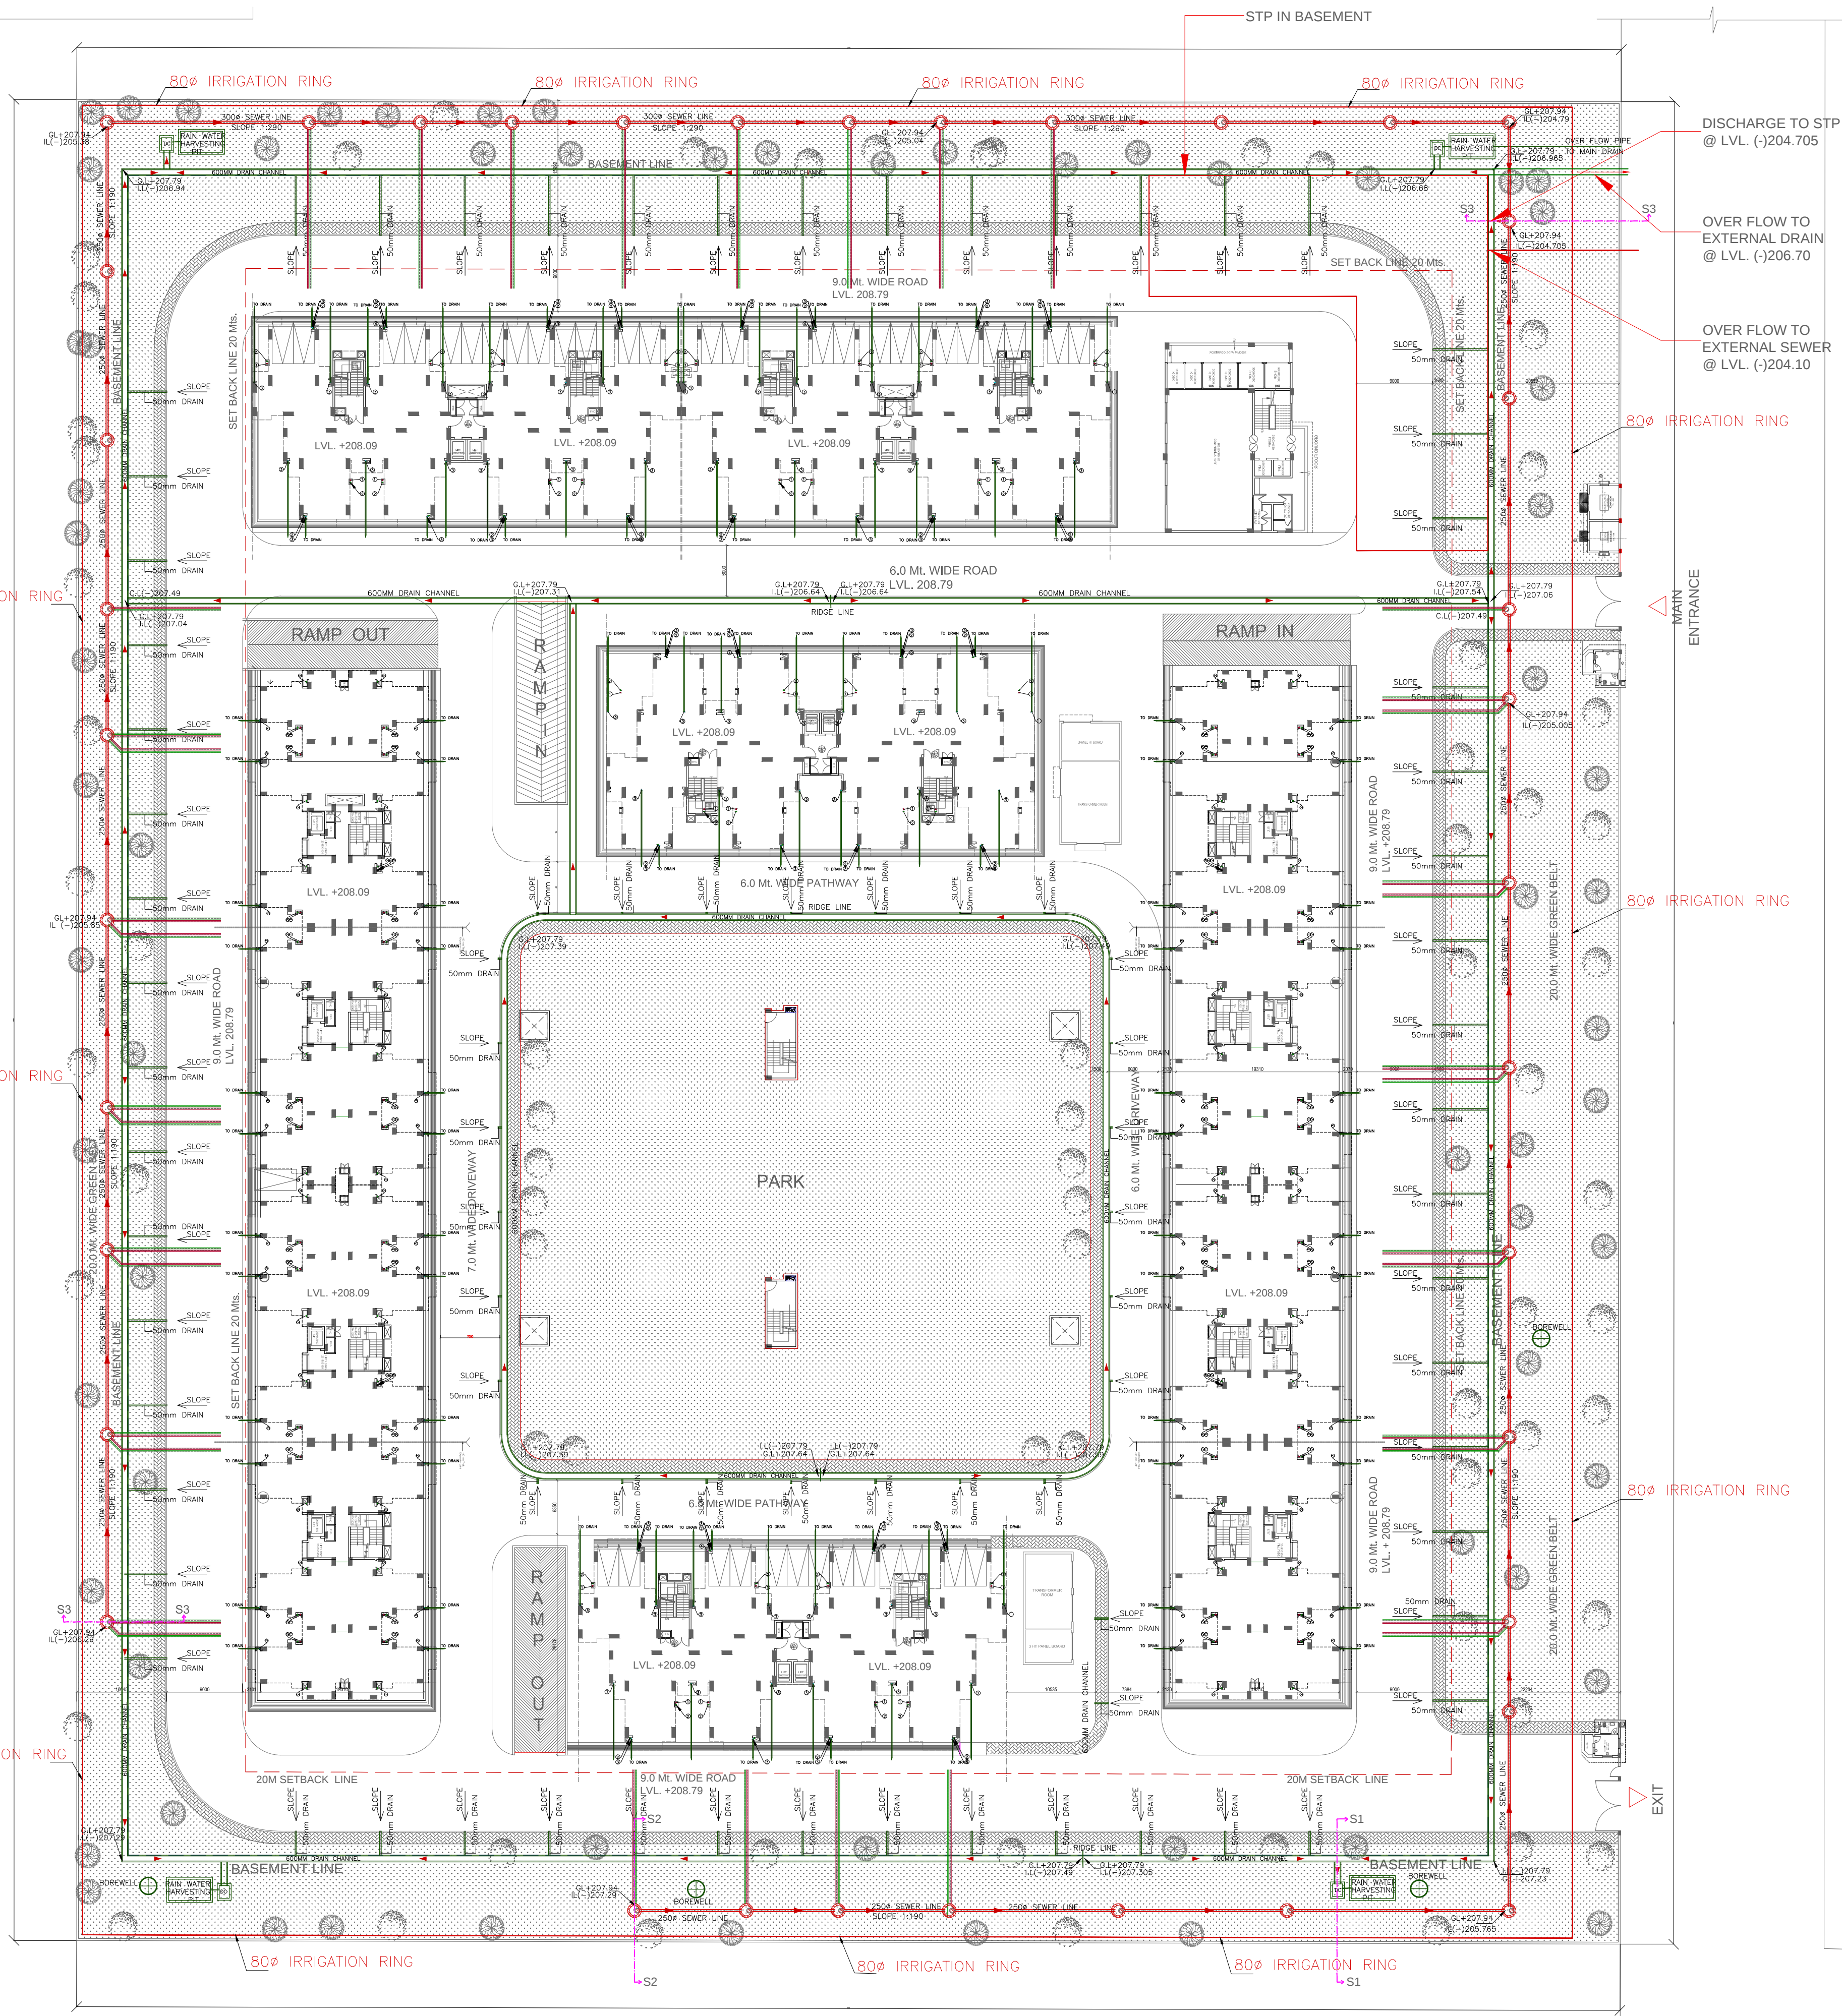

NOTE:-
PLINTH LEVEL = 208.09
INTERNAL ROAD LEVEL = 207.79
OUTER DRAINAGE TOP = 207.45
OUTER DRAIN INVERT LVL. = 206.40
(ALL INVERT LEVEL ARE MENTION WITH RESPECT PLINTH/ROAD LEVEL).
SEWERAGE WATER IS BEING TREATED BY STP & TREATED WATER IS BEING USED AT SITE. OVERFLOW PIPE FROM STP TO EXTERNAL SEWERAGE LINE IS PROVIDED AT ADEQUATE DISCHARGE LEVEL - 204.1 (APPROX)

- Notes:-
1. All dimensions are in millimeters.
 2. All levels are in millimeters.
 3. The drawing shall be read, not scaled either in part or in full.
 4. This drawing is read in conjunction with relevant architectural, structural and all services drawings.
 5. Any discrepancy, if so, shall be immediately brought to the notice of the Consultants before start of construction work.
 6. The drawing shall be used for the purpose issued and shall not be used for any other purpose without the written consent from the Consultants.

SUBMISSION DRAWING

PROJECT:
**GROUP HOUSING, PLOT NO GH-03A
OMICRON -1 AT GREATER NOIDA .**

CONSTRUCTION AGENCY :
**GREATER NOIDA INDUSTRIAL DEVELOPMENT
AUTHORITY,
169 CHITVAN ESTATE SECTOR
GAMMA - II GREATER NOIDA, GAUTAM BUDH
NAGAR, UTTAR PRADESH 201308**

DRG. TITLE:
SITE PLAN-EXTERNAL DEVELOPMENT

REVISIONS:

S.N.	REVISION	DATE	DESCRIPTION

DATE: 13.07.2017	DRG NO.: OM-1A /ARCH/WD/ST-01	
SCALE: 1:300	DRWN BY: FAIZAN CHKD BY: AMIT	
TCD:		SHEET NO.: ST-01

CONSULTING ARCHITECTS:
ARCH-EN DESIGN
Architect ASHOK KUMAR
DELHI OFF: B-65, RAJIV BHAS, NEW DELHI-16
WIL-4148022, Fax: 011-4338286
LUCKNOW OFF: 45/ANSHUL KHAND, GOMTI NAGAR, LUCKNOW
8521-488222, Fax: 0522- 488288


ELECTRICAL CONSULTANTS:
RAD infra
CONSULTING MEP ENGINEERS
Plot No 4, Gali 11, Nand Vihar,
Sector -16 A, Dwarka, NEW DELHI-110078
TELEPHONE:64630016
E-MAIL:radinfra2011@gmail.com

PLUMBING & FIRE FIGHTING CONSULTANTS
SYSTEM CONSULTANCY SERVICES
1 - 4/22, Sector 16, Rohini
Email: writetosc@gmail.com

STRUCTURAL CONSULTANTS
SPAN STRUCTURES
CONSULTING STRUCTURAL ENGINEERS
AN ISO 9001:2008 CERTIFIED COMPANY
ER. OMKAR VERMA
B.Tech (Civil), M.Tech (Str) Hons
8/14, Indira Nagar , Lucknow (UP) .
Tel. - 0522-4049199, + 91- 9335903324

FOR CLIENTS: FOR ARCH-EN DESIGN:


SITE LAYOUT

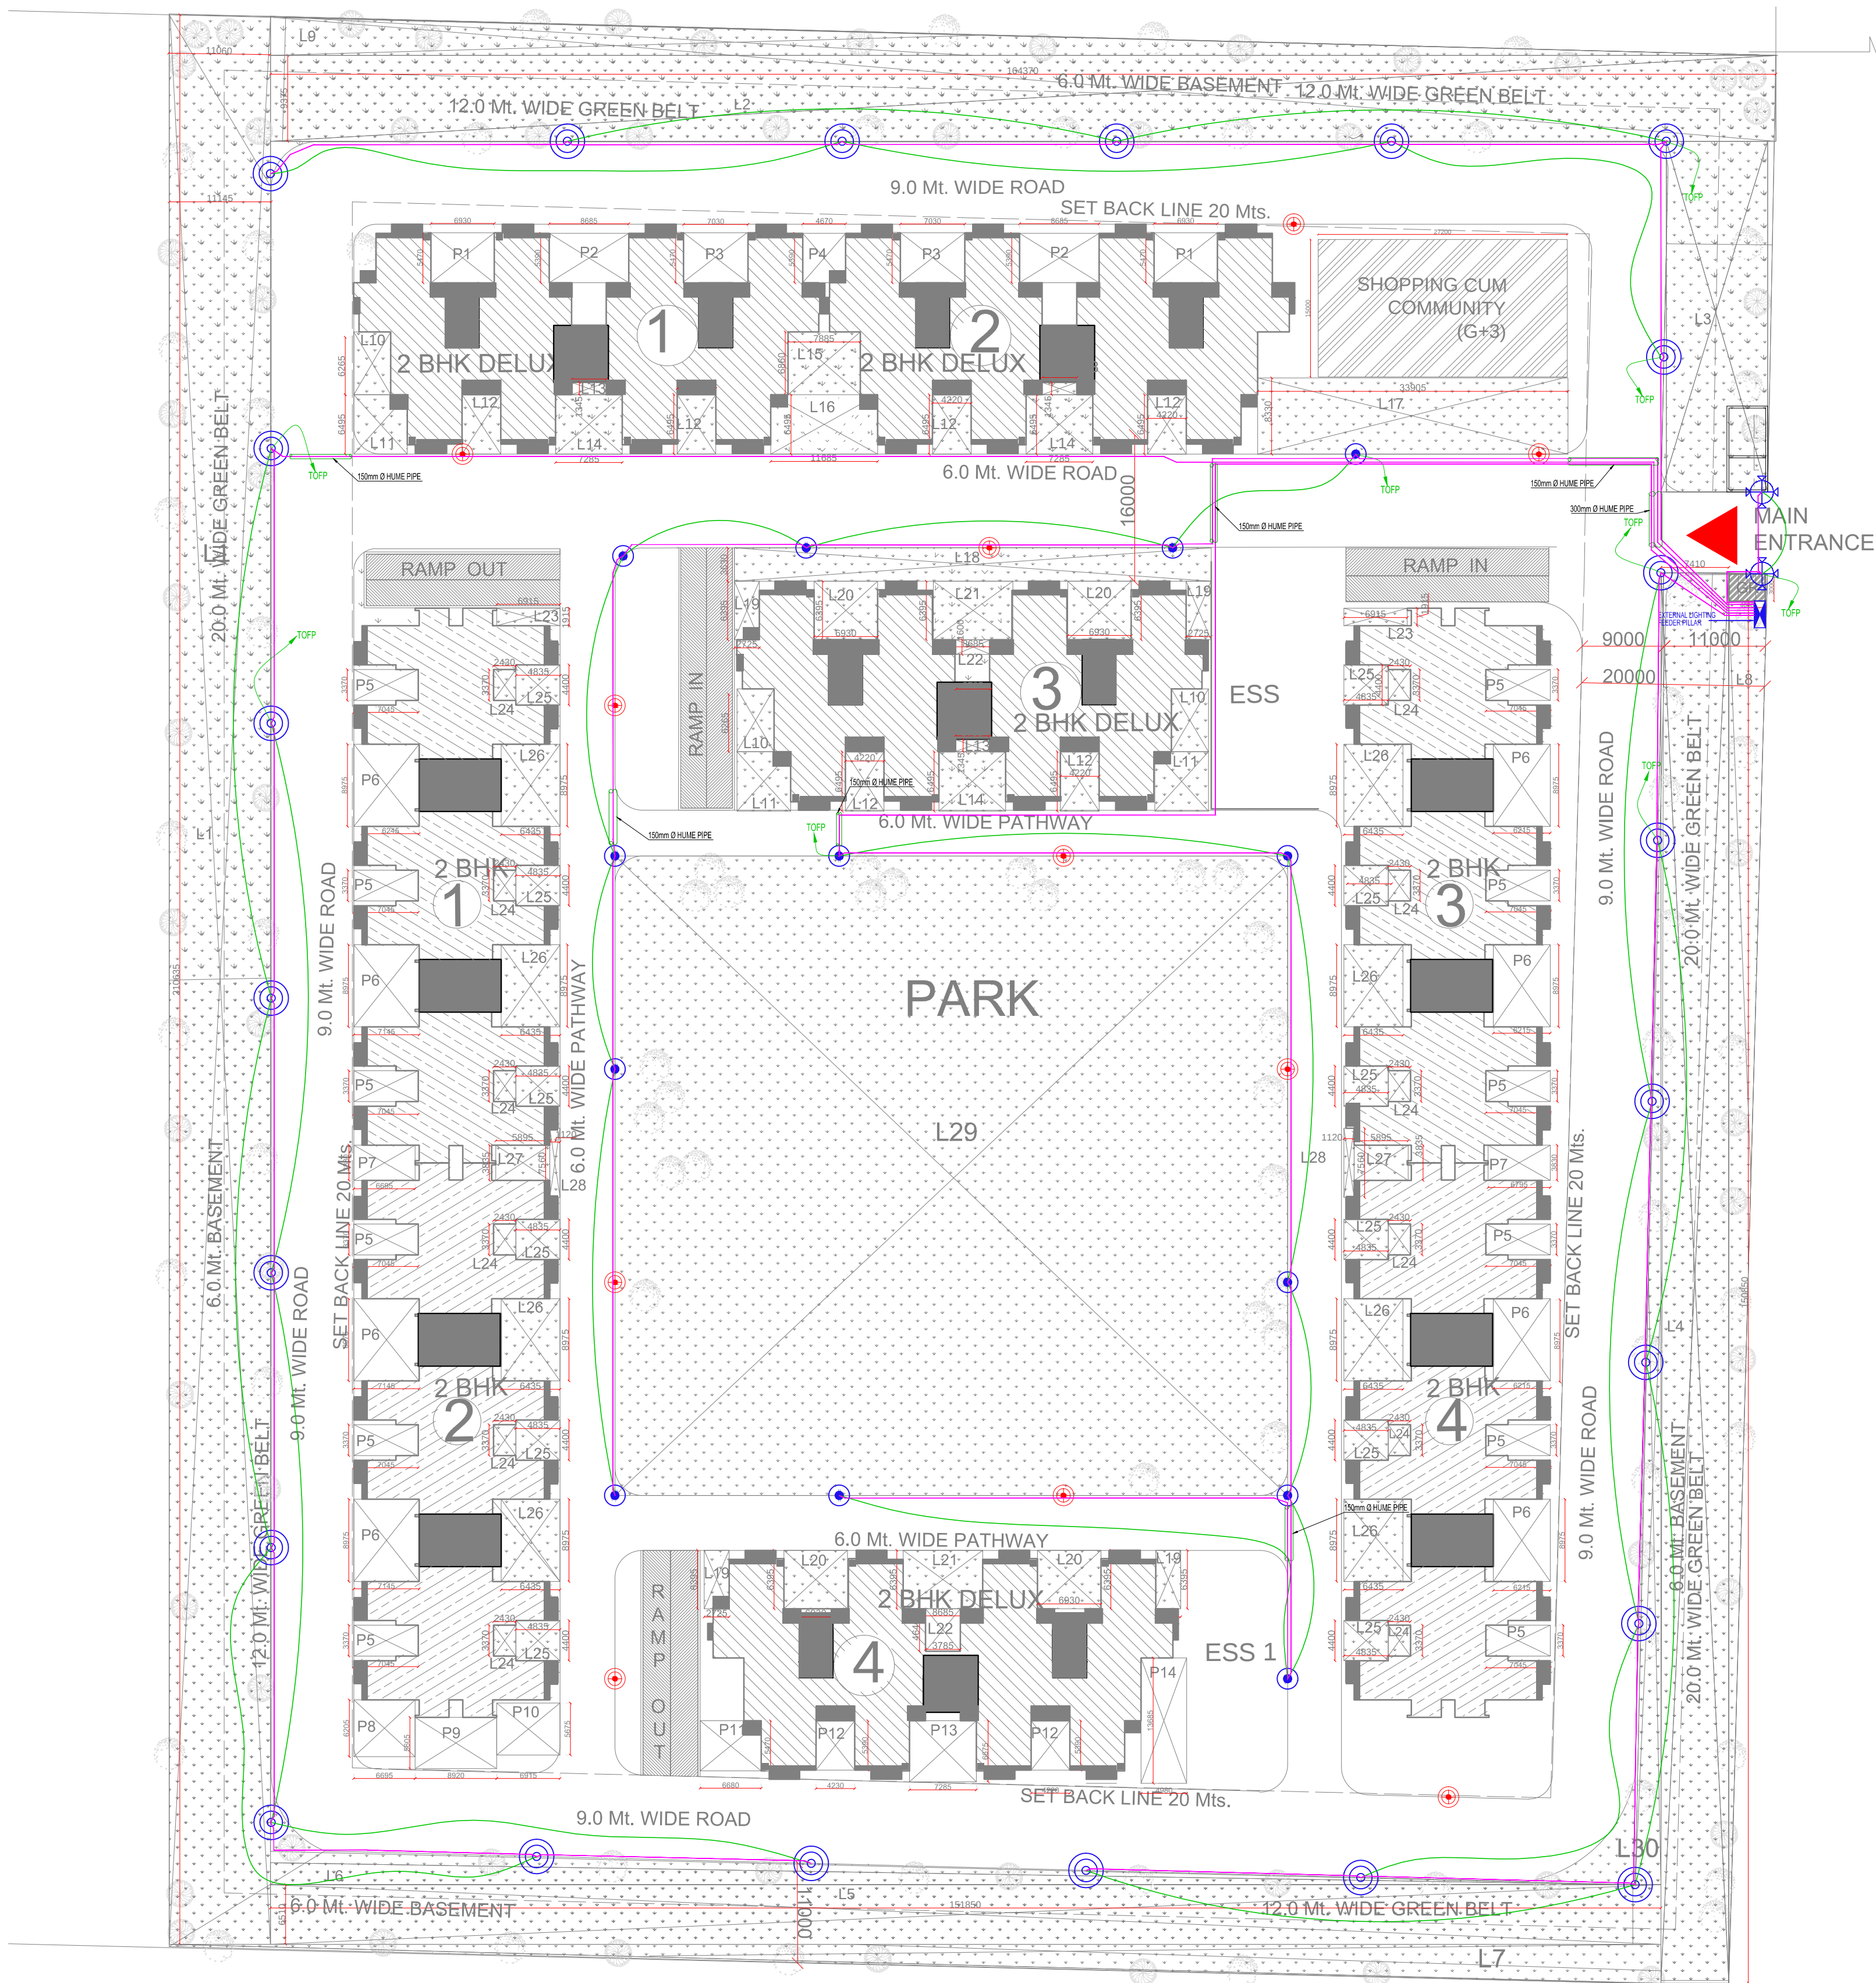

SITE PLAN

ELECTRICAL LEGEND	
1.	6Mr LED LIGHT POLE (ABOVE GROUND LVL.) WITH SOLLAR BECKUP Schneider make Solar Brika-24 LED/BAJAJ
2.	6Mr LED LIGHT POLE (ABOVE GROUND LVL.) Schneider make Brika-19W LED
3.	6Mr LED LIGHT POLE (ABOVE GROUND LVL.) Schneider make Brika-19W LED
4.	POST TOP LANTERN (BAJAJ BJMPPTI 70SV LPF)
5.	FEEDER PILLAR

NOTE:-
1) ALL ITEMS SHALL BE APPROVED BY ELECTRICAL CONSULTANT / ARCHITECT.
2) LUX CALCULATION SHEET SHALL BE PROVIDED BY OEM FOR APPROVAL.
3) EXTERNAL LIGHTING FEEDER PILLAR SHALL BE ADVANCE PANELS & SWITCHGEAR / ABB / SIEMENS / GE MAKE .
PANEL SHALL BE MANUFACTURE AT THEIR RESPECTIVE PLANTS, AUTHORIZED INTEGRATORS SHALL NOT ALLOWED.
4) SHOP DRAWING WITH PROPER DIMENTION SHALL BE PROVIDED BY ELECTRICAL CONTRACTOR FOR APPROVAL.
5) PRIOR INSPECTION OF ELECTRICAL ITEMS SHALL BE DONE AT THEIR MANUFACTURING PLANT BY ELECTRICAL CONSULTANT.

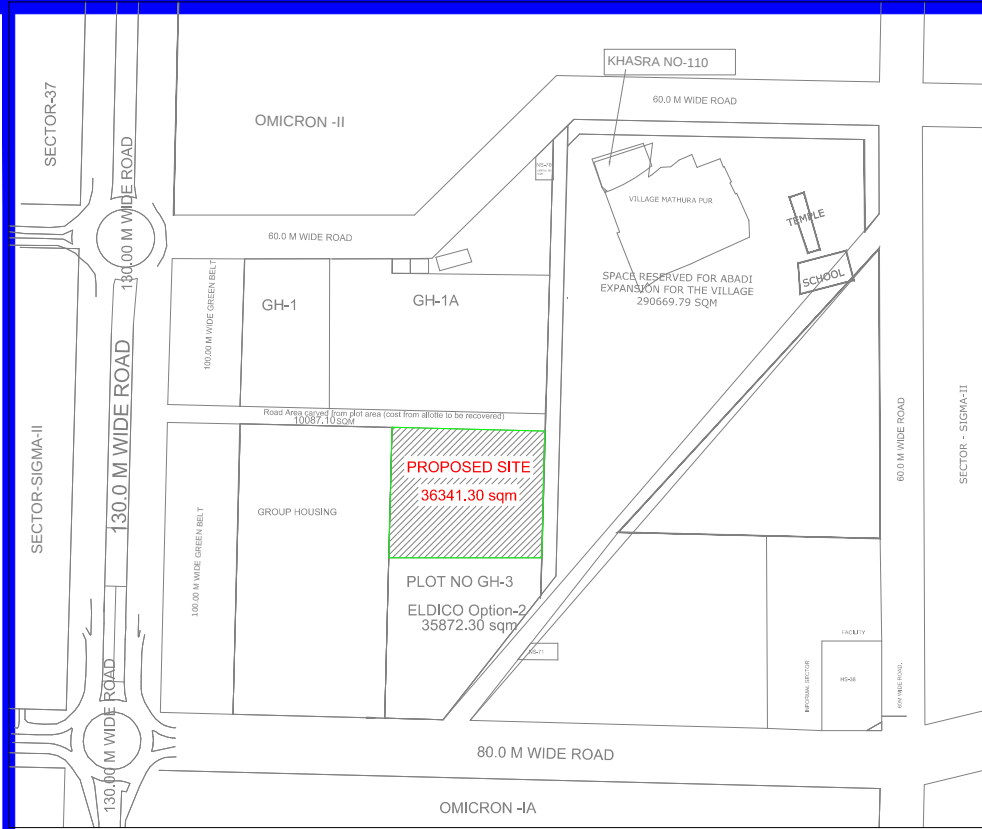

KEY PLAN (NTS)

PROJECT:
GROUP HOUSING FOR 2 BHK & 2 BHK DELUX PLOT NO GH-03A , OMICRON -1 AT GREATER NOIDA .

CONSTRUCTION AGENCY :
GREATER NOIDA INDUSTRIAL DEVELOPMENT AUTHORITY, 169 CHITVAN ESTATE SECTOR GAMMA - II GREATER NOIDA, GAUTAM BUDH NAGAR, UTTAR PRADESH 201308

REVISIONS :			
S.NO	REVISION	DATE	DESCRIPTION
1	R1	27.07.16	LIGHTING LOCATION REVISED

DRG. TITLE:
EXTERNAL LIGHTING LAYOUT SITE PLAN

DRAWN BY: **SANJAY** CHECKED BY: **PRASHANT SHARMA**

DATE: 10-07-2016 SCALE : 1:400 DRG NO. : EL-OLIG3A-101A(EX.)



CONSULTING ARCHITECTS:
ARCH-EN DESIGN
Architect: **ASHOK KUMAR**

DELHI OFF.: B-3/5, HAUZ KHAS, NEW DELHI-16.
011-45188222, Fax:- 011- 45188288

LUCKNOW OFF.: 4/5,VISHAL KHAND,GOMTI NAGAR, LUCKNOW
0522-4088222, Fax :- 0522- 4088288

HARISH VERMA A.C.E.O.	RAMA RAMAN C.E.O
ASHWANI KUMAR MANAGER (PLNG.)	MANISH LAL SR.EXE.(PLNG.)
NIMISHA SHARMA S.M. (PLNG./ARCH.)	LEENU SAHGAL G.M. (PLNG./ARCH.)

 **GREATER NOIDA INDUSTRIAL DEVELOPMENT AUTHORITY**