

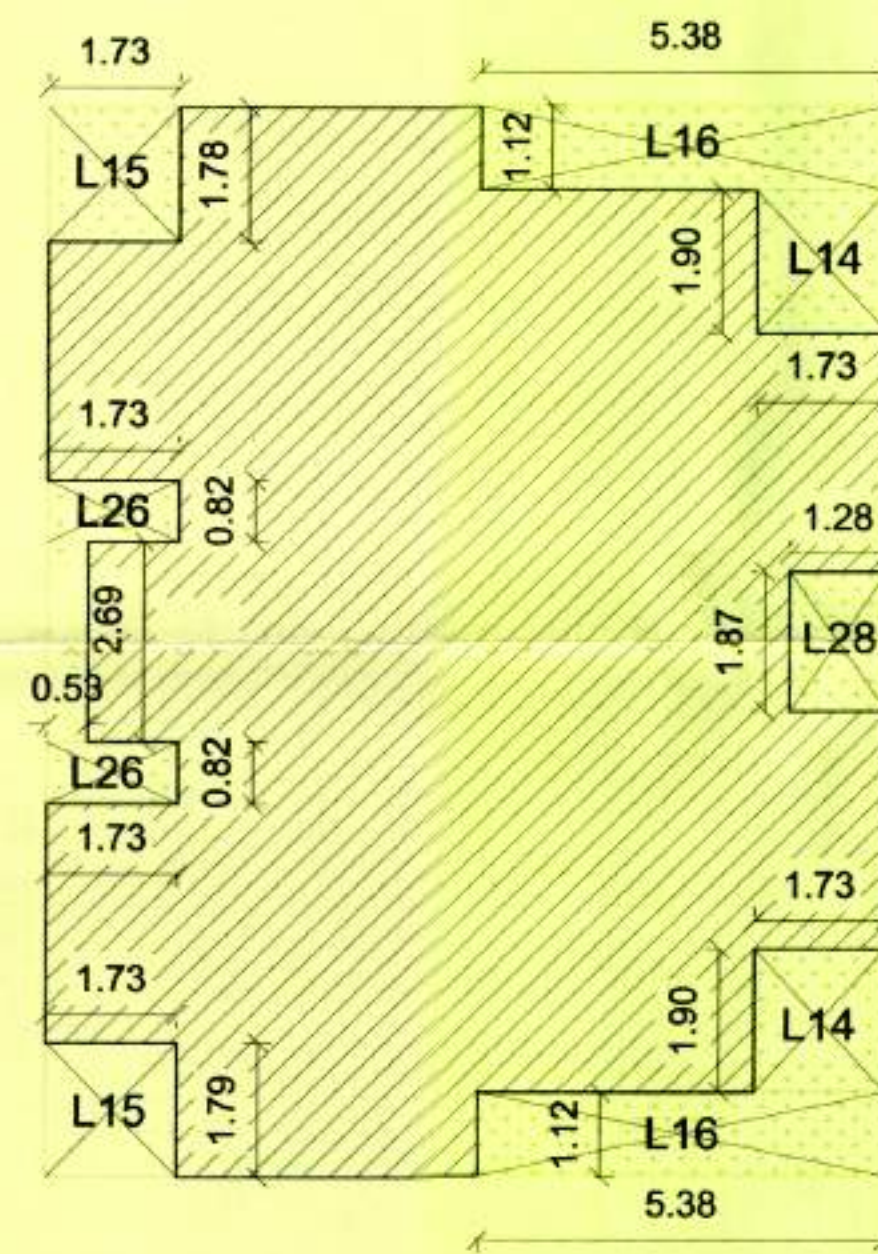


24 M WIDE ROAD

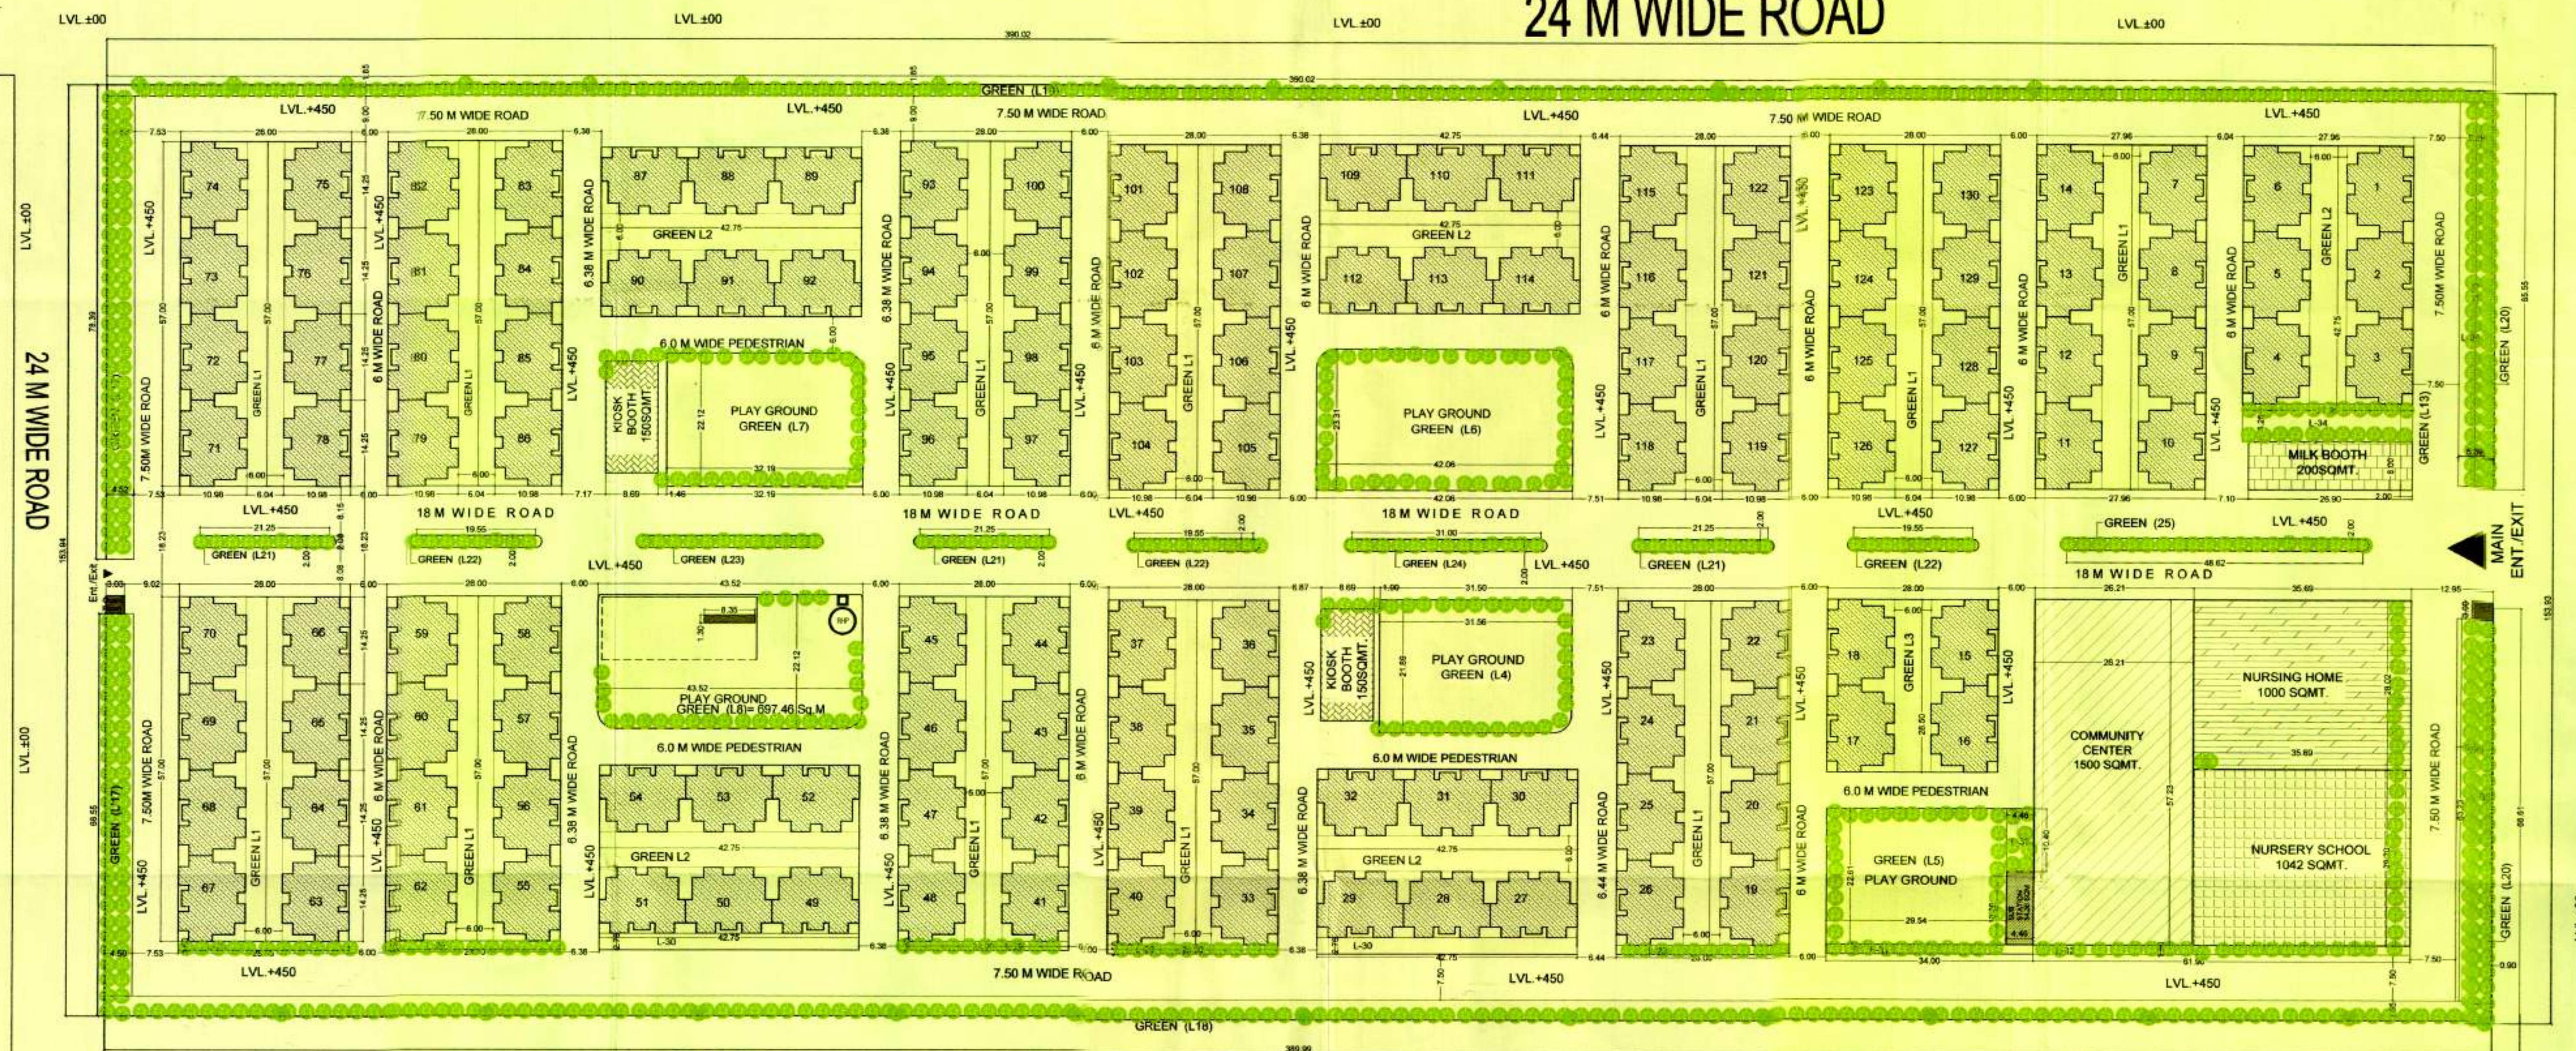

TYPICAL AREA DETAIL OF
 LANDSCAPE AREA L14, L15,
 L16, L26, L27 & L28

S.No.	Item	Length	Width	No	NO'S OF BLOCK	Area	UNIT
1	L1	57	6	12		4104.00	SqM.
2	L2	42.75	6	5		1282.50	SqM.
3	L3	6	28.5	1		171.00	SqM.
4	L4	31.56	21.89	1		690.85	SqM.
5	L5	29.54	22.61	1		667.90	SqM.
6	L6	23.31	42.06	1		980.42	SqM.
7	L7	32.19	22.12	1		712.04	SqM.
8	L8					947.69	SqM.
9	L9	4.5	28.04	2		252.36	SqM.
10	L10	26.2	11.5	1		301.30	SqM.
11	L11	31.2	4.5	1		140.40	SqM.
12	L12	29.19	4.5	1		131.36	SqM.
13	L13	2	14.75	1		29.50	SqM.
14	L14	1.73	1.9	2	130	854.62	SqM.
15	L15	1.73	1.79	2	130	805.14	SqM.
16	L16	5.38	1.12	2	130	1566.06	SqM.
17	L17	4.5	78.39	1		352.76	SqM.
18	L17	4.5	66.55	1		299.48	SqM.
19	L18	389.99	3.65	1		1423.46	SqM.
20	L19	386.06	1.85	1		714.21	SqM.
21	L20	63.23	0.9	2		113.81	SqM.
22	L21	21.25	2	3		127.50	SqM.
23	L22	19.55	2	3		117.30	SqM.
24	L23	28.69	2	1		57.38	SqM.
25	L24	31	2	1		62.00	SqM.
26	L25	48.62	2	1		97.24	SqM.
27	L26	1.73	0.82	2	130	368.84	SqM.
28	L27	2.69	0.53	1		1.43	SqM.
29	L28	1.28	1.87	1	130	311.17	SqM.
30	L29	28	1.5	5		1050.00	SqM.
31	L30	42.75	2.76	1		117.99	SqM.
32	L31	34	1.5	1		51.00	SqM.
33	L32	61.9	1.5	1		92.85	SqM.
34	L33	4.46	10.36	1		46.21	SqM.
35	L34	27.96	6.25	1		174.75	SqM.
36	L35	5.44	64.73	1		352.13	SqM.
37	L36	5.39	65.55	1		353.31	SqM.
TOTAL LANDSCAPE AREA						19922.54	SqM.

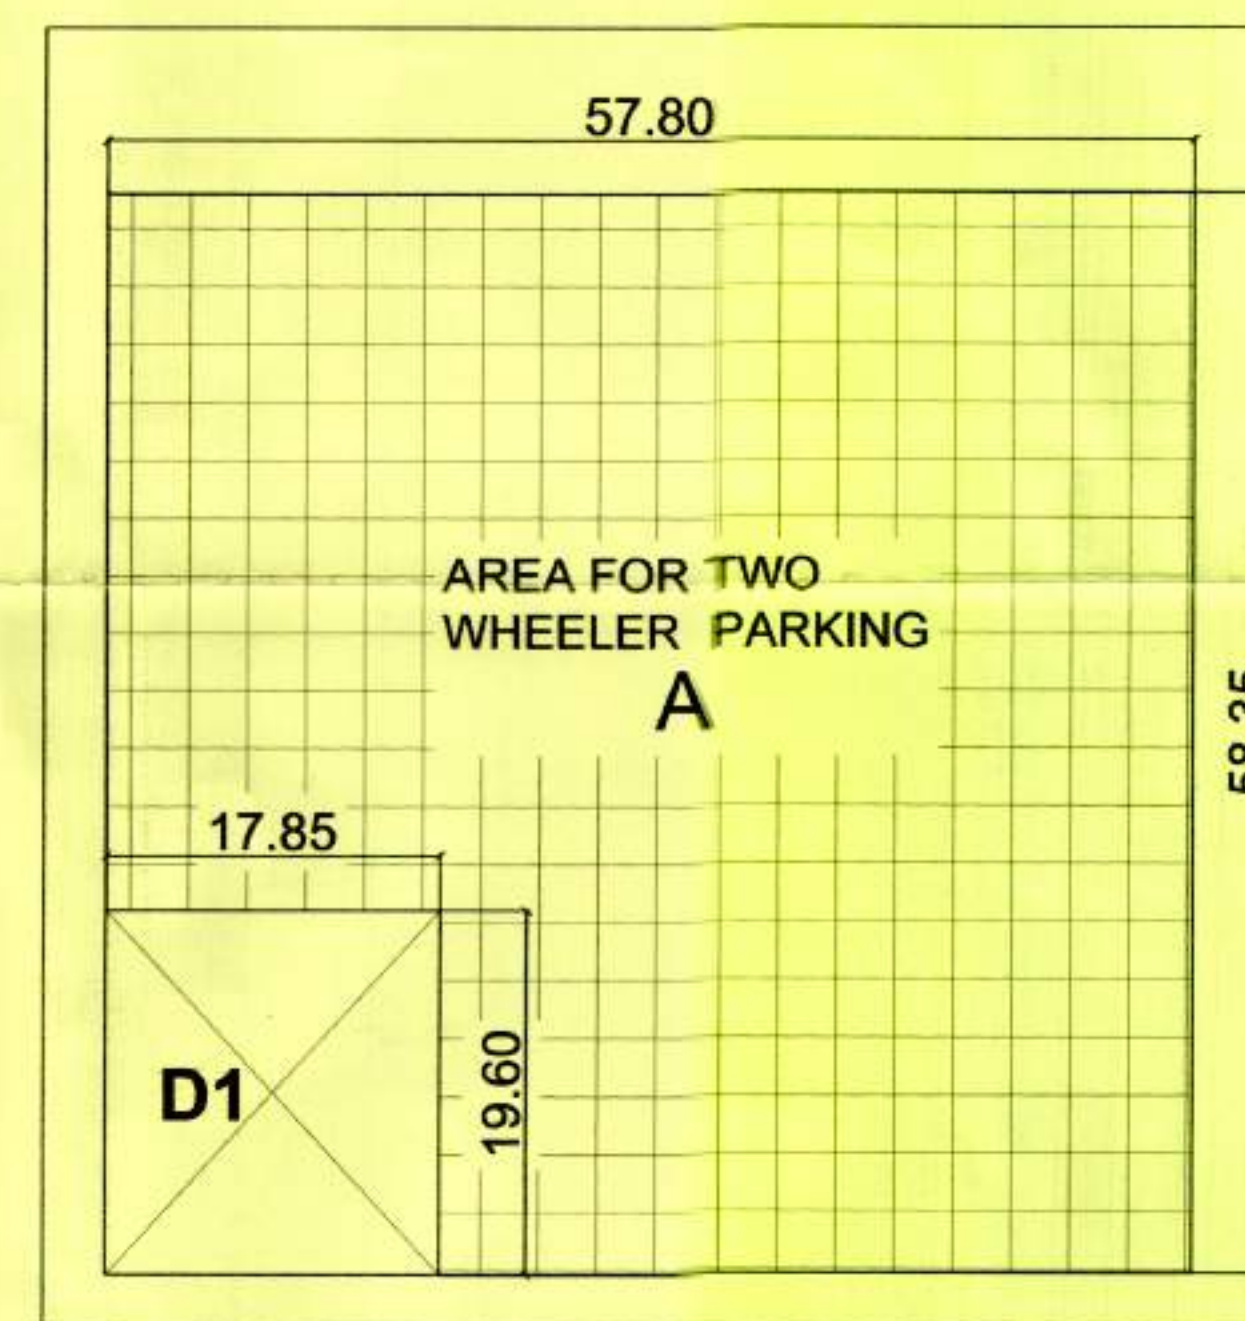

S.No.	Item	Length	Width	No	Area	Unit
A		5780	5835	1	33.73	SQM
DEDUCTION						
1	D1	1785	1960	1	3.50	SQM
TOTAL DEDUCTION					3.50	SQM
TOTAL CLUSTER AREA					30.23	SQM
TOTAL AREA					130.00	
TOTAL NO'S OF UNITS					3929.90	SQM
TOTAL PARKING AREA					131.00	ECS
ECS IN STILL (30/SQMT.)					131.00	ECS

NO OF ECS REQUIRED AS RECOMMENDED BY GNDA	129 NOS.		
Site Parking Area/Block	30.23	SQ. M	Refer Parking Calculation Drawing
Site Parking Area/Block (No of Block-130)	3929.90		
Total Proposed Parking/ECS (Considering 30sq.m/ECS)	131.00		
SAY	131 ECS		

SUBMISSION DRAWING

S.No.	SYMBOL	DESCRIPTION
01		BOUNDARY WALL
02		SETBACK LINE
03		RESIDENTIAL UNITS - TYPE-A (CENTRAL BLOCKS)
04		RESIDENTIAL UNITS - TYPE-B (CORNER BLOCKS)
05		LANDSCAPE (L)

S.No.	REVISION	DATE
1		
2		
3		

PROJECT:
 PROPOSED GROUP HOUSING SCHEME UNDER INFORMAL CATEGORY IN SECTOR - 10 & 12, GREATER NOIDA.

JOB TITLE:
 INFORMAL HOUSING

DRG. TITLE:
 SITE LAYOUT PLAN - GREEN & PARKING AREA CALCULATIONS
 SCALE: 1:500
 DATE: 26-04-2017
 DRG. NO.: SP-02

CONSULTING ARCHITECTS:
ARCH-EN DESIGN
 Architect: ASHOK KUMMAR
 DELHI OFF: 3/6, KATSE KULAS, NEW DELHI-16
 REGD. NO. CA/14/1075
 LUCKNOW OFF: KUNDA KUNDA, KUNDA KUNDA, LUCKNOW
 REGD. NO. CA/14/1075
 ASHOK KUMMAR
 B. ARCH, ALL INDIA
 REGD. NO. CA/14/1075
 B/107, GROUND FLOOR, HALI KHAS
 NEW DELHI-16 PIN: 111-42188222

24 M WIDE ROAD

GOOD FOR CONSTRUCTION

REVISIONS :

S.N.	REVISION	DATE	DESCRIPTION
1	R-1	09-MAY-2014	REVISED LAYOUT PLAN AS/MEETING
2	R-2	03-JULY-2014	INTERNAL ROAD LVL.+450 FROM MAIN ROAD & PLINTH LVL. OF BLDG. IS +300 FROM INTERNAL ROADS
3	R-3	20-AUG.-2014	REPLACE BUILDING BLOCKS & COMMON FACILITIES.
4	R-4	07-JAN.-2017	EXTERNAL LIGHTING REVISED AS PER LAYOUT.

PROJECT:

PROPOSED GROUP HOUSING
SCHEME UNDER INFORMAL
CATEGORY IN SECTOR - 10 & 12,
GREATER NOIDA.

JOB TITLE:

INFORMAL HOUSING

DRG. TITLE:

EXTERNAL LIGHTING LAYOUT
(SITE PLAN)

N	SCALE	DATE	DRG. NO.-
	DEALT BY: SANJAY	07-01-2017	EL-10&12.-101B(EXT.L)
			CHECKED BY: PRASHANT SHARMA

CONSULTING ARCHITECTS:


AED
ARCH-EN DESIGN

Architect **ASHOK KUMMAR**
DELHI OFF.: B-1/32, HAUZ KHAS, NEW DELHI-16.
011-45188222, Fax:- 011- 45188288
LUCKNOW OFF.: 4/5,VISHAL KHAND,GOMTI NAGAR, LUCKNOW
0522-4088222, Fax :- 0522- 4088288






**GREATER NOIDA INDUSTRIAL
DEVELOPMENT AUTHORITY**

ELECTRICAL LEGEND

S.No.	BOQ S.No.	SYMBOL	DESCRIPTION	QUANTITY
01	40.00-40.03	⊙	36W LED SOLAR LIGHT WITH 7M POLE (SINGLE ARM) BRP 409 LED CW 036 MR 7M SOLAR POLE	06 POLES 06 LUMINAIRES
02	41.00-41.01 & 44.00-44.01	⊙	72W LED LIGHT WITH 7M POLE (SINGLE ARM) BRP 410 LED CW 072 MR +7M POLE (SINGLE ARM)	21 POLES 21 LUMINAIRES
03	42-42.02	⊙	36W LED SOLAR LIGHT WITH 6M POLE (SINGLE ARM) BRP 409 LED CW 036 MR 6M SOLAR POLE	24 POLES 24 LUMINAIRES
04	39.02-39.03 & 43.01-43.02	⊙	36W LED LIGHT WITH 6M POLE (SINGLE ARM) BRP 409 LED CW 036 MR FG S1 PSU GR+6M POLE	66 POLES 66 LUMINAIRES
05	41.00-41.01 & 44.00-44.01	⊙	72W LED LIGHT WITH 7M POLE (DOUBLE ARM) BRP 410 LED CW 072 MR +7M POLE (DOUBLE ARM)	16 POLES 32 LUMINAIRES
06	37.02-37.03	⊙	150W LED POST TOP LIGHT BGP 150 LED PSU 220+4M GI TUBULAR POLE	02 POLES 02 LUMINAIRES
07		—	4c x 16 sq. mm. XLPE AL. AR. Cable	
08		R Y B	PHASE SEQUENCE	
09		⊙	FEEDER PILLAR	06 NOS.

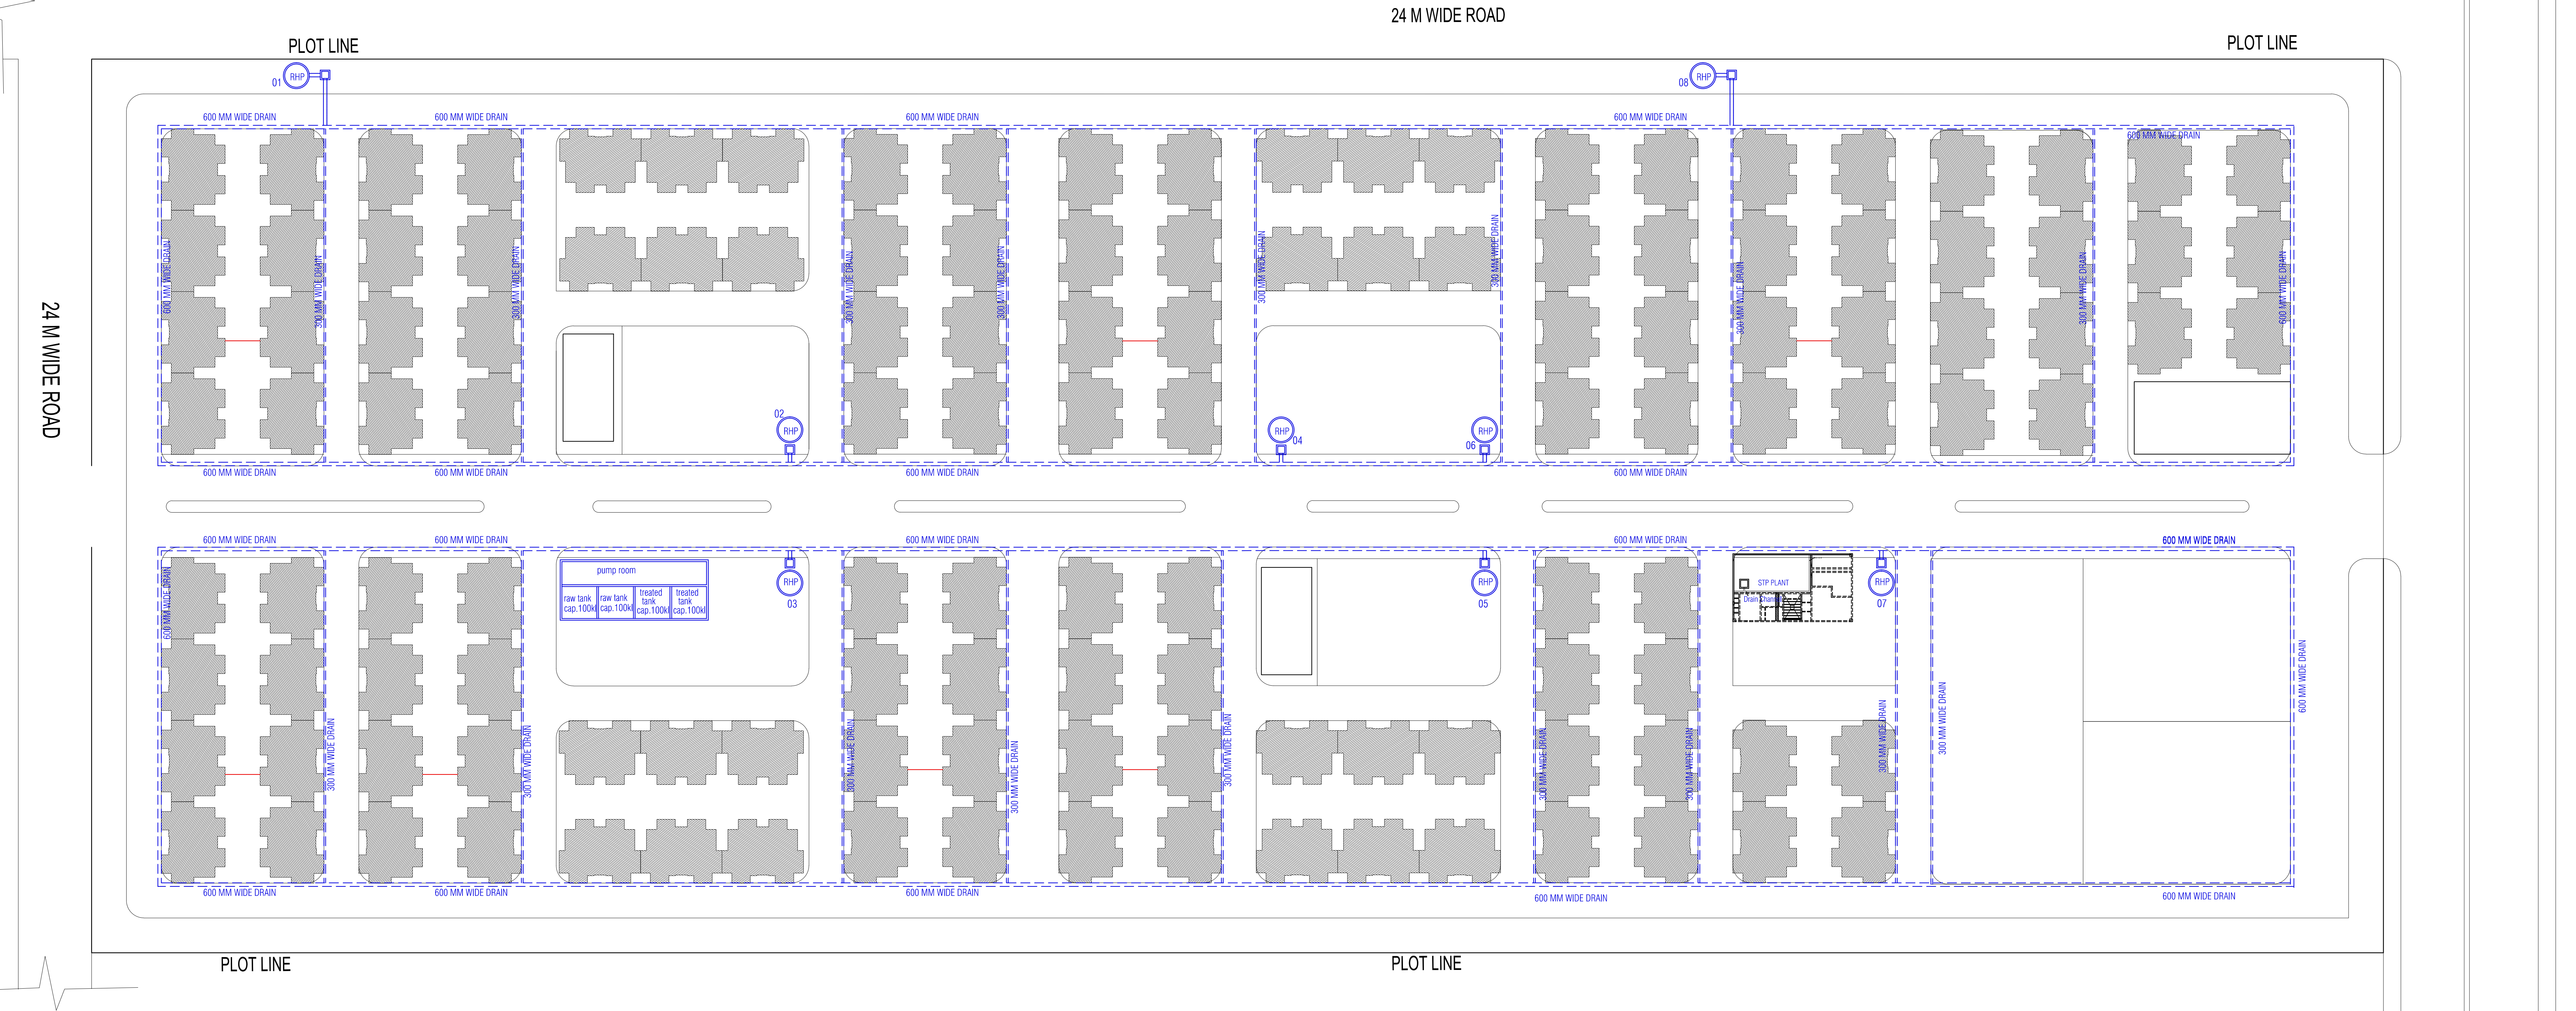

NOTE:-
01- PIGEOMETER TO BE PROVIDED AT SITE AS PER APPROVAL OF ENGINEER IN CHARGE.
02- BLIND PIPE SHOULD BE USED DEPENDING UPON NATURE OF SOIL AS PER INSTRUCTION OF ENGINEER IN CHARGE.

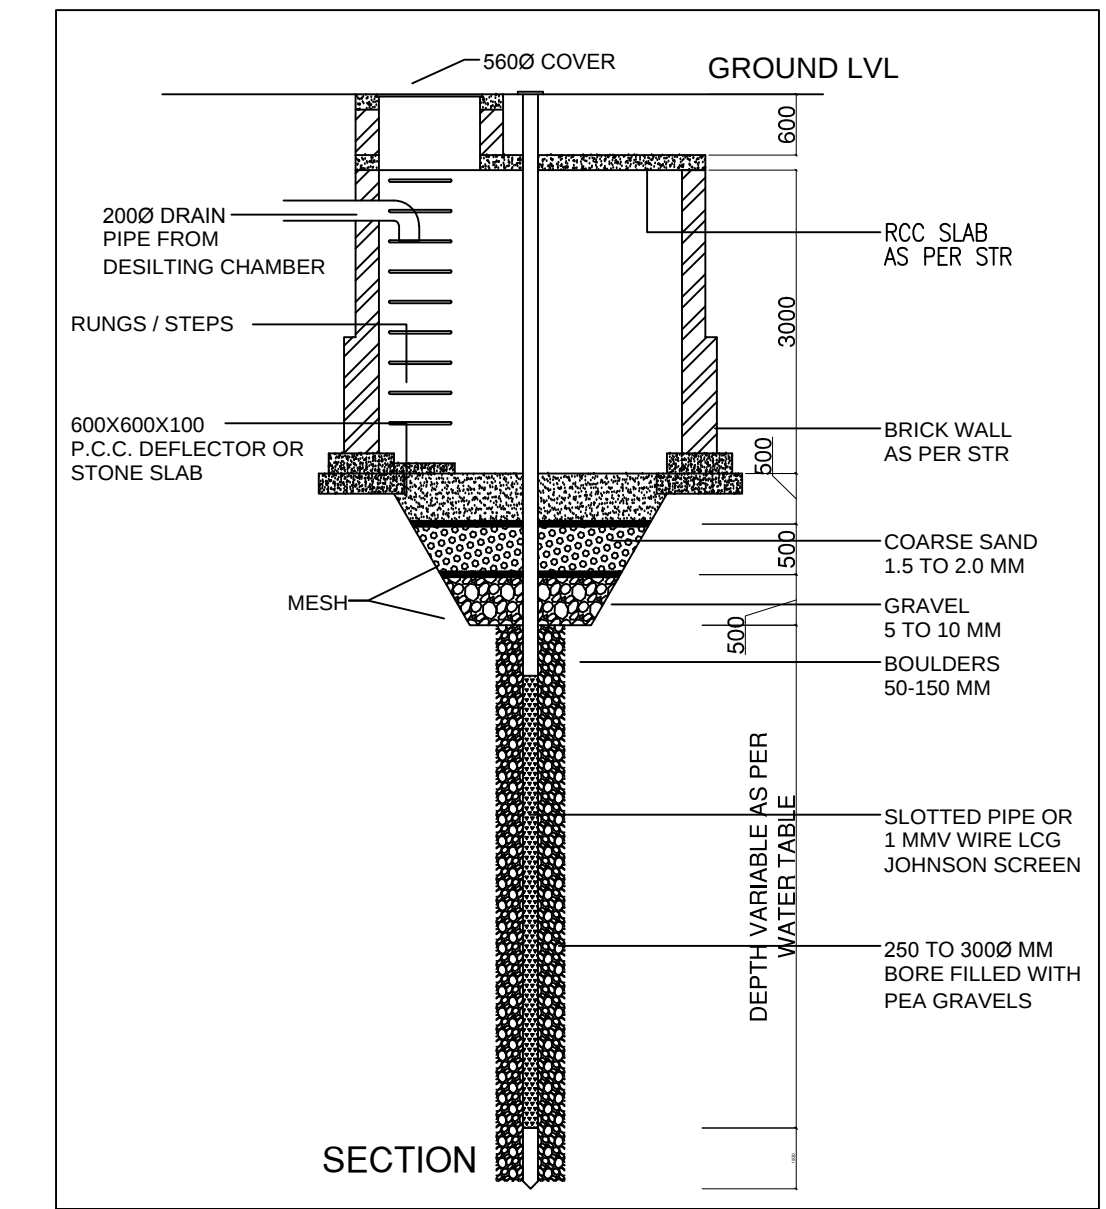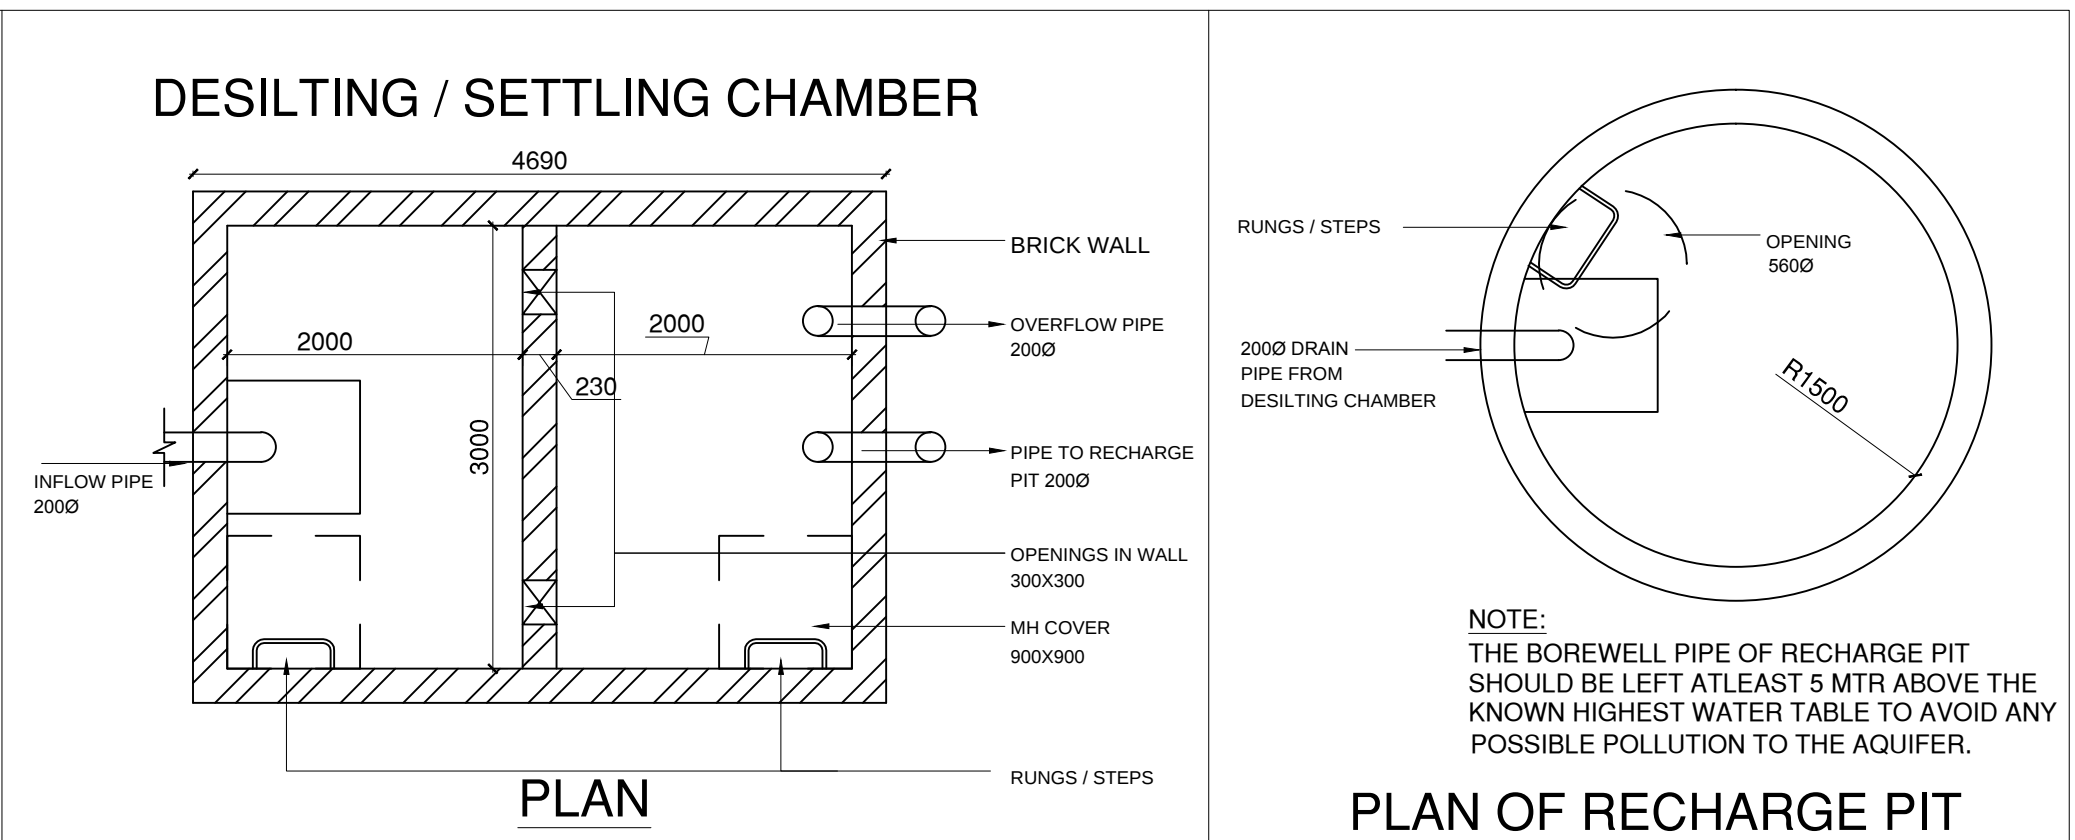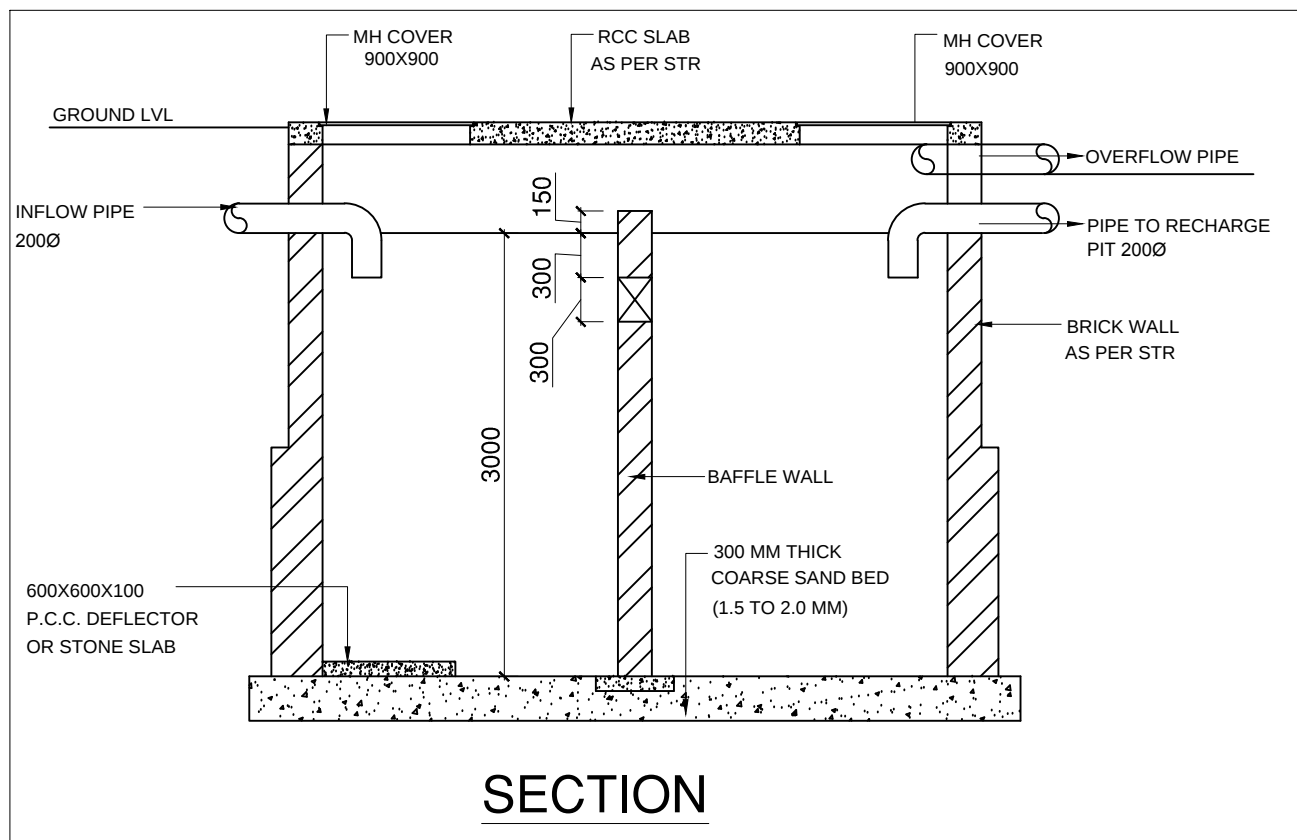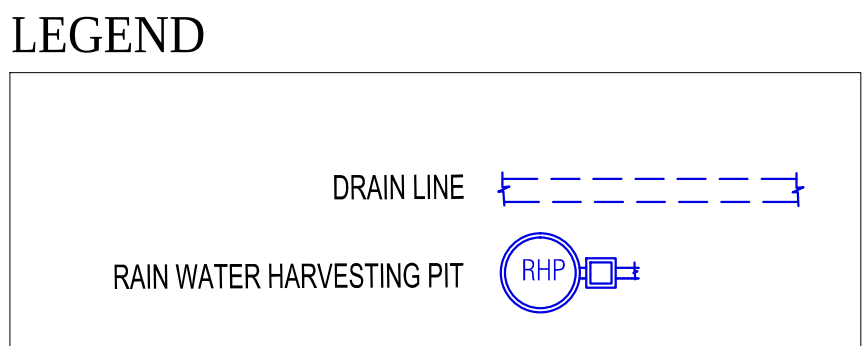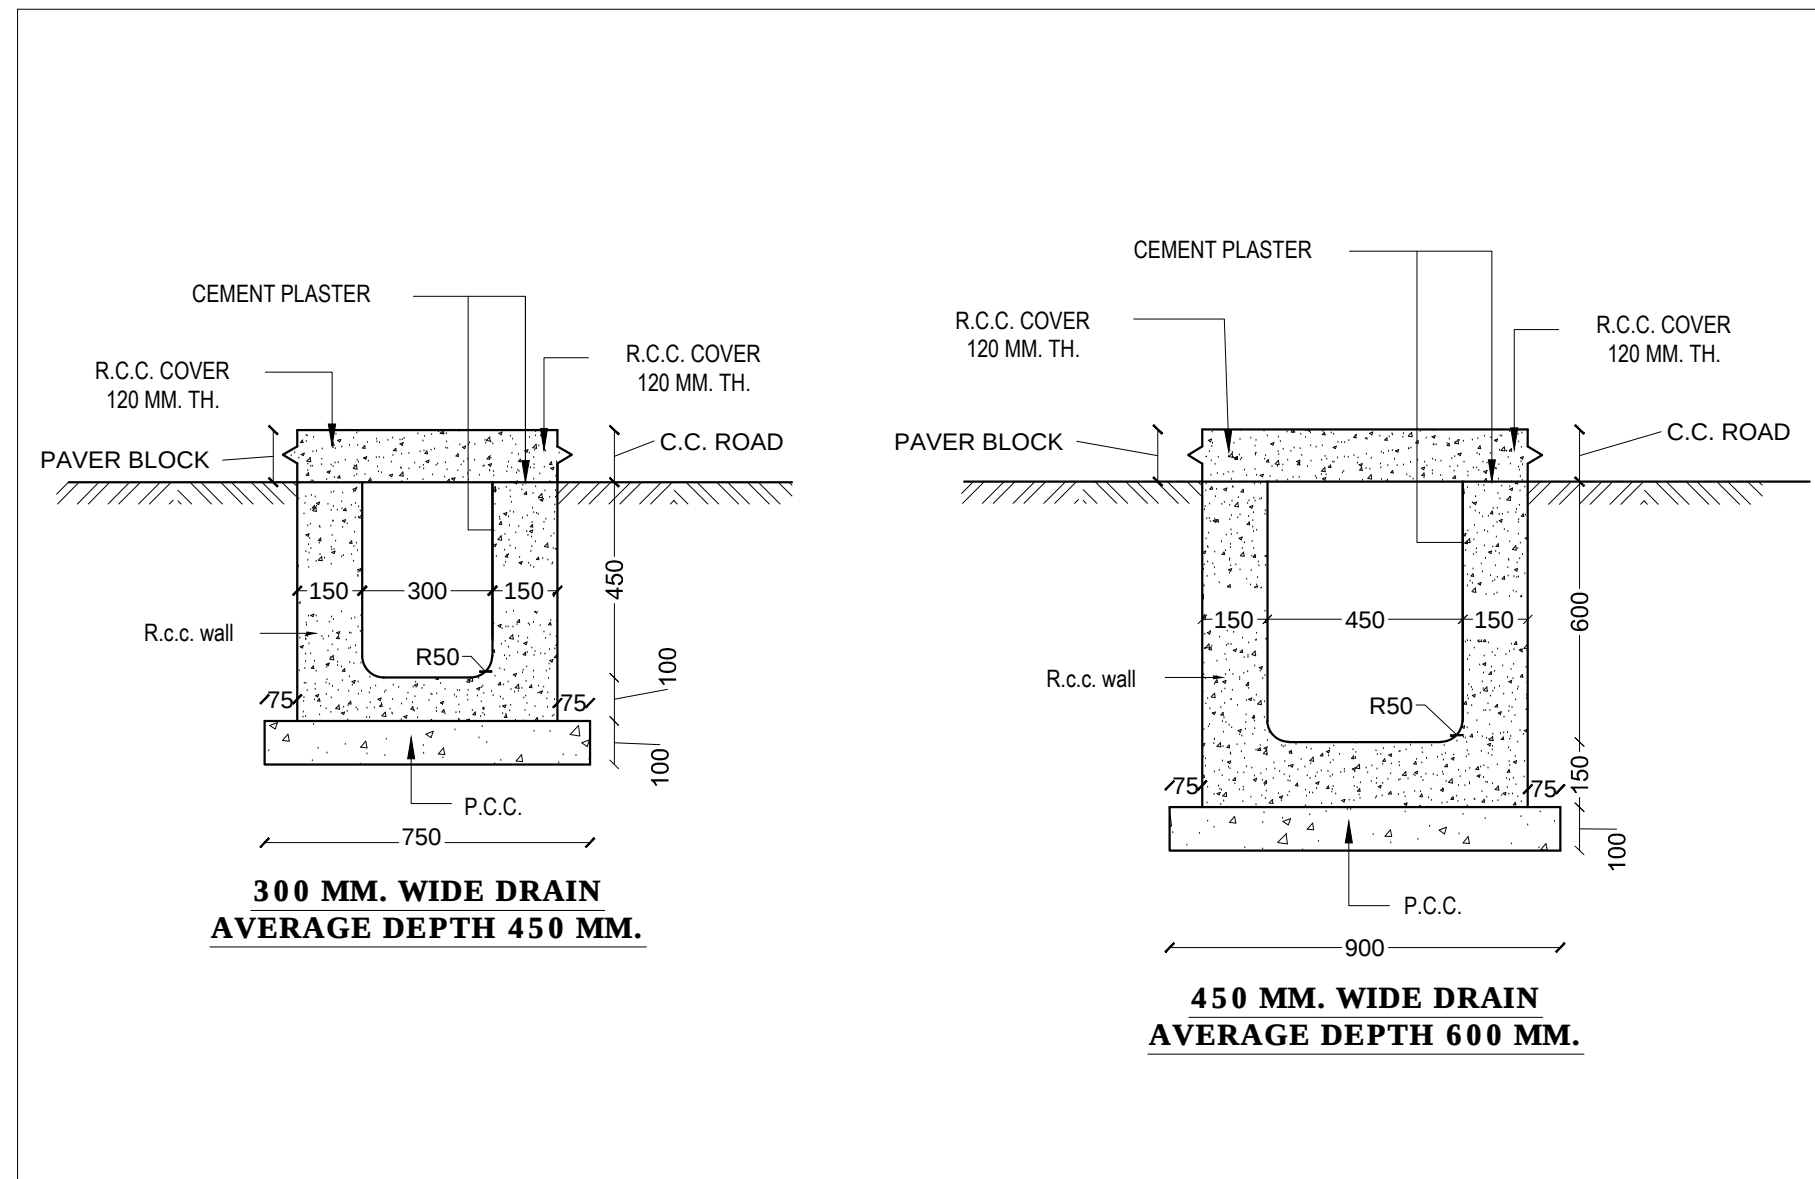

REVISIONS :			
S.N.	REVISION	DATE	
1			
2			
3			

PROJECT:
PROPOSED GROUP HOUSING SCHEME UNDER INFORMAL CATEGORY IN SECTOR - 10 & 12, GREATER NOIDA.

JOB TITLE:
INFORMAL HOUSING

DRG. TITLE:
SITE LAYOUT PLAN - DRAINAGE & RWH LAYOUT PLAN







SCALE	DATE	DRG. NO.
NTS	26-04-2017	PL-02

CONSULTING ARCHITECTS:
ARCH-EN DESIGN
Architect **ASHOK KUMMAR**
DELHI OFF: B-51, BALIYABAS, NEW DELHI-110
011-45188222, Fax: 011-45188288
LUCKNOW OFF: 45 VIKRAM BHANDARWADI NAGAR, LUCKNOW
0522-4888222, Fax: 0522-4888288

APPROVED BY	DESIGNED BY	CHECKED BY	DATE	SCALE

24 M WIDE ROAD

24 M WIDE ROAD

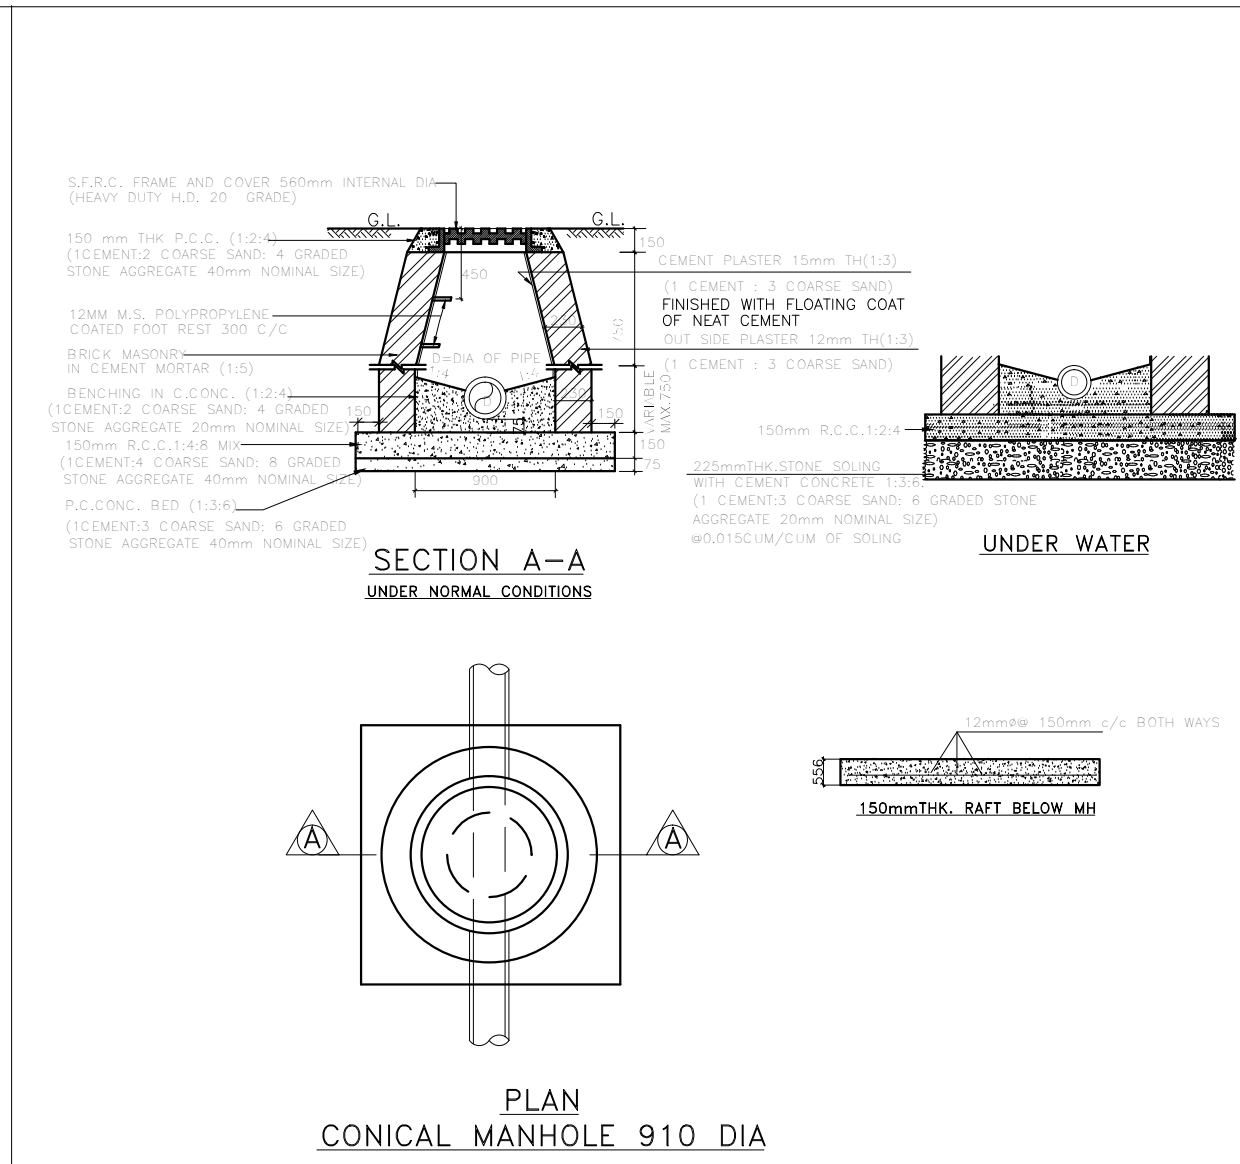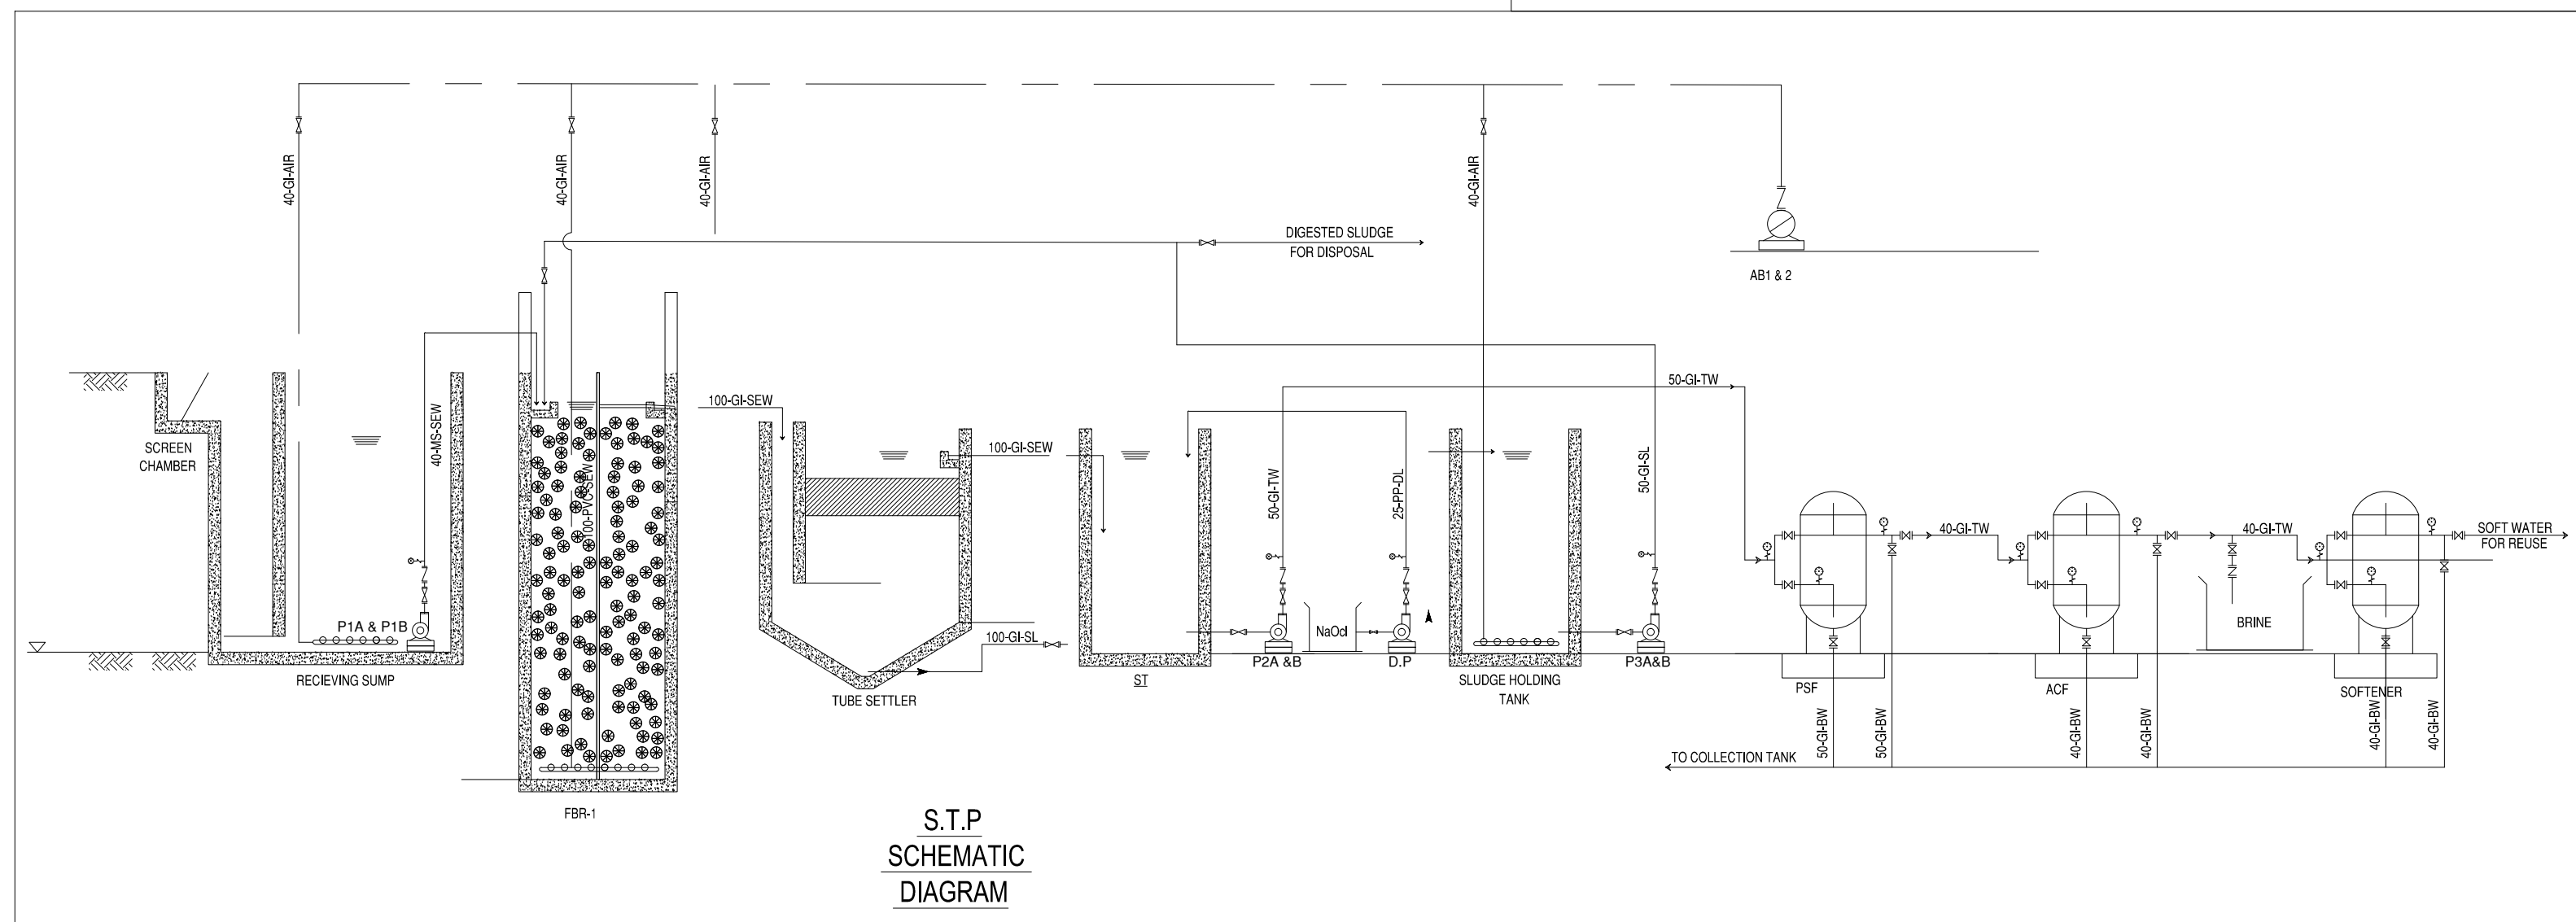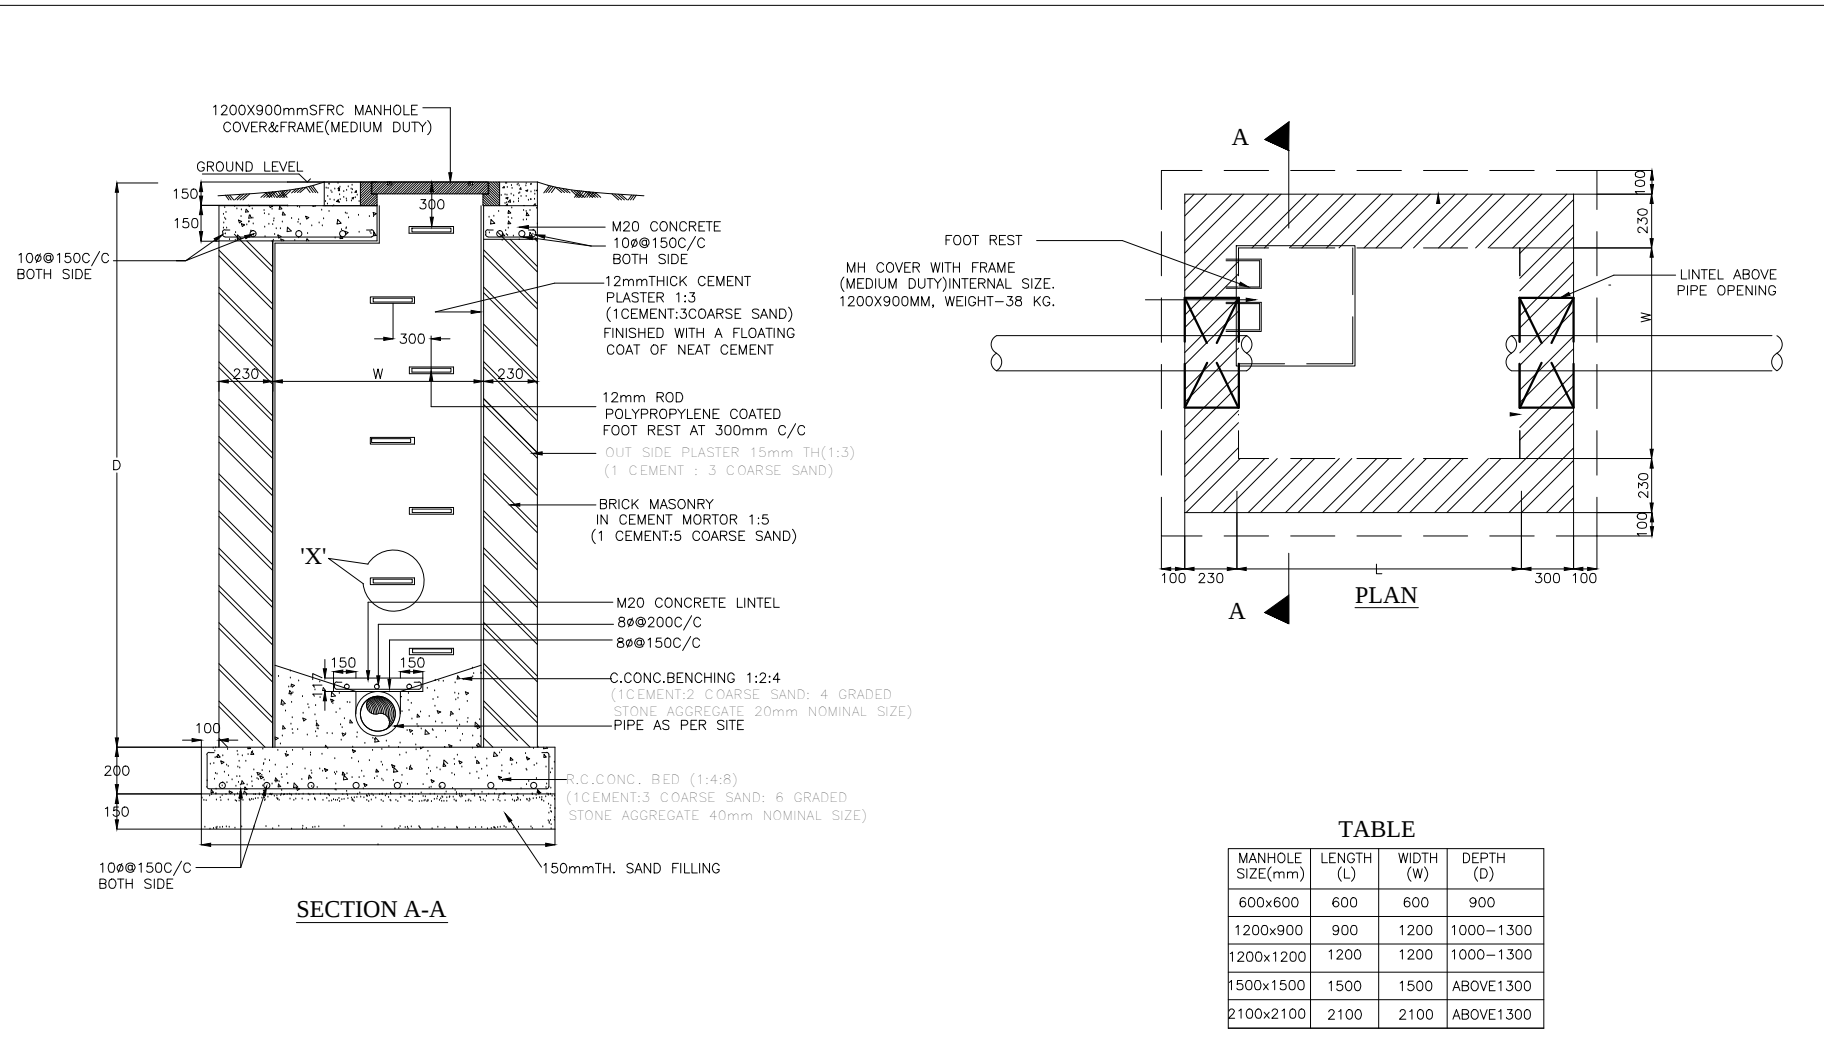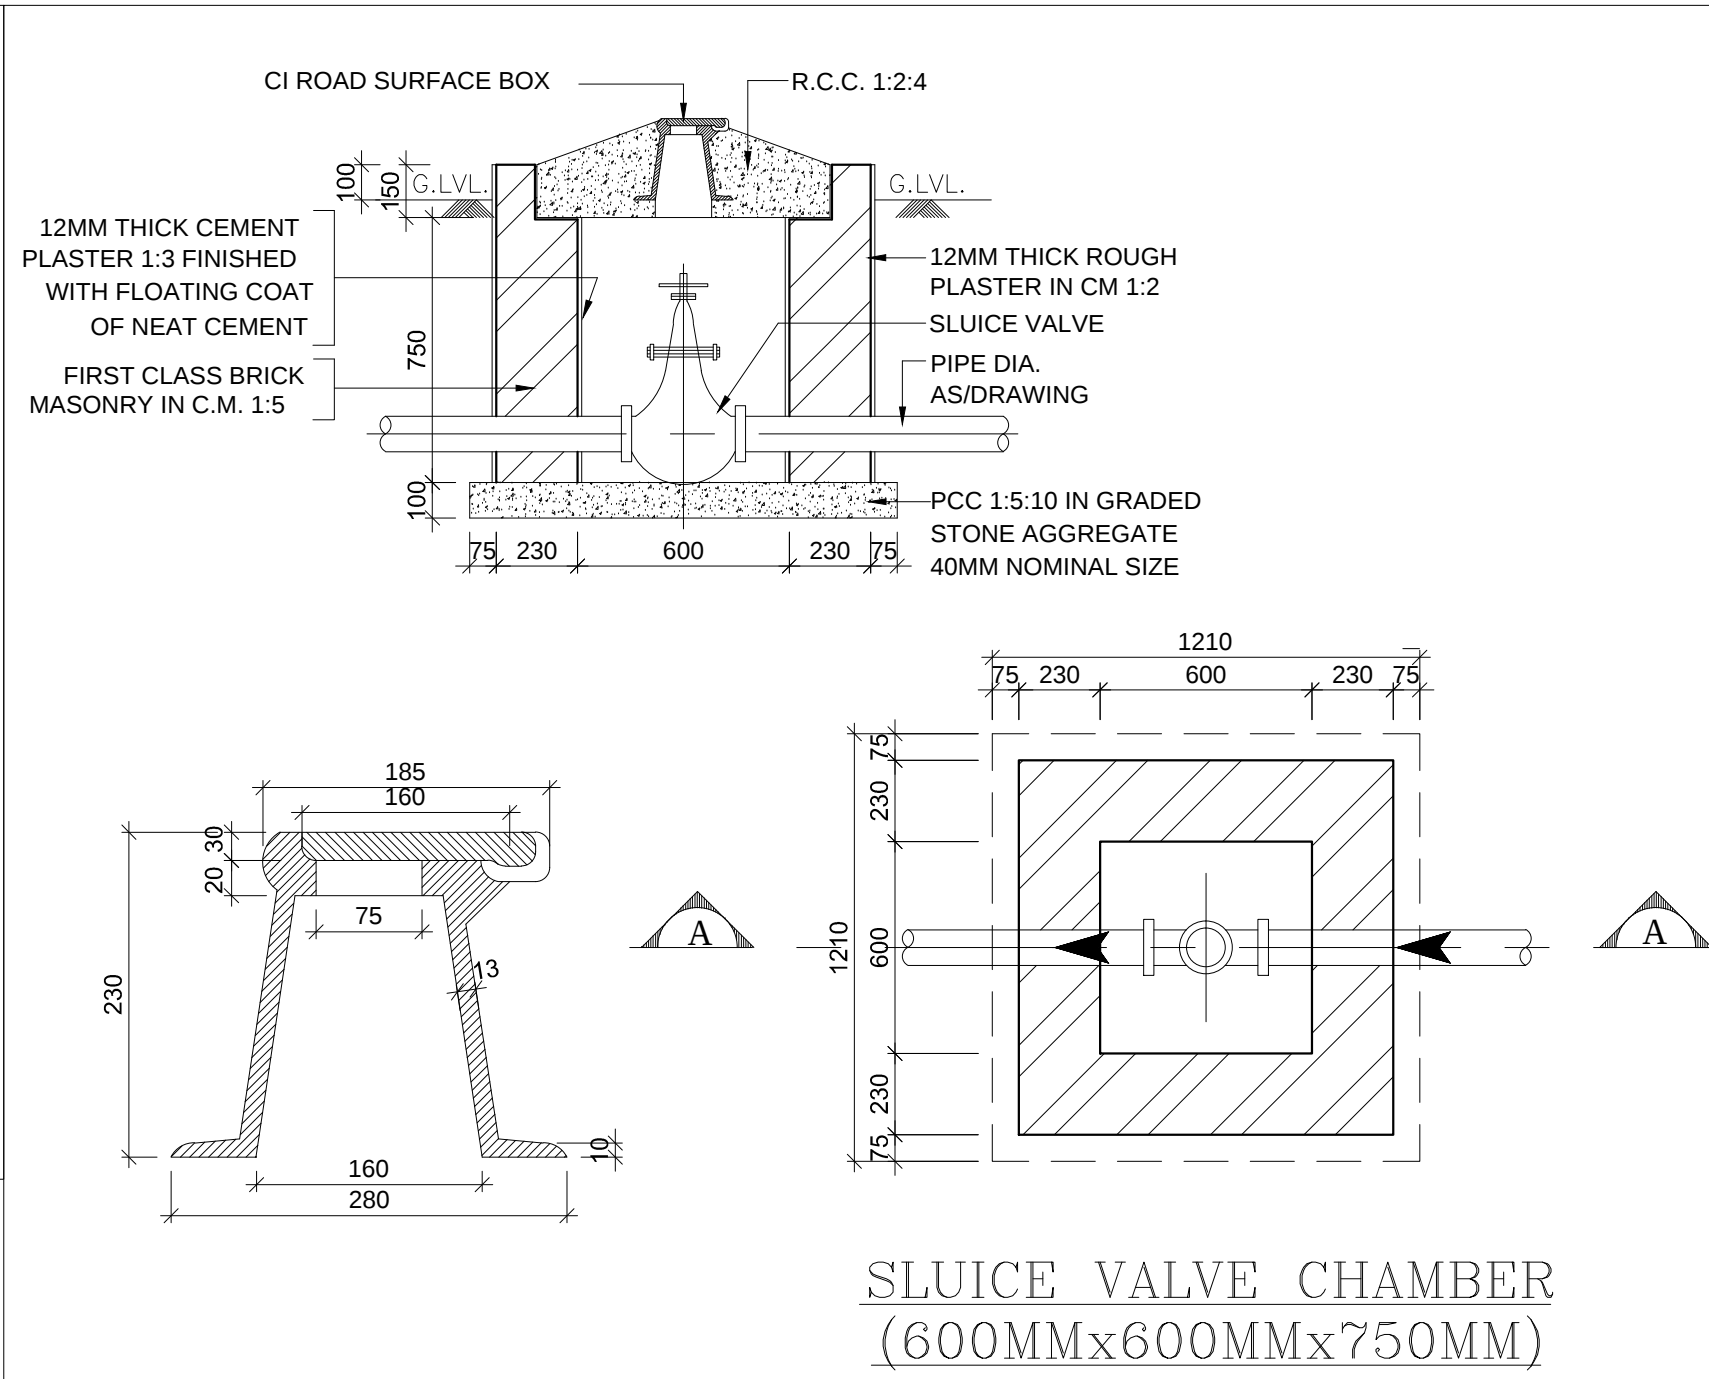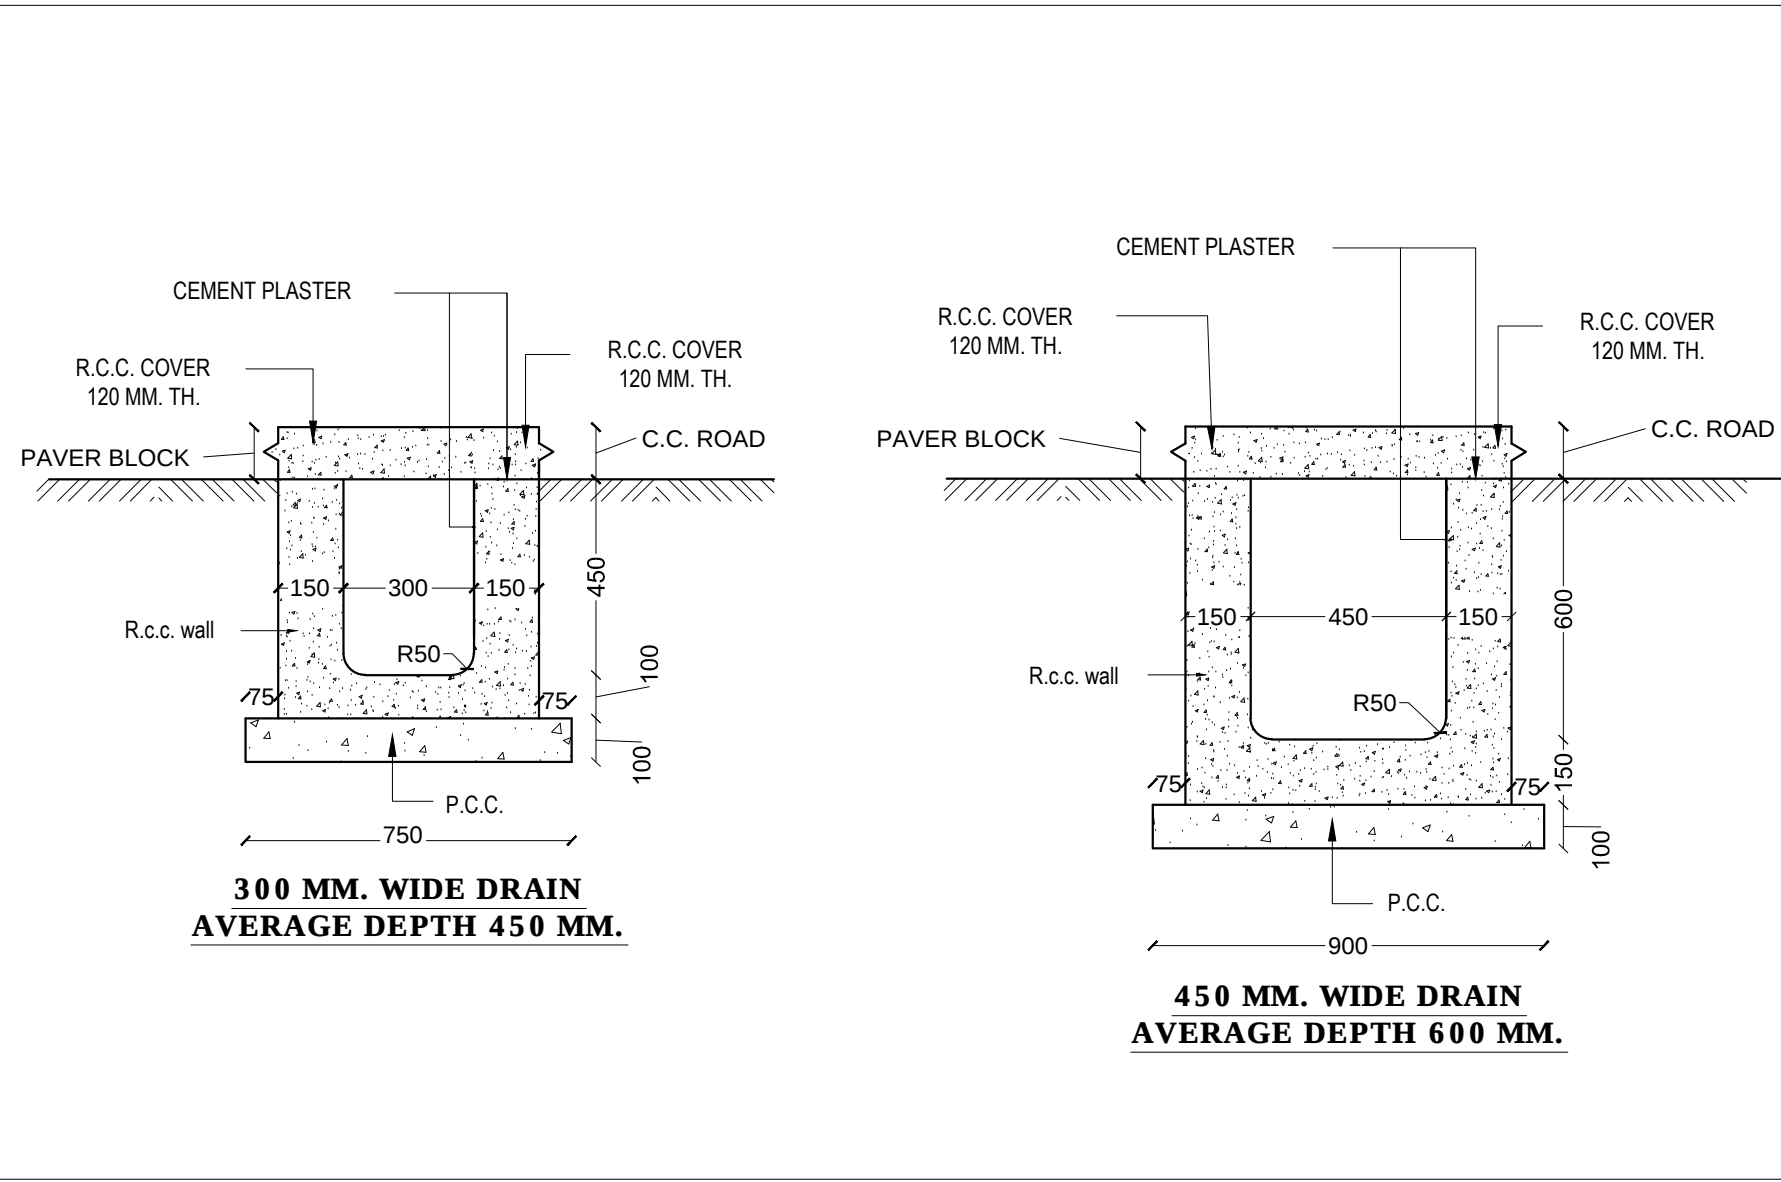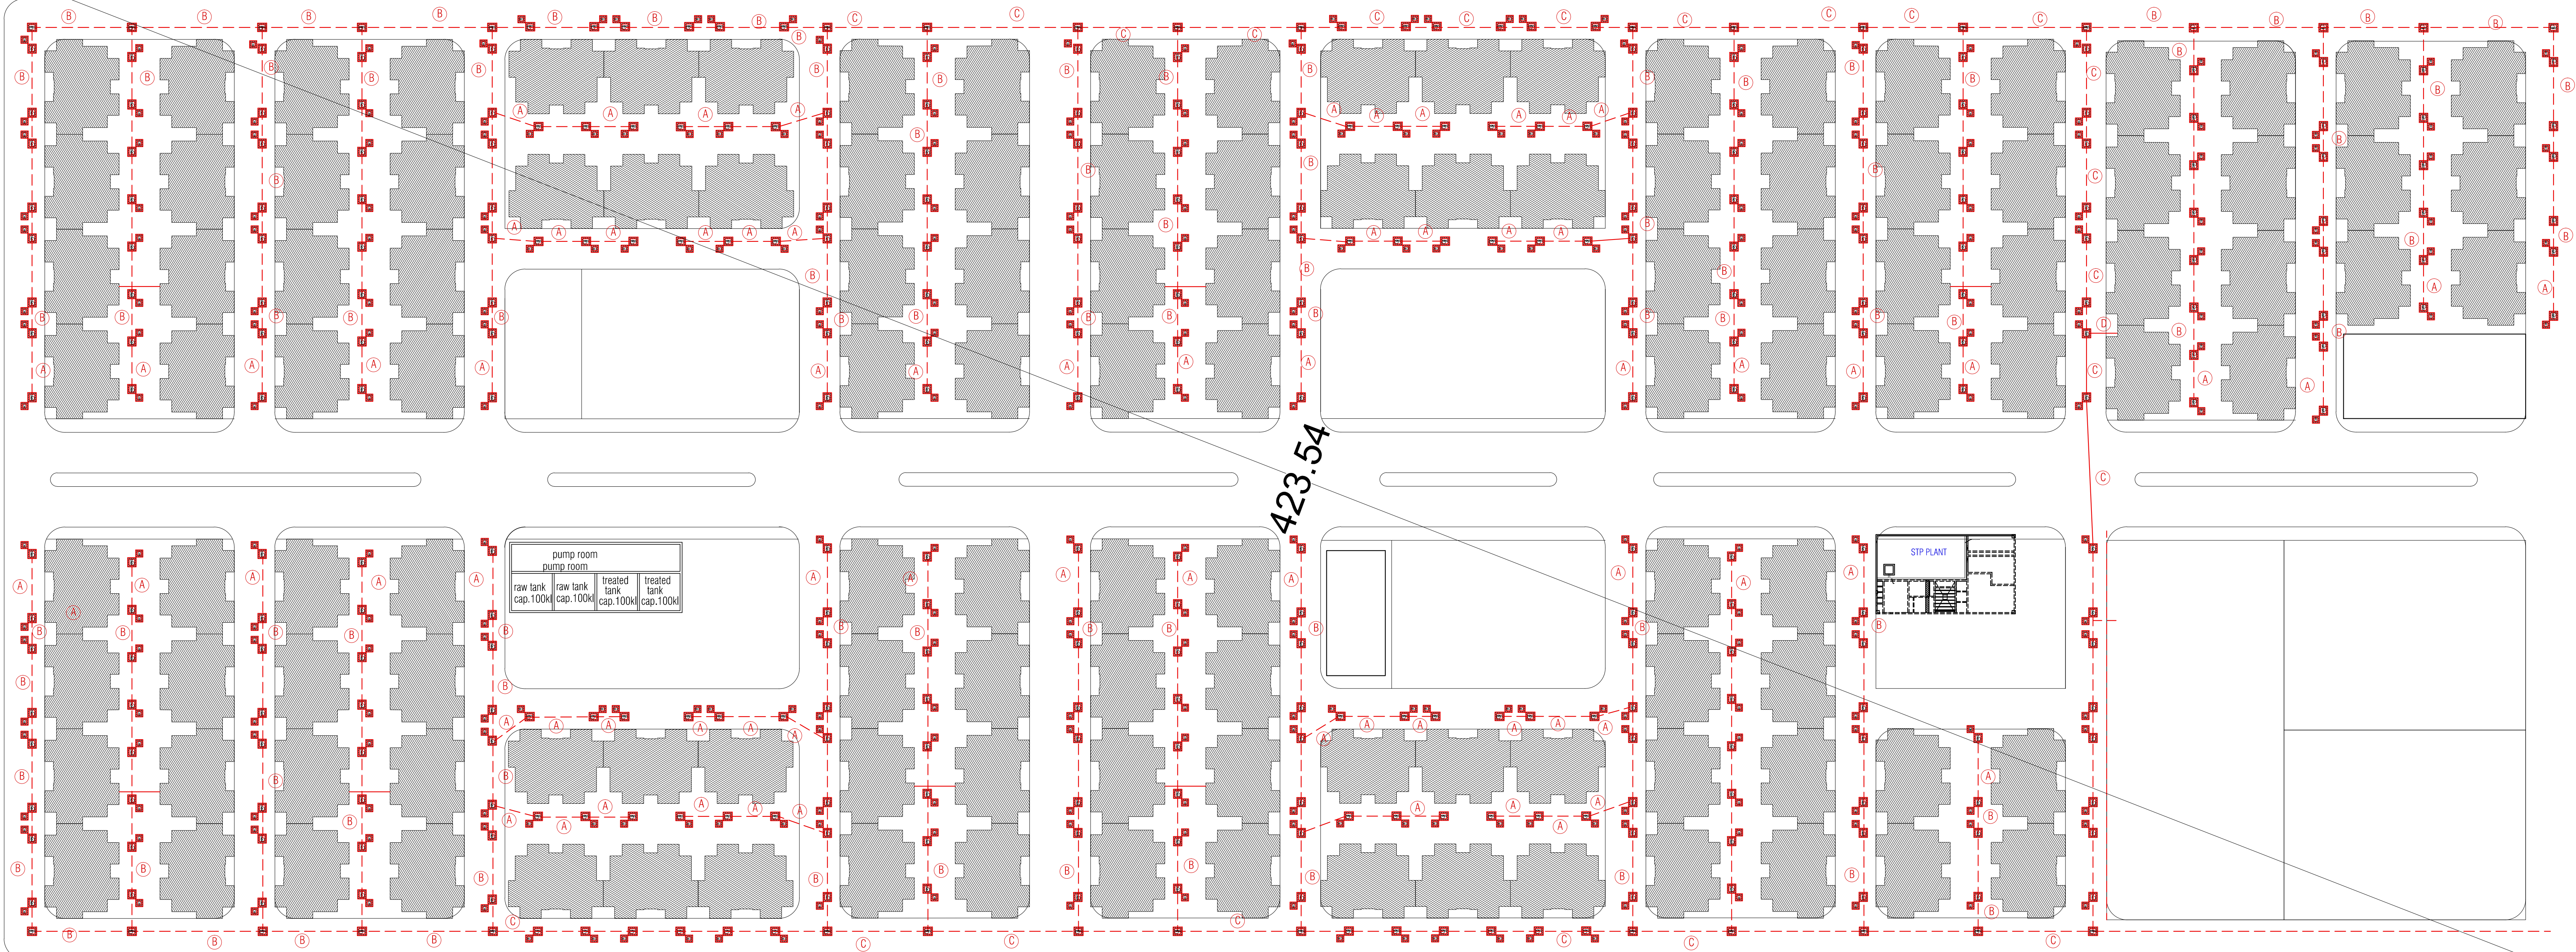

NOTE : -
A - 150ø SEWAGE LINE
B - 250ø SEWAGE LINE
C - 300ø SEWAGE LINE
D - 450ø SEWAGE LINE
VC - VALVE CHAMBER

REVISIONS :		
S.N.	REVISION	DATE
1		
2		
3		

PROJECT:
PROPOSED GROUP HOUSING
SCHEME UNDER INFORMAL
CATEGORY IN SECTOR - 10 & 12,
GREATER NOIDA.

JOB TITLE:
INFORMAL HOUSING

DRG. TITLE:
SITE LAYOUT PLAN -
PLUMBING SITE LAYOUT PLAN

SCALE	DATE	DRG. NO. -
NTS	25-04-2017	PL-01

CONSULTING ARCHITECTS:
AED
ARCH-EN DESIGN
Architect ASHOK KUMMAR
DELHI OFF: B-3, RAJZ ARIAN, NEW DELHI-110028
LUCKNOW OFF: 45/158/222, F-11, 45/158/228
6222-488222, Fax: +91-522-488228