

SUBMISSION DRAWING

NORTH

SHEET NO.

1/17

LEGEND : (FIRE ALARM SYSTEM)

S.No.	SYMBOL	DESCRIPTION	HEIGHT OF F.L.
1.	SPK	SPEAKER FOR A. SYSTEM	CEILING
2.	SD	SMOKE DETECTOR ABOVE FALSE CEILING WITHIN	CEILING
3.	SD	SMOKE DETECTOR BELOW FALSE CEILING	CEILING
4.	HTD	HEAT DETECTOR	CEILING
5.	HTD	HEAT & HOODER	CEILING
6.	HTD	HEAT & HOODER	CEILING
7.	HTD	HEAT & HOODER	CEILING
8.	HTD	HEAT & HOODER	CEILING
9.	HTD	HEAT & HOODER	CEILING
10.	HTD	HEAT & HOODER	CEILING
11.	HTD	HEAT & HOODER	CEILING
12.	HTD	HEAT & HOODER	CEILING
13.	HTD	HEAT & HOODER	CEILING
14.	HTD	HEAT & HOODER	CEILING
15.	HTD	HEAT & HOODER	CEILING
16.	HTD	HEAT & HOODER	CEILING
17.	HTD	HEAT & HOODER	CEILING
18.	HTD	HEAT & HOODER	CEILING
19.	HTD	HEAT & HOODER	CEILING
20.	HTD	HEAT & HOODER	CEILING
21.	HTD	HEAT & HOODER	CEILING

DOOR / WINDOW SCHEDULE

S.No.	TYPE	SIZE	ILL. LEVEL	DOOR SIZE	WINDOW SIZE	REMARKS
1.	D	2000X2150	-	-	-	MAIN ENTRANCE DOOR
2.	D1	2000X2150	-	-	-	MAIN ENTRANCE DOOR
3.	D2	1800X2150	-	-	-	MAIN ENTRANCE DOOR
4.	D3	1200X2150	-	-	-	MAIN ENTRANCE DOOR
5.	D4	1000X2150	-	-	-	MAIN ENTRANCE DOOR
6.	D5	900X2150	-	-	-	MAIN ENTRANCE DOOR
7.	D6	800X2150	-	-	-	MAIN ENTRANCE DOOR
8.	D7	700X2150	-	-	-	MAIN ENTRANCE DOOR
9.	DW1	600X2150	800	2000	3000X2	UPPER FLOOR
10.	DW2	500X2150	800	2000	1500X2	UPPER FLOOR
11.	DW3	400X2150	800	2000	1000X2	UPPER FLOOR
12.	DW4	300X2150	800	2000	500X2	UPPER FLOOR
13.	DW5	200X2150	800	1000	2500X1	UPPER FLOOR
14.	DW6	1500X2150	800	1000	750X1	UPPER FLOOR
15.	GW1	2000X2150	-	-	-	MAIN ENTRANCE DOOR
16.	GW2	1800X2150	-	-	-	MAIN ENTRANCE DOOR
17.	GW3	1600X2150	-	-	-	MAIN ENTRANCE DOOR
18.	GW4	1400X2150	-	-	-	MAIN ENTRANCE DOOR
19.	GW5	1200X2150	-	-	-	MAIN ENTRANCE DOOR
20.	GW6	1000X2150	-	-	-	MAIN ENTRANCE DOOR
21.	GW7	800X2150	-	-	-	MAIN ENTRANCE DOOR
22.	GW8	600X2150	-	-	-	MAIN ENTRANCE DOOR

PROJECT TITLE:

EKANA MALL AT
EKANA SPORTZ CITY, LUCKNOW

THIS IS TO CERTIFY THAT THIS BUILDING IS PROPOSED
AS PER THE RULES & REGULATIONS OF MAHARAJA 2021

SIGN OF LAND LORD.




SIGN OF ARCHITECT.



SCALE:-
ISO-A1

DATE:-
06-07-2018

Skyline
architectural consultant pvt. ltd.
architects, engineers, planner
interior design, interior design, & exterior
Office - 1st & 2nd floor, Laxmi Vardan commercial complex at
patrakar puram crossing gomti nagar, lucknow.
Dist - +91-522-2593123, 2394123, 4044123
Email - skyline@skyline.com
ARCHITECTS :- SANJAY & VIJAY SINHA

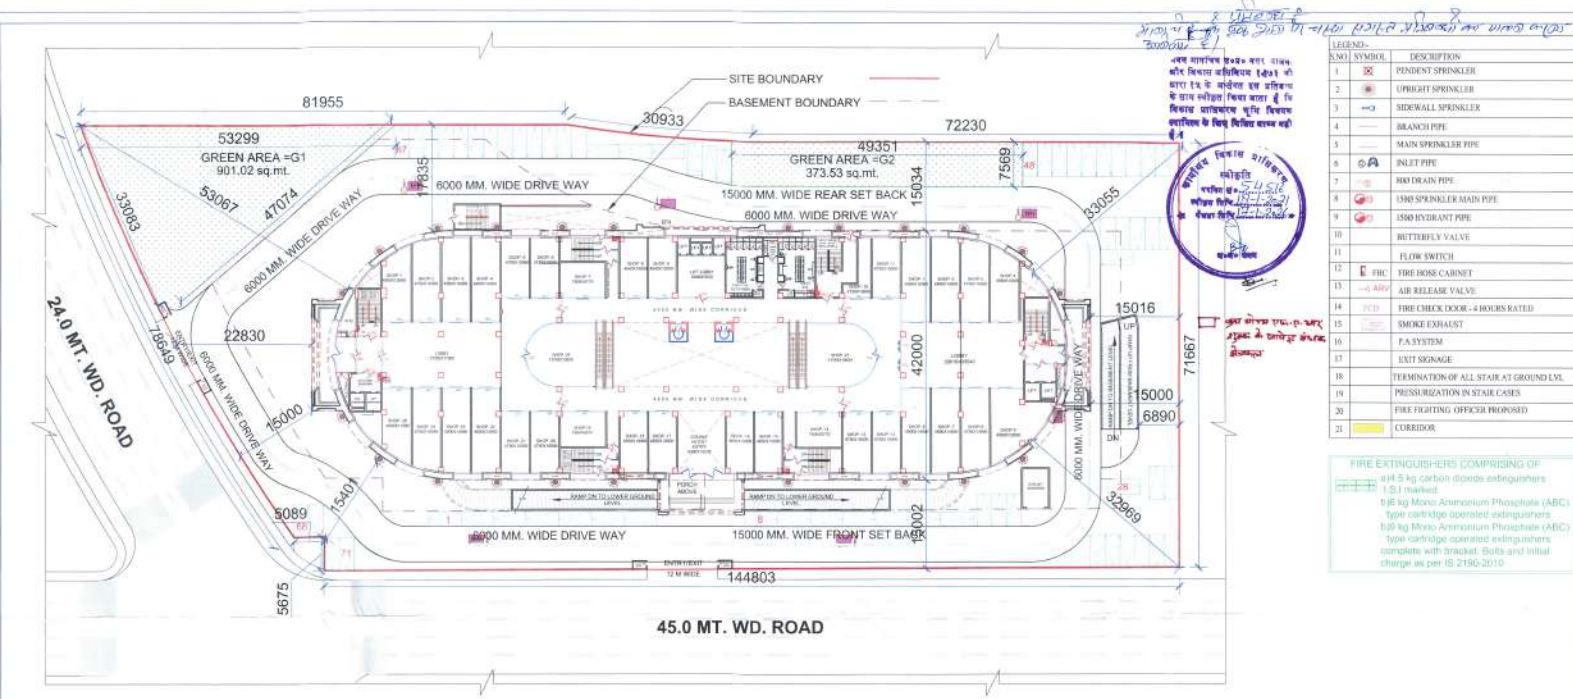


NO. OF CARS PARKING IN GROUND LEVEL = 71 NOS.

SITE PLAN


SCALE-1:200

TOTAL GREEN AREA = 1274.55 sq.mt.

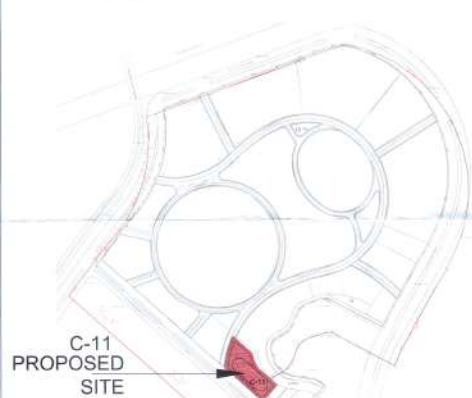


C-11
PROPOSED
SITE

KEY PLAN
(N.T.S.)

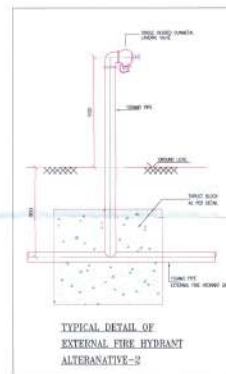


TYPICAL DETAIL OF
EXTERNAL FIRE HYDRANT
ALTERNATIVE-2

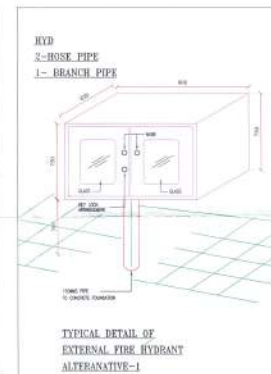


TYPICAL DETAIL OF
EXTERNAL FIRE HYDRANT
ALTERNATIVE-1

G1 = 901.02 sq.mt.
G2 = 373.53 sq.mt.
TOTAL GREEN AREA = 1274.55 sq.mt.

AREA STATEMENT CHART	
S.NO.	AREA IN SQ. MT.
1.0	TOTAL PLOT AREA
2.0	TOTAL PERMISSIBLE GREEN AREA (10 %)
3.0	TOTAL AVAILABLE GREEN AREA
4.0	TOTAL PERMISSIBLE GROUND COVERAGE AREA (40 %)
5.0	TOTAL PERMISSIBLE F.A.R. (2.5 %)
6.0	PURCHASABLE F.A.R. (1.25 %)
7.0	TOTAL PERMISSIBLE COVERED AREA (F.A.R. (1.25+0.5 = 1.75 %))
8.0	SECOND BASEMENT COVERED AREA
9.0	FIRST BASEMENT COVERED AREA
10.0	LOWER GROUND FLOOR COVERED AREA
11.0	GROUND FLOOR COVERED AREA
12.0	UPPER GROUND FLOOR COVERED AREA
13.0	FIRST FLOOR COVERED AREA
14.0	SECOND FLOOR COVERED AREA
15.0	THIRD FLOOR COVERED AREA
16.0	FOURTH FLOOR COVERED AREA
17.0	FOURTH FLOOR MEZZANINE COVERED AREA
18.0	FIFTH FLOOR COVERED AREA
19.0	SIXTH FLOOR COVERED AREA
20.0	SEVENTH FLOOR COVERED AREA
21.0	EIGHT FLOOR COVERED AREA
22.0	COVERED AREA FOR ROOF TOP RESTURANT AT TERRACE FLOOR
23.0	TERRACE FLOOR COVERED AREA (MUMTY & MACHINE ROOM)
24.0	TOTAL COVERED AREA
25.0	TOTAL CHARGEABLE AREA
TOTAL REQUIRED CAR PARKING	
1.0	TOTAL NO. OF CHAIRS IN AUDITORIUM
2.0	1 CAR PARK FOR 10 CHAIRS (1244/10 = 124.4)
3.0	COVERED AREA OF SHOPPING MALL
4.0	NO. OF CARS (Required 3 pcs per 100 sqmt.) (25347.89 X 3 / 100 = 760.43)
5.0	COVERED AREA OF OFFICE
6.0	NO. OF CARS (Required 3 pcs per 100 sqmt.) (11886.10 X 3 / 100 = 239.72)
7.0	TOTAL REQUIRED CAR PARKING = (124.4+760.43+239.72 = 1124.55)
8.0	TOTAL AVAILABLE CAR PARKING
9.0	TOTAL CAR PARKING IN SECOND BASEMENT (230X230X230) MULTI-LEVEL PARKING
10.0	TOTAL CAR PARKING IN FIRST BASEMENT (224X224X224) MULTI-LEVEL PARKING
11.0	TOTAL CAR PARKING IN SITE PLAN
12.0	TOTAL AVAILABLE CAR PARKING (680+672+86 = 1448 CARS)

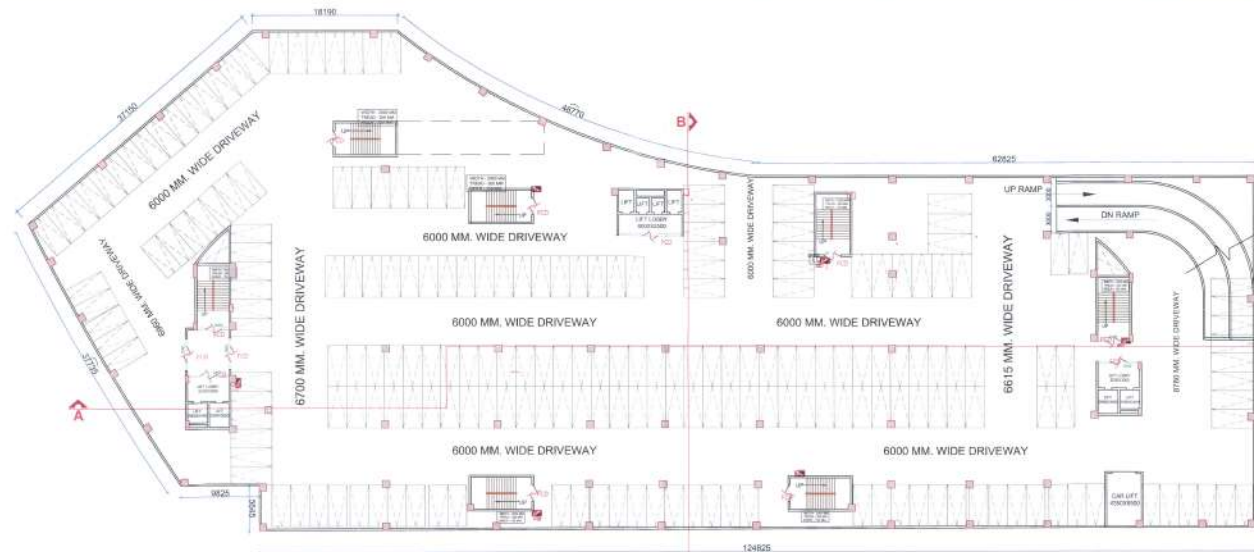

THREE LEVEL CAR PARKING
NO. OF PARKING = 230 NOS.
TOTAL CAR PARKING
IN SECOND BASEMENT = 230X3 =690 NOS.

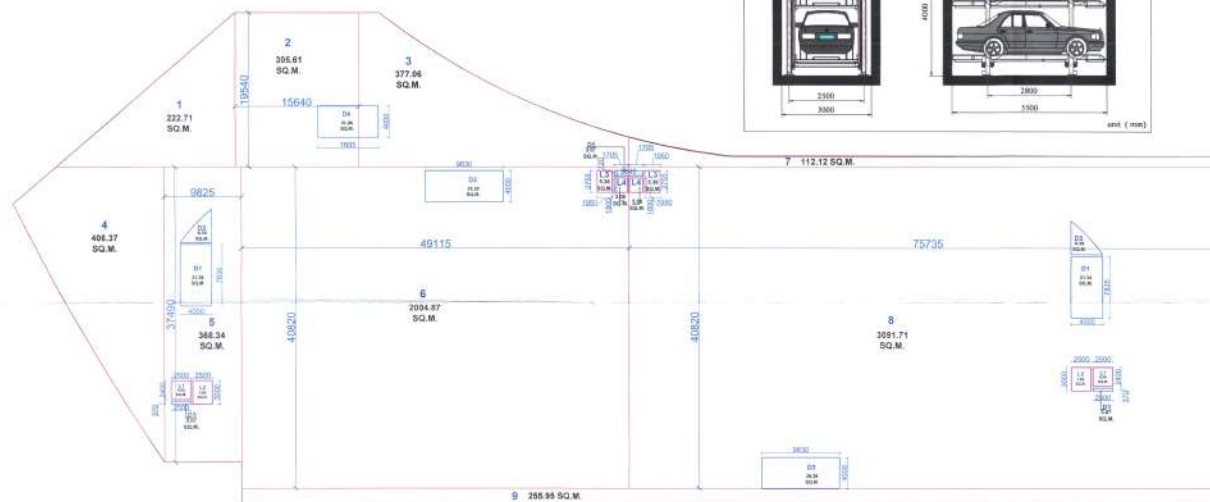

एक सार्वजनिक ४०२० मर-पावन, सीर विकास अधिविवन १९७३ की मारा १५ के अर्गुल्ल इस प्रसिद्ध के साथ स्वीकृत किया जाता है कि विकास सार्वजनिक भूमि विकास स्वाधिन के शिष्ट विधि लागू नहीं है ।



SUBMISSION DRAWING

NORTH

SHEET NO.

2/17

SECOND MARKET FLOOR AREA						
S.N.	DESCRIPTION	NET WT	NET WT IN MT	AREA	QUANTITY	AREA IN SQM
PROPOSED RUGS						
1.0	1			222.91	1	222.91
2.0	2	18.84	18.84	205.08	1	205.08
3.0	3	1.08	1.08	57.48	1	57.48
4.0	4			408.27	1	408.27
5.0	5	8.62	37.49	208.24	1	208.24
6.0	6	40.8	40.8	234.67	1	234.67
7.0	7			143.12	1	143.12
8.0	8	10.16	46.68	219.71	1	219.71
9.0	9			308.06	1	308.06
TOTAL AREA						2746.78
SHUT & LEFT AREA						
1.0	1	2.6	2.6	8	1	8
2.0	2			3	1	3
3.0	3	1.08	1.08	57.48	1	57.48
4.0	4	1.08	1.08	57.48	1	57.48
5.0	5	1.7	1.8	26.56	1	26.56
6.0	6	7.63	7.63	24.24	1	24.24
7.0	7	8	8	9.39	1	9.39
8.0	8	5.63	5.63	20.78	1	20.78
9.0	9	7.63	7.63	39.25	1	39.25
10.0	10	7.68	7.68	31.02	1	31.02
TOTAL AREA						258.04
TOTAL SECOND MARKET FLOOR AREA				(2746.78+258.04)		2994.82

PROJECT TITLE:

EKANA MALL AT
EKANA SPORTZ CITY, LUCKNOW

THIS IS TO CERTIFY THAT THIS BUILDING IS PROPOSED
AS PER THE RULES & REGULATIONS OF MAHAYOUJANA 2021



SIGN OF LANDLORD

SIGN OF ARCHITECT	
-------------------	--


SCALE
ISO-A1

DATE _____

06-07-2018



architectural consultant pvt. ltd.
architects, engineers, planner
landscape design, interior design, & value
Office: lind & lind floor lakshmi verdan commercial complex at
patrakar puram crossing gemlinagar, lucknow.
Dial: - +91-522-2393123, 2394123, 4644123
Email Id:- skyline@usahcc.com
ARCHITECTS - SANJAY & VIJAY SINHA

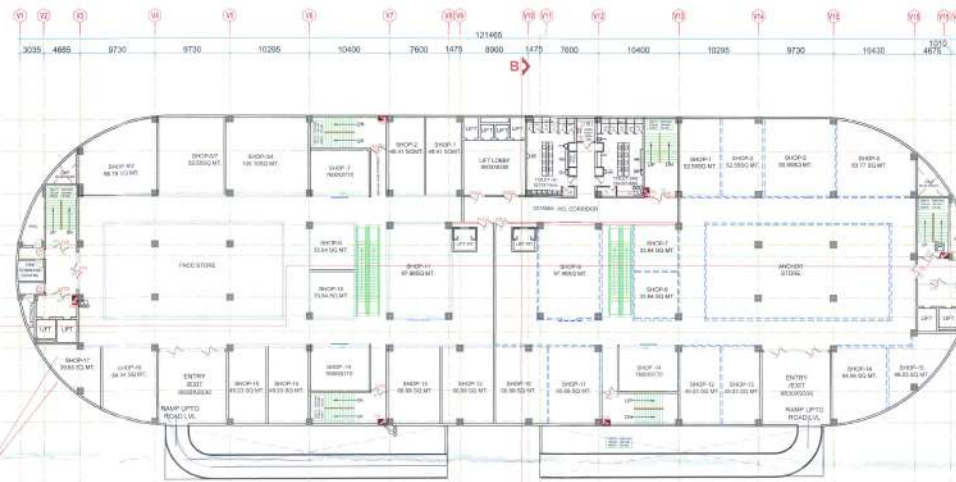

LOWER GROUND PLAN
SCALE-1:150



ENVELOPE PLAN OF LOWER GROUND PLAN
SCALE-1:150

LOWER GROUND FLOOR AREA					
S.NO	DISCRIPTION	SIZE IN MT	SIZE IN MT	AREA	QUANTITY
PROPOSED BUILDING					
1.0	1	X	X	628.00	2
2.0	2	84.085	40.050	3367.60	1
3.0	3	X	X	25.49	2
4.0	4	30.490	3.230	98.48	2
AREA -A1					4871.55
DUCT & LIFT AREA					
1.0	D1	4.00	8.25	33.00	2
2.0	D2	X	X	9.20	2
3.0	S1	9.83	4.00	39.32	2
TOTAL AREA					163.04
AREA A1 - DUCT					(4871.55 - 163.04)
TOTAL LOWER GROUND FLOOR AREA					4708.51 SQ.MT.

एक मॉल एका स्पोर्ट्स सिटी लखनऊ
एक मॉल एका स्पोर्ट्स सिटी लखनऊ
SUBMISSION DRAWING

NORTH

SHEET NO.

4/17

DOOR / WINDOW SCHEDULE						
S. NO	TYPE	SIZE	SHALL LEVEL	DOOR SIZE	WINDOW UNTEL LEVEL	REMARKS
1.	D	3000X2500	-	-	2550	BASEMENT DOOR
2.	D1	2000X2500	-	-	2550	BASEMENT DOOR
3.	D2	1500X2500	-	-	2550	BASEMENT DOOR
4.	D3	1200X2500	-	-	2550	BASEMENT DOOR
5.	D4	1000X2500	-	-	2550	BASEMENT DOOR
6.	D5	800X2500	-	-	2550	BASEMENT DOOR
7.	D6	600X2500	-	-	2550	BASEMENT DOOR
8.	D7	400X2500	-	-	2550	BASEMENT DOOR
9.	DW1	3000X2500	900	2000	3000X2500	BASEMENT DOOR
10.	DW2	3000X2500	900	2000	3000X2500	BASEMENT DOOR
11.	DW3	3000X2500	900	2000	3000X2500	BASEMENT DOOR
12.	DW4	3000X2500	900	2000	3000X2500	BASEMENT DOOR
13.	DW5	3000X2500	900	2000	3000X2500	BASEMENT DOOR
14.	DW6	3000X2500	900	2000	3000X2500	BASEMENT DOOR
15.	DW7	3000X2500	900	2000	3000X2500	BASEMENT DOOR
16.	DW8	3000X2500	900	2000	3000X2500	BASEMENT DOOR
17.	DW9	3000X2500	900	2000	3000X2500	BASEMENT DOOR
18.	DW10	3000X2500	900	2000	3000X2500	BASEMENT DOOR
19.	DW11	3000X2500	900	2000	3000X2500	BASEMENT DOOR
20.	DW12	3000X2500	900	2000	3000X2500	BASEMENT DOOR
21.	DW13	3000X2500	900	2000	3000X2500	BASEMENT DOOR
22.	DW14	3000X2500	900	2000	3000X2500	BASEMENT DOOR

LEGEND : (FIRE ALARM SYSTEM)		HEIGHT OF
S. NO.	SYMBOL / DESCRIPTION	HEIGHT OF
1.	SPRINKLER SYSTEM	1000MM
2.	SMOKE DETECTOR	1000MM
3.	SMOKE DETECTOR	1000MM
4.	SMOKE DETECTOR	1000MM
5.	SMOKE DETECTOR	1000MM
6.	SMOKE DETECTOR	1000MM
7.	SMOKE DETECTOR	1000MM
8.	SMOKE DETECTOR	1000MM
9.	SMOKE DETECTOR	1000MM
10.	SMOKE DETECTOR	1000MM

PROJECT TITLE:

EKANA MALL AT
EKANA SPORTZ CITY, LUCKNOW


THIS IS TO CERTIFY THAT THIS BUILDING IS PROPOSED
AS PER THE RULES & REGULATIONS OF U.P. ARCHITECTURE ACT, 1962.



SCALE: 1:200

DATE: 06-07-2018

Skyline
architectural consultant pvt. ltd.
architects, engineers, planner
interior design, interior design, & value
Office: 1st & 2nd floor, Laxmi Vardan commercial complex at
gautam puram crossing gomti nagar, lucknow.
Dial: +91-522-2393123, 2394123, 4844123
Email id: skyline@usahcc.com
ARCHITECTS :- SANJAY & VIJAY SINHA

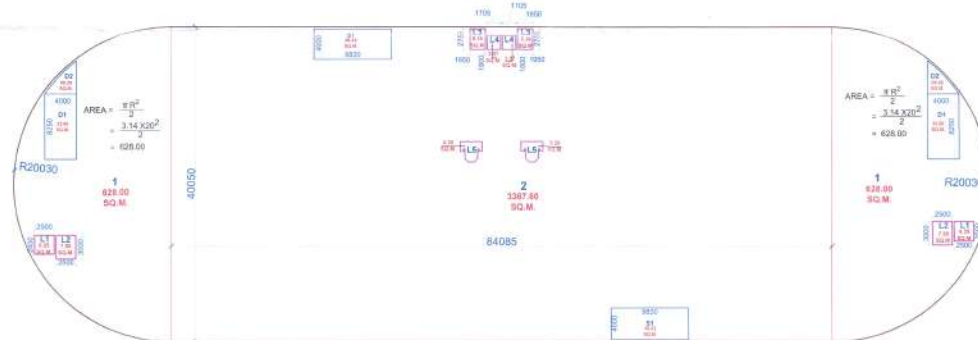

GROUND FLOOR AREA						
S.NO	DISCRIPTION	SIZE IN MT	SIZE IN MT	AREA	QUANTITY	AREA IN SQMT
PROPOSED BUILDING						
1.0	1	X	X	628.00	2	1256.00
2.0	2	84.085	40.050	3367.60	1	3367.60
AREA A1						4623.60
DUCT & LIFT AREA						
1.0	L1	2.50	2.50	6.25	2	12.50
2.0	L2	2.50	3.00	7.50	2	15.00
3.0	L3	1.95	2.75	5.36	2	10.73
4.0	L4	1.71	1.80	3.07	2	6.14
5.0	L5	X	X	5.30	2	10.60
6.0	D1	4.00	8.25	33.00	2	66.00
7.0	D2	X	X	9.20	2	18.40
8.0	S1	9.83	4.00	39.32	2	78.64
TOTAL AREA						218.00
AREA A1 - DUCT & LIFT AREA						4405.60
TOTAL GROUND FLOOR AREA						4405.60 SQ.MT.

नवन वातावरण बनाई नवन वातावरण
कीर विकास प्रतिष्ठान (प्रा.) की
वाता १५ के अनुसार एक प्रतिष्ठान
के वाता वातावरण बनाया है कि
वातावरण वातावरण वातावरण
वातावरण के लिए वातावरण वातावरण
है।



SUBMISSION DRAWING

NORTH

SHEET NO.

5/17

DOOR / WINDOW SCHEDULE

S.NO.	TYPE	SIZE	DOOR LEVEL	WINDOW LEVEL	REMARKS
1.	D1	3000X2500	-	-	MAIN ENTRANCE DOOR
2.	D1	2000X2500	-	-	MAIN ENTRANCE DOOR
3.	D2	1500X2500	-	-	MAIN ENTRANCE DOOR
4.	D3	1000X2500	-	-	MAIN ENTRANCE DOOR
5.	D4	1000X2500	-	-	MAIN ENTRANCE DOOR
6.	D5	800X2500	-	-	MAIN ENTRANCE DOOR
7.	D6	800X2500	-	-	MAIN ENTRANCE DOOR
8.	D7	600X2500	-	-	MAIN ENTRANCE DOOR
9.	DW1	800X2500	999	2000	2000X2
10.	DW2	500X2500	999	2000	1500X2
11.	DW3	400X2500	999	2000	1000X2
12.	DW4	300X2500	999	2000	500X2
13.	DW5	300X2500	999	1000	2000X1
14.	DW6	1750X2500	999	1000	700X1
15.	GD1	2000X2500	-	-	2000X2
16.	GDW1	1000X2500	-	2000	4000X2
17.	GDW2	800X2500	-	2000	3000X2
18.	GDW3	600X2500	-	2000	2400X2
19.	GDW4	400X2500	-	2000	1600X1
20.	GDW5	4500X2500	-	1500	1500X2
21.	BP01	2000X2500	-	-	2000
22.	V1	750X1900	1500	-	2500

PROJECT TITLE:

EKANA MALL AT
EKANA SPORTZ CITY, LUCKNOW

THIS IS TO CERTIFY THAT THIS BUILDING IS PROPOSED
AS PER THE RULES & REGULATIONS OF MAHARASHTRA 2021





SCALE: 1:200



DATE: 06-07-2018

Skyline

architectural consultant pvt. ltd.
architects, engineers, planners
landscape design, interior design, & value
Office: 1st & 11th floor laxmi varden commercial complex at
patrakar duram crossing gomti nagar, lucknow.
Dist: +91-522-2394123, 2394123, 4044123
Email id: skyline@usahecc.com
ARCHITECTS: SANJAY & VIJAY SINHA

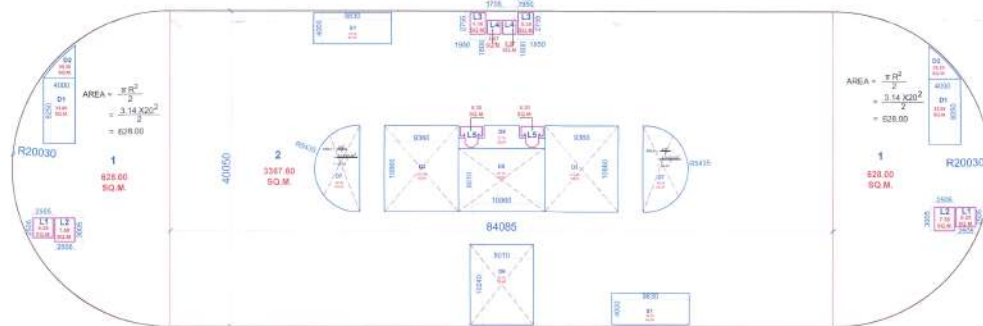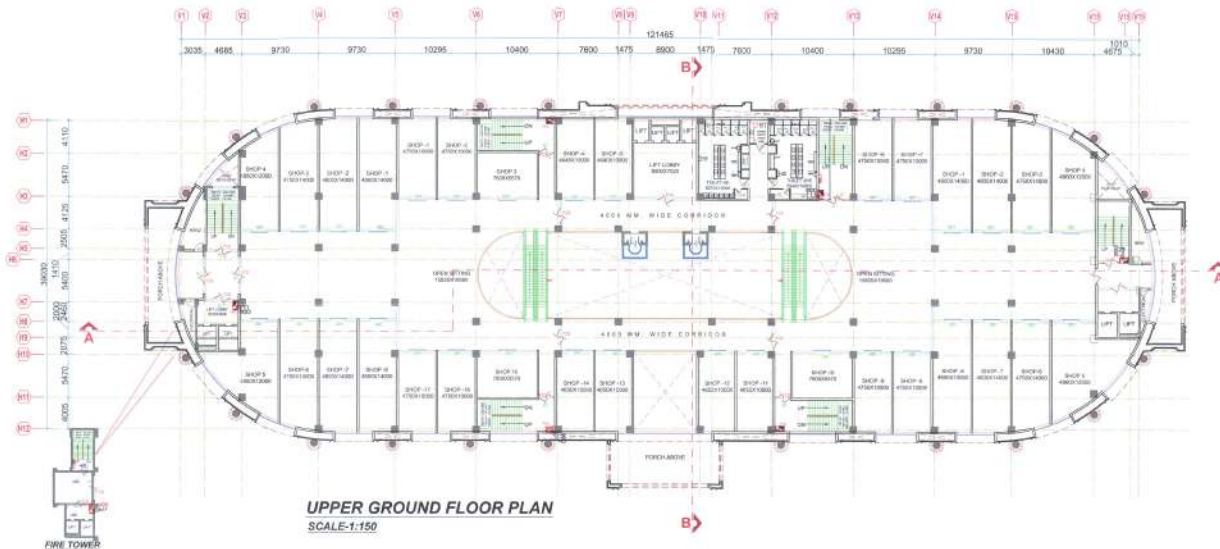

UPPER GROUND FLOOR PLAN
SCALE: 1:150

UPPER GROUND FLOOR AREA					
S.NO	DISCRIPTION	SIZE IN MT	SIZE IN MT	AREA	QUANTITY
PROPOSED BUILDING					
1.0	1	X	X	628.00	2
2.0	2	84.085	40.050	3367.60	1
AREA A1					4623.60
DUCT & LIFT AREA					
1.0	L1	2.50	2.50	6.25	2
2.0	L2	2.50	3.00	7.50	2
3.0	L3	1.95	2.75	5.36	2
4.0	L4	1.71	1.80	3.07	2
5.0	L5	X	X	5.30	2
6.0	D1	4.00	8.25	33.00	2
7.0	D2	X	X	9.20	2
8.0	D3	9.36	16.88	101.55	2
9.0	D4	X	X	17.74	1
10.0	D5	10.96	8.01	87.79	1
11.0	D6	8.01	10.24	82.02	1
12.0	D7	X	X	46.29	2
13.0	S1	9.83	4.00	39.32	2
TOTAL AREA					701.43
AREA A1 - DUCT & LIFT AREA				(4623.60 - 701.43)	3922.17
TOTAL UPPER GROUND FLOOR AREA					3922.17

नगर पालिका प्रमुख, नगर पालिका, श्रीर विमान अड्डा, लखनऊ-201001
को-12 के अन्तर्गत इस प्रोजेक्ट के लिए लीज कागजात है कि विमान अड्डा, लखनऊ, नगर पालिका, नगर पालिका के लिए लीज कागजात है।



SUBMISSION DRAWING

NORTH

SHEET NO.

6/17

DOOR / WINDOW SCHEDULE

S. NO.	TYPE	SIZE	SILL LEVEL	DOOR SIZ	WINDOW SIZE	UNIT/L	REMARKS
1.	D	3000X2550	-	-	2550	-	MAIN ENTRANCE DOOR
2.	D1	2100X2550	-	-	2550	-	MAIN ENTRANCE DOOR
3.	D2	1500X2550	-	-	2550	-	MAIN ENTRANCE DOOR
4.	D3	1200X2550	-	-	2550	-	MAIN ENTRANCE DOOR
5.	D4	1000X2550	-	-	2550	-	MAIN ENTRANCE DOOR
6.	D5	900X2550	-	-	2550	-	MAIN ENTRANCE DOOR
7.	D6	800X2100	-	-	2100	-	MAIN ENTRANCE DOOR
8.	D7	600X2550	-	-	2550	-	MAIN ENTRANCE DOOR
9.	DW1	6000X2550	900	2000	3000X2	2550	MAIN ENTRANCE DOOR
10.	DW2	5000X2550	800	2000	1000X2	2550	MAIN ENTRANCE DOOR
11.	DW3	4000X2550	800	2000	1000X2	2550	MAIN ENTRANCE DOOR
12.	DW4	3000X2550	800	2000	500X2	2550	MAIN ENTRANCE DOOR
13.	DW5	3000X2550	800	1000	2000X1	2550	MAIN ENTRANCE DOOR
14.	DW6	1700X2550	800	1000	700X1	2550	MAIN ENTRANCE DOOR
15.	DW7	2000X2550	-	-	2550	-	MAIN ENTRANCE DOOR
16.	DW8	1000X2550	-	-	2550	-	MAIN ENTRANCE DOOR
17.	DW9	800X2550	-	-	2550	-	MAIN ENTRANCE DOOR
18.	DW10	600X2550	-	-	2550	-	MAIN ENTRANCE DOOR
19.	DW11	600X2550	-	-	2550	-	MAIN ENTRANCE DOOR
20.	DW12	400X2550	-	-	2550	-	MAIN ENTRANCE DOOR
21.	SFD1	2000X2550	-	-	2550	-	MAIN ENTRANCE DOOR
22.	V1	750X1500	1500	-	2550	-	MAIN ENTRANCE DOOR

PROJECT TITLE:

EKANA MALL AT
EKANA SPORTZ CITY, LUCKNOW

THIS IS TO CERTIFY THAT THIS BUILDING IS PROPOSED
AS PER THE RULES & REGULATIONS OF URBAN L.A. 1973





SCALE:-
1:200

DATE:-
06-07-2018

Skyline

architectural consultant pvt. ltd.
architects, engineers, planner
interior designer, landscape architect
Office - 1st & 2nd floor, Laxmi Vardaan Commercial Complex at
patrakar puram crossing gomti nagar, lucknow.
Dist. :- 91-522-2393123, 2394123, 4044123
Email Id :- skyline@usahcc.com
ARCHITECTS :- SANJAY & VIJAY SINHA

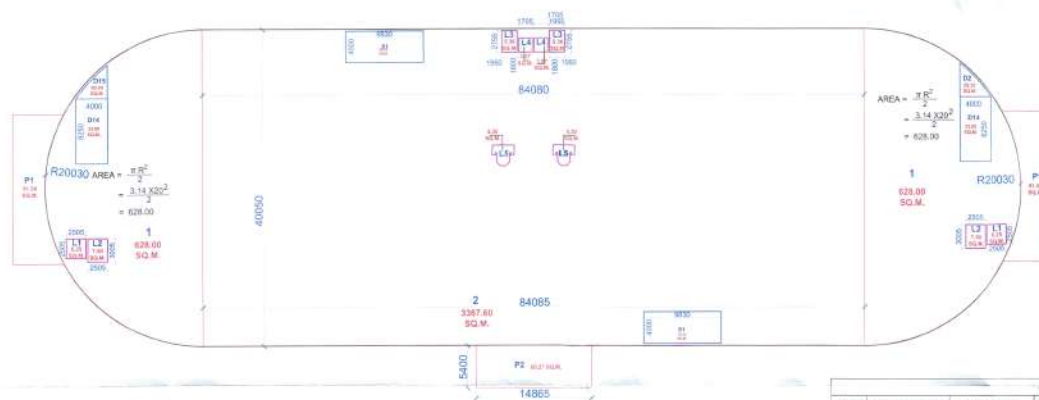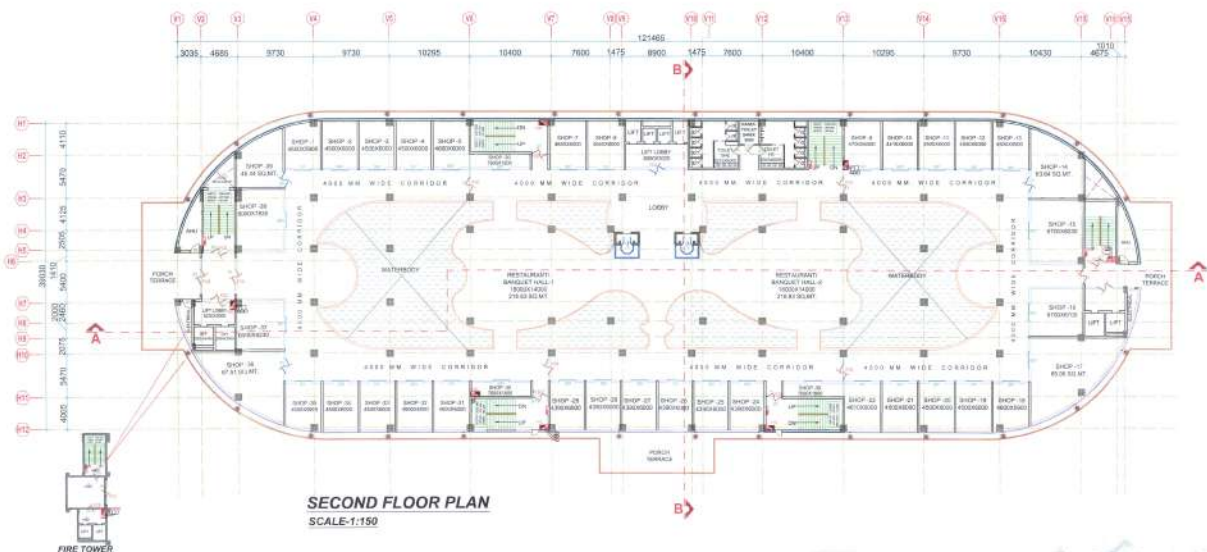

SECOND FLOOR AREA						
S.NO	DISCRPTION	SIZE IN MT	SIZE IN MT	AREA	QUANTITY	AREA IN SQMT
PROPOSED BUILDING						
1.0	1	X	X	628.00	2	1256.00
2.0	2	84.685	40.00	3387.60	1	3387.60
	PORCH P1	X	X	91.54	2	183.08
	PORCH P2	14.865	5.400	80.27	1	80.27
	AREA A1					4806.68
DUCT & LIFT AREA						
1.0	L1	2.50	2.50	6.25	2	12.50
2.0	L2	2.50	3.00	7.50	2	15.00
3.0	L3	1.95	2.75	5.36	2	10.73
4.0	L4	1.71	1.80	3.07	2	6.14
5.0	L5	X	X	5.30	2	10.60
6.0	D14	4.00	8.25	33.00	2	66.00
7.0	D15	X	X	5.20	2	10.40
8.0	S1	9.83	4.00	39.32	2	78.64
	TOTAL AREA					218.00
	AREA A1 - DUCT & LIFT AREA				(4806.68 - 218.00)	4588.68
	TOTAL SECOND FLOOR AREA					4588.68 SQ.MET.

भारत ग्राहक शिक्षा दिवस २०२० नगर योजना और विकास समितियों (टीडीओ) को मार्च १५ के अवसर पर आयोजित के साथ स्वीकृत किया जाता है कि विकास प्राधिकरण भूमि विकास समिति के लिए निर्धारित समय नहीं है।



SUBMISSION DRAWING

NORTH

SHEET NO.

8/17

DOOR		WINDOW SCHEDULE					REMARKS
S. NO	TYPE	SIZE	HELL LEVEL	DOOR SIZE	WINDOW SIZE	HELL LEVEL	
1.	D1	3000X2500	-	-	-	2500	MAIN ENTRANCE DOOR
2.	D1	2000X2500	-	-	-	2500	ENTRANCE OF STAFF ROOM
3.	D2	1500X2500	-	-	-	2500	STAFF ROOM DOOR
4.	D3	3000X2500	-	-	-	2500	ENTRANCE OF STAFF ROOM
5.	D4	1000X2500	-	-	-	2500	STAFF ROOM DOOR
6.	D5	900X2500	-	-	-	2500	STAFF ROOM DOOR
7.	D6	800X2500	-	-	-	2500	STAFF ROOM DOOR
8.	D7	1000X2500	-	-	-	2500	STAFF ROOM DOOR
9.	D8	1000X2500	-	-	-	2500	STAFF ROOM DOOR
10.	D9	1000X2500	-	-	-	2500	STAFF ROOM DOOR
184.	D183	1000X2500	-	-	-	2500	STAFF ROOM DOOR

PROJECT TITLE:

EKANA MALL AT
 EKANA SPORTZ CITY, LUCKNOW

THIS IS TO CERTIFY THAT THIS BUILDING IS PROPOSED
AS PER THE RULES & REGULATIONS OF MAHAYODHANA 2021

SIGN OF LANDLORD



SIGN OF ARCHITECT
AMERICAN INSTITUTE OF ARCHITECTS



SCALE:
ISO-A1

1:200

DATE:- 06-07-2018



architectural consultant pvt. ltd.
architects, engineers, planner
landscape design, interior design, & exterior
Office - 1st & 11th floor laxmi vardan commercial complex at
patrakar puram crossing gomtinagar, lucknow.
Dist - +91-522-2393123, 2394123, 4044123
Email for: skyline@usahcc.com
ARCHITECTS - SANJAY & VIJAY SINHA

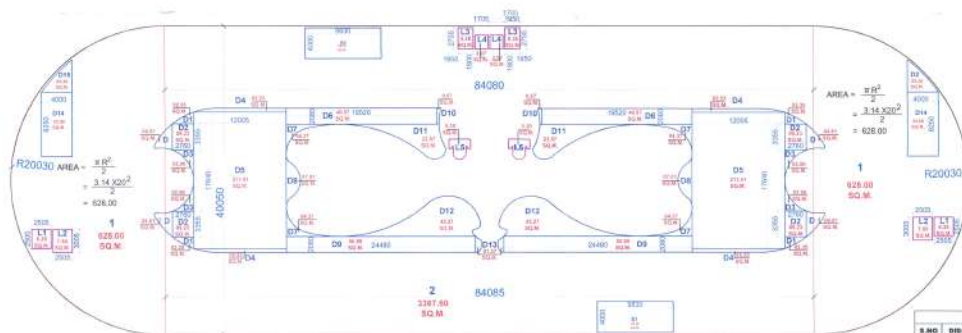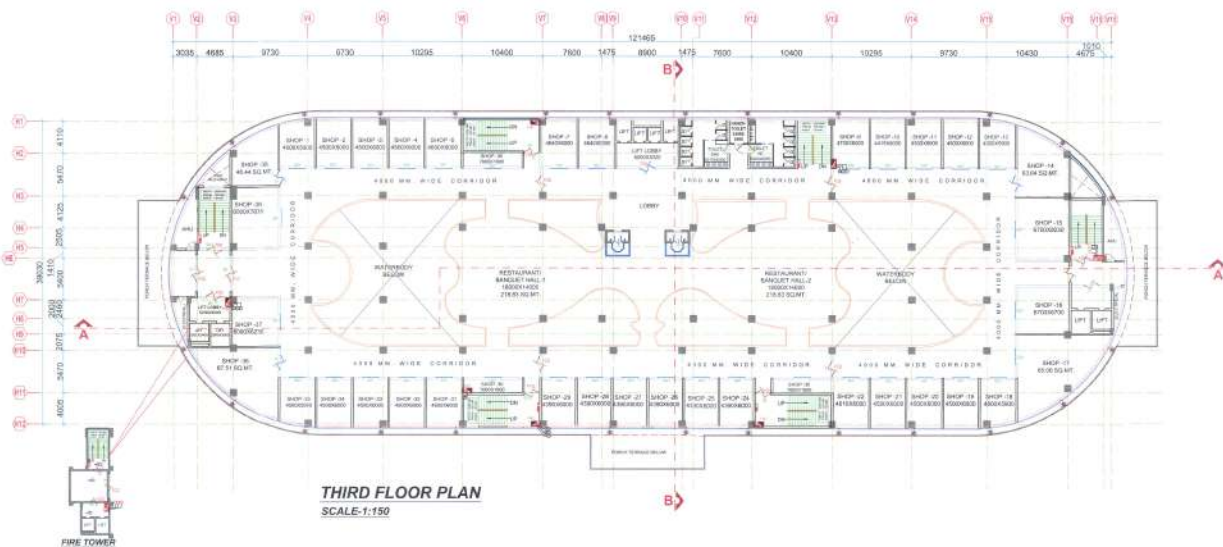

THIRD FLOOR AREA					
S.NO	DESCRIPTION	SIZE IN MT	SIZE IN MT	AREA	QUANTITY
1.0	1	X	X	829.00	2
2.0	2	84.085	48.648	3387.60	1
AREA A1				4216.60	
DUCT & LIFT AREA					
1.0	L1	2.80	2.80	6.26	2
2.0	L2	2.80	2.80	7.80	2
3.0	L3	1.80	2.70	6.26	2
4.0	L4	1.71	1.80	3.07	2
5.0	L5	X	X	6.30	2
6.0	D	X	X	4.61	4
7.0	D1	X	X	3.38	4
8.0	D2	3.76	3.38	9.23	4
9.0	D3	X	X	2.06	4
10.0	D4	X	X	6.83	4
11.0	D5	12.00	17.83	211.41	2
12.0	D6	19.01	2.80	48.87	2
13.0	D7	X	X	4.37	4
14.0	D8	X	X	7.81	2
15.0	D9	24.46	2.80	60.58	2
16.0	D10	X	X	0.67	2
17.0	D11	X	X	29.87	2
18.0	D12	X	X	46.37	2
19.0	D13	X	X	1.27	2
20.0	D14	4.00	8.28	30.80	2
21.0	D15	X	X	9.20	2
22.0	D16	8.83	4.60	39.50	2
TOTAL AREA				1008.80	
AREA A1 - DUCT & LIFT AREA				1823.80 - 1008.80	3628.11
TOTAL THIRD FLOOR AREA					3628.11 SQ.MT.

यह योजना केवल प्रारंभिक चरण के लिए है।
यह योजना केवल प्रारंभिक चरण के लिए है।
यह योजना केवल प्रारंभिक चरण के लिए है।



SUBMISSION DRAWING

NORTH

SHEET NO.

9/17

DOOR / WINDOW SCHEDULE

S.NO	TYPE	SIZE	SKL. LEVEL	DOOR SIZE	WINDOW SIZE	UNTEL LEVEL	REMARKS
1.	D	3000X2550	-	-	-	-	DOOR WINDOW
2.	D1	2000X2550	-	-	-	-	DOOR WINDOW
3.	D2	1500X2550	-	-	-	-	DOOR WINDOW
4.	D3	1200X2550	-	-	-	-	DOOR WINDOW
5.	D4	1000X2550	-	-	-	-	DOOR WINDOW
6.	D5	800X2550	-	-	-	-	DOOR WINDOW
7.	D6	600X2550	-	-	-	-	DOOR WINDOW
8.	D7	400X2550	-	-	-	-	DOOR WINDOW
9.	DW1	3000X2550	900	2550	3000X2550	2550	DOOR WINDOW
10.	DW2	3000X2550	900	2550	3000X2550	2550	DOOR WINDOW
11.	DW3	3000X2550	900	2550	3000X2550	2550	DOOR WINDOW
12.	DW4	3000X2550	900	2550	3000X2550	2550	DOOR WINDOW
13.	DW5	3000X2550	900	2550	3000X2550	2550	DOOR WINDOW
14.	DW6	3000X2550	900	2550	3000X2550	2550	DOOR WINDOW
15.	DW7	3000X2550	900	2550	3000X2550	2550	DOOR WINDOW
16.	DW8	3000X2550	900	2550	3000X2550	2550	DOOR WINDOW
17.	DW9	3000X2550	900	2550	3000X2550	2550	DOOR WINDOW
18.	DW10	3000X2550	900	2550	3000X2550	2550	DOOR WINDOW
19.	DW11	3000X2550	900	2550	3000X2550	2550	DOOR WINDOW
20.	DW12	3000X2550	900	2550	3000X2550	2550	DOOR WINDOW
21.	DW13	3000X2550	900	2550	3000X2550	2550	DOOR WINDOW
22.	V1	750X1500	1500	-	-	-	DOOR WINDOW

PROJECT TITLE:

EKANA MALL AT
EKANA SPORTZ CITY, LUCKNOW

THIS IS TO CERTIFY THAT THIS BUILDING IS PROPOSED
AS PER THE RULES & REGULATIONS OF MAHARASHTRA.

SIGN OF LANDLORD

SIGN OF ARCHITECT

SCALE-
ISO-A1

1:200

DATE-
06-07-2018

Skyline

architectural consultant pvt. ltd.

architects, engineers, planner

interior design, renovation & repair



Office - 1st & 2nd floor, same varan commercial complex at

patrakar puram crossing gomti nagar, lucknow.

Dial - +91-522-2393123, 2394123, 4044123

E-mail - skyline@usa.net

ARCHITECTS :- SANJAY & VIJAY SINHA

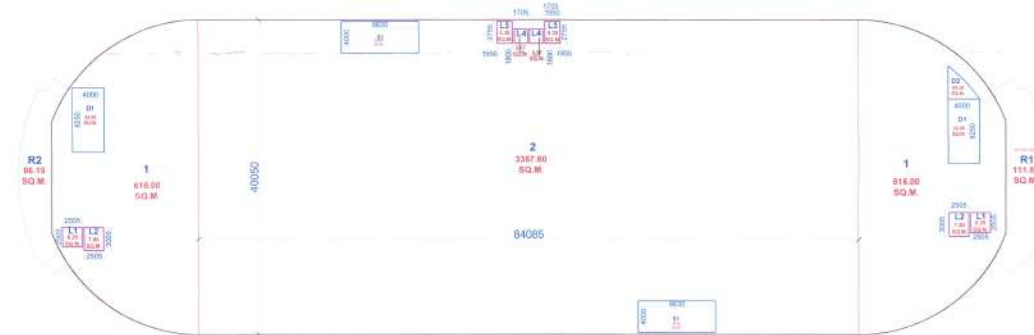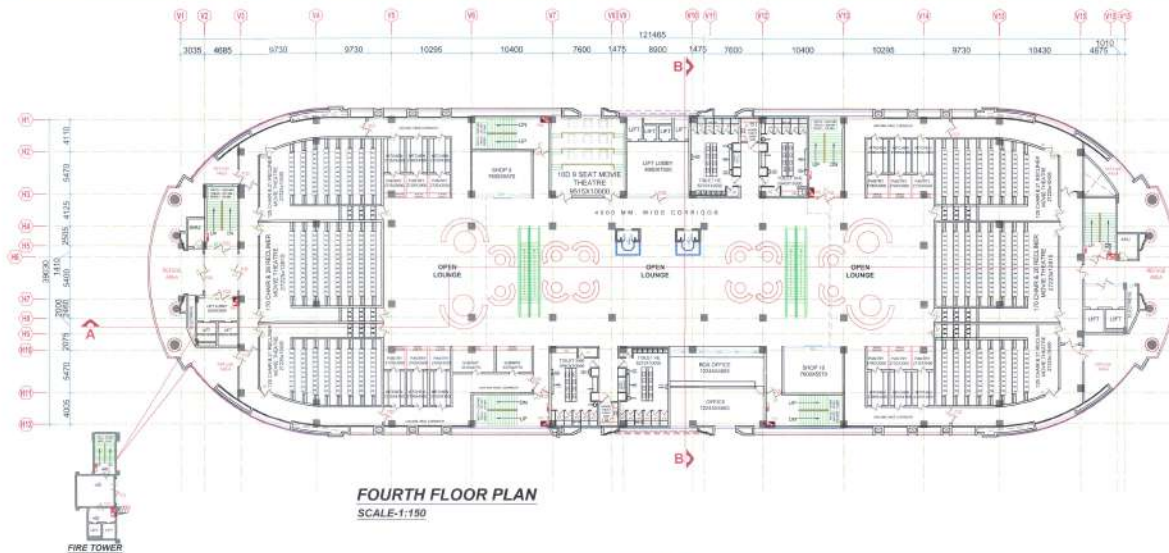

FOURTH FLOOR AREA						
S.NO	DISCRIPTION	SIZE IN MT	SIZE IN MT	AREA	QUANTITY	AREA IN SQMT
PROPOSED BUILDING						
1.0	1	X	X	616.00	2	1232.00
2.0	2	84.085	40.050	3367.60	1	3367.60
3.0	R1	X	X	111.89	1	111.89
4.0	R2	X	X	86.19	1	86.19
AREA A1						4797.68
DUCT & LIFT AREA						
1.0	L1	2.50	2.50	6.25	2	12.50
2.0	L2	2.50	3.00	7.50	2	15.00
3.0	L3	1.95	2.75	5.36	2	10.73
4.0	L4	1.71	1.80	3.07	2	6.14
5.0	D1	4.00	8.25	33.00	2	66.00
6.0	D2	X	X	9.20	1	9.20
7.0	S1	9.83	4.00	39.32	2	78.64
TOTAL AREA						198.20
AREA A1 - DUCT & LIFT AREA						4599.48
TOTAL FOURTH FLOOR AREA						4599.48 SQ.MT.



SUBMISSION DRAWING

NORTH
SHEET NO.
10/17

DOOR / WINDOW SCHEDULE						
S. NO.	TYPE	SIZE	DOOR LEVEL	WINDOW LEVEL	REMARKS	
1.	D1	2000X2500	-	-	2050	DOOR TO ROOM 101
2.	D2	1500X2500	-	-	2050	DOOR TO ROOM 102
3.	D3	1200X2500	-	-	2050	DOOR TO ROOM 103
4.	D4	1000X2500	-	-	2050	DOOR TO ROOM 104
5.	D5	800X2500	-	-	2050	DOOR TO ROOM 105
6.	D6	600X2500	-	-	2100	DOOR TO ROOM 106
7.	D7	400X2500	-	-	2100	DOOR TO ROOM 107
8.	DW1	800X2500	000	2000	2000X2	LIFT SHAFT
9.	DW2	500X2500	000	2000	1500X2	LIFT SHAFT
10.	DW3	400X2500	000	2000	1000X2	LIFT SHAFT
11.	DW4	300X2500	000	2000	500X2	LIFT SHAFT
12.	DW5	200X2500	000	1800	200X2	LIFT SHAFT
13.	DW6	1750X2100	000	1800	750X1	LIFT SHAFT
14.	DW7	2000X2500	-	-	2050	DOOR TO ROOM 108
15.	DW8	1500X2500	-	-	2050	DOOR TO ROOM 109
16.	DW9	1000X2500	-	-	2050	DOOR TO ROOM 110
17.	DW10	800X2500	-	-	2050	DOOR TO ROOM 111
18.	DW11	600X2500	-	-	2050	DOOR TO ROOM 112
19.	DW12	400X2500	-	-	2050	DOOR TO ROOM 113
20.	DW13	300X2500	-	-	2050	DOOR TO ROOM 114
21.	DW14	200X2500	-	-	2050	DOOR TO ROOM 115
22.	W1	750X1500	1500	-	2050	W1

PROJECT TITLE:
EKANA MALL AT
EKANA SPORTZ CITY, LUCKNOW

THIS IS TO CERTIFY THAT THIS BUILDING IS PROPOSED
AS PER THE RULES & REGULATIONS OF MAHANO, JANA 2021.

SIGN OF LANDLORD
SCALE: 1:200
DATE: 06-07-2018

SIGN OF ARCHITECT
SCALE: 1:200
DATE: 06-07-2018



Skyline
architectural consultants pvt. ltd.
architects, engineers, planner
landscape design, interior design, & value
Office: 11th & 12th floor, Iqbal Market, Lucknow.
Dial: +91-522-3393123, 2394123, 4044123
Email: skyline@usaahce.com
ARCHITECTS: SANJAY & VIJAY SINHA



architectural consultant pvt. ltd.
architects, engineers, planners
landscape design, interior design, & value
Office - 2nd & 3rd floor laxmi vardaan commercial complex at
patrakar puram crossing gomtinagar, lucknow.
Dist - +91-522-2393123, 2394123, 4044123
Email id - skyline@usahoc.com
ARCHITECTS - SANJAY & VIJAY SINHA



architectural consultant pvt. ltd.
architects, engineers, planner
landscape design, interior design, & value
Office - 11nd & 11rd floor laami varidan commercial complex at
patrakur puram crossing gomtinagar, lucknow.
Email - +91-522-2393123, 2394123, 4044123
Email Id: skyline@usahc.com
ARCHITECTS - SANJAY & VIJAY SINHA

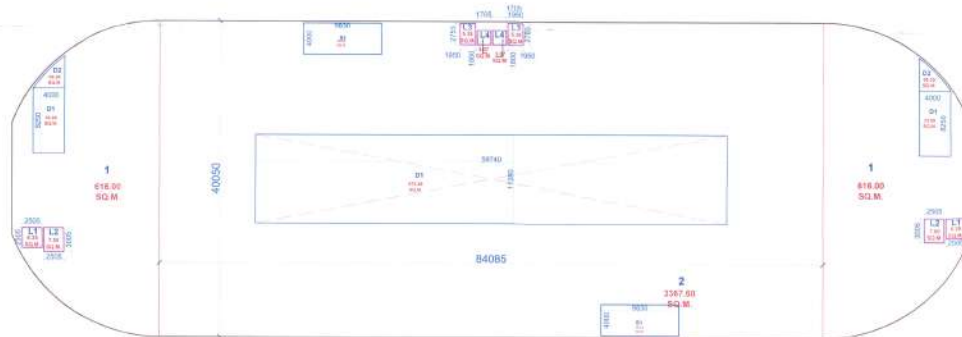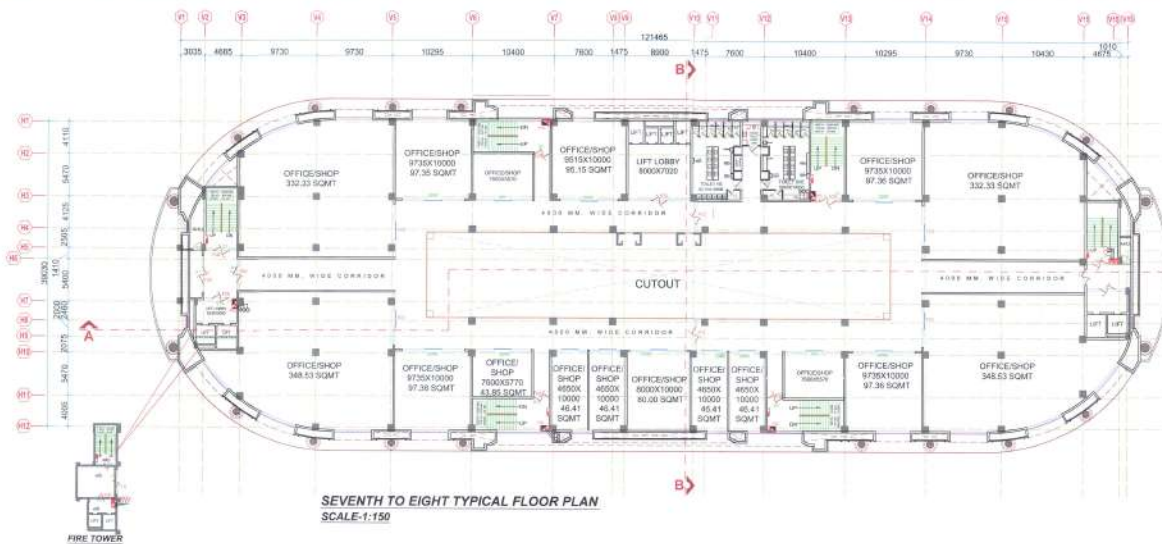

एक वाणिज्यिक इमारत नगर नगर, लखनऊ में स्थित है। इस इमारत का डिजाइन और निर्माण आधुनिक तकनीकों का उपयोग करके किया गया है।



SUBMISSION DRAWING

NORTH

SHEET NO.

14/17

DOOR / WINDOW SCHEDULE

S.NO	TYPE	SIZE	BILL LEVEL	DOOR SIZE	WINDOW SIZE	LINTEL LEVEL	REMARKS
1.	D	3000X2100	-	-	-	2550	MAIN ENTRANCE DOOR
2.	D1	2000X2100	-	-	-	2550	SMALL ENTRANCE DOOR
3.	D2	1500X2100	-	-	-	2550	SMALL ENTRANCE DOOR
4.	D3	1200X2100	-	-	-	2550	SMALL ENTRANCE DOOR
5.	D4	1000X2100	-	-	-	2550	SMALL ENTRANCE DOOR
6.	D5	800X2100	-	-	-	2550	SMALL ENTRANCE DOOR
7.	D6	600X2100	-	-	-	2100	SMALL ENTRANCE DOOR
8.	D7	600X2100	-	-	-	2550	SMALL ENTRANCE DOOR
9.	DW1	3000X2100	900	2000	3000X2	2550	UPPER WINDOW
10.	DW2	3000X2100	900	2000	3000X2	2550	UPPER WINDOW
11.	DW3	4000X2100	900	2000	4000X2	2550	UPPER WINDOW
12.	DW4	3000X2100	900	2000	3000X2	2550	UPPER WINDOW
13.	DW5	3000X2100	900	1000	3000X1	2550	UPPER WINDOW
14.	DW6	1700X2100	900	1000	1700X1	2550	UPPER WINDOW
15.	DW7	2000X2100	-	-	-	2550	UPPER WINDOW
16.	GDW1	10000X2100	-	2000	4000X2	2550	UPPER WINDOW
17.	GDW2	8000X2100	-	2000	3000X2	2550	UPPER WINDOW
18.	GDW3	6000X2100	-	2000	2000X2	2550	UPPER WINDOW
19.	GDW4	4000X2100	-	2000	4000X1	2550	UPPER WINDOW
20.	GDW5	4000X2100	-	1000	1000X2	2550	UPPER WINDOW
21.	SPD1	2000X2100	-	-	-	2550	UPPER WINDOW
22.	V1	7500X1500	1500	-	-	2550	VENT

PROJECT TITLE:

EKANA MALL AT
EKANA SPORTZ CITY, LUCKNOW

THIS IS TO CERTIFY THAT THIS BUILDING IS PROPOSED
AS PER THE RULES & REGULATIONS OF MAHATMA JEE.



SCALE:

SG-A1

1:200

DATE:

06-07-2018

Skyline

architectural consultant pvt. ltd.
architects, engineers, planner
landscape design, interior design, & value
Office - Ind & line floor, interior design, & value
gatrakar, puram, crossing gemini nagar, lucknow,
Dial - +91-22-2393123, 2394123, 4044123
Email id - skyline@usaahcc.com
ARCHITECTS :- SANJAY & VIJAY SINHA

S.NO	DISCRPTION	SIZE IN MT	SIZE IN MT	AREA	QUANTITY	AREA IN SQMT
SEVENTH TO EIGHTH TYPICAL FLOOR AREA						
PROPOSED BUILDING						
1.0	1	X	X	616.00	2	1232.00
2.0	2	84.085	40.050	3367.60	1	3367.60
	AREA A1					4599.60
DUCT & LIFT AREA						
1.0	L1	2.50	2.50	6.25	2	12.50
2.0	L2	2.50	3.00	7.50	2	15.00
3.0	L3	1.95	2.75	5.36	2	10.73
4.0	L4	1.71	1.80	3.07	2	6.14
5.0	D1	4.00	8.25	33.00	2	66.00
6.0	D2	X	X	9.20	2	18.40
7.0	D3	X	X	673.86	1	673.86
8.0	S1	9.83	4.00	39.32	2	78.64
	TOTAL AREA					881.26
	AREA A1 - DUCT & LIFT AREA				(4599.60 - 881.26)	3718.34
	TOTAL SEVENTH FLOOR AREA					3718.34 SQ.MT.
	SEVENTH TO EIGHTH FLOOR AREA				(3718.34 X 2)	7436.68
	TOTAL SEVENTH TO EIGHTH TYPICAL FLOOR AREA					7436.68 SQ.MT.

SUBMISSION DRAWING

NORTH

SHEET NO.

17/17

एक वाणिज्यिक परियोजना के रूप में, एका मल्ल का निर्माण महाराष्ट्र के राजधानी नगर मुंबई में, एका मल्ल के माध्यम से एक वाणिज्यिक के साथ एकीकृत किया गया है कि विकास प्राधिकरण मुंबई विधान सभा के लिए विनिर्दिष्ट क्षेत्र में है।



DOOR / WINDOW SCHEDULE

S. NO.	TYPE	SIZE	DOOR LEVEL	WINDOW LEVEL	REMARKS
1.	D1	3000X2500	-	-	MAIN ENTRANCE DOOR
2.	D1	2000X2500	-	-	FLAT ENTRANCE DOOR
3.	D2	1500X2500	-	-	STAIR DOOR
4.	D3	1200X2500	-	-	STAIR DOOR
5.	D4	1800X2500	-	-	STAIR DOOR
6.	D5	1800X2500	-	-	STAIR DOOR
7.	D6	1800X2500	-	-	STAIR DOOR
8.	D7	1800X2500	-	-	STAIR DOOR
9.	DW1	1800X2500	-	-	STAIR DOOR
10.	DW2	1800X2500	-	-	STAIR DOOR
11.	DW3	1800X2500	-	-	STAIR DOOR
12.	DW4	1800X2500	-	-	STAIR DOOR
13.	DW5	1800X2500	-	-	STAIR DOOR
14.	DW6	1800X2500	-	-	STAIR DOOR
15.	DW7	1800X2500	-	-	STAIR DOOR
16.	DW8	1800X2500	-	-	STAIR DOOR
17.	DW9	1800X2500	-	-	STAIR DOOR
18.	DW10	1800X2500	-	-	STAIR DOOR
19.	DW11	1800X2500	-	-	STAIR DOOR
20.	DW12	1800X2500	-	-	STAIR DOOR
21.	DW13	1800X2500	-	-	STAIR DOOR
22.	DW14	1800X2500	-	-	STAIR DOOR

PROJECT TITLE:

EKANA MALL AT
EKANA SPORTS CITY, LUCKNOW

THIS IS TO CERTIFY THAT THIS BUILDING IS PROPOSED
AS PER THE RULES & REGULATIONS OF MAHARASHTRA 2021.

SIGN OF LAND LORD.



SIGN OF ARCHITECT.



SCALE ISO-A1

DATE: 06-07-2018




architectural consultant pvt. ltd.
architects, engineers, planner
interior design, landscape design, & interior
Office :- 10th floor laxmi vardan commercial complex at
patrakar puram crossing gomtinagar, lucknow,
Dist :- +91-522-2393123, 2394123, 4044123
Email :- skyline@usahcc.com
ARCHITECTS :- SANJAY & VIJAY SINHA



SECTION AT A-A'
SCALE: 1:200



SECTION AT B-B'
SCALE: 1:200

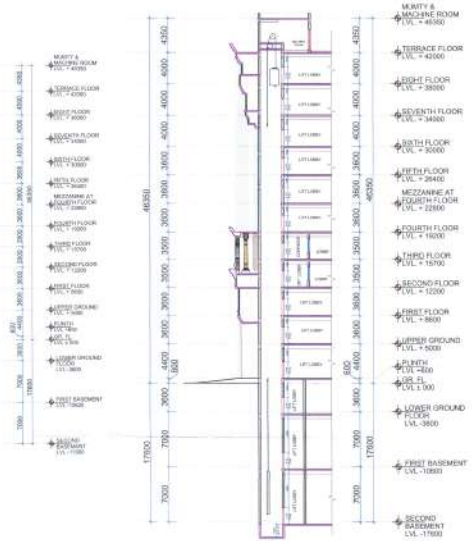

DETAIL OF LIFT
SCALE: 1:200



PLAN OF LIFT
SCALE: 1:200

