


TOTAL SITE AREA									
S.NO.		PARTICULARS				AREA SQ.M			
GRAND TOTAL COVERAGE AREA						888.597			
Exclusions									
	FAR AREA OF UNIT-1	117.093	sq	ft	sq	ft		117.093	
	FAR AREA OF BALCONY OF UNIT-1	4.128	sq	ft	sq	ft		4.128	
	NON-FAR AREA OF BALCONY OF UNIT-1	13.553	sq	ft	sq	ft		13.553	
	FAR AREA OF UNIT-6	108.587	sq	ft	sq	ft		108.587	
	FAR AREA OF BALCONY OF UNIT-6	3.683	sq	ft	sq	ft		3.683	
	NON-FAR AREA OF BALCONY OF UNIT-6	14.421	sq	ft	sq	ft		14.421	
	FAR AREA OF CIRCULATION AND GROUND FLOOR							21.669	
	10% ADDITIONAL JAIL FOR GROUND FLOOR							24.235	
	ENTRANCE LOBBY							24.693	
	NON-FAR AREA OF GROUND FLOOR							13.155	
	INCLUDING SHIP AREA							12.043	
TOTAL								515.044	
TOTAL SITE AREA								151.933	

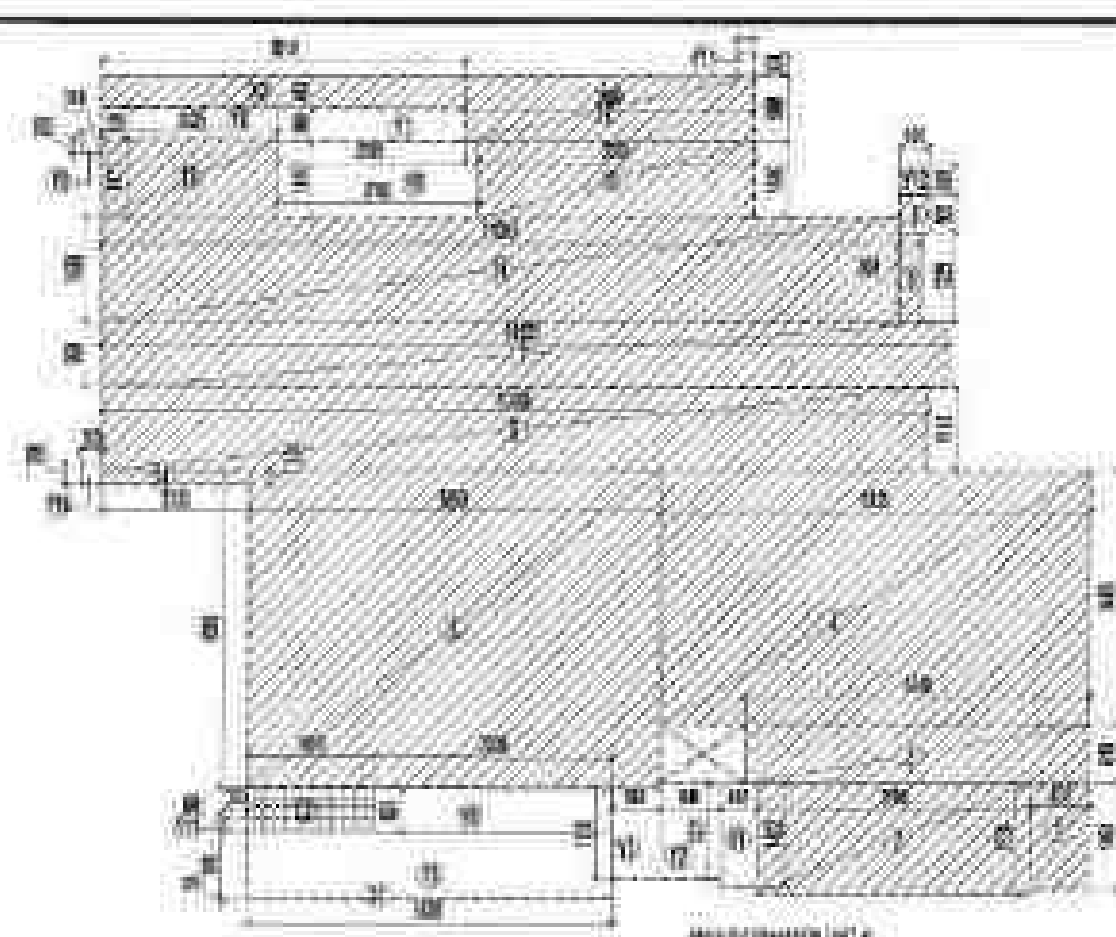

P.A.R. COVERED AREA CALCULATION FOR GROUND FLOOR UNIT: A					
Sl. No.	PARTICULARS				AREA (sq. ft.)
COVERED AREA OF UNIT					
1	0.85	x	3.92	=	3.32
2	3.75	x	3.25	=	12.19
3	4.75	x	3.80	=	18.13
4	3.85	x	3.60	=	13.86
5	3.85	x	3.30	=	12.68
6	11.40	x	3.10	=	35.34
7	11.40	x	3.80	=	43.32
8	2.25	x	3.25	=	7.31
9	0.40	x	0.50	=	0.20
10	11.40	x	4.00	=	45.60
11	3.75	x	1.80	=	6.75
12	0.85	x	0.90	=	0.77
13	3.85	x	1.00	=	3.85
14	1.00	x	0.80	=	0.80
TOTAL AREA: (sq. ft.)					108.56

FURTHER AREA OF BALCONY (B) = (1 + 10) = 11						
91			3.030	x	3.530	= 10.791
92			3.012	x	3.440	= 10.361
(11+10)					x	10.665

TOTAL (B)					0.001
TOTAL F&R AREA FOR UNIT: 8 * F&R AREA * (B SALDOY AREA)					
8	F&R AREA			*	106.54
8	(B SALDOY AREA)			*	0.001
TOTAL					107.55

WIND FLOW AREA OF BALCONY WITH AREA UNIT: m					
71	0.85	0	0.00	0	0.00
72	0.85	X	0.34	0	0.00
73	0.85	0	0.00	0	0.00
74	0.85	0	0.00	0	0.00
75	0.85	0	0.00	0	0.00
76	0.85	X	0.34	0	0.00
77	0.85	0	0.00	0	0.00
78	0.85	0	0.00	0	0.00
79	0.85	0	0.00	0	0.00
80	0.85	X	0.34	0	0.00
81	0.85	0	0.00	0	0.00
TOTAL AREA:					14.424


COVERED AREA OF UNIT 8 = T, A, B AREA + P, A, B AREA OF BALCONY + NON PAV AREA OF BALCONY					
1	F.F.S (Rd)			0	100.567
2	P, A, B AREA OF BALCONY			0	3.065
3	NON PAV AREA OF BALCONY			0	14.421
TOTAL					124.853

FLIGHTSHEET ANALYSIS						
FLY	PERCENTAGE	WIND	WAVE	WAVE	WAVE	WAVE
10	100	0	0	0	0	0
11	100	0	0	0	0	0
12	100	0	0	0	0	0
77	100	0	0	0	0	0

AREA CALCULATION TOWARDS 1% ADDITIONAL F.A.T AT GROUND FLOOR				
S.NO.	PARTICULARS			AREA (SQ.M)
FIRST STAIRCASE AREA				
F1	0.741	X	4.030	= 3.003
F2	0.545	X	3.730	= 2.033
F3	1.420	X	4.500	= 6.390
F4	0.550	X	1.500	= 0.825
F5	0.445	X	3.500	= 1.558
F6	0.620	X	5.400	= 3.348
F7	1.517	X	5.375	= 8.155
F8	1.316	X	2.300	= 3.028
F9	2.724	X	2.500	= 6.810
TOTAL FIRST STAIRCASE AREA				= 45.560

LIFT LIFT						-	
CU			2.40	X	4.80	=	11.680
TOTAL LIFT LIFT AREA						=	11.680
CLIMBERS							
CU			1.80	X	0.80	=	1.440
CU			1.80	X	5.60	=	10.080
TOTAL CLIMBER AREA						=	2.160
MAINTENANCE STONE							
MC			0.90	X	2.60	=	2.340
MC			5.50	X	2.00	=	10.900
MC			5.50	X	4.60	=	10.240

TOTAL AREA (WITH TOWER) =				31.258
WINDY'S TOWER AREA				
W1	4.807	3'	5.700	1.988
W2	5.563	5'	5.281	19.811
W3	8.822	5'	5.620	5.720
TOTAL AREA (WITH TOWER) =				9.519
TOTAL MIN. ADDITIONAL FLOOR AREA FOR SQUARED FLOOR, (A+H)				91.462

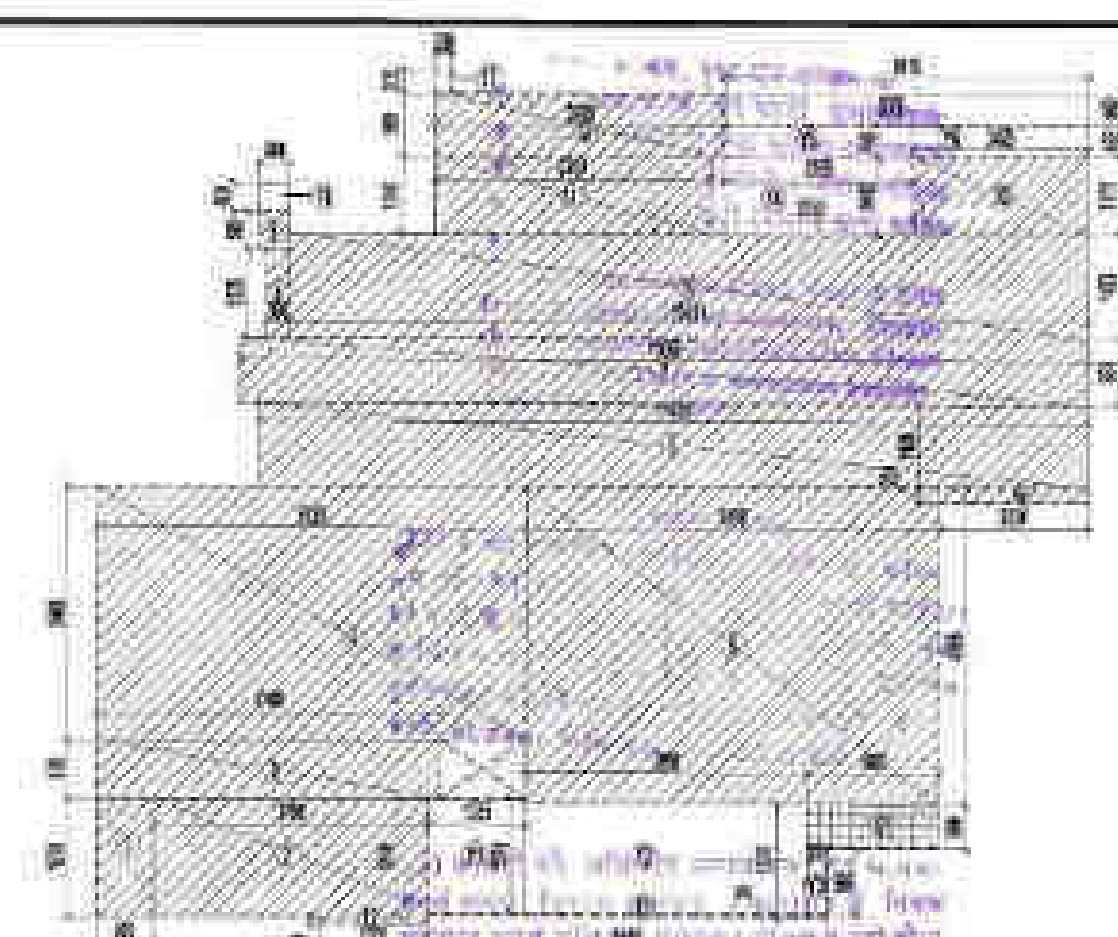

F.L.R. COVERED AREA CALCULATION FOR GROUND FLOOR UNIT - F						
S.NO.	PARTICULARS					AREA (SQ.M)
COVERED AREA OF UNIT						
		0.00	M	0.00	M	0.00
2		2.29	M	1.00	M	3.41
3		0.00	M	0.00	M	0.00
4		2.50	M	1.00	M	3.50
5		0.00	M	0.00	M	0.00
6		1.40	M	0.00	M	1.40
7		1.40	M	0.00	M	1.40
8		0.00	M	0.00	M	0.00
9		0.00	M	0.00	M	0.00
10		0.00	M	0.00	M	0.00
100		0.00	M	0.00	M	0.00
TOTAL AREA (sq. m)						100.00



T-AC model by					T-AC model by	
1	2	3	4	5	6	7
1	2	3	4	5	6	7
1	2	3	4	5	6	7
1	2	3	4	5	6	7

TOTAL (B)					4.125
TOTAL F.A.R. AREA FOR UNIT - 7 = F.A.R. AREA + (B) BRICKVY AREA					1.831
1	F.A.R. AREA				107.043
2	(B) BRICKVY AREA				1.831



MIN. FILL AREA OF SLOPE WITH 1:1.5 H:1 V						100.124
1	1.000	0	1.575	*	3.100	
2	1.000	0	1.000	*	3.075	
3	0.900	0	0.000	*	2.900	
4	1.000	0	1.000	*	3.000	
5	1.000	0	0.000	*	1.000	
6	1.000	0	0.000	*	1.000	
7	0.900	0	0.000	*	0.900	
8	0.900	0	0.000	*	0.900	
(TOTAL AREA)						13.500

CONCRETE AREA OF JOIST (F.F.A.R. AREA - F.F.A.R. AREA OF BALCONY + NON F.F.A.R. AREA OF BALCONY)				
1	F.F.A. AREA		*	197.093
2	F.F.A. AREA OF BALCONY		*	4.126
3	NON F.F.A. AREA OF BALCONY		+	13.531
TOTAL				214.750

F.A.R. COVERED AREA CALCULATION FOR CIRCULATION AT GROUND FLOOR						
SL.NO.	PARTICULARS					AREA, SQ.M.
1	117	X	1.270	=	1.485	
2	280	X	1.465	=	5.697	
3	220	X	1.465	=	6.333	
4	280	X	3.000	=	7.147	
5	3735	X	0.240	=	8.925	
6	3025	X	4.800	=	14.613	
7	6935	X	2.150	=	1.497	
8	1620	X	0.880	=	1.762	
9	2535	X	0.351	=	0.883	
10	2.650	X	3.750	=	10.125	
11	7.725	X	1.140	=	8.797	
12	6.800	X	0.800	=	5.440	
TOTAL CIRCULATION AREA FOR GROUND FLOOR					64.222	

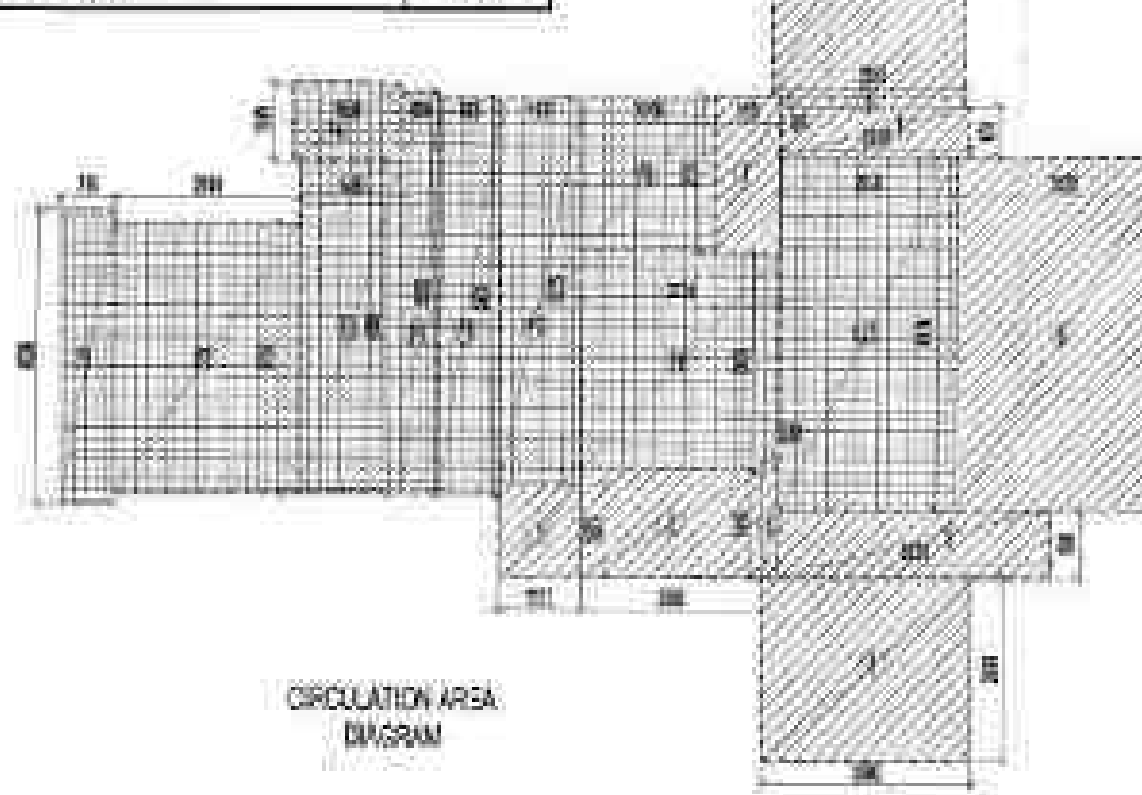
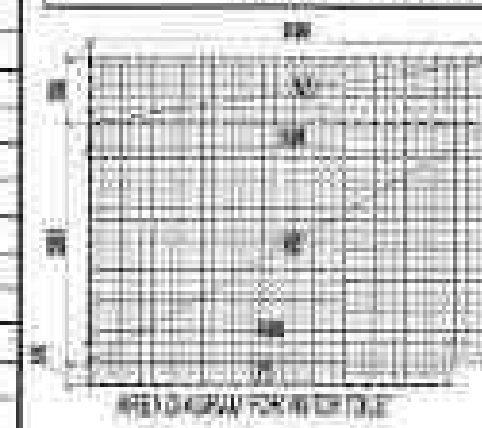


OF GROUND FLOOR						
		7000	X	1340	=	9320
		6800	X	1485	=	10095
					=	19415

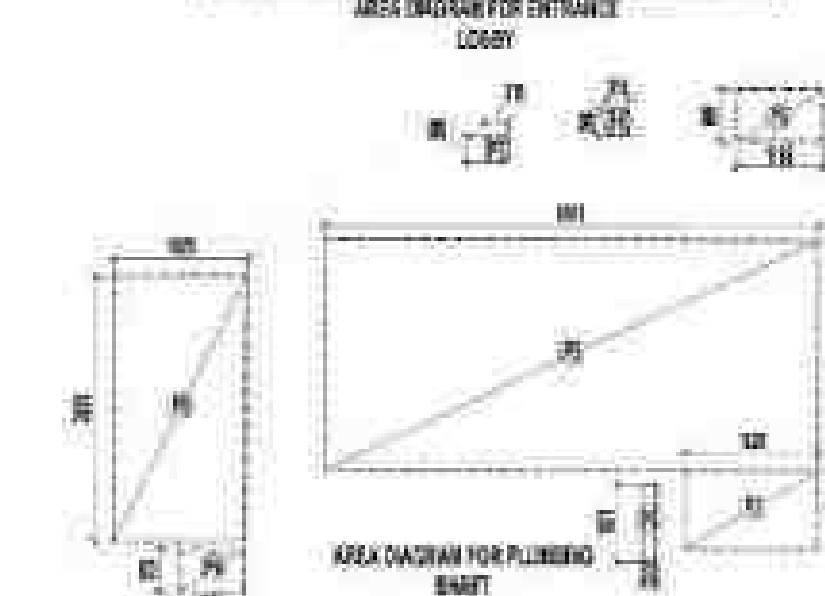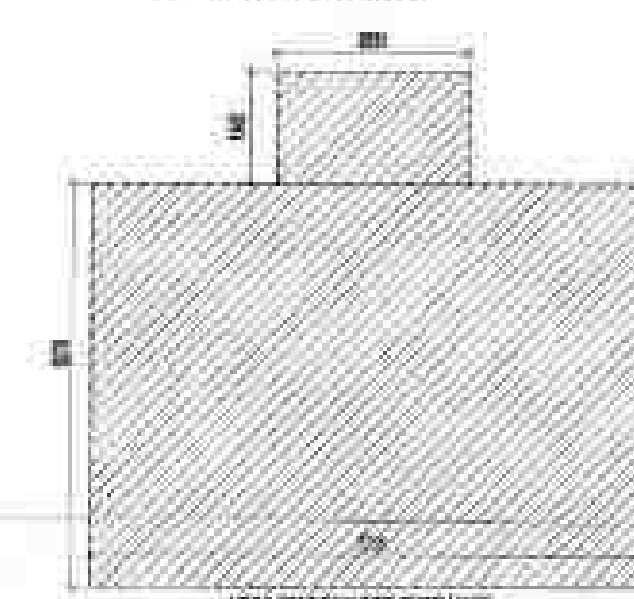


DOUBLE ENTRY TRACT LOG WITH CALCULATION						
DATE	FIELD COLUMNS					WELL ID
1	100	0	100			100
2	101	0	101			101
TOTAL AREA						200

[illegible]

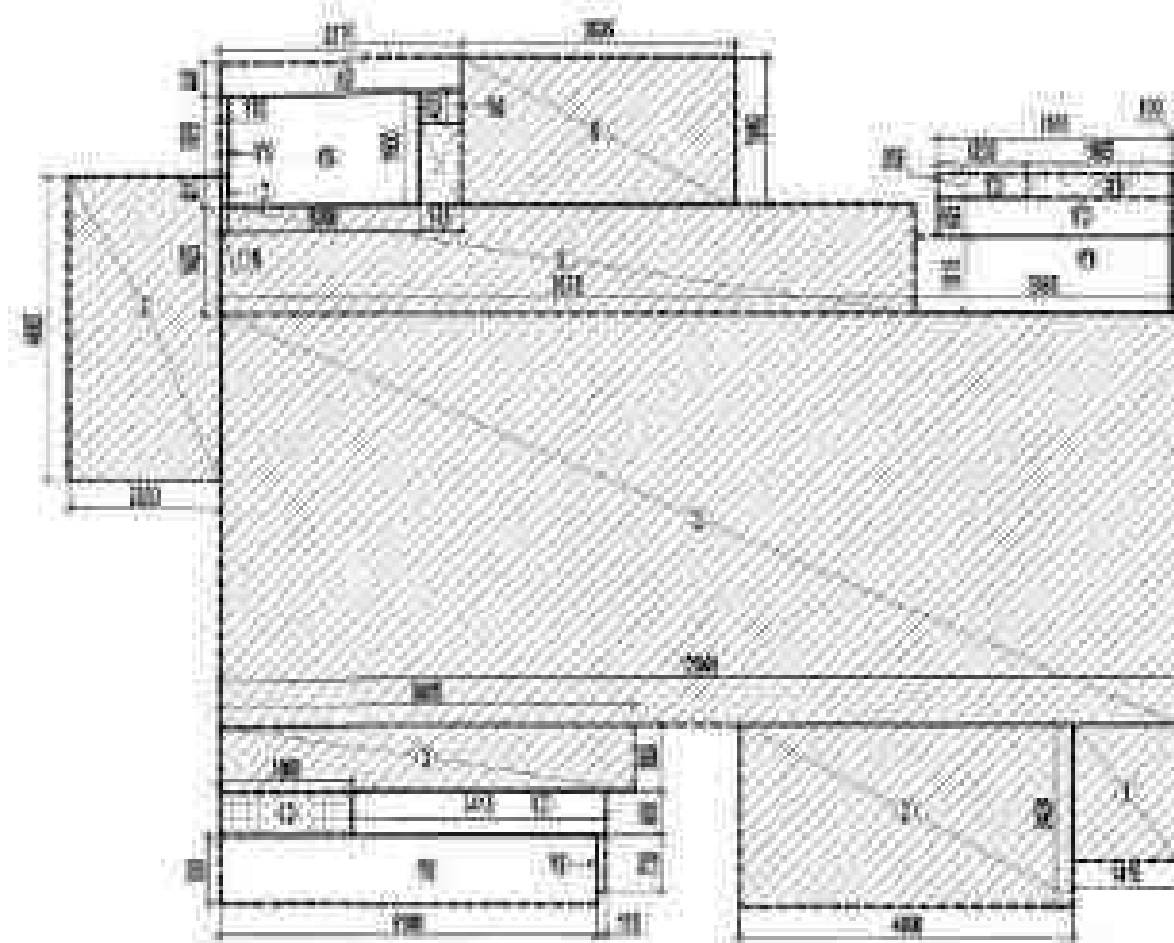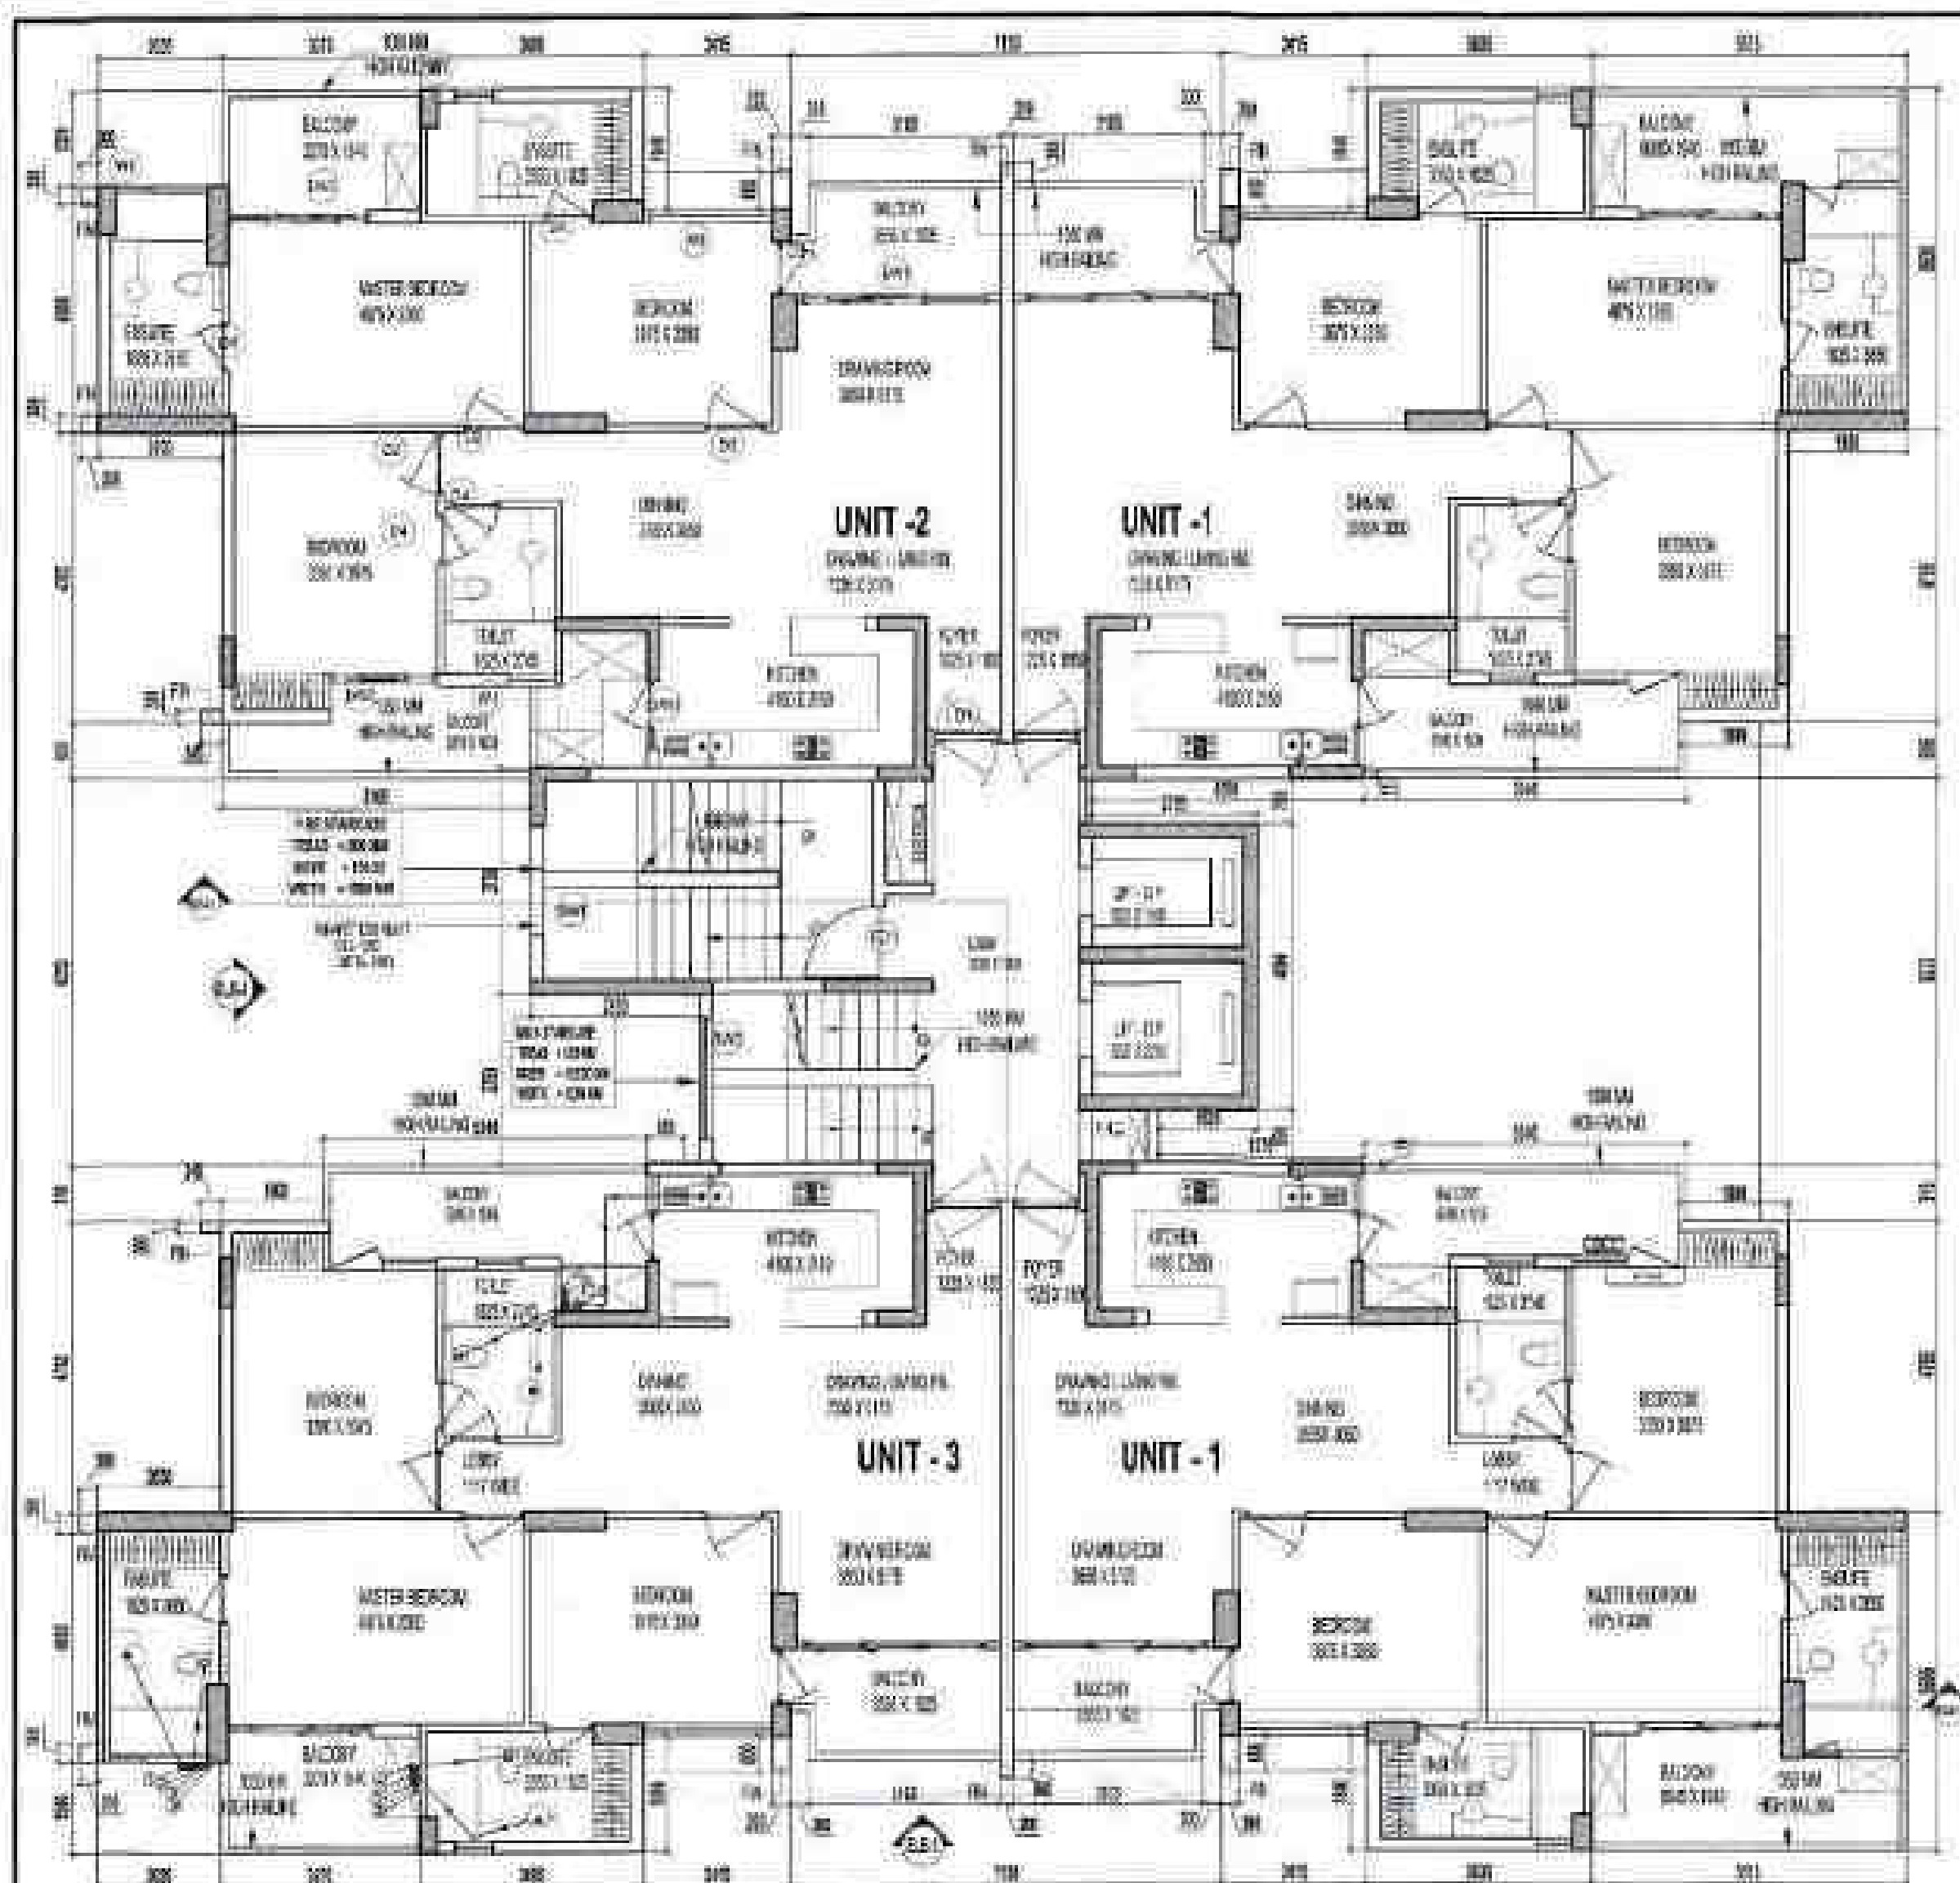

AREA DIAGRAM FOR UNIT 2

S.NO.	PARTICULARS	AREA (SQ.M)
1	COVERED AREA OF UNIT	118.883
2	F.A.R. AREA OF UNIT	118.883
3	F.A.R. AREA OF BALCONY	0.510
4	TOTAL F.A.R. AREA FOR UNIT 2	119.393

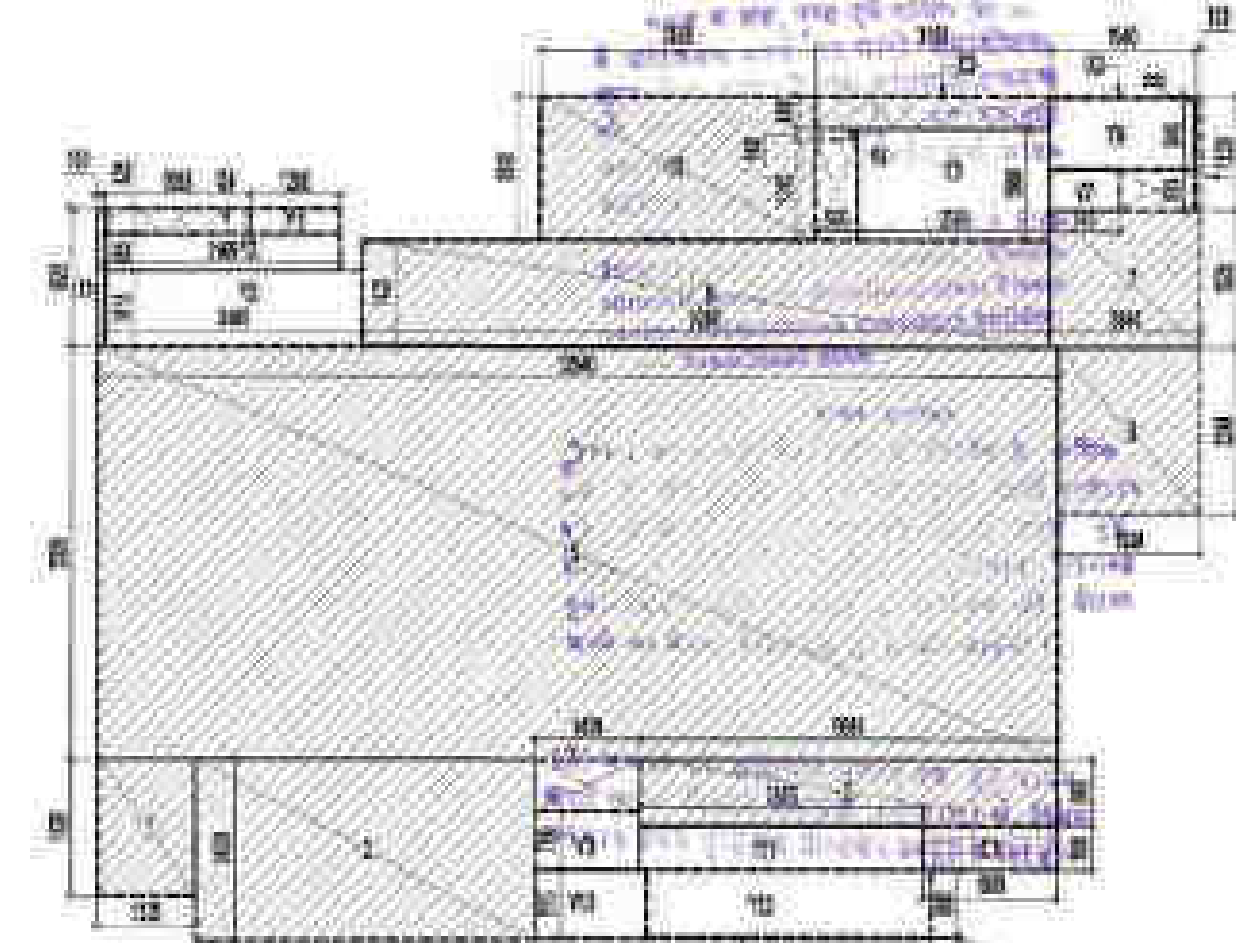

AREA DIAGRAM FOR UNIT 1

S.NO.	PARTICULARS	AREA (SQ.M)
1	COVERED AREA OF UNIT	118.883
2	F.A.R. AREA OF UNIT	118.883
3	F.A.R. AREA OF BALCONY	0.510
4	TOTAL F.A.R. AREA FOR UNIT 1	119.393

F.A.R. COVERED AREA CALCULATION FOR UNIT 2

S.NO.	PARTICULARS	AREA (SQ.M)
1	COVERED AREA OF UNIT	118.883
2	F.A.R. AREA OF UNIT	118.883
3	F.A.R. AREA OF BALCONY	0.510
4	TOTAL F.A.R. AREA FOR UNIT 2	119.393

TOTAL F.A.R. AREA AT TYPICAL FLOOR

S.NO.	PARTICULARS	AREA (SQ.M)
1	F.A.R. AREA OF UNIT 1	118.883
2	F.A.R. AREA OF UNIT 2	118.883
3	F.A.R. AREA OF BALCONY	0.510
4	TOTAL F.A.R. AREA	238.276

COVERED AREA OF UNIT 2 + F.A.R. AREA OF UNIT 2 + F.A.R. AREA OF BALCONY + NON F.A.R. AREA OF BALCONY

S.NO.	PARTICULARS	AREA (SQ.M)
1	F.A.R. AREA	118.883
2	NON F.A.R. AREA OF BALCONY	0.510
3	TOTAL F.A.R. AREA	119.393

F.A.R. AREA OF BALCONY (S1 + S2 + S3)

S.NO.	PARTICULARS	AREA (SQ.M)
1	F.A.R. AREA	118.883
2	NON F.A.R. AREA OF BALCONY	0.510
3	TOTAL F.A.R. AREA	119.393

TOTAL F.A.R. AREA FOR UNIT 2 + F.A.R. AREA OF BALCONY + NON F.A.R. AREA OF BALCONY


S.NO.	PARTICULARS	AREA (SQ.M)
1	F.A.R. AREA	118.883
2	NON F.A.R. AREA OF BALCONY	0.510
3	TOTAL F.A.R. AREA	119.393

NON F.A.R. AREA OF BALCONY UNIT 3

S.NO.	PARTICULARS	AREA (SQ.M)
1	F.A.R. AREA	118.883
2	NON F.A.R. AREA OF BALCONY	0.510
3	TOTAL F.A.R. AREA	119.393

COVERED AREA OF UNIT 2 + F.A.R. AREA OF UNIT 2 + F.A.R. AREA OF BALCONY + NON F.A.R. AREA OF BALCONY

S.NO.	PARTICULARS	AREA (SQ.M)
1	F.A.R. AREA	118.883
2	NON F.A.R. AREA OF BALCONY	0.510
3	TOTAL F.A.R. AREA	119.393

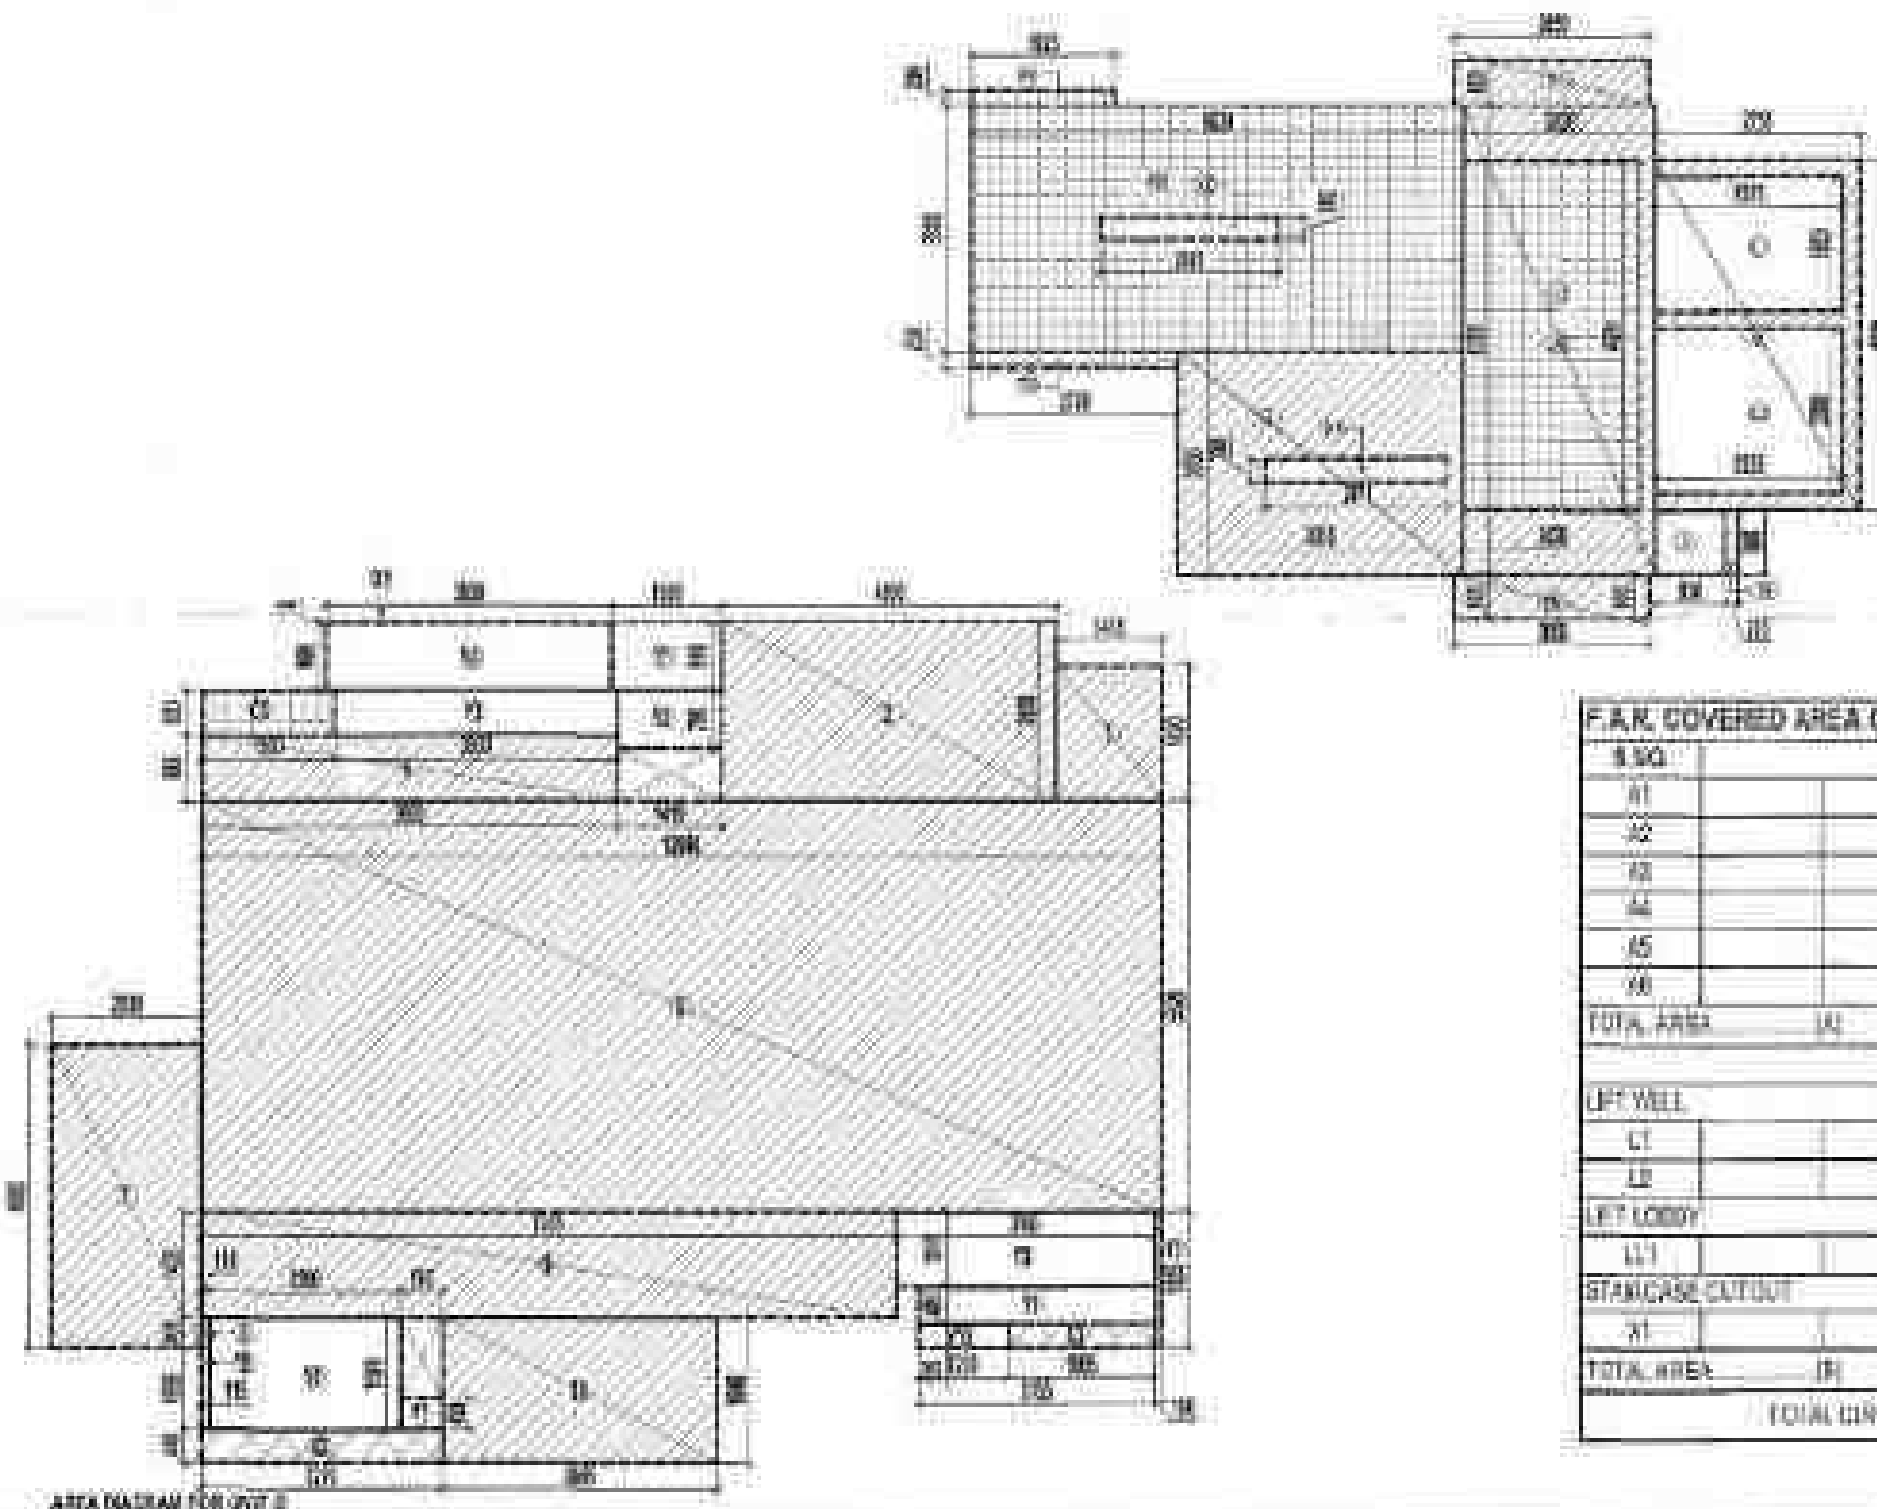

F.A.R. COVERED AREA CALCULATION FOR CIRCULATION AT TYPICAL FLOOR

S.NO.	PARTICULARS	AREA (SQ.M)
1	COVERED AREA OF UNIT	118.883
2	F.A.R. AREA OF UNIT	118.883
3	F.A.R. AREA OF BALCONY	0.510
4	TOTAL F.A.R. AREA FOR UNIT 3	119.393

AREA CALCULATION TOWARDS 15% ADDITIONAL F.A.R. AT TYPICAL FLOOR

S.NO.	PARTICULARS	AREA (SQ.M)
1	COVERED AREA OF UNIT	118.883
2	F.A.R. AREA OF UNIT	118.883
3	F.A.R. AREA OF BALCONY	0.510
4	TOTAL F.A.R. AREA FOR UNIT 3	119.393

THIS DRAWING IS A "CONCEPT" drawing of the proposed project. It is not a final drawing and is not to be used for construction without the approval of the authority.

GENERAL NOTES:
1. ALL DIMENSIONS ARE TO FACE UNLESS OTHERWISE SPECIFIED.
2. THE DIMENSIONS OF THE BUILDING ARE TO BE TAKEN FROM THE EXTERIOR FACE OF THE WALLS.
3. THE DIMENSIONS OF THE BUILDING ARE TO BE TAKEN FROM THE EXTERIOR FACE OF THE WALLS.

SCHEDULE OF OPENINGS

S.NO.	ITEM	QTY	UNIT	REMARKS
1	DOOR	1	NO	DOOR
2	WINDOW	1	NO	WINDOW
3	ROOF	1	NO	ROOF
4	WALL	1	NO	WALL
5	FLOOR	1	NO	FLOOR
6	CEILING	1	NO	CEILING
7	STAIR	1	NO	STAIR
8	ELECTRICAL	1	NO	ELECTRICAL
9	PLUMBING	1	NO	PLUMBING
10	PAINT	1	NO	PAINT
11	ROOFING	1	NO	ROOFING
12	GLAZING	1	NO	GLAZING
13	IRONING	1	NO	IRONING
14	WATER	1	NO	WATER
15	SEWER	1	NO	SEWER
16	WIND	1	NO	WIND
17	WIND	1	NO	WIND
18	WIND	1	NO	WIND
19	WIND	1	NO	WIND
20	WIND	1	NO	WIND

AREA LEGEND:

AREA	DESCRIPTION
1	DOOR
2	WINDOW
3	ROOF
4	WALL
5	FLOOR
6	CEILING
7	STAIR
8	ELECTRICAL
9	PLUMBING
10	PAINT
11	ROOFING
12	GLAZING
13	IRONING
14	WATER
15	SEWER
16	WIND
17	WIND
18	WIND
19	WIND
20	WIND

SUBMISSION DRAWING

DATE: 10/10/2023

IV COUNTY PVT. LTD.

PROJECT: TOWER-B1, B2, B3, B4, B5, B6

OWNER: IV COUNTY PVT. LTD.

ARCHITECT: IV COUNTY PVT. LTD.

TOWN PLANNER: IV COUNTY PVT. LTD.



TOWN PLANNER SIGN: [Signature]

TOWN PLANNER: IV COUNTY PVT. LTD.

CONFORMANCE


8-021

This drawing is not to be used for construction without the approval of the authority.

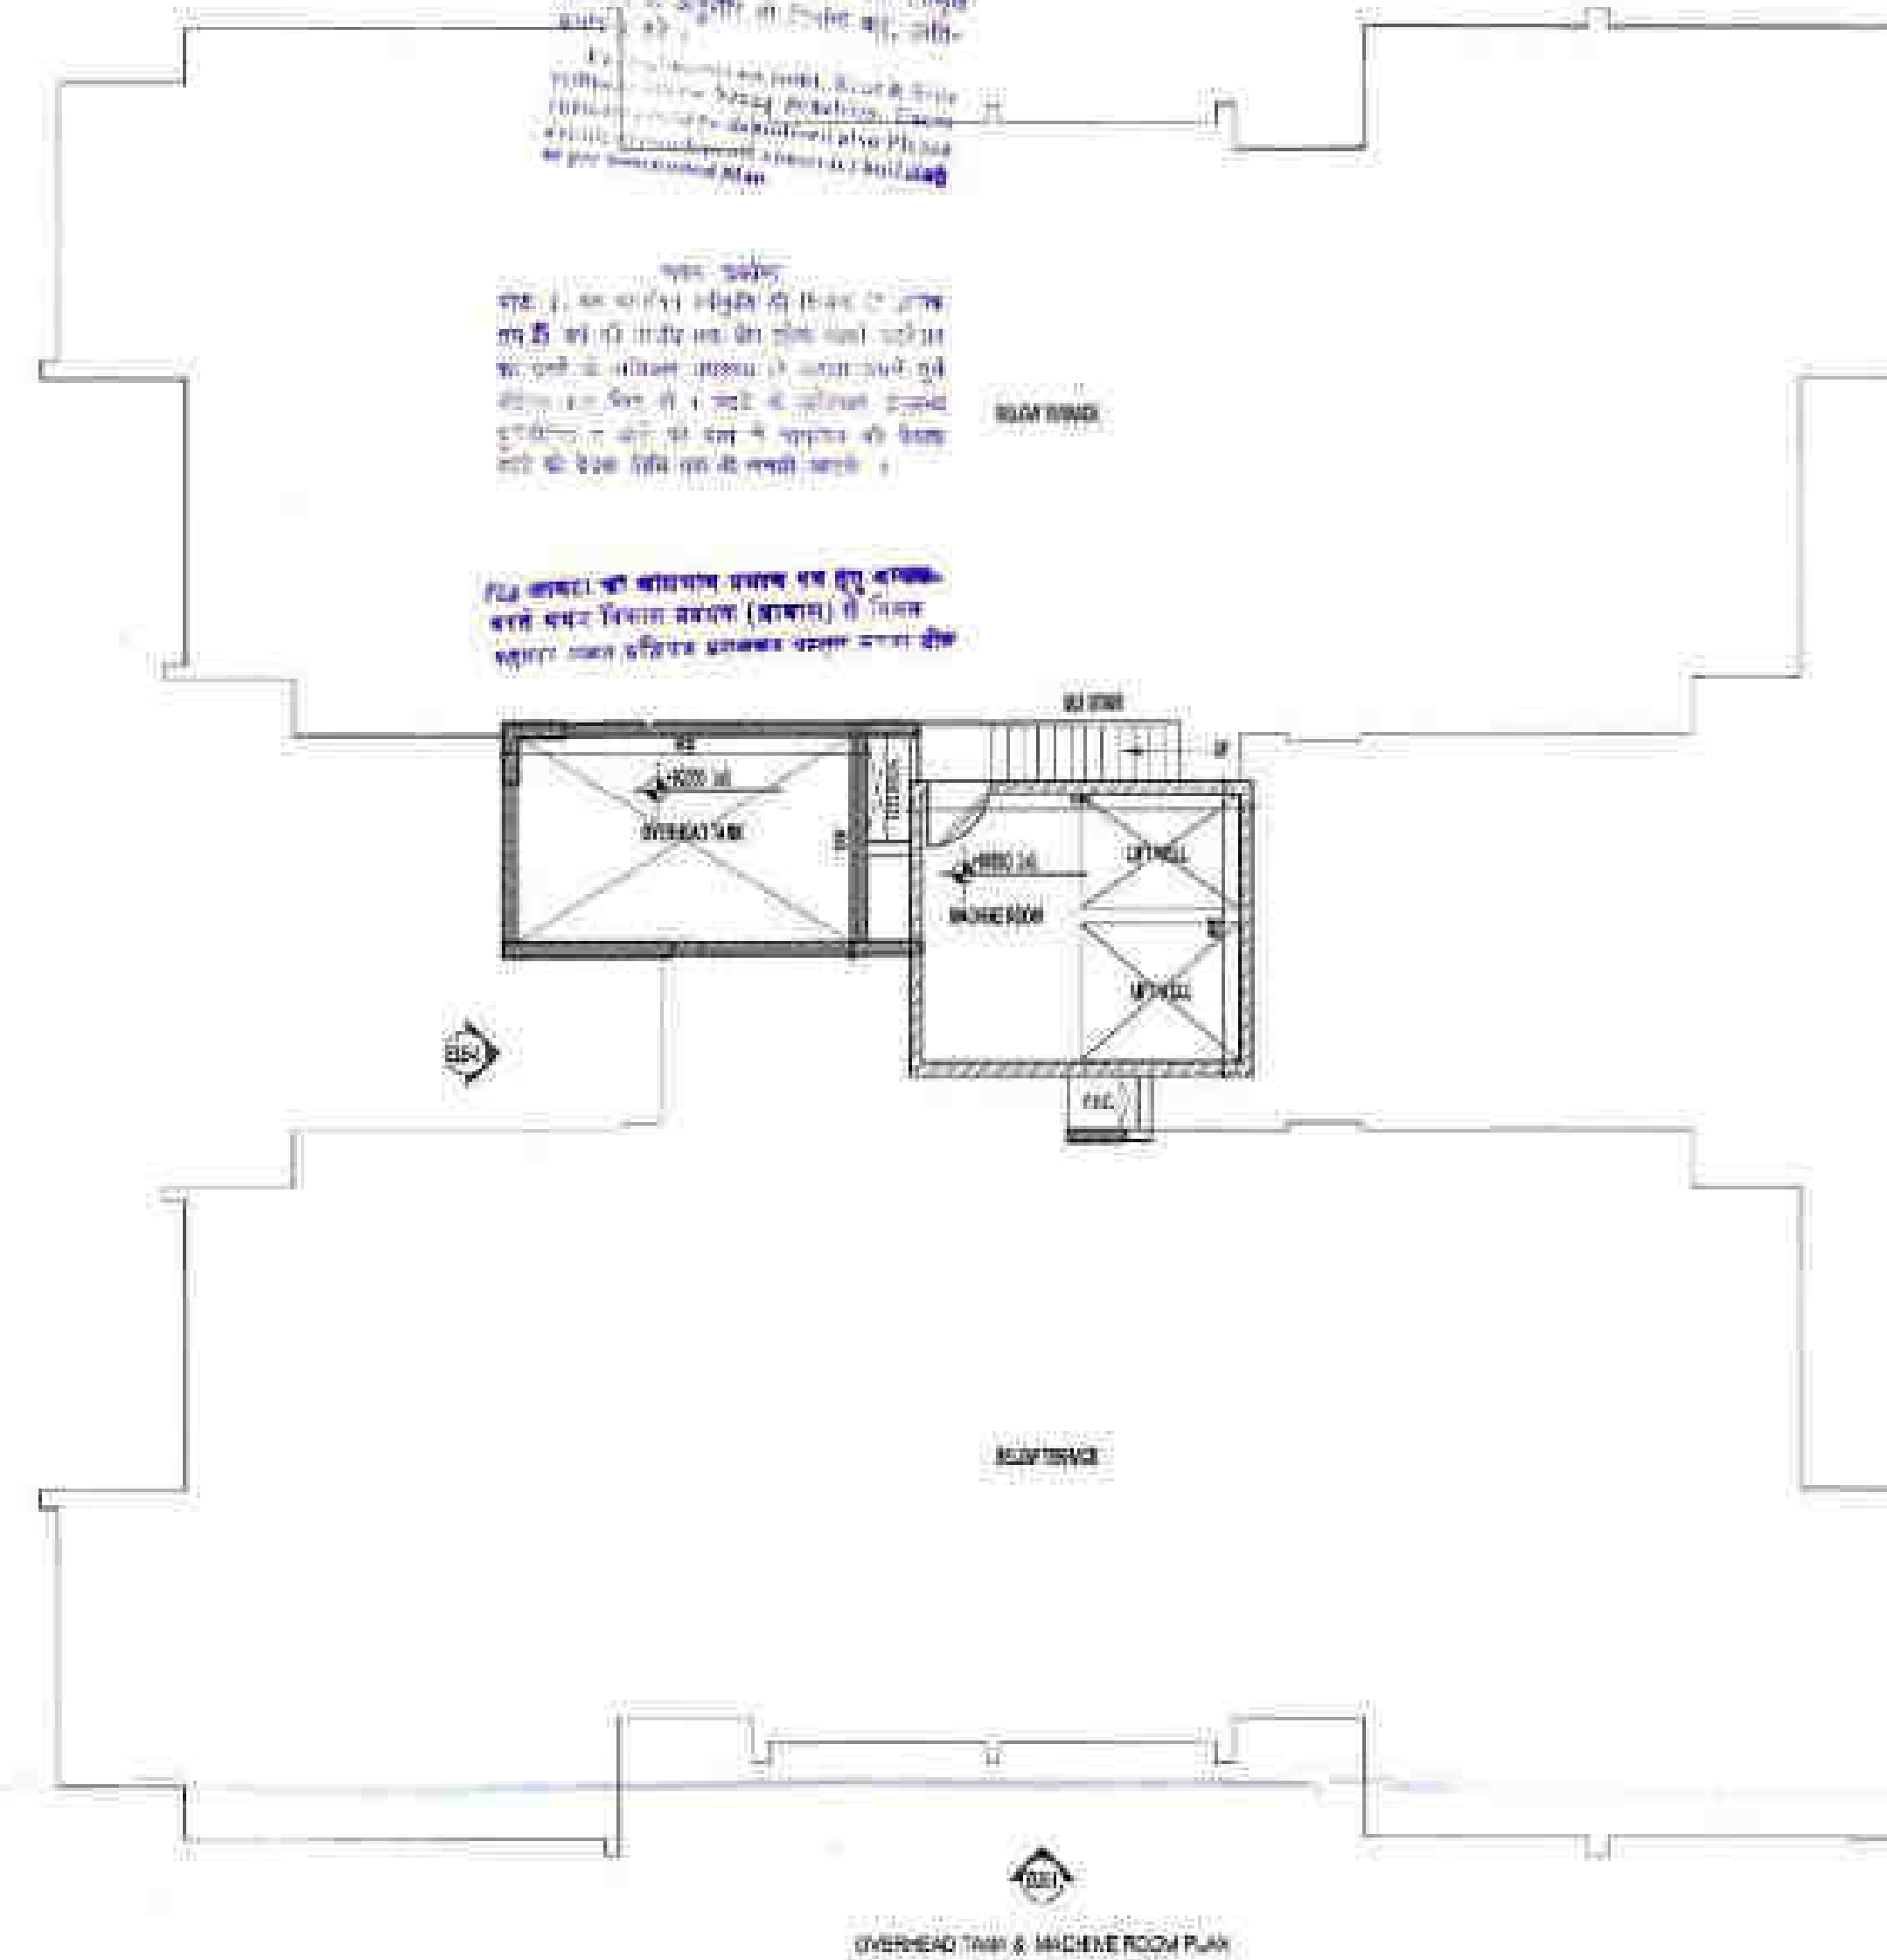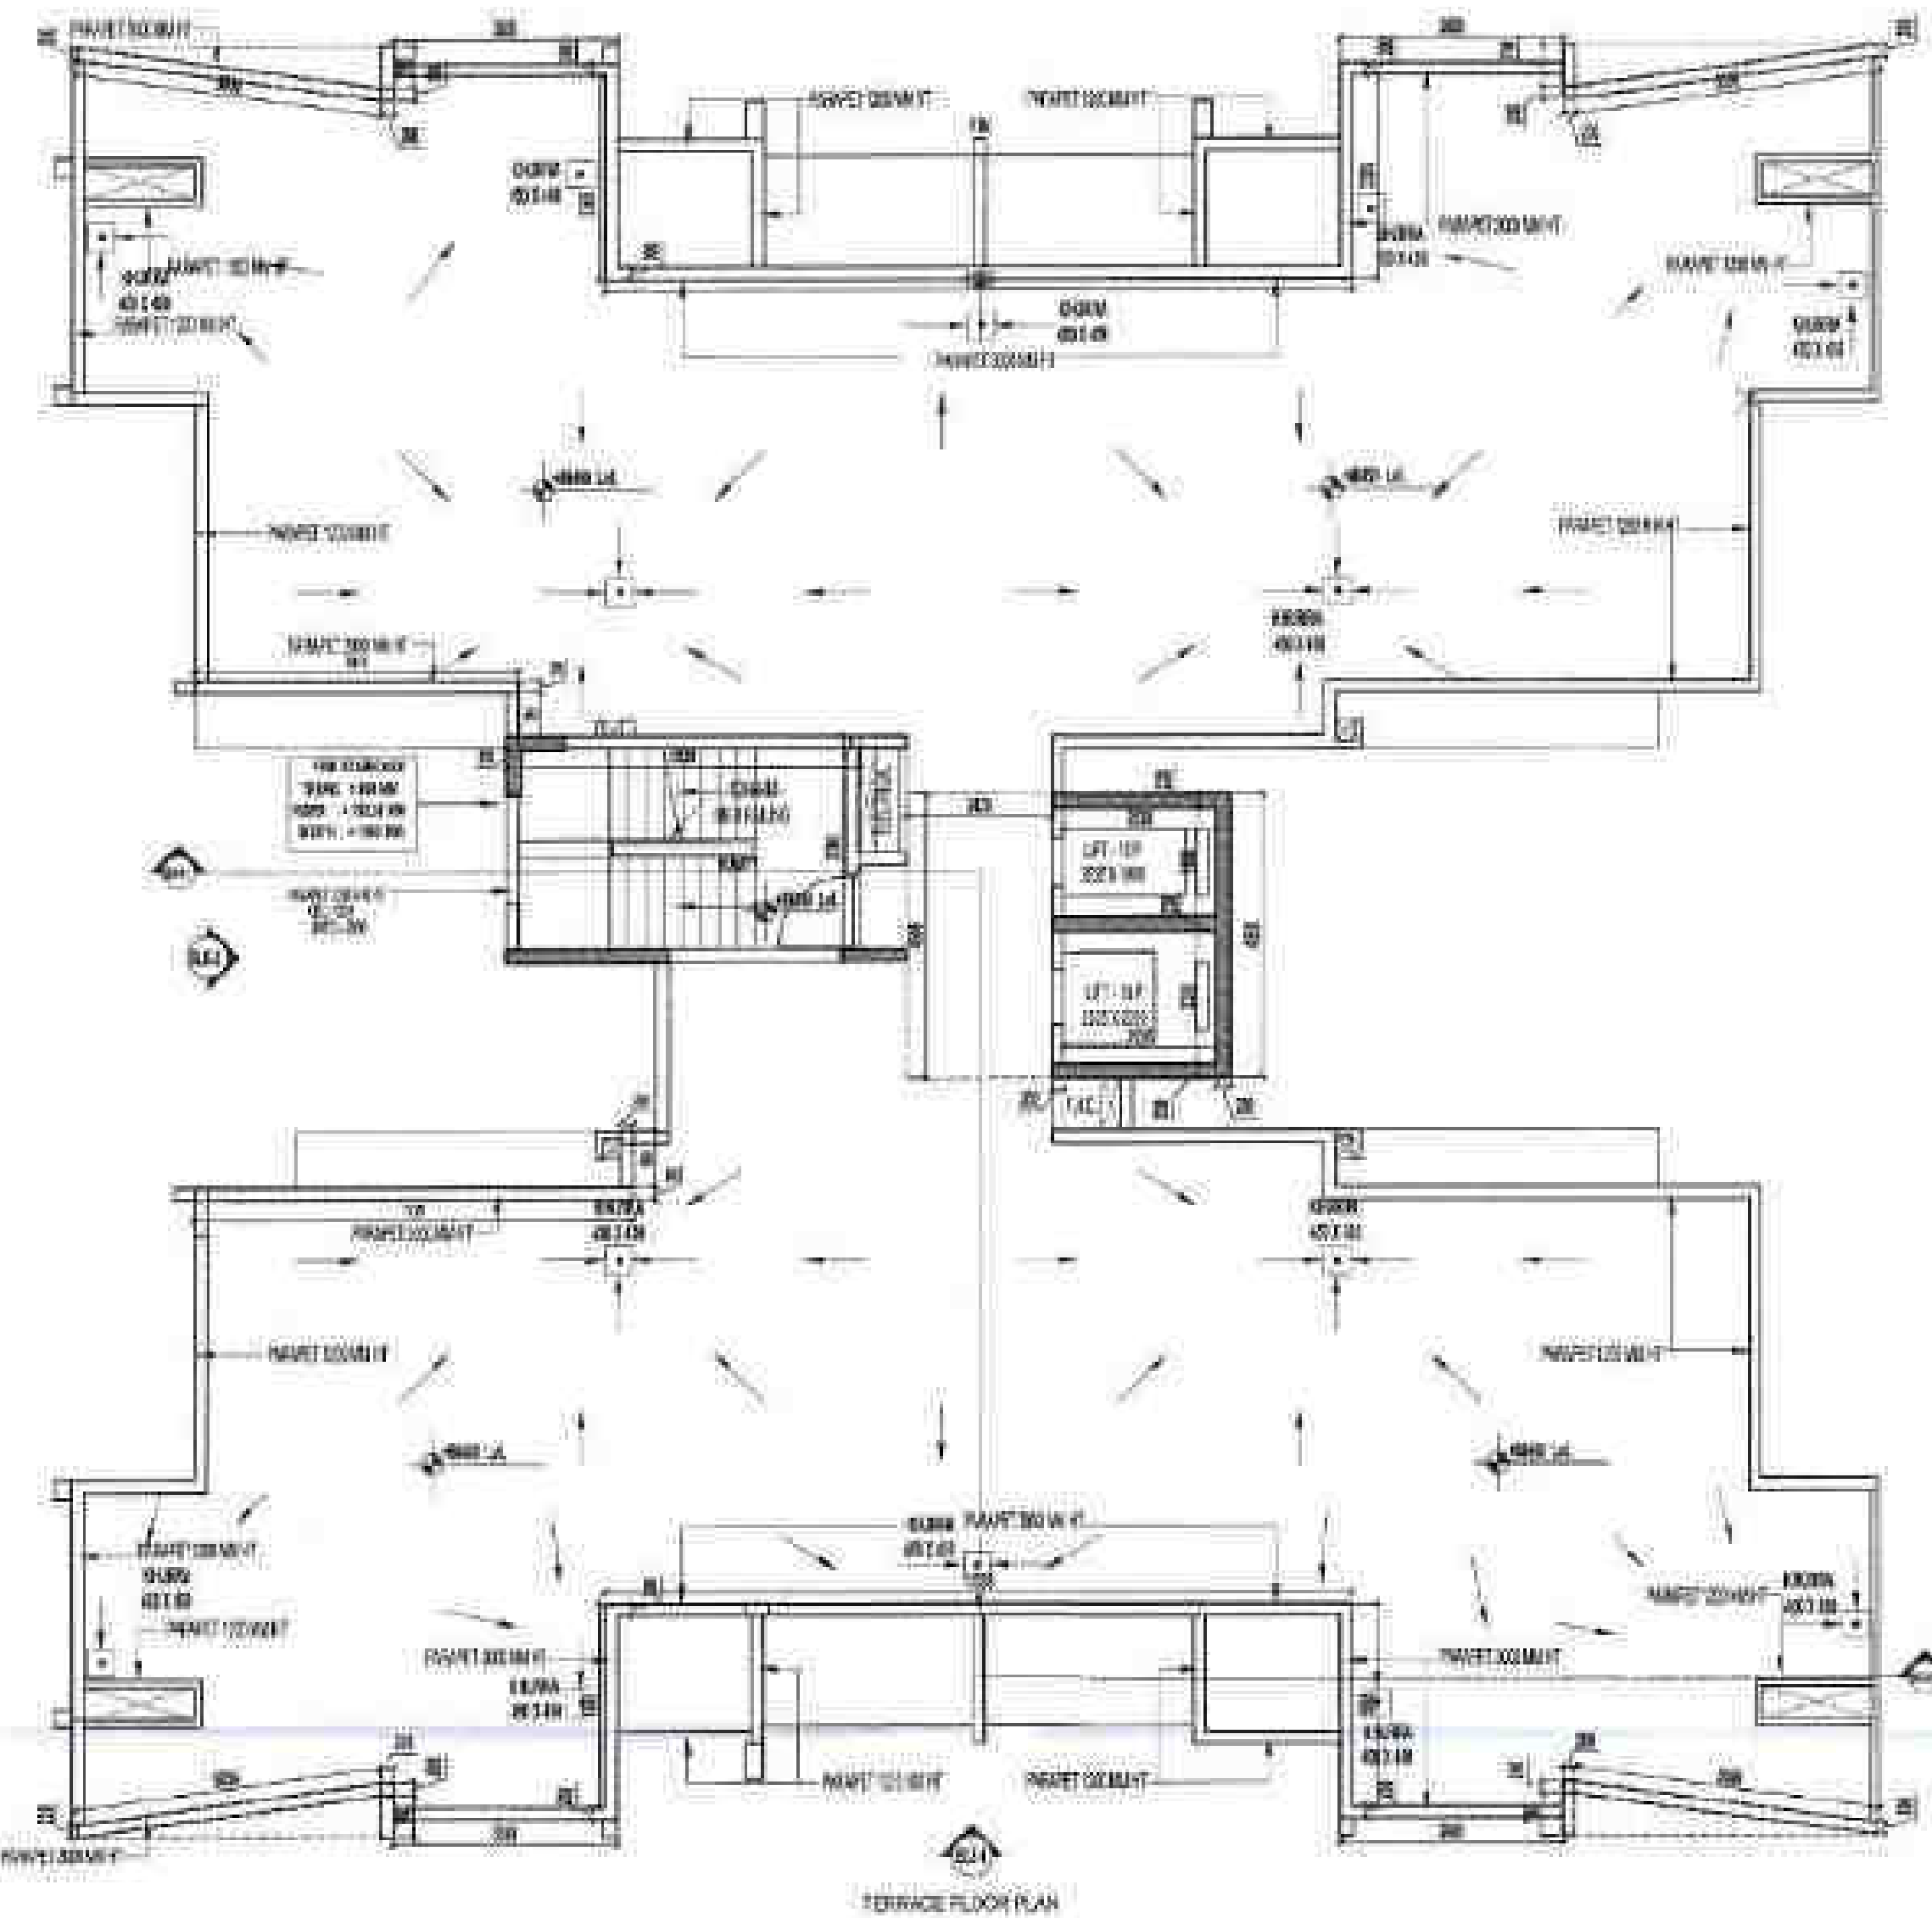

TOTAL F.A.R. AREA OF TERRACE FLOOR PLAN = CIRCULATION LOBBY + PARAPET WALL
= 1.79 + 18.19
= 19.98 SQM

S.NO.	PARTICULARS	AREA (SQ.M)
TERRACE LIFT LOBBY AREA		
1	2 X 0.018 X 0.300	0.002
2	2 X 0.024 X 0.300	0.008
3	2 X 0.028 X 0.700	0.039
4	2 X 0.028 X 0.080	0.004
5	2 X 0.028 X 0.300	0.004
6	2 X 0.028 X 0.300	0.004
7	2 X 0.028 X 0.300	0.004
8	2 X 0.028 X 0.300	0.004
9	2 X 0.028 X 0.300	0.004
10	2 X 0.028 X 0.300	0.004
11	2 X 0.028 X 0.300	0.004
12	2 X 0.028 X 0.300	0.004
13	2 X 0.028 X 0.300	0.004
14	2 X 0.028 X 0.300	0.004
15	2 X 0.028 X 0.300	0.004
TOTAL AREA		0.039

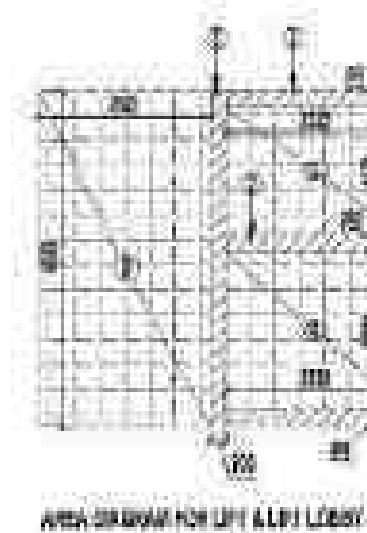


S.NO.	PARTICULARS	AREA (SQ.M)
TERRACE LIFT LOBBY AREA		
1	2 X 0.028 X 0.300	0.004
2	2 X 0.028 X 0.300	0.004
3	2 X 0.028 X 0.300	0.004
TOTAL F.A.R. AREA		0.012

S.NO.	PARTICULARS	AREA (SQ.M)
TERRACE LIFT LOBBY AREA & FIRE STAIRCASE		
A	2 X 0.028 X 0.300	0.004
B	2 X 0.028 X 0.300	0.004
C	2 X 0.028 X 0.300	0.004
TOTAL AREA		0.012

S.NO.	PARTICULARS	AREA (SQ.M)
TERRACE LIFT LOBBY AREA & FIRE STAIRCASE		
A	2 X 0.028 X 0.300	0.004
B	2 X 0.028 X 0.300	0.004
C	2 X 0.028 X 0.300	0.004
TOTAL AREA		0.012

TOTAL F.A.R. AREA OF TERRACE FLOOR PLAN = 1.79 SQM

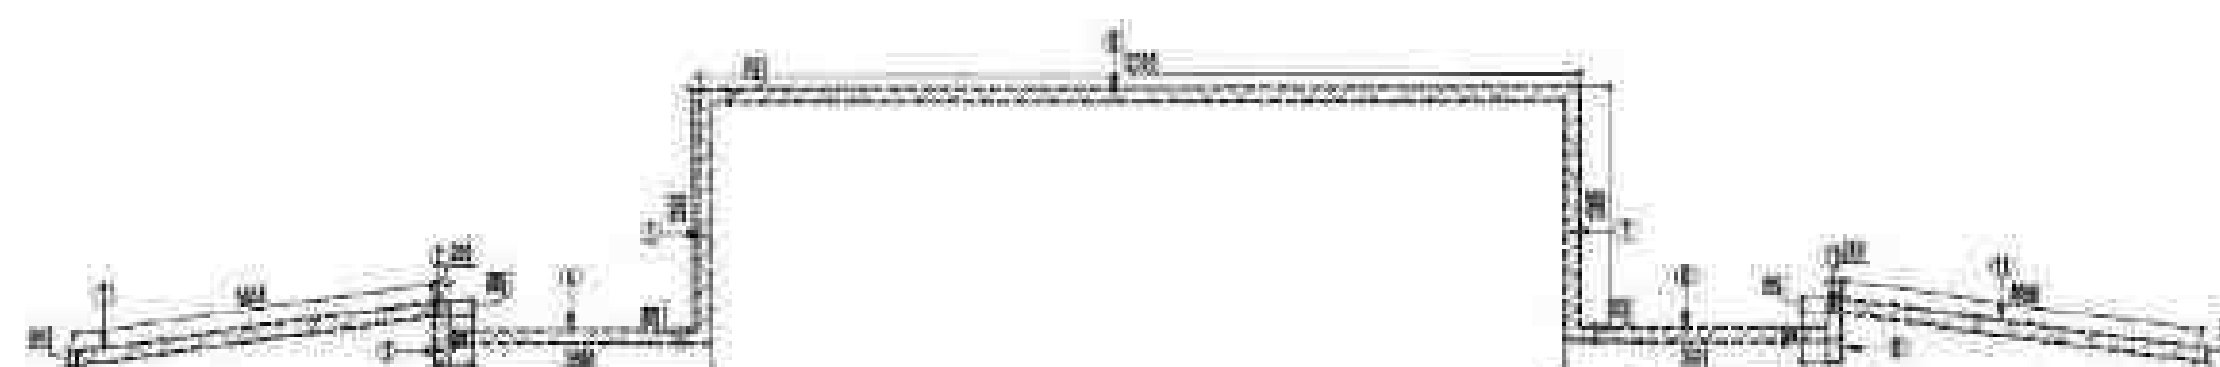

IV COUNTY PVT. LTD.

PROPOSED GROUP HOUSING FOR IV COUNTY PVT. LTD. AT PLOT NO. 131-132-133-134-135, MOH. 1, P.

PROJECT: IV COUNTY PVT. LTD.

DATE: 10/10/2023

SCALE: 1:100

DESIGNER: CIVIL ENGINEER

CHECKED: CIVIL ENGINEER

APPROVED: CIVIL ENGINEER

TOWN PLANNER SIGN: _____

TOWN PLANNER: _____

CONTRACTOR: _____

DATE: 10/10/2023

5-022

SUBMISSION DRAWING

TERRACE FLOOR PLAN

TOWER-B1, B2, B3, B4, B5, B6

IV COUNTY PVT. LTD.

Antarctica Signatory

CONTRACTOR

DATE: 10/10/2023

5-022

SCHEDULE OF OPENINGS


S.NO.	TYPE	WIDTH	HEIGHT	AREA	UNIT	REMARKS
1	DOOR	0.900	2.100	1.890	SQ.M	DOORWAY
2	DOOR	0.900	2.100	1.890	SQ.M	DOORWAY
3	DOOR	0.900	2.100	1.890	SQ.M	DOORWAY
4	DOOR	0.900	2.100	1.890	SQ.M	DOORWAY
5	DOOR	0.900	2.100	1.890	SQ.M	DOORWAY
6	DOOR	0.900	2.100	1.890	SQ.M	DOORWAY
7	DOOR	0.900	2.100	1.890	SQ.M	DOORWAY
8	DOOR	0.900	2.100	1.890	SQ.M	DOORWAY
9	DOOR	0.900	2.100	1.890	SQ.M	DOORWAY
10	DOOR	0.900	2.100	1.890	SQ.M	DOORWAY

SCHEDULE OF OPENINGS FOR COMMON AREAS

S.NO.	TYPE	WIDTH	HEIGHT	AREA	UNIT	REMARKS
1	DOOR	0.900	2.100	1.890	SQ.M	DOORWAY
2	DOOR	0.900	2.100	1.890	SQ.M	DOORWAY
3	DOOR	0.900	2.100	1.890	SQ.M	DOORWAY

AREA LEGEND

SYMBOL	DESCRIPTION
1	DOOR
2	WINDOW
3	DOOR
4	WINDOW
5	DOOR
6	WINDOW
7	DOOR
8	WINDOW
9	DOOR
10	WINDOW

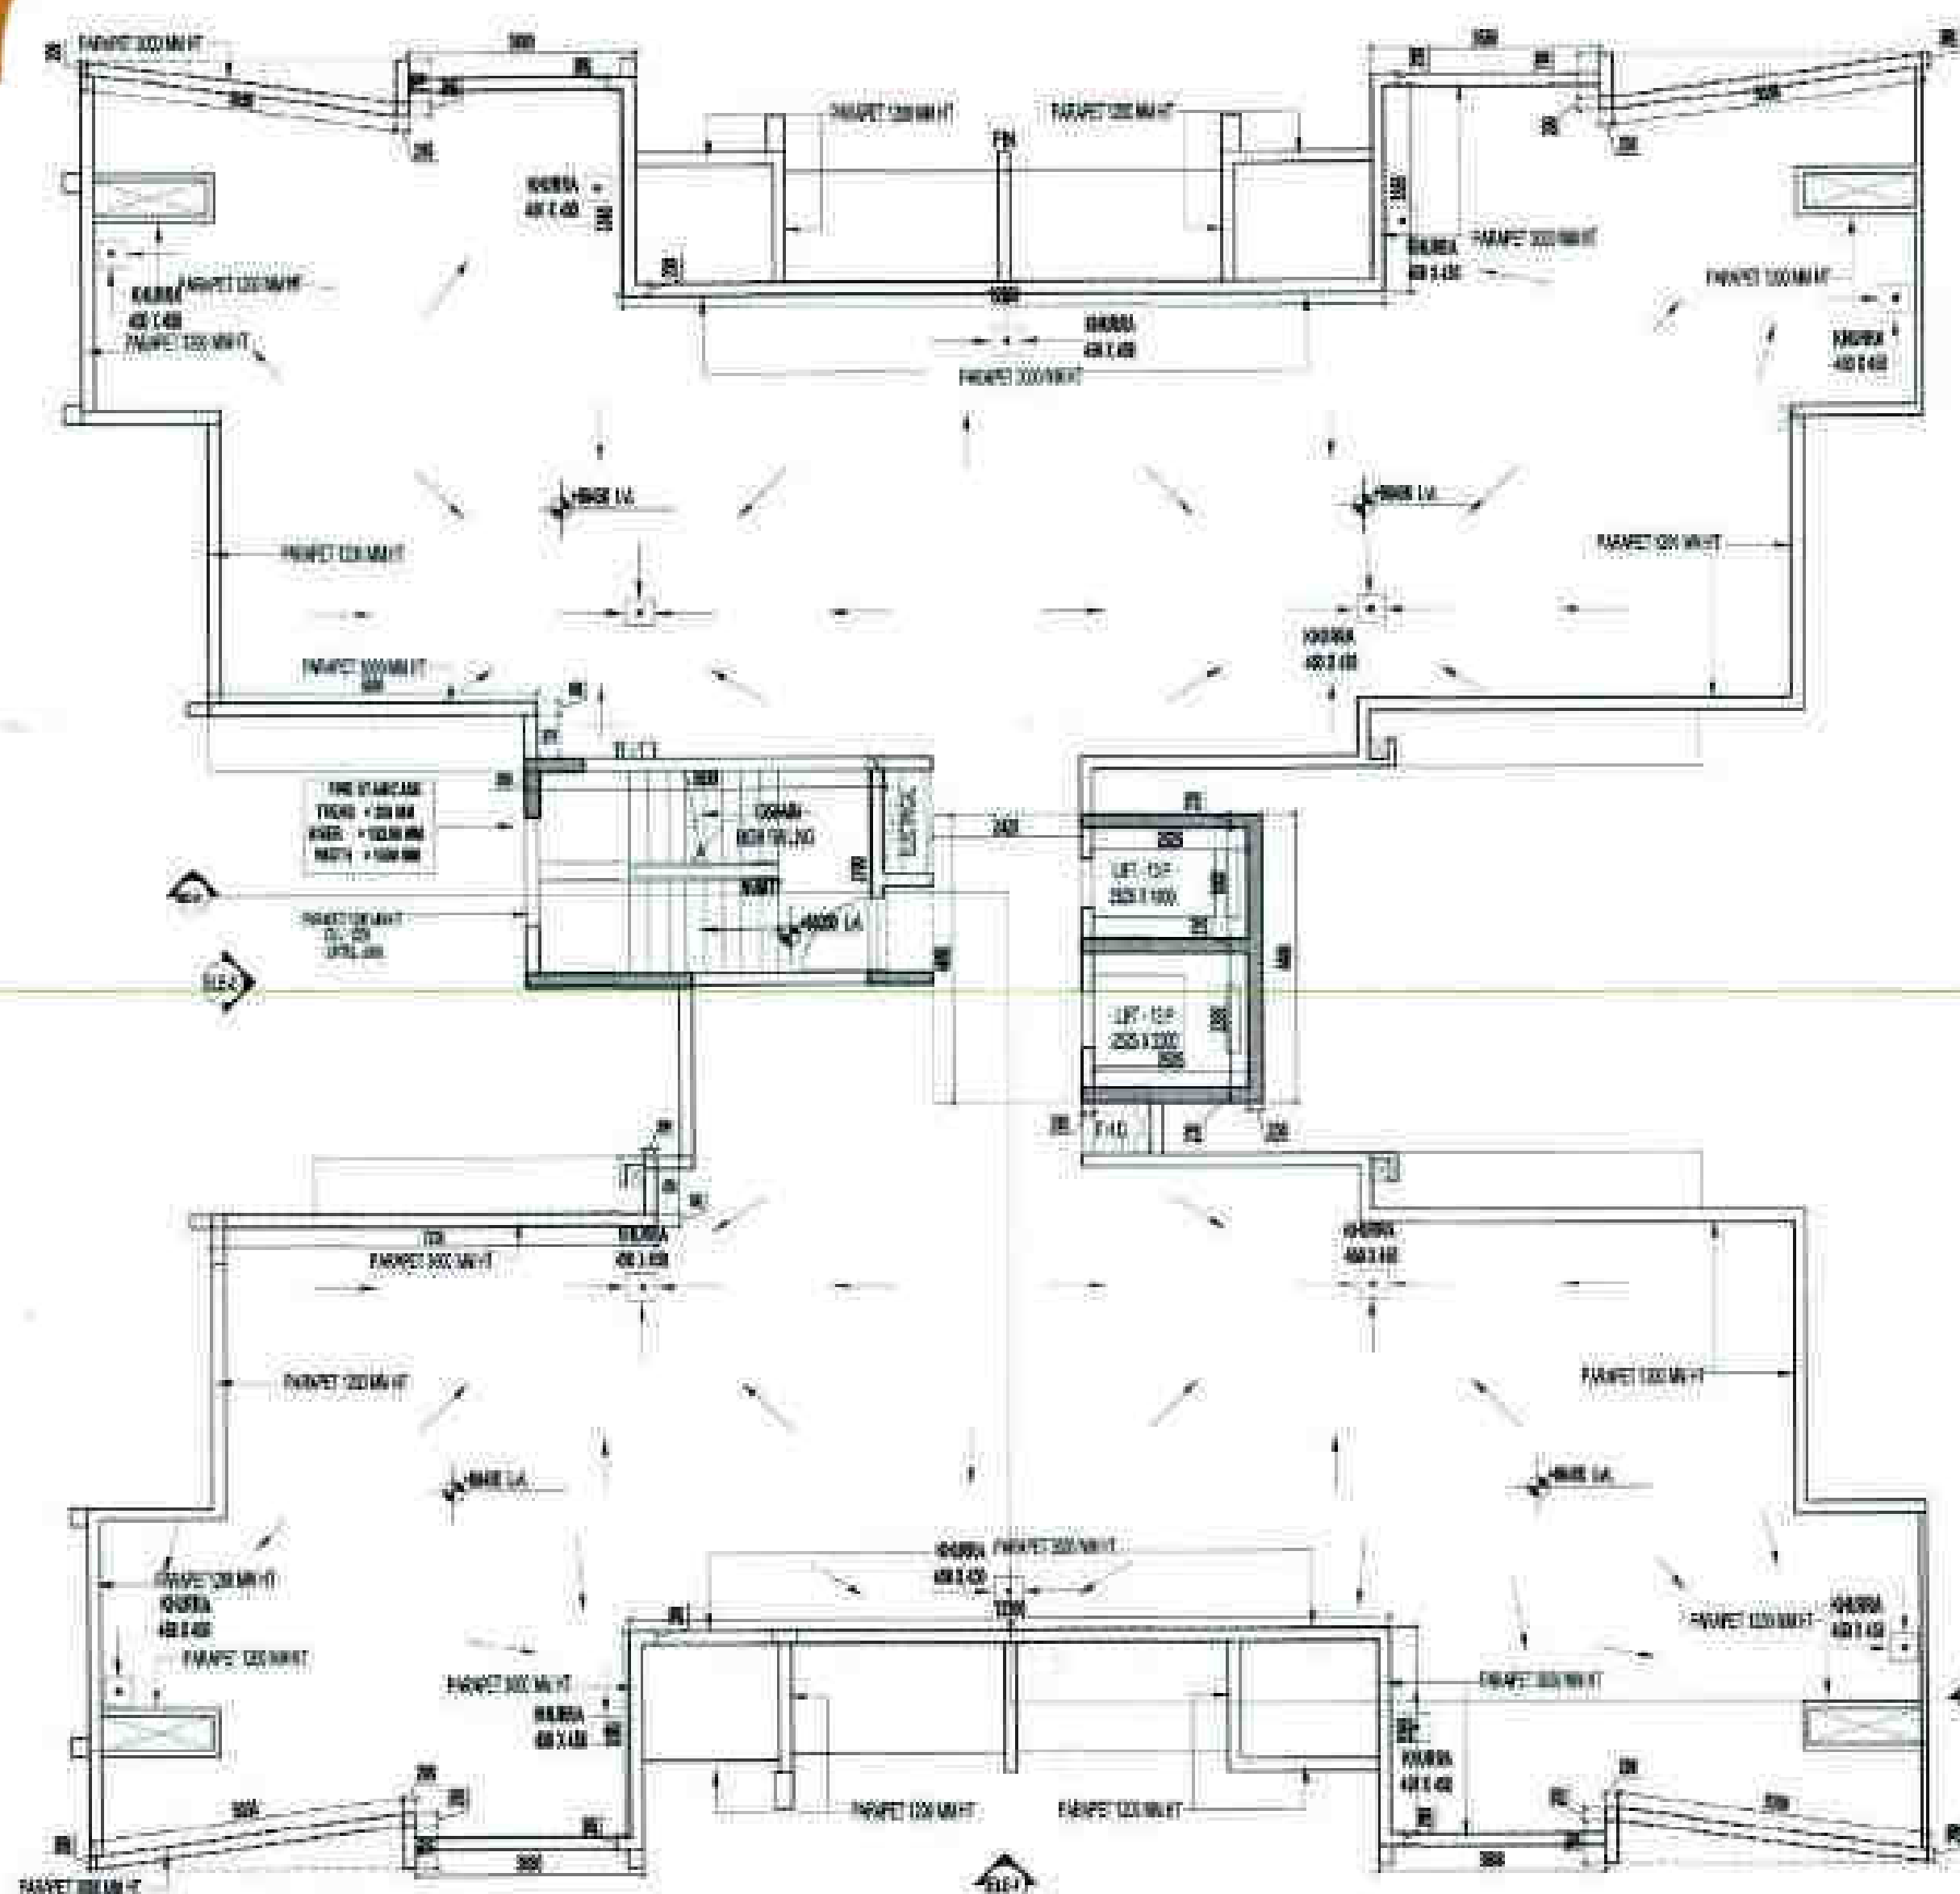


TOTAL F.A.R. AREA OF TERRACE FLOOR PLAN = CIRCULATION LOBBY + PARAPET WALL
= 3.759 + 18.196
= 21.945 SQMT

S.NO.	PARTICULARS	AREA (SQ.M)
TERRACE LIFT LOBBY AREA		
1	0.056 X 0.000	0.000
2	0.056 X 0.000	0.000
3	0.000 X 0.000	0.000
4	0.000 X 0.000	0.000
5	0.000 X 0.000	0.000
6	0.000 X 0.000	0.000
7	0.000 X 0.000	0.000
8	0.000 X 0.000	0.000
9	0.000 X 0.000	0.000
10	0.000 X 0.000	0.000
11	0.000 X 0.000	0.000
12	0.000 X 0.000	0.000
13	0.000 X 0.000	0.000
14	0.000 X 0.000	0.000
15	0.000 X 0.000	0.000
TOTAL AREA		18.196


S.NO.	PARTICULARS	AREA (SQ.M)
TERRACE LIFT LOBBY AREA		
1	0.056 X 0.000	0.000
2	0.056 X 0.000	0.000
3	0.000 X 0.000	0.000
TOTAL F.A.R. AREA		3.759

S.NO.	PARTICULARS	AREA (SQ.M)
TERRACE LIFT LOBBY AREA		
1	0.056 X 0.000	0.000
2	0.056 X 0.000	0.000
3	0.000 X 0.000	0.000
TOTAL F.A.R. AREA		3.759

S.NO.	PARTICULARS	AREA (SQ.M)
TERRACE LIFT LOBBY AREA		
1	0.056 X 0.000	0.000
2	0.056 X 0.000	0.000
3	0.000 X 0.000	0.000
TOTAL F.A.R. AREA		3.759

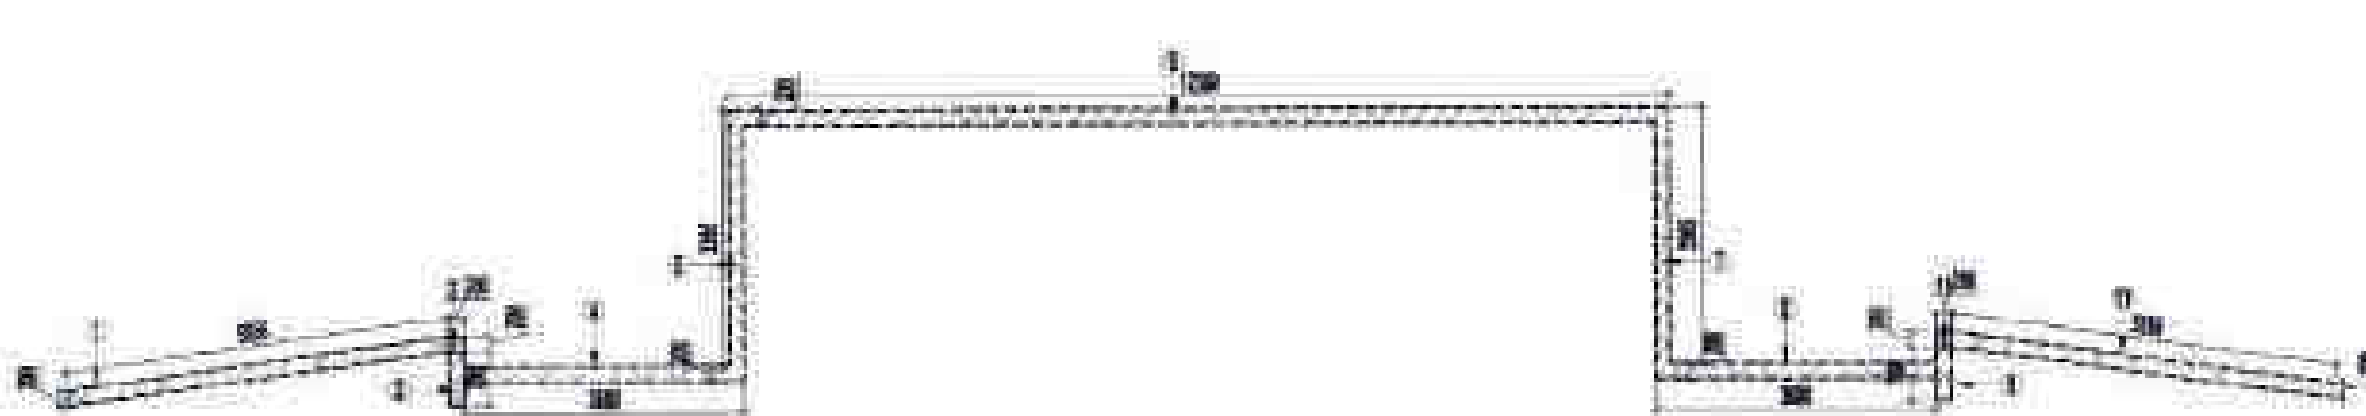

TOTAL F.A.R. AREA OF TERRACE FLOOR PLAN = 17.59 SQMT

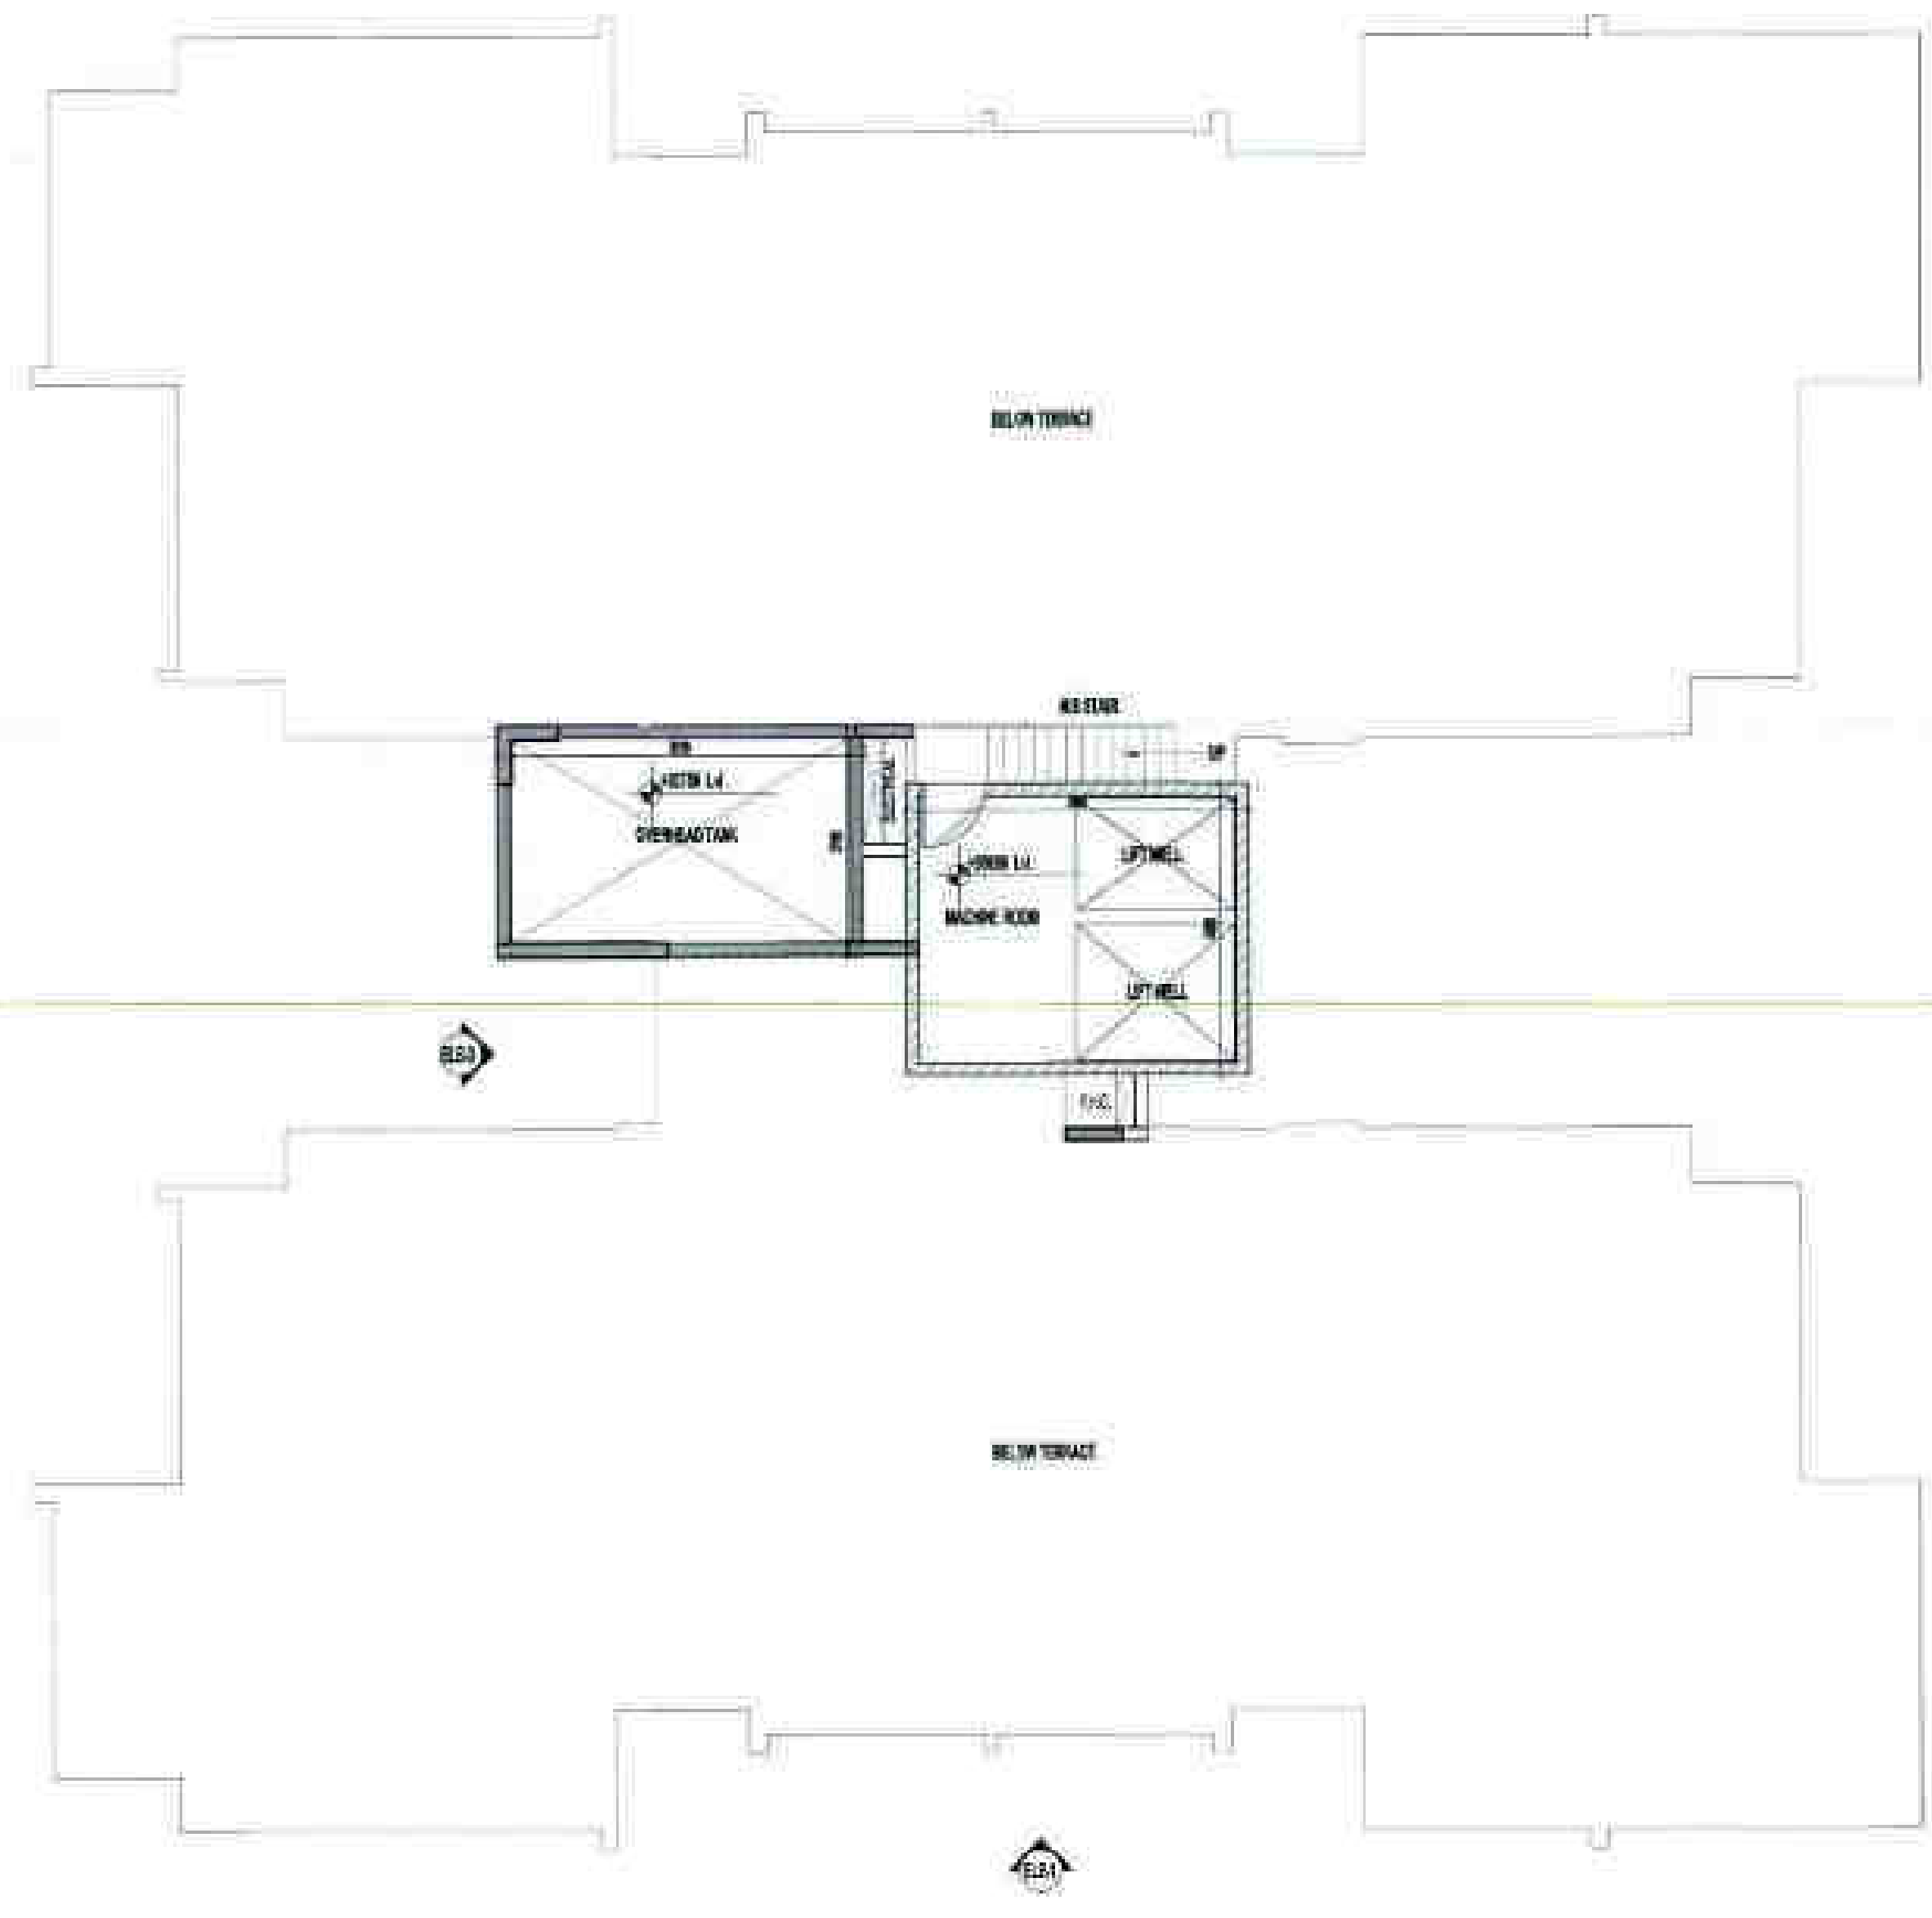

DATE	REVISION	REMARKS
15/07/2021	1	ISSUED FOR PERMIT
15/07/2021	2	ISSUED FOR PERMIT
15/07/2021	3	ISSUED FOR PERMIT

GENERAL NOTE:
1. ALL DIMENSIONS ARE IN METERS.
2. ALL DIMENSIONS ARE TO FACE UNLESS OTHERWISE SPECIFIED.
3. ALL DIMENSIONS ARE TO FACE UNLESS OTHERWISE SPECIFIED.
4. ALL DIMENSIONS ARE TO FACE UNLESS OTHERWISE SPECIFIED.

AREA LEGEND	AREA
1. TERRACE LIFT LOBBY AREA	3.759 SQ.M
2. TERRACE LIFT LOBBY AREA	3.759 SQ.M
3. TERRACE LIFT LOBBY AREA	3.759 SQ.M
4. TERRACE LIFT LOBBY AREA	3.759 SQ.M
5. TERRACE LIFT LOBBY AREA	3.759 SQ.M
6. TERRACE LIFT LOBBY AREA	3.759 SQ.M
7. TERRACE LIFT LOBBY AREA	3.759 SQ.M
8. TERRACE LIFT LOBBY AREA	3.759 SQ.M
9. TERRACE LIFT LOBBY AREA	3.759 SQ.M
10. TERRACE LIFT LOBBY AREA	3.759 SQ.M
11. TERRACE LIFT LOBBY AREA	3.759 SQ.M
12. TERRACE LIFT LOBBY AREA	3.759 SQ.M
13. TERRACE LIFT LOBBY AREA	3.759 SQ.M
14. TERRACE LIFT LOBBY AREA	3.759 SQ.M
15. TERRACE LIFT LOBBY AREA	3.759 SQ.M

SUBMISSION DRAWING

IV COUNTY PVT. LTD.

Cleo County

PROPOSED SHOPS, STALLS FOR IV COUNTY PVT. LTD. AT PLOT NO. 38-35-35-35-35-35, BEHIND, (1/2)

OWNER SIGN: [Signature]

ARCHITECT SIGN: [Signature]

TOWN PLANNER SIGN: [Signature]

TOWN PLANNER: [Name]



PROJECT: [Name]

CONFORMANCE

DATE: 15/07/2021

SCALE: 1:100

THIS DRAWING IS VALID FOR 12 MONTHS FROM THE DATE OF ISSUANCE.

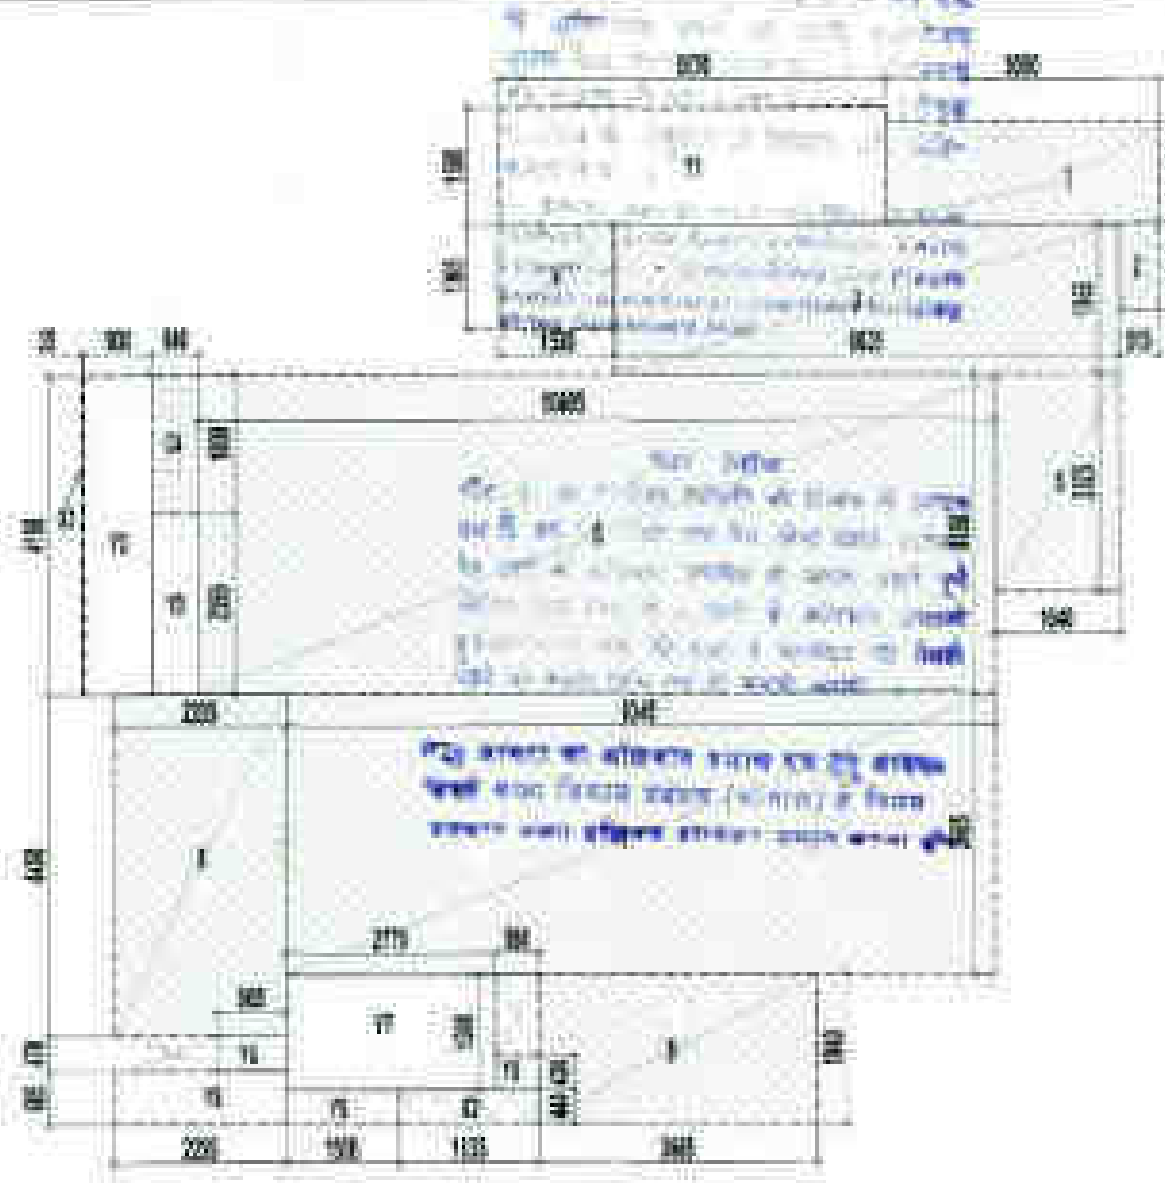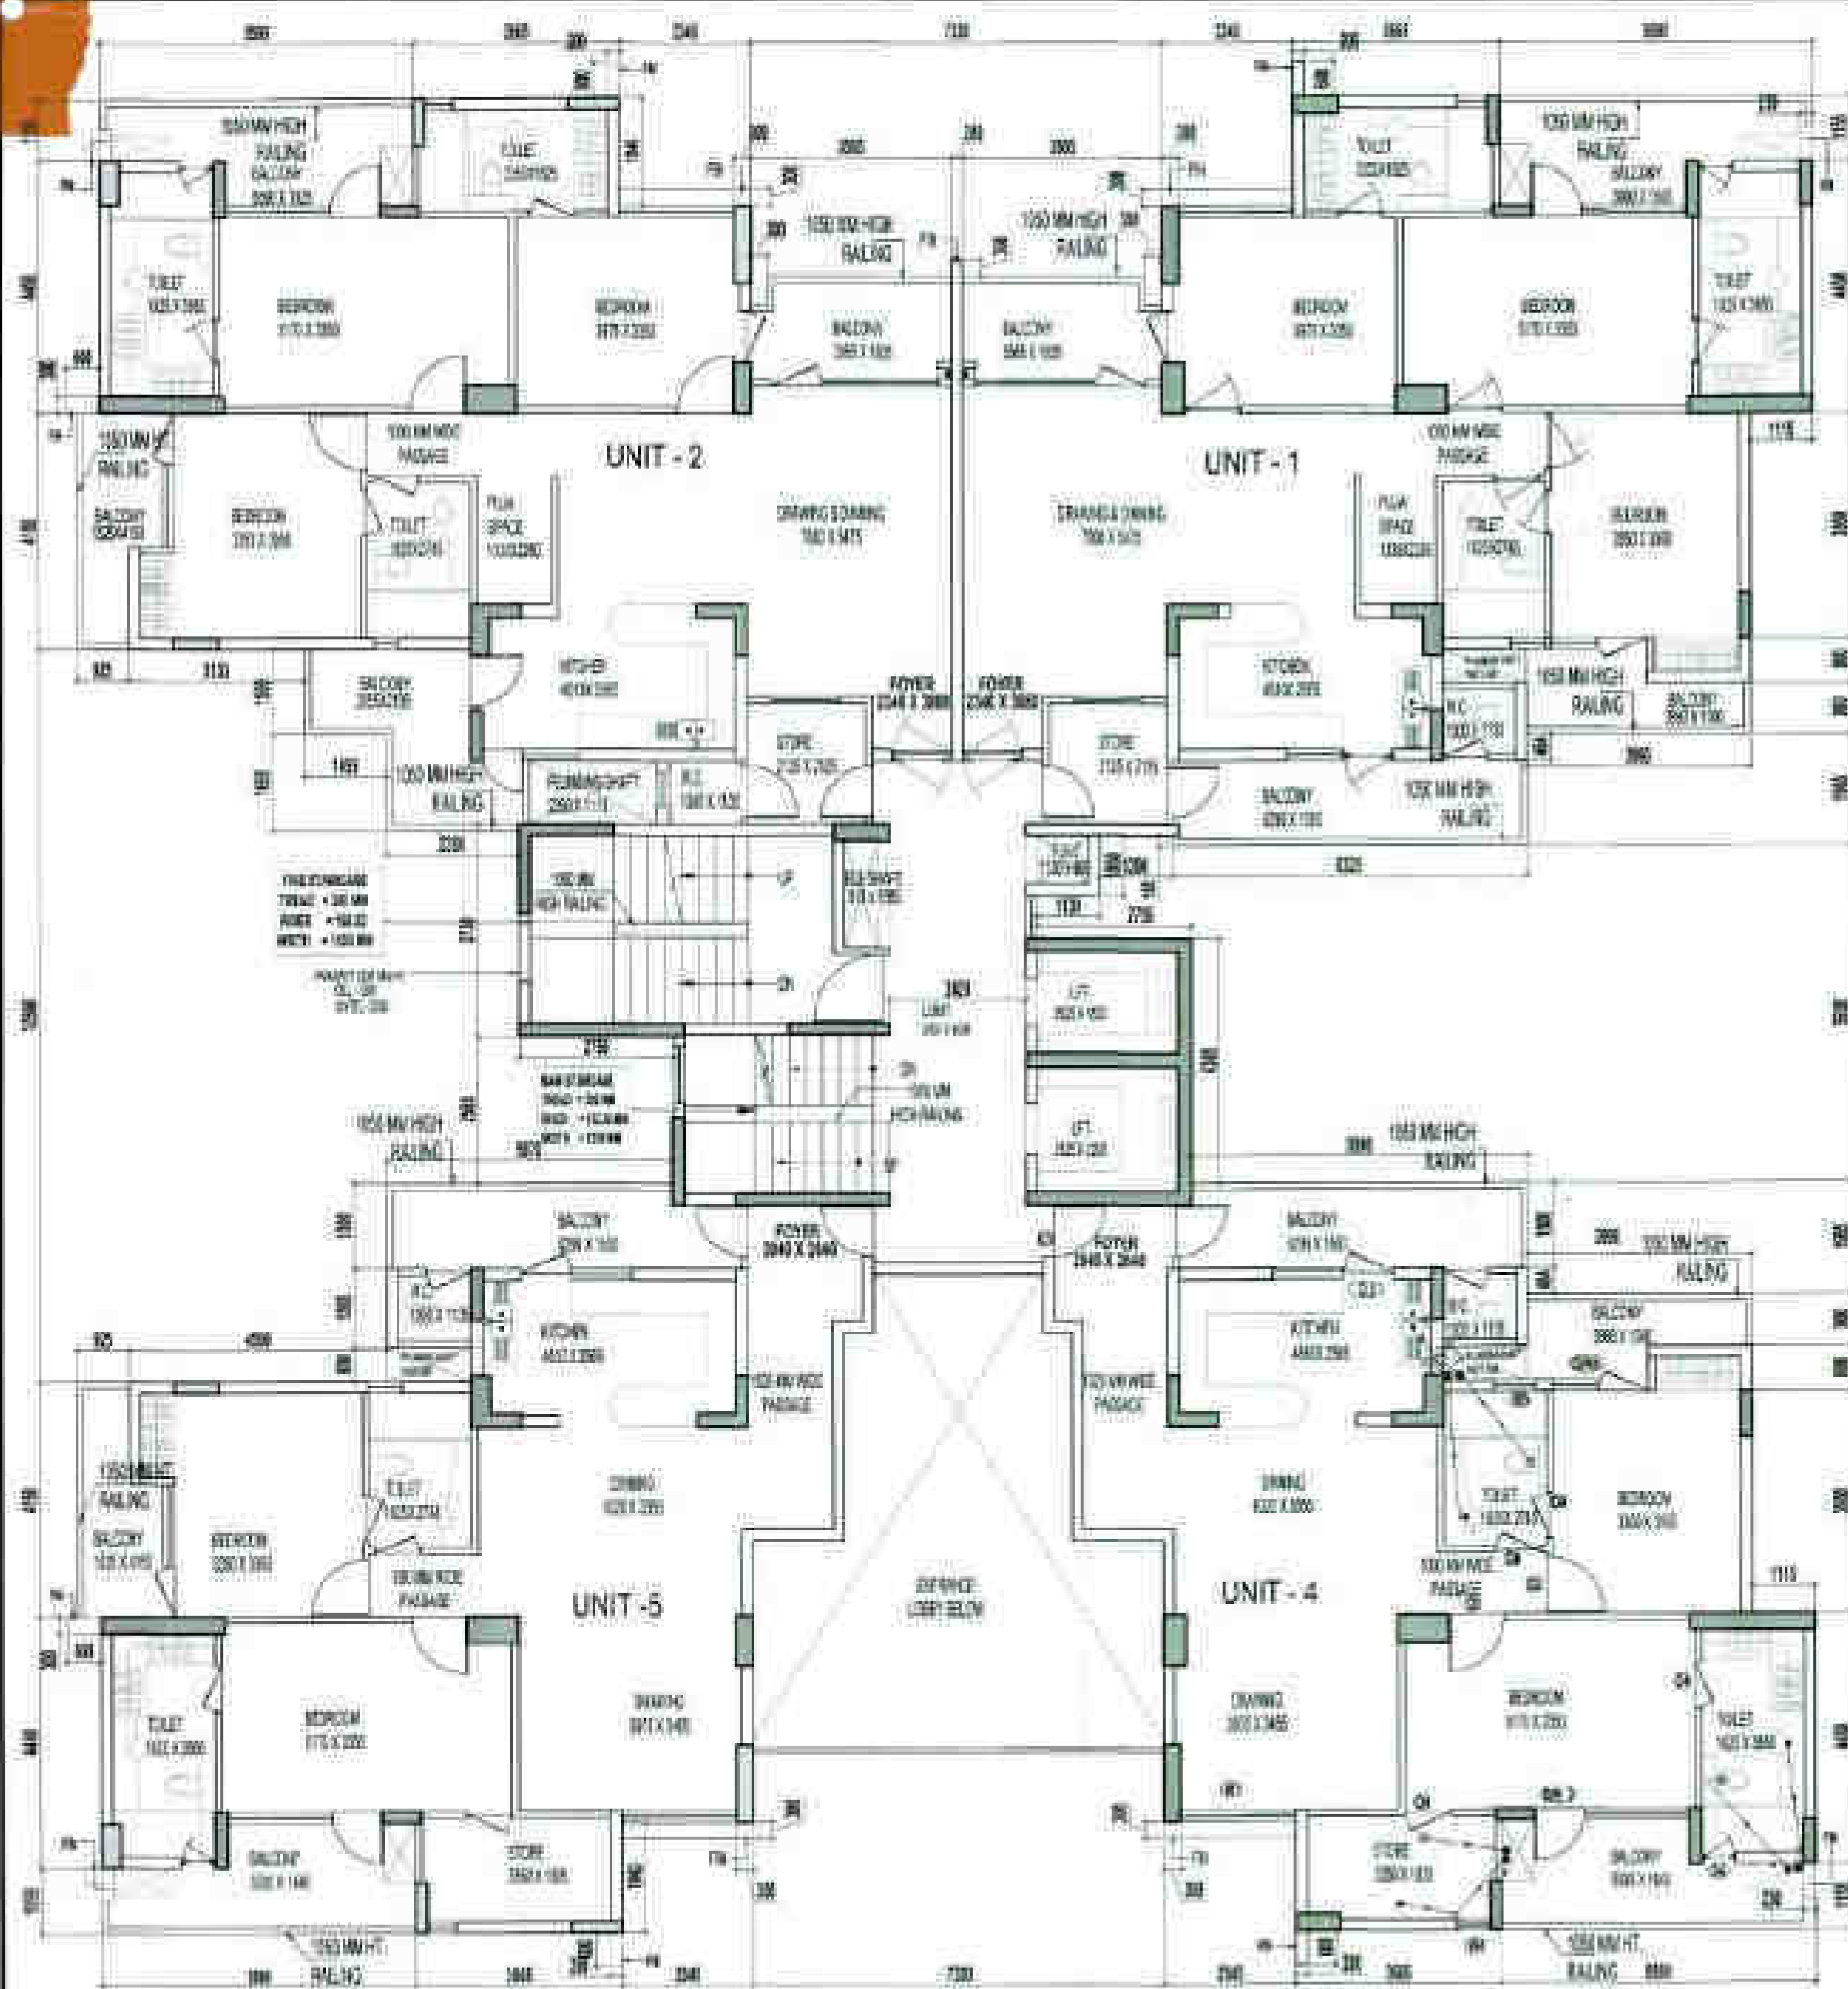

F.A.R. COVERED AREA CALCULATION FOR UNIT-5

S.NO.	PARTICULARS	AREA (SQ.M)
1	COVERED AREA OF UNIT	118.893
2	F.A.R. AREA OF BALCONY (10.0 X 1.0)	10.000
3	TOTAL F.A.R. AREA FOR UNIT-5	128.893

F.A.R. AREA OF BALCONY (10.0 X 1.0)

S.NO.	PARTICULARS	AREA (SQ.M)
1	F.A.R. AREA	10.000
2	TOTAL F.A.R. AREA	10.000

TOTAL F.A.R. AREA FOR UNIT-5


S.NO.	PARTICULARS	AREA (SQ.M)
1	F.A.R. AREA	118.893
2	F.A.R. AREA OF BALCONY	10.000
3	TOTAL F.A.R. AREA	128.893

COVERED AREA OF UNIT-5


S.NO.	PARTICULARS	AREA (SQ.M)
1	COVERED AREA OF UNIT	118.893
2	F.A.R. AREA OF BALCONY	10.000
3	TOTAL F.A.R. AREA	128.893

COVERED AREA OF UNIT-5

S.NO.	PARTICULARS	AREA (SQ.M)
1	COVERED AREA OF UNIT	118.893
2	F.A.R. AREA OF BALCONY	10.000
3	TOTAL F.A.R. AREA	128.893

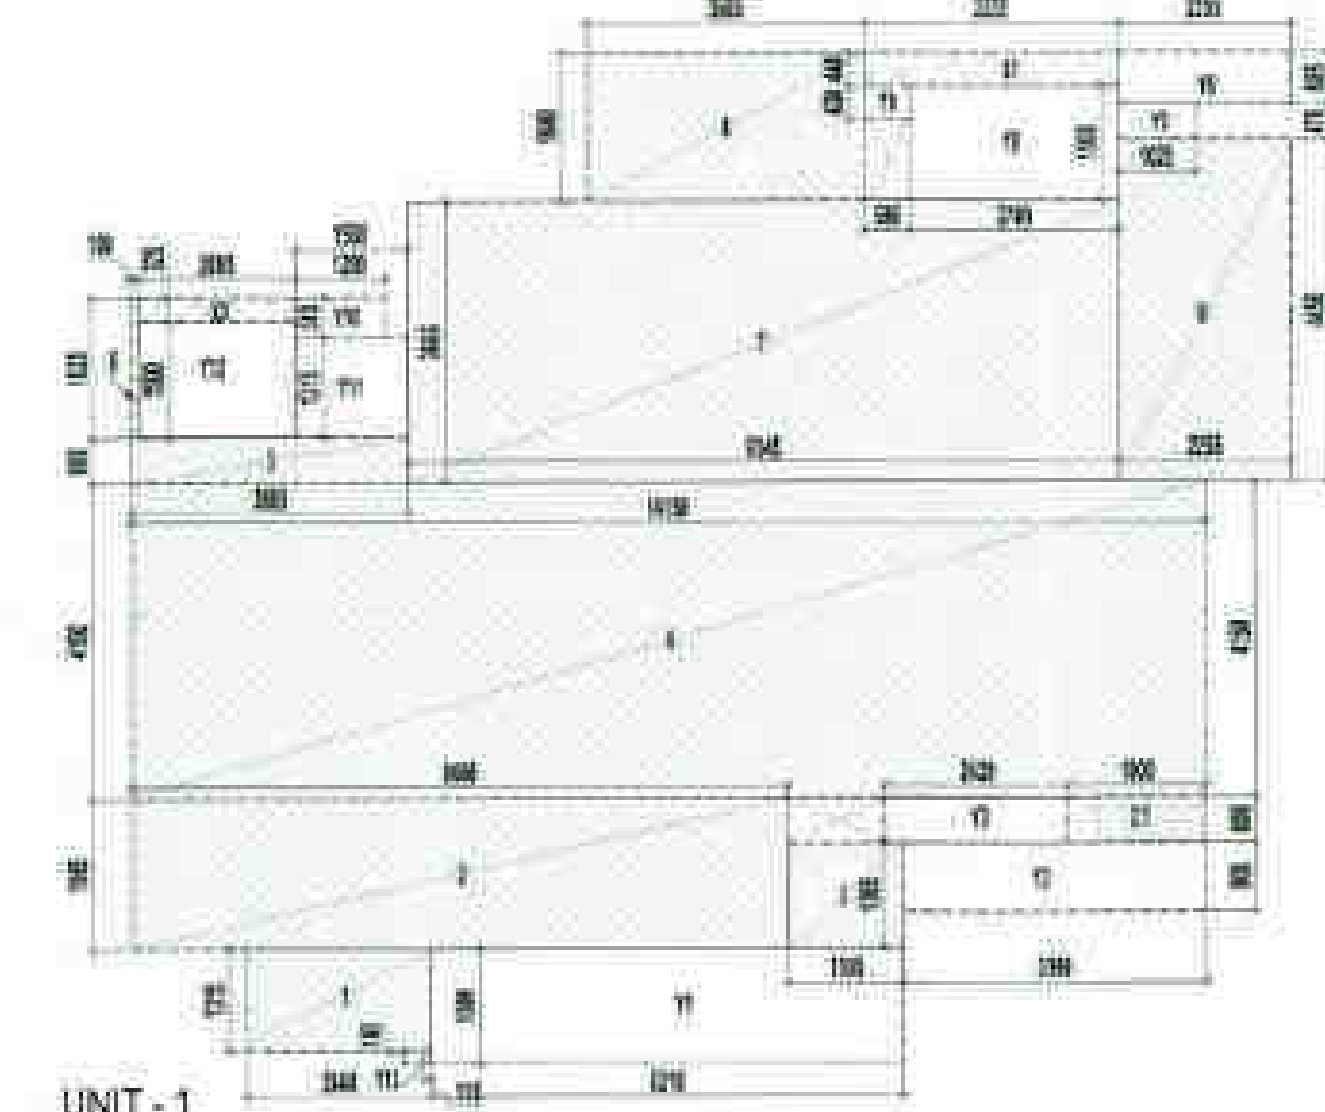

UNIT-1

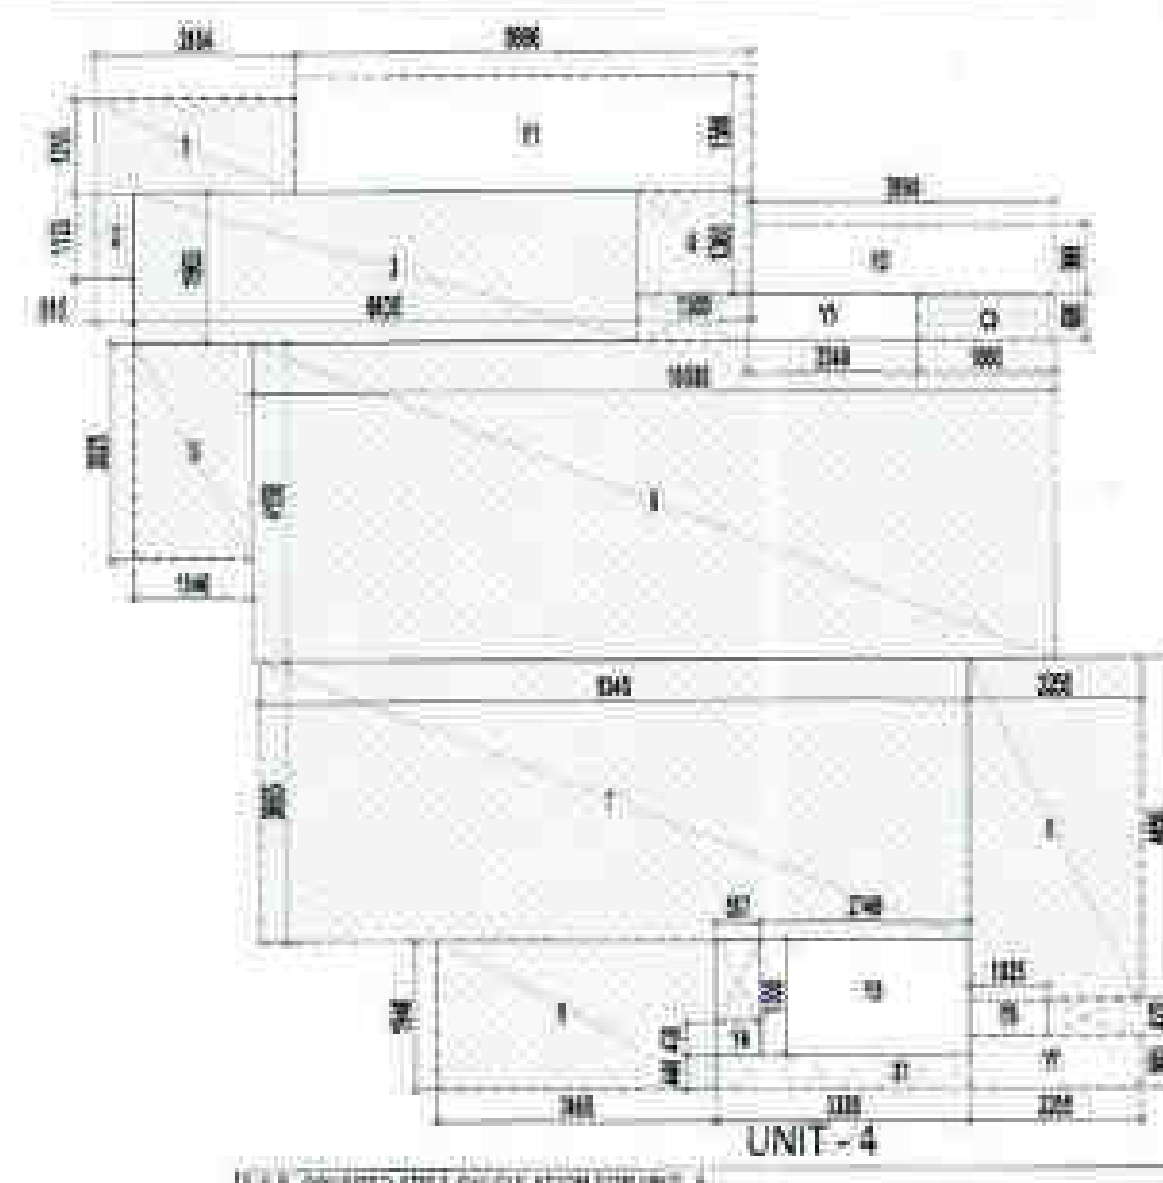

F.A.R. COVERED AREA CALCULATION FOR UNIT-4

S.NO.	PARTICULARS	AREA (SQ.M)
1	COVERED AREA OF UNIT	118.893
2	F.A.R. AREA OF BALCONY (10.0 X 1.0)	10.000
3	TOTAL F.A.R. AREA FOR UNIT-4	128.893

F.A.R. AREA OF BALCONY (10.0 X 1.0)

S.NO.	PARTICULARS	AREA (SQ.M)
1	F.A.R. AREA	10.000
2	TOTAL F.A.R. AREA	10.000

TOTAL F.A.R. AREA FOR UNIT-4

S.NO.	PARTICULARS	AREA (SQ.M)
1	F.A.R. AREA	118.893
2	F.A.R. AREA OF BALCONY	10.000
3	TOTAL F.A.R. AREA	128.893

COVERED AREA OF UNIT-4

S.NO.	PARTICULARS	AREA (SQ.M)
1	COVERED AREA OF UNIT	118.893
2	F.A.R. AREA OF BALCONY	10.000
3	TOTAL F.A.R. AREA	128.893

COVERED AREA OF UNIT-4

S.NO.	PARTICULARS	AREA (SQ.M)
1	COVERED AREA OF UNIT	118.893
2	F.A.R. AREA OF BALCONY	10.000
3	TOTAL F.A.R. AREA	128.893

AREA CALCULATION TOWARDS THE ADDITIONAL F.A.R. AT FIRST FLOOR


S.NO.	PARTICULARS	AREA (SQ.M)
1	COVERED AREA OF UNIT	118.893
2	F.A.R. AREA OF BALCONY	10.000
3	TOTAL F.A.R. AREA	128.893

F.A.R. COVERED AREA CALCULATION FOR CIRCULATION AT FIRST FLOOR

S.NO.	PARTICULARS	AREA (SQ.M)
1	COVERED AREA OF UNIT	118.893
2	F.A.R. AREA OF BALCONY	10.000
3	TOTAL F.A.R. AREA	128.893

TOTAL F.A.R. AREA AT FIRST FLOOR

S.NO.	PARTICULARS	AREA (SQ.M)
1	COVERED AREA OF UNIT	118.893
2	F.A.R. AREA OF BALCONY	10.000
3	TOTAL F.A.R. AREA	128.893

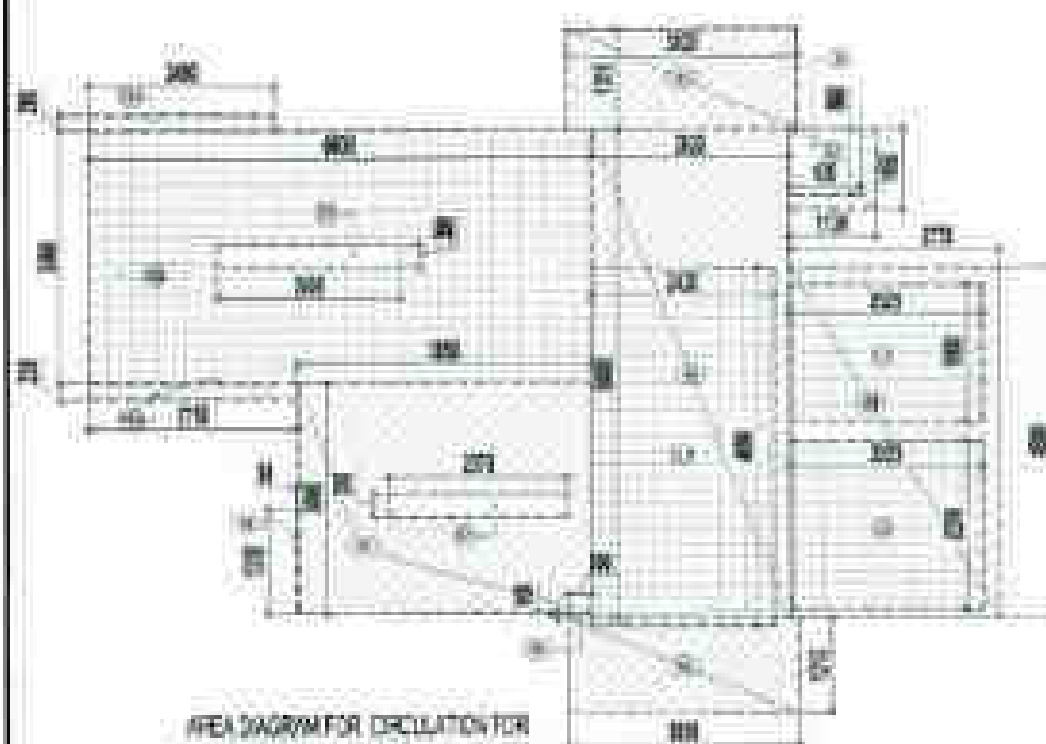

F.A.R. COVERED AREA CALCULATION FOR UNIT-1

S.NO.	PARTICULARS	AREA (SQ.M)
1	COVERED AREA OF UNIT	118.893
2	F.A.R. AREA OF BALCONY (10.0 X 1.0)	10.000
3	TOTAL F.A.R. AREA FOR UNIT-1	128.893

F.A.R. AREA OF BALCONY (10.0 X 1.0)

S.NO.	PARTICULARS	AREA (SQ.M)
1	F.A.R. AREA	10.000
2	TOTAL F.A.R. AREA	10.000

TOTAL F.A.R. AREA FOR UNIT-1

S.NO.	PARTICULARS	AREA (SQ.M)
1	F.A.R. AREA	118.893
2	F.A.R. AREA OF BALCONY	10.000
3	TOTAL F.A.R. AREA	128.893

COVERED AREA OF UNIT-1

S.NO.	PARTICULARS	AREA (SQ.M)
1	COVERED AREA OF UNIT	118.893
2	F.A.R. AREA OF BALCONY	10.000
3	TOTAL F.A.R. AREA	128.893

COVERED AREA OF UNIT-1

S.NO.	PARTICULARS	AREA (SQ.M)
1	COVERED AREA OF UNIT	118.893
2	F.A.R. AREA OF BALCONY	10.000
3	TOTAL F.A.R. AREA	128.893

This drawing is a "CONCEPT" drawing of this drawing or part thereof may not be used or reproduced without the permission of the architect.

NO. 1042/3788

DATE: 10/10/2023

PROJECT: IV COUNTY PVT. LTD.




ARCHITECT: CONFLUENCE

TOWN PLANNER: CONFLUENCE

TOWN PLANNER: CONFLUENCE

5-027


This drawing is available on www.confluence.com

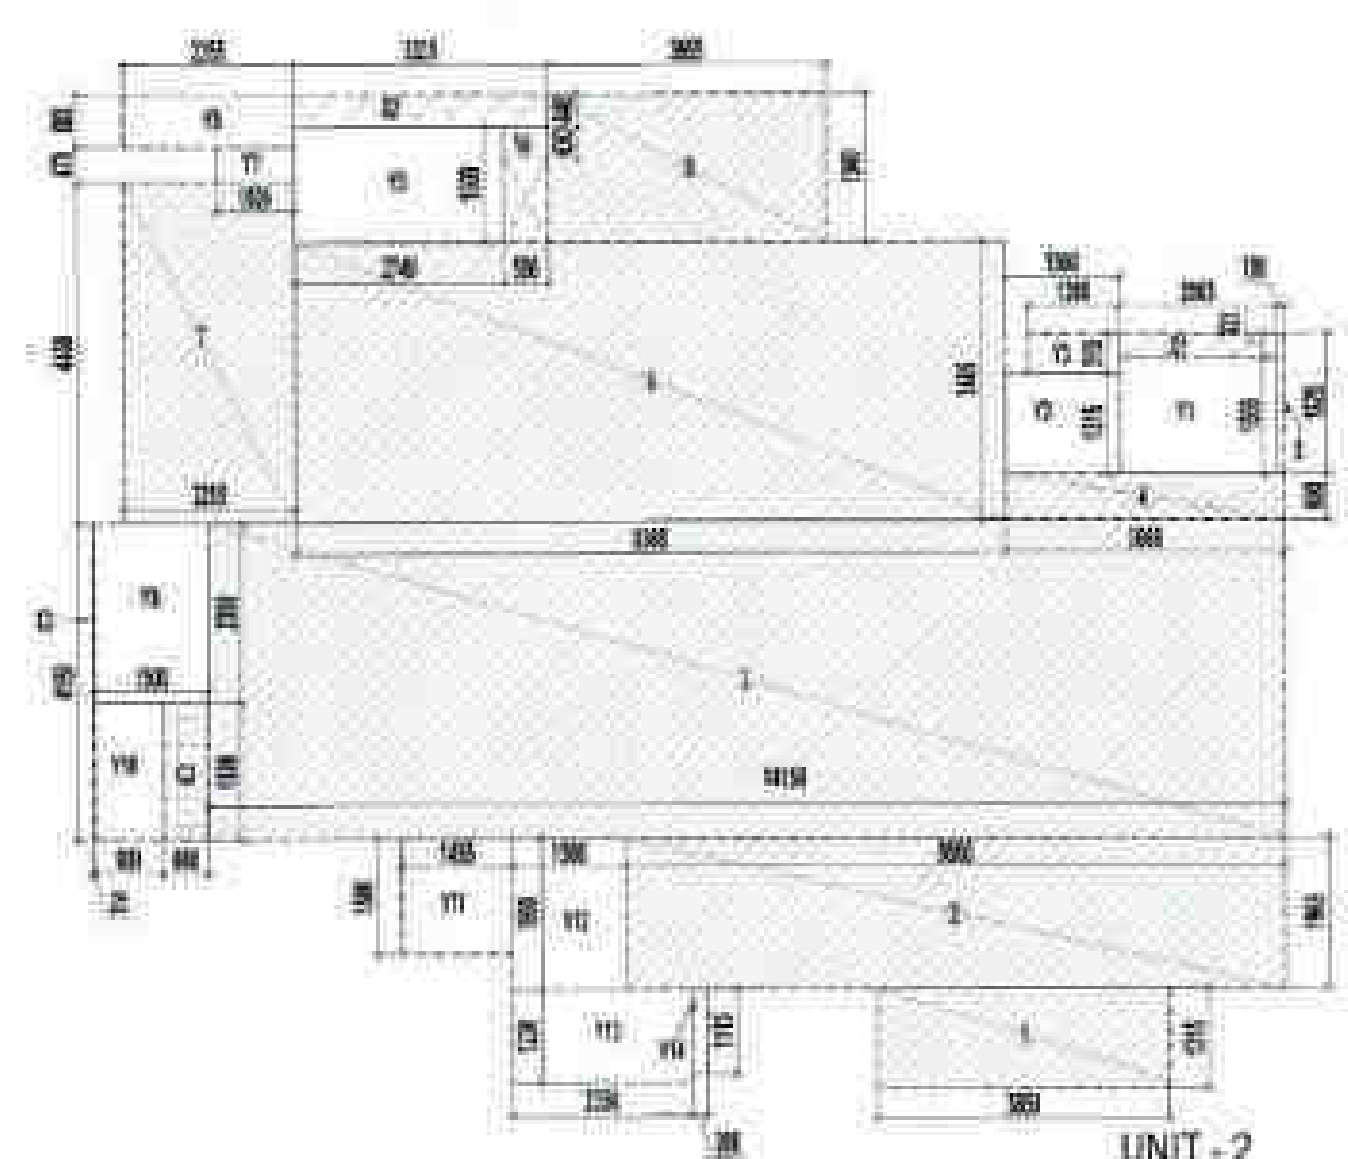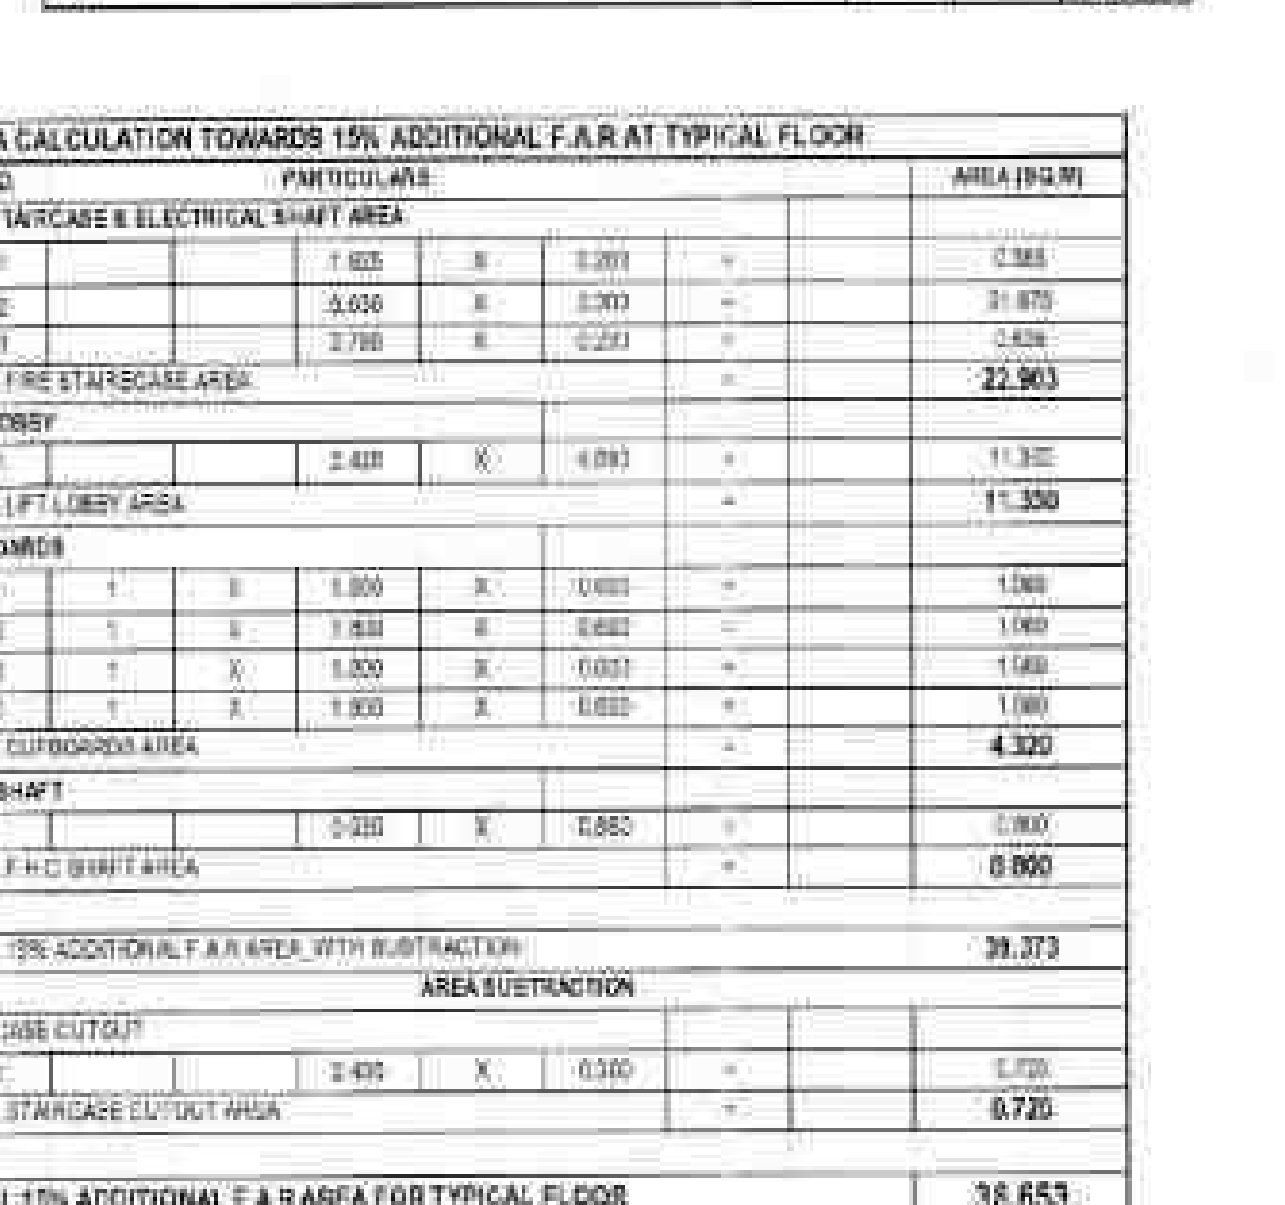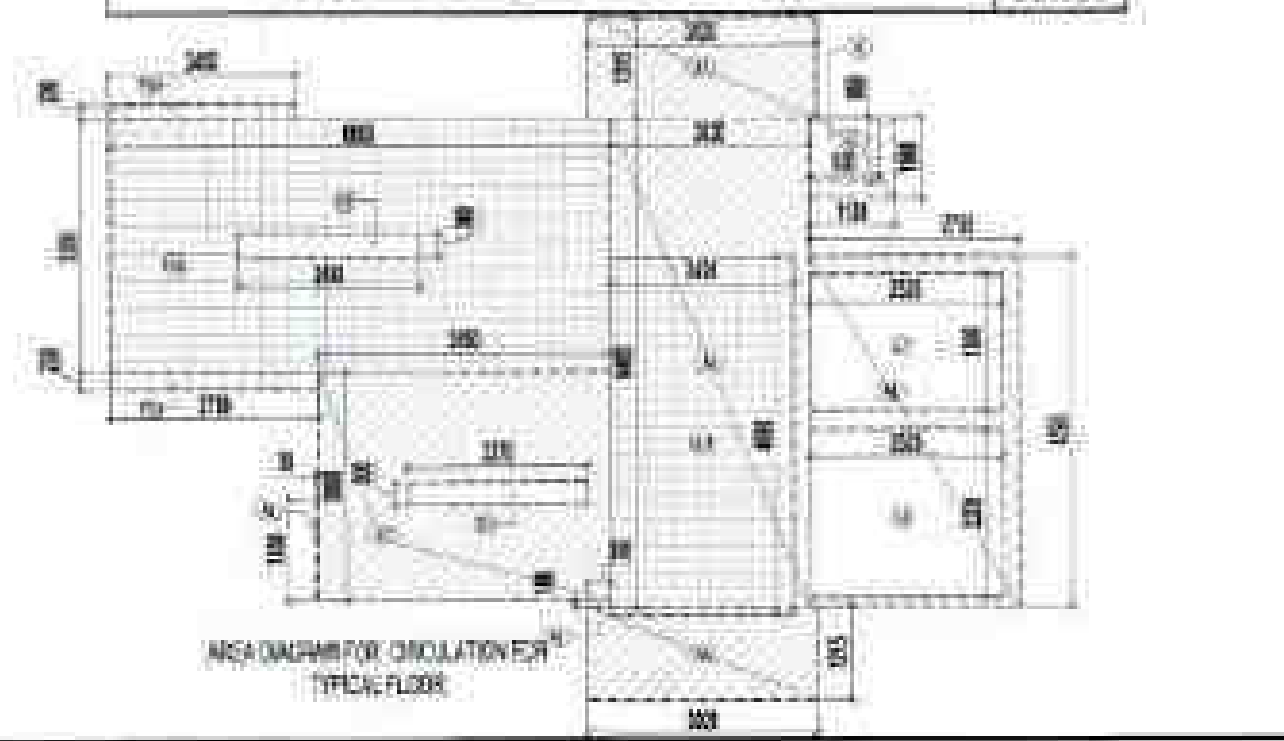






CONJUGATE AREA OF THE 1, 2, 4, 6 WITH -NBT, 8, 8 AREA OF SALT-OUT + NON-FIB AREA OF SALT-OUT				
1	7.147 AREA		0	134.578
2	2.274 AREA OF SALT-OUT		0	2.342
3	NON-FIB AREA OF SALT-OUT		0	25.491
TOTAL				162.412

F.A.R. COVERED AREA CALCULATION FOR CIRCULATION AT TYPICAL FLOOR					
S.NO		PARTICULARS			WHEEL SQ.
A-1		2.00	X	0.001	0.00
A-2		2.75	X	4.493	12.07
A-3		2.00	X	8.203	16.58
A-4		3.00	X	3.033	11.00
A-5		2.00	X	0.003	0.00
A-6		0.00	0	0.00	0.00
TOTAL AREA		(A)			44.22
AREA SUBTRACTION					
LIFT SHA.					
L-1		2.00	X	1.000	0.00
L-2		0.00	X	0.00	0.00
LIFT LOBBY					
L-1		2.40	X	4.493	11.00
STAIRCASE OUTLET					
X-1		2.67	X	0.000	0.00
TOTAL AREA		(B)			22.00
TOTAL CIRCULATION AREA PER FLOOR		(A-B)			22.13

AREA CALCULATION TOWARDS 15% ADDITIONAL F.A.R AT TYPICAL FLOOR						
S.NO	PARTICULARS					AREA (SQ.M)
FIRE STAIRCASE & ELECTRICAL SHAFT AREA						
F1		1.625	X	1.200	+	0.988
F2		0.636	X	1.200	+	0.1878
F3		2.788	X	0.253	+	0.626
TOTAL FIRE STAIRCASE AREA						22.903
LIFT LOBBY						
L1		2.418	X	0.083	+	1.332
TOTAL LIFT LOBBY AREA						11.330
CLIPBOARD						
C1	1	0	X	0.000	+	1.000
C2	1	0	X	0.000	+	1.000
C3	1	X	0.000	X	0.000	1.000
C4	0	X	1.000	X	0.000	1.000
TOTAL CLIPBOARD AREA						4.320
F.H.C SHAFT						
S		0.255	X	0.880	+	0.000
TOTAL F.H.C SHAFT AREA						0.880
TOTAL 15% ADDITIONAL F.A.R AREA WITH SUBTRACTION						39.373
AREA SUBTRACTION						
STAIRCASE CUTOFF						
C1		2.435	X	0.010	+	0.720
TOTAL STAIRCASE CUTOFF AREA						0.720
TOTAL 15% ADDITIONAL F.A.R AS PER FOR TYPICAL FLOOR						38.653

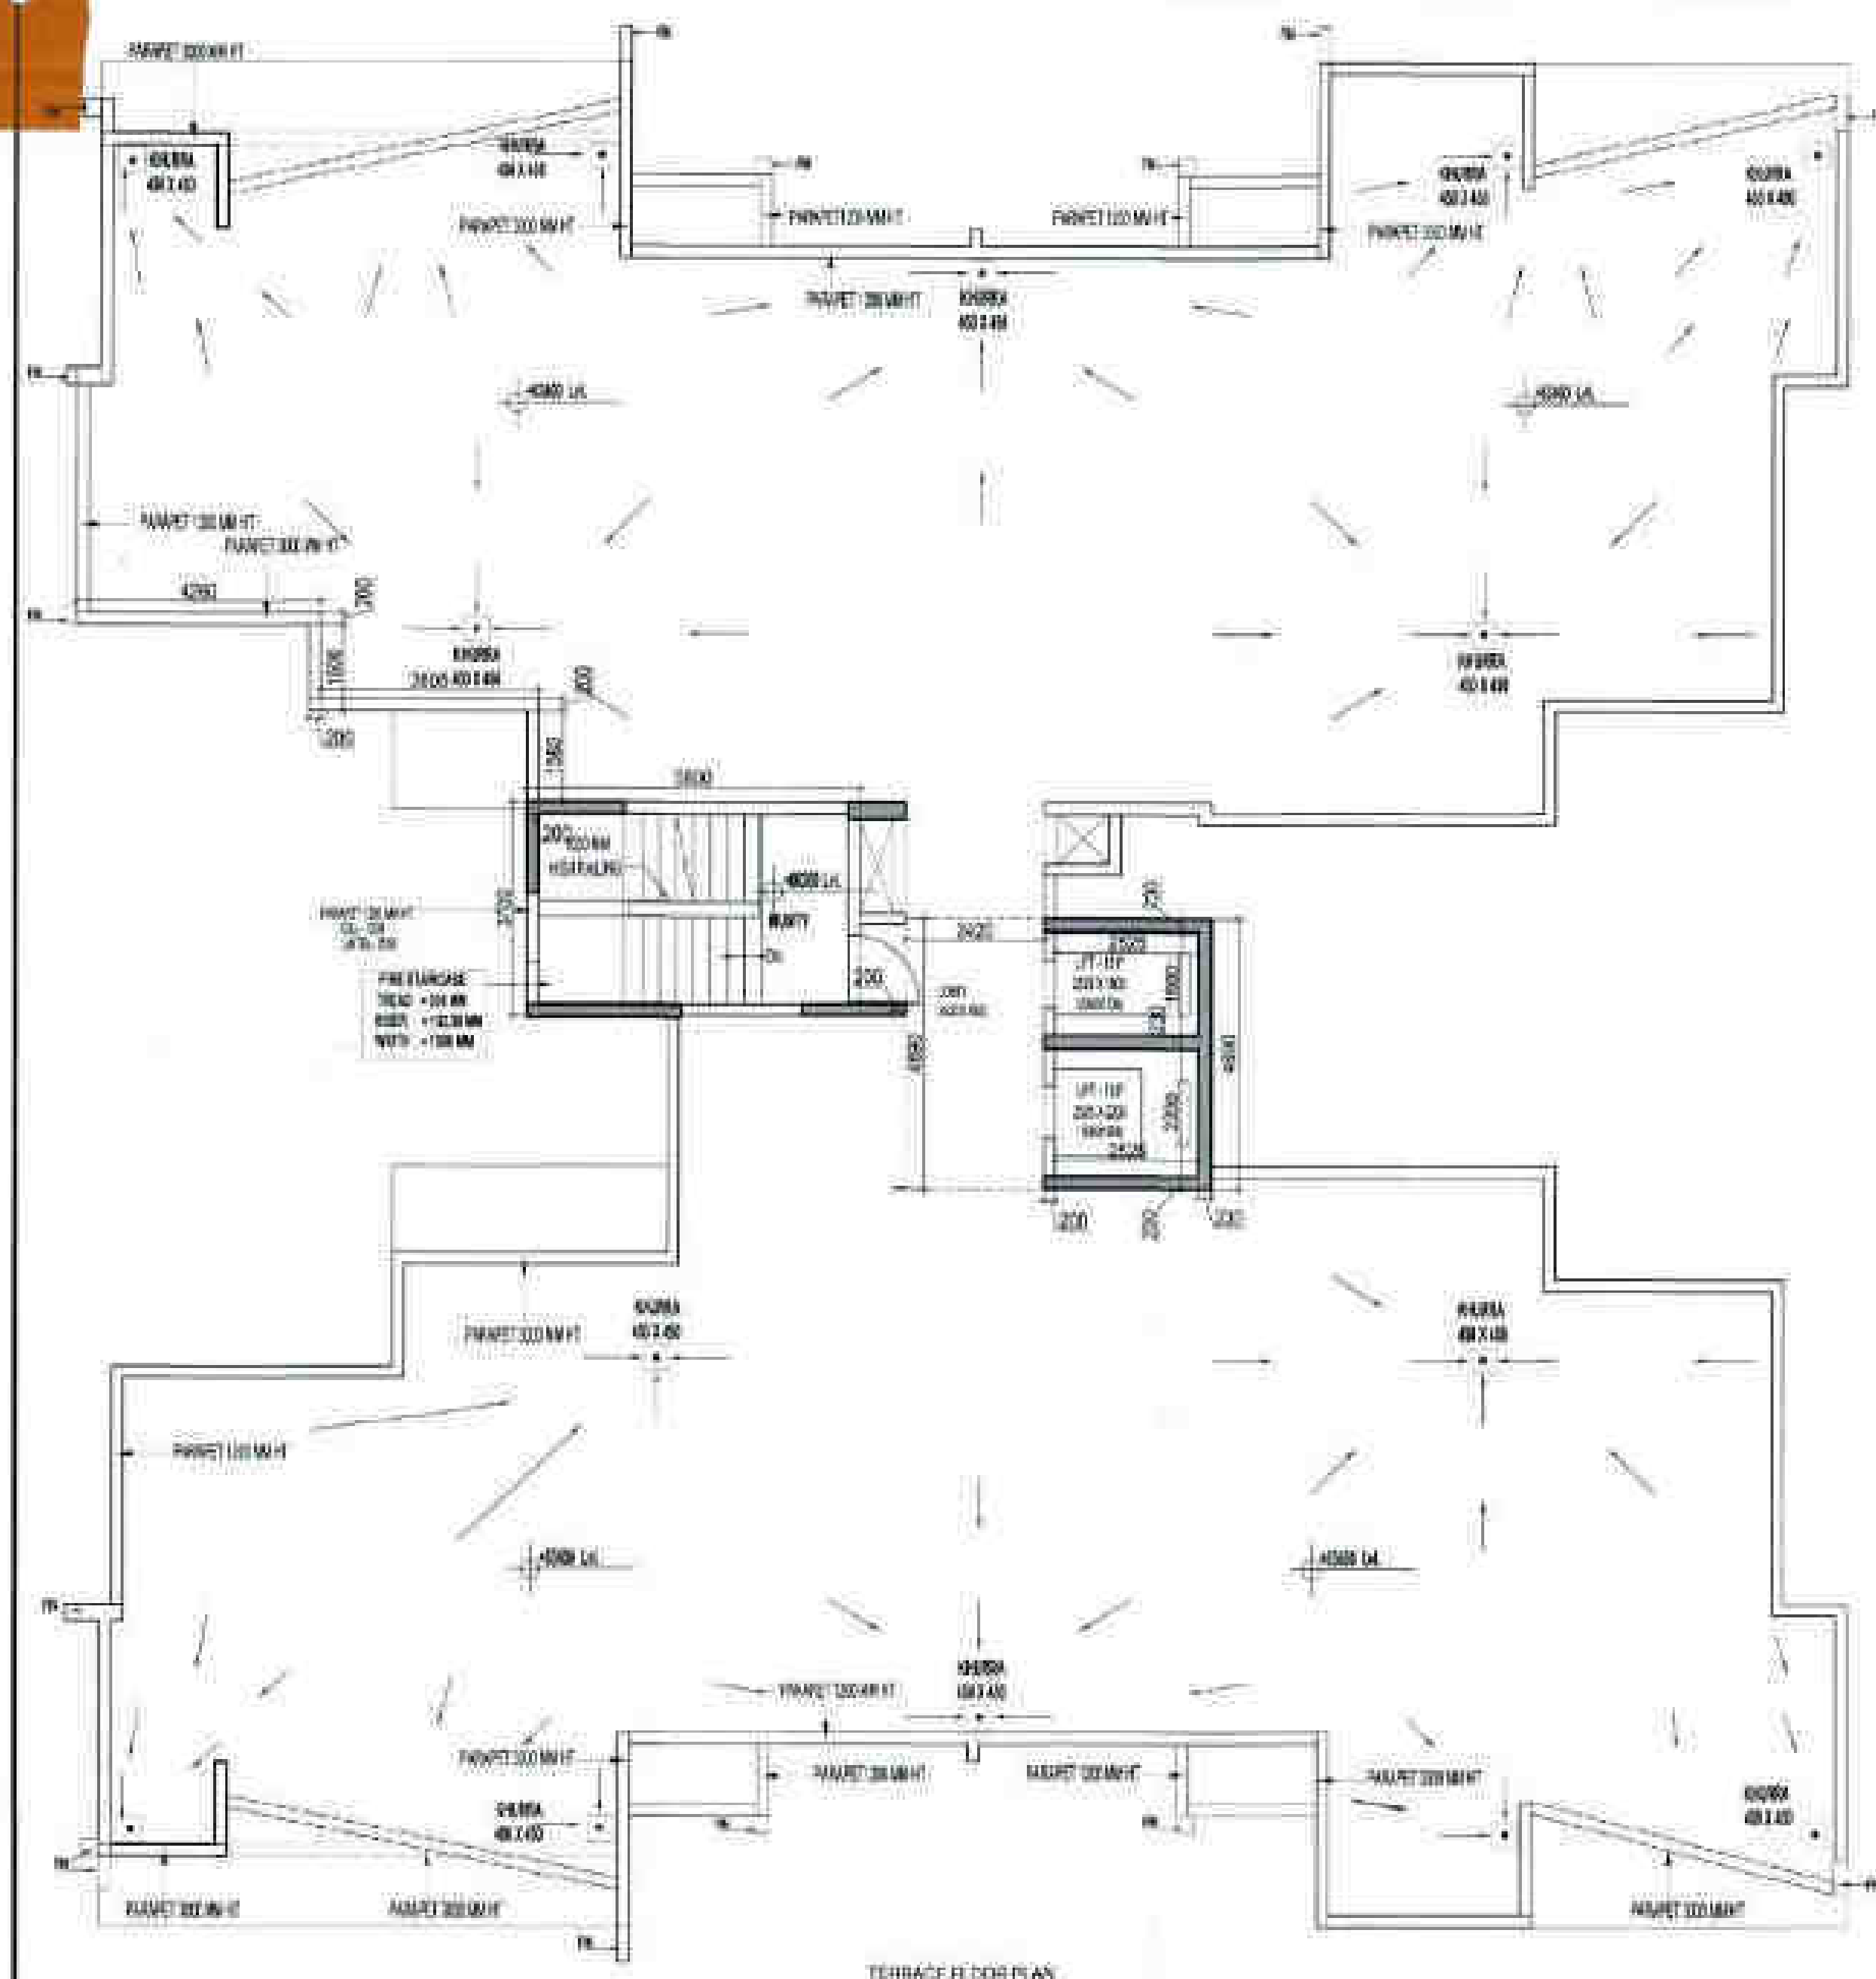


TOTAL F.A.R AREA OF TERRACE FLOOR PLAN = 19.555 SQMT

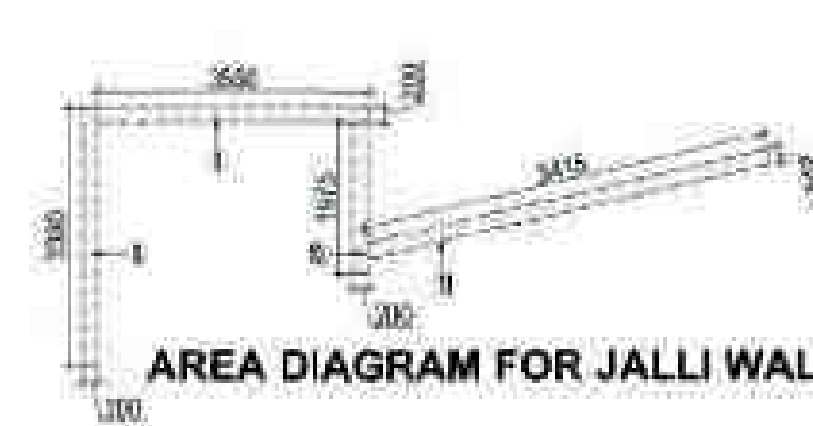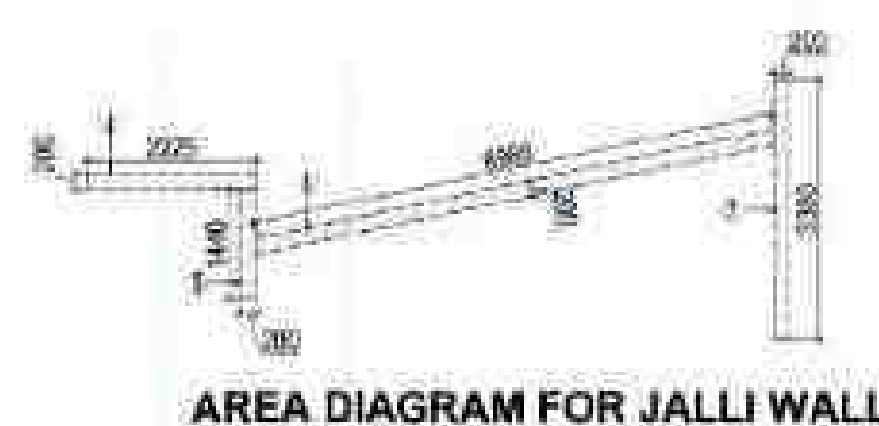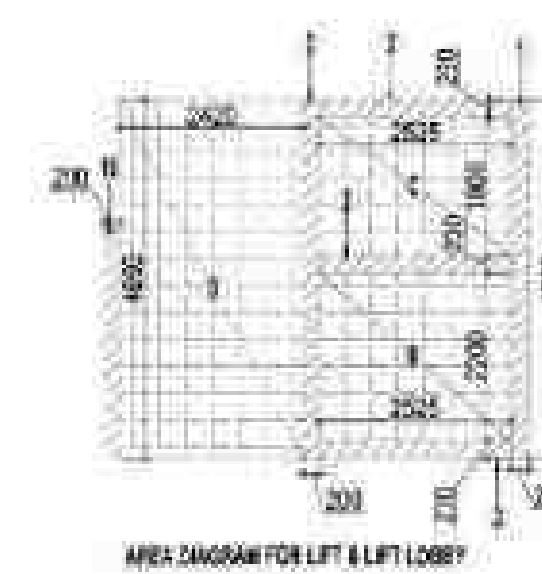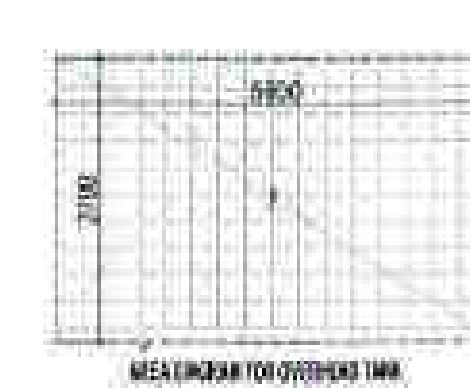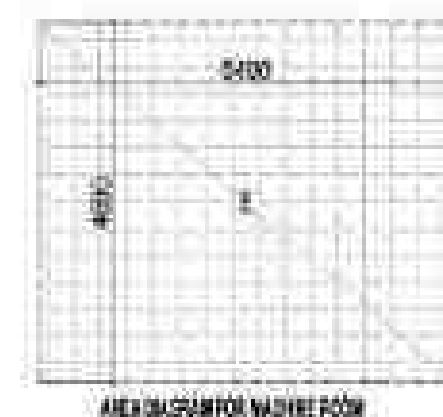

F.A.R. COVERED AREA CALCULATION FOR TERRACE						AREA (SQ.M)	
S.NO.	PARTICULARS						
TERRACE LIFT LOBBY AREA							
1	0.200	X	4.500	=		0.900	
2	0.200	X	4.500	=		0.900	
3	0.200	X	4.500	=		0.900	
4	0.200	X	4.500	=		0.900	
5	0.200	X	4.500	=		0.900	
6	0.200	X	4.500	=		0.900	
7	0.200	X	4.500	=		0.900	
8	0.200	X	4.500	=		0.900	
9	0.200	X	4.500	=		0.900	
10	0.200	X	4.500	=		0.900	
11	0.200	X	4.500	=		0.900	
12	0.200	X	4.500	=		0.900	
13	0.200	X	4.500	=		0.900	
14	0.200	X	4.500	=		0.900	
15	0.200	X	4.500	=		0.900	
TOTAL F.A.R. AREA							19.555

AREA CALCULATION TOWARDS 15% ADDITIONAL F.A.R.						AREA (SQ.M)	
S.NO.	PARTICULARS						
TERRACE LIFT LOBBY AREA & FIRE STAIRCASE							
A	5.000	X	3.700	=		18.500	
B	2.000	X	2.000	=		4.000	
C	2.000	X	1.800	=		3.600	
LIFT LOBBY							
D	3.000	X	4.000	=		12.000	
TOTAL AREA							42.900

AREA CALCULATION TOWARDS 15% ADDITIONAL F.A.R.						AREA (SQ.M)	
S.NO.	PARTICULARS						
AREA FOR MACHINE ROOM							
E	0.400	X	4.000	=		1.600	
AREA FOR OVERHEAD TANK							
F	5.800	X	3.700	=		21.460	
TOTAL AREA							47.200

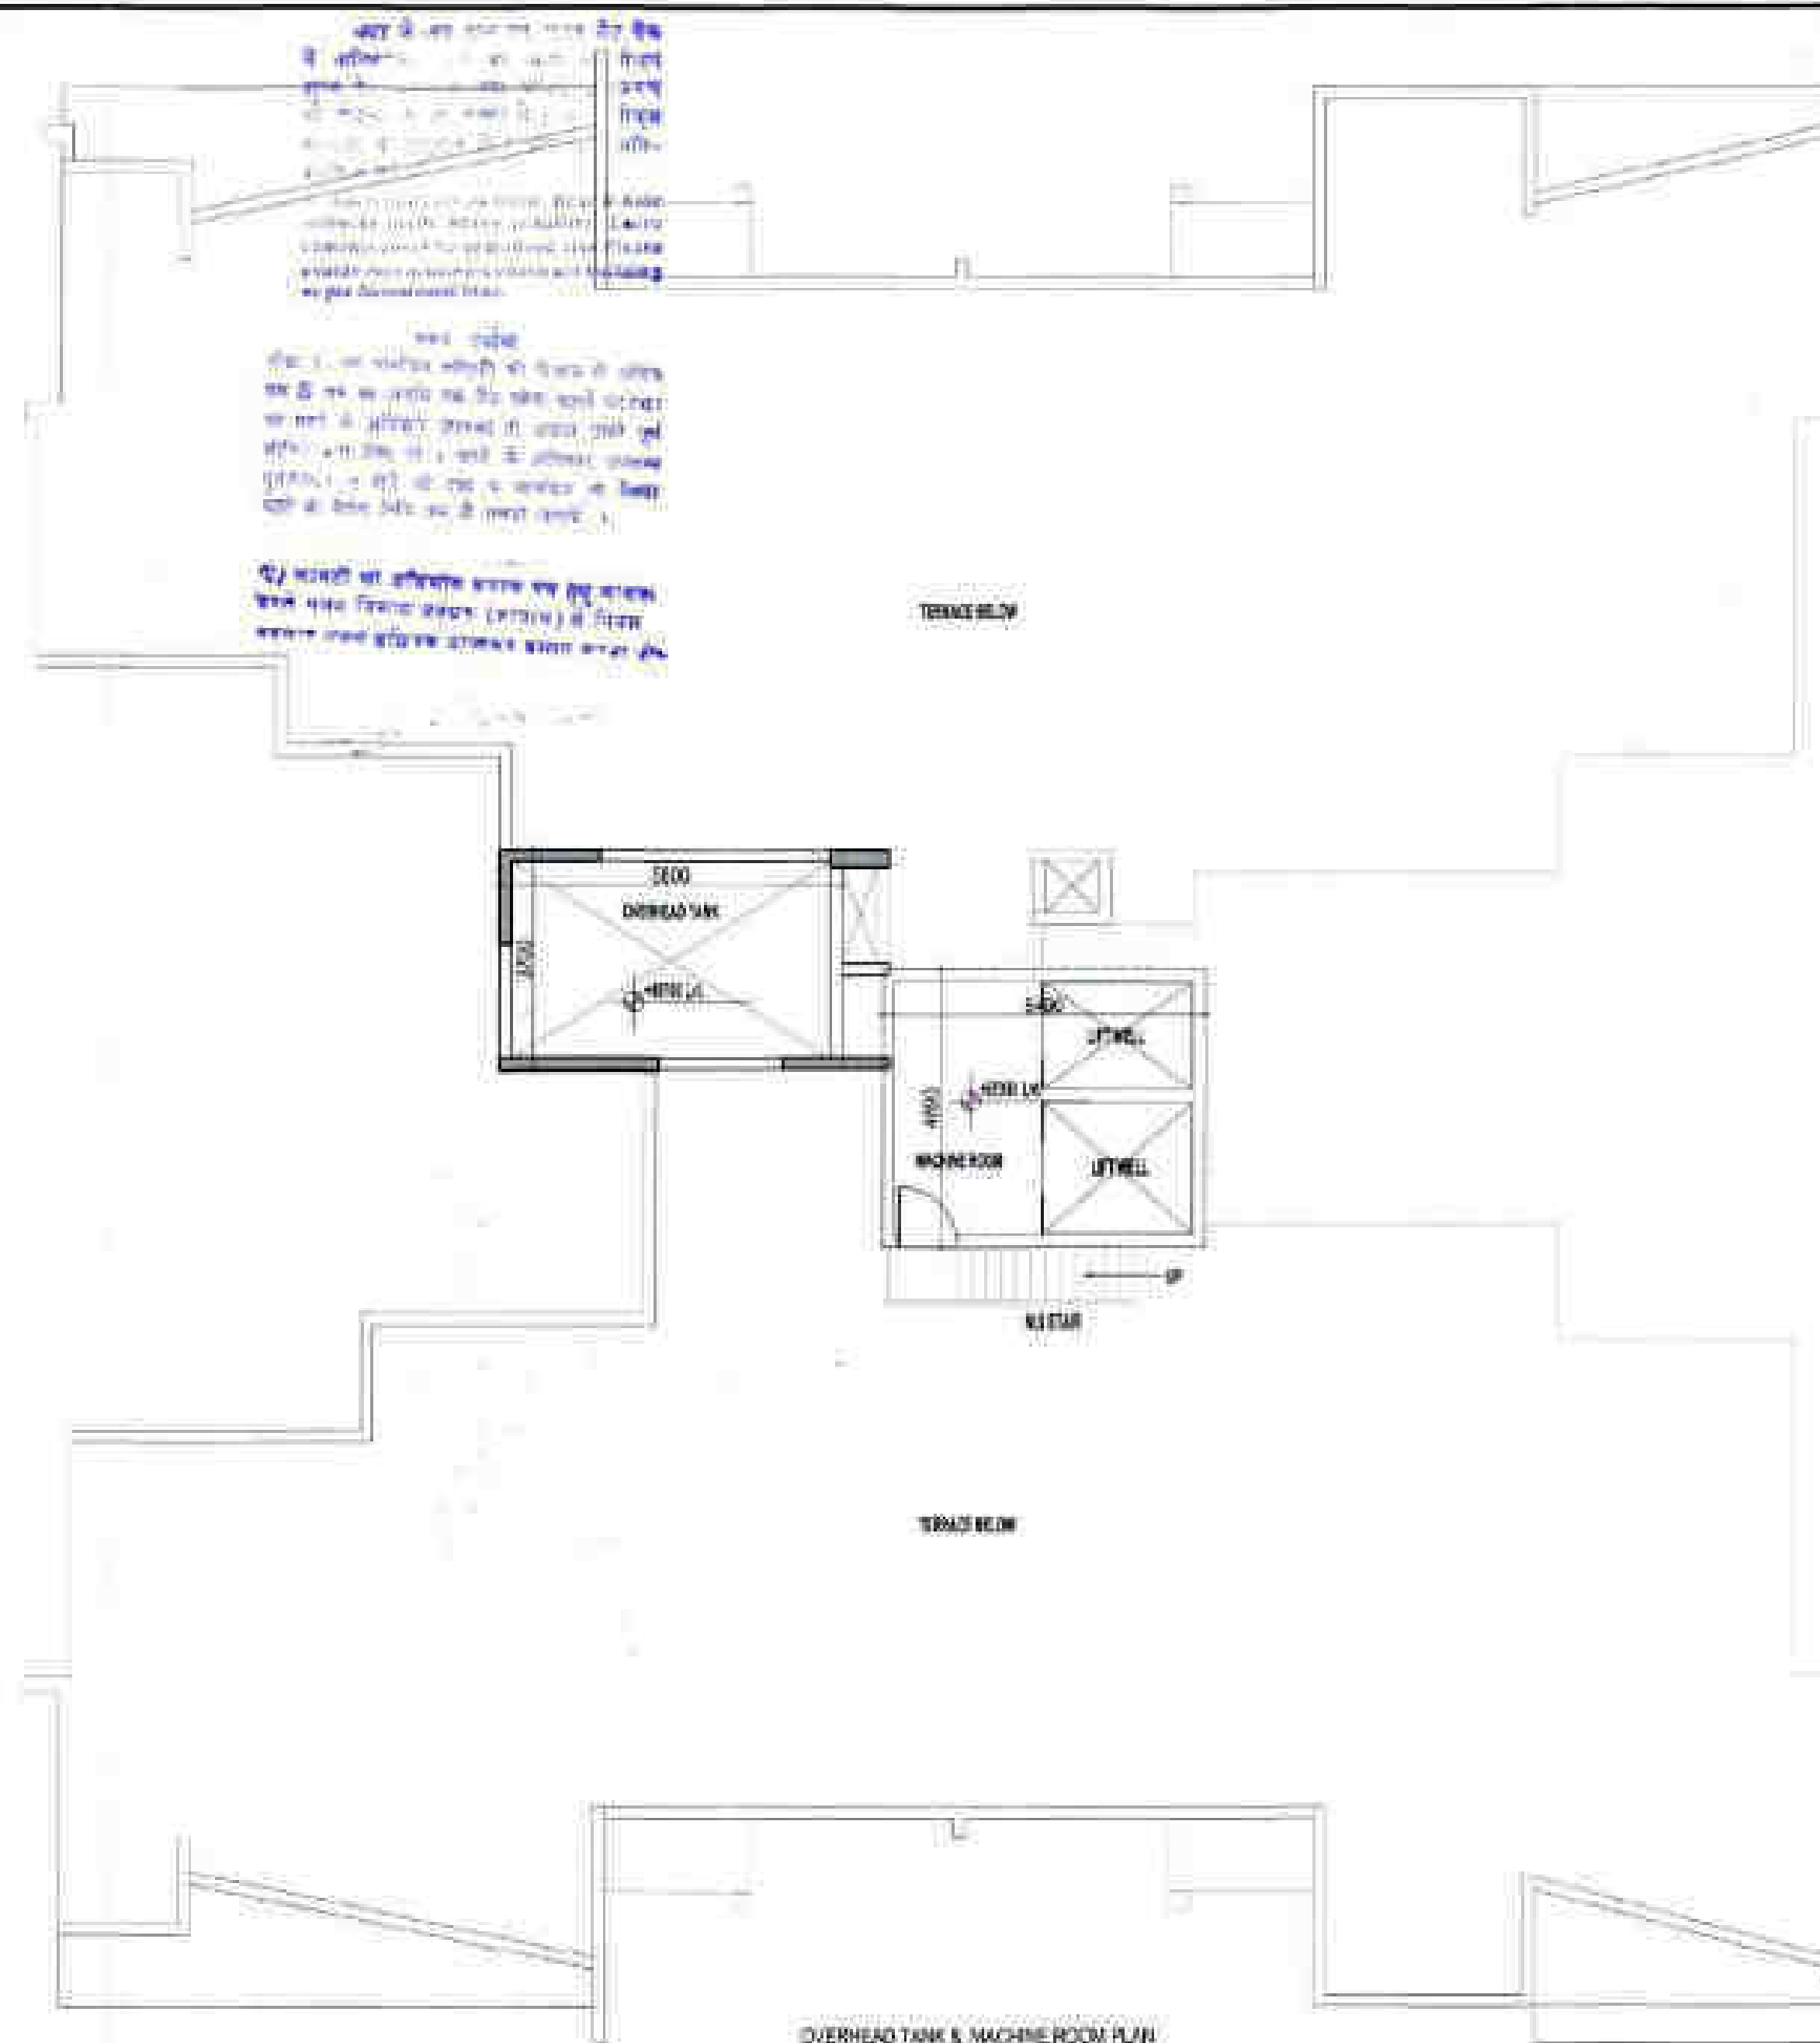

II-2024/1042/37/18

This drawing is a "CONCEPT" drawing of the building or part thereof and may not be used or reproduced without the permission of the Architect.

NO. OF SHEETS: 10
DATE: 10/04/2024
SHEET NO: 10
REVISION: 01/01/2024
DESIGNER: [Signature]
CHECKER: [Signature]
APPROVER: [Signature]

LEGEND

1. 1000 DC & VENT PIPE
2. 1000 WASTE & VENT PIPE
3. 1000 SANITARY PIPE
4. COLD WATER SUPPLY PIPE
5. HOT WATER SUPPLY PIPE
6. 750 SANITARY PIPE
7. FLOOR DRAIN (WASTE)
8. FLOOR TRAP (WASTE)
9. FLOOR DRAIN (WASTE)
10. FLOOR DRAIN (WASTE)
11. FLOOR DRAIN (WASTE)
12. FLOOR DRAIN (WASTE)
13. FLOOR DRAIN (WASTE)
14. FLOOR DRAIN (WASTE)
15. FLOOR DRAIN (WASTE)
16. FLOOR DRAIN (WASTE)
17. FLOOR DRAIN (WASTE)
18. FLOOR DRAIN (WASTE)
19. FLOOR DRAIN (WASTE)
20. FLOOR DRAIN (WASTE)

SCALE: 1/4" = 1'-0"

TERRACE FLOOR PLAN
TOWER-C4,C6

OWNER SIGN: [Signature]
ARCHITECT SIGN: [Signature]

TOWN PLANNER SIGN: [Signature]

TOWN PLANNER: [Signature]


CONFORMANCE

DATE: 10/04/2024
DRAWN BY: [Signature]
CHECKED BY: [Signature]
APPROVED BY: [Signature]

8-029


This drawing is available on www.confluence.com

III-2071/04/2/3/7/10

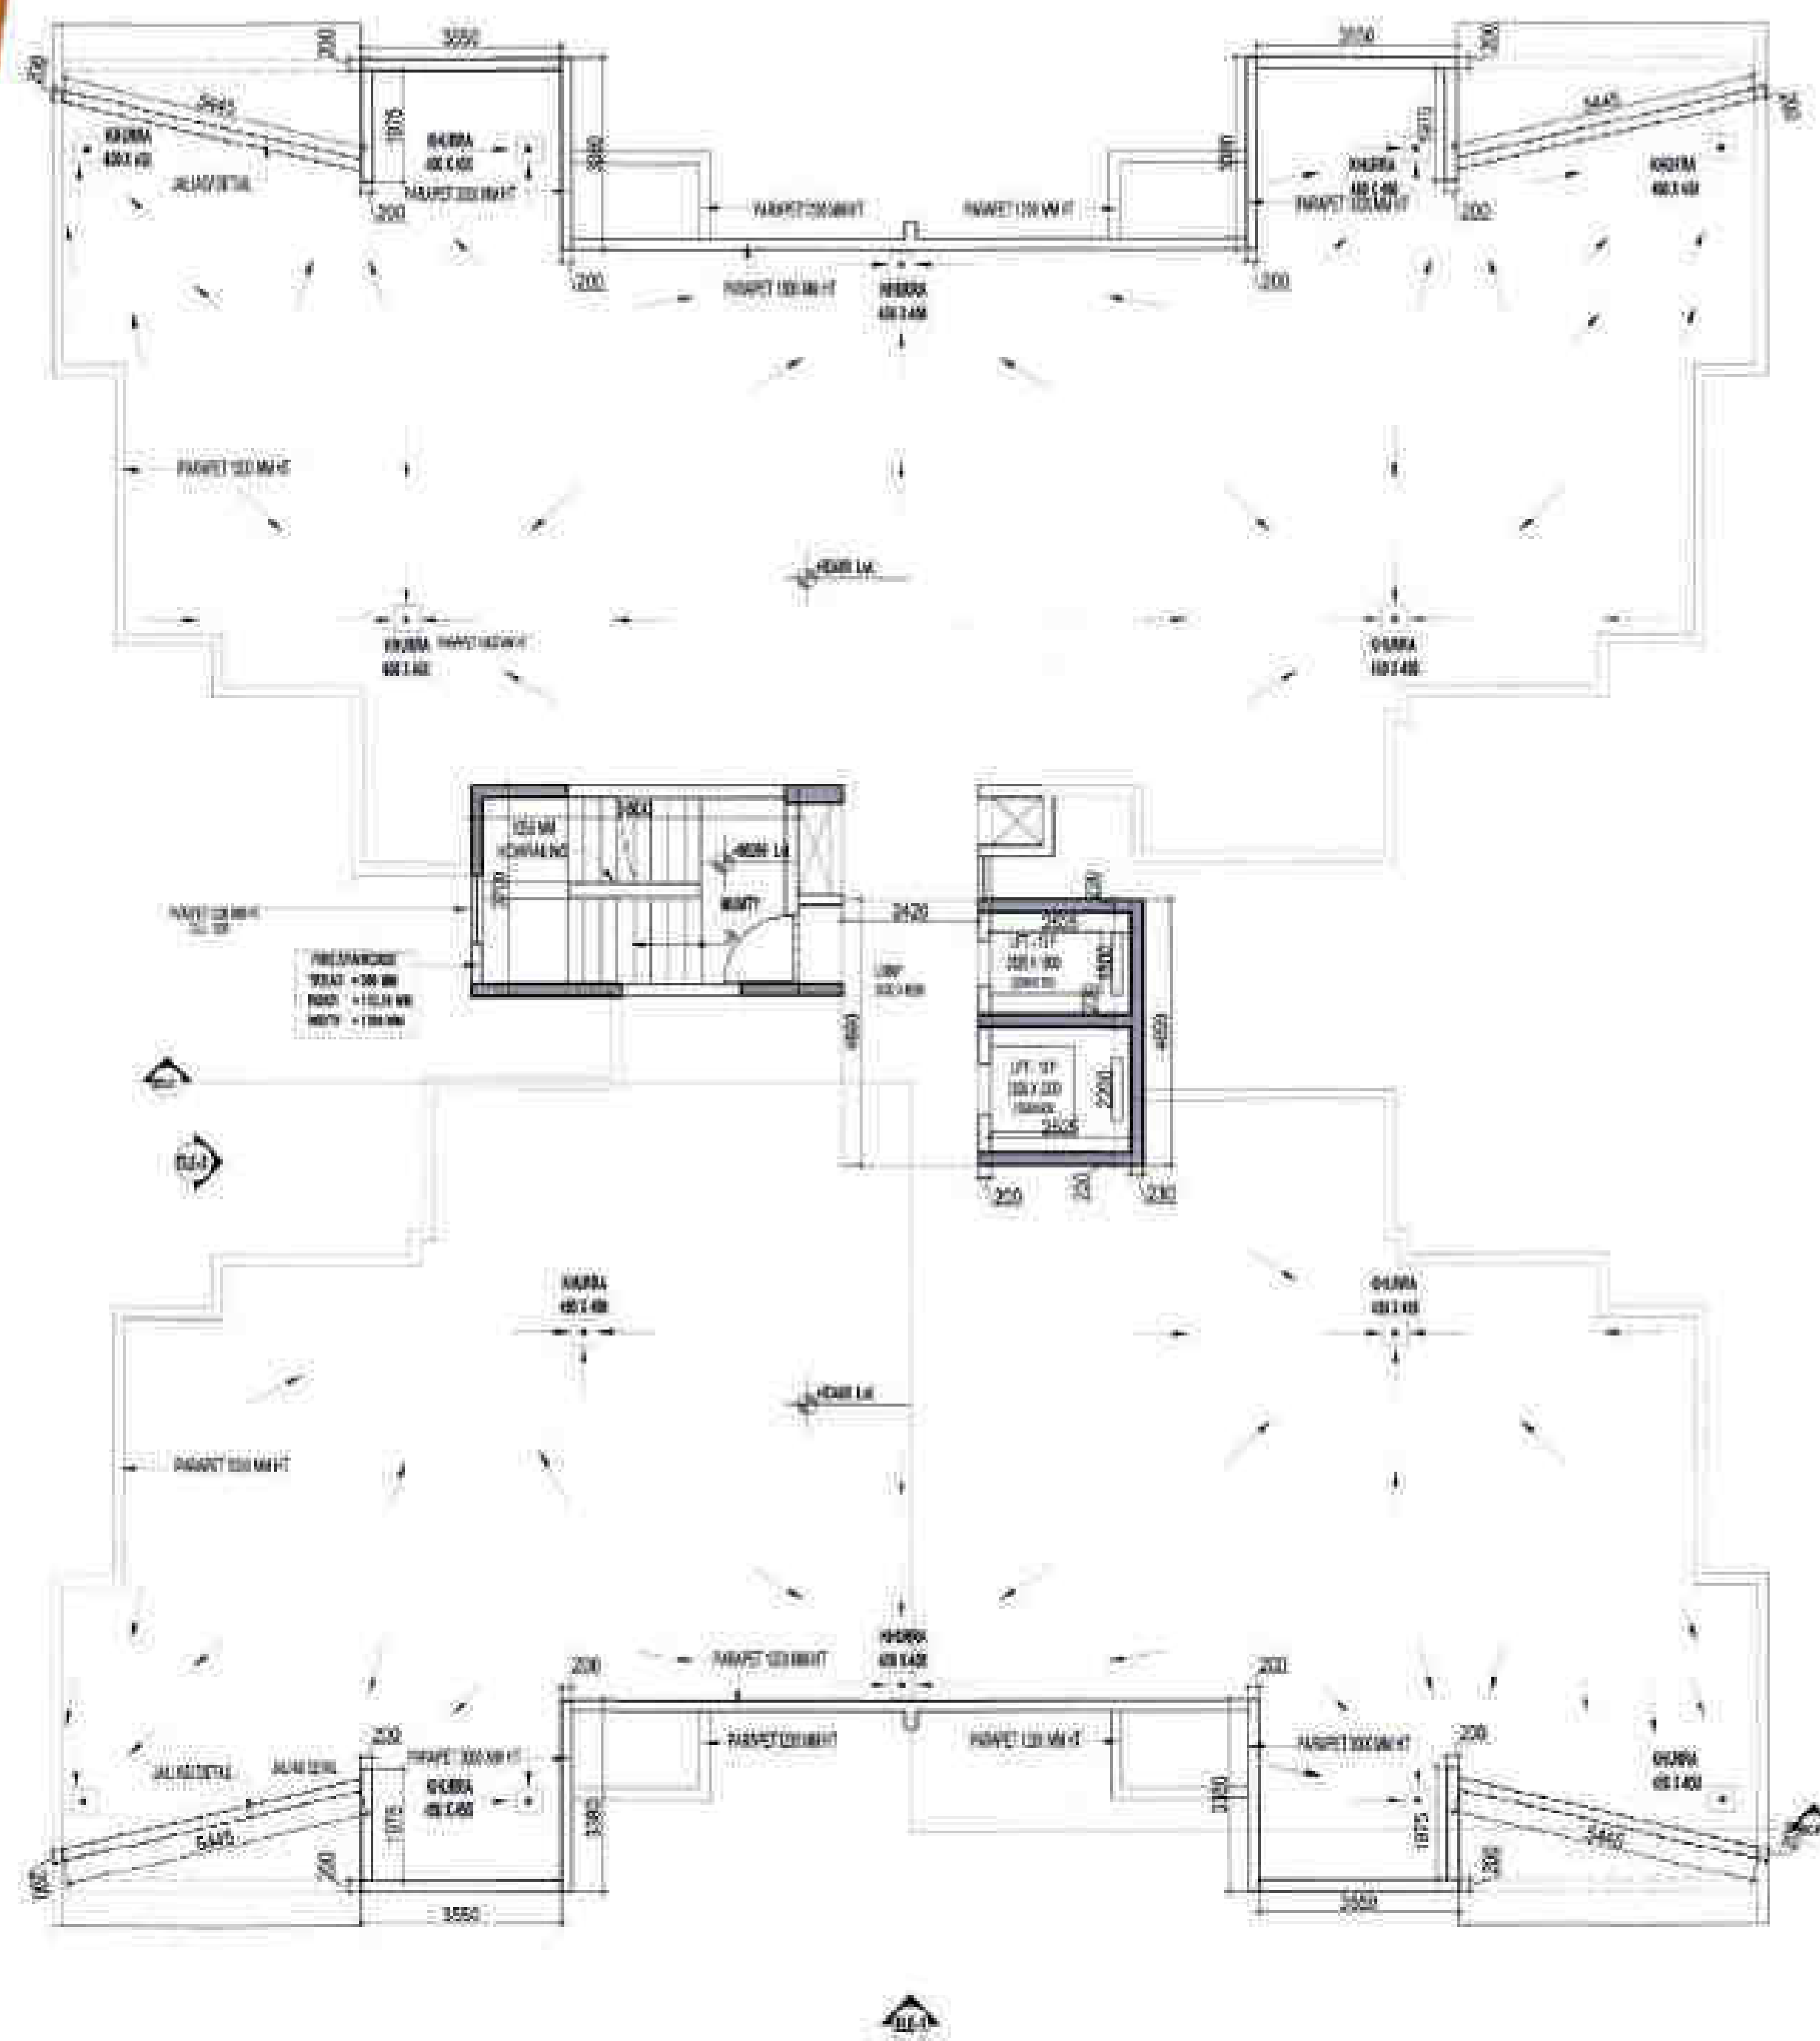

TOTAL F.A.R. AREA OF TERRACE FLOOR PLAN = 15.238 SQ.M

S. NO.	PARTICULARS					AREA (SQ.M)
1	4	3.44	X	0.200	-	4.324
2	4	1.575	X	0.200	-	1.580
3	4	3.532	X	0.200	-	3.842
4	4	0.200	X	0.200	-	0.200
TOTAL AREA						11.490


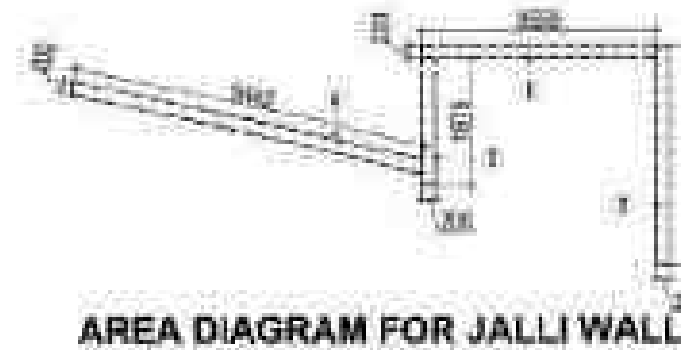


AREA DIAGRAM FOR JALLI WALL


F.A.R. COVERED AREA CALCULATION FOR TERRACE							
S.NO	PARTICULARS					AREA (SQ.M)	
TERRACE LIFT LOBBY AREA							
1			0.200	X	4.090	=	1.079
2	5		2.505	X	0.200	=	1.742
3			0.200	X	4.090	=	0.818
TOTAL F.A.R. AREA							3.759

AREA CALCULATION TOWARDS 15 % ADDITIONAL F.A.R AT TERRACE FLOOR						
S.NO	PARTICULARS					AREA (SQ.M)
TERRACE LIFT LOBBY AREA & FIRE STAIRCASE						
A	5.800	X	2.700	=		21.480
B	2.000	X	2.200	=		4.400
C	2.520	X	1.800	=		4.540
LIFT LOBBY						
D	1.400	X	4.090	=		11.526
TOTAL AREA						42.946


AREA CALCULATION TOWARDS 15% ADDITIONAL F.A.R. AT TERRACE FLOOR						
S.NO.	PARTICULARS					AREA (SQ.M)
AREA FOR WASHING ROOM						
E	2.480	X	4.190	=		20.748
AREA FOR OVERHEAD TANK						
F	2.800	X	3.120	=		21.480
TOTAL AREA						42.228

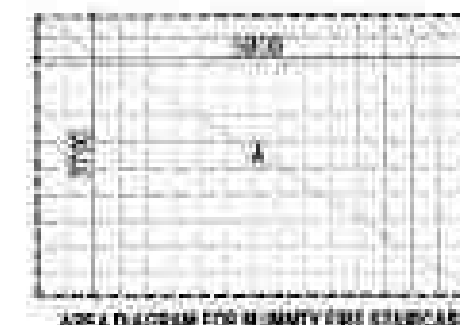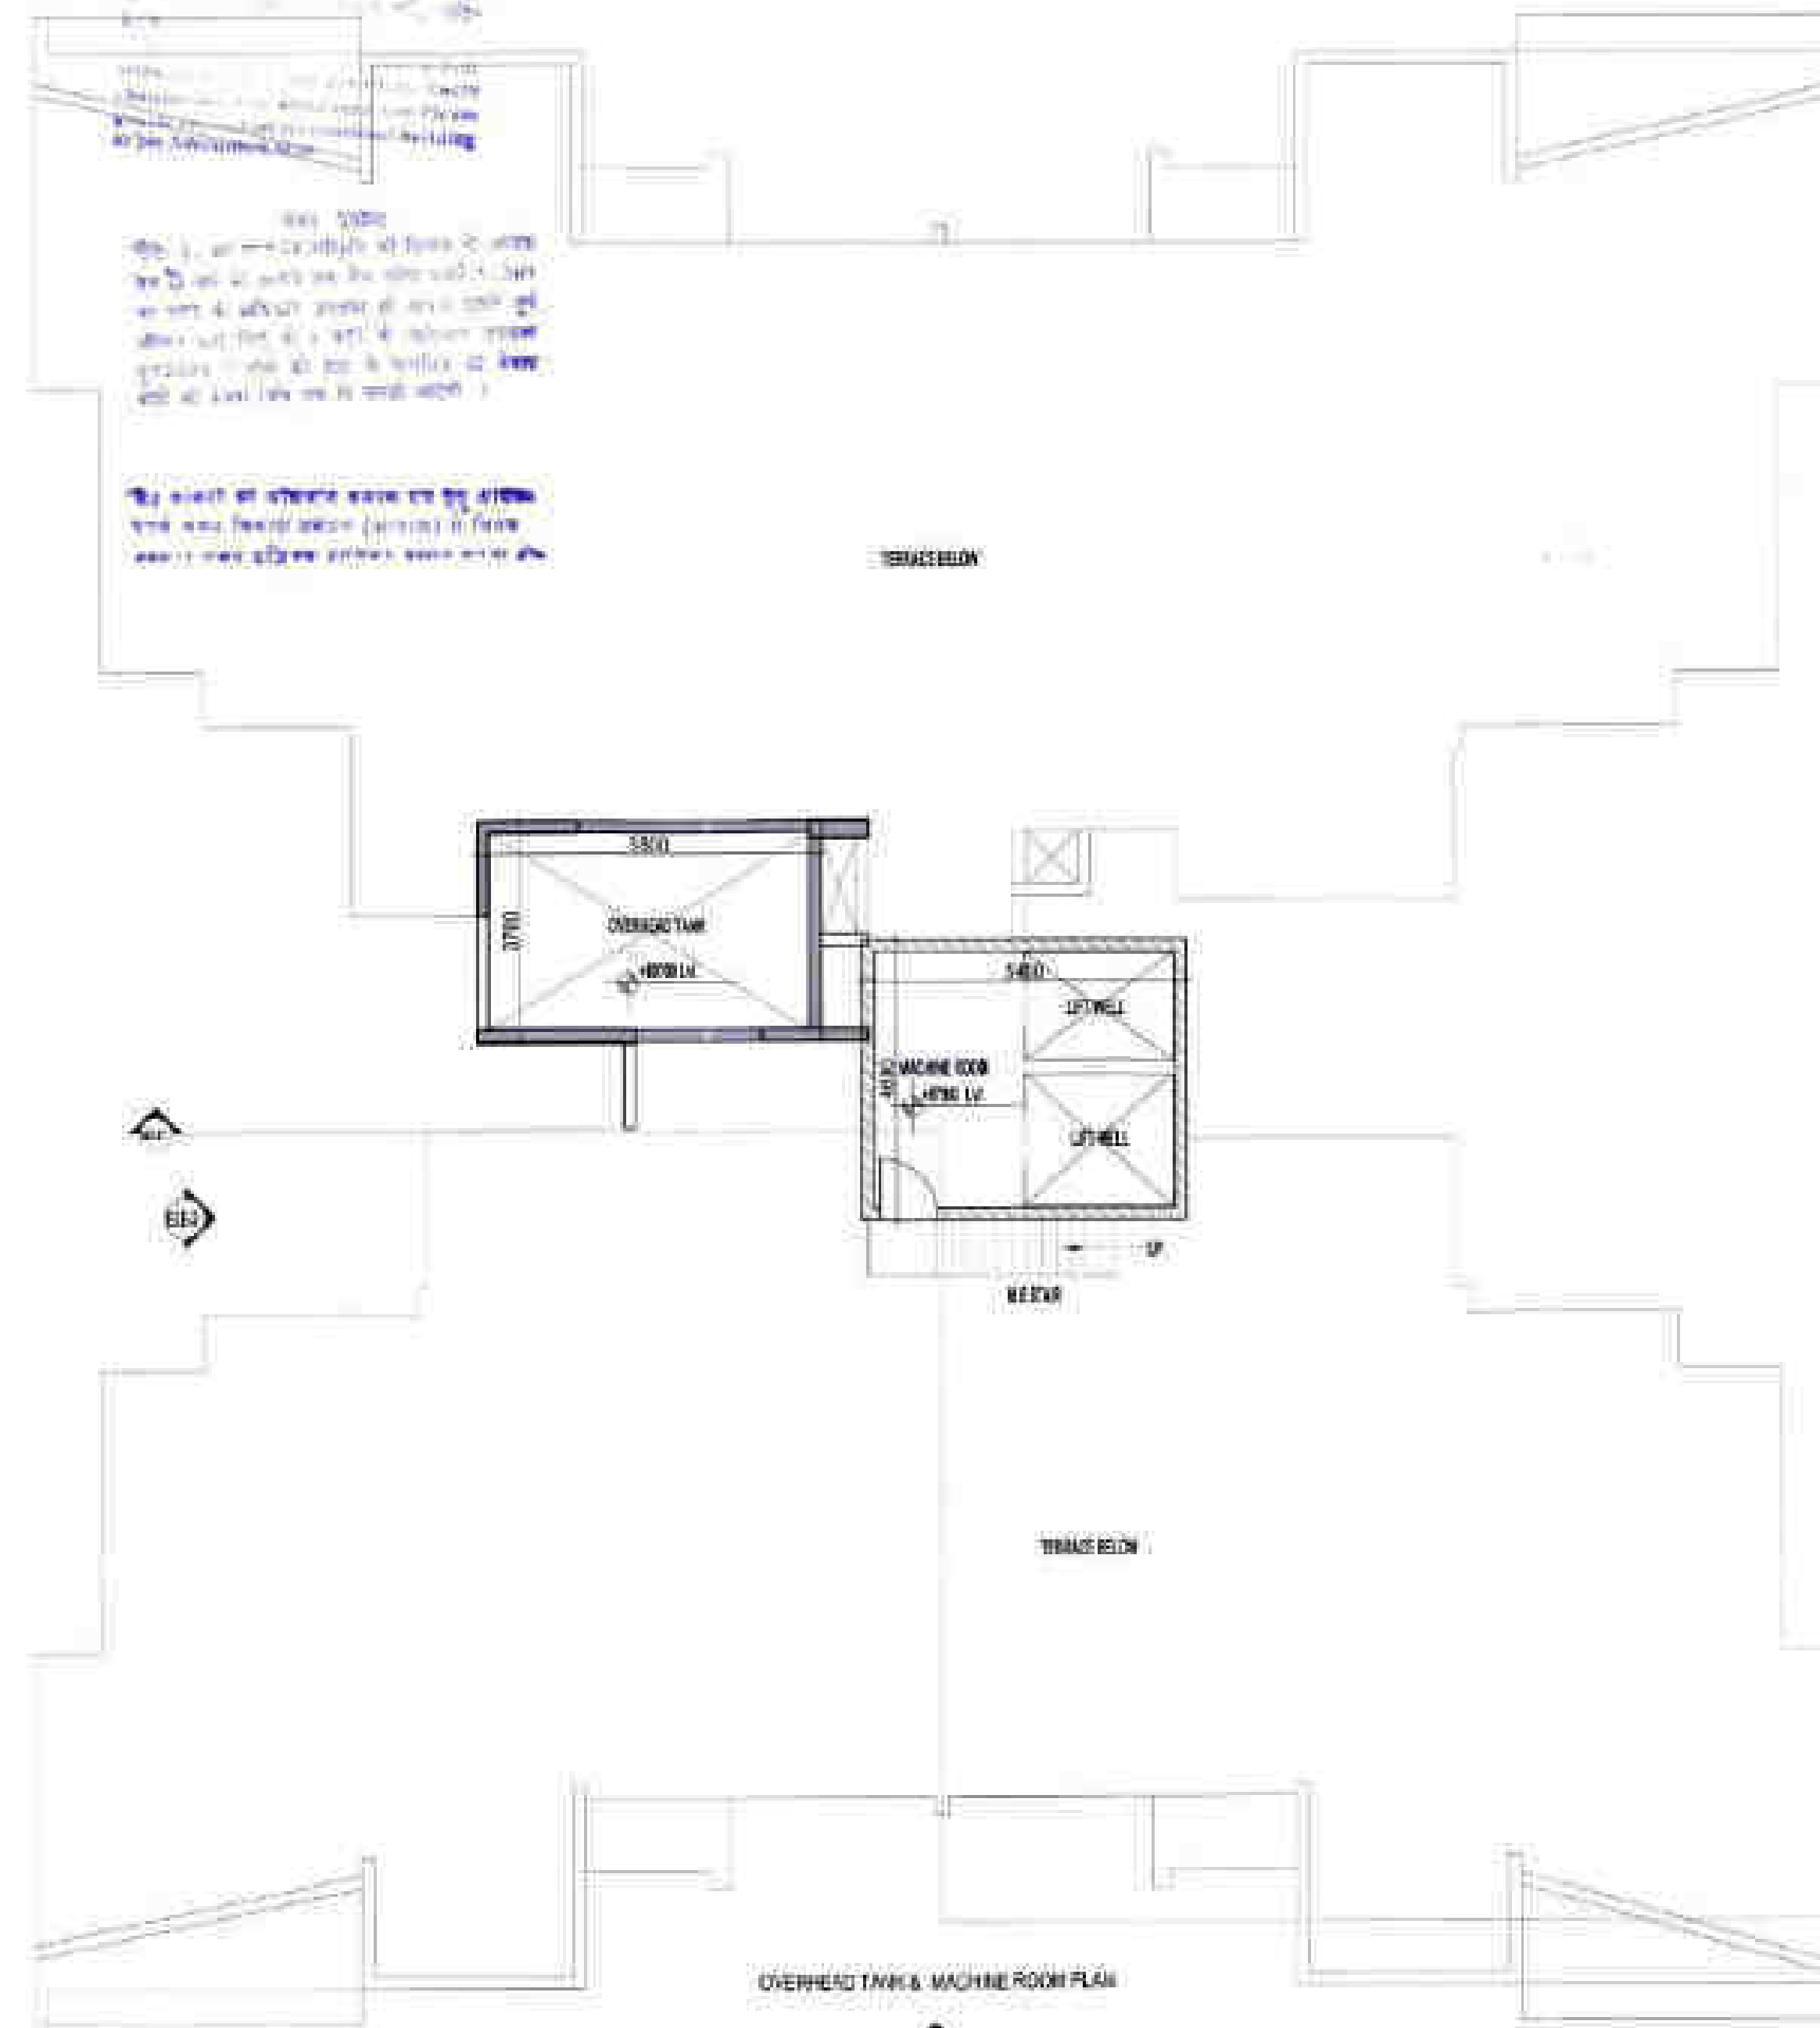

AREA DIAGRAM FOR MACHINE ROOM

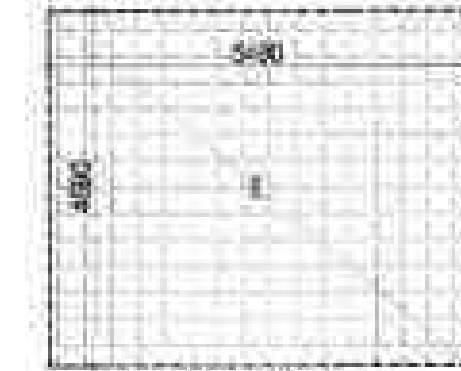

AREA DIAGRAM FOR OVERHEAD TANK

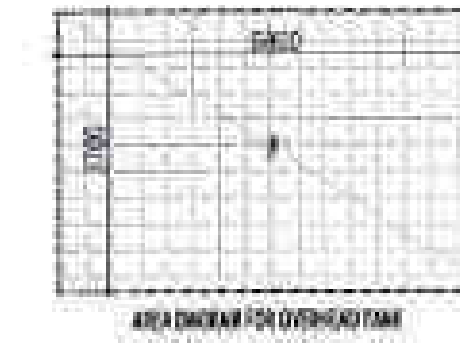

AREA DIAGRAM FOR LIFT & LIFT LOBBY



AREA DIAGRAM FOR LIFT & LIFT LOBBY

REVISIONS			
NO.	DATE	REVISION	BY
1	10/01/2010	ISSUED FOR PERMIT	ARCHITECT
2	10/01/2010	ISSUED FOR PERMIT	ARCHITECT
3	10/01/2010	ISSUED FOR PERMIT	ARCHITECT

SCHEDULE OF OPENINGS			
S. NO.	TYPE	WIDTH	HEIGHT
1	DOOR	200	200
2	DOOR	200	200
3	DOOR	200	200
4	DOOR	200	200
5	DOOR	200	200
6	DOOR	200	200
7	DOOR	200	200
8	DOOR	200	200
9	DOOR	200	200
10	DOOR	200	200

SCHEDULE OF OPENINGS FOR COMMON AREAS			
S. NO.	TYPE	WIDTH	HEIGHT
1	DOOR	200	200
2	DOOR	200	200
3	DOOR	200	200

AREA LEGEND			
1	AREA	15%	AREA
2	AREA	15%	AREA

SUBMISSION DRAWING			
1	AREA	15%	AREA
2	AREA	15%	AREA

IV COUNTY PVT. LTD.			
1	AREA	15%	AREA
2	AREA	15%	AREA

Cleo County			
1	AREA	15%	AREA
2	AREA	15%	AREA

TERRACE FLOOR PLAN			
1	AREA	15%	AREA
2	AREA	15%	AREA

OWNER SIGN			
1	AREA	15%	AREA
2	AREA	15%	AREA


TOWN PLANNER SIGN			
1	AREA	15%	AREA
2	AREA	15%	AREA

TOWN PLANNER			
1	AREA	15%	AREA
2	AREA	15%	AREA


CONFLUENCE			
1	AREA	15%	AREA
2	AREA	15%	AREA

S-207			
1	AREA	15%	AREA
2	AREA	15%	AREA

THIS DRAWING IS AVAILABLE ON WWW.BLR.ACCIDENTS.COM			
1	AREA	15%	AREA
2	AREA	15%	AREA

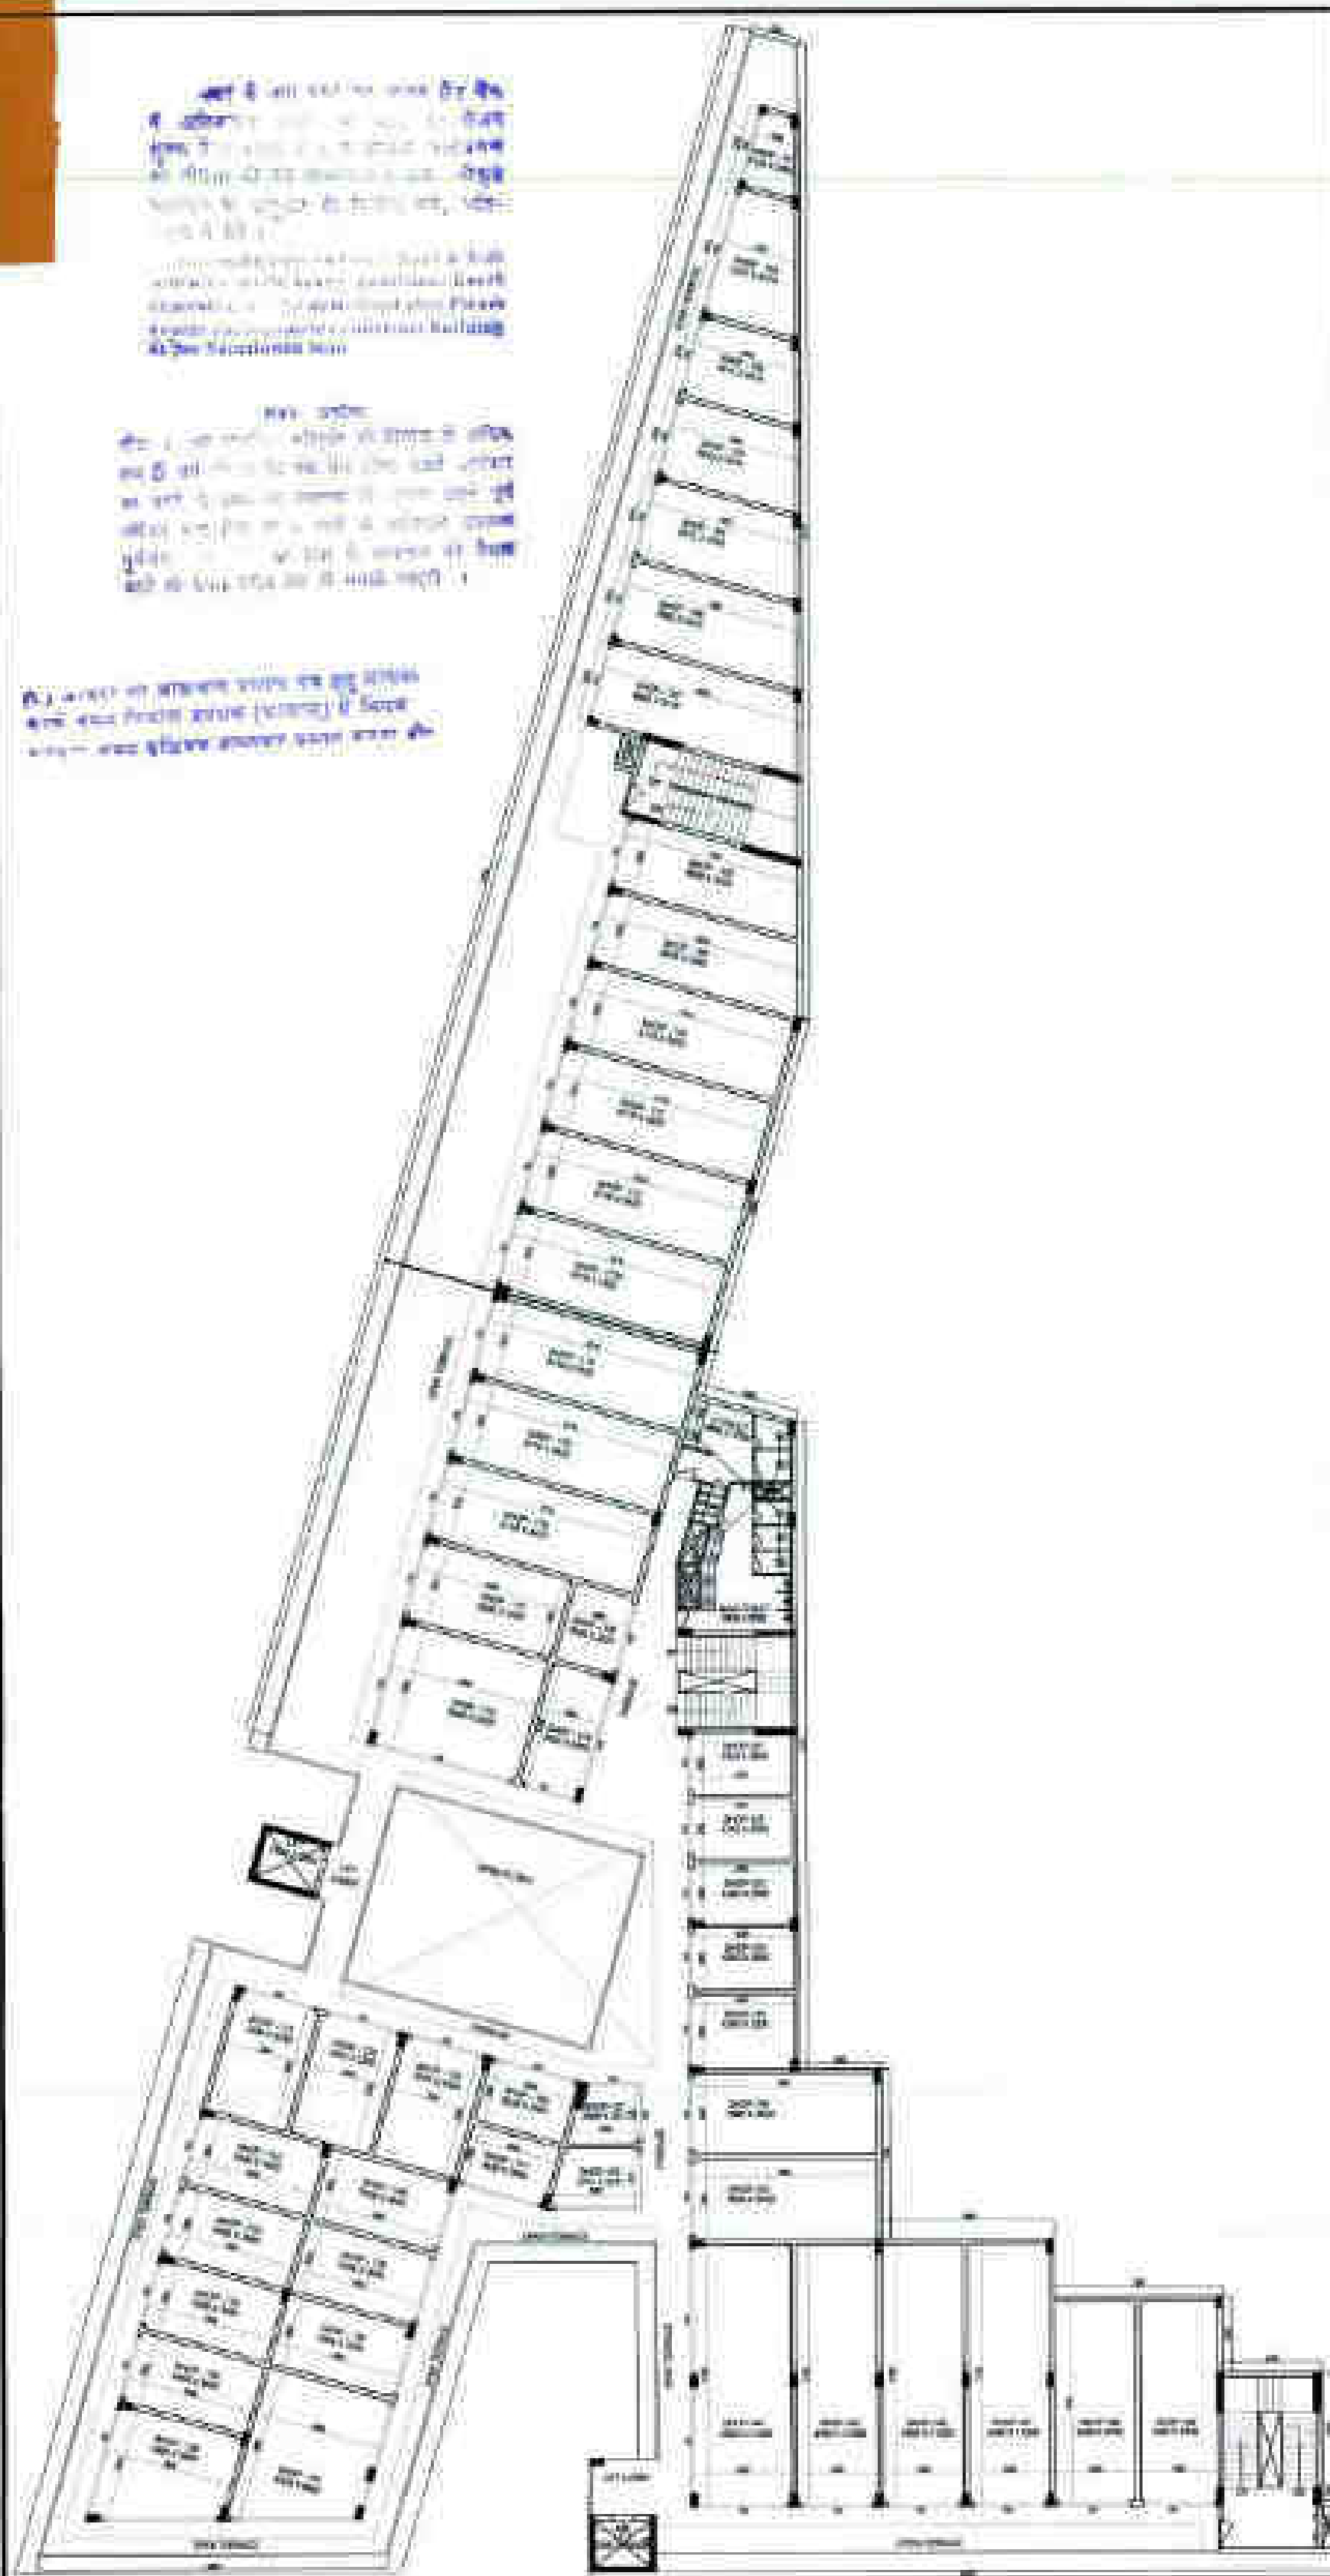

(1) FIRST FLOOR PLAN

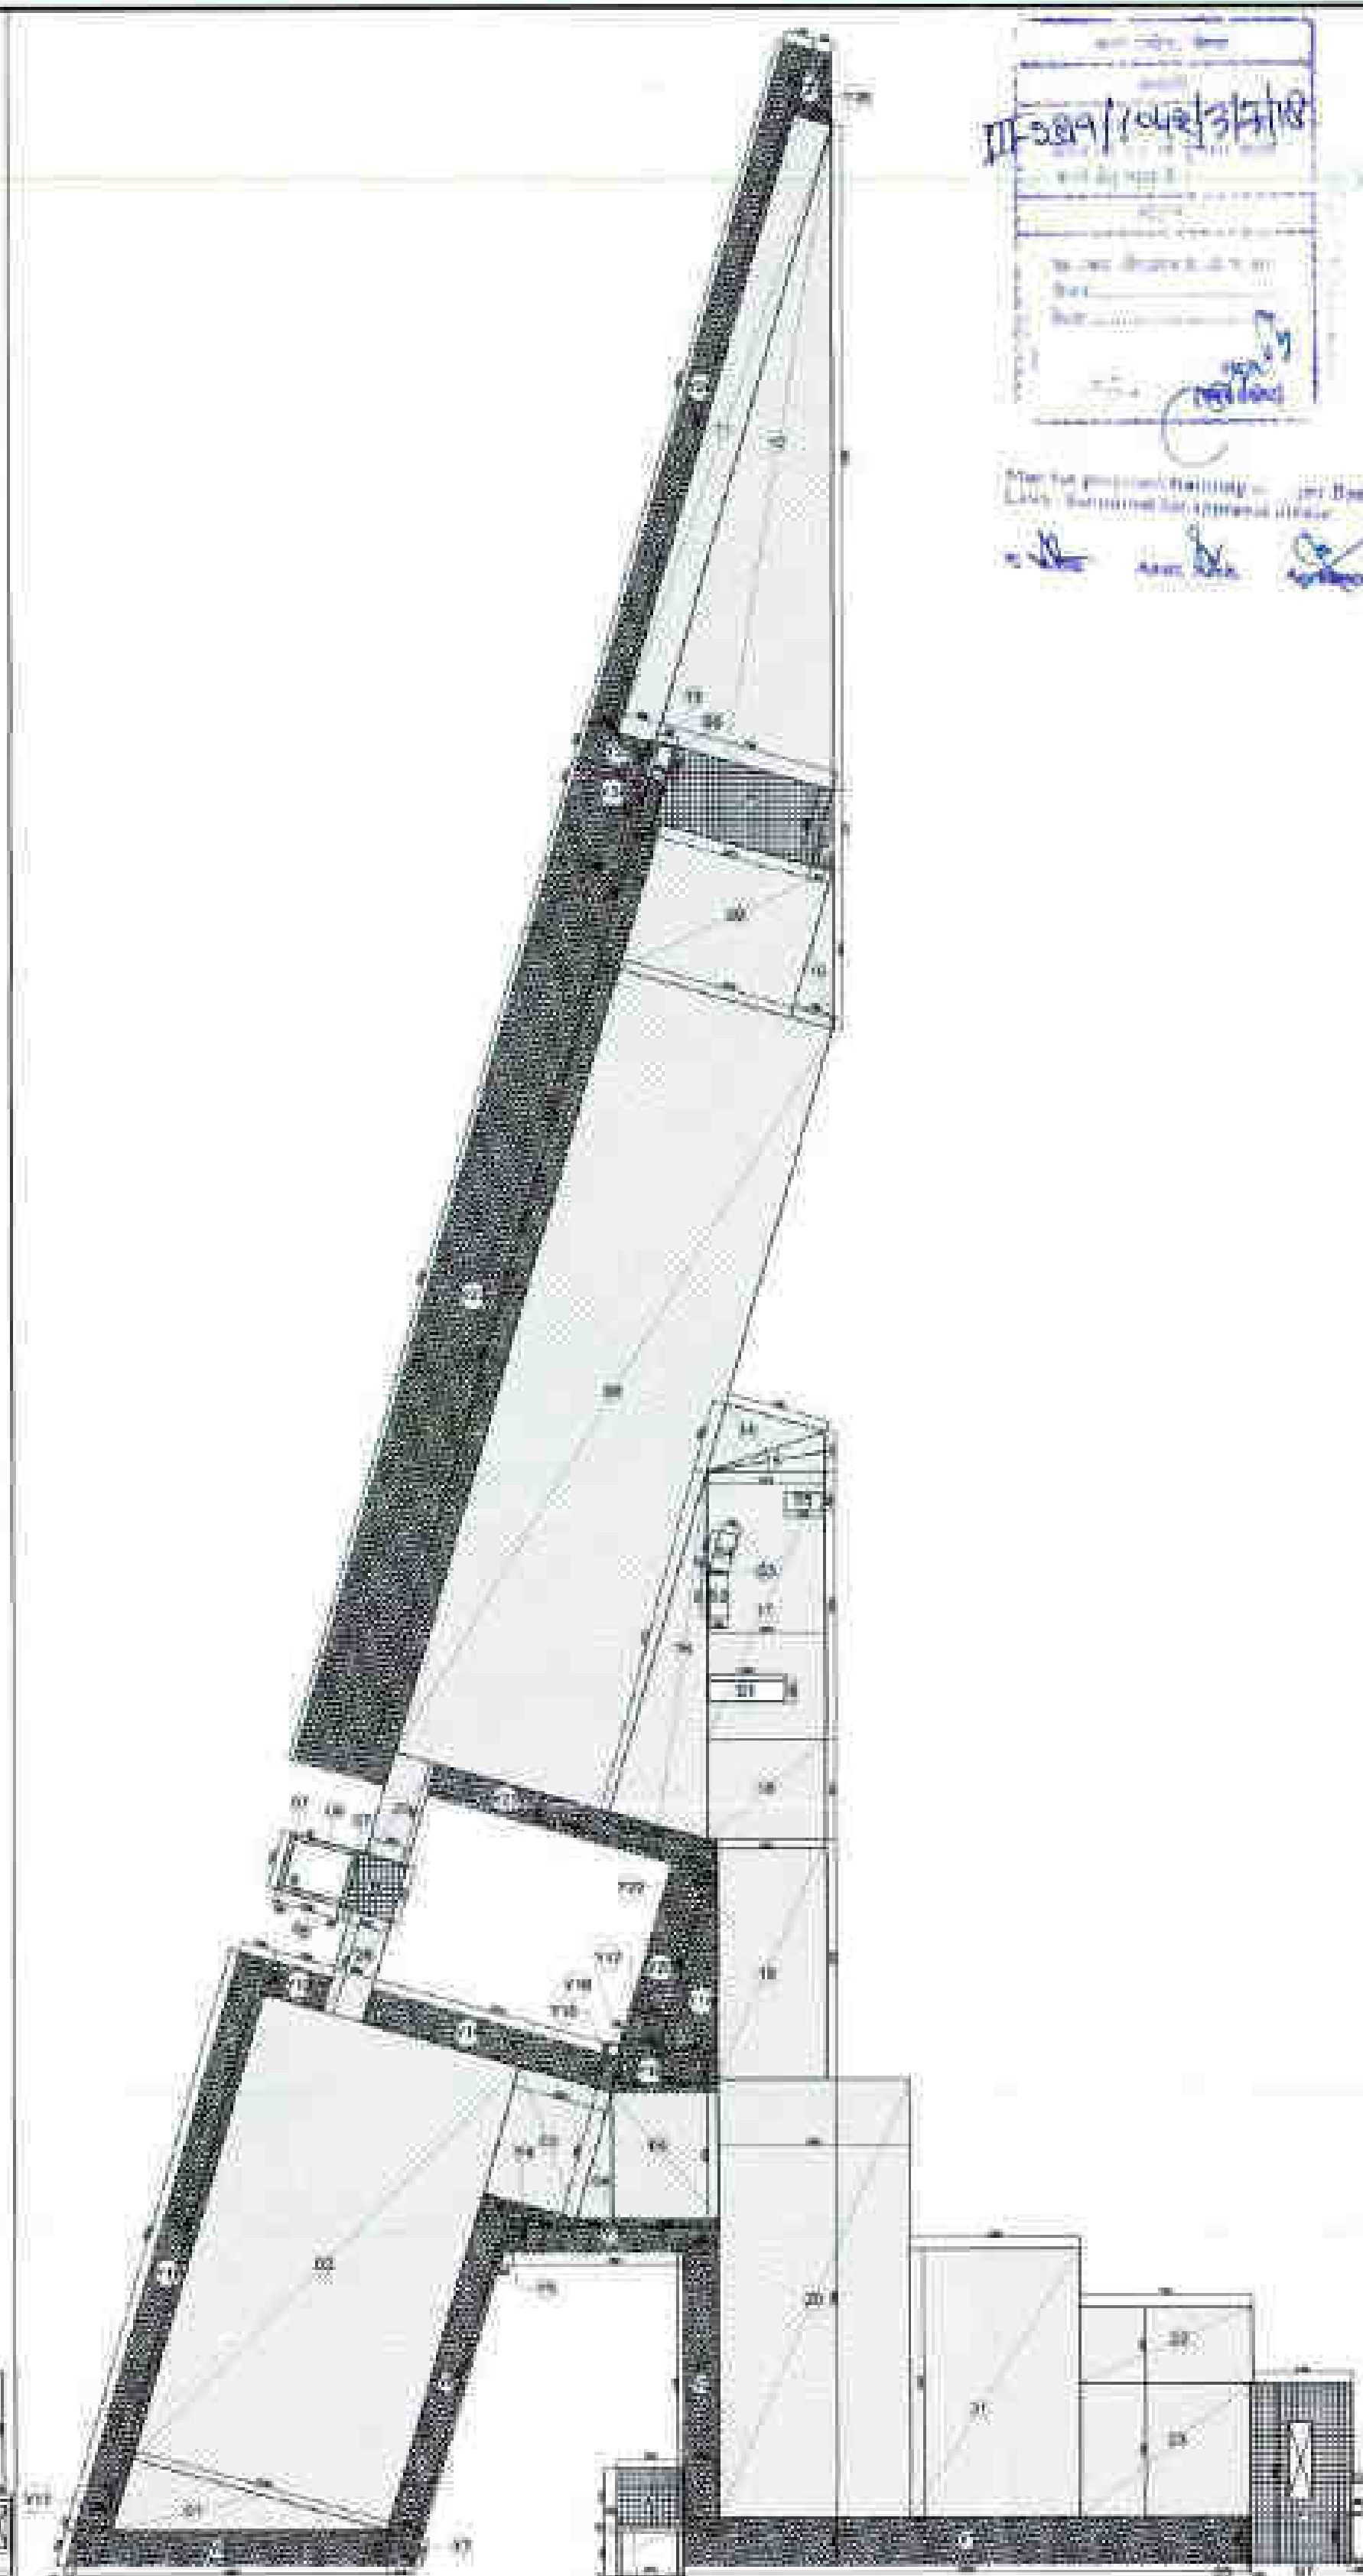

(2) FIRST FLOOR AREA DIAGRAM

F.A.R. COVERED AREA CALCULATION FOR FIRST FLOOR

S.NO.	0.5	X	PARTICULARS	AREA(SQ.M)
1	0.5	X	11.301	18.144
2			11.301	233.479
3			4.035	22.798
4	0.5	X	1.545	4.365
5			2.486	13.511
6	2	X	2.550	1.173
7	2	X	2.510	1.155
8			9.416	328.411
9			9.416	60.884
10	0.5	X	1.866	6.370
11			1.666	45.793
12	0.5	X	7.786	110.845
13			0.906	1.450
14	0.5	X	4.381	6.699
15	0.5	X	5.050	4.401
16	0.5	X	4.312	32.707
17			5.050	58.221
18			5.050	21.417
19			5.050	51.808
20			8.150	153.220
21			7.300	83.950
22			7.300	23.725
23			7.300	41.975
24			0.900	1.980
25			0.100	0.200
26			2.810	0.646
27			1.950	0.449
28			1.800	5.100
29			1.800	8.086
TOTAL AREA (A)				1345.960
SUBTRACTION				
S1			3.300	3.300
S2			0.800	1.452
S3	0.5	X	0.800	0.091
S4			0.800	1.294
S5			1.500	0.990
S6			0.600	0.780
S7			0.600	1.077
TOTAL AREA (B)				8.983
TOTAL F.A.R. (A-B)				1336.976

NON F.A.R. AREA OF BALCONY

Y1			24.05	X	2.000	=	48.100
Y2			1.500	X	11.4	=	17.100
Y3			8.667	X	1.431	=	12.402
Y4	0.5	X	2.635	X	0.75	=	0.988
Y5	0.5	X	0.407	X	1.431	=	0.291
Y6			1.5	X	15.004	=	22.506
Y7	0.5	X	1.135	X	1.5	=	0.851
Y8	0.5	X	1.135	X	1.5	=	0.851
Y9			13.307	X	1.5	=	19.961
Y10	0.5	X	0.425	X	1.559	=	0.331
Y11	0.5	X	1.5	X	0.452	=	0.339
Y12			1.5	X	20.66	=	30.990
Y13			2.585	X	1.5	=	3.878
Y14			10.747	X	1.5	=	16.121
Y15	0.5	X	0.386	X	1.5	=	0.290
Y16			0.209	X	0.545	=	0.114
Y17	0.5	X	1.917	X	0.545	=	0.522
Y18			4.076	X	1.442	=	5.878
Y19	0.5	X	2.082	X	8.056	=	8.386
Y20			2.105	X	8.056	=	16.958
Y21			12.345	X	1.400	=	17.283
Y22	0.5	X	0.398	X	1.4	=	0.279
Y23			4.085	X	42.744	=	174.609
Y24			3.73	X	1.85	=	6.901
Y25			2.94	X	1.5	=	4.410
Y26			1.25	X	27.487	=	34.359
Y27			0.84	X	2.924	=	2.456
Y28			0.825	X	2.924	=	2.412
TOTAL AREA							449.565
AREA CALCULATION TOWARDS 15% ADDITIONAL F.A.R AT FIRST FLOOR							
A			2.81	X	2.450	=	6.885
B			2.1	X	2.510	=	5.271
C			6.873	X	3.351	=	23.031
D			0.106	X	1.750	=	0.186
E	0.5		0.924	X	3.377	=	1.560
F			4.18	X	7.750	=	32.395
TOTAL AREA							69.328

NORTH POINT

THE DRAWING IS A COMPUTER GENERATED DRAWING AND NOT A PHOTOGRAPH. IT IS NOT TO BE USED FOR ANY OTHER PURPOSE WITHOUT THE PERMISSION OF THE ARCHITECT.

DATE: 10/04/2018

BY: [Signature]

FOR: [Signature]

REVISIONS

NO.	DATE	DESCRIPTION	BY

GENERAL NOTE:

1. ALL DIMENSIONS ARE IN METERS UNLESS OTHERWISE SPECIFIED.

2. THE DRAWING IS A PRELIMINARY DRAWING.

AREA LEGEND

NO.	DESCRIPTION
1	FLOOR AREA
2	FLOOR AREA
3	FLOOR AREA
4	FLOOR AREA
5	FLOOR AREA
6	FLOOR AREA
7	FLOOR AREA
8	FLOOR AREA
9	FLOOR AREA
10	FLOOR AREA
11	FLOOR AREA
12	FLOOR AREA
13	FLOOR AREA
14	FLOOR AREA
15	FLOOR AREA
16	FLOOR AREA
17	FLOOR AREA
18	FLOOR AREA
19	FLOOR AREA
20	FLOOR AREA
21	FLOOR AREA
22	FLOOR AREA
23	FLOOR AREA
24	FLOOR AREA
25	FLOOR AREA
26	FLOOR AREA
27	FLOOR AREA
28	FLOOR AREA
29	FLOOR AREA

KEY PLAN

SUBMISSION DRAWING

DATE: 10/04/2018

BY: [Signature]

FOR: [Signature]

OWNER SIGN


ARCHITECT SIGN

TOWN PLANNER SIGN


TOWN PLANNER

CONFORMANCE

CONFORMANCE WITH THE REQUIREMENTS OF THE TOWN AND COUNTRY PLANNING ACT, 1973.

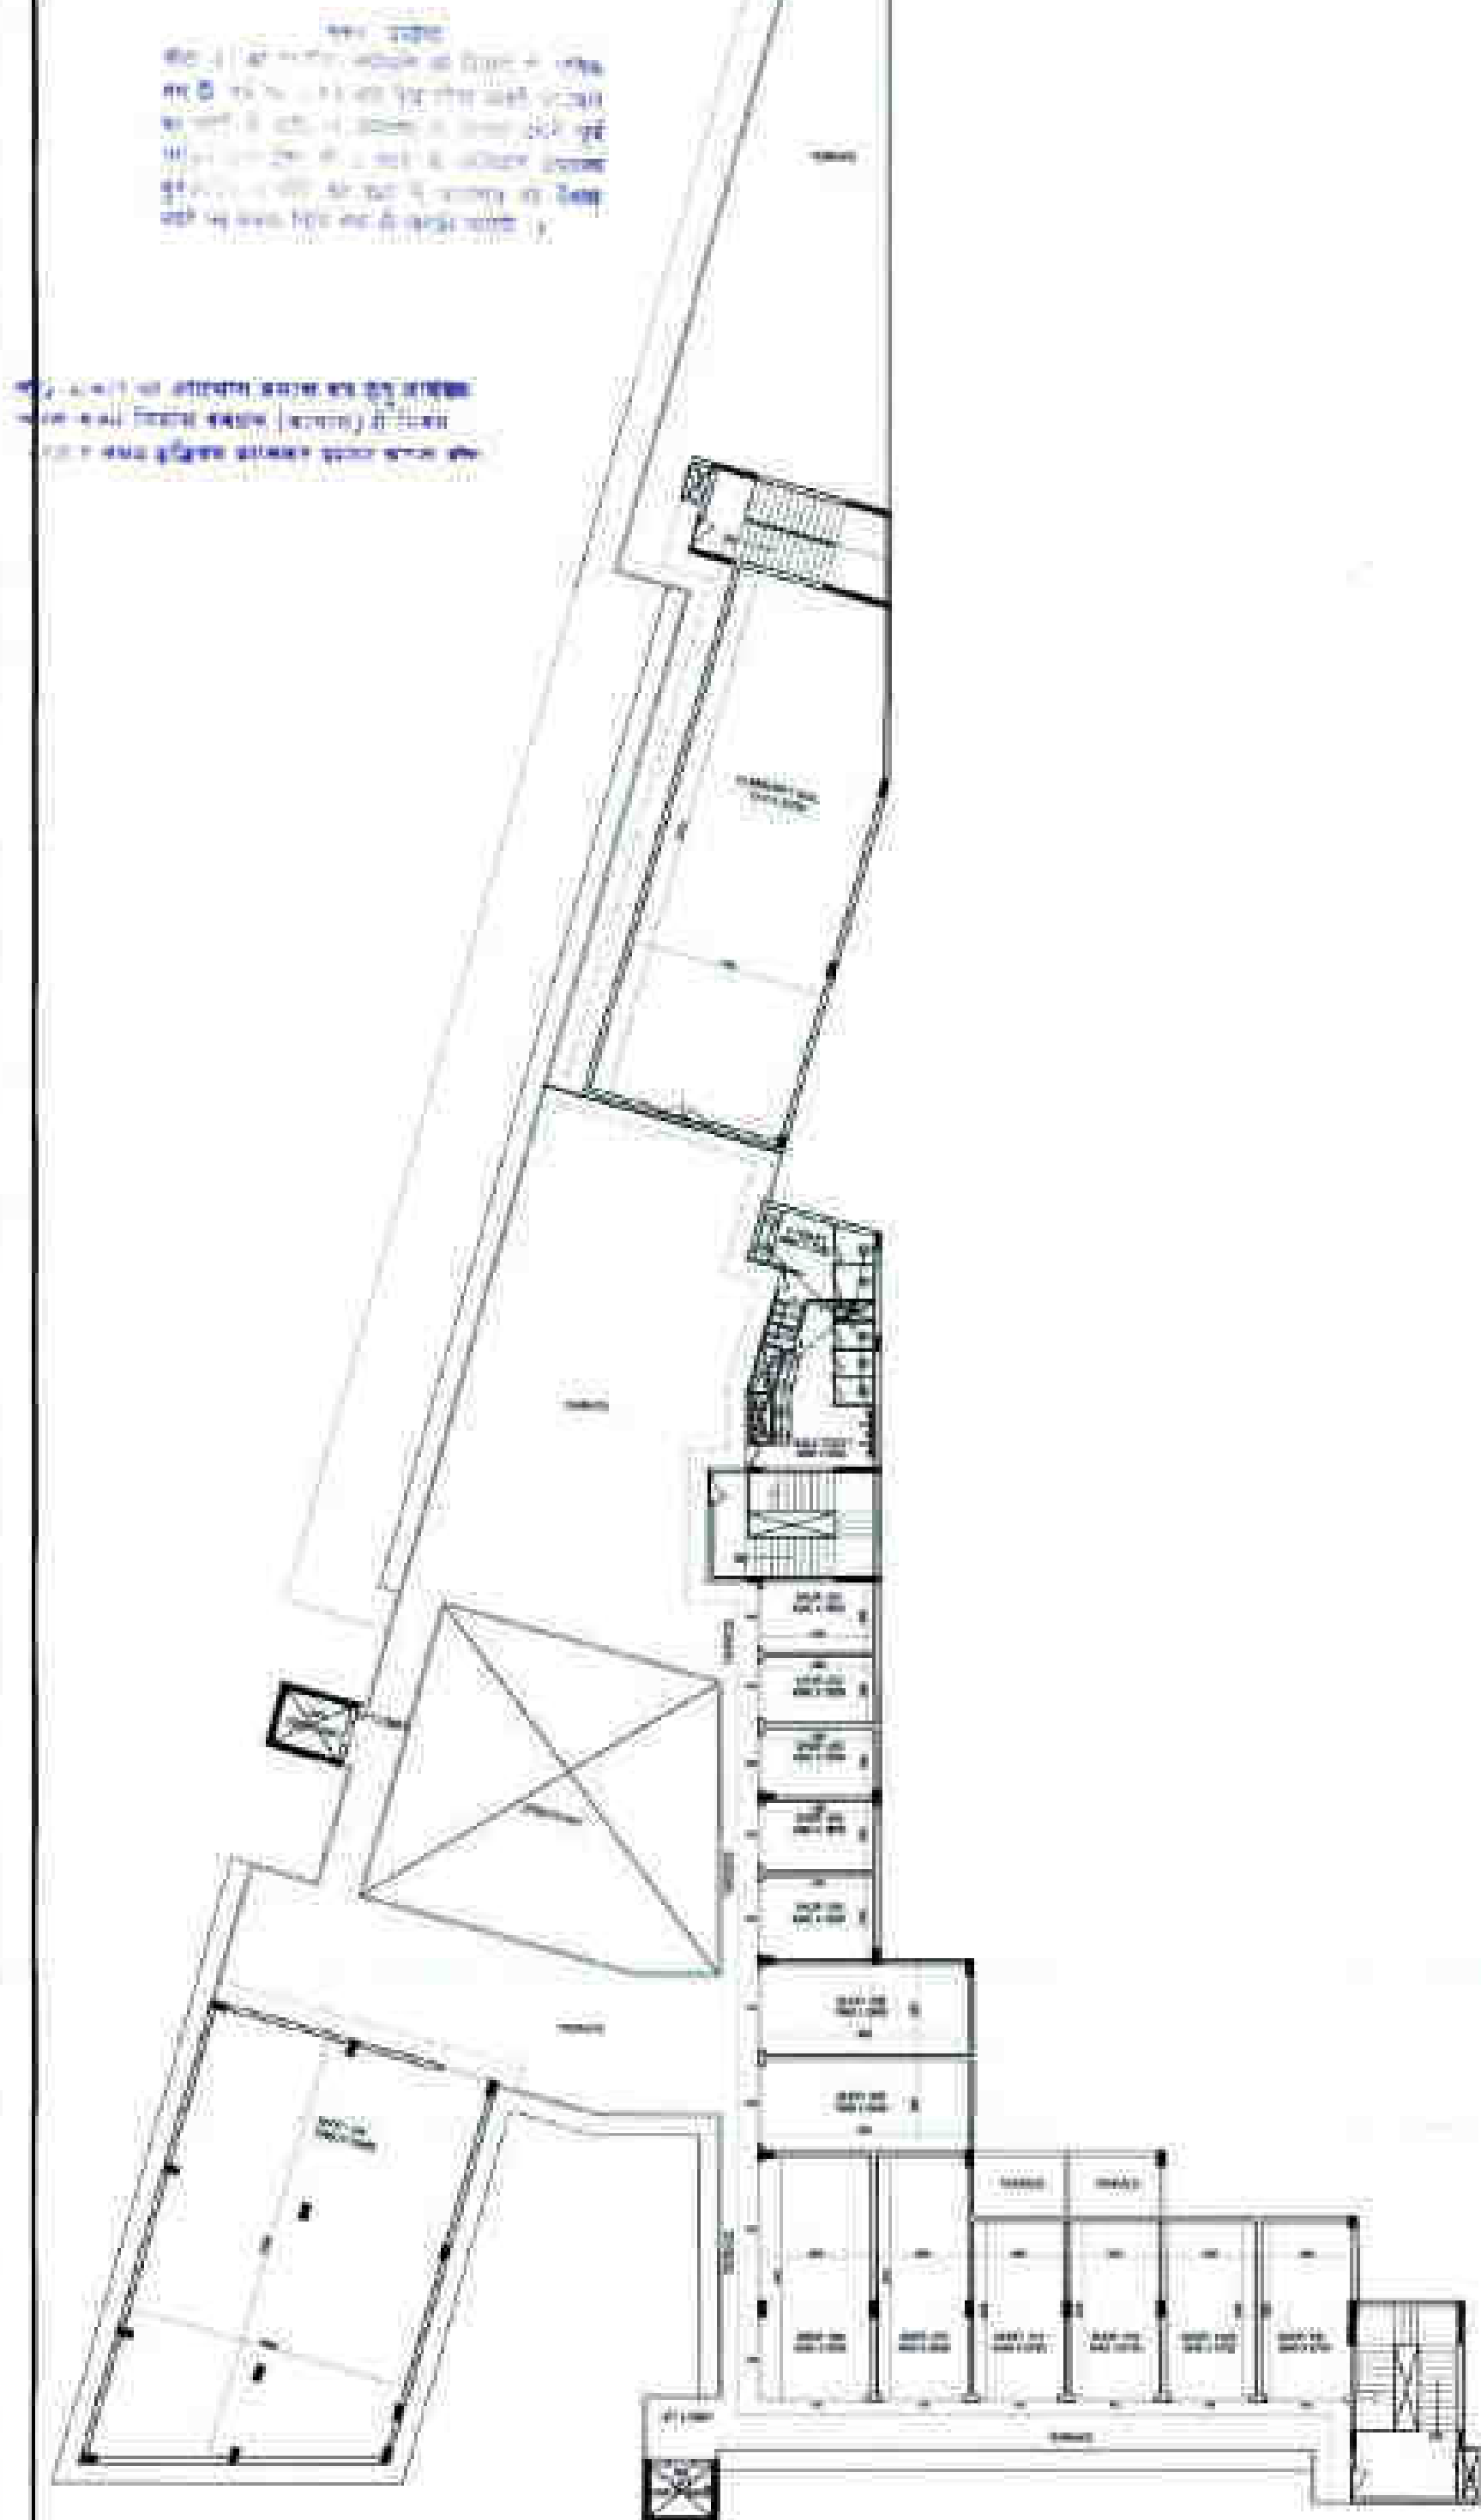

11) SECOND FLOOR PLAN

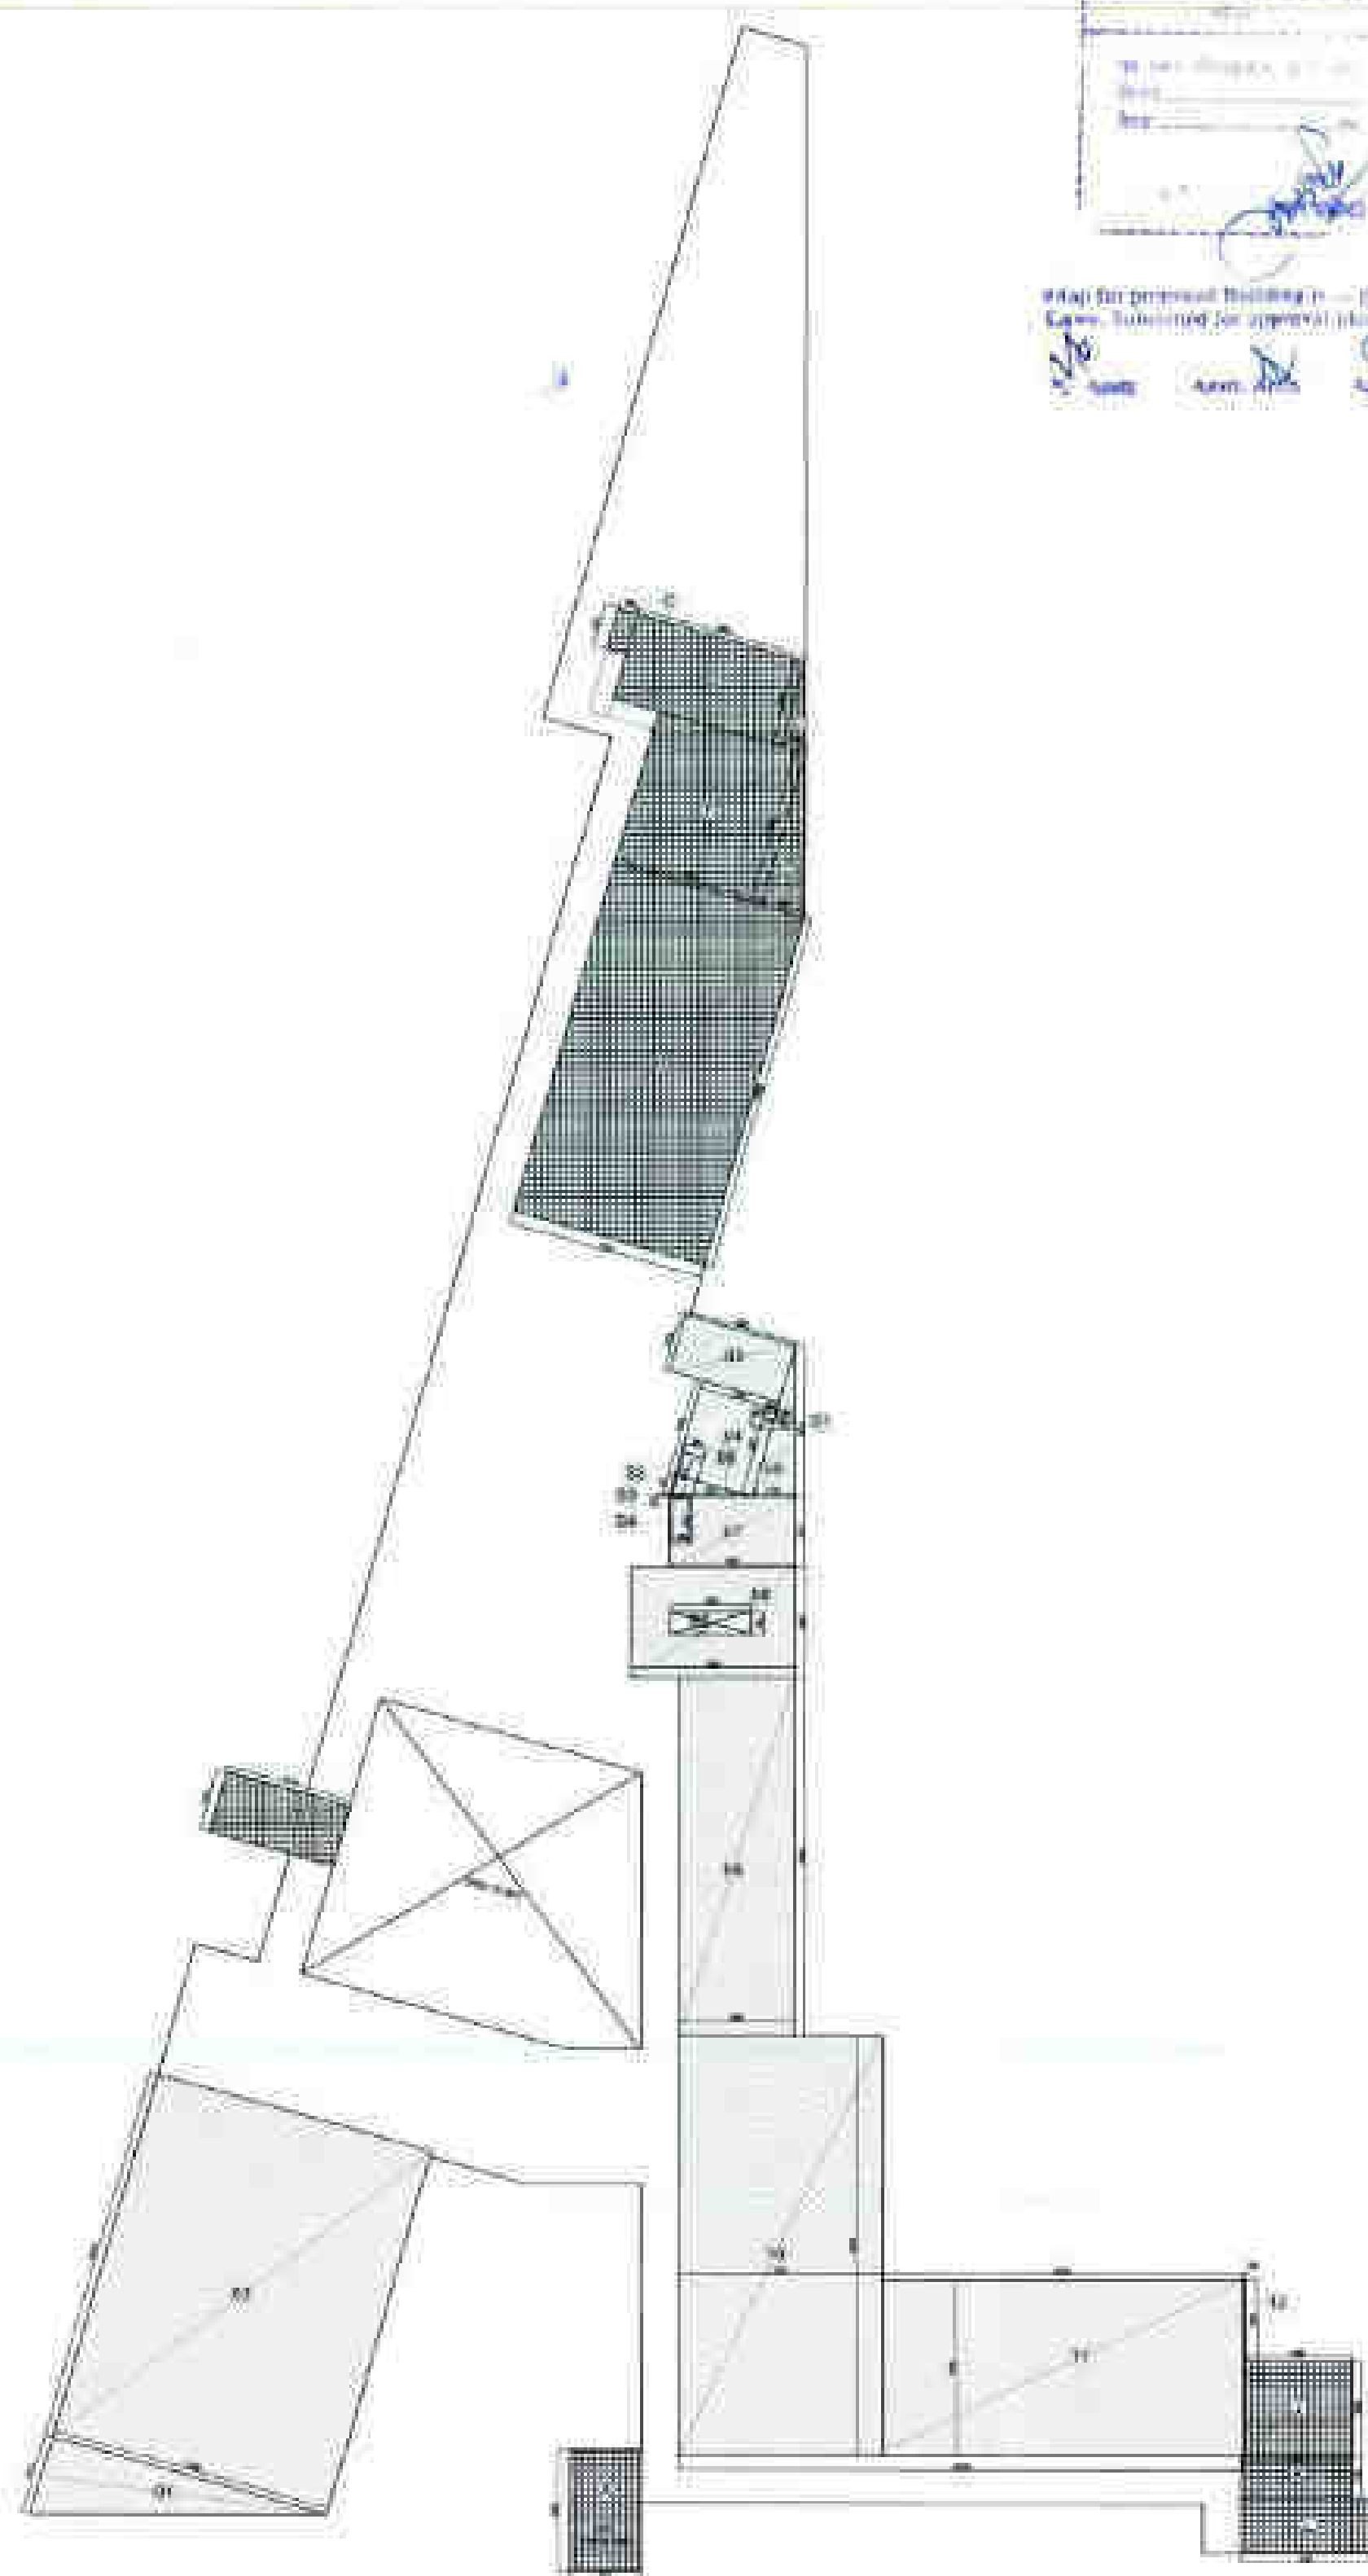

(2) SECOND FLOOR AREA DIAGRAM

F.A.R. COVERED AREA CALCULATION FOR SECOND FLOOR

S.NO.	PARTICULARS						AREA(SQ.M)
1	0.5	X	11.300	X	3.213	=	18.153
2			11.300	X	15.211	=	171.884
3			4.580	X	2.355	=	10.786
4			3.194	X	3.944	=	12.597
5	0.5	X	1.722	X	6.058	=	5.216
6			3.321	X	0.910	=	3.022
7			5.043	X	2.911	=	14.680
8			6.550	X	4.400	=	28.820
9			4.650	X	14.400	=	66.960
10			8.150	X	16.895	=	137.694
11			14.500	X	7.095	=	102.878
12			0.100	X	3.250	=	0.325

TOTAL AREA (A)

SUBTRACTION

S1			1.500	X	0.66	=	0.990
S2			0.800	X	1.677	=	1.342
S3	0.5	X	0.103	X	0.8	=	0.041
S4			0.800	X	1.815	=	1.452
S5			3.250	X	0.9	=	2.925

TOTAL AREA (B)	
----------------	--

TOTAL F.A.R. (A-B)


AREA CALCULATION TOWARDS 15% ADDITIONAL F.A.R AT SECOND FLOOR							
A			2.81	X	4.860	=	13.657
B			5.11	X	2.510	=	12.826
C			0.8	X	1.700	=	1.360
D			6.95	X	3.550	=	24.673
E	0.5		0.97	X	3.550	=	1.722
F			6.105	X	6.364	=	38.852
G	0.5		1.811	X	6.364	=	5.763
H			7.916	X	14.536	=	115.067
J			4.28	X	3.845	=	16.457
K			4.38	X	1.708	=	7.481
L			5.181	X	2.200	=	11.398
TOTAL AREA						=	249.255

TOTAL AREA	
------------	--

AREA LEGEND

11/11/2013/13-50	
①	1986 60K & 100T PIPE
②	1986 60K & 100T PIPE
③	1986 60K & 100T PIPE
④	1986 60K & 100T PIPE
⑤	1986 60K & 100T PIPE
⑥	1986 60K & 100T PIPE
⑦	1986 60K & 100T PIPE
⑧	1986 60K & 100T PIPE
⑨	1986 60K & 100T PIPE
⑩	1986 60K & 100T PIPE
⑪	1986 60K & 100T PIPE
⑫	1986 60K & 100T PIPE
⑬	1986 60K & 100T PIPE
⑭	1986 60K & 100T PIPE
⑮	1986 60K & 100T PIPE
⑯	1986 60K & 100T PIPE
⑰	1986 60K & 100T PIPE
⑱	1986 60K & 100T PIPE
⑲	1986 60K & 100T PIPE
⑳	1986 60K & 100T PIPE
㉑	1986 60K & 100T PIPE
㉒	1986 60K & 100T PIPE
㉓	1986 60K & 100T PIPE
㉔	1986 60K & 100T PIPE
㉕	1986 60K & 100T PIPE
㉖	1986 60K & 100T PIPE
㉗	1986 60K & 100T PIPE
㉘	1986 60K & 100T PIPE
㉙	1986 60K & 100T PIPE
㉚	1986 60K & 100T PIPE
㉛	1986 60K & 100T PIPE
㉜	1986 60K & 100T PIPE
㉝	1986 60K & 100T PIPE
㉞	1986 60K & 100T PIPE
㉟	1986 60K & 100T PIPE
㊱	1986 60K & 100T PIPE
㊲	1986 60K & 100T PIPE
㊳	1986 60K & 100T PIPE
㊴	1986 60K & 100T PIPE
㊵	1986 60K & 100T PIPE
㊶	1986 60K & 100T PIPE
㊷	1986 60K & 100T PIPE
㊸	1986 60K & 100T PIPE
㊹	1986 60K & 100T PIPE
㊺	1986 60K & 100T PIPE
㊻	1986 60K & 100T PIPE
㊼	1986 60K & 100T PIPE
㊽	1986 60K & 100T PIPE
㊾	1986 60K & 100T PIPE
㊿	1986 60K & 100T PIPE

KEY PLAN

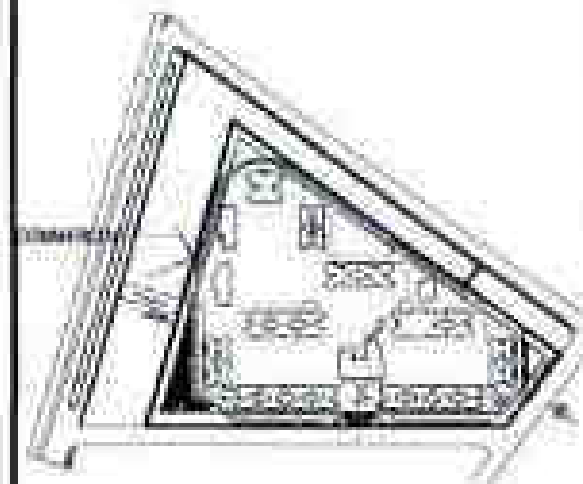

SUBMISSION DRAWING

IV COUNTY PVT. LTD.

PROPOSED GROUP HOLDING FOR
N. CHINCH PVT. LTD.
AT PLOT NO.-25-CL, SECTOR-11
Gurgaon, Haryana

DATE	PROJECT NUMBER	SHEET NO.
DATE	PROJECT NO.	SHEET NO.

TABLE 1

SECOND FLOOR PLAN

TOWER-COMMERCIAL

CONVULSIVUM

Table 1

Abstract

17

1

ATTORNEY GENERAL

11/11/94-12/31/94

TOWN PLANNING

1997, 1998, 1999, 2678, 26

1

[illegible]

Abstract

1

1

1999, 2000, 2001, 2680, 26

[illegible]

2010年12月31日

1	2	3	100
---	---	---	---	---	---	---	---	---	----	----	-----

11. <http://www.elsevier.com/locate/locate/locate>


100

1000

(GENERAL NOTES)
1. NOT VENTILABLE ROOM, FURNITURE, ATTACHED ETC. IF IT IS NOT NATURALLY VENTILATED WILL BE MECHANICALLY VENTILATED
2. THIS DRAWING IS OF PRELIMINARY TYPE AS PER N.B.E.



(2) TERRACE LEVEL AREA DIAGRAM

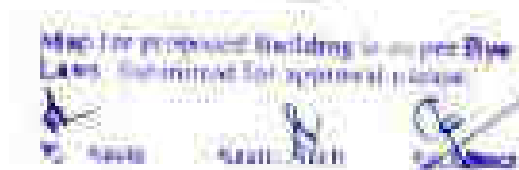[illegible][illegible]

PLUMBING LEGEND	
	1/2" COLD WATER PIPE
	1/2" HOT WATER & VENT PIPE
	3/4" DRAIN/WASTE/VENT PIPE
	1" DRAIN/WASTE/VENT PIPE
	1 1/2" DRAIN/WASTE/VENT PIPE
	2" DRAIN/WASTE/VENT PIPE
	3" DRAIN/WASTE/VENT PIPE
	4" DRAIN/WASTE/VENT PIPE
	6" DRAIN/WASTE/VENT PIPE
	8" DRAIN/WASTE/VENT PIPE
	10" DRAIN/WASTE/VENT PIPE
	12" DRAIN/WASTE/VENT PIPE
	14" DRAIN/WASTE/VENT PIPE
	16" DRAIN/WASTE/VENT PIPE
	18" DRAIN/WASTE/VENT PIPE
	20" DRAIN/WASTE/VENT PIPE
	22" DRAIN/WASTE/VENT PIPE
	24" DRAIN/WASTE/VENT PIPE
	26" DRAIN/WASTE/VENT PIPE
	28" DRAIN/WASTE/VENT PIPE
	30" DRAIN/WASTE/VENT PIPE
	32" DRAIN/WASTE/VENT PIPE
	34" DRAIN/WASTE/VENT PIPE
	36" DRAIN/WASTE/VENT PIPE
	38" DRAIN/WASTE/VENT PIPE
	40" DRAIN/WASTE/VENT PIPE
	42" DRAIN/WASTE/VENT PIPE
	44" DRAIN/WASTE/VENT PIPE
	46" DRAIN/WASTE/VENT PIPE
	48" DRAIN/WASTE/VENT PIPE
	50" DRAIN/WASTE/VENT PIPE
	52" DRAIN/WASTE/VENT PIPE
	54" DRAIN/WASTE/VENT PIPE
	56" DRAIN/WASTE/VENT PIPE
	58" DRAIN/WASTE/VENT PIPE
	60" DRAIN/WASTE/VENT PIPE
	62" DRAIN/WASTE/VENT PIPE
	64" DRAIN/WASTE/VENT PIPE
	66" DRAIN/WASTE/VENT PIPE
	68" DRAIN/WASTE/VENT PIPE
	70" DRAIN/WASTE/VENT PIPE
	72" DRAIN/WASTE/VENT PIPE
	74" DRAIN/WASTE/VENT PIPE
	76" DRAIN/WASTE/VENT PIPE
	78" DRAIN/WASTE/VENT PIPE
	80" DRAIN/WASTE/VENT PIPE
	82" DRAIN/WASTE/VENT PIPE
	84" DRAIN/WASTE/VENT PIPE
	86" DRAIN/WASTE/VENT PIPE
	88" DRAIN/WASTE/VENT PIPE
	90" DRAIN/WASTE/VENT PIPE
	92" DRAIN/WASTE/VENT PIPE
	94" DRAIN/WASTE/VENT PIPE
	96" DRAIN/WASTE/VENT PIPE
	98" DRAIN/WASTE/VENT PIPE
	100" DRAIN/WASTE/VENT PIPE

This architectural floor plan depicts a triangular building with a central courtyard. The building's perimeter is defined by a thick line, and the interior is divided into several rooms and a central open space. The layout is symmetrical, with rooms on either side of the central courtyard. The drawing is a technical sketch, likely for a design or construction project.

IV COUNTY PVT. LTD.

DATE	PROJECT NUMBER	INITIATED BY
01/01/01	0000000000000000	0000000000000000
01/01/01	0000000000000000	0000000000000000
01/01/01	0000000000000000	0000000000000000

TONNER - COMMERCIAL

[illegible]

TOWN OF ANDOVER

— **Abstract** —

[illegible]

author(s)	year	country	abstract
[author(s)]	year		abstract

7. **Indicate the number of times you have used each of the following services in the last 12 months:**

This meeting is available on video. <http://www.elsevier.com/locate/ehp>



China could be democracy

Chinese leaders are beginning to realize that China must become a democracy if it is to survive as a great power.

आप, प्रयोग
 प्रयोग १. एक ग्लास में पानी भर लें। उसमें एक
 टुकड़ा लाल रंग का कागज डाल दें। पानी
 का रंग लाल हो जाएगा। अब उसमें कुछ
 नीला रंग का कागज डाल दें। पानी का रंग
 नीला हो जाएगा। अब उसमें कुछ हरा रंग का
 कागज डाल दें। पानी का रंग हरा हो जाएगा।


[illegible]

AREA CALCULATION TOWARDS 15% ADDITIONAL F.A.R FOR SECOND FLOOR								AREA (SQ. M)
S.NO	PARTICULARS							
1				0.00	m	8.308	+	8.308
2			X	0.00	m	0.700	+	0.700
3				5.92	m	8.669	+	18.413
4				0.04	m	10.674	+	10.695
5				22.851	m	14.373	+	208.075
6				7.945	m	10.664	+	14.737
7				0.031	m	2.462	+	2.516
8	0.5		X	3.13	m	56.318	+	15.372
9				2.942	m	20.277	+	18.336
10	0.5		X	0.700	m	0.857	+	2.318
11	0.5		X	0.010	m	2.454	+	3.583
12	0.5		X	2.830	m	2.458	+	3.584
13				2.830	m	0.803	+	2.563
14	0.5		X	12.688	m	3.259	+	31.307
15	0.5		X	0.06	m	2.506	+	3.788
16				14.155	m	2.488	+	16.942
17	0.5		X	0.932	m	3.728	+	5.680
18				37.658	m	5.919	+	194.474
19				48.783	m	4.788	+	239.634
20				1.836	m	3.816	+	18.372
21	0.5		X	1.973	m	1.042	+	5.227
22	0.5		X	1.934	m	0.610	+	3.555
23	0.5		X	0.116	m	0.670	+	0.598
24	0.5		X	0.072	m	1.546	+	2.068
25				0.180	m	0.617	+	1.382
26				5.971	m	6.588	+	16.751
27				0.034	m	7.370	+	10.962
TOTAL 15% ADDITIONAL F.A.R AREA WITHOUT SUBTRACTION..... (A)								1225.988
AREA SUBTRACTION								
STAIRCASE CUTOUT								
31				1.410	m	1.700	+	2.482
32				0.000	m	3.800	+	3.780
33				0.000	m	1.240	+	3.648
34				1.338	m	7.008	+	9.355
35				1.630	m	1.180	+	3.058
36				1.130	m	1.860	+	4.228
37				0.830	m	0.830	+	0.760
38				1.328	m	7.176	+	8.507
39				0.830	m	1.250	+	3.640
TOTAL CUTOUT AREA..... (B)								26.238
TOTAL 15% ADDITIONAL F.A.R AREA..... (A) - (B)								1197.750

This strategy is a "COPYRIGHT" violation of this strategy, or part thereof, may be used or reproduced without the permission of THE AUTHOR.

[illegible]

GENERAL NOTES:
1. LAY OUT TABLE ROOM, 10'0" X 10'0" IN THE WEST BATHING ROOM.
2. MEASUREMENTS WILL BE USED TO DETERMINE THE LOCATION OF THE TABLE.
3. THE TABLE IS TO BE PLACED IN THE WEST BATHING ROOM.

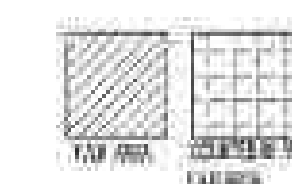[illegible]

SUBMISSION DRAWING

IV COUNTY PVT. LTD.



PROPERTY OF THE U.S. MARINE CORPS
IN COUNTY, CALIF.
AT FORT MEADE, CALIFORNIA-12
MARCH 1970

DATE	PROJECT/PROGRAM	LOCATION/ST
PLANTING	HOUSING/SHED	SUPPLIES/SHED
ROADS	WATER	ARTIFICIAL

TABLE 1

SECOND FLOOR PLAN
COMMUNITY CENTRE


 AUTHORIZED SIGNATORY

TITANIA TRIANGLE FACTA

TRANSLATIONS



File Name	File Size	Download Count	Download Date
0-001	1.0 MB	100	10/10/2010




AREA CALCULATION TOWARDS 15% ADDITIONAL F.A.R AT GROUND FLOOR							
S.NO	PARTICULARS						AREA(SQ.M)
A	0.5	X	5.000	X	5.000	=	12.500
B			5.000	X	5.000	=	25.000
C	0.5	X	5.000	X	5.000	=	12.500
D			15.000	X	5.000	=	75.000
TOTAL AREA						=	125.000

[illegible]

NO OF PARTS	DATE	THRU TO	COUNTING
WORKER	DATE	THRU TO	BT

GENERAL NOTES:
1. ALL MATERIALS, POOR, TRUCK ACCESSIBLE, IS OF MATERIAL
UNAVAILABLE FOR THE WORKMAN. TO BE KEPT.
2. THE WORKMAN SHALL BE RESPONSIBLE FOR THE COST OF
THE WORK. (SEE ATTACHED FOR DETAILS OF WORK.)

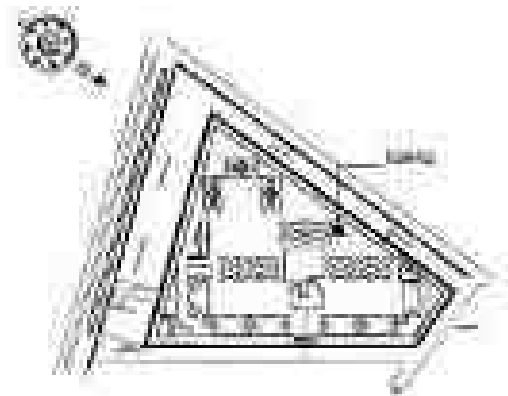

SUBMISSION DRAWING

IV COUNTY PVT. LTD.

CLACK COUNTY

CLACK COUNTY

PROPOSED NEW HOLDING TANK
IN CLACK COUNTY, WY.
AT PLAT NO. 34-35-36-37-1048-1

DATE	REPORT NUMBER	REPORT BY
PREPARED	FOR NAME AND	ADDRESS TO WHOM
RECEIVED	DATE	DATE
BY	FOR NAME AND	DATE

RESEARCH DESIGN

COMMUNITY HALL

GROUND FLOOR PLAN

1	2	3	466
---	---	---	---	---	---	---	---	---	----	----	-----	-----	
COMPETITIVE LTD



Authorized Signature _____



Source: *For a further study.*

© 2004 Pearson Education, Inc. All rights reserved. Printed in the United States of America. This publication is protected by copyright. Any unauthorized reproduction or distribution of this work in any form or by any means, electronic or mechanical, including photocopying, recording, or by any information storage and retrieval system, without permission in writing from the publisher is prohibited. This publication may contain copyrighted material from the Internet or other electronic sources. Any copyright notices appearing in this publication are hereby acknowledged.

[illegible]

TOWN PLANNER

Journal of Health Politics, Policy and Law

[illegible]

www.scribd.com



Conflue

34,196,0000 0000-0000-0000-0000

1. **NAME** _____
 2. **ADDRESS** _____
 3. **CITY** _____
 4. **STATE** _____
 5. **ZIP** _____
 6. **PHONE** _____
 7. **DATE** _____
 8. **SIGNATURE** _____
 9. **PRINT NAME** _____
 10. **PRINT ADDRESS** _____
 11. **PRINT CITY** _____
 12. **PRINT STATE** _____
 13. **PRINT ZIP** _____
 14. **PRINT PHONE** _____
 15. **PRINT DATE** _____
 16. **PRINT SIGNATURE** _____
 17. **PRINT NAME** _____
 18. **PRINT ADDRESS** _____
 19. **PRINT CITY** _____
 20. **PRINT STATE** _____
 21. **PRINT ZIP** _____
 22. **PRINT PHONE** _____
 23. **PRINT DATE** _____
 24. **PRINT SIGNATURE** _____
 25. **PRINT NAME** _____
 26. **PRINT ADDRESS** _____
 27. **PRINT CITY** _____
 28. **PRINT STATE** _____
 29. **PRINT ZIP** _____
 30. **PRINT PHONE** _____
 31. **PRINT DATE** _____
 32. **PRINT SIGNATURE** _____
 33. **PRINT NAME** _____
 34. **PRINT ADDRESS** _____
 35. **PRINT CITY** _____
 36. **PRINT STATE** _____
 37. **PRINT ZIP** _____
 38. **PRINT PHONE** _____
 39. **PRINT DATE** _____
 40. **PRINT SIGNATURE** _____
 41. **PRINT NAME** _____
 42. **PRINT ADDRESS** _____
 43. **PRINT CITY** _____
 44. **PRINT STATE** _____
 45. **PRINT ZIP** _____
 46. **PRINT PHONE** _____
 47. **PRINT DATE** _____
 48. **PRINT SIGNATURE** _____
 49. **PRINT NAME** _____
 50. **PRINT ADDRESS** _____
 51. **PRINT CITY** _____
 52. **PRINT STATE** _____
 53. **PRINT ZIP** _____
 54. **PRINT PHONE** _____
 55. **PRINT DATE** _____
 56. **PRINT SIGNATURE** _____
 57. **PRINT NAME** _____
 58. **PRINT ADDRESS** _____
 59. **PRINT CITY** _____
 60. **PRINT STATE** _____
 61. **PRINT ZIP** _____
 62. **PRINT PHONE** _____
 63. **PRINT DATE** _____
 64. **PRINT SIGNATURE** _____
 65. **PRINT NAME** _____
 66. **PRINT ADDRESS** _____
 67. **PRINT CITY** _____
 68. **PRINT STATE** _____
 69. **PRINT ZIP** _____
 70. **PRINT PHONE** _____
 71. **PRINT DATE** _____
 72. **PRINT SIGNATURE** _____
 73. **PRINT NAME** _____
 74. **PRINT ADDRESS** _____
 75. **PRINT CITY** _____
 76. **PRINT STATE** _____
 77. **PRINT ZIP** _____
 78. **PRINT PHONE** _____
 79. **PRINT DATE** _____
 80. **PRINT SIGNATURE** _____
 81. **PRINT NAME** _____
 82. **PRINT ADDRESS** _____
 83. **PRINT CITY** _____
 84. **PRINT STATE** _____
 85. **PRINT ZIP** _____
 86. **PRINT PHONE** _____
 87. **PRINT DATE** _____
 88. **PRINT SIGNATURE** _____
 89. **PRINT NAME** _____
 90. **PRINT ADDRESS** _____
 91. **PRINT CITY** _____
 92. **PRINT STATE** _____
 93. **PRINT ZIP** _____
 94. **PRINT PHONE** _____
 95. **PRINT DATE** _____
 96. **PRINT SIGNATURE** _____
 97. **PRINT NAME** _____
 98. **PRINT ADDRESS** _____
 99. **PRINT CITY** _____
 100. **PRINT STATE** _____
 101. **PRINT ZIP** _____
 102. **PRINT PHONE** _____
 103. **PRINT DATE** _____
 104. **PRINT SIGNATURE** _____
 105. **PRINT NAME** _____
 106. **PRINT ADDRESS** _____
 107. **PRINT CITY** _____
 108. **PRINT STATE** _____
 109. **PRINT ZIP** _____
 110. **PRINT PHONE** _____
 111. **PRINT DATE** _____
 112. **PRINT SIGNATURE** _____
 113. **PRINT NAME** _____
 114. **PRINT ADDRESS** _____
 115. **PRINT CITY** _____
 116. **PRINT STATE** _____
 117. **PRINT ZIP** _____
 118. **PRINT PHONE** _____
 119. **PRINT DATE** _____
 120. **PRINT SIGNATURE** _____
 121. **PRINT NAME** _____
 122. **PRINT ADDRESS** _____
 123. **PRINT CITY** _____
 124. **PRINT STATE** _____
 125. **PRINT ZIP** _____
 126. **PRINT PHONE** _____
 127. **PRINT DATE** _____
 128. **PRINT SIGNATURE** _____
 129. **PRINT NAME** _____
 130. **PRINT ADDRESS** _____
 131. **PRINT CITY** _____
 132. **PRINT STATE** _____
 133. **PRINT ZIP** _____
 134. **PRINT PHONE** _____
 135. **PRINT DATE** _____
 136. **PRINT SIGNATURE** _____
 137. **PRINT NAME** _____
 138. **PRINT ADDRESS** _____
 139. **PRINT CITY** _____
 140. **PRINT STATE** _____
 141. **PRINT ZIP** _____
 142. **PRINT PHONE** _____
 143. **PRINT DATE** _____
 144. **PRINT SIGNATURE** _____
 145. **PRINT NAME** _____
 146. **PRINT ADDRESS** _____
 147. **PRINT CITY** _____
 148. **PRINT STATE** _____
 149. **PRINT ZIP** _____
 150. **PRINT PHONE** _____
 151. **PRINT DATE** _____
 152. **PRINT SIGNATURE** _____
 153. **PRINT NAME** _____
 154. **PRINT ADDRESS** _____
 155. **PRINT CITY** _____
 156. **PRINT STATE** _____
 157. **PRINT ZIP** _____
 158. **PRINT PHONE** _____
 159. **PRINT DATE** _____
 160. **PRINT SIGNATURE** _____
 161. **PRINT NAME** _____
 162. **PRINT ADDRESS** _____
 163. **PRINT CITY** _____
 164. **PRINT STATE** _____
 165. **PRINT ZIP** _____
 166. **PRINT PHONE** _____
 167. **PRINT DATE** _____
 168. **PRINT SIGNATURE** _____
 169. **PRINT NAME** _____
 170. **PRINT ADDRESS** _____
 171. **PRINT CITY** _____
 172. **PRINT STATE** _____
 173. **PRINT ZIP** _____
 174. **PRINT PHONE** _____
 175. **PRINT DATE** _____
 176. **PRINT SIGNATURE** _____
 177. **PRINT NAME** _____
 178. **PRINT ADDRESS** _____
 179. **PRINT CITY** _____
 180. **PRINT STATE** _____
 181. **PRINT ZIP** _____
 182. **PRINT PHONE** _____
 183. **PRINT DATE** _____
 184. **PRINT SIGNATURE** _____
 185. **PRINT NAME** _____
 186. **PRINT ADDRESS** _____
 187. **PRINT CITY** _____
 188. **PRINT STATE** _____
 189. **PRINT ZIP** _____
 190. **PRINT PHONE** _____
 191. **PRINT DATE** _____
 192. **PRINT SIGNATURE** _____
 193. **PRINT NAME** _____
 194. **PRINT ADDRESS** _____
 195. **PRINT CITY** _____
 196. **PRINT STATE** _____
 197. **PRINT ZIP** _____
 198. **PRINT PHONE** _____
 199. **PRINT DATE** _____
 200. **PRINT SIGNATURE** _____
 201. **PRINT NAME** _____
 202. **PRINT ADDRESS** _____
 203. **PRINT CITY** _____
 204. **PRINT STATE** _____
 205. **PRINT ZIP** _____
 206. **PRINT PHONE** _____
 207. **PRINT DATE** _____
 208. **PRINT SIGNATURE** _____
 209. **PRINT NAME** _____
 210. **PRINT ADDRESS** _____
 211. **PRINT CITY** _____
 212. **PRINT STATE** _____
 213. **PRINT ZIP** _____
 214. **PRINT PHONE** _____
 215. **PRINT DATE** _____
 216. **PRINT SIGNATURE** _____
 217. **PRINT NAME** _____
 218. **PRINT ADDRESS** _____
 219. **PRINT CITY** _____
 220. **PRINT STATE** _____

3-091

1. The first step is to identify the problem or question that needs to be answered. This involves understanding the context and the specific requirements of the task.

[illegible]
