


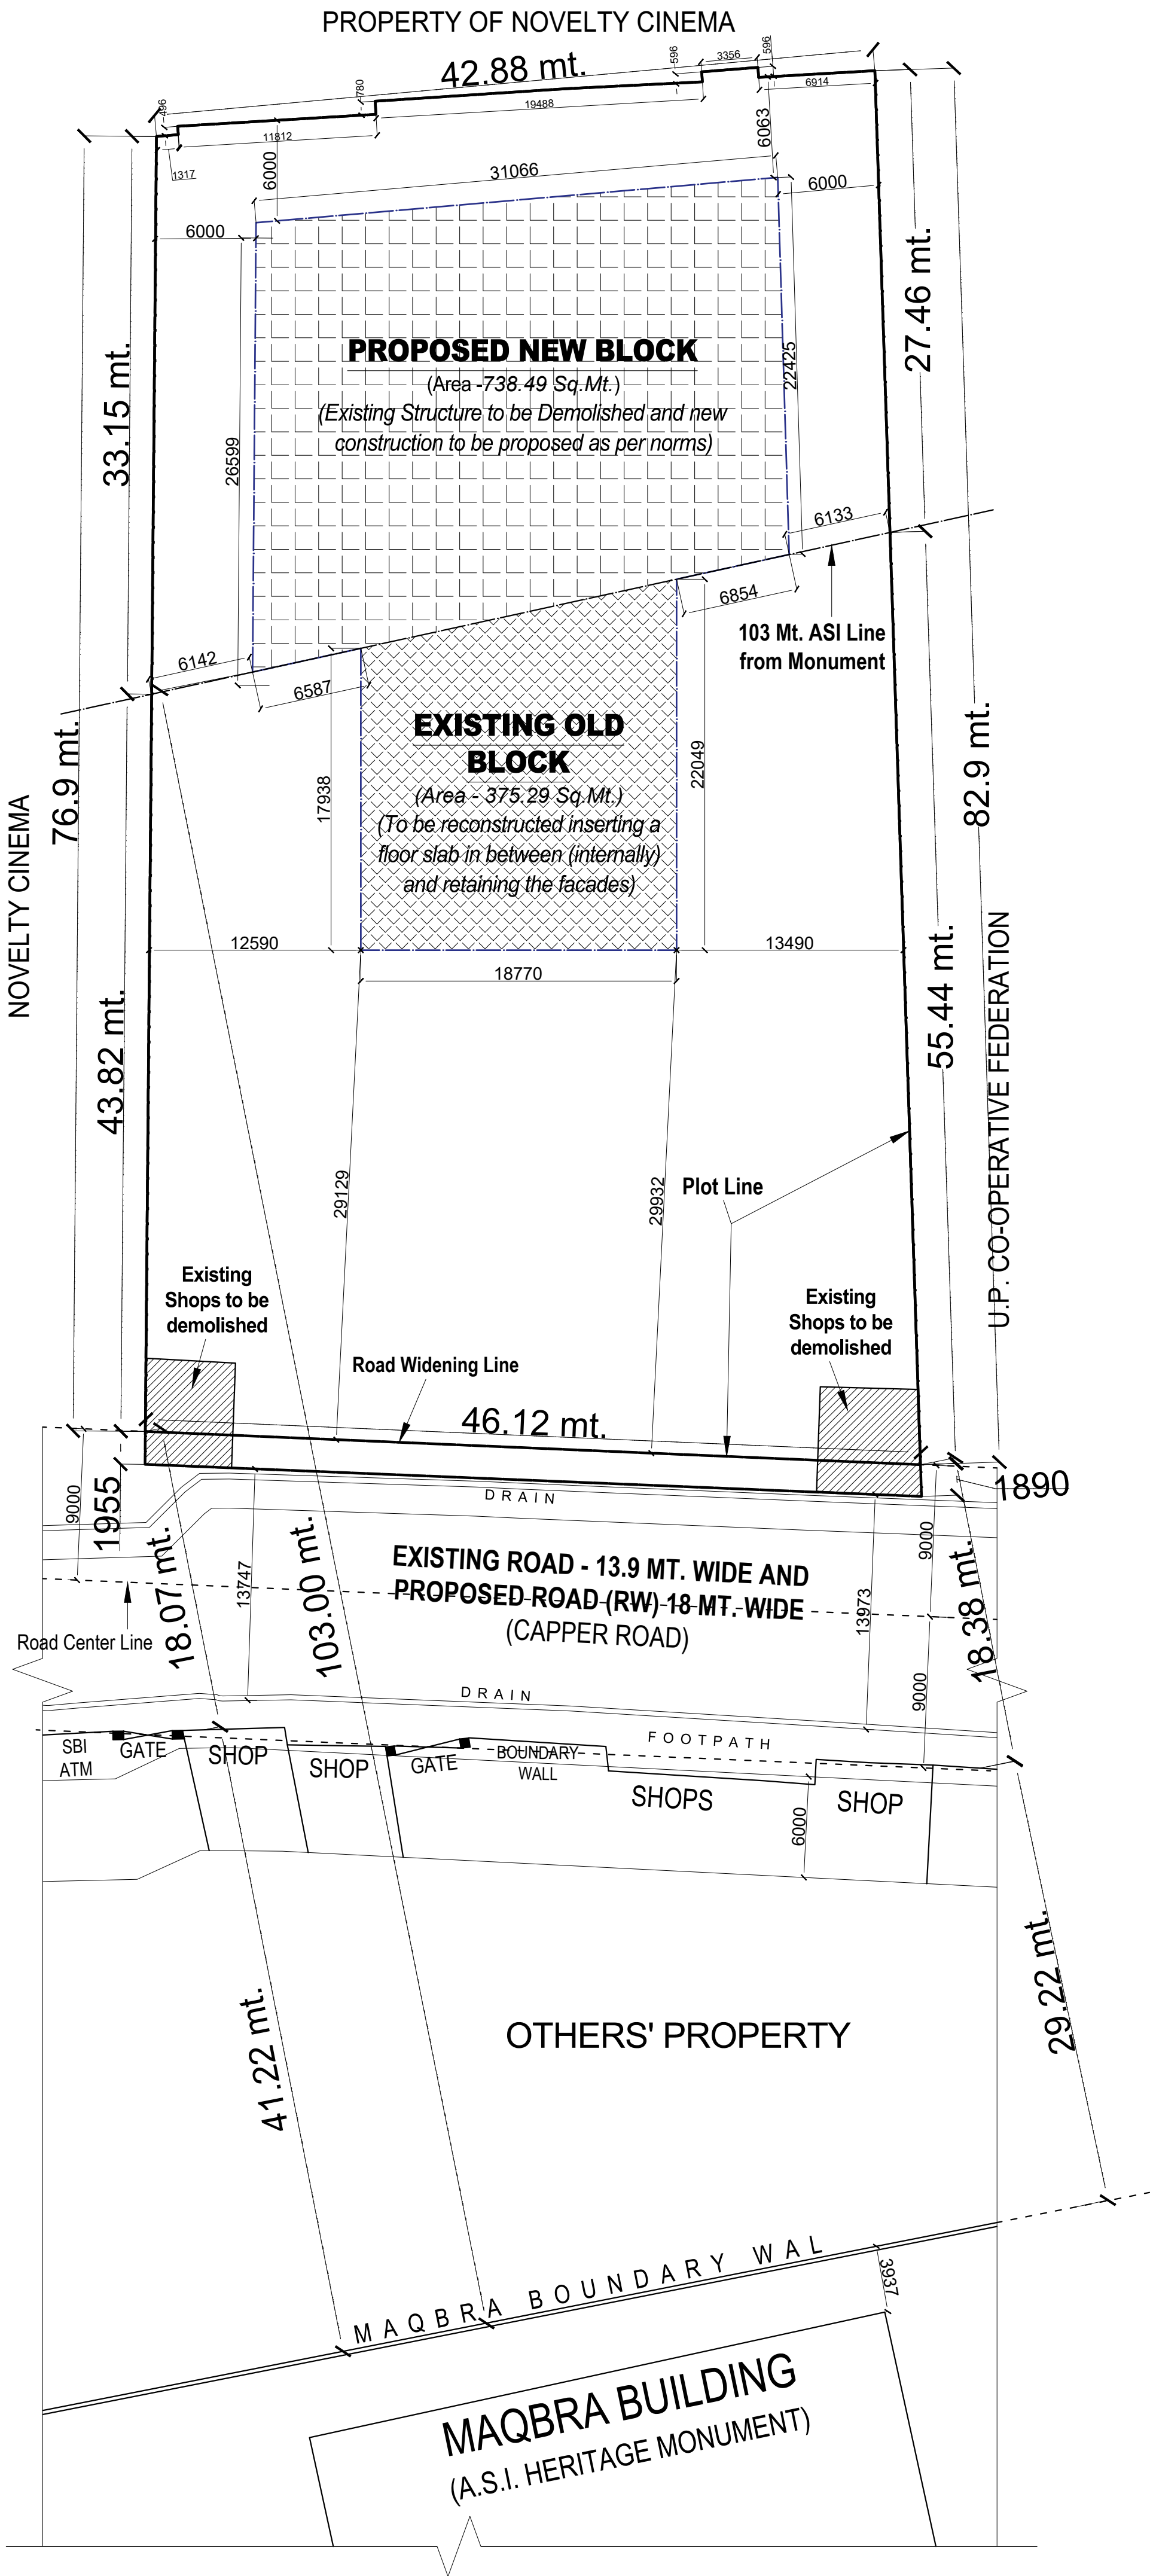

PROPOSED
COMMERCIAL COMPLEX
& GROUP HOUSING

FOR DR. RAJESH KUMAR SETH,
DR. VIJAY KUMAR SETH,
DR. AJEET KUMAR SETH,
MR. VIKRAM SETH,
DR. (MRS.) SUNITA SETH,
MR. RAVI SETH,
DR. (MRS.) VEENA BAJPAI,
MR. ANKUR BAJPAI,
MR. AMIT SETH;
ON PLOT NO. 4 AT
CAPPER ROAD, LALBAGH,
LUCKNOW.

OWNER'S SIGN

THIS IS TO CERTIFY THAT THIS PROPOSED DRAWING IS
PREPARED AS PER MASTER PLAN 2031 AND
BUILDING BYE LAWS-2016


*All Dimensions are in Millimeters or as specified

DWG. TITLE -
SITE LAYOUT PLAN

SCALE -	SHEET NO. -	JOB NO. -
DATED -	DEALT BY -	CHECKED. BY -
ARCHITECT		

SUBMISSION DRAWING

point architects pvt. ltd.
ARCHITECTS & INT. DESIGNERS
FLAT No. 1, G. FLOOR, 4/45, ROYAL COURT
WAZIR HASAN ROAD, LUCKNOW
Ph.: 0522-4073807, Email: point_arch_@rediffmail.com

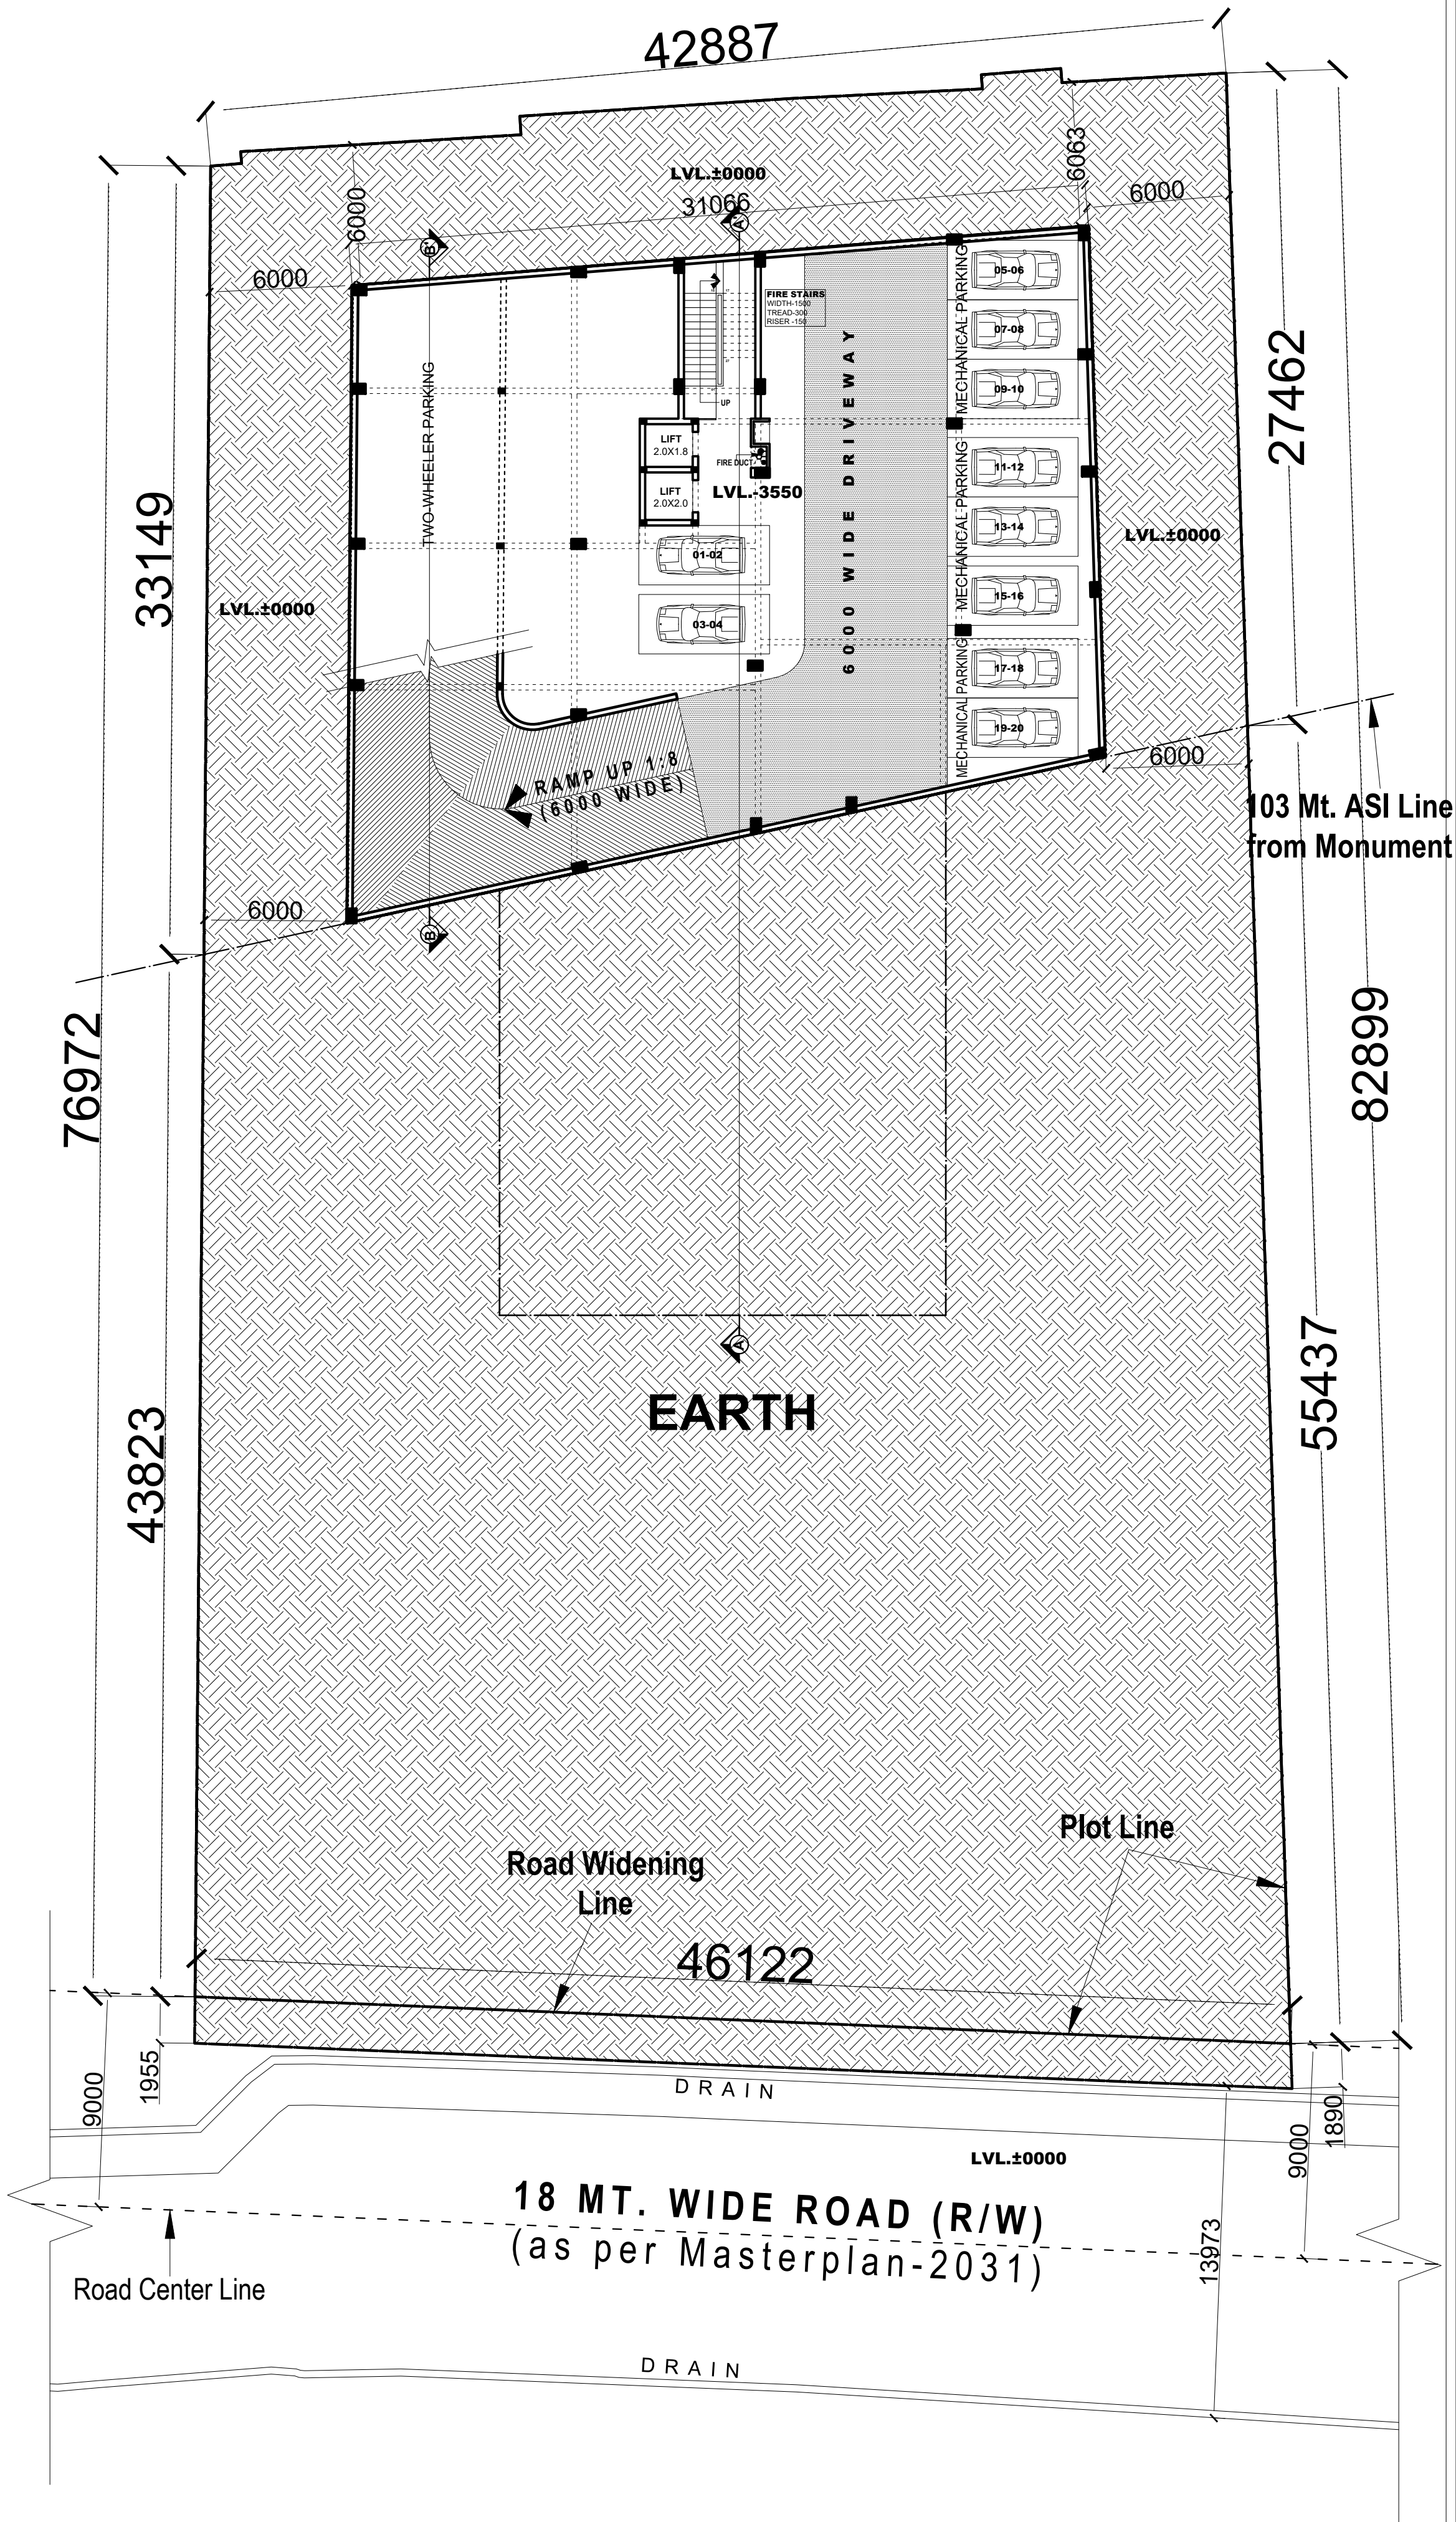

PROPOSED -

PROPOSED COMMERCIAL COMPLEX & GROUP HOUSING

FOR DR. RAJESH KUMAR SETH,
DR. VIJAY KUMAR SETH,
DR. AJEET KUMAR SETH,
MR. VIKRAM SETH,
DR. (MRS.) SUNITA SETH,
MR. RAVI SETH,
DR. (MRS.) VEENA BAJPAI,
MR. ANKUR BAJPAI,
MR. AMIT SETH;
ON PLOT NO. 4 AT
CAPPER ROAD, LALBAGH,
LUCKNOW.

OWNER'S SIGN

THIS IS TO CERTIFY THAT THIS PROPOSED DRAWING IS
PREPARED AS PER MASTER PLAN 2031 AND
BUILDING BYE LAWS-2016


*All Dimensions are in Millimeters or as specified

DWG. TITLE - **BASEMENT PLAN**
(MECHANICALLY VENTILATED AND LIGHTED)

SCALE - SHEET NO. - JOB NO. -


DATED - DEALT BY - CHECKED. BY -

ARCHITECT

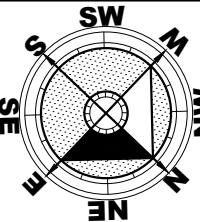

SUBMISSION DRAWING

point architects pvt. ltd.
ARCHITECTS & INT. DESIGNERS
FLAT No. 1, G. FLOOR, 4/45, ROYAL COURT
WAZIR HASAN ROAD, LUCKNOW
Ph.: 0522-4073807, Email: point_arch_@rediffmail.com

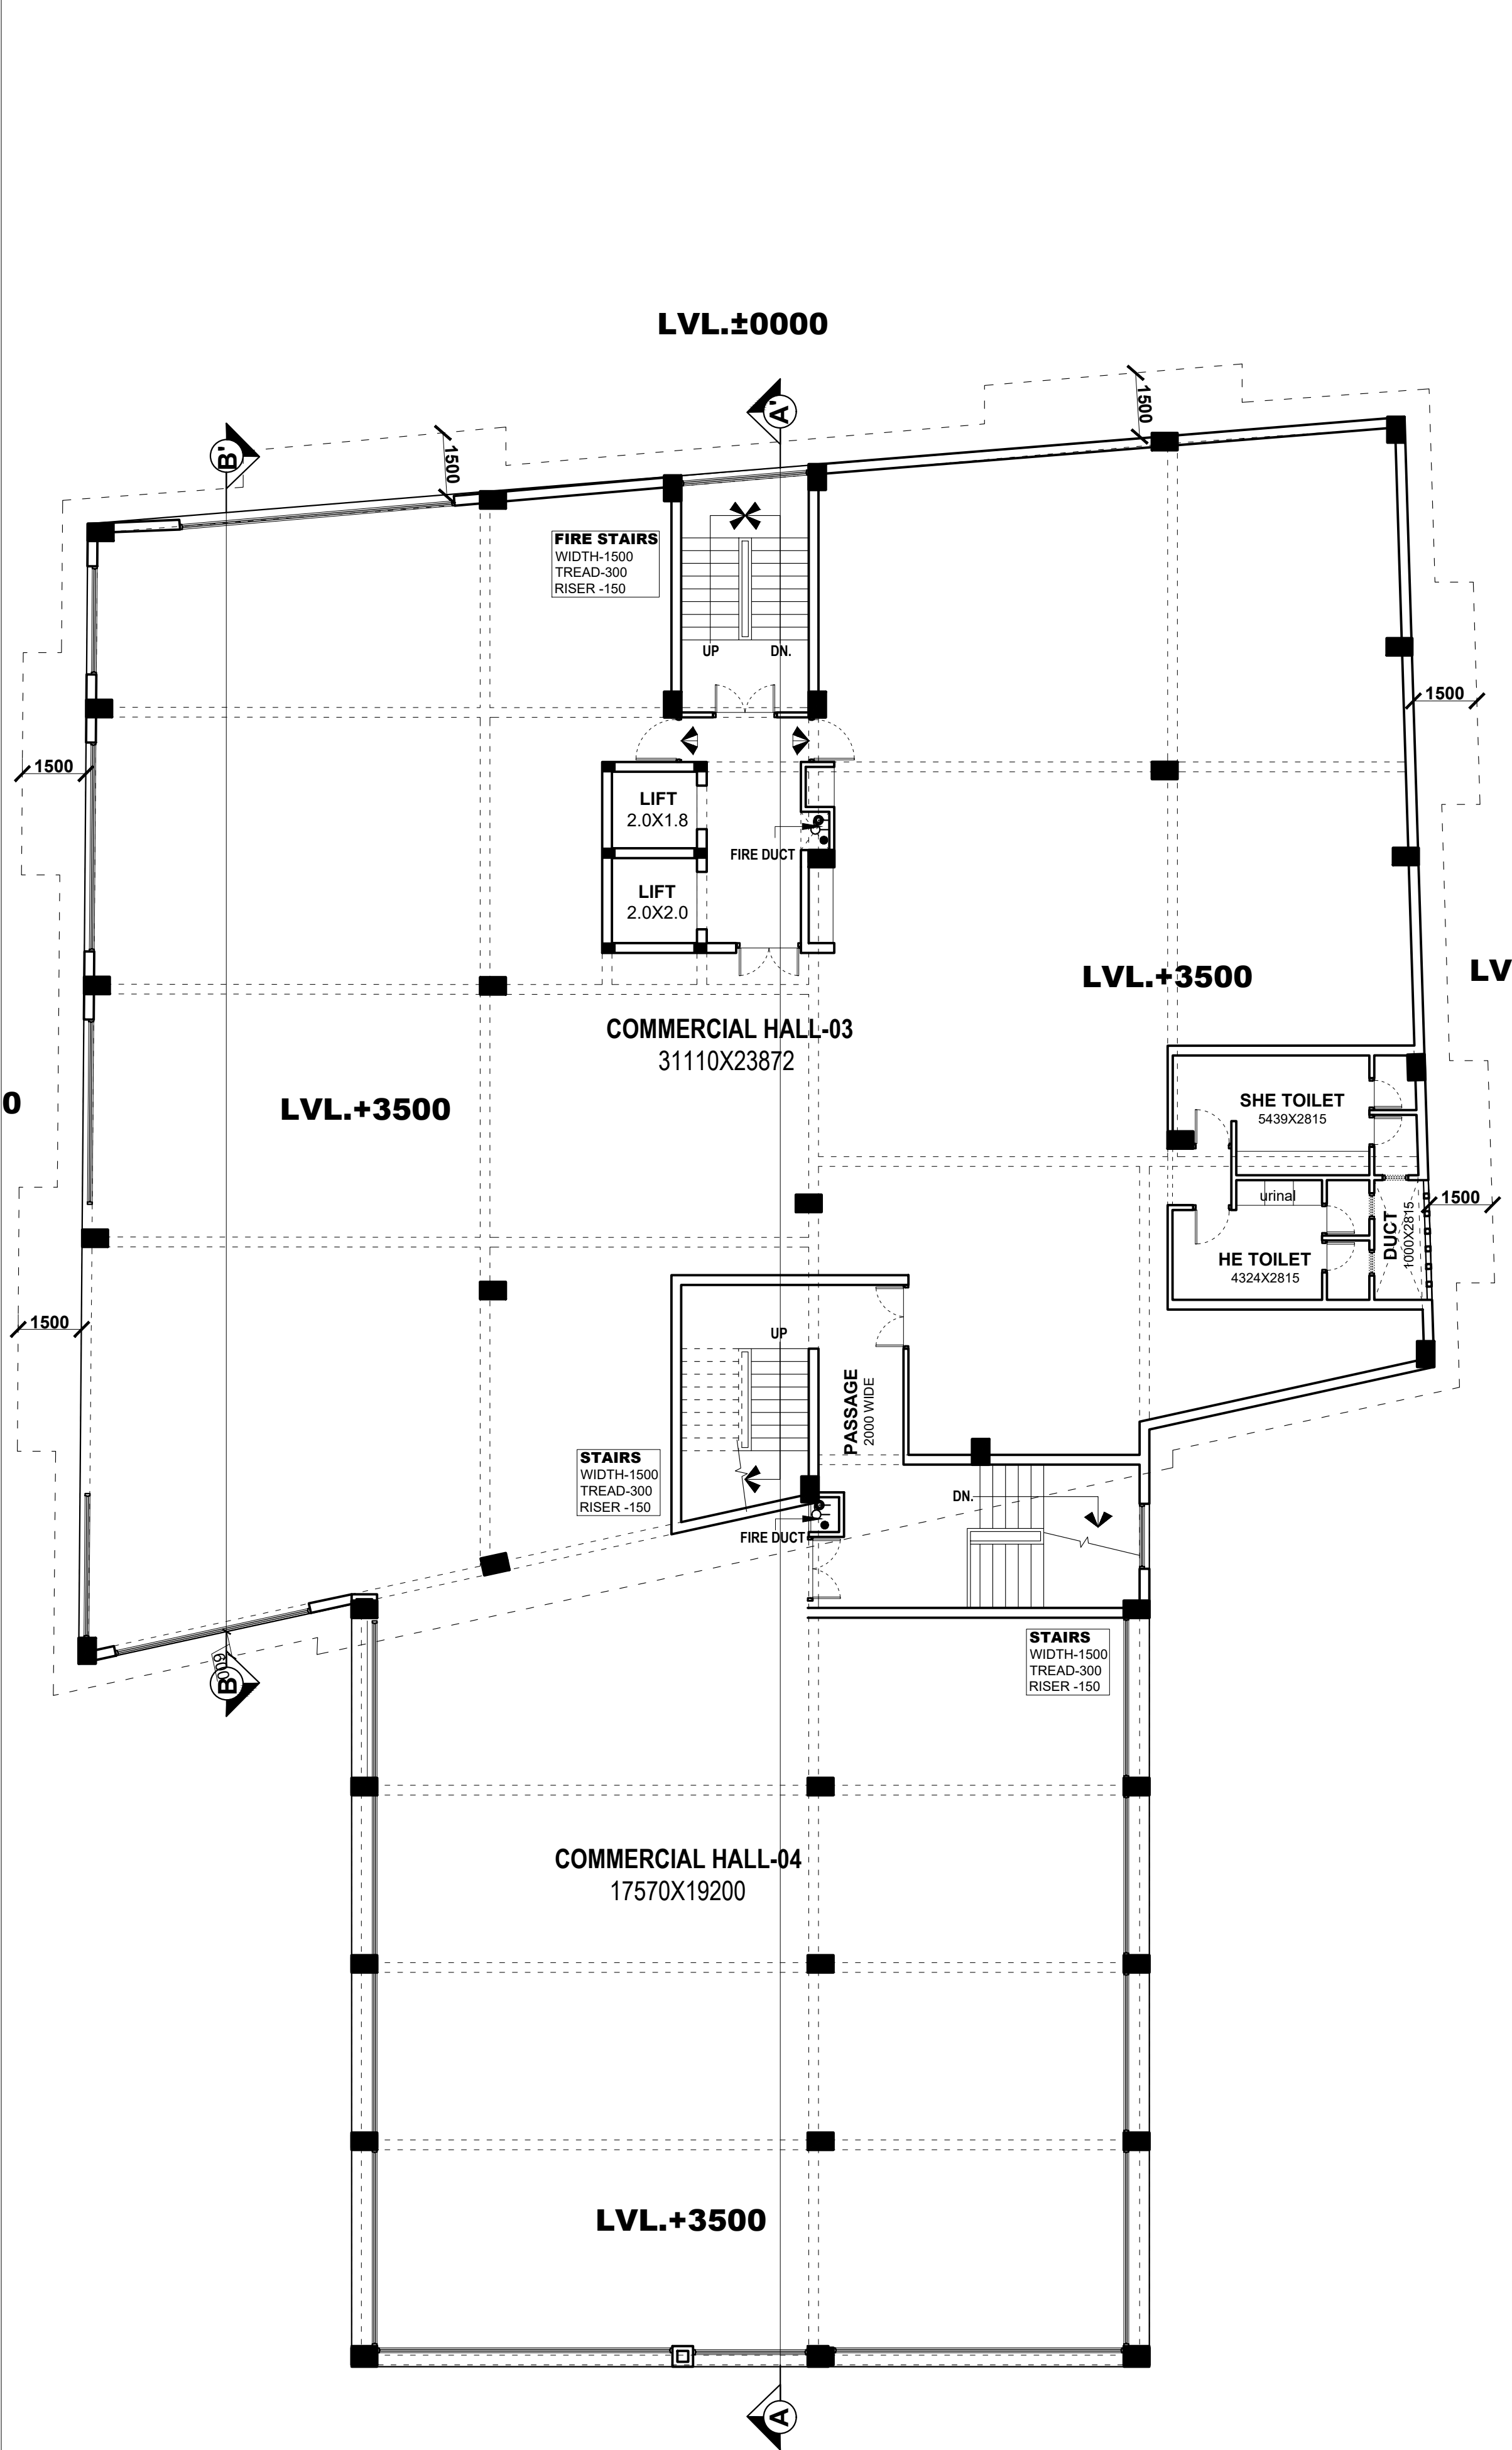

PROPOSED -

**PROPOSED
COMMERCIAL COMPLEX
& GROUP HOUSING**

FOR DR. RAJESH KUMAR SETH,
DR. VIJAY KUMAR SETH,
DR. AJEET KUMAR SETH,
MR. VIKRAM SETH,
DR. (MRS.) SUNITA SETH,
MR. RAVI SETH,
DR. (MRS.) VEENA BAJPAI,
MR. ANKUR BAJPAI,
MR. AMIT SETH;
ON PLOT NO. 4 AT
CAPPER ROAD, LALBAGH,
LUCKNOW.

OWNER'S SIGN

THIS IS TO CERTIFY THAT THIS PROPOSED DRAWING IS
PREPARED AS PER MASTER PLAN 2031 AND
BUILDING BYE LAWS-2016

*All Dimensions are in Millimeters or as specified


DWG. TITLE -

FIRST FLOOR PLAN

SCALE - SHEET NO. - JOB NO. -


DATED - DEALT BY - CHECKED. BY -

ARCHITECT

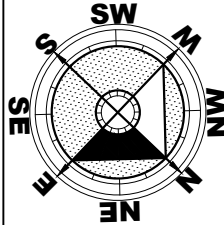

SUBMISSION DRAWING

point architects pvt. ltd.
ARCHITECTS & INT. DESIGNERS
FLAT No. 1, G. FLOOR, 4/45, ROYAL COURT
WAZIR HASAN ROAD, LUCKNOW
Ph.: 0522-4073807, Email: point_arch_@rediffmail.com

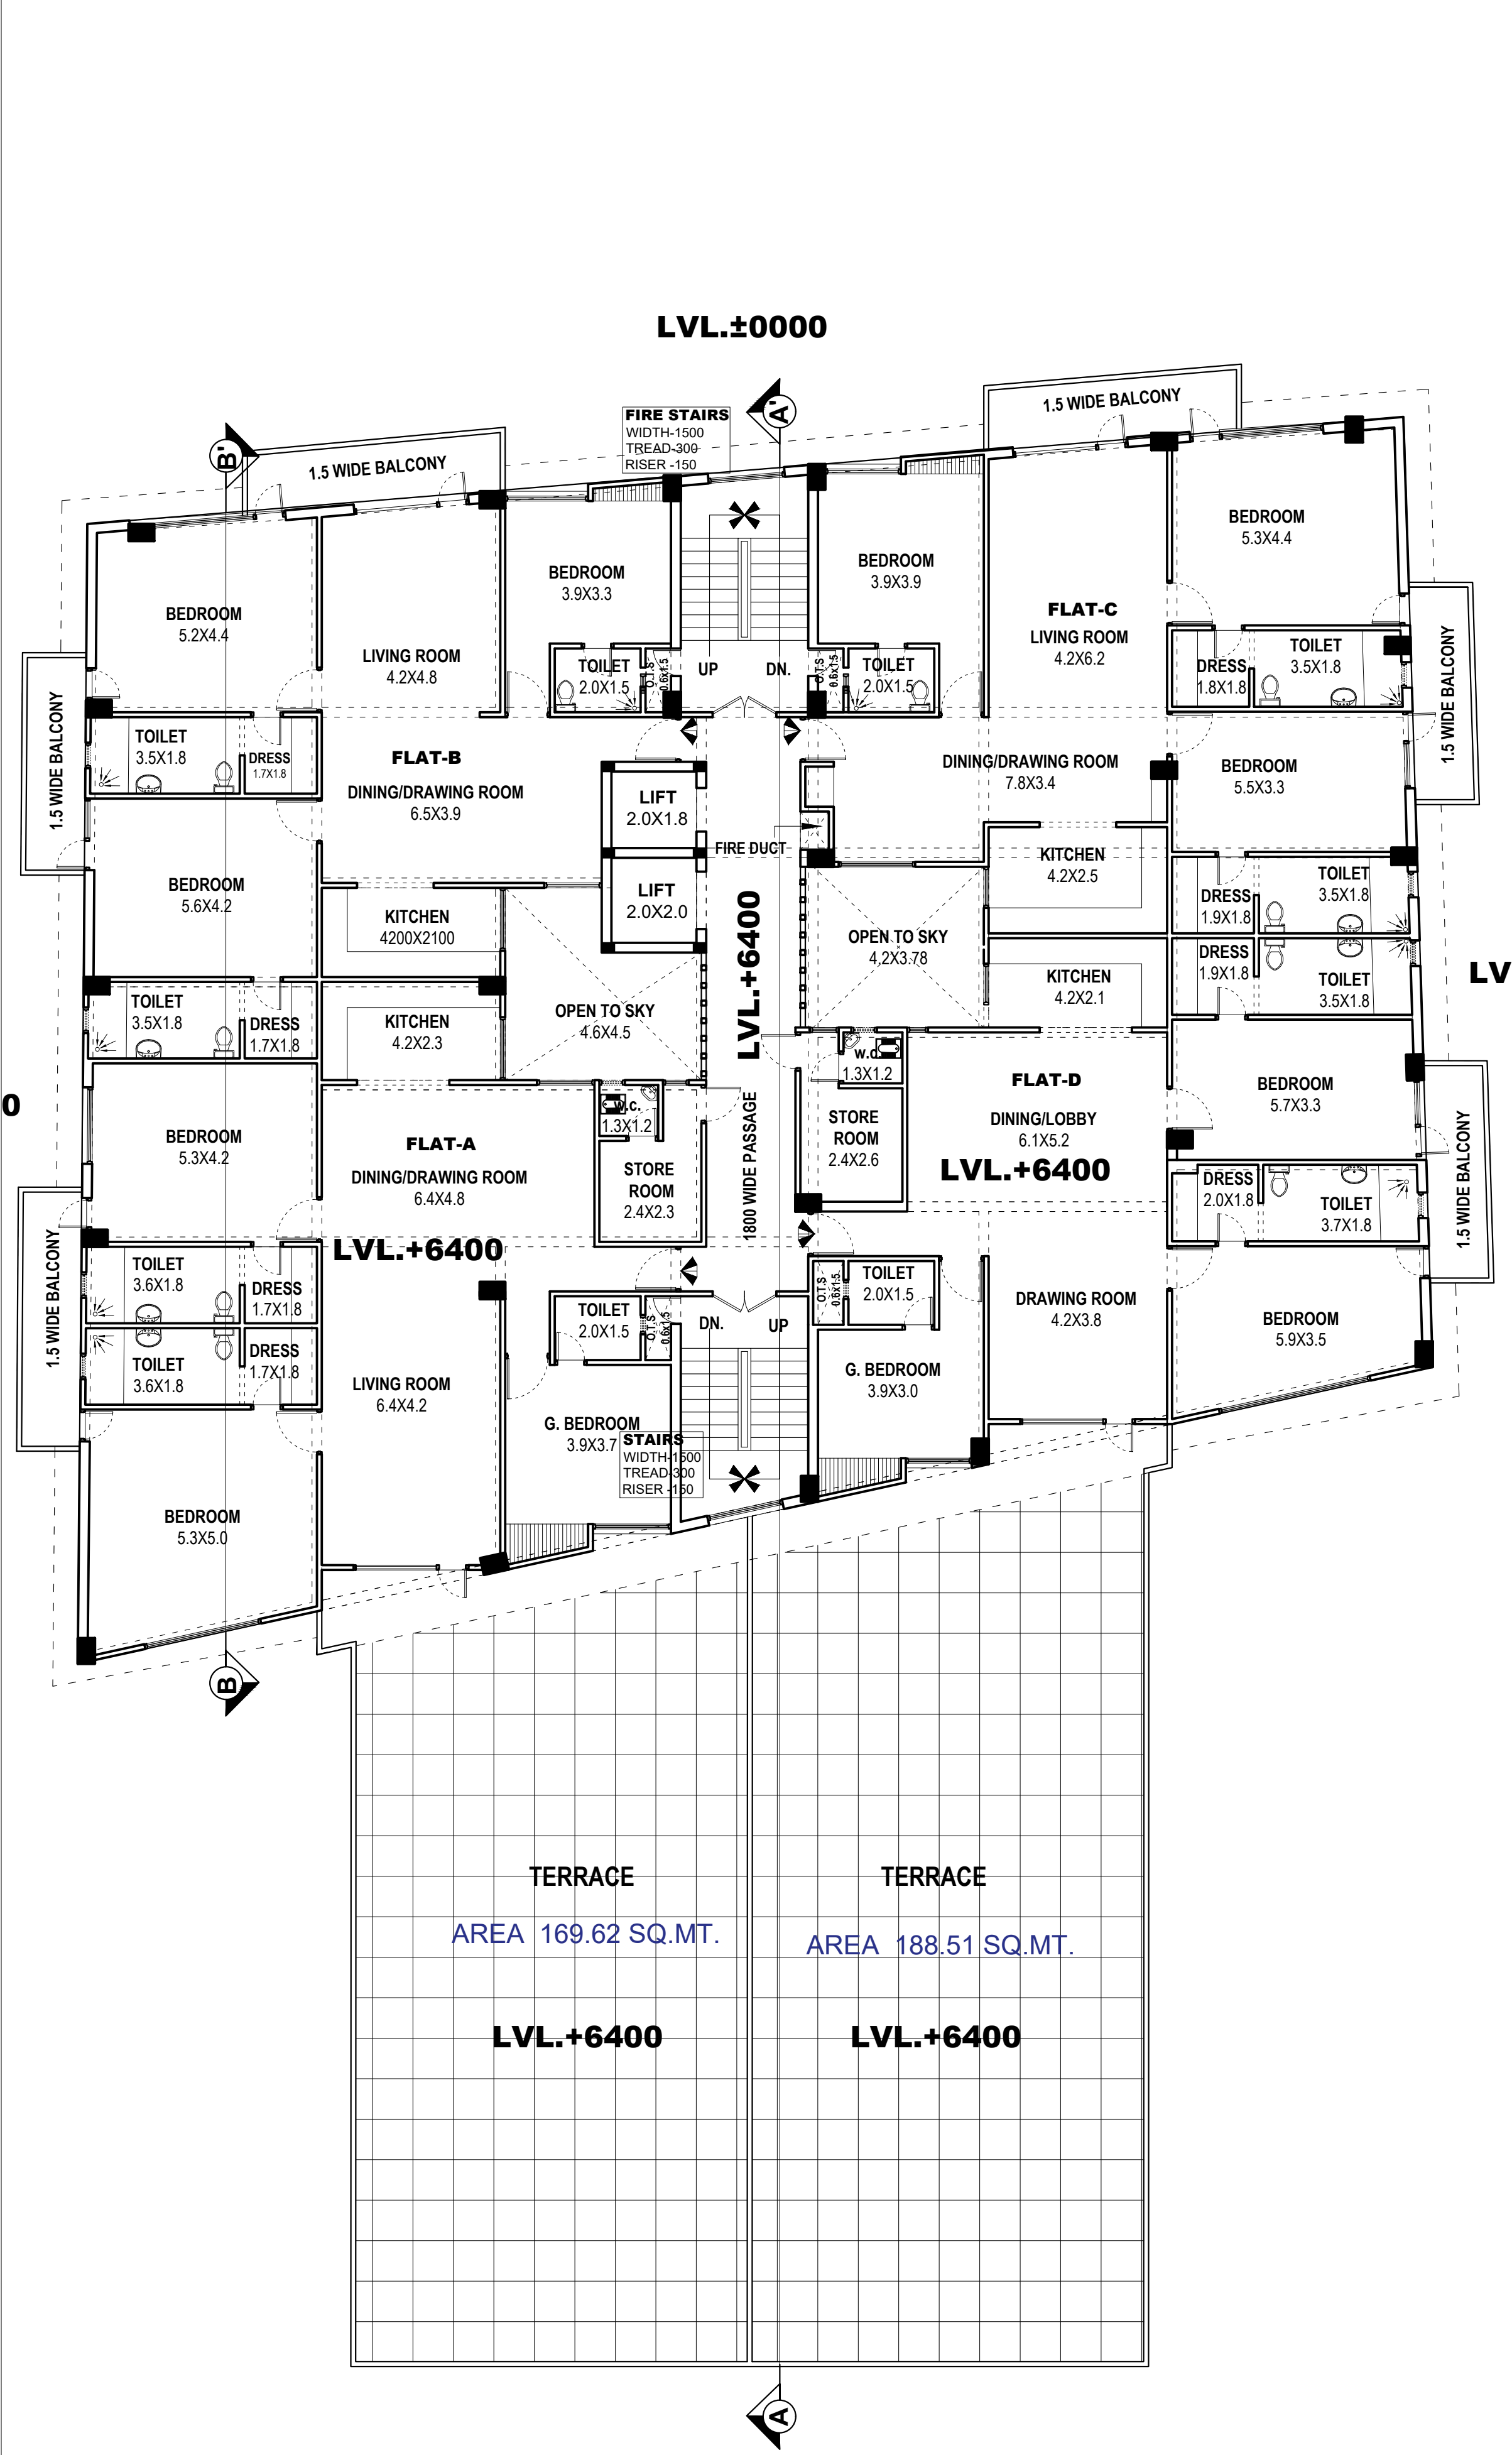

PROPOSED -

PROPOSED
COMMERCIAL COMPLEX
& GROUP HOUSING

FOR DR. RAJESH KUMAR SETH,
DR. VIJAY KUMAR SETH,
DR. AJEET KUMAR SETH,
MR. VIKRAM SETH,
DR. (MRS.) SUNITA SETH,
MR. RAVI SETH,
DR. (MRS.) VEENA BAJPAI,
MR. ANKUR BAJPAI,
MR. AMIT SETH;
ON PLOT NO. 4 AT
CAPPER ROAD, LALBAGH,
LUCKNOW.

OWNER'S SIGN

THIS IS TO CERTIFY THAT THIS PROPOSED DRAWING IS
PREPARED AS PER MASTER PLAN 2031 AND
BUILDING BYE LAWS-2016


*All Dimensions are in Millimeters or as specified

DWG. TITLE -
SECOND FLOOR PLAN

SCALE -	SHEET NO. -	JOB NO. -
DATED -	DEALT BY -	CHECKED. BY -
ARCHITECT		

SUBMISSION DRAWING

point architects pvt. ltd.
ARCHITECTS & INT. DESIGNERS
FLAT No. 1, G. FLOOR, 4/45, ROYAL COURT
WAZIR HASAN ROAD, LUCKNOW
Ph.: 0522-4073807, Email: point_arch_@rediffmail.com

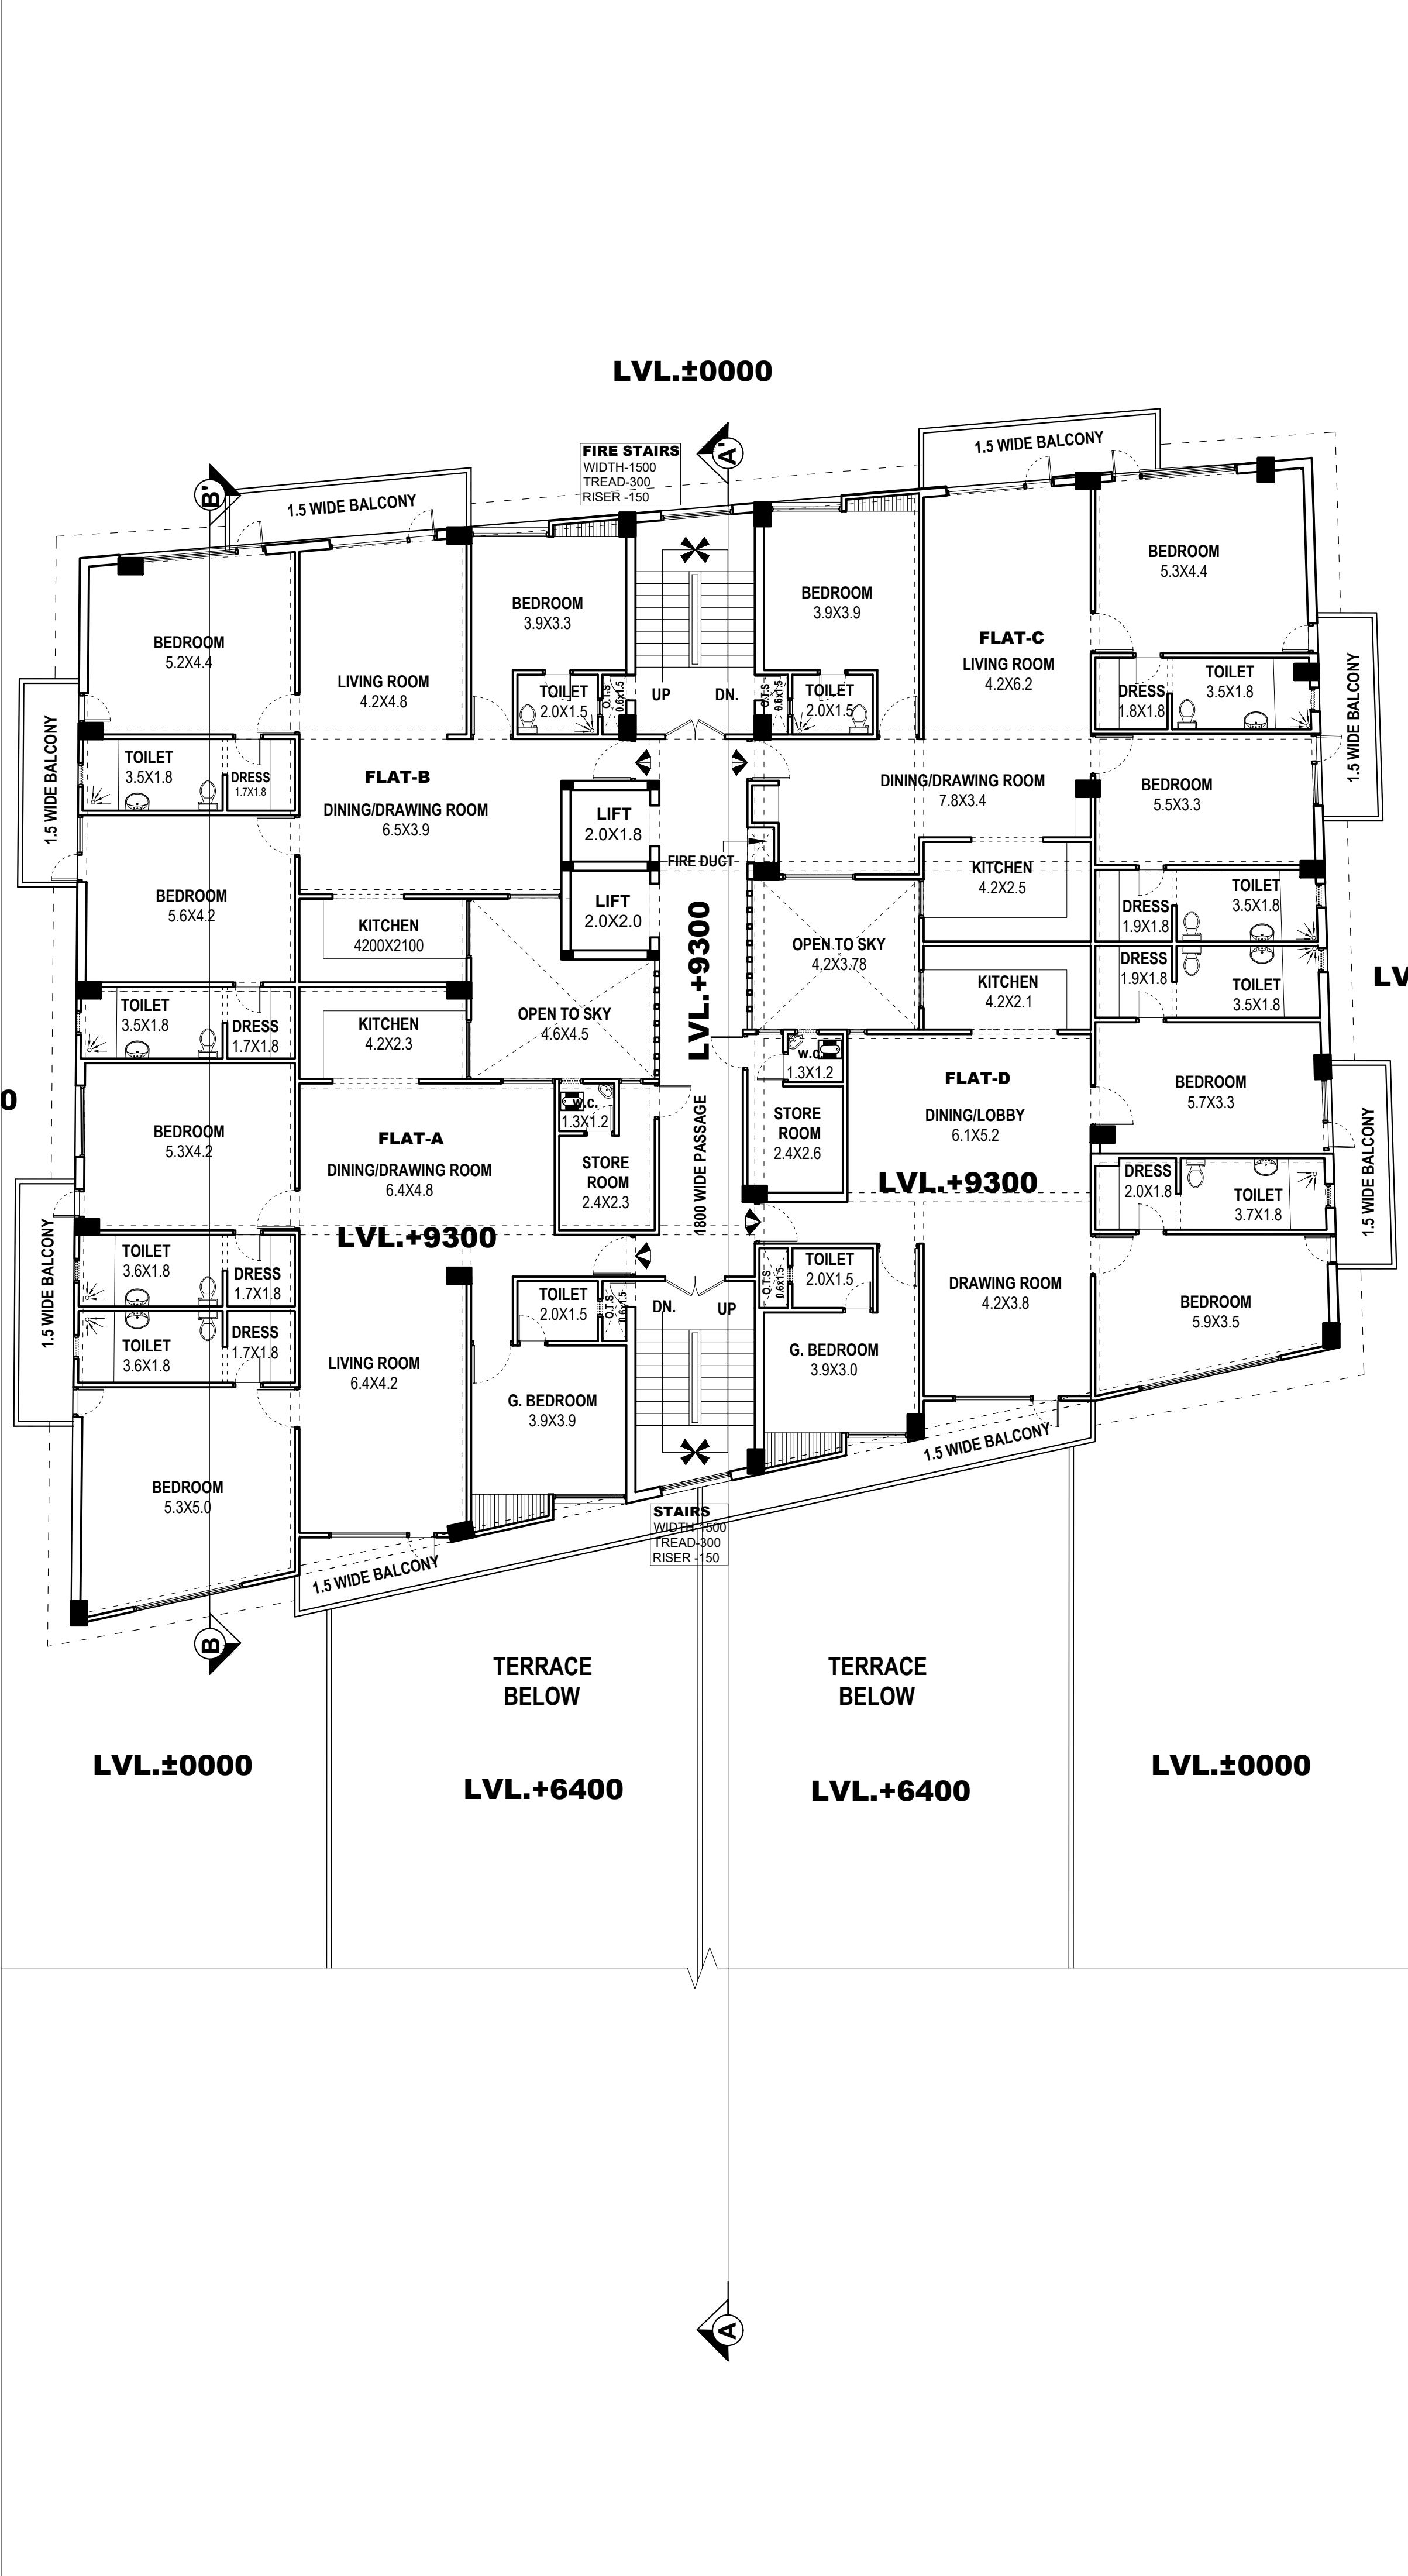

PROPOSED -

PROPOSED
COMMERCIAL COMPLEX
& GROUP HOUSING

FOR DR. RAJESH KUMAR SETH,
DR. VIJAY KUMAR SETH,
DR. AJEET KUMAR SETH,
MR. VIKRAM SETH,
DR. (MRS.) SUNITA SETH,
MR. RAVI SETH,
DR. (MRS.) VEENA BAJPAI,
MR. ANKUR BAJPAI,
MR. AMIT SETH;
ON PLOT NO. 4 AT
CAPPER ROAD, LALBAGH,
LUCKNOW.

OWNER'S SIGN

THIS IS TO CERTIFY THAT THIS PROPOSED DRAWING IS
PREPARED AS PER MASTER PLAN 2031 AND
BUILDING BYE LAWS-2016

*All Dimensions are in Millimeters or as specified

DWG. TITLE -
THIRD FLOOR PLAN

SCALE -

SHEET NO. -

JOB NO. -

DATED -


DEALT BY -

CHECKED. BY -

ARCHITECT

SUBMISSION DRAWING

point architects pvt. ltd.
ARCHITECTS & INT. DESIGNERS
FLAT No. 1, G. FLOOR, 4/45, ROYAL COURT
WAZIR HASAN ROAD, LUCKNOW
Ph.: 0522-4073807, Email: point_arch_@rediffmail.com

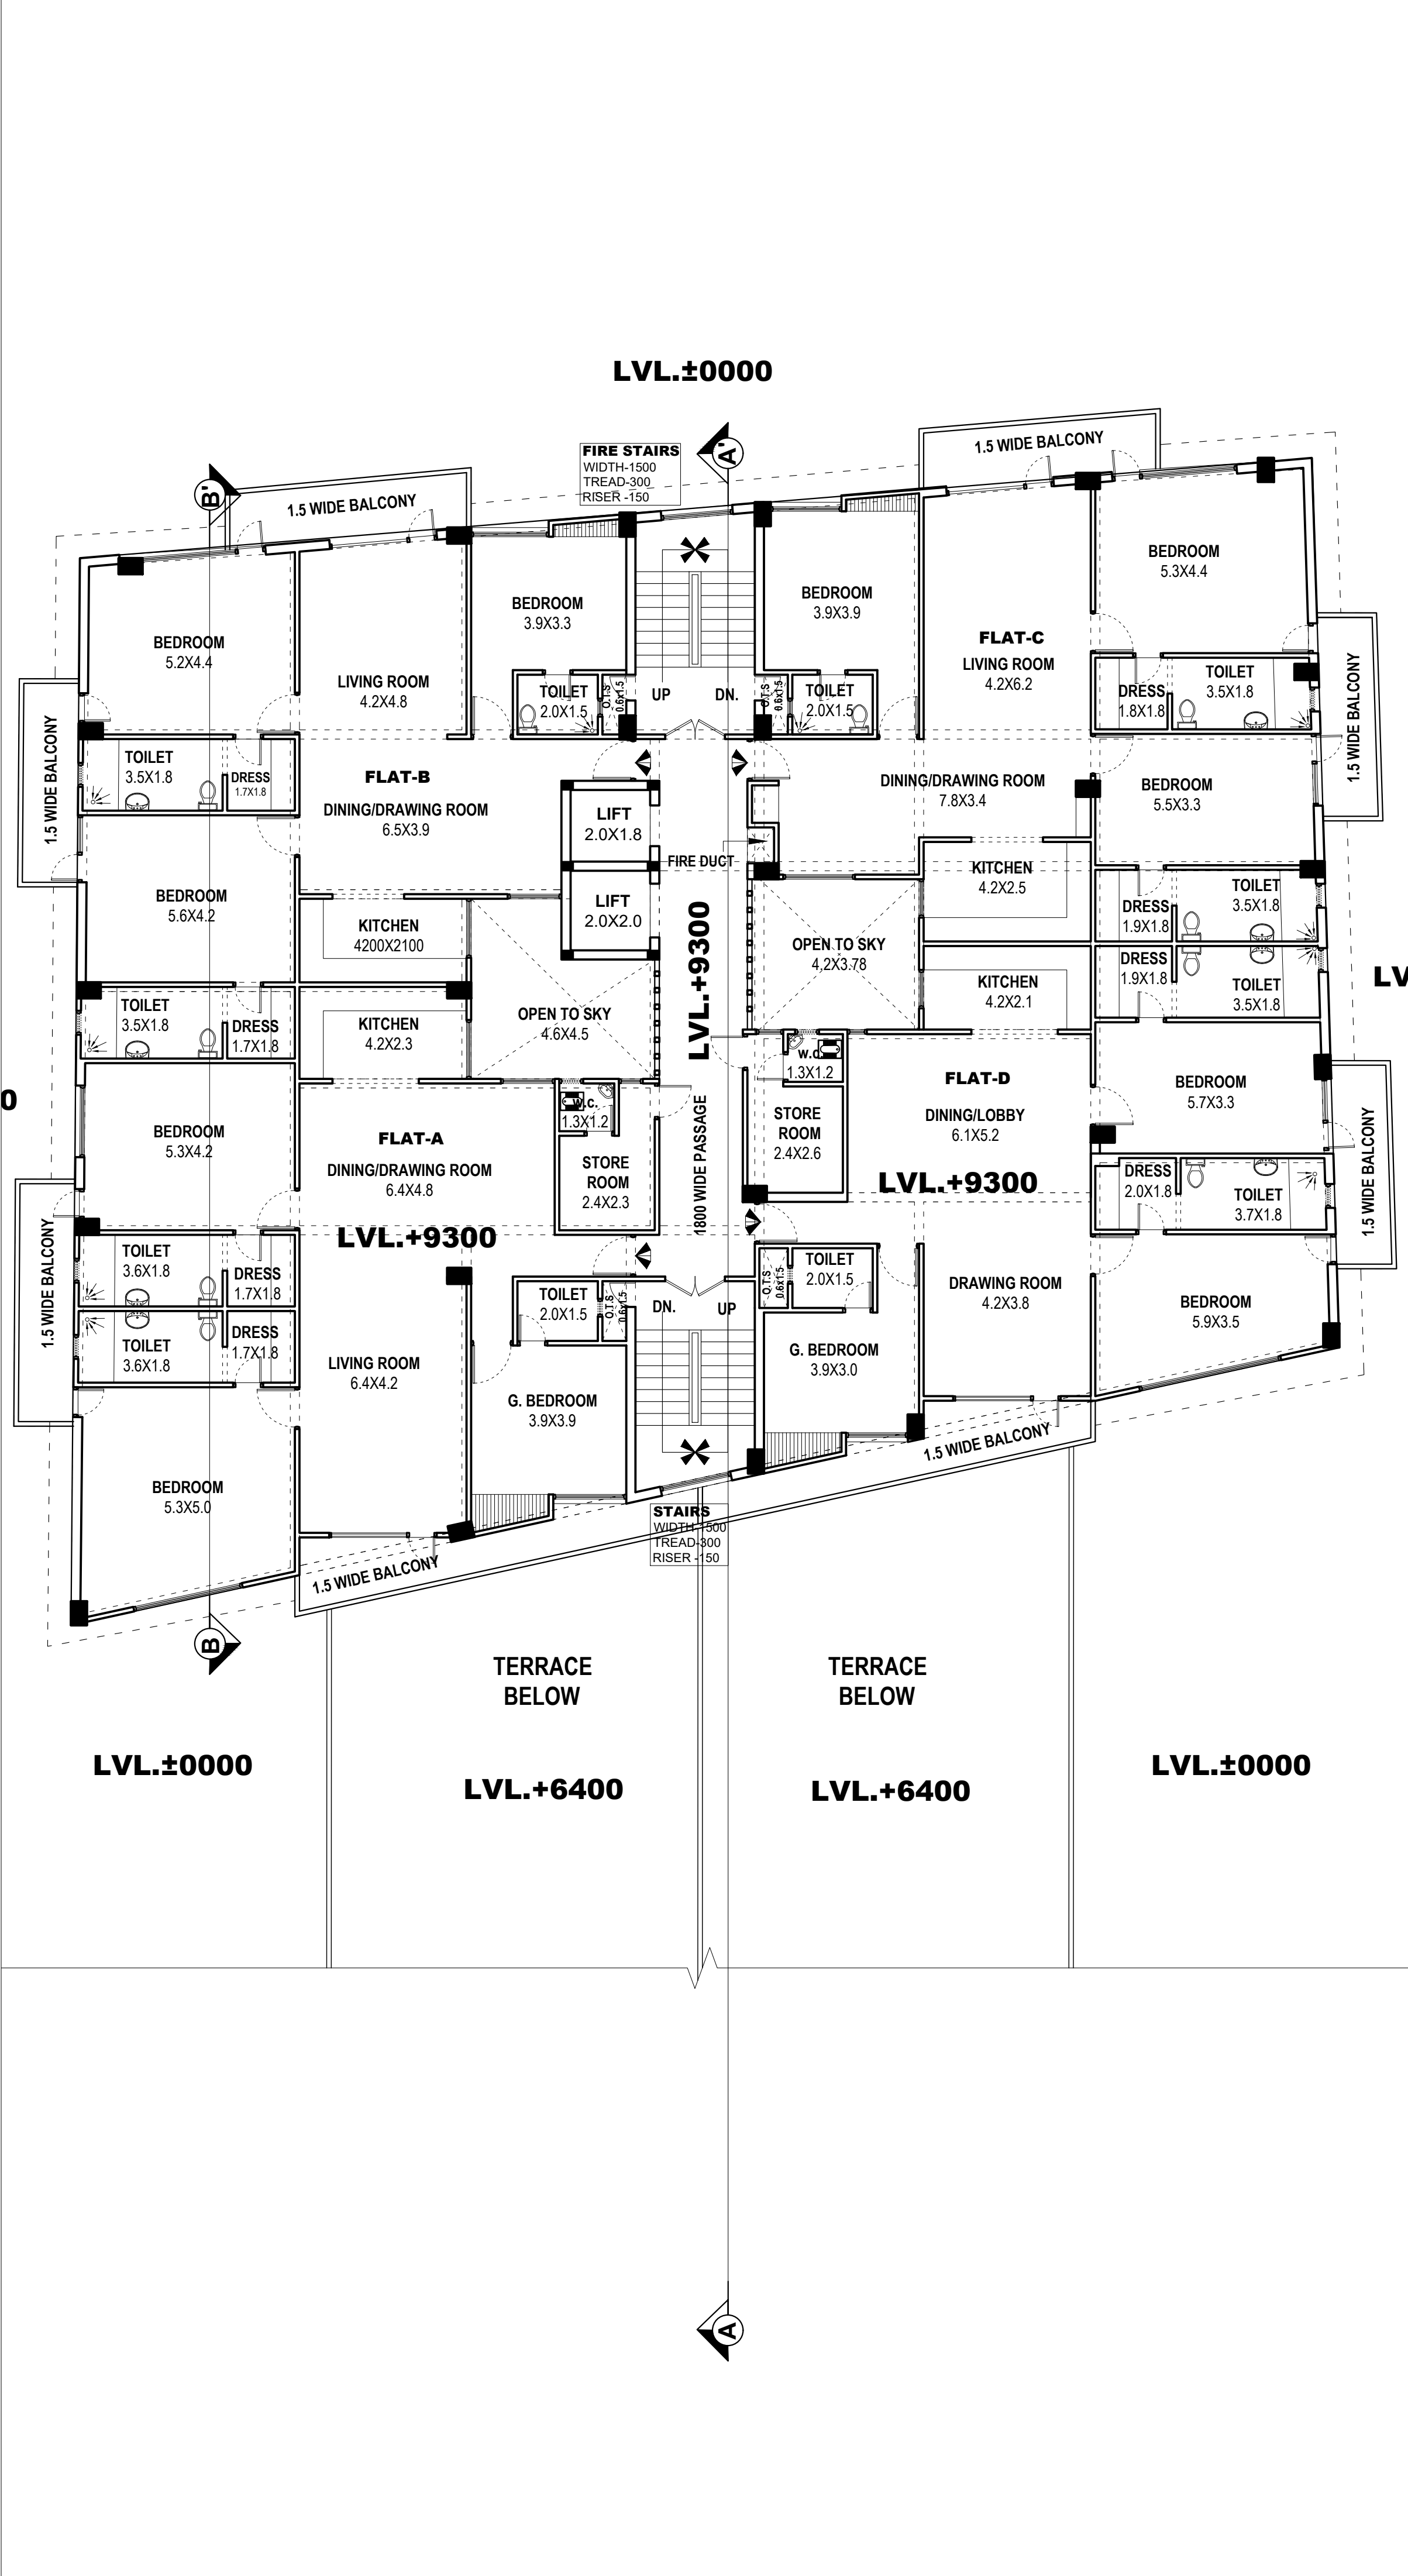

PROPOSED -

PROPOSED
COMMERCIAL COMPLEX
& GROUP HOUSING

FOR DR. RAJESH KUMAR SETH,
DR. VIJAY KUMAR SETH,
DR. AJEET KUMAR SETH,
MR. VIKRAM SETH,
DR. (MRS.) SUNITA SETH,
MR. RAVI SETH,
DR. (MRS.) VEENA BAJPAI,
MR. ANKUR BAJPAI,
MR. AMIT SETH;
ON PLOT NO. 4 AT
CAPPER ROAD, LALBAGH,
LUCKNOW.

OWNER'S SIGN

THIS IS TO CERTIFY THAT THIS PROPOSED DRAWING IS
PREPARED AS PER MASTER PLAN 2031 AND
BUILDING BYE LAWS-2016

*All Dimensions are in Millimeters or as specified

DWG. TITLE -
FOURTH FLOOR PLAN

SCALE -

SHEET NO. -

JOB NO. -

DATED -


DEALT BY -

CHECKED. BY -

ARCHITECT

SUBMISSION DRAWING

point architects pvt. ltd.
ARCHITECTS & INT. DESIGNERS
FLAT No. 1, G. FLOOR, 4/45, ROYAL COURT
WAZIR HASAN ROAD, LUCKNOW
Ph.: 0522-4073807, Email: point_arch_@rediffmail.com

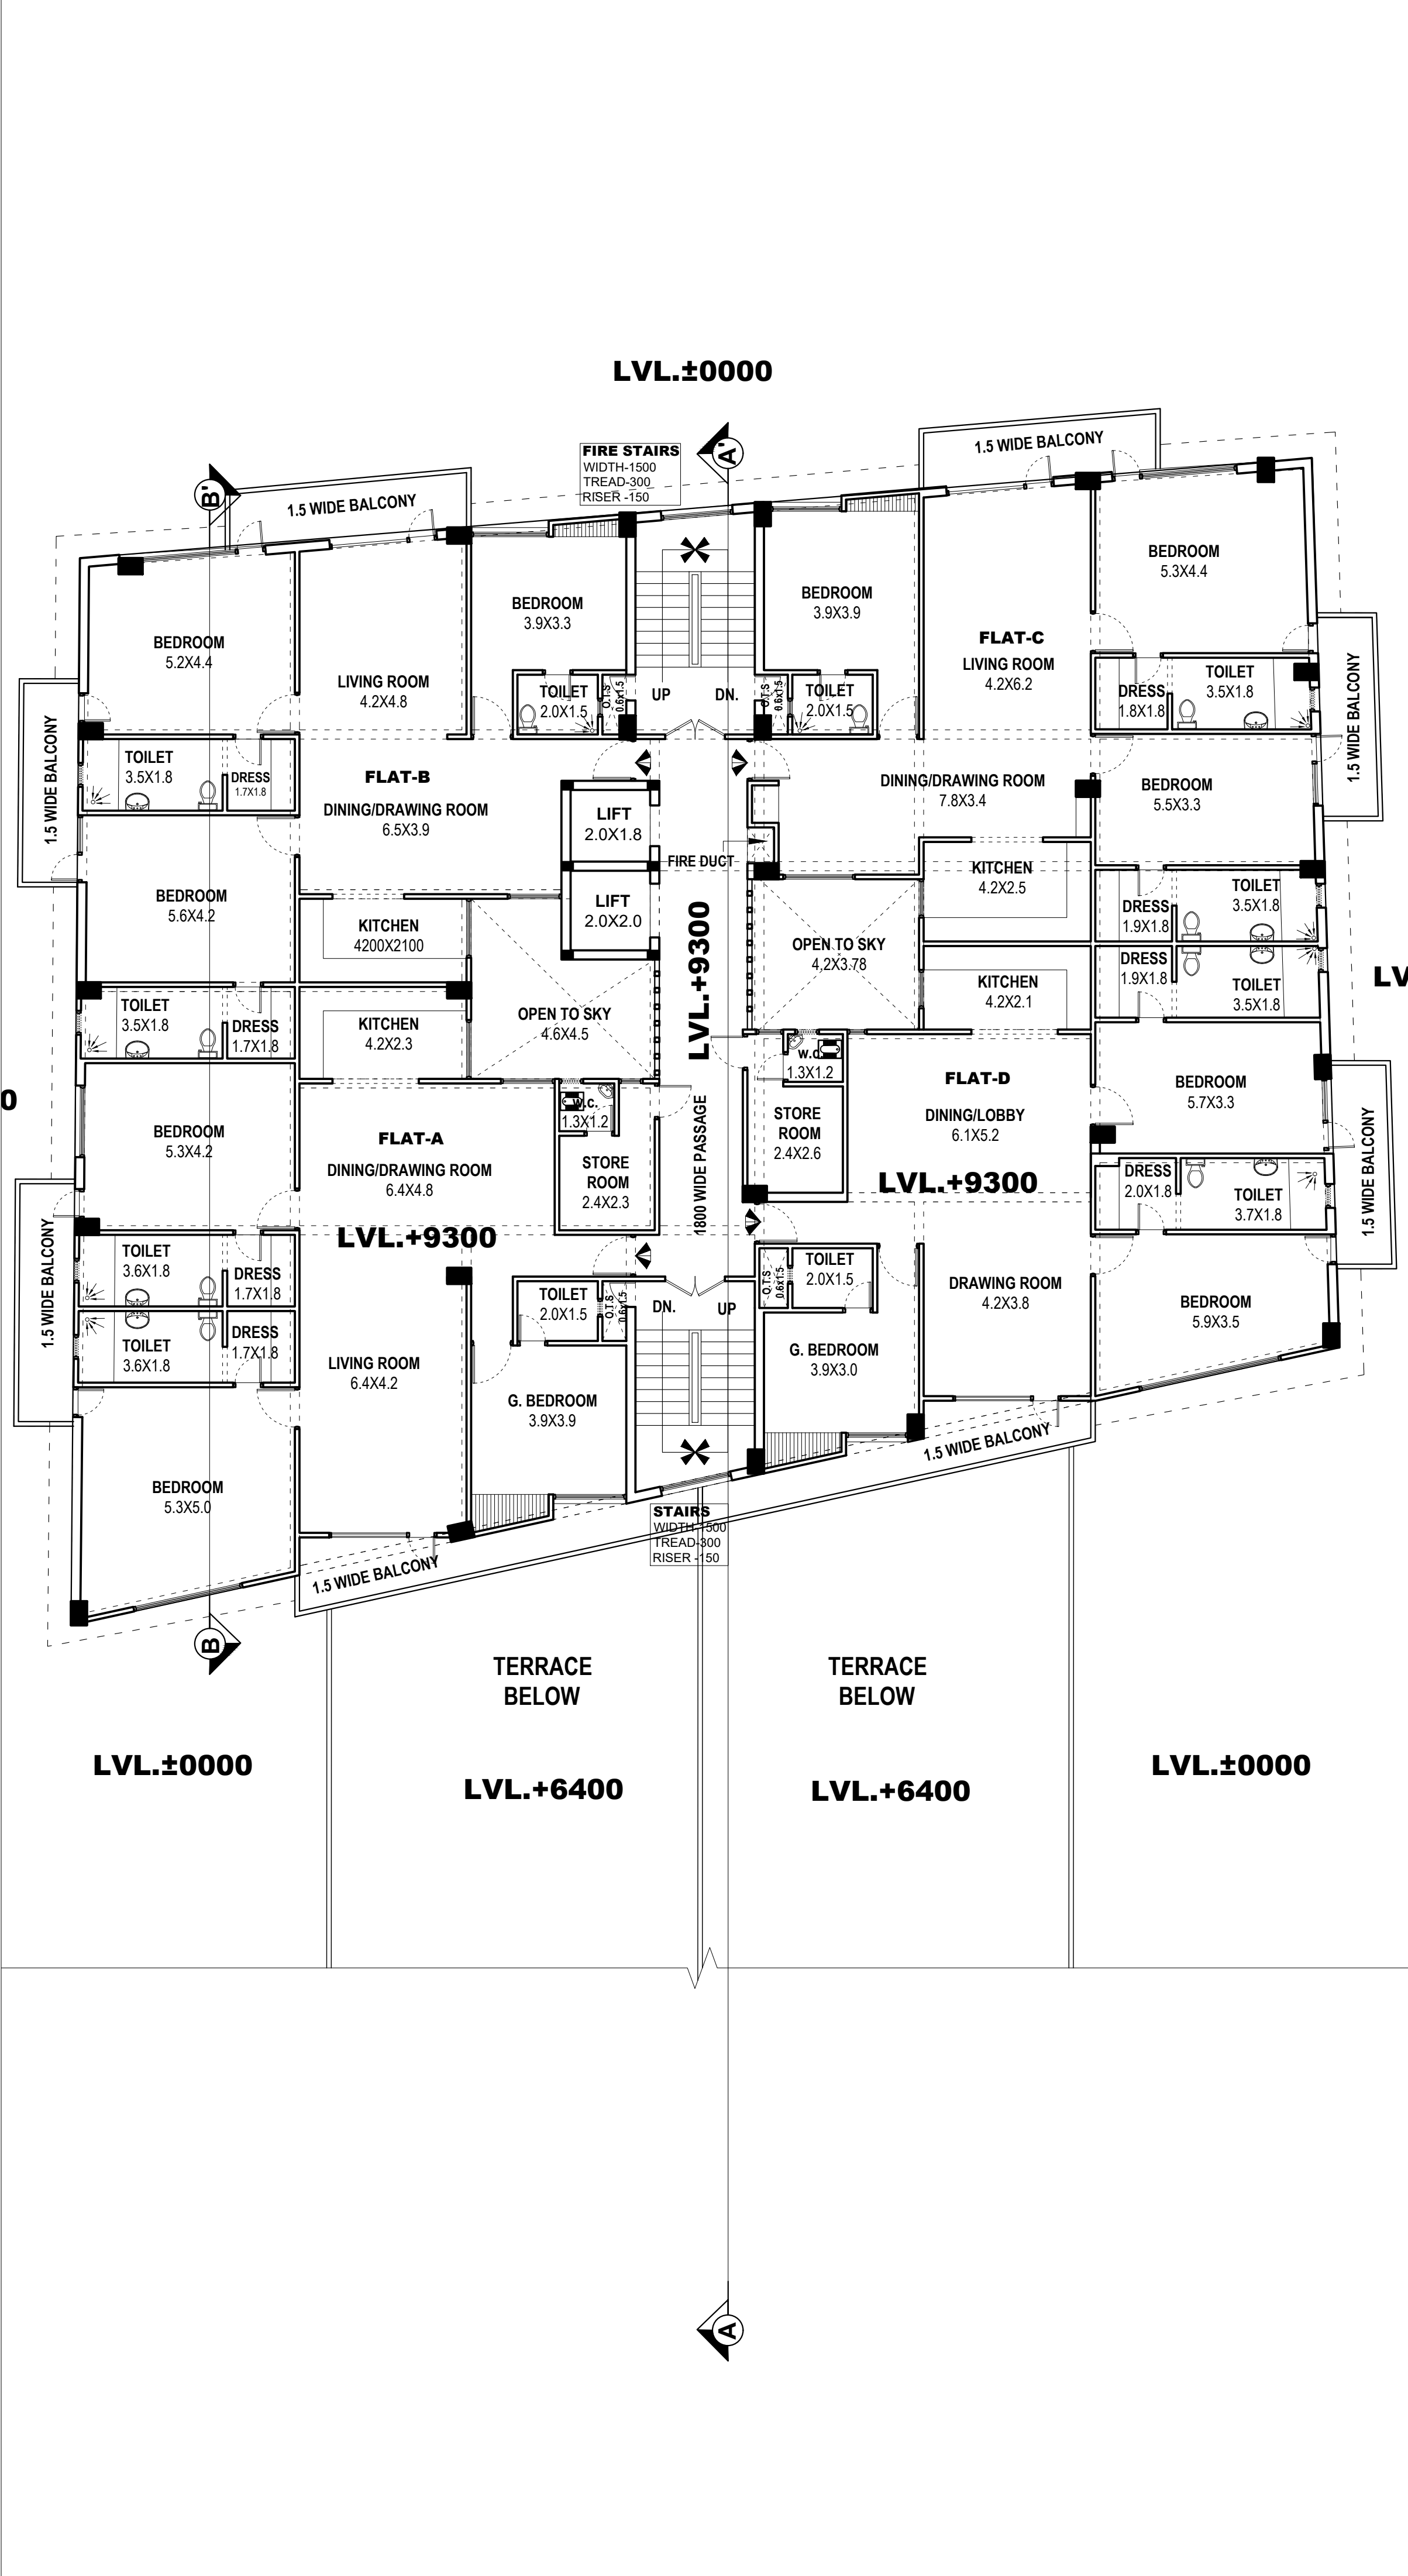

PROPOSED -

PROPOSED
COMMERCIAL COMPLEX
& GROUP HOUSING

FOR DR. RAJESH KUMAR SETH,
DR. VIJAY KUMAR SETH,
DR. AJEET KUMAR SETH,
MR. VIKRAM SETH,
DR. (MRS.) SUNITA SETH,
MR. RAVI SETH,
DR. (MRS.) VEENA BAJPAI,
MR. ANKUR BAJPAI,
MR. AMIT SETH;
ON PLOT NO. 4 AT
CAPPER ROAD, LALBAGH,
LUCKNOW.

OWNER'S SIGN

THIS IS TO CERTIFY THAT THIS PROPOSED DRAWING IS
PREPARED AS PER MASTER PLAN 2031 AND
BUILDING BYE LAWS-2016

*All Dimensions are in Millimeters or as specified

DWG. TITLE -
FIFTH FLOOR PLAN

SCALE -

SHEET NO. -

JOB NO. -

DATED -


DEALT BY -

CHECKED. BY -

ARCHITECT

SUBMISSION DRAWING

point architects pvt. ltd.
ARCHITECTS & INT. DESIGNERS
FLAT No. 1, G. FLOOR, 4/45, ROYAL COURT
WAZIR HASAN ROAD, LUCKNOW
Ph.: 0522-4073807, Email: point_arch_@rediffmail.com

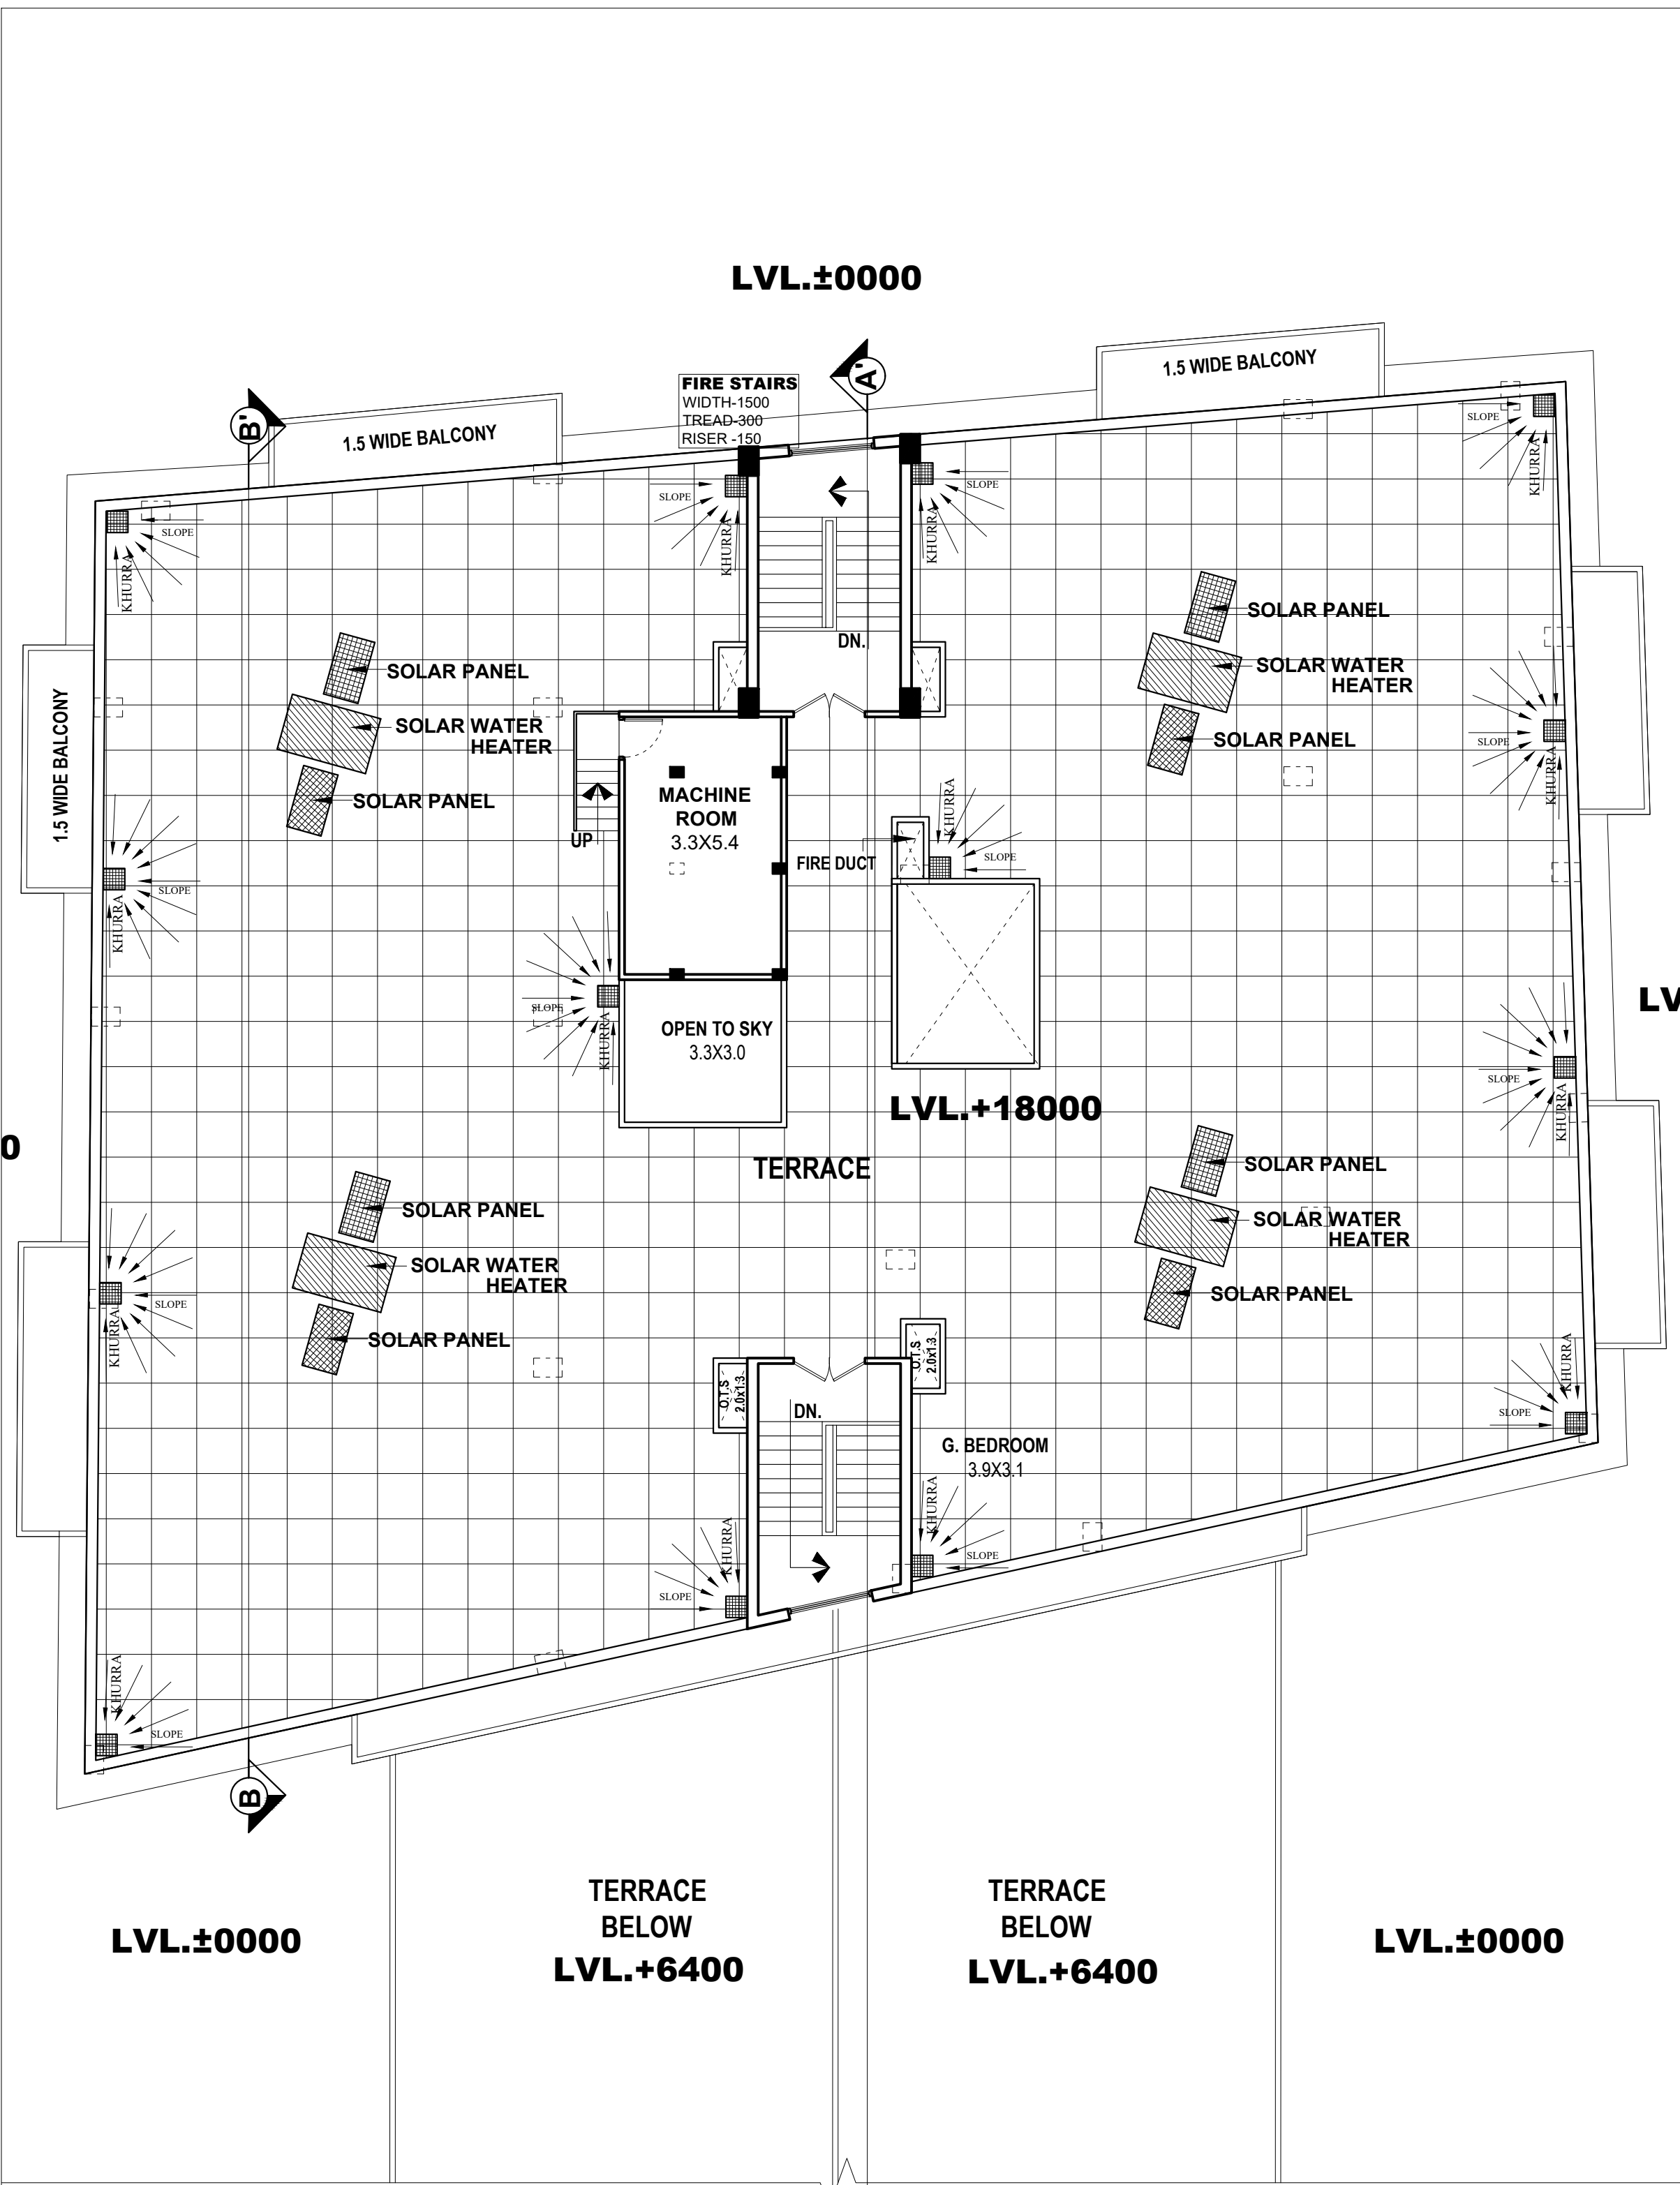

PROPOSED
COMMERCIAL COMPLEX
& GROUP HOUSING

FOR DR. RAJESH KUMAR SETH,
DR. VIJAY KUMAR SETH,
DR. AJEET KUMAR SETH,
MR. VIKRAM SETH,
DR. (MRS.) SUNITA SETH,
MR. RAVI SETH,
DR. (MRS.) VEENA BAJPAI,
MR. ANKUR BAJPAI,
MR. AMIT SETH;
ON PLOT NO. 4 AT
CAPPER ROAD, LALBAGH,
LUCKNOW.

OWNER'S SIGN

THIS IS TO CERTIFY THAT THIS PROPOSED DRAWING IS
PREPARED AS PER MASTER PLAN 2031 AND
BUILDING BYE LAWS-2016


*All Dimensions are in Millimeters or as specified

DWG. TITLE -
TERRACE FLOOR PLAN

SCALE -	SHEET NO. -	JOB NO. -
DATED -	DEALT BY -	CHECKED. BY -
ARCHITECT		

SUBMISSION DRAWING


point architects pvt. ltd.
ARCHITECTS & INT. DESIGNERS
FLAT No. 1, G. FLOOR, 4/45, ROYAL COURT
WAZIR HASAN ROAD, LUCKNOW
Ph.: 0522-4073807, Email: point_arch_@rediffmail.com

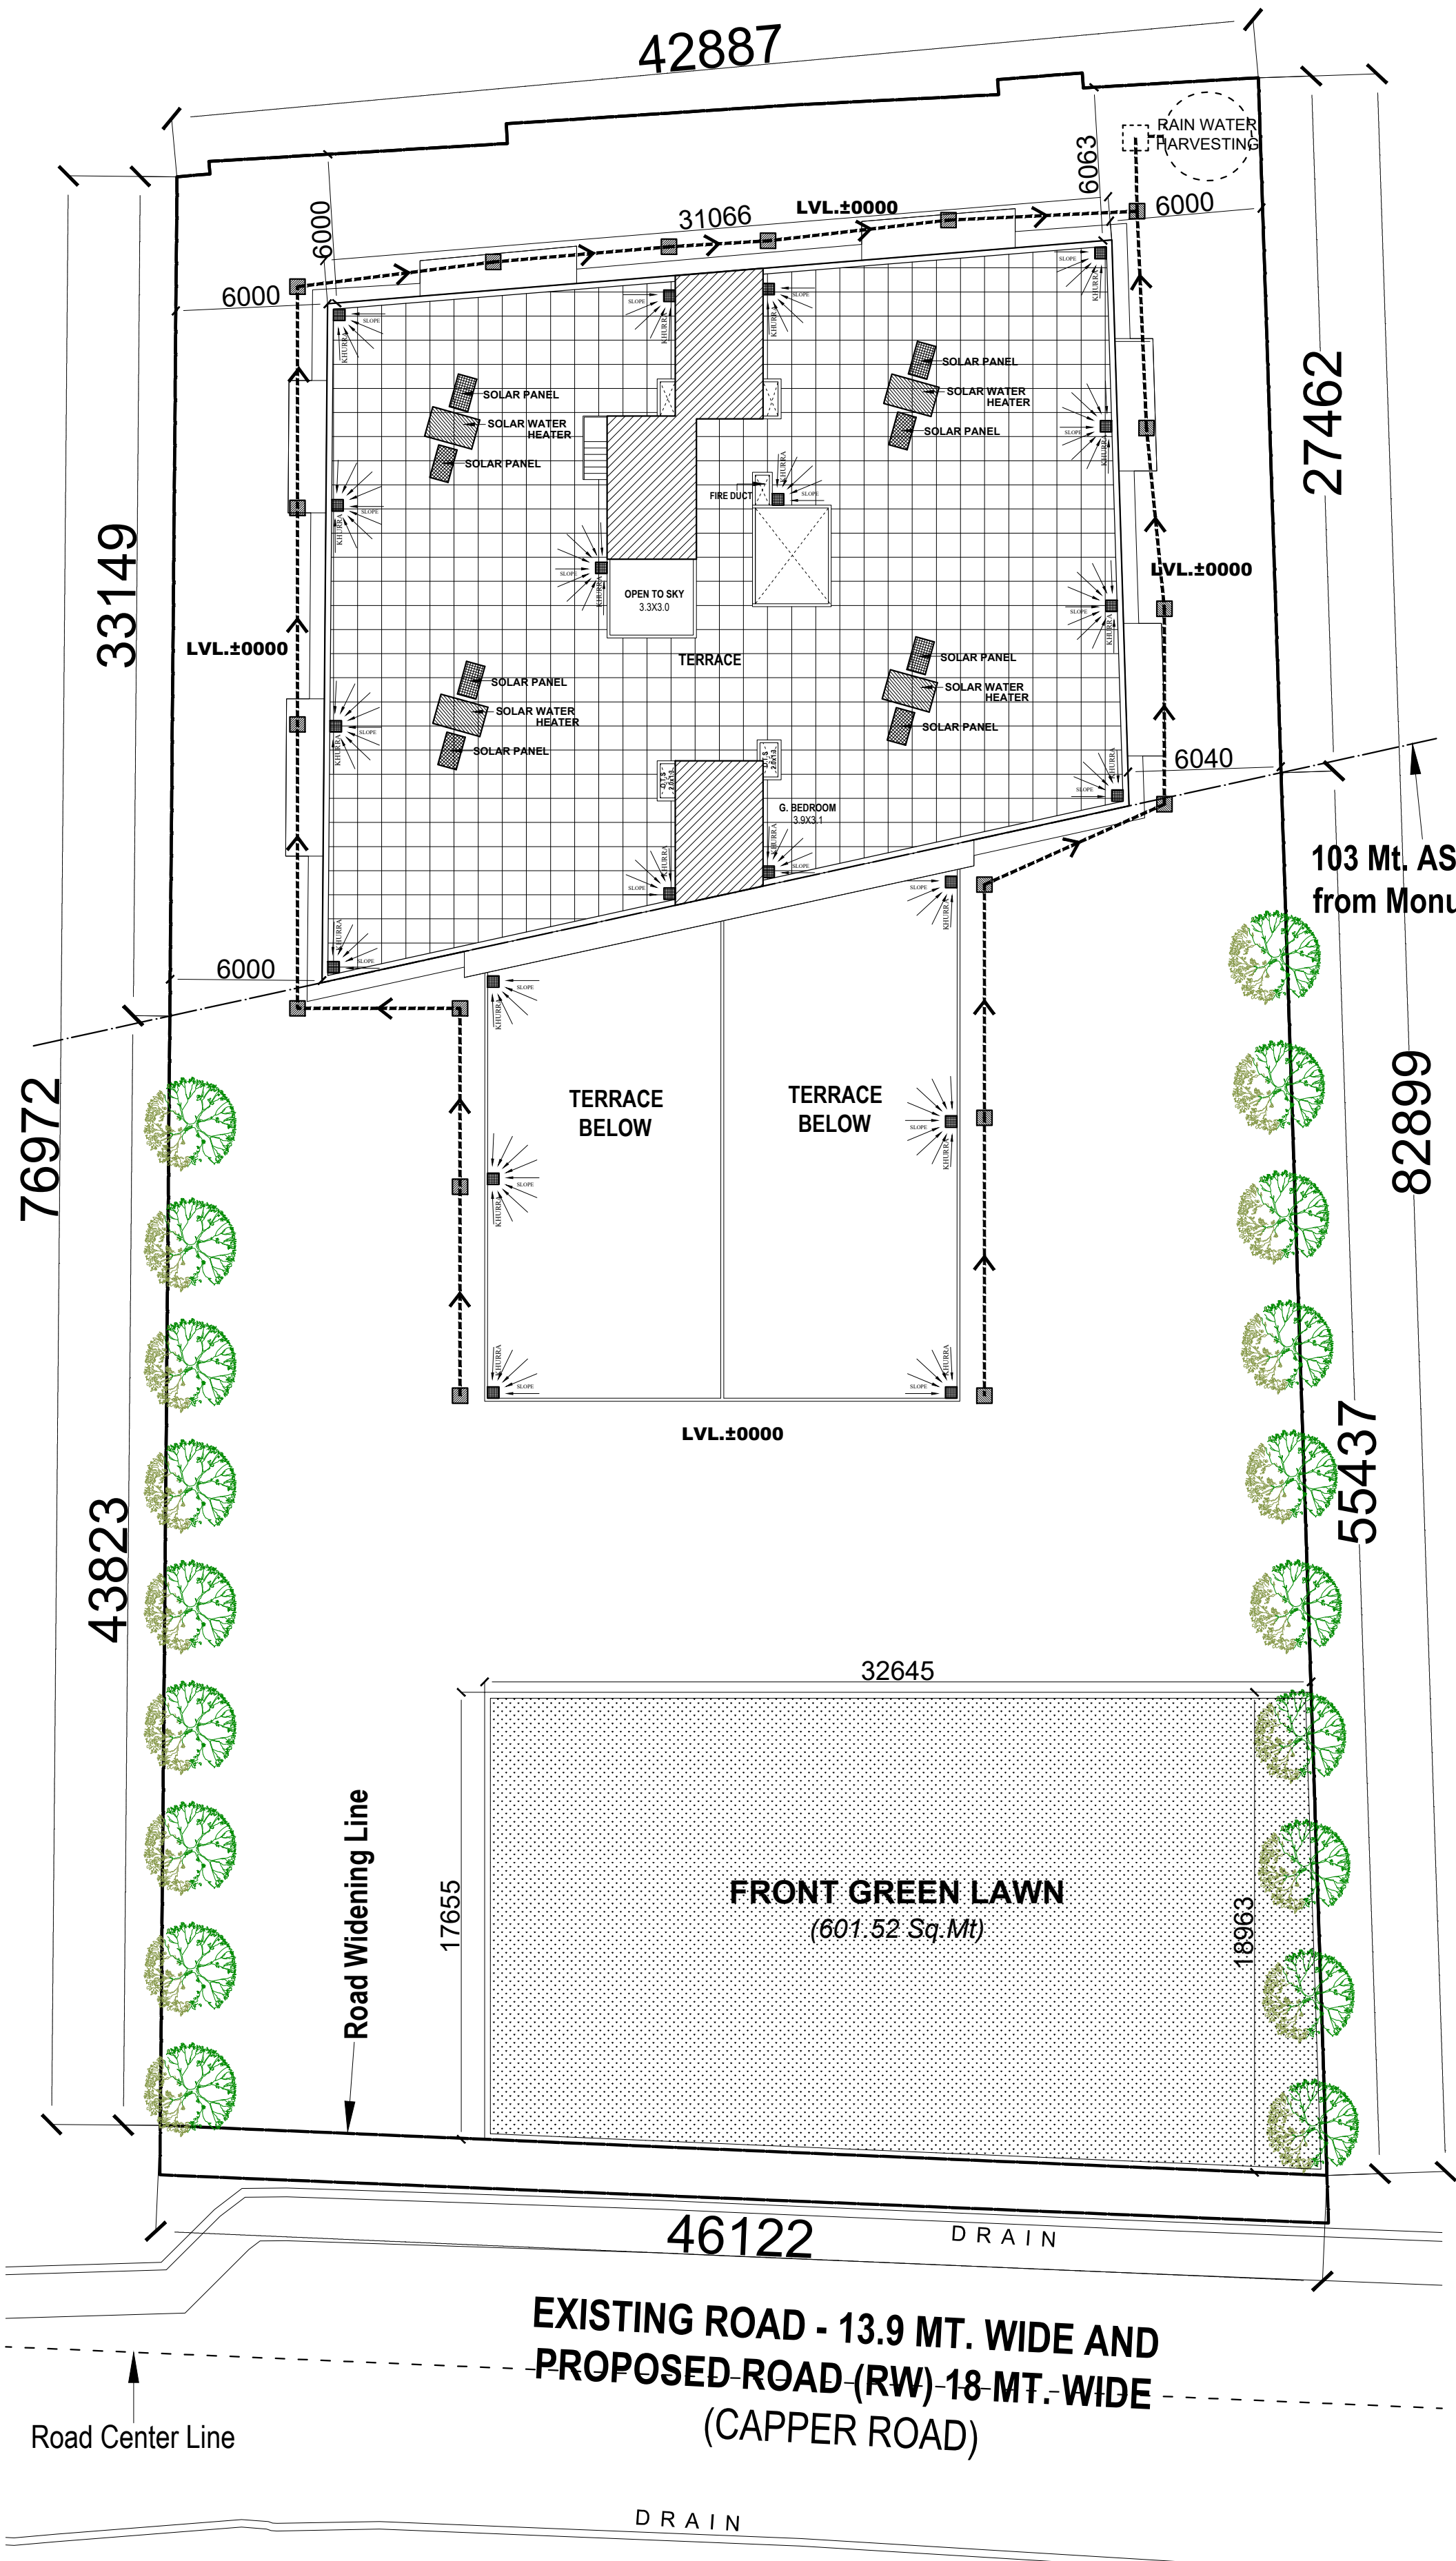

LANDSCAPE , RAIN WATER HARVESTING

**PROPOSED
COMMERCIAL COMPLEX
& GROUP HOUSING**

FOR DR. RAJESH KUMAR SETH,
DR. VIJAY KUMAR SETH,
DR. AJEET KUMAR SETH,
MR. VIKRAM SETH,
DR. (MRS.) SUNITA SETH,
MR. RAVI SETH,
DR. (MRS.) VEENA BAJPAI,
MR. ANKUR BAJPAI,
MR. AMIT SETH;
ON PLOT NO. 4 AT
CAPPER ROAD, LALBAGH,
LUCKNOW.

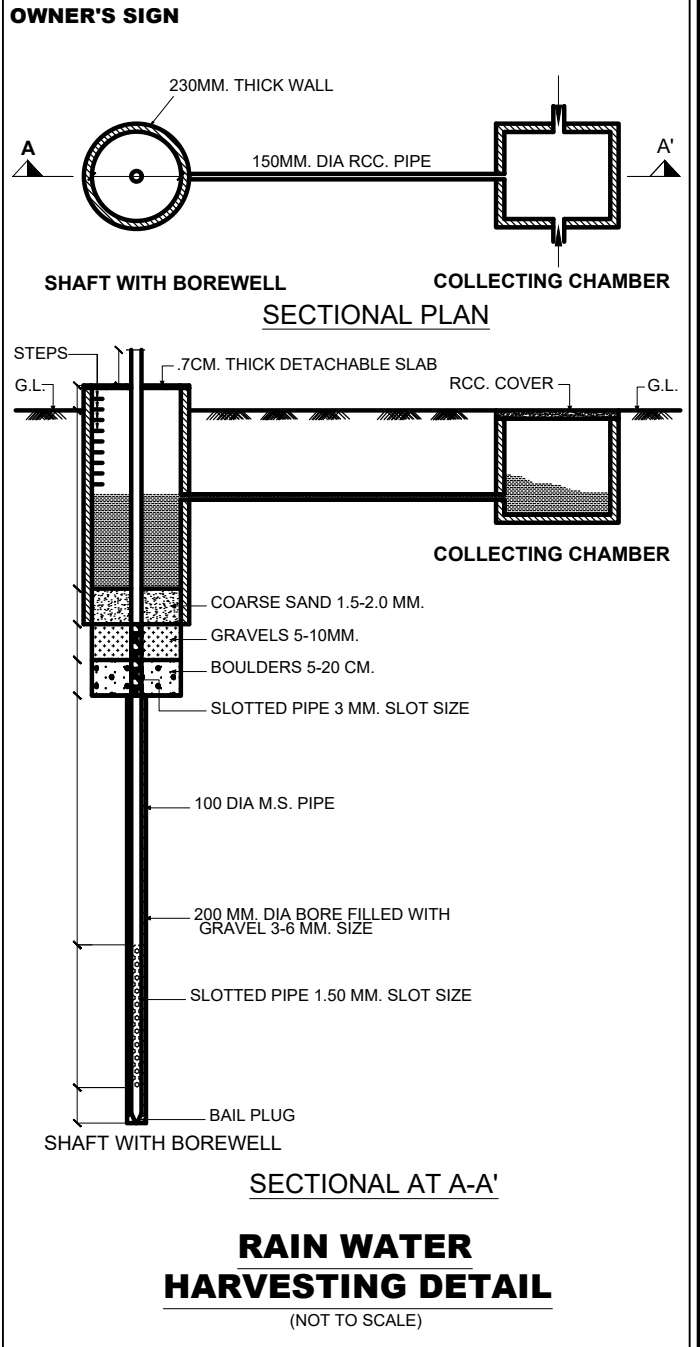

THIS IS TO CERTIFY THAT THIS PROPOSED DRAWING IS
PREPARED AS PER MASTER PLAN 2031 AND
BUILDING BYE LAWS-2016

*All Dimensions are in Millimeters or as specified

**DWG. TITLE -
DEVELOPMENT PLAN**


SCALE -	SHEET NO. -	JOB NO. -
---------	-------------	-----------

DATED -	DEALT BY -	CHECKED. BY -
---------	------------	---------------

ARCHITECT	
-----------	--

SUBMISSION DRAWING

point architects pvt. ltd.
ARCHITECTS & INT. DESIGNERS
FLAT No. 1, G. FLOOR, 4/45, ROYAL COURT
WAZIR HASAN ROAD, LUCKNOW
Ph.: 0522-4073807, Email: point_arch_@rediffmail.com

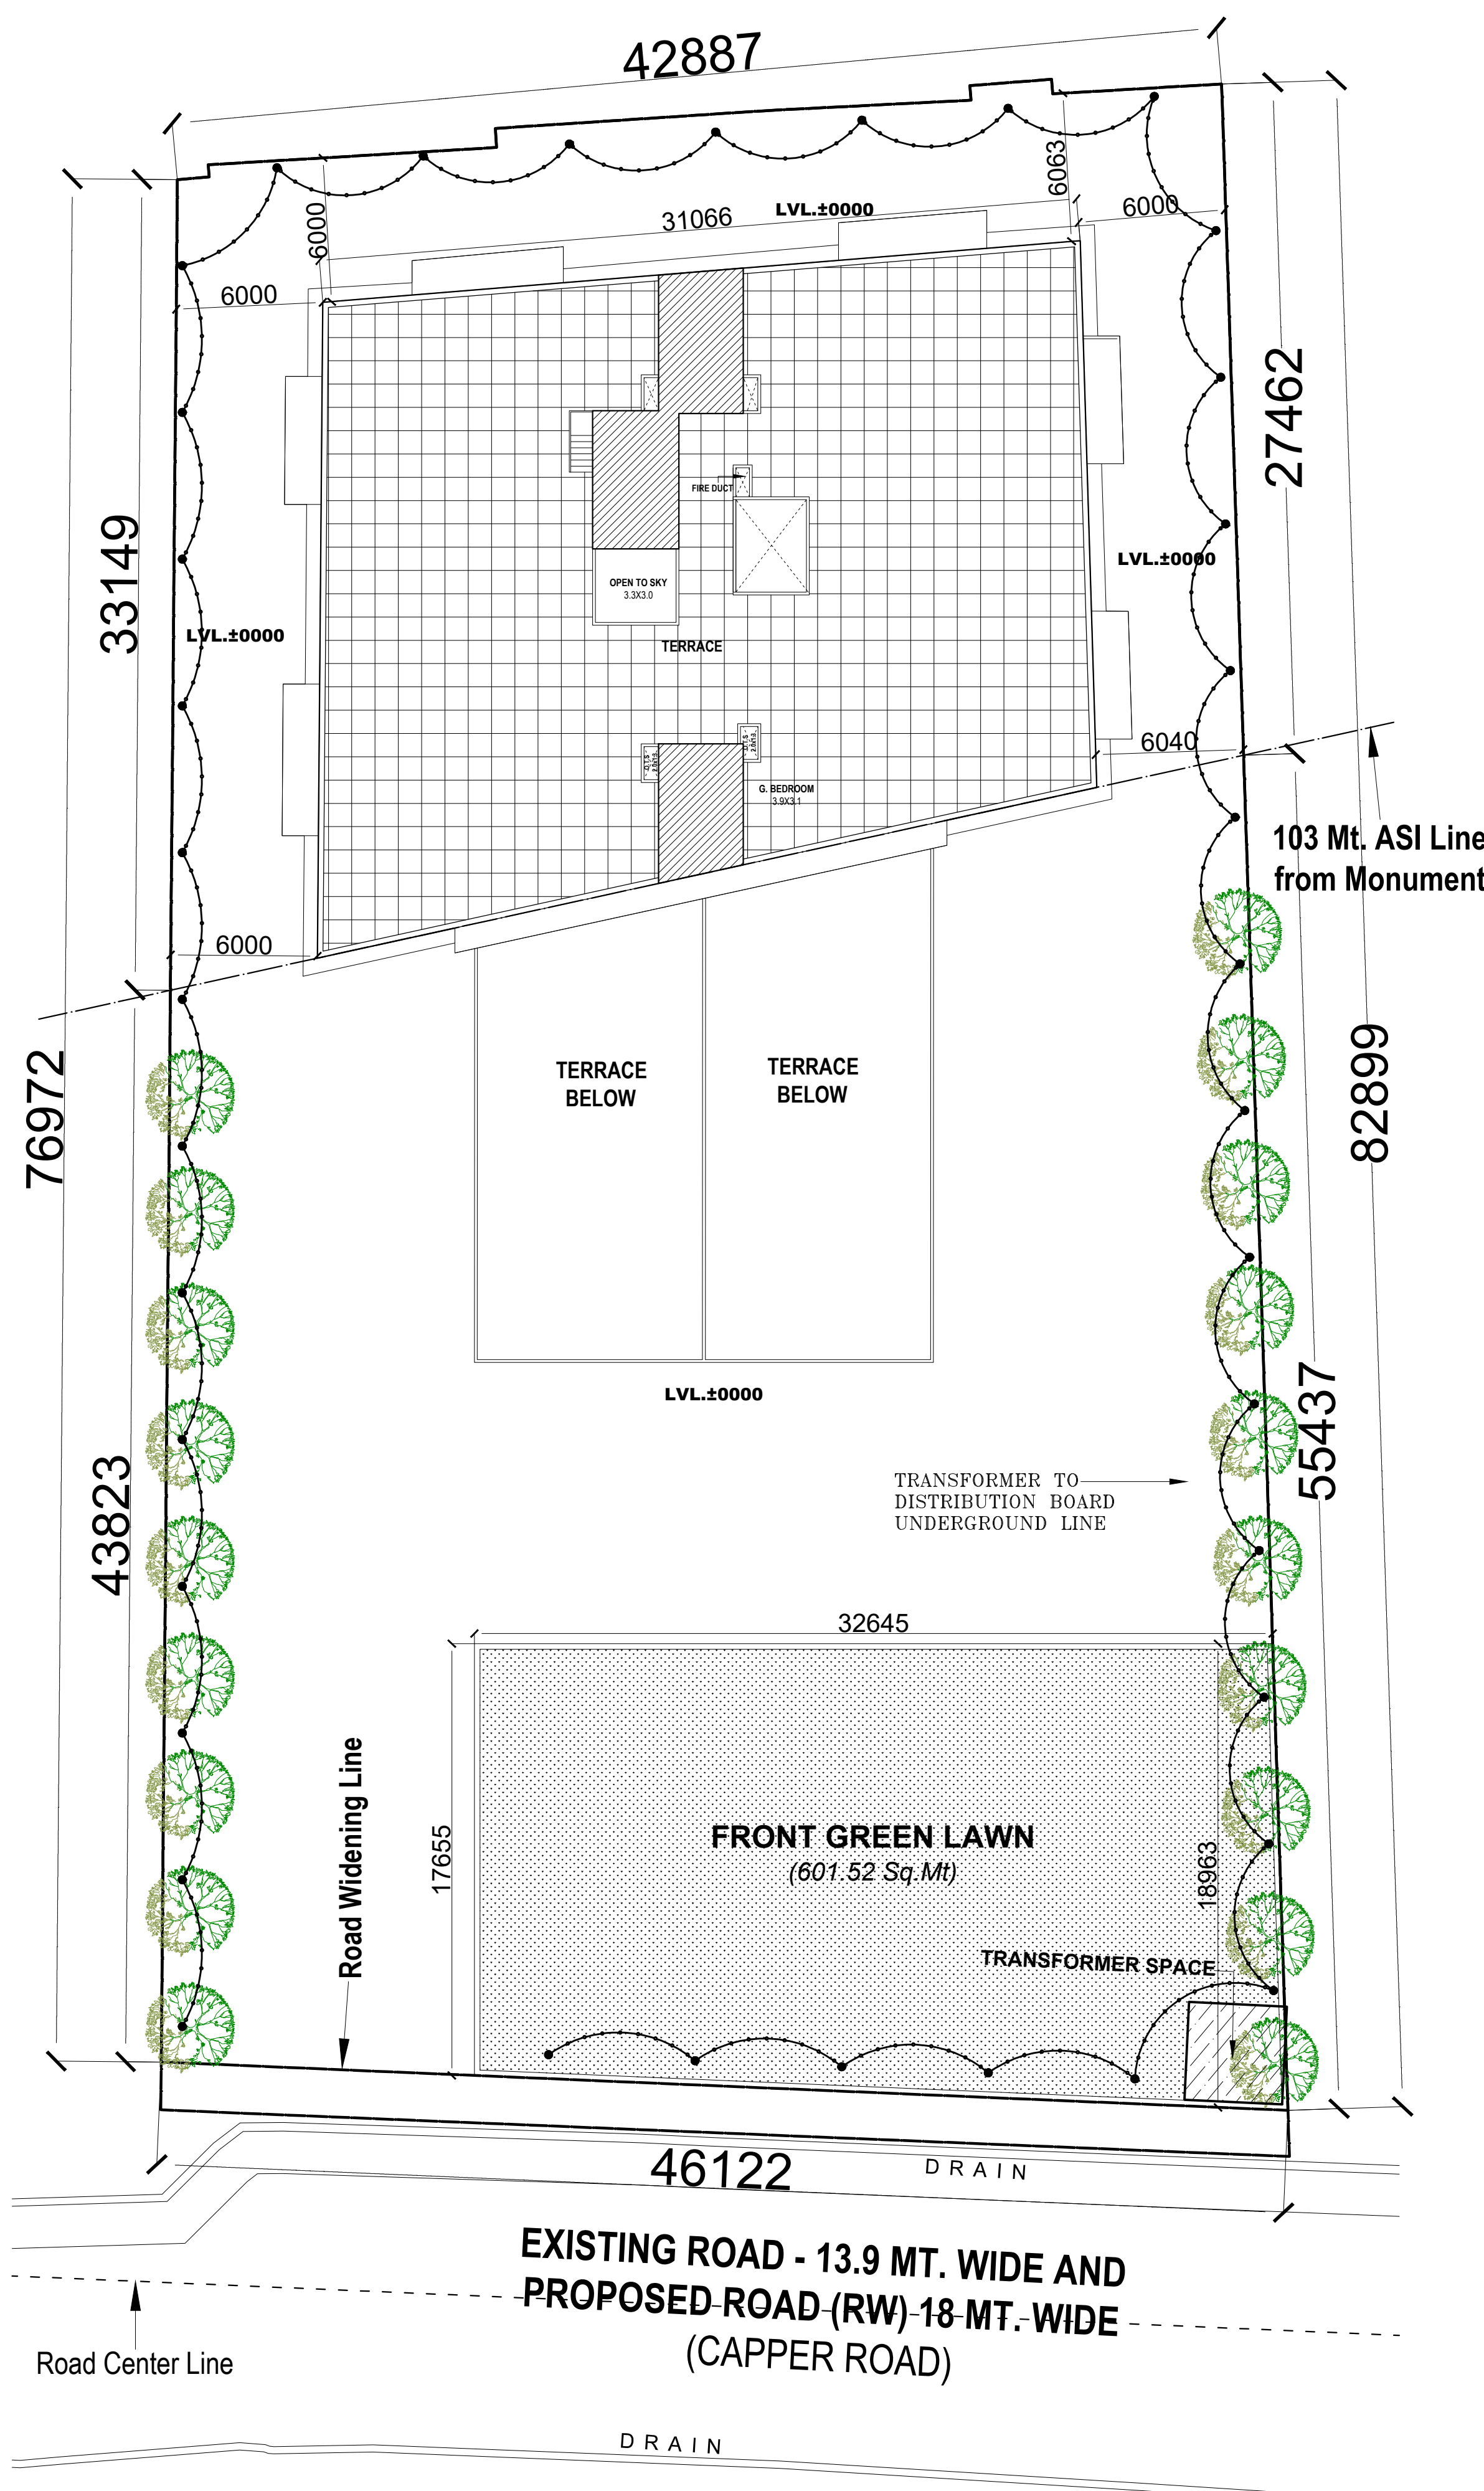

WATER DISPOSAL PLAN

PROPOSED COMMERCIAL COMPLEX & GROUP HOUSING

FOR DR. RAJESH KUMAR SETH,
DR. VIJAY KUMAR SETH,
DR. AJEET KUMAR SETH,
MR. VIKRAM SETH,
DR. (MRS.) SUNITA SETH,
MR. RAVI SETH,
DR. (MRS.) VEENA BAJPAI,
MR. ANKUR BAJPAI,
MR. AMIT SETH;
ON PLOT NO. 4 AT
CAPPER ROAD, LALBAGH,
LUCKNOW.

OWNER'S SIGN

LEGENDS		
S.NO.	SYMBOL	DESCRIPTION
1.		ELECTRIC LINE (UNDER GROUND - ARMOURED CABLE)
2.		3.2 mts. HIGH 50 mmØ m.s. pole 2.4mt OBOVE AND 0.8 MTS BELOW GROUND WITH 125 WATT H.P.M.V. POST TOP LANTERN.
3.		GLOBE TYPE LIGHT.

THIS IS TO CERTIFY THAT THIS PROPOSED DRAWING IS PREPARED AS PER MASTER PLAN 2031 AND BUILDING BYE LAWS-2016

*All Dimensions are in Millimeters or as specified

DWG. TITLE - **ELECTRICITY SITE PLAN**


SCALE -	SHEET NO. -	JOB NO. -

DATED -	DEALT BY -	CHECKED. BY -

ARCHITECT	

SUBMISSION DRAWING

point architects pvt. ltd.
ARCHITECTS & INT. DESIGNERS
FLAT No. 1, G. FLOOR, 4/45, ROYAL COURT
WAZIR HASAN ROAD, LUCKNOW
Ph.: 0522-4073807, Email: point_arch_@rediffmail.com

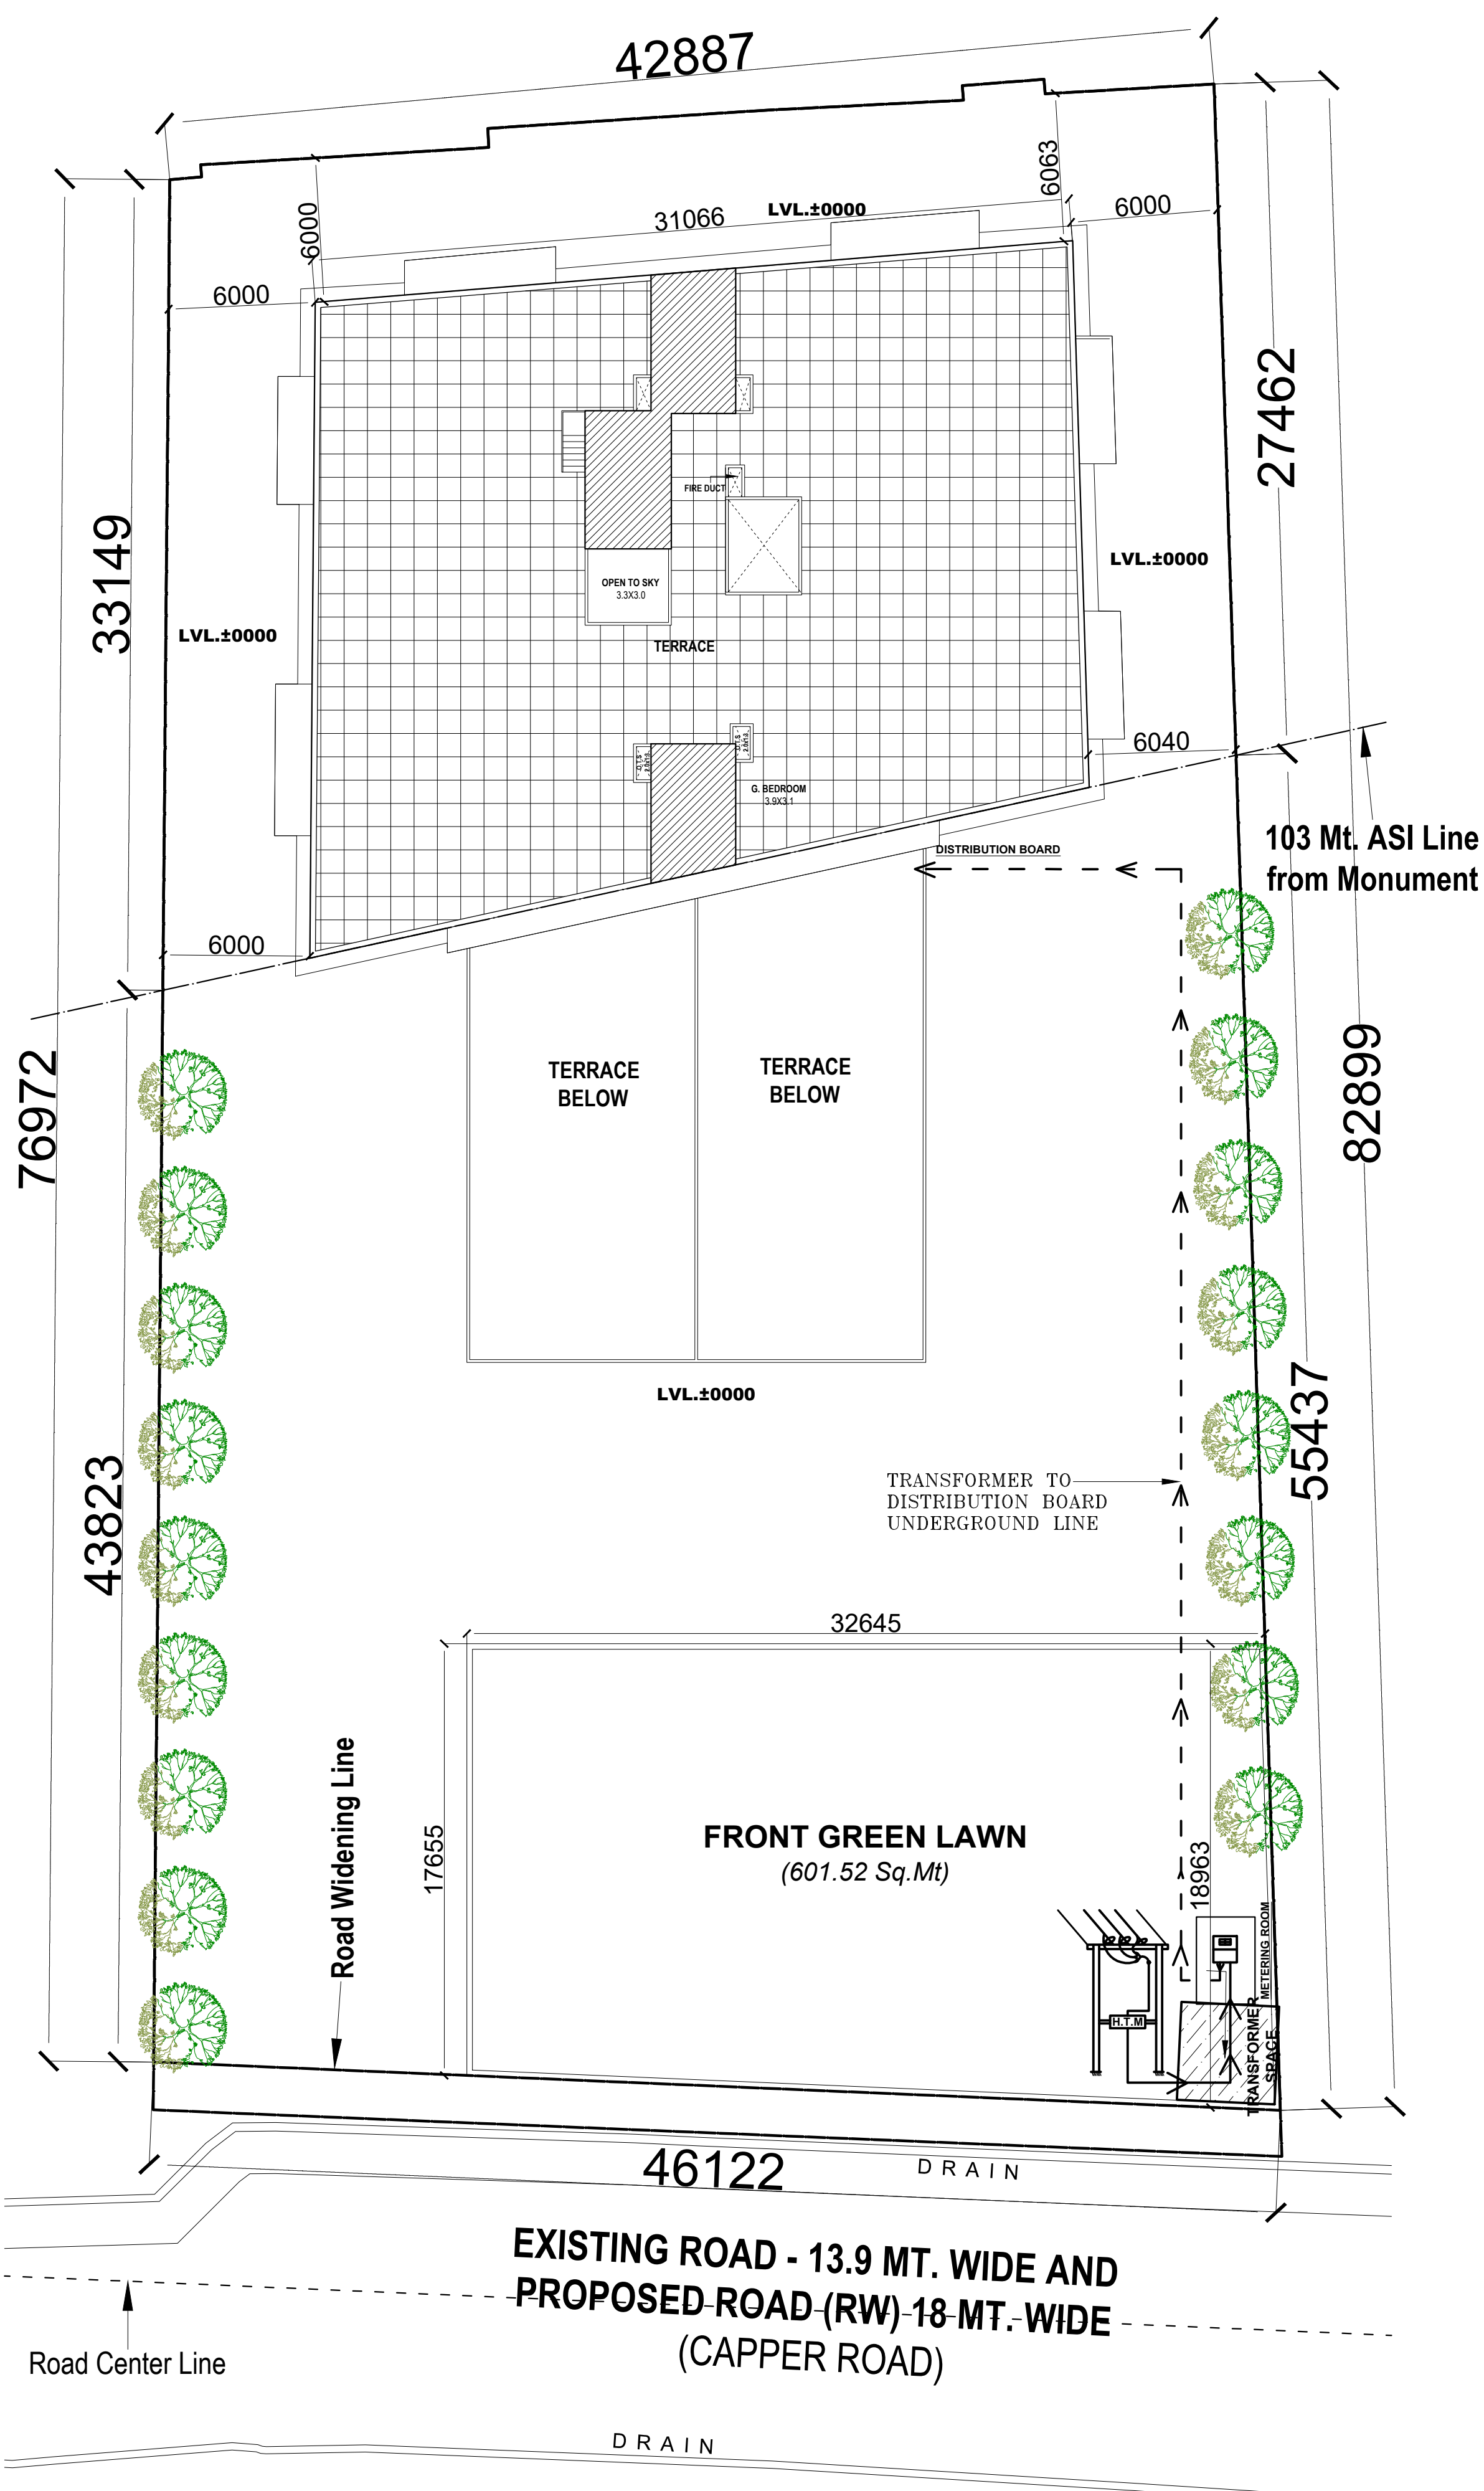

WATER DISPOSAL PLAN

PROPOSED -
PROPOSED
COMMERCIAL COMPLEX
& GROUP HOUSING

FOR DR. RAJESH KUMAR SETH,
DR. VIJAY KUMAR SETH,
DR. AJEET KUMAR SETH,
MR. VIKRAM SETH,
DR. (MRS.) SUNITA SETH,
MR. RAVI SETH,
DR. (MRS.) VEENA BAJPAI,
MR. ANKUR BAJPAI,
MR. AMIT SETH;
ON PLOT NO. 4 AT
CAPPER ROAD, LALBAGH,
LUCKNOW.

OWNER'S SIGN

LEGENDS		
S.NO.	SYMBOL	DESCRIPTION
1.		ELECTRIC LINE (UNDER GROUND - ARMoured CABLE)
2.		3.2 mts. HIGH 50 mmØ m.s. pole 2.4mt OBOVE AND 0.8 MTS BELOW GROUND WITH 125 WATT H.P.M.V. POST TOP LANTERN.
3.		GLOBE TYPE LIGHT.

THIS IS TO CERTIFY THAT THIS PROPOSED DRAWING IS
PREPARED AS PER MASTER PLAN 2031 AND
BUILDING BYE LAWS-2016


*All Dimensions are in Millimeters or as specified

DWG. TITLE -
ELECTRICITY SUPPLY PLAN

SCALE - SHEET NO. - JOB NO. -

DATED - DEALT BY - CHECKED. BY -

ARCHITECT

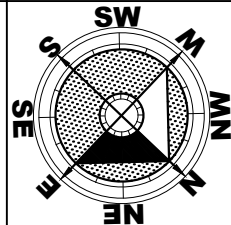

SUBMISSION DRAWING

point architects pvt. ltd.
ARCHITECTS & INT. DESIGNERS
FLAT No. 1, G. FLOOR, 4/45, ROYAL COURT
WAZIR HASAN ROAD, LUCKNOW
Ph.: 0522-4073807, Email: point_arch_@rediffmail.com