


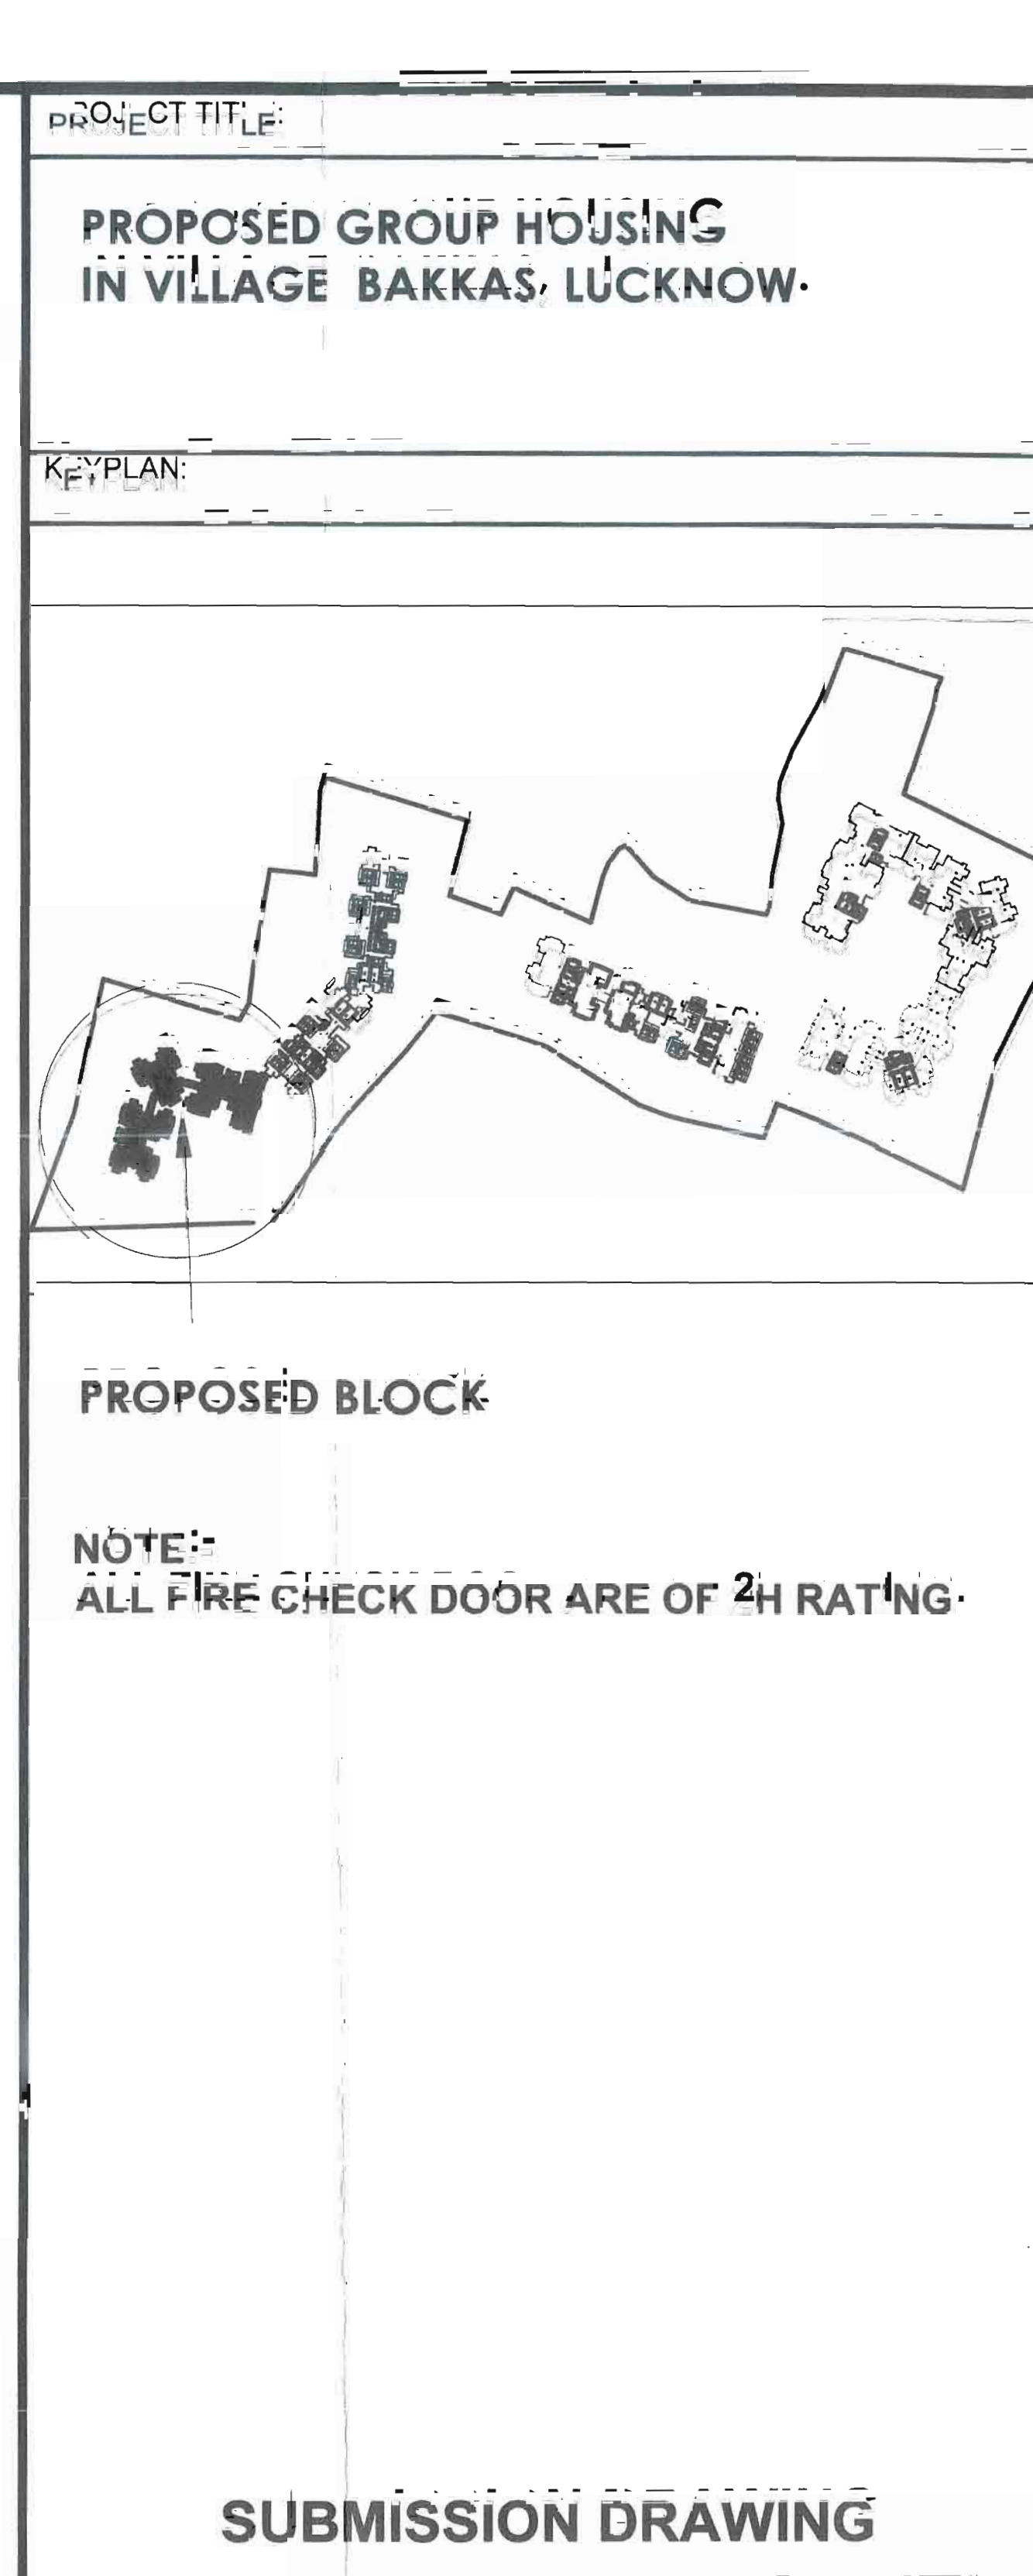


AREA (115°-131° FLOOR PLAN) (CYCICAL)			
LINE	LENGTH	WIDTH (IN)	AREA (SQ. IN)
TYPE 1			
1	150	145	21750
2	855	695	13470
3	100	100	2130
4	515	235	11460
5	200	400	8180
6	200	400	2930
7	100	160	25950
CARPET AREA OF FLOOR			63,540
TYPE 2			
1	245	075	1180
2	135	020	3,040
3	140	135	1,890
4	1445	145	4,020
5	645	150	33,710
6	140	135	3,070
7	645	120	6,060
CARPET AREA OF CORRIDOR, MEA			65,340
LINE	LENGTH	WIDTH (IN)	AREA (SQ. IN)
TYPE 3			
1	200	250	2,295
2	300	683	13,140
3	270	250	1,600
4	200	507.5	40,174
5	300	240	12,840
6	19.75	200	27,563
DEDUCTION			10,469
1	160	180	1,567
2	160	290	4,995
3	160	180	1,862
TOTAL AREA (63,540+65,340-10,469)			718,490

[illegible]

LEGEND	
SYMBOL	PIPE DESCRIPTION
P1	DIESEL DRIVEN PUMP 2850 LMP
P2	ELECTRICAL DRIVEN PUMP 2850 LMP
P3	JOCKEY PUMP 180 LMP
(A) 	150Ø HYDRANT PIPE
(B) 	150Ø HYDRANT PIPE

Emergency exit with symbol provided on each floor of the building as per NBC-2005 norms; the building shall have fire escape of the building to be installed emergency light with one hour battery backup with separate circuit!



	FIRE HOSE CABINET
(H) 	HOOTERS
	MANUAL CALL POINT [MCP]
	PUBLIC ADDRESS SYSTEM WITH ALARM PANEL
	CO2 TYPE FIRE EXTINGUISHER
	ABC TYPE FIRE EXTINGUISHER
CONTROL PANEL	FIRE CONTROL PANEL
	FIRE SERVICE INLET
	YARD HYDRANT

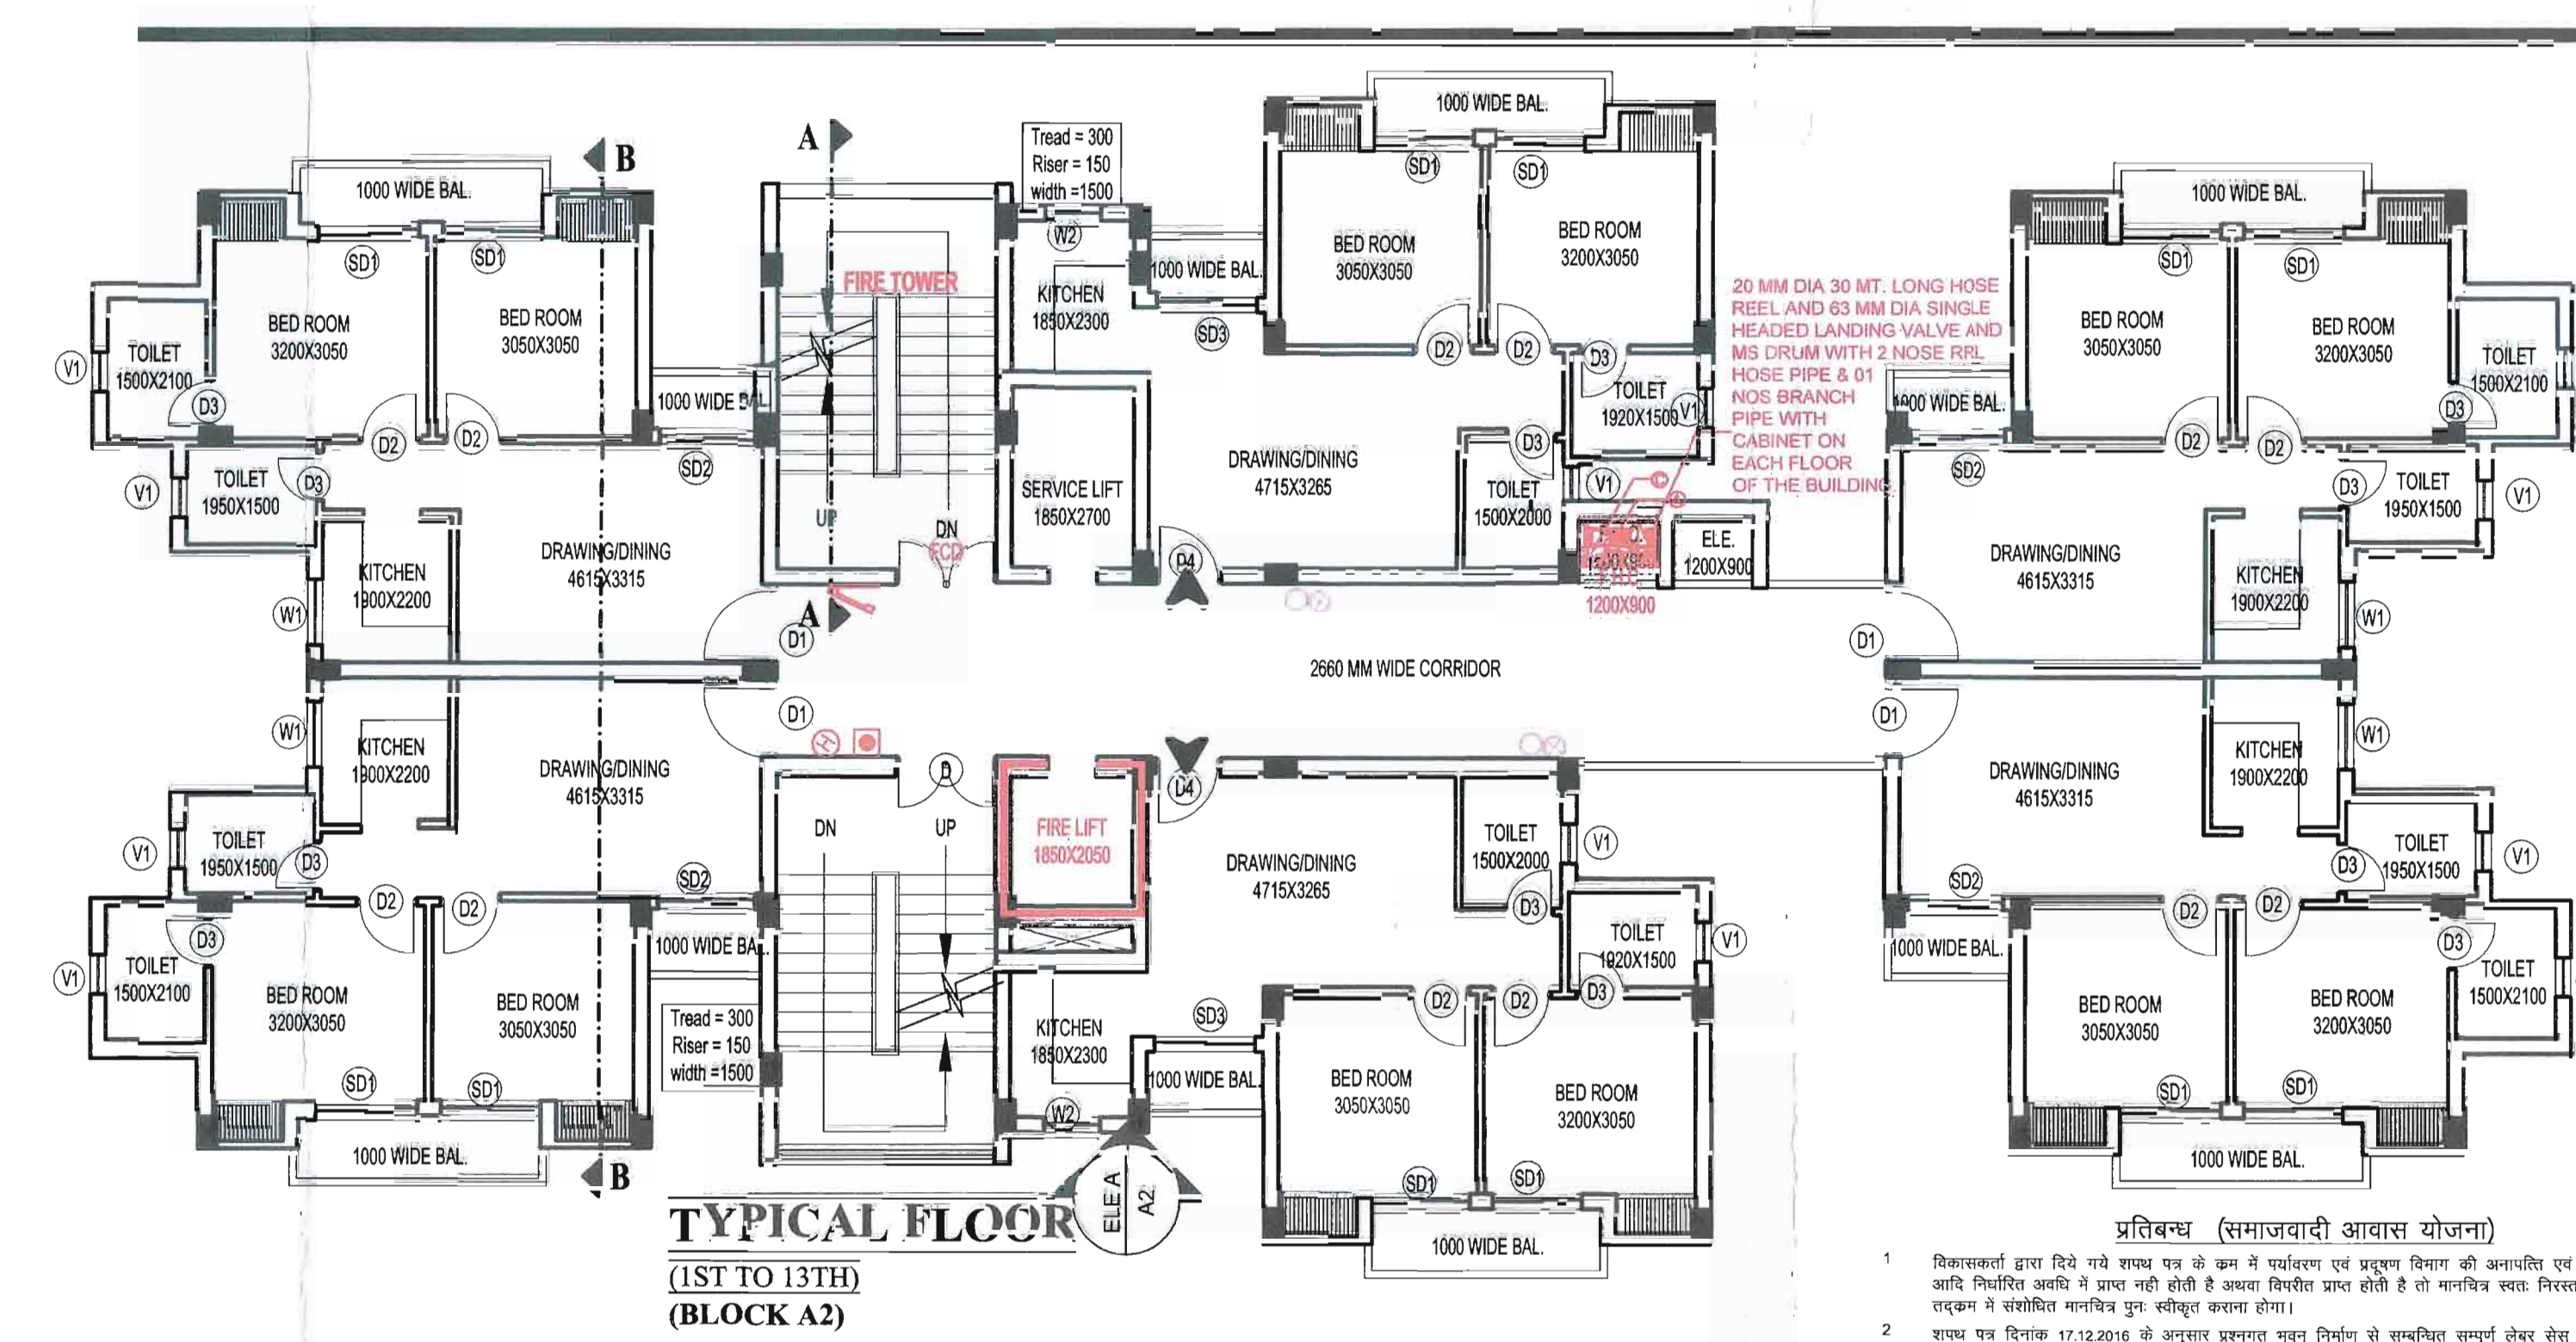

SCHEDULE OF DOORS & WINDOWS					
S.NO.	TYPE	WIDTH	HIGHT	SILL	LINTEL
01	D1	1200	2100	-	2100
02	D2	900	2100	-	2100
03	D3	750	2100	-	2100
04	D4	1000	2100	-	2100
05	FD	1500	2100	-	2100
06	SD1	1500	2350	-	2350
07	SD2	1450	2350	-	2350
08	SD3	1540	2350	-	2350
09	SD4	1220	2350	-	2350
10	SD5	2500	2350	-	2350
11	W1	1000	2350	1050	2350
12	W2	850	2350	1050	2350
13	W3	1700	2350	900	2350
14	W4	750	2350	900	2350
14	V1	600	2250	1050	2350


[illegible]

LEGEND	
SYMBOL	PIPE DESCRIPTION
P1	DIESEL DRIVEN PUMP 2850 LMP
P2	ELECTRICAL DRIVEN PUMP 2850 LMP
P3	LOCOMY PUMP 180 LMP
(A) 	150W HYDRANT PIPE
(C) 	150W HYDRANT PIPE
 Emergency exit with symbol provided on each floor of the building as per ABC-2005 norms. all corridors and storerooms of the building shall be installed emergency light with one hour battery backup with separate circuit.	
	FIRE HOSE CABINET
(H) 	HOOTERS
	MANUAL CALL POINT [MCP]
	PUBLIC ADDRESS SYSTEM WITH ALARM PANEL
	CO ₂ TYPE FIRE EXTINGUISHER
	ABC TYPE FIRE EXTINGUISHER
 FIRE CONTROL PANEL FIRE SERVICE INLET	
	YARD HYDRANT

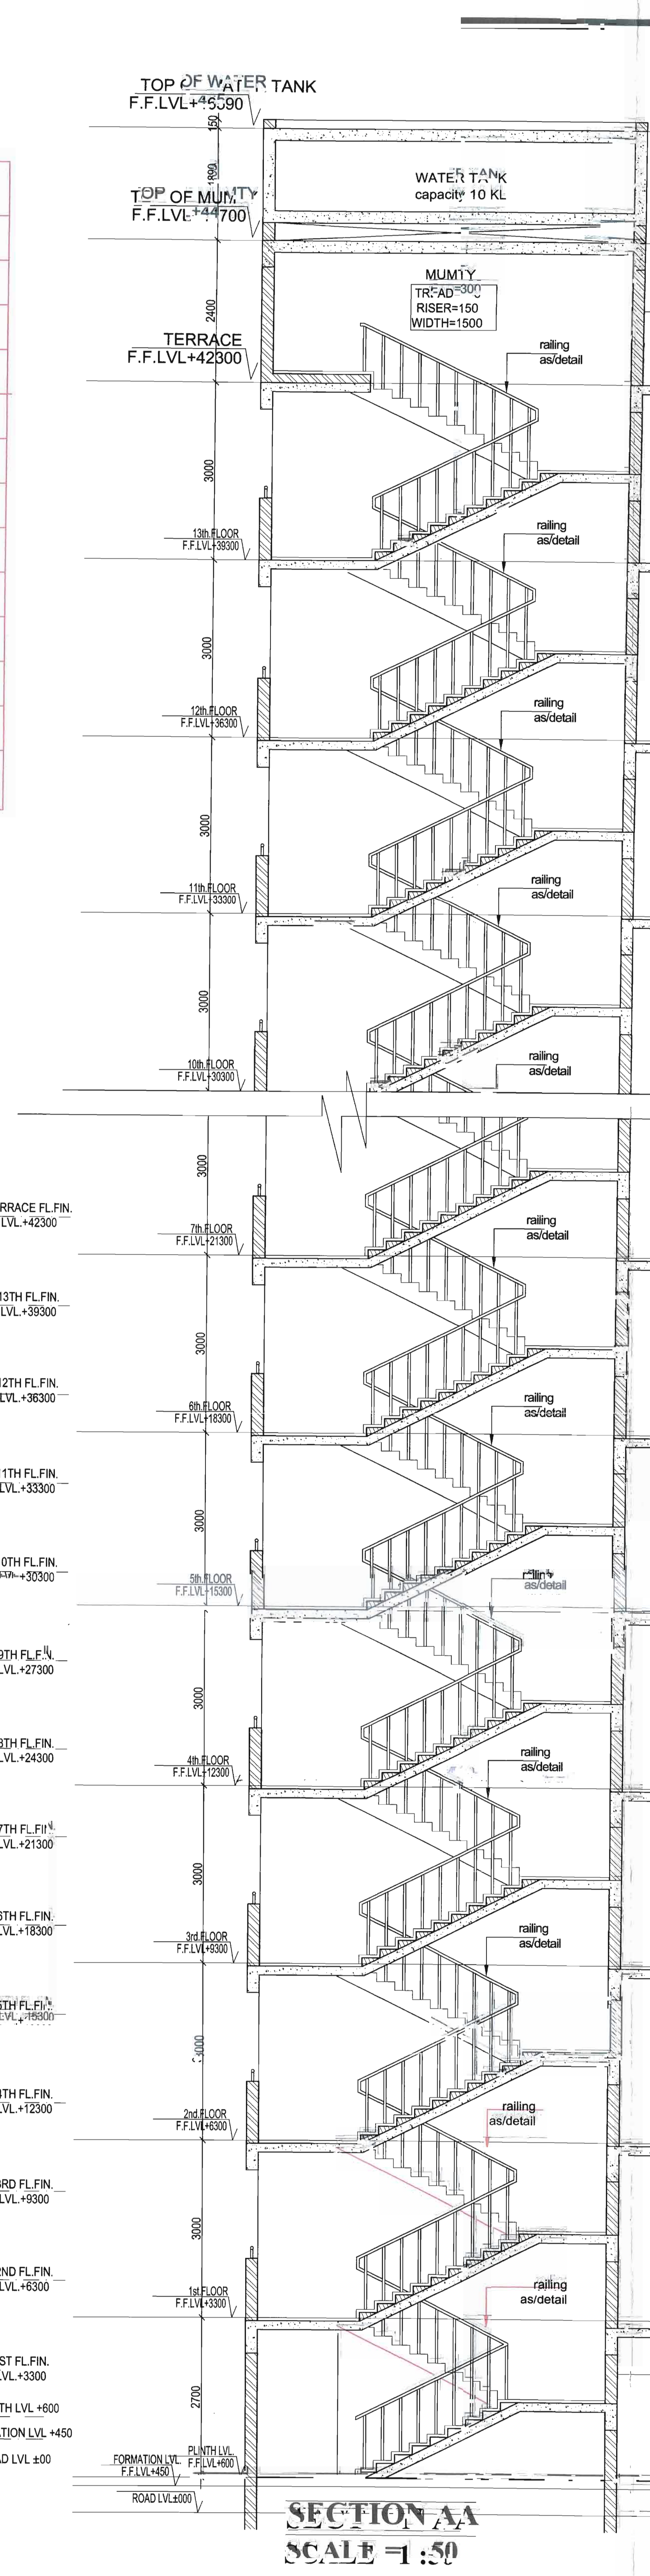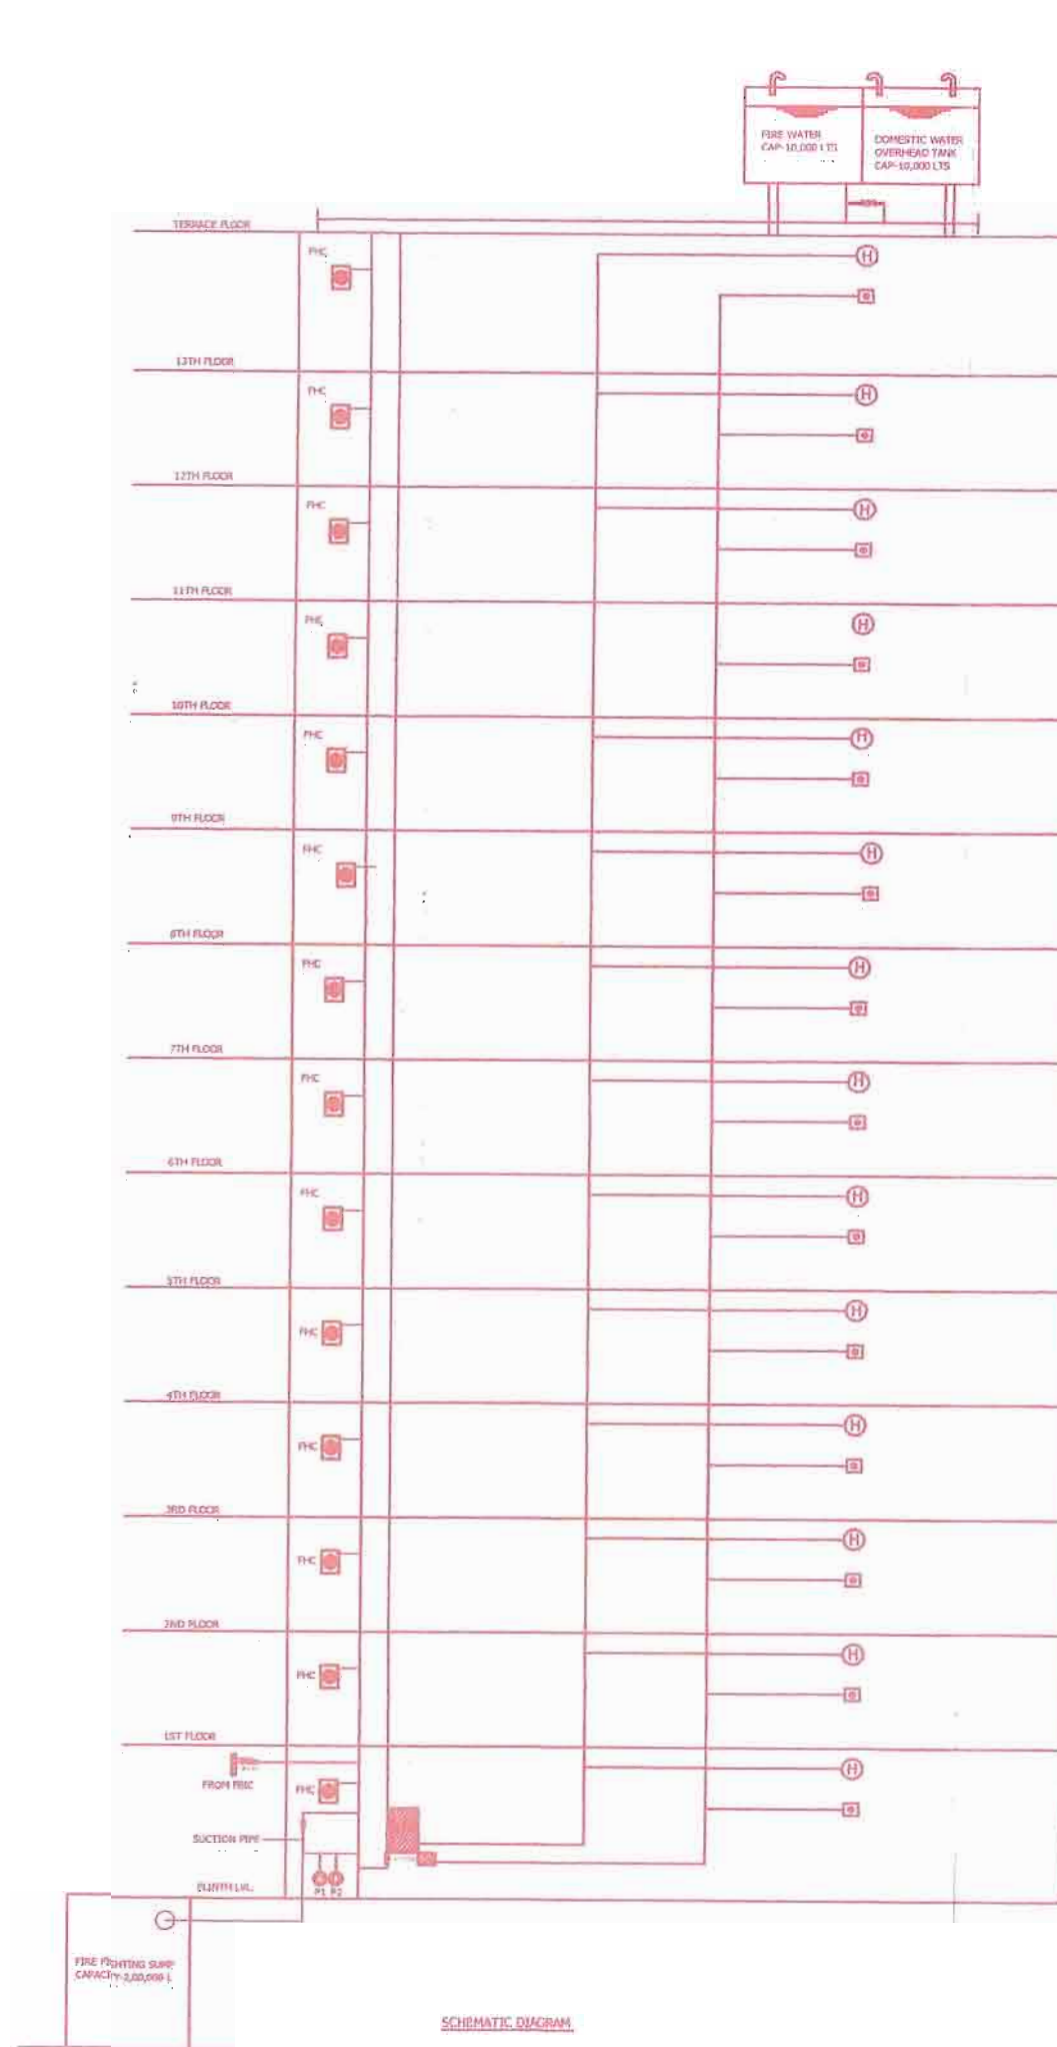

PROJECT TITLE:
**PROPOSED GROUP HOUSING
IN VILLAGE BAKKAS, LUCKNOW.**

KEYPLAN

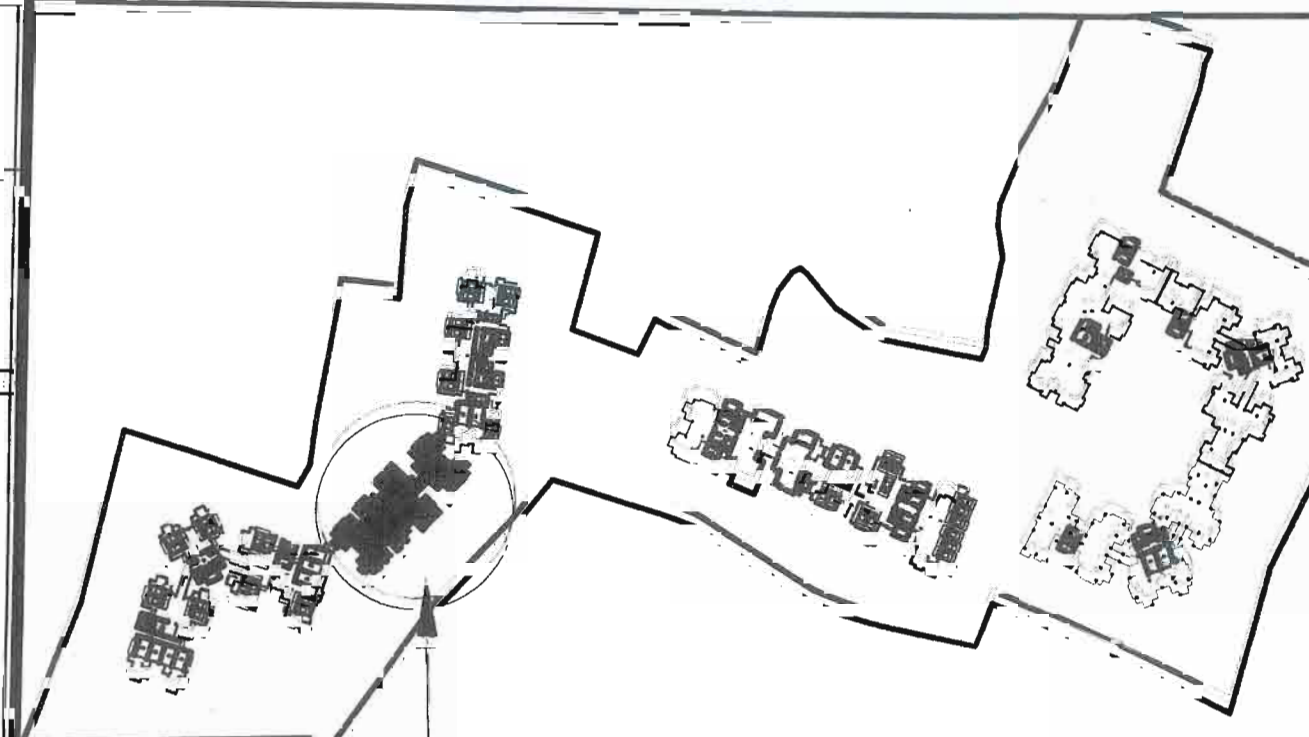

PROPOSED BLOCK

NOTE:-
ALL FIRE CHECK DOOR ARE OF 2H RATING.

SUBMISSION DRAWING

NORTH:

NOTE:

यह मानचित्र लखनऊ महायोजना 2021, भवन उपविधि 2008 तथा समाजवादी आवास योजना के अनुरूप तैयार किया गया है।

DRAWING TITLE

BLOCK A2

DRAWING NO:

KUTUMB/GH-1/SUB/05

SCALE	1:100 OR AS SHOWN	DATE	JUNE 2016
-------	-------------------	------	-----------

DATE	BY	CHECKED	DATE

CLIENT: _____

M/S ABC INFRA PROMOTERS
PVT. LTD. / CONSORTIUM

DEVELOPER


EXCELLA KUTUMB

PRINCIPAL ARCHITECT:

JSR DESIGN PVT. LTD.
G-67, DEFENCE COLONY
NEW DELHI-110025

ARCHITECT:

ARPITA SINGH
Architect
CA/2011/52017

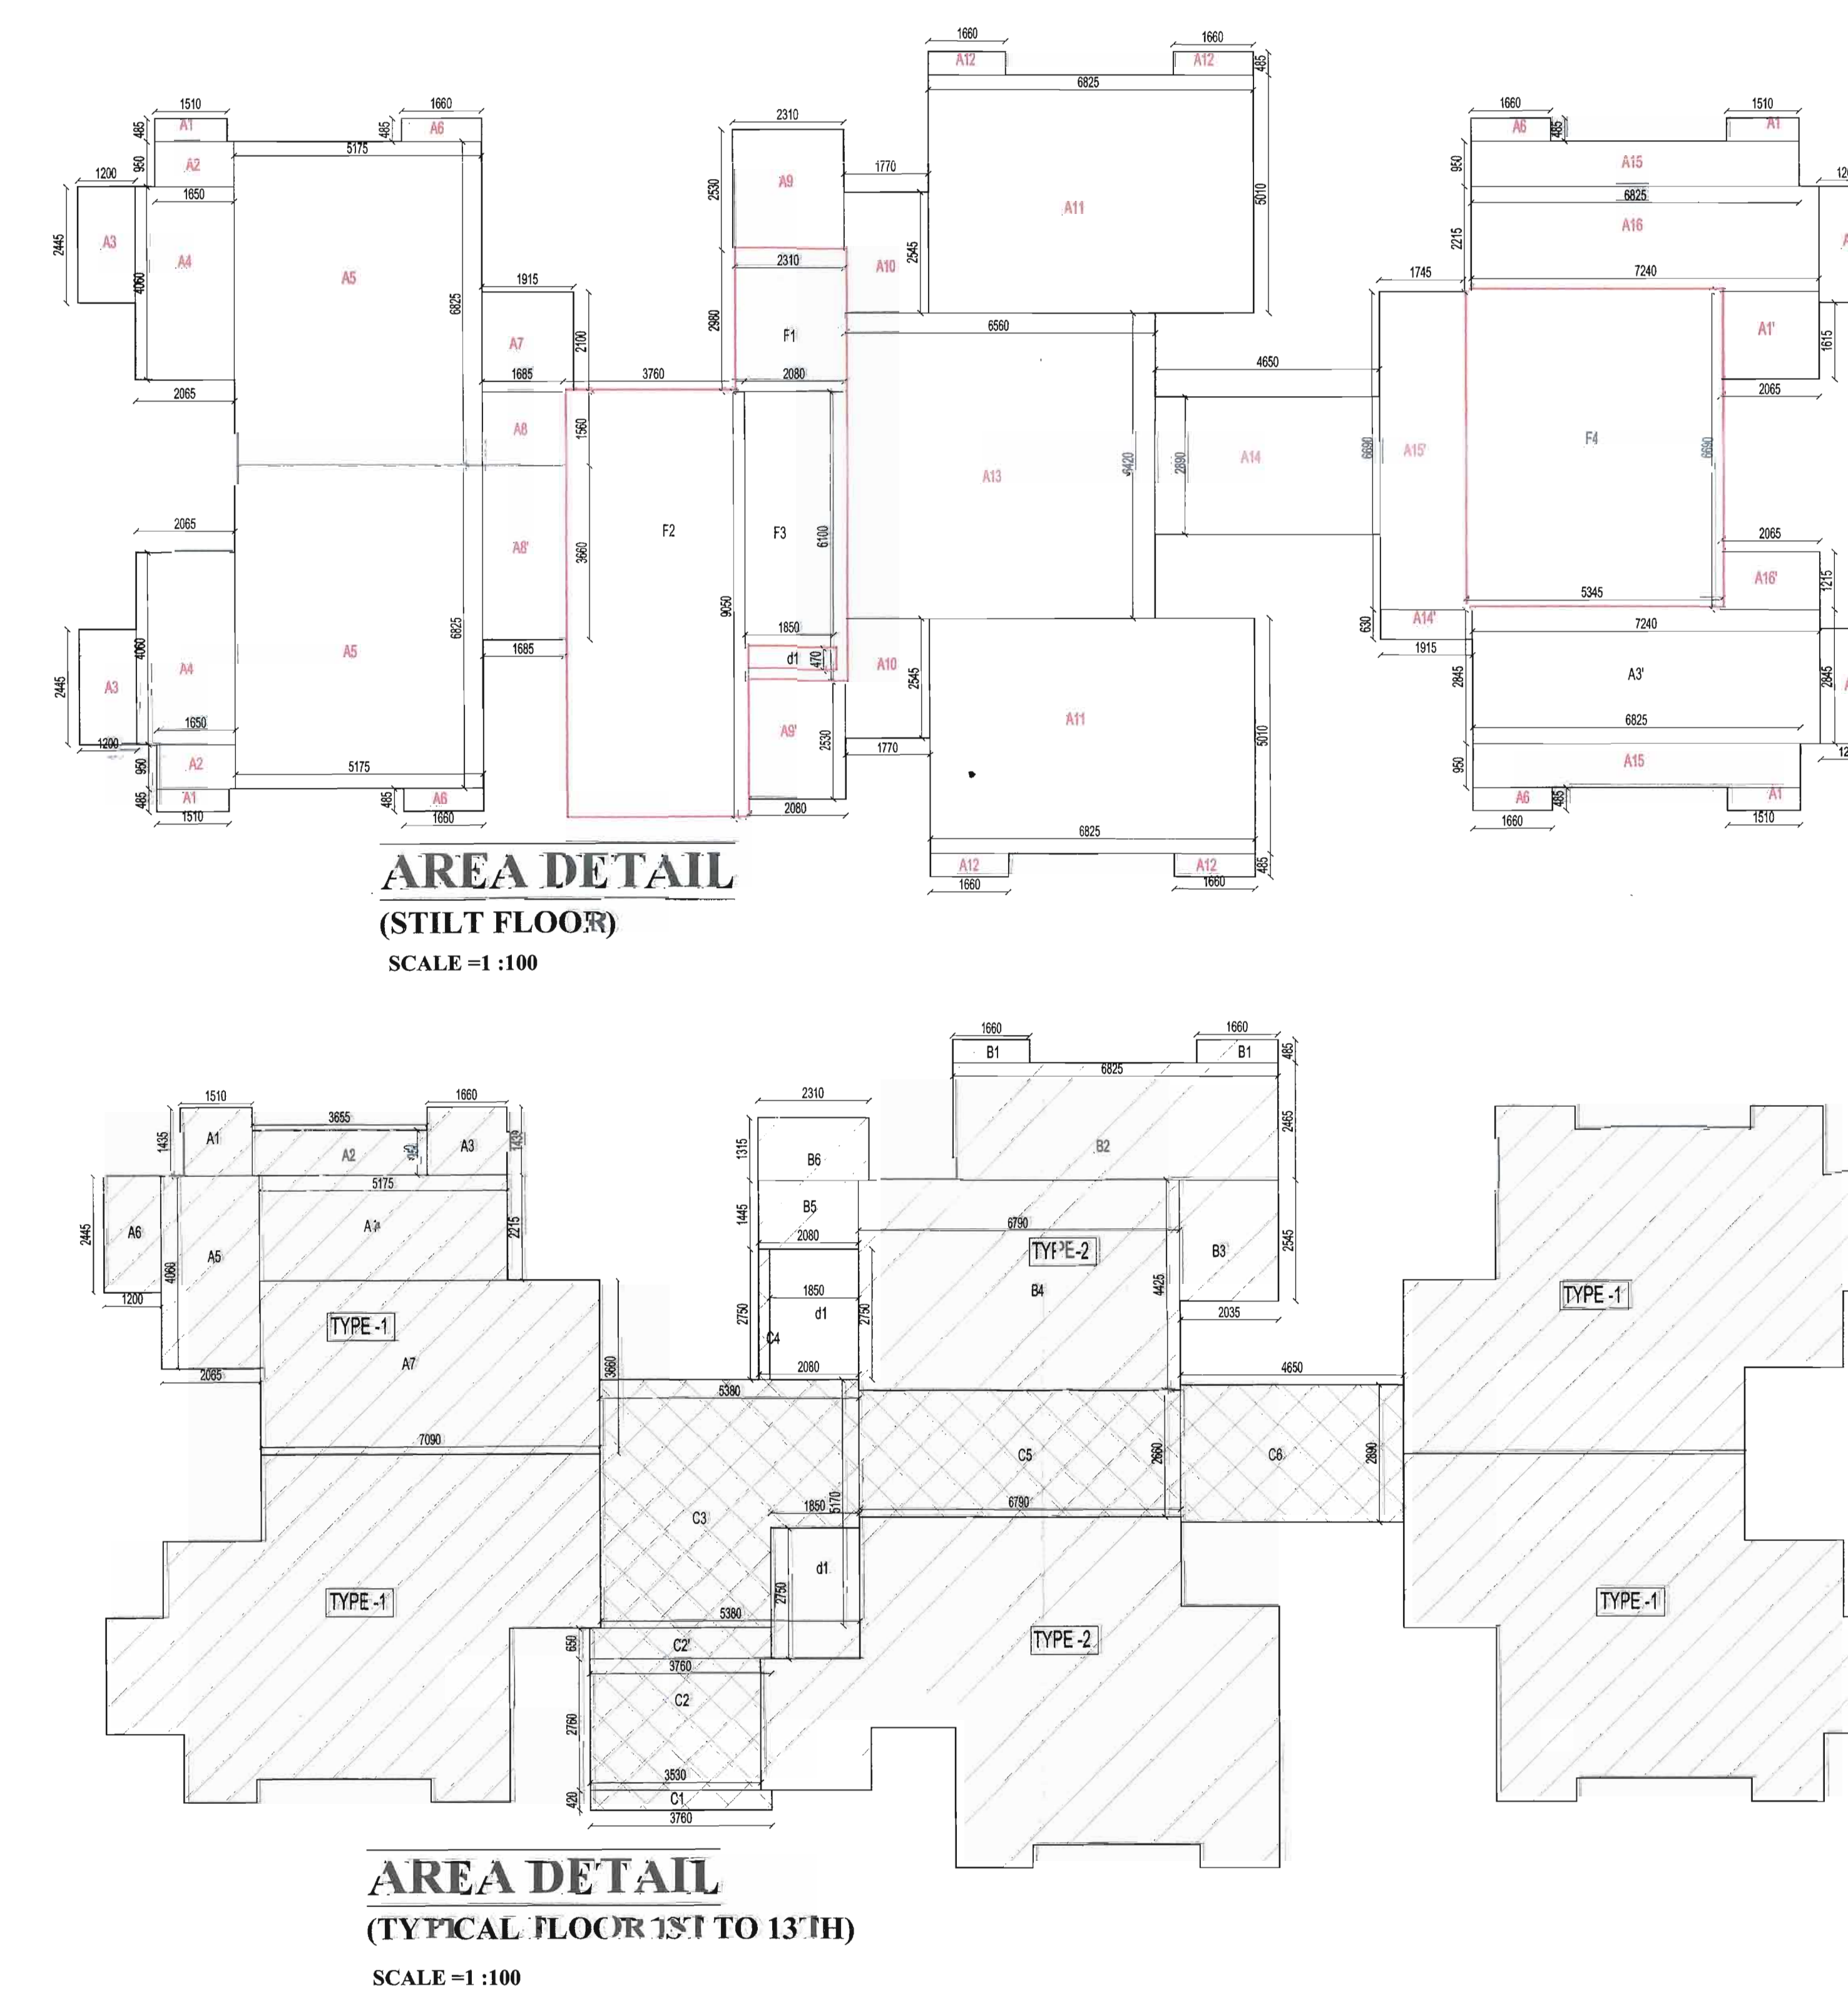


STRT AREA			
NAME	LENGTH(M)	WIDTH(M)	AREA(SQ.M)
A1	1,150	0.80	2,930
A2	2,065	1,015	2,100
A3	1,450	2,000	3,300
A4	2,000	2,465	4,120
A5	2,465	2,465	6,120
A6	2,065	4,000	26,720
A7	5,115	1,015	5,190
A8	2,065	0,885	4,320
A9	1,450	1,015	1,470
A10	1,485	1,500	2,230
A11	1,485	1,500	2,230
A12	1,485	1,500	2,230
A13	3,078	2,530	7,790
A14	3,078	3,540	10,900
A15	6,825	5,510	69,390
A16	6,825	5,510	69,390
A17	6,180	6,300	41,100
A18	6,180	6,300	41,100
A19	1,955	2,886	5,640
A20	1,955	2,886	5,640
A21	6,825	9,000	27,970
A22	6,825	9,000	27,970
A23	2,465	2,235	5,500
A24	2,465	2,235	5,500
A25	2,465	2,235	5,500
A83	2,465	2,235	5,500
A84	2,465	2,235	5,50

AREA #11 & 13TH FLOOR PLAN				
NO.	NAME	AREA (SQ. FT.)	PERCENT	TOTAL
TYPE				
A1	1,50.0			
A2	485	0.50	1	
A3	600	1.45	1	
A4	1,175	2.50	1	
A5	2,000	4.50	1	
A6	1,300	2.45	1	
A7	2,000			
A	CARPET AREA OF A			10,475
B1	1,550	0.48	2	
B2	6,825	2.46	1	
B3	2,000	2.45	1	
B4	560	0.44	1	
B5	2,000	1.45	1	
B6	2,810	2.45	1	
B	CARPET AREA OF B			10,475
CIRCULATION AREA				
NAME	LENGTH(M)	WIDTH(M)	AREA	
C1	3.240	0.420	1	
C2	3.240	0.420	1	
C3	6.290	0.420	1	
C4	2.080	2.720	1	
C5	6.290	2.660	1	
C6	6.450	2.660	1	
TOTAL				
REDUCTION				
H1	1.855	3.790	2	
TOTAL AREA AFTER REDUCTIONS				
C				



ELEVATION A SCALE=1:100
(BLOCK A2)

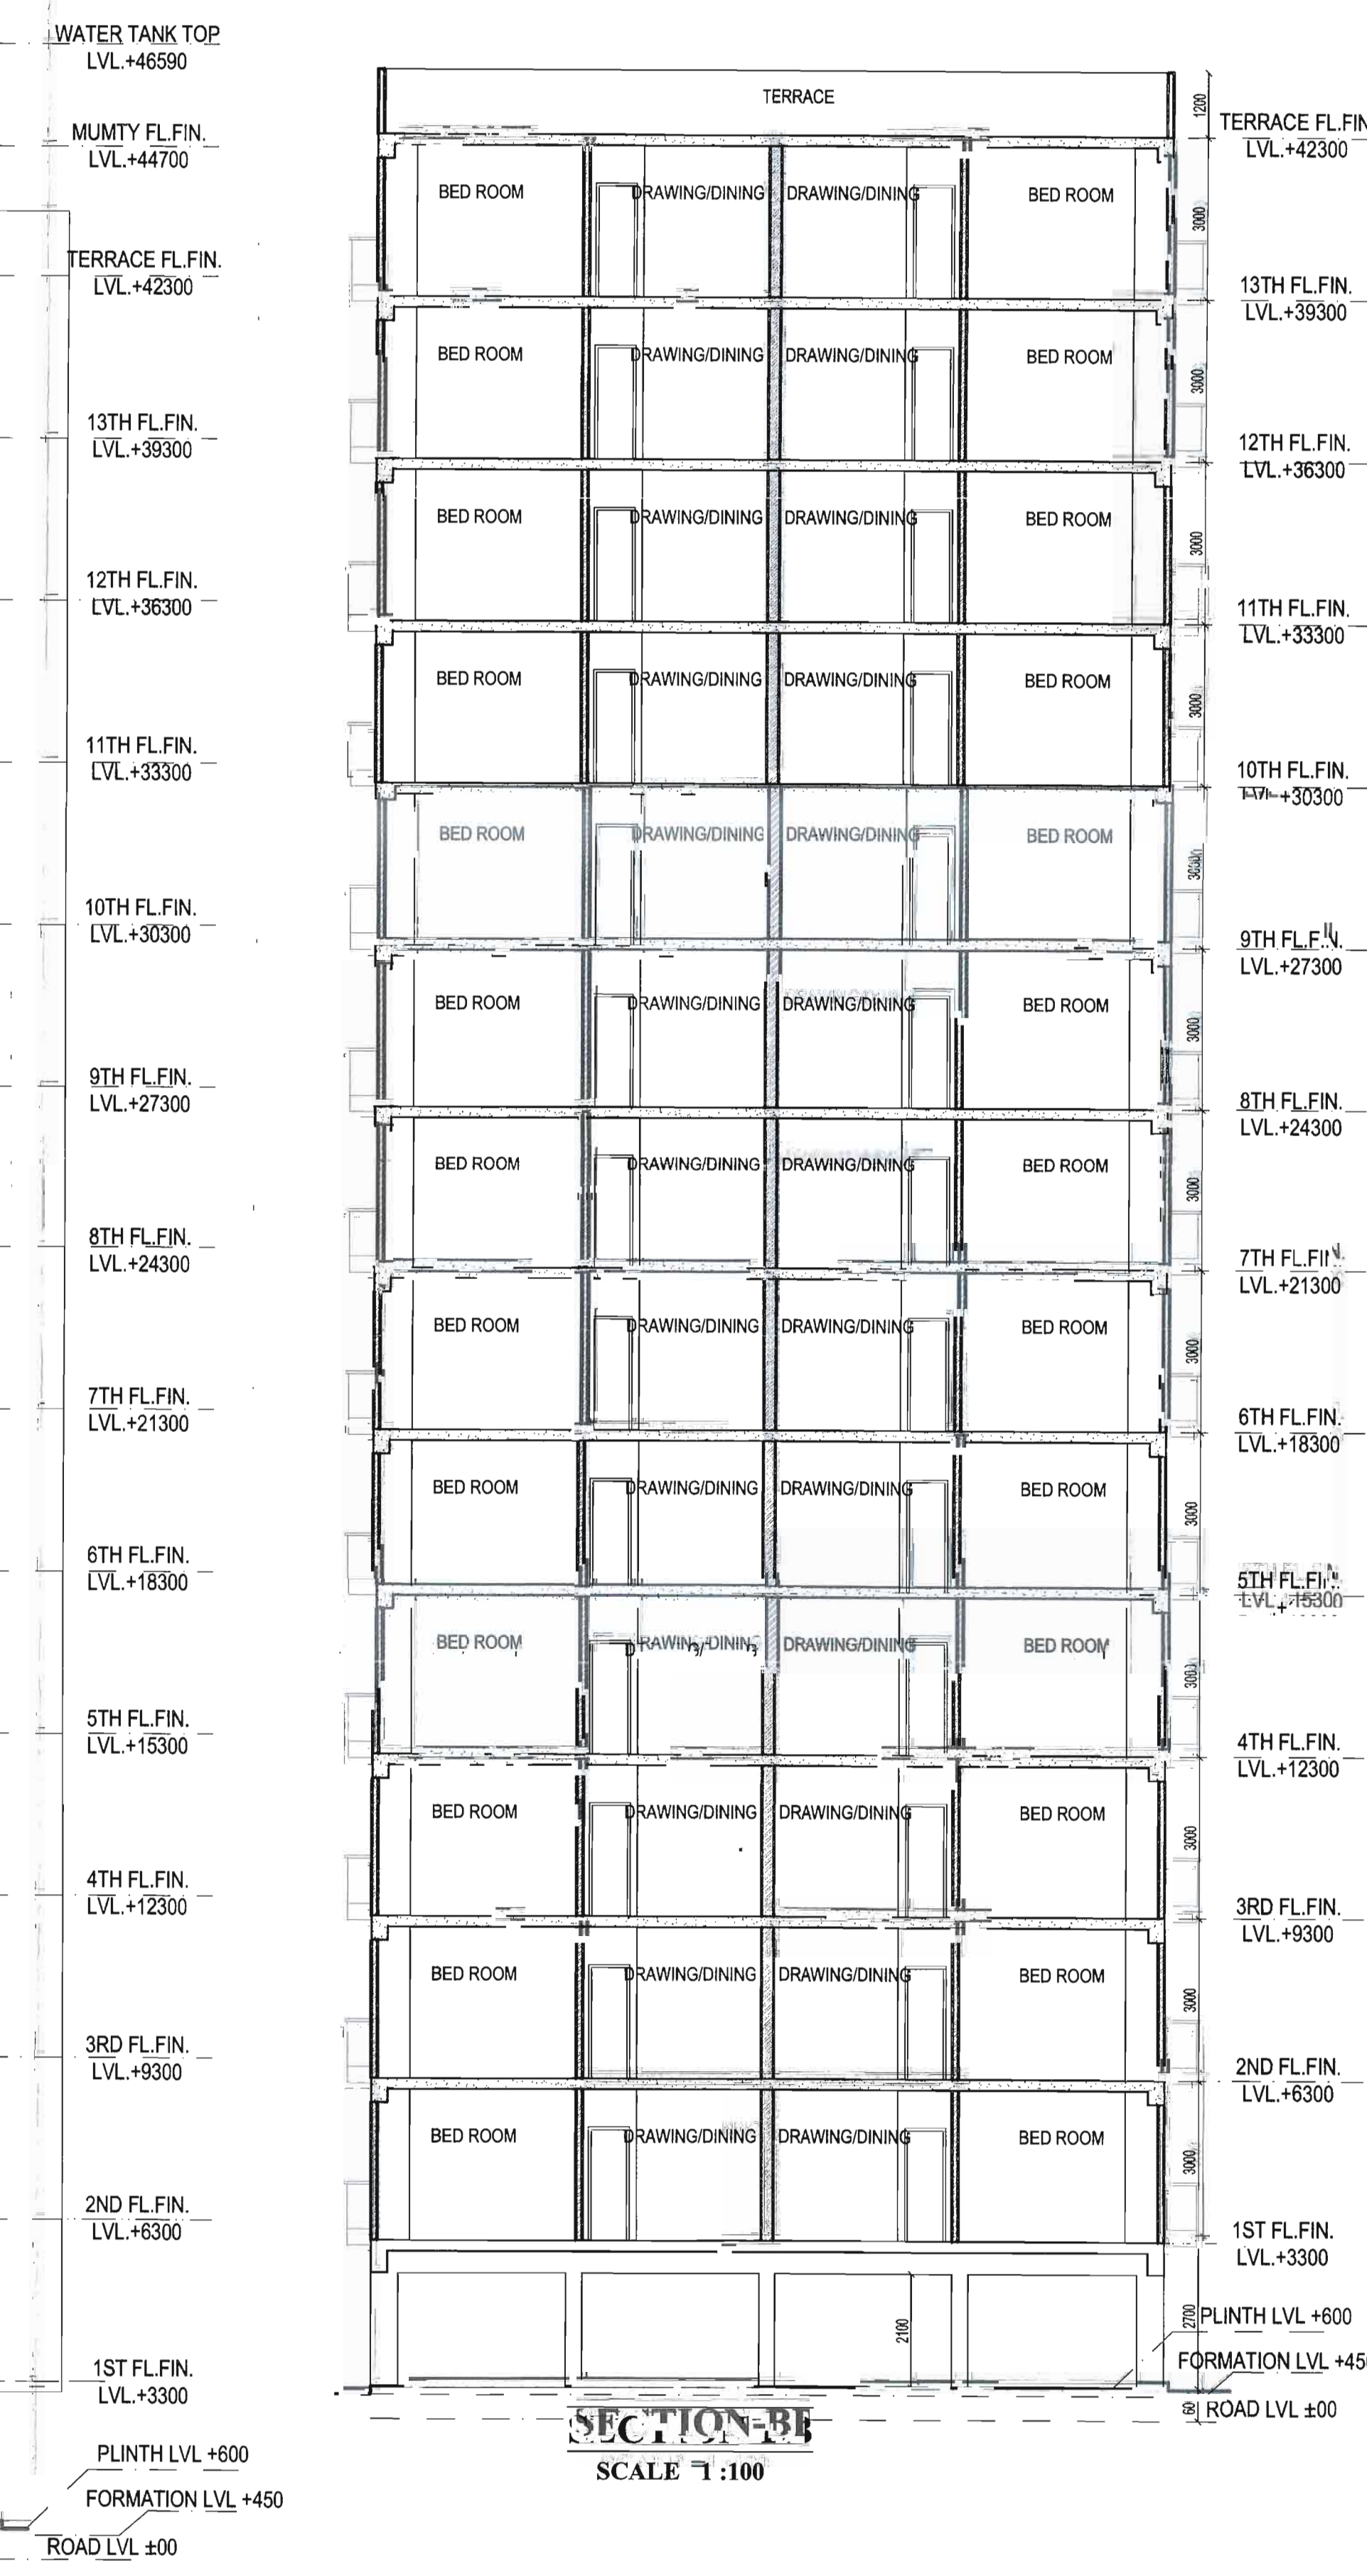

SECTION-B
SCALE 1:100

SECTION AA
SCALE = 1:50