
 
 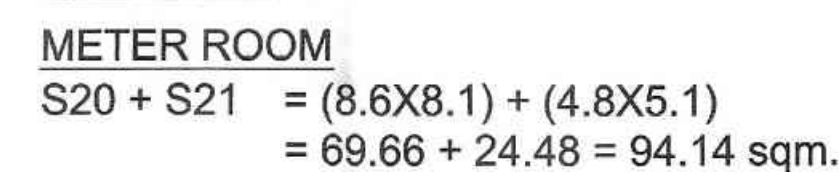



प्रश्न १०. निम्नलिखित वाक्यों में कौन से वाक्य सत्य हैं और कौन से असत्य हैं।
 (a) प्रत्येक व्यक्ति को अपने अधिकारों का उपयोग करने का अधिकार है।
 (b) प्रत्येक व्यक्ति को अपने अधिकारों का उपयोग करने का अधिकार है।
 (c) प्रत्येक व्यक्ति को अपने अधिकारों का उपयोग करने का अधिकार है।
 (d) प्रत्येक व्यक्ति को अपने अधिकारों का उपयोग करने का अधिकार है।

(८) आबंटन को अधिकतम प्रमाण पर, शुरू करने के लिए आवश्यक विचार प्रत्यक्ष (आवृत्ति) से निर्धारित किया जायेगा।



BLOCK - "A"
(STILT + 6)

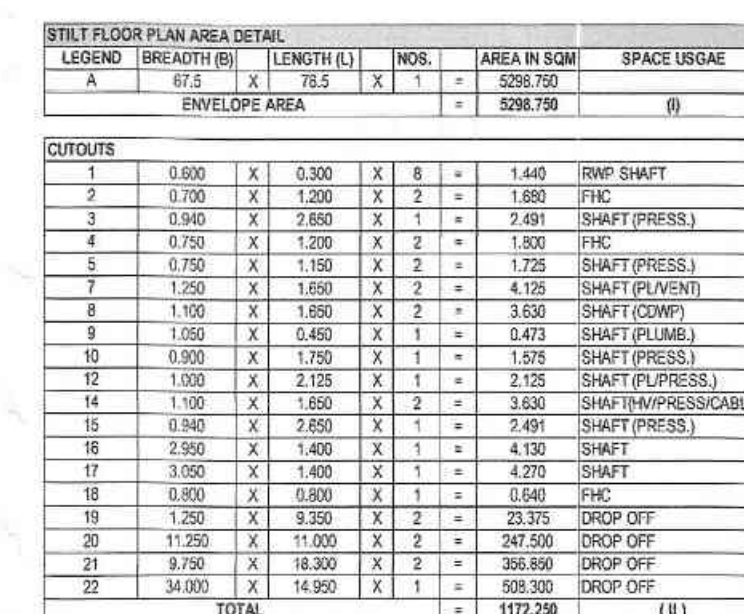

PARKING AREA DETAIL						
B1	1	1.350	X	2.500	X	1 = 2.625
B2	1	1.950	X	2.250	X	1 = 14.125
B3	1	1.650	X	2.300	X	1 = 14.250
B4	1	1.850	X	2.300	X	1 = 45.855
B5	1	17.250	X	31.600	X	1 = 103.585
B6	1	5.150	X	2.250	X	1 = 6.000
B7	6	9.025	X	22.850	X	1 = 219.831
B8	12	12.545	X	24.625	X	1 = 317.955
B9	1	1.000	X	2.575	X	1 = 4.000
B10	0	0.850	X	1.850	X	1 = 1.575
B11	1	1.000	X	25.500	X	1 = 100.450
B12	1	1.000	X	11.000	X	1 = 300.750
B13	5	10.100	X	5.500	X	1 = 35.000
B14	1	17.250	X	31.600	X	1 = 103.585
B15	5	5.250	X	5.000	X	1 = 42.000
B16	1	7.000	X	2.500	X	1 = 14.750
B17	1	6.000	X	2.500	X	1 = 12.500
B18	4	4.650	X	4.250	X	1 = 19.763
B19	1	2.150	X	4.750	X	1 = 10.213
B20	1	1.500	X	1.600	X	1 = 3.300
B21	2	2.400	X	1.400	X	1 = 3.300
B22	1	7.800	X	1.800	X	1 = 4.461
TOTAL PARKING AREA						2541.750

SERVICES							
S1	1,900	X	3,680	X	1	= 5,888	UPS ROOM
S2	6,100	X	4,950	X	1	= 30,195	UPS ROOM
S3	2,850	X	2,650	X	2	= 15,100	1FT LOBBY
S4	6,000	X	6,000	X	2	= 92,200	1FT LOBBY
S5	3,000	X	6,150	X	2	= 36,600	1FT LOBBY
S6	2,900	X	4,750	X	1	= 11,675	1FT LOBBY
S7	4,000	X	3,150	X	1	= 8,600	1FT LOBBY
S8	2,200	X	4,750	X	1	= 10,450	1FT CORN
S9	12,000	X	1,500	X	1	= 79,800	1FT CORN
S10	4,400	X	7,150	X	1	= 17,900	1FT CORN
S13	3,050	X	4,000	X	1	= 14,825	1FT CORN
G14	2,625	X	3,150	X	1	= 8,669	1FT CORN
S15	3,900	X	3,400	X	1	= 13,260	1FT CORN
S16	4,000	X	4,000	X	1	= 23,250	1FT CORN
S17	3,800	X	1,850	X	1	= 7,000	1FT CORN

TOTAL SERVICES		=	373.93	
9	1.000 X 0.450	X 1	=	0.473 (SHAFT PLUMB)
10	0.000 X 1.750	X 1	=	1.575 (SHAFT PRESS.)
TOTAL DEDUCTION FROM SERVICES		=	2.048	
NET SERVICES AREA (373.933 - 2.048)		=	371.885	
BUILDING SERVICES AREA		=	371.885	(IV)
TOTAL F.A.R AREA ON FLOOR (I) - (II) - (III) - (IV)		=	1536.321	SQM
PARKING AREA		=	2218.294	
PARKING PROPOSED		=	73.543	

SHEET TITLE

STILT FLOOR
AREA DETAIL

OWNER:

URVASI INFRATECH PVT. LTD.

THROUGH : AUTHORISED SIGNATORY

CONSULTANT

R.N.Gupta & Associates
Consulting Engineers, Architects & Valuers
E - 1, Sector-55, Noida
Phones - (+120) 4321556
email-info@rngcorp.com

PROJECT :

PROPOSED I.T. SEZ PARK, NOIDA
PLOT NO - 01, SECTOR - 143 A
GAUTAM BUDDHA NAGAR , NOIDA (U.P)

SCALE 1:100	DATE 26 - 03 - 2021
-------------	---------------------

ARCHITECT'S SIGNATURE


OWNER'S SIGNATURE



Map for proposed Building is as per Bya

Leave submitted for approval: ☒ Please.

Pl. Asst. Asst. Architect

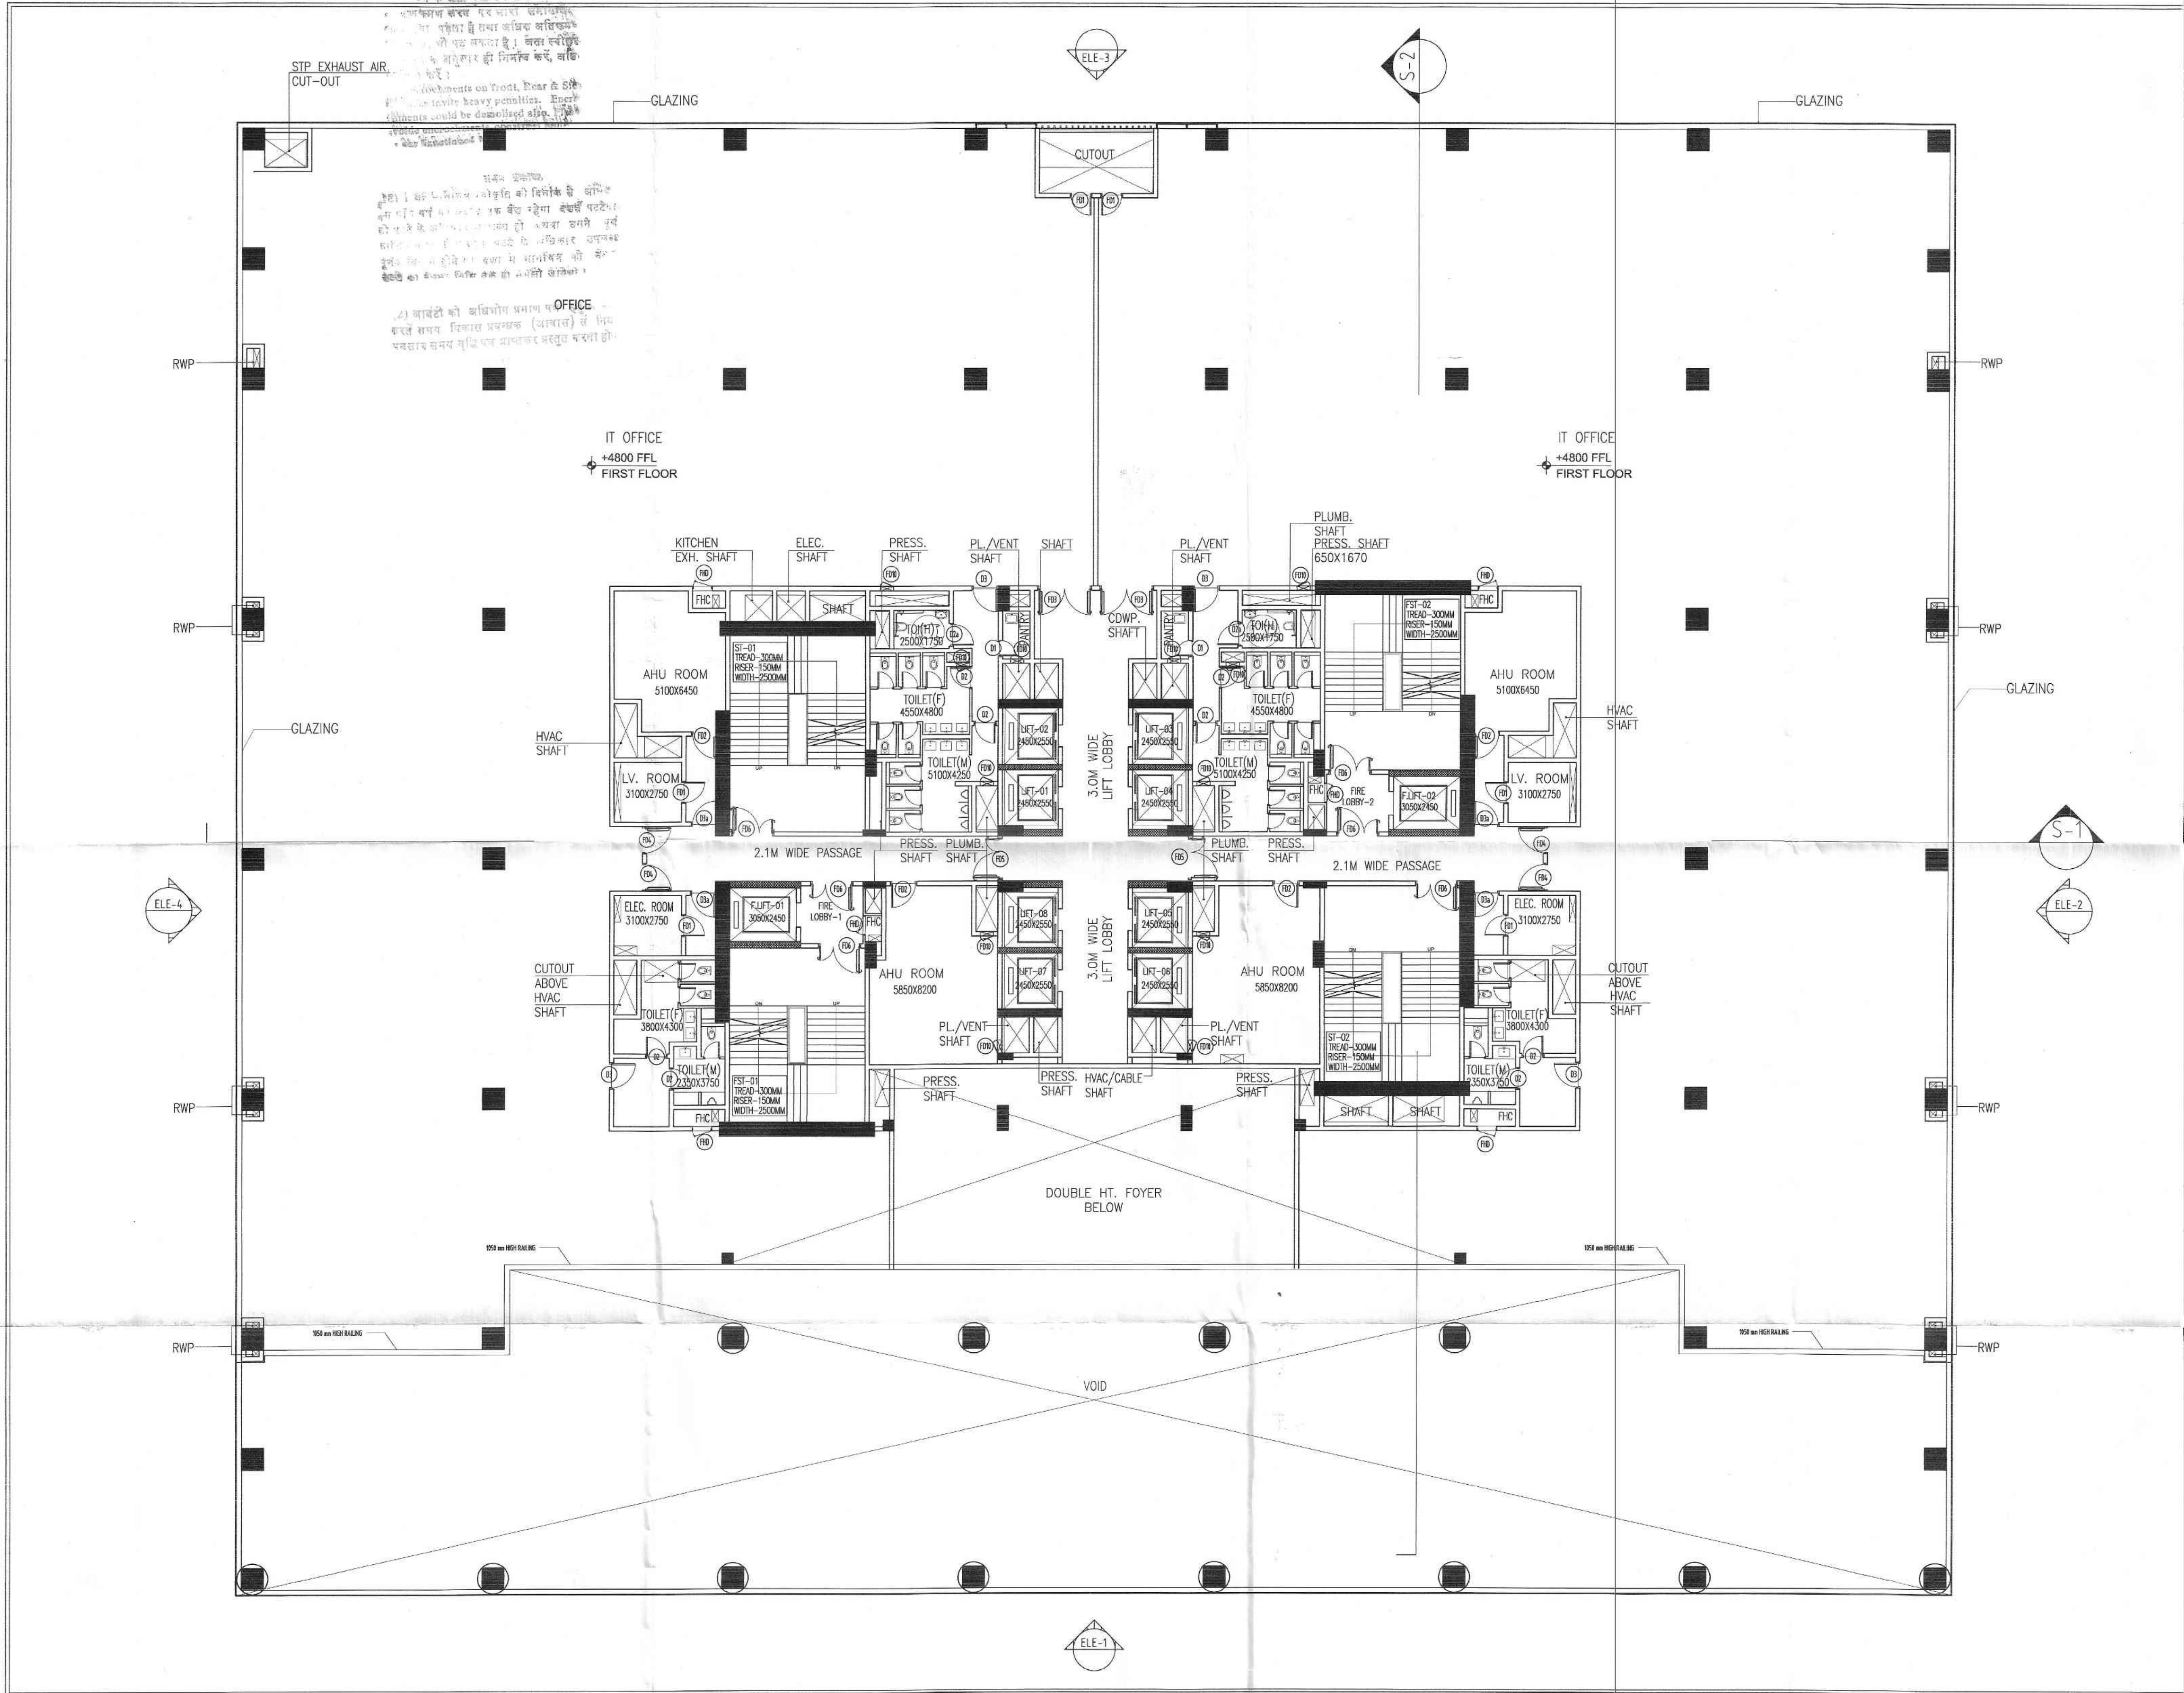

SHEET NO.-A/03

BLOCK - "A"
(STILT + 6)

DOOR WINDOW SCHEDULE				
TYPE	DOOR SIZE (ROUGH OPENING)	CUL. LVL.	LOCATION	FIRE RATING
FIRE DOORS				
FD-01	1000X2100	0	ELECTRICAL ROOM LV. ROOM SPACE FOR DEV.	2HR
FD-02	1000X2100	0	MAIL ROOM ROOM FIRE CONTROL ROOM KITCHEN PANTRY ROOM	2HR
FD-03	2400X2100	0	MAIN LIFT LOBBY ENTRY PLUMBING PUMP ROOM FIRE LIFT ROOM ATT. ROOM IT TRAVEL ROOM	2HR
FD-04	1000X2100	0	OFFICE SERVICE ENTRY	2HR
FD-05	1000X2100	0	MAIN LIFT LOBBY ATT. ROOM	2HR
FD-06	1000X2100	0	STAIRCASE FIRE STAIRCASE FIRE TOWER	2HR
FD-07	1000X2100	0	STAIRCASE FIRE STAIRCASE FIRE TOWER	2HR
FD-08	1000X2100	0	STAIRCASE FIRE STAIRCASE FIRE TOWER	2HR
NORMAL DOORS				
D1	700X2100	0	PANTRY	N/A
D2	1000X2100	0	TOILET DRIVER'S TOILET SERV. ROOM	N/A
D3	1000X2100	0	HANDICAP TOILET	N/A
D4	1000X2100	0	INTERNAL DOOR	N/A
D5	1000X2100	0	MAIN LIFT LOBBY INTERNAL DOOR	N/A
D6	1000X2100	0	SHUTTLE CABLE TRENCH	N/A
D7	1000X2100	0	SHUTTLE CABLE TRENCH	N/A
D8	1000X2100	0	SHUTTLE CABLE TRENCH	N/A
GLASS DOORS				
G1	2100X2100	0	ENTRANCE LOBBY	N/A
G2	2100X2100	0	ENTRANCE LOBBY	N/A

SANITARY FIXTURES REQUIRED				
FIRST FLOOR				
BLOCK A				
3470.482				
OCCUPANCY @ 10 SQM/PERSON				
PROVIDED				
MALE FEMALE MALE FEMALE				
173.5 173.5				
7 12 8 14				
7 7 8 10				
4 -				
2.2				
-0.7				
6 8				
TOTAL				

SUBMISSION DRAWING

SHEET TITLE

FIRST FLOOR PLAN

OWNER:

URVASI INFRATECH PVT. LTD.

PROJECT :


PROPOSED I.T. SEZ PARK, NOIDA
PLOT NO - 01, SECTOR - 143 A
GAUTAM BUDDHA NAGAR , NOIDA (U.P)

SCALE 1:100

DATE 26 - 03 - 2021

ARCHITECT'S SIGNATURE

OWNER'S SIGNATURE

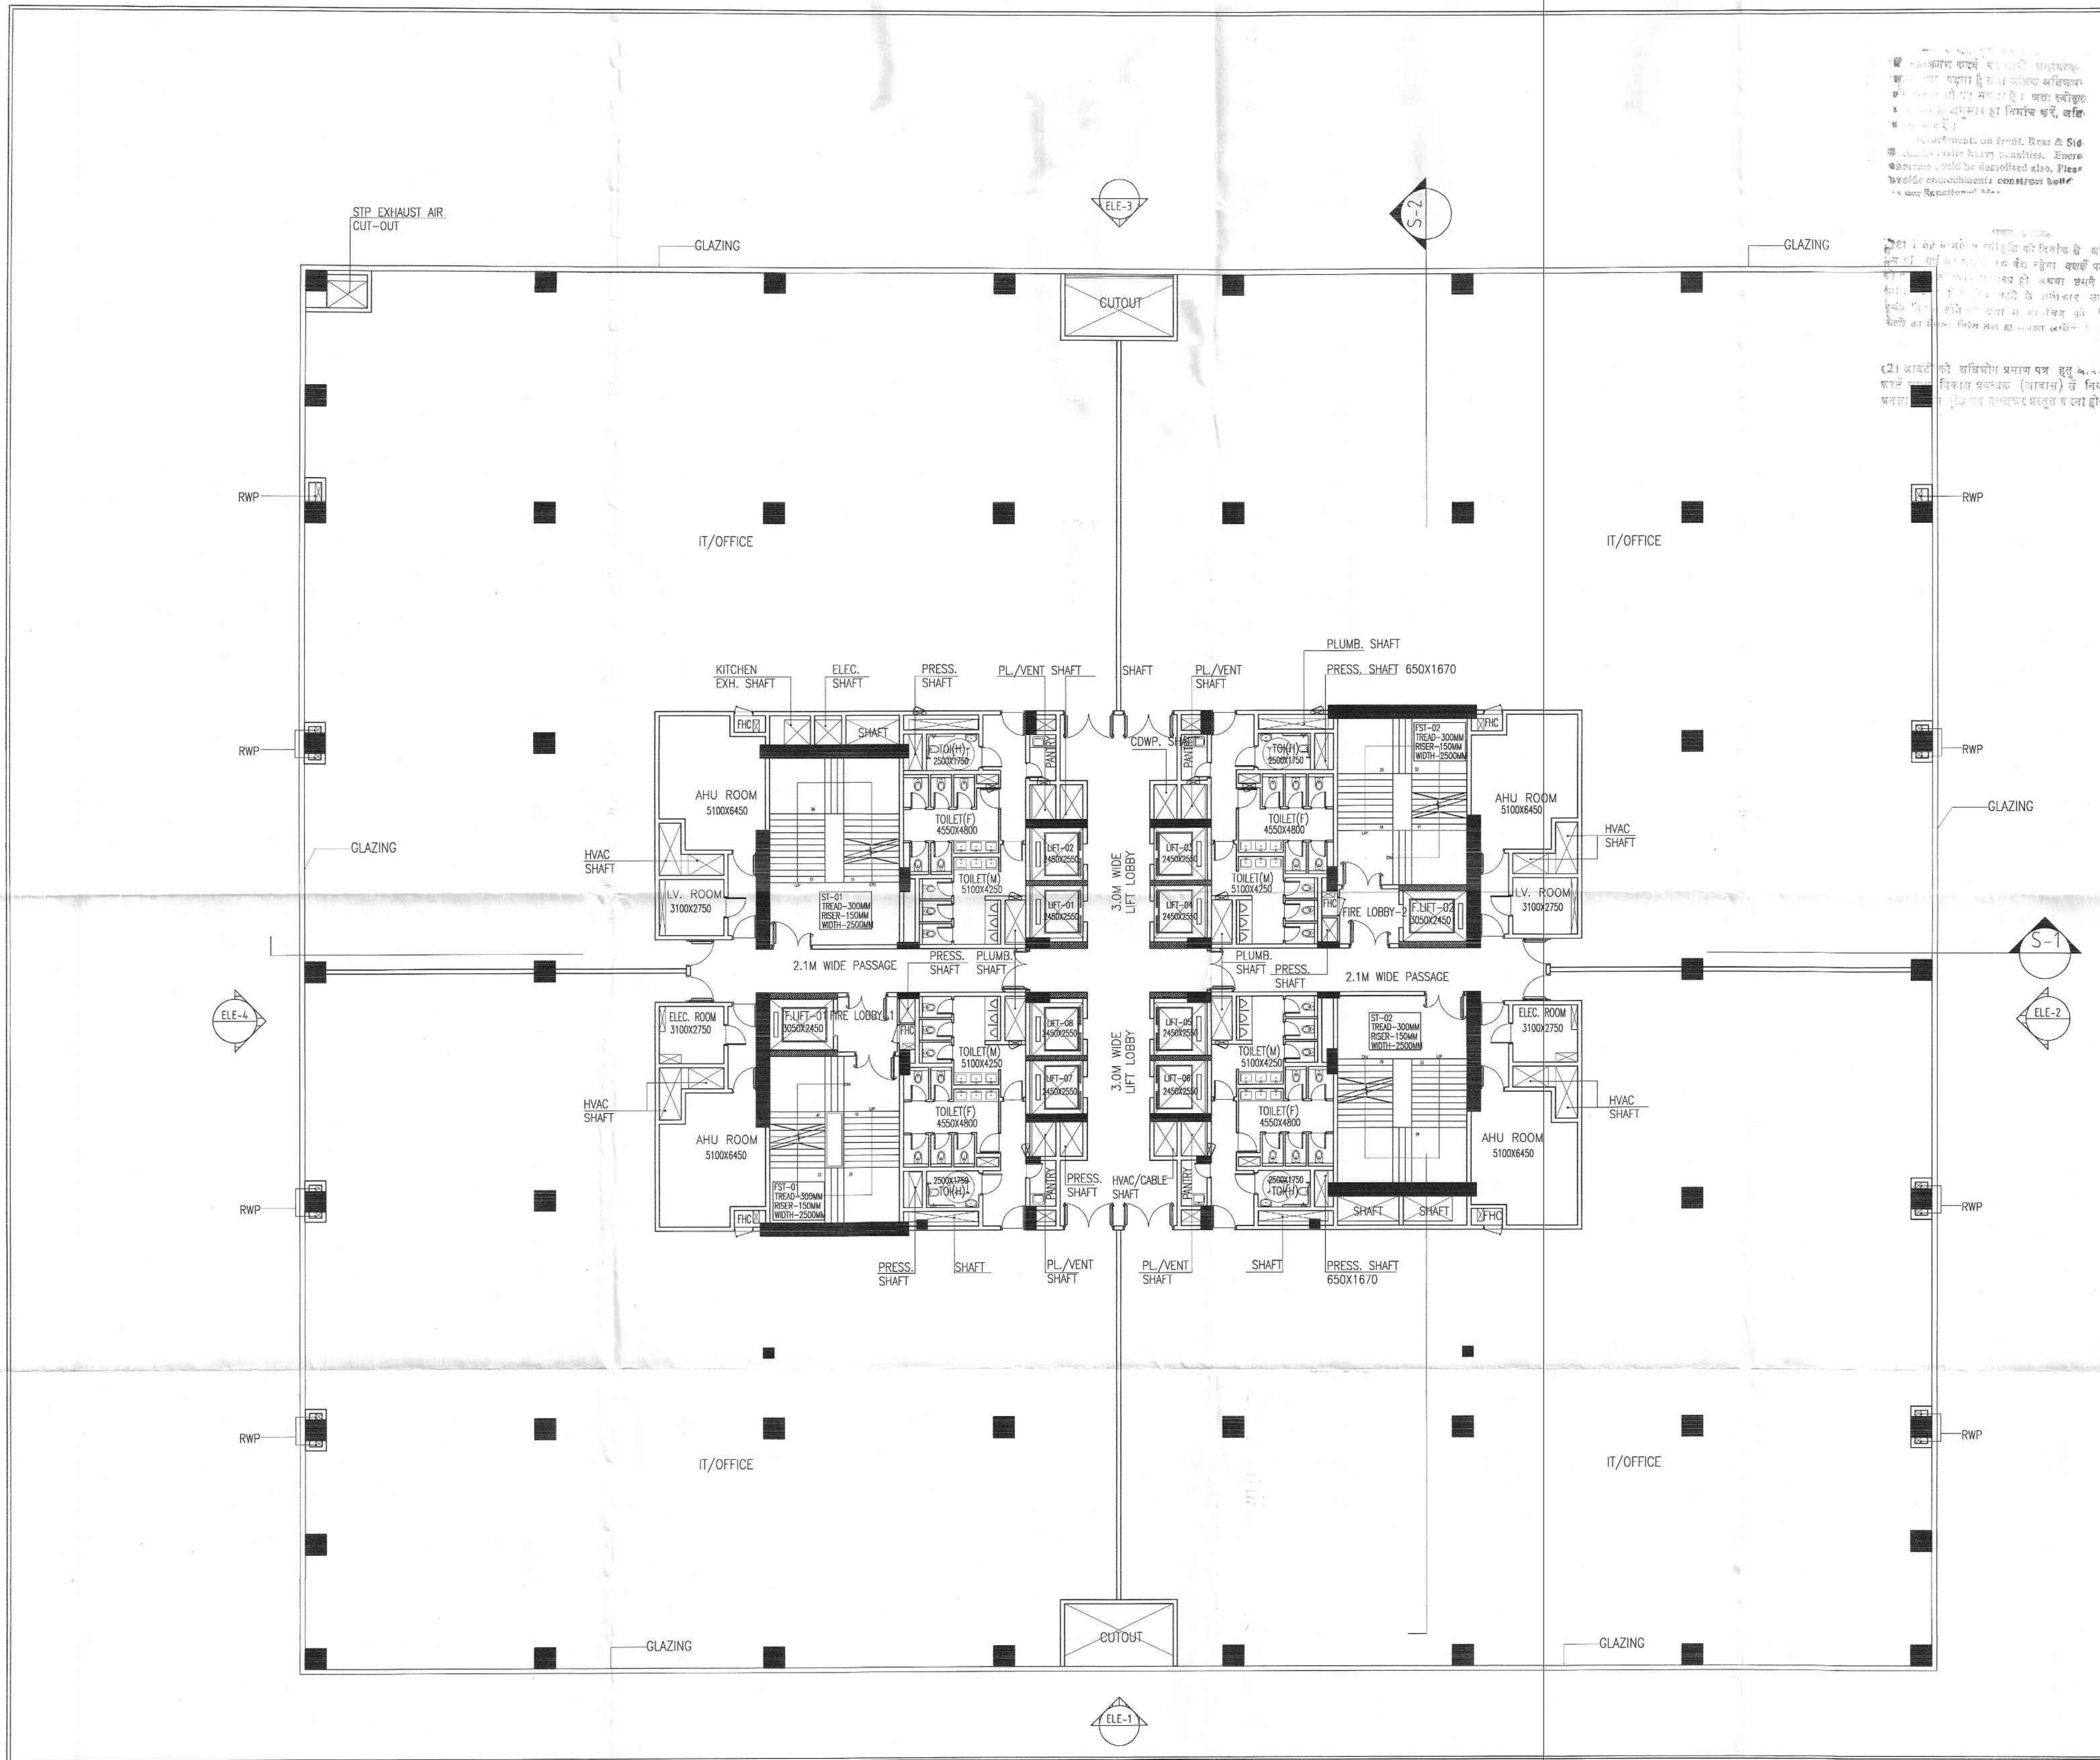

आवक और निकलने वाले वायु को नियंत्रित करने के लिए भारी पन्नीयों का प्रयोग किया गया है। भारी पन्नीयों का प्रयोग करने से वायु का प्रवाह नियंत्रित हो सकेगा।
आवक और निकलने वाले वायु को नियंत्रित करने के लिए भारी पन्नीयों का प्रयोग किया गया है। भारी पन्नीयों का प्रयोग करने से वायु का प्रवाह नियंत्रित हो सकेगा।

(2) आवक और निकलने वाले वायु को नियंत्रित करने के लिए भारी पन्नीयों का प्रयोग किया गया है। भारी पन्नीयों का प्रयोग करने से वायु का प्रवाह नियंत्रित हो सकेगा।

SHEET NO. -A/04

BLOCK - "A"
(STILT + 6)

DOOR WINDOW SCHEDULE		LOCATION	FIRE RATING
TYPE	DOOR (H/SH/OPENING)		
FIRE DOORS			
F01	1000X2100	0	2100
F02	1000X2100	0	2100
F03	2400X2400	0	2400
F04	1200X2400	0	2400
F05	1200X2400	0	2400
F06	1200X2400	0	2400
F100	1200X2400	0	2400

SANITARY FIXTURES REQUIRED

TYPICAL FLOOR	BLOCK A
FAR AREA	4801.550
OCCUPANCY @ 10 SQM/PERSON	480
	MALE FEMALE MALE FEMALE
WC	10 16 12 20
WB	10 10 12 12
FOR 100	4 -
FOR 101 TO 200 @ 3%	4.2
FOR OVER 200 @ 2.5%	1.0
TOTAL	9 12

FLOOR	LEVEL (F.F.L.)
2ND FLOOR	+9000 MM
3RD FLOOR	+13200 MM
4TH FLOOR	+17400 MM
5TH FLOOR	+21600 MM

SUBMISSION DRAWING

SHEET TITLE
2ND TO 5TH (TYPICAL) FLOOR PLAN

OWNER:
URVASI INFRATECH PVT. LTD.

THROUGH : AUTHORIZED SIGNATORY

CONSULTANT
R.N.Gupta & Associates
Consulting Engineers, Architects & Valuers
E - 1, Sector-55, Noida
Phones - (+120) 4321556
email-info@rngcorp.com

PROJECT :
PROPOSED I.T. SEZ PARK, NOIDA
PLOT NO - 01, SECTOR - 143 A
GAUTAM BUDDHA NAGAR , NOIDA (U.P)

SCALE 1:100 DATE 26 - 03 - 2021


ARCHITECT'S SIGNATURE

OWNER'S SIGNATURE

BCR-720/720/26-11-21

Map for proposed Building is as per By Laws submitted for approval Please.

Pt. Asst. Asstt. Archt. Asstt. Archt.

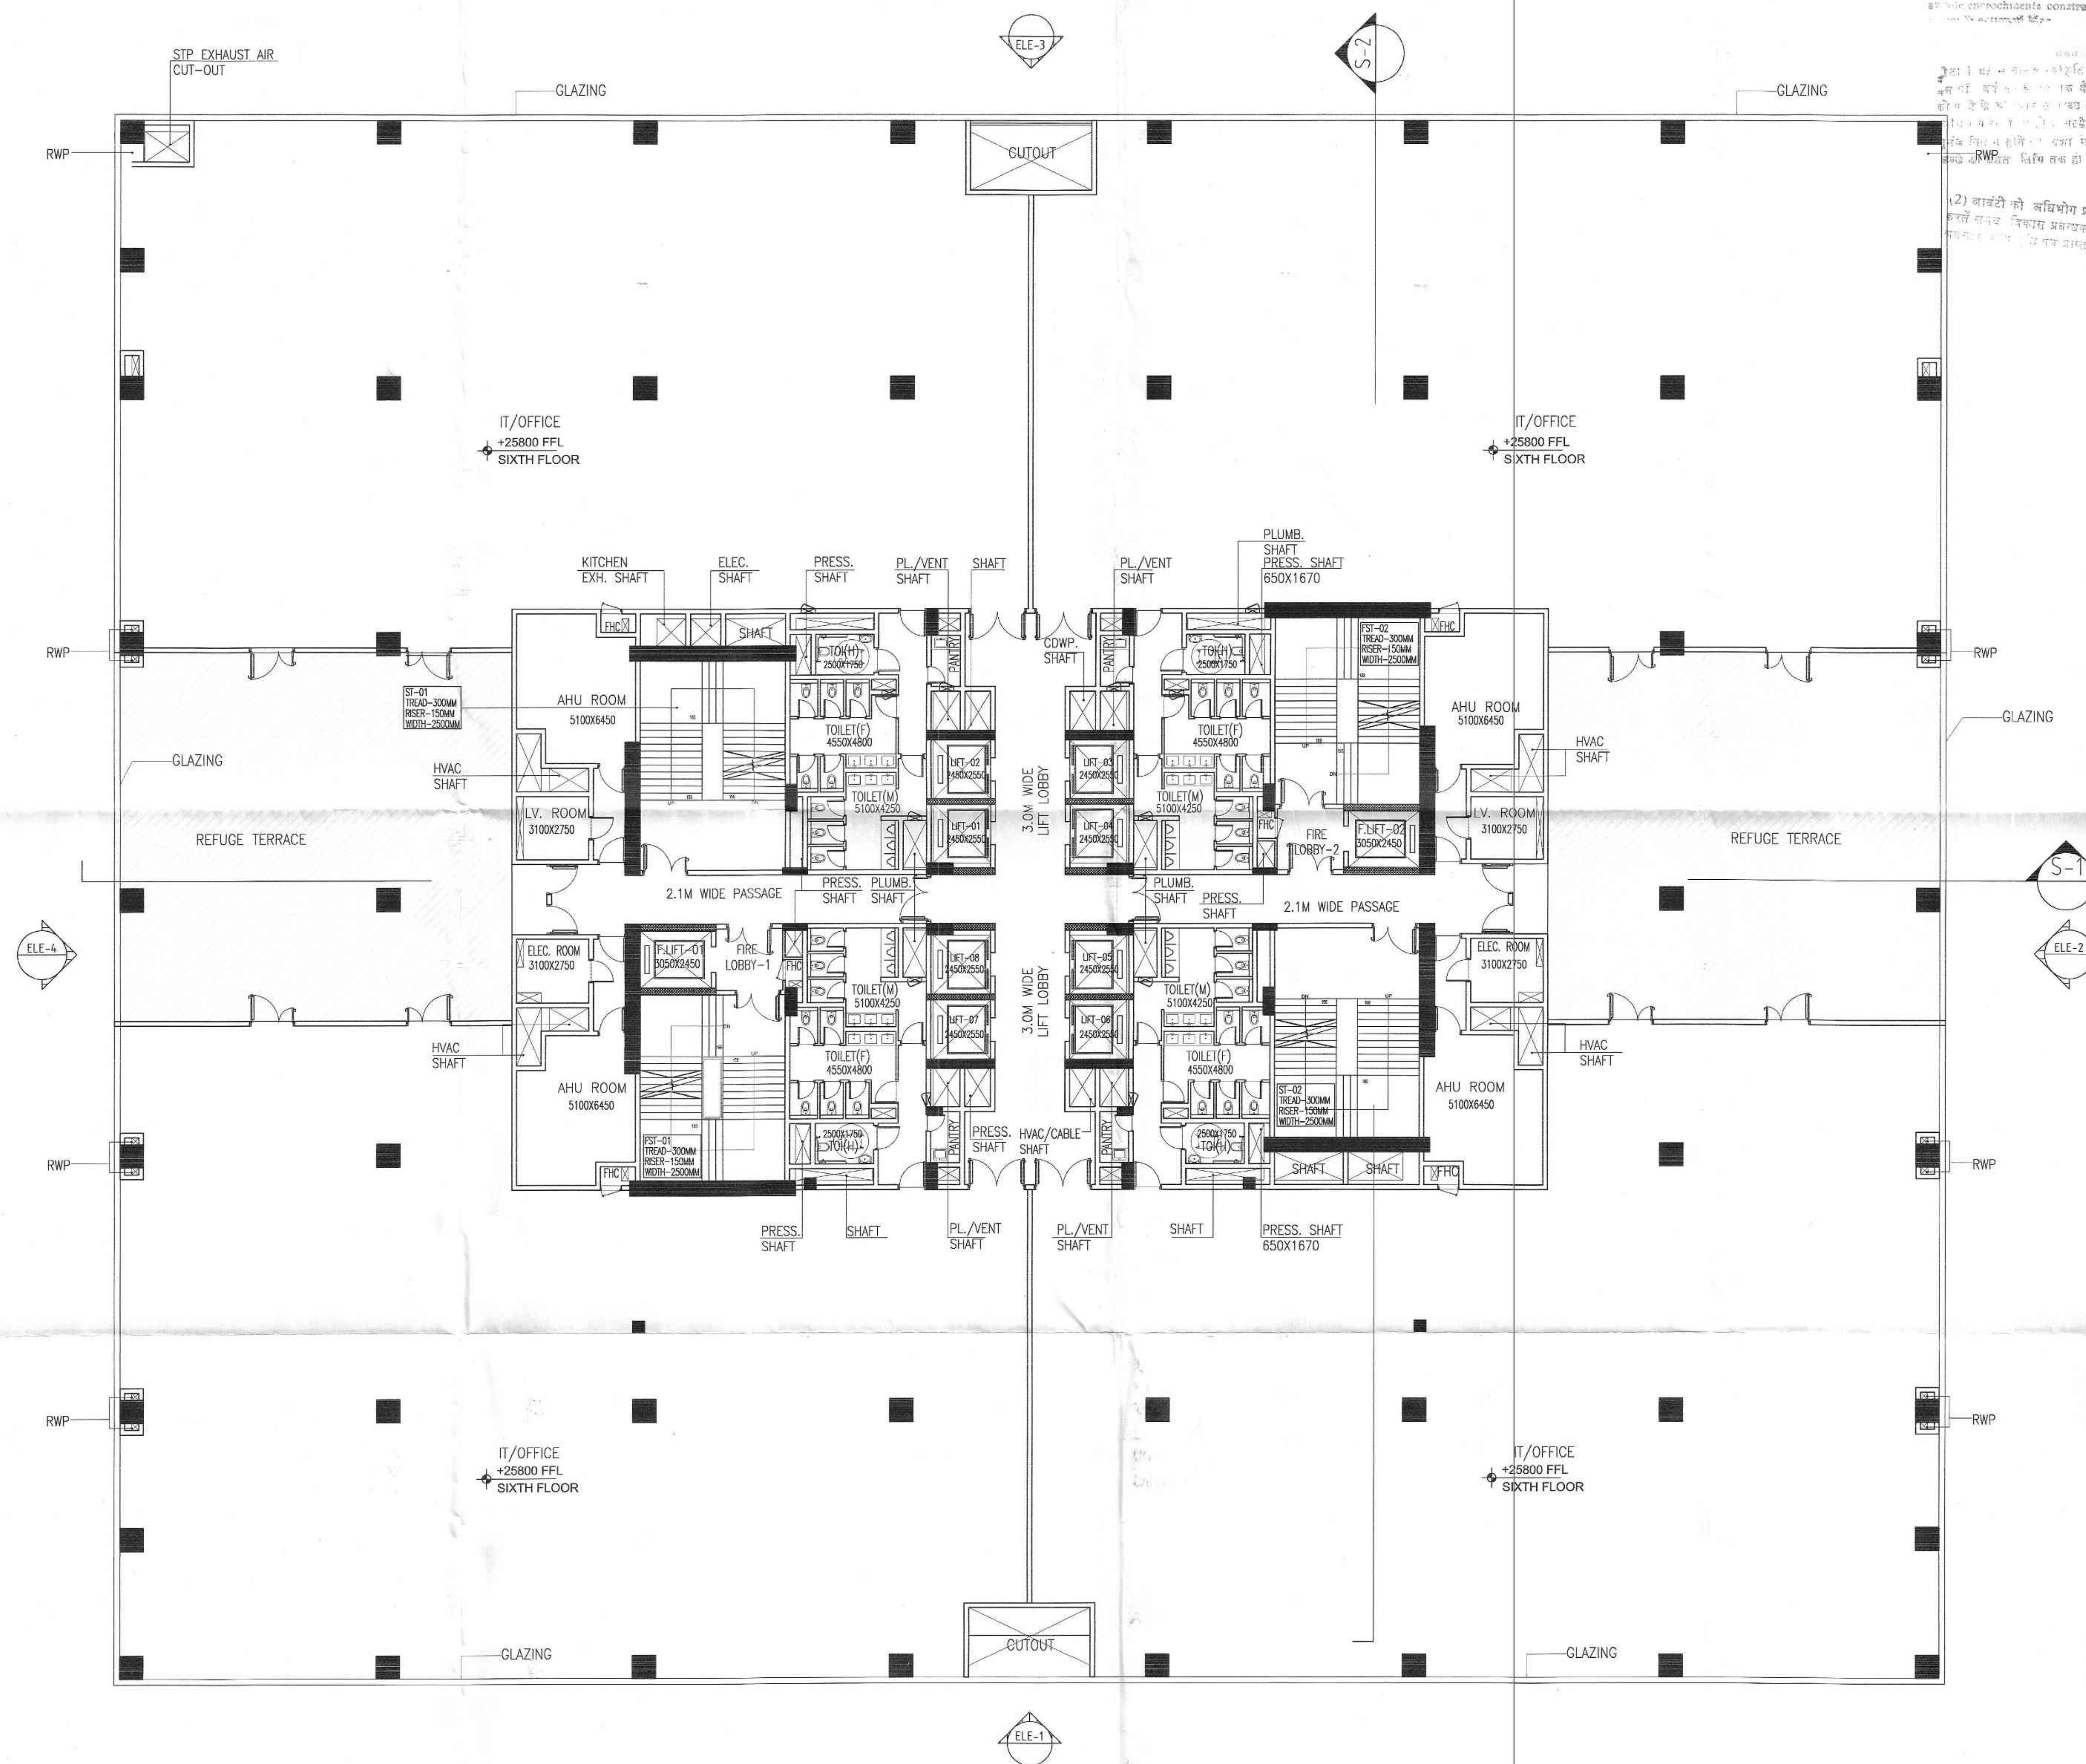

DOOR WINDOW SCHEDULE						
TYPE	DOOR SIZE (ROUGH OPENING)	COL VAL	UNIT/LVS	LOCATION	FIRE RATING	
FIRE DOORS						
FD1	550X2100	0	2100	ELECTRICAL ROOM, LV ROOM, SPACE FOR DOG	2HR	
FD2	1000X2100	0	2100	PAINT ROOM, FIRE CONTROL ROOM, ELEC PAINT PAUL	2HR	
FD3	3435X2100	0	2100	PAINT LEFT FLOOR ELEV, PLUMBING PLANT ROOM, FIRE PLANT ROOM, IT ROOM, IT FURNISH ROOM	2HR	
FD4	1280X2100	0	2400	OFFICE SERVICE ENTRY	2HR	
FD5	3335X2100	0	2400	MAINT. OFFICE, HT. MEILUR	2HR	
FD6	5160X2100	0	2100	STAIRCASE, FIRE STAIRCASE, FIRE CORNER	2HR	
FD10	1020X900	1000	2100	GAZE (ACCESS DOOR)	2HR	
NORMAL DOORS						
D1	750X2100	0	1100	PANTRY	NA	
D2	3000X2100	0	2100	TOILET, MEN'S TOILET/RAIN ROOM	NA	
D3	1030X2100	0	2100	HANDICAP TOILET	NA	
D4	1000X2100	0	2100	INTERNAL DOOR	NA	
D5	1200X2100	0	2100	MAIN LOBBY INTERNAL DOOR	NA	
D6	3000X2100	0	2100	SHUTTLE CABLE TRENCH	NA	
FD2	900X300	75	2100	RHC	NA	
GLASS DOORS						
GL1	2110X2451	0	2055	ENTRANCE LOBBY	NA	
GL2	3000X2400	0	2055	CREDS. CAFE	2HR	
REFUGUE AREA CALCULATION						
GROSS AREA AT TYPICAL FLOOR					5276	SQM
GROSS AREA AT WHEEL CHAIR					4821.58	SQM
TOTAL AREA					10147.58	SQM
POPULATION @ 10 SQM/ PERSON					1014.76	PERSONS
AREA @ 0.3 SQM/ PERSON					3304.83	SQM
ADDITIONAL 0.9 SQM FOR WHEEL CHAIR FOR EVERY 200 OCCUPANT					4.57	SQM
TOTAL REFUGUE AREA REQUIRED					3309.39	SQM
REFUGUE AREA PROVIDED					5208.55	SQM
NET AREA TAKEN IN FAR					2195.56	SQM
SANITARY FIXTURES REQUIRED						
FAR AREA			BLOCK A			
OCCUPANCY @ 10 SQM/PERSON			4922.604			
			419		PROVIDED	
			MALE	FEMALE		
			225	225		
WC			9	15	12	
WB			9	9	12	
URINAL						
FOR 100			4	-		
FOR 100 TO 200 @ 3%			3.7			
FOR OVER 200 @ 1.5%			0.6			
TOTAL			8	12		

SUBMISSION DRAWING	
SHEET TITLE	
6TH FLOOR PLAN	
OWNER:	
URVASI INFRATECH PVT. LTD.	
THROUGH :	AUTHORISED SIGNATORY
CONSULTANT	
R.N.Gupta & Associates Consulting Engineers, Architects & Valuers E - 1, Sector-55, Noida Phones - (+120) 4321556 email-info@rngcorp.com	
PROJECT :	
PROPOSED I.T. SEZ PARK, NOIDA PLOT NO - 01, SECTOR - 143 A GAUTAM BUDDHA NAGAR , NOIDA (U.P)	
SCALE 1:100	DATE 26 - 03 - 2021
ARCHITECT'S SIGNATURE	
	
OWNER'S SIGNATURE	



जय श्रीगणेश, श्रीगुरु
बातवर्ता
श्रीगुरुदेव, सर्वत्र भवतु।
ब्रह्म की शक्ति को सर्वदा प्राप्त
रहे। ध्यान है।

BC [726] 726/26-11-2-1
भक्ति
पाना.....
धारा.....
(सत्यवादी धर्म)

Map for proposed Building is as per By-Laws submitted for approval. Please.

Bgr
M. Adet. Asst. Secy. Amlal

SHEET NO.-A/06


BLOCK - "A"
(STILT + 6)

P.C/R-720/20/26-11-21

Map for proposed Building as per Bye
Laws submitted for approval Please.

Architect
P.C. Raut

MUMTY AREA DETAIL						
LEGEND	BREADTH (B)	AREA	NOS.		TOTAL AREA	SPACE USGAE
A	6.600	23.400	X 2	=	308.880	SQM
B	0.750	2.950	X 2	=	4.425	SQM
TOTAL AREA				=	313.305	SQM

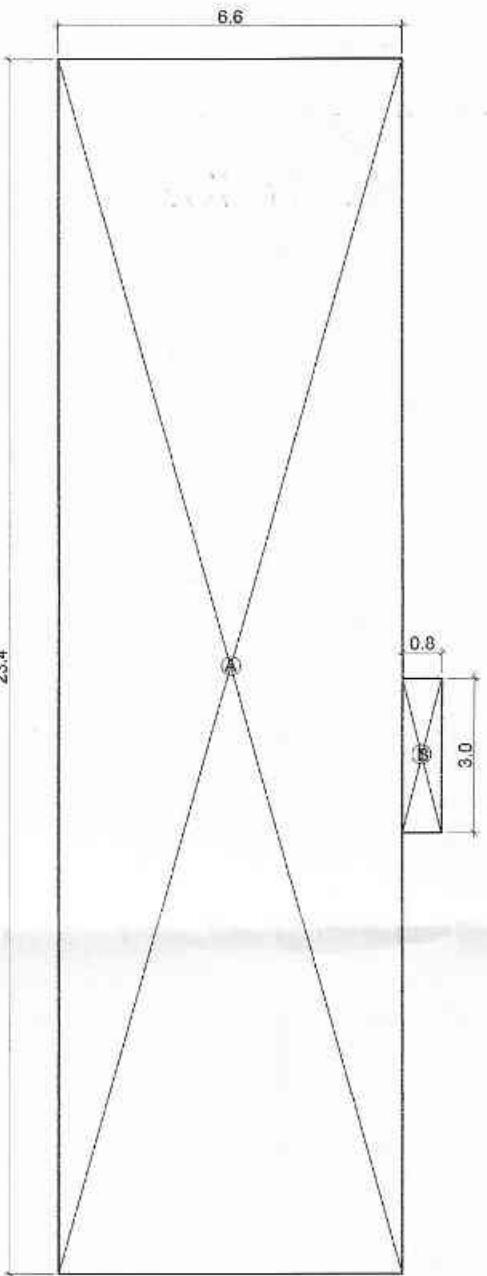

MUMMTY AREA

SUBMISSION DRAWING

SHEET TITLE

TERRACE PLAN

OWNER:

URVASI INFRATECH PVT. LTD.

PROJECT :

PROPOSED I.T. SEZ PARK, NOIDA
PLOT NO - 01, SECTOR - 143 A
GAUTAM BUDDHA NAGAR , NOIDA (U.P)


SCALE 1:100


DATE 26 - 03 - 2021

ARCHITECT'S SIGNATURE


[Handwritten Signature]

OWNER'S SIGNATURE

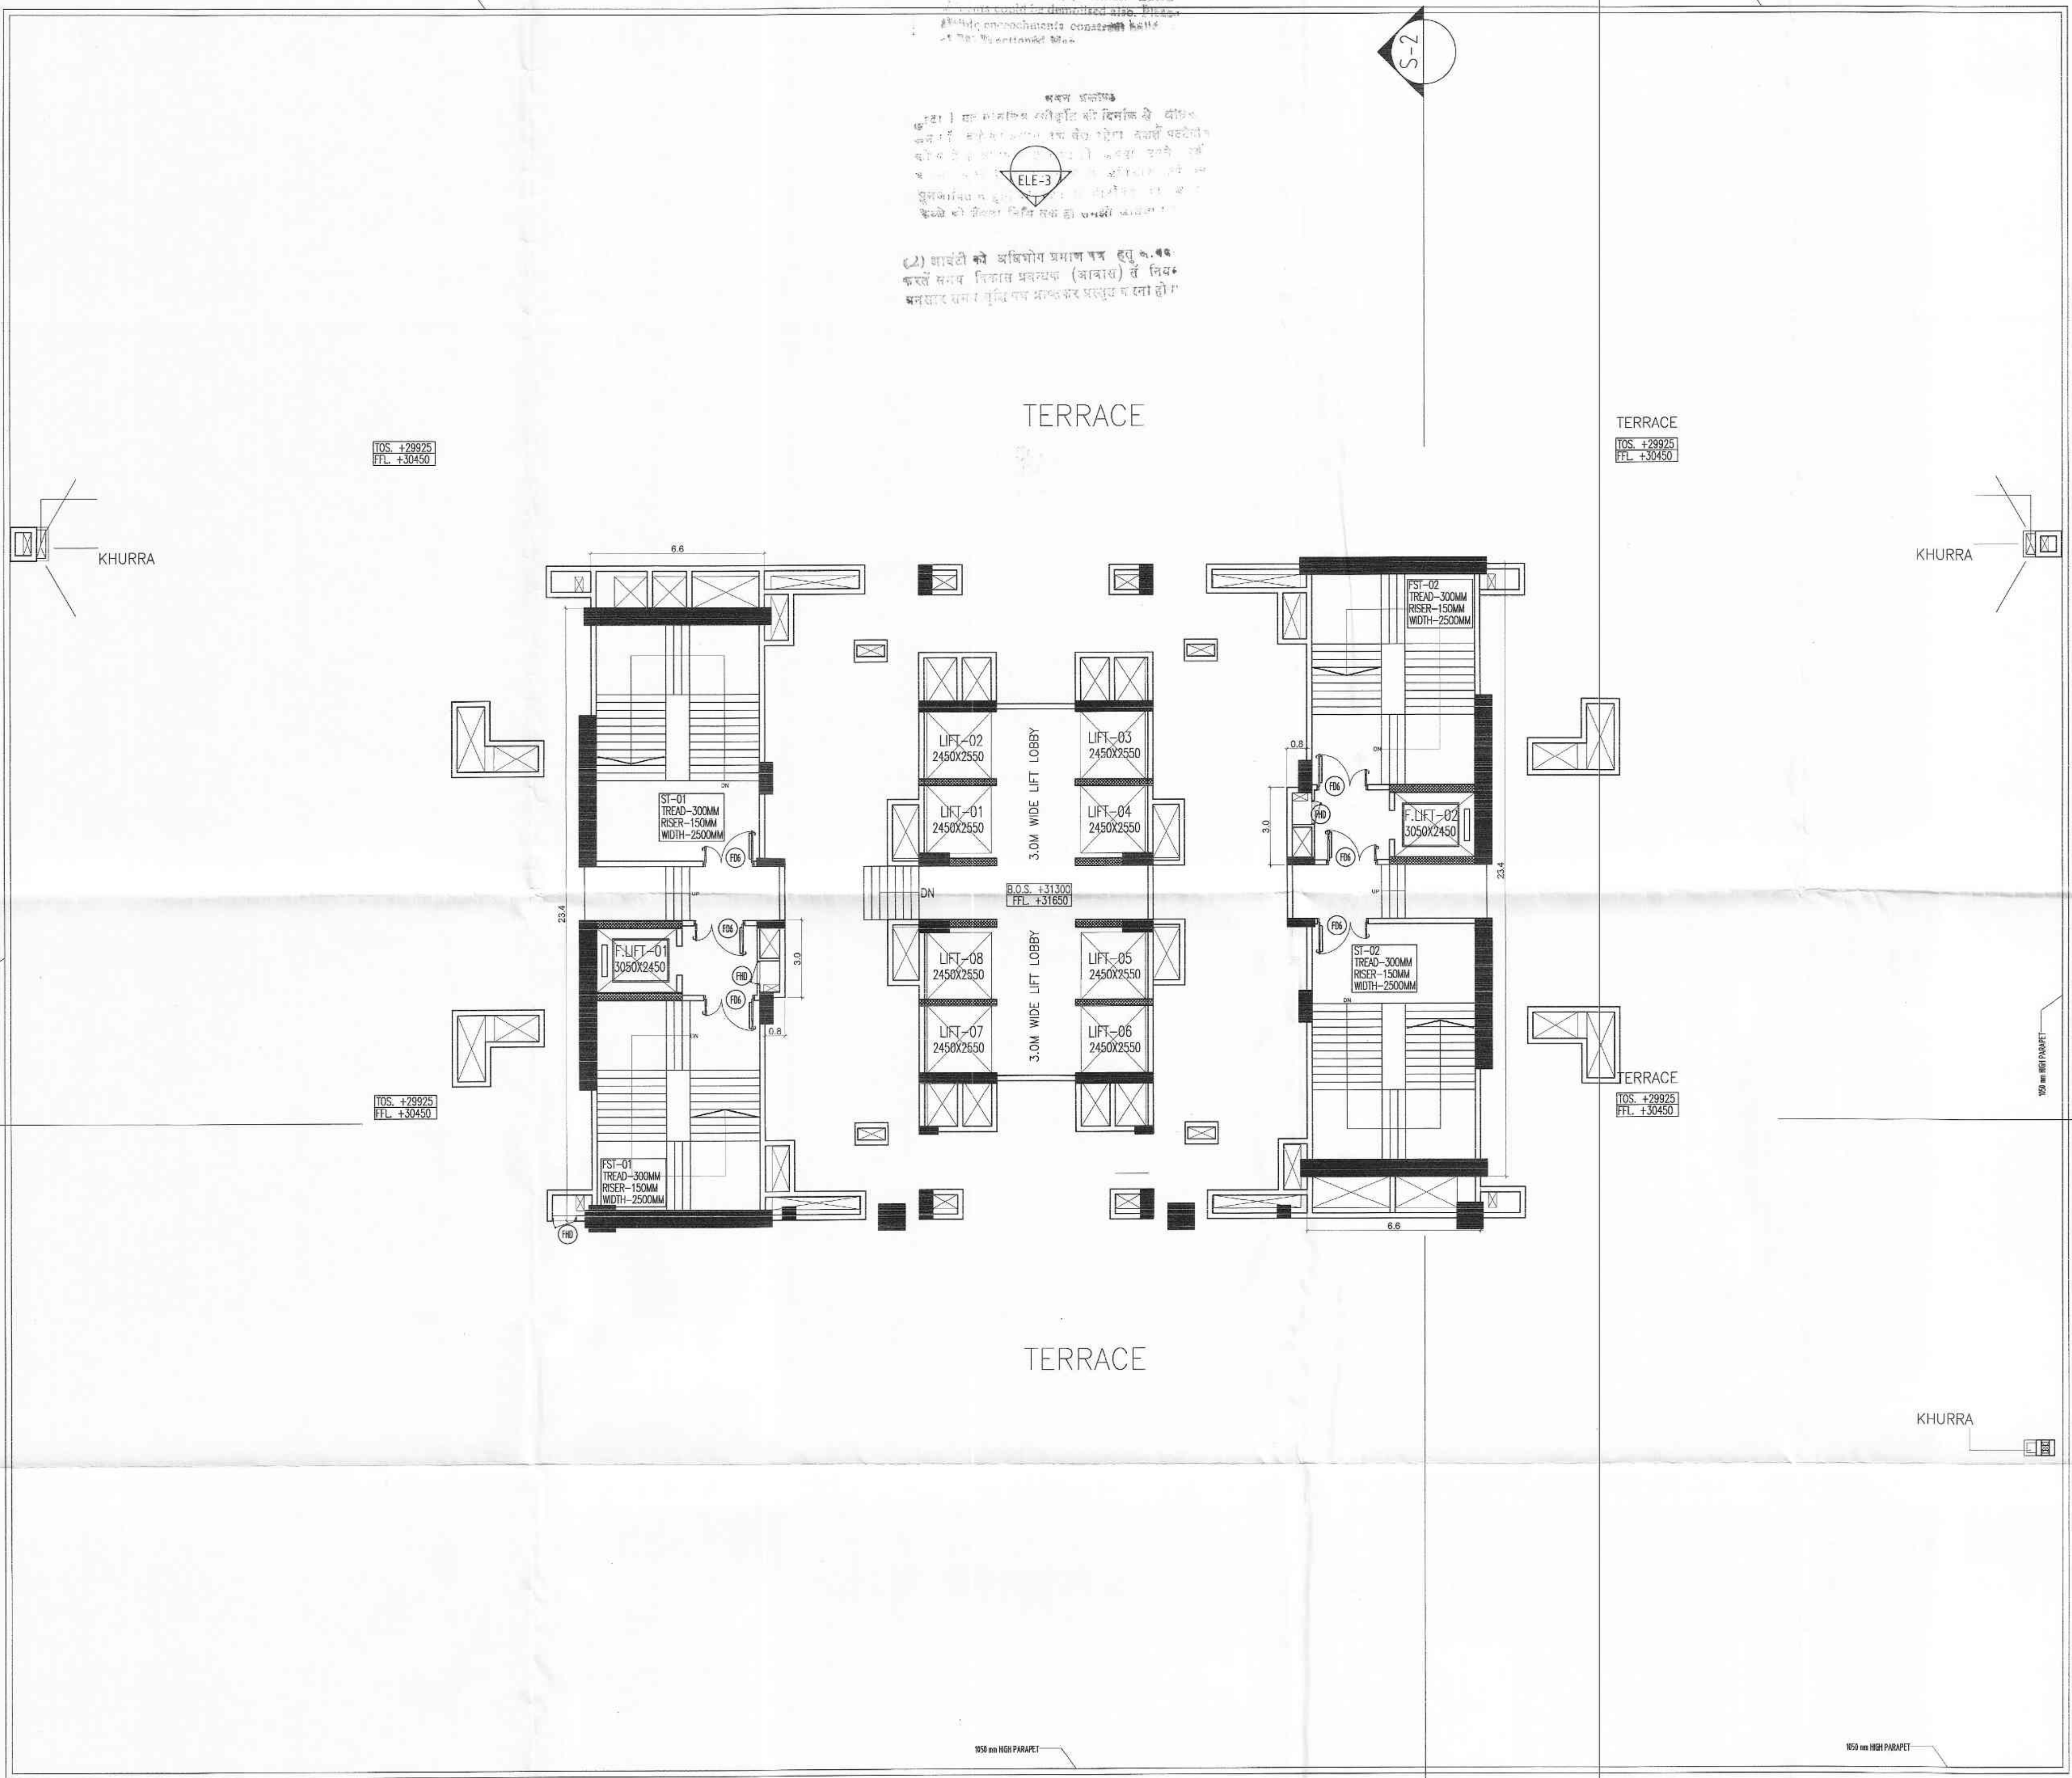

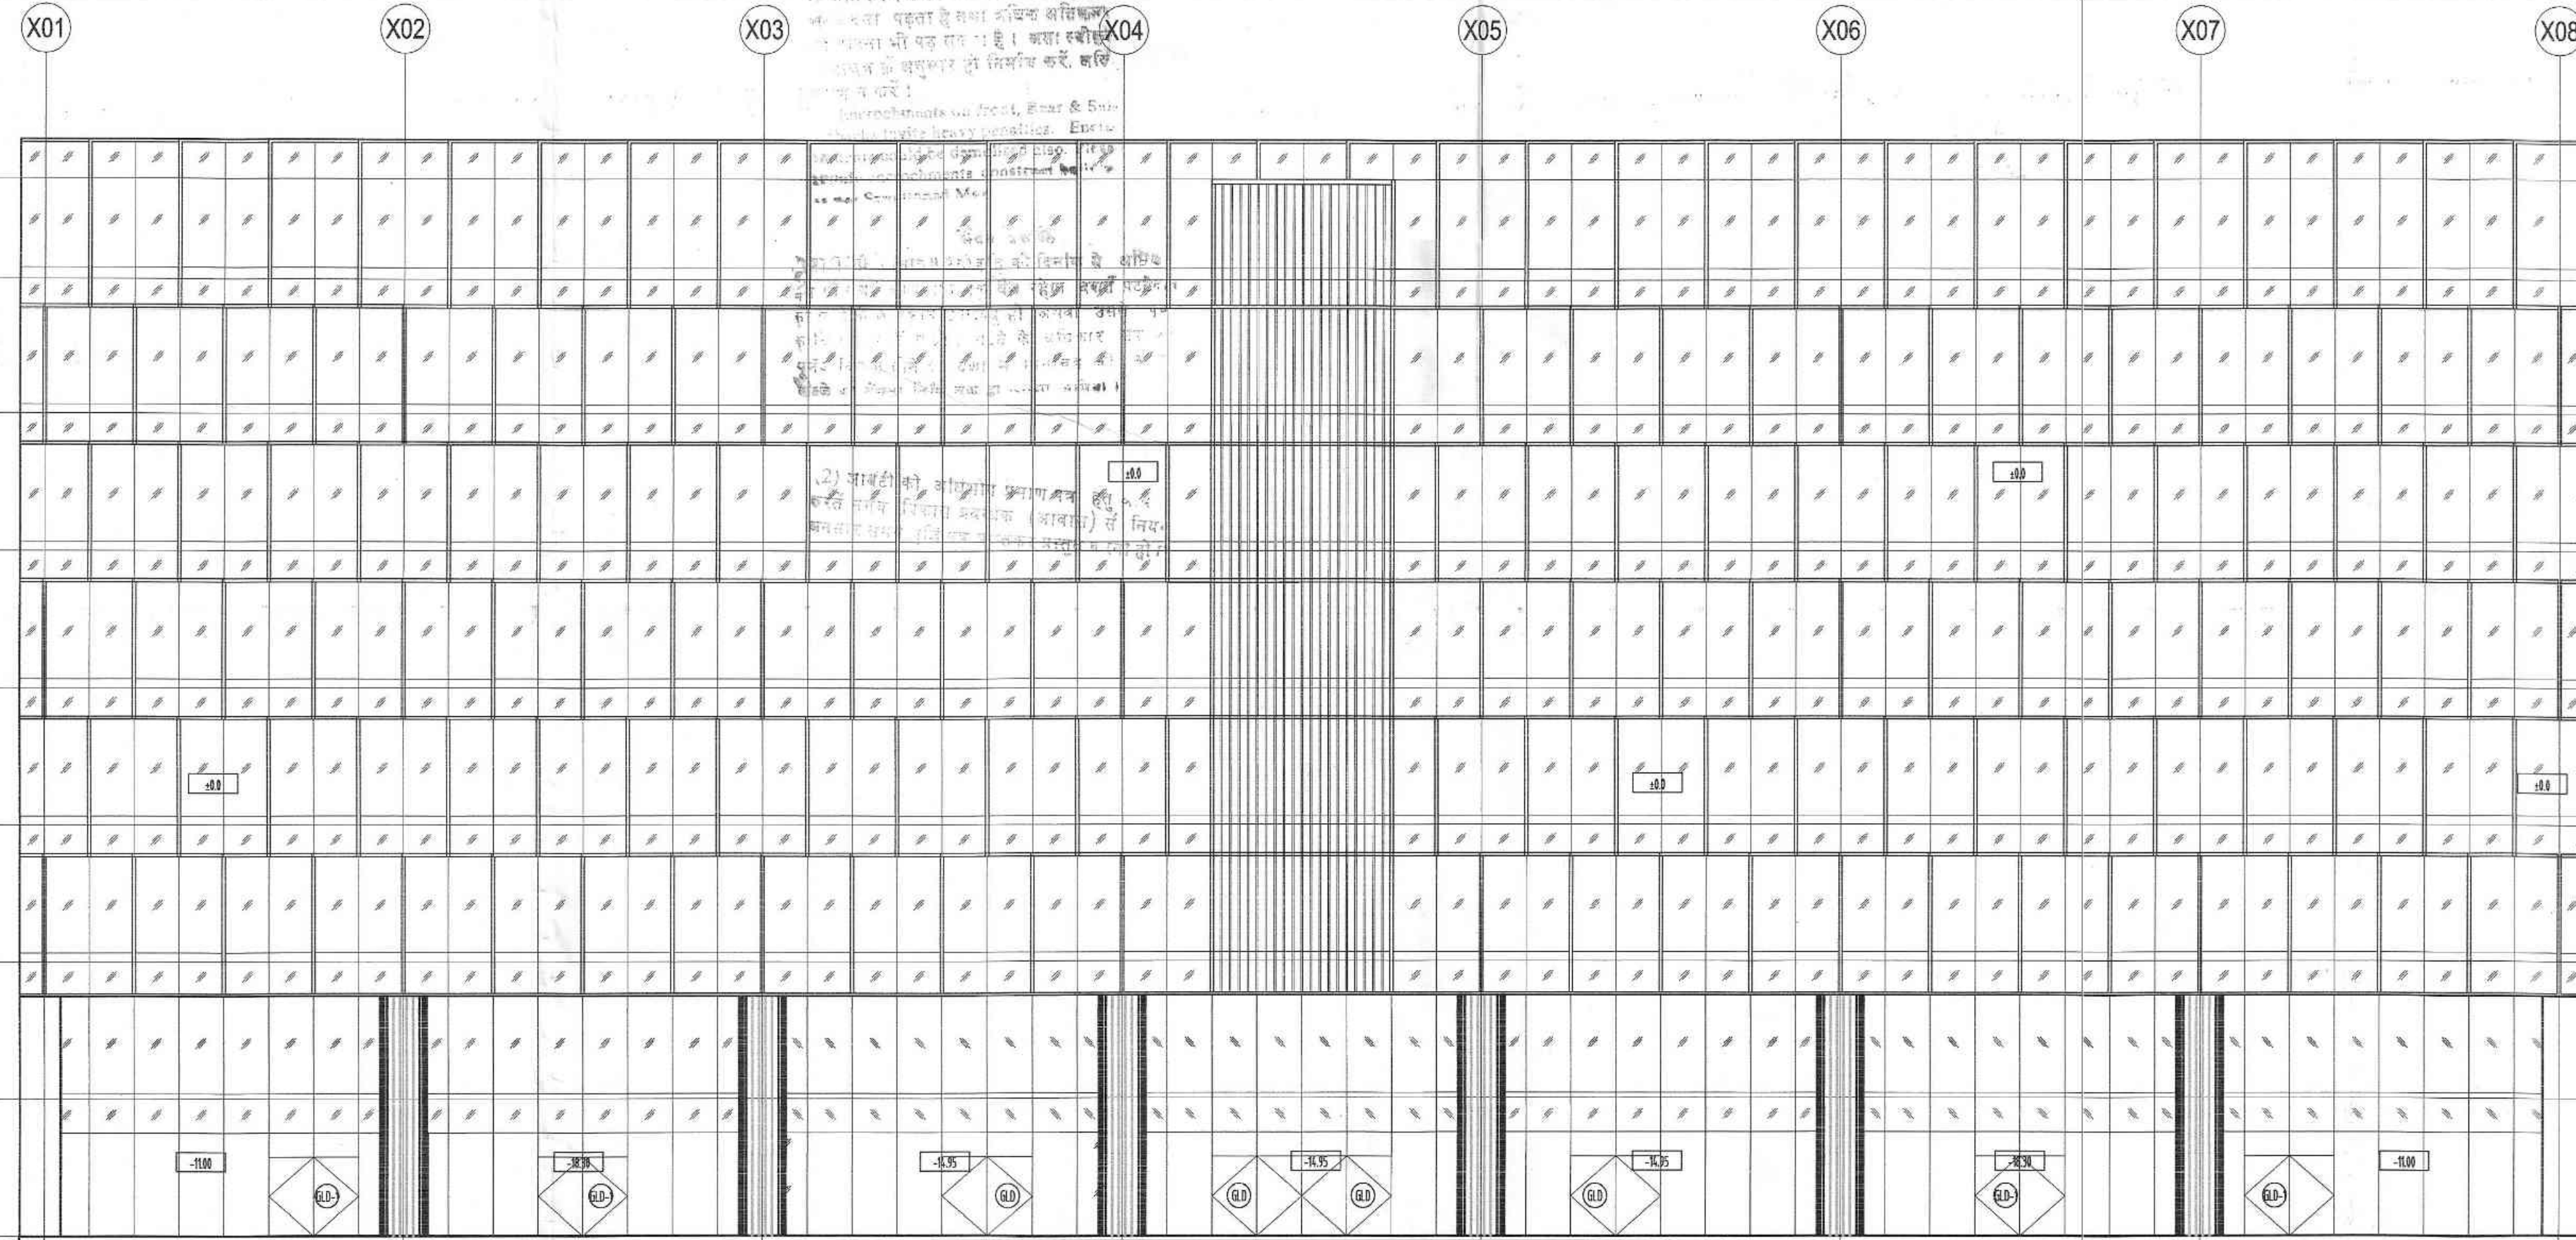

ELEVATION - 1

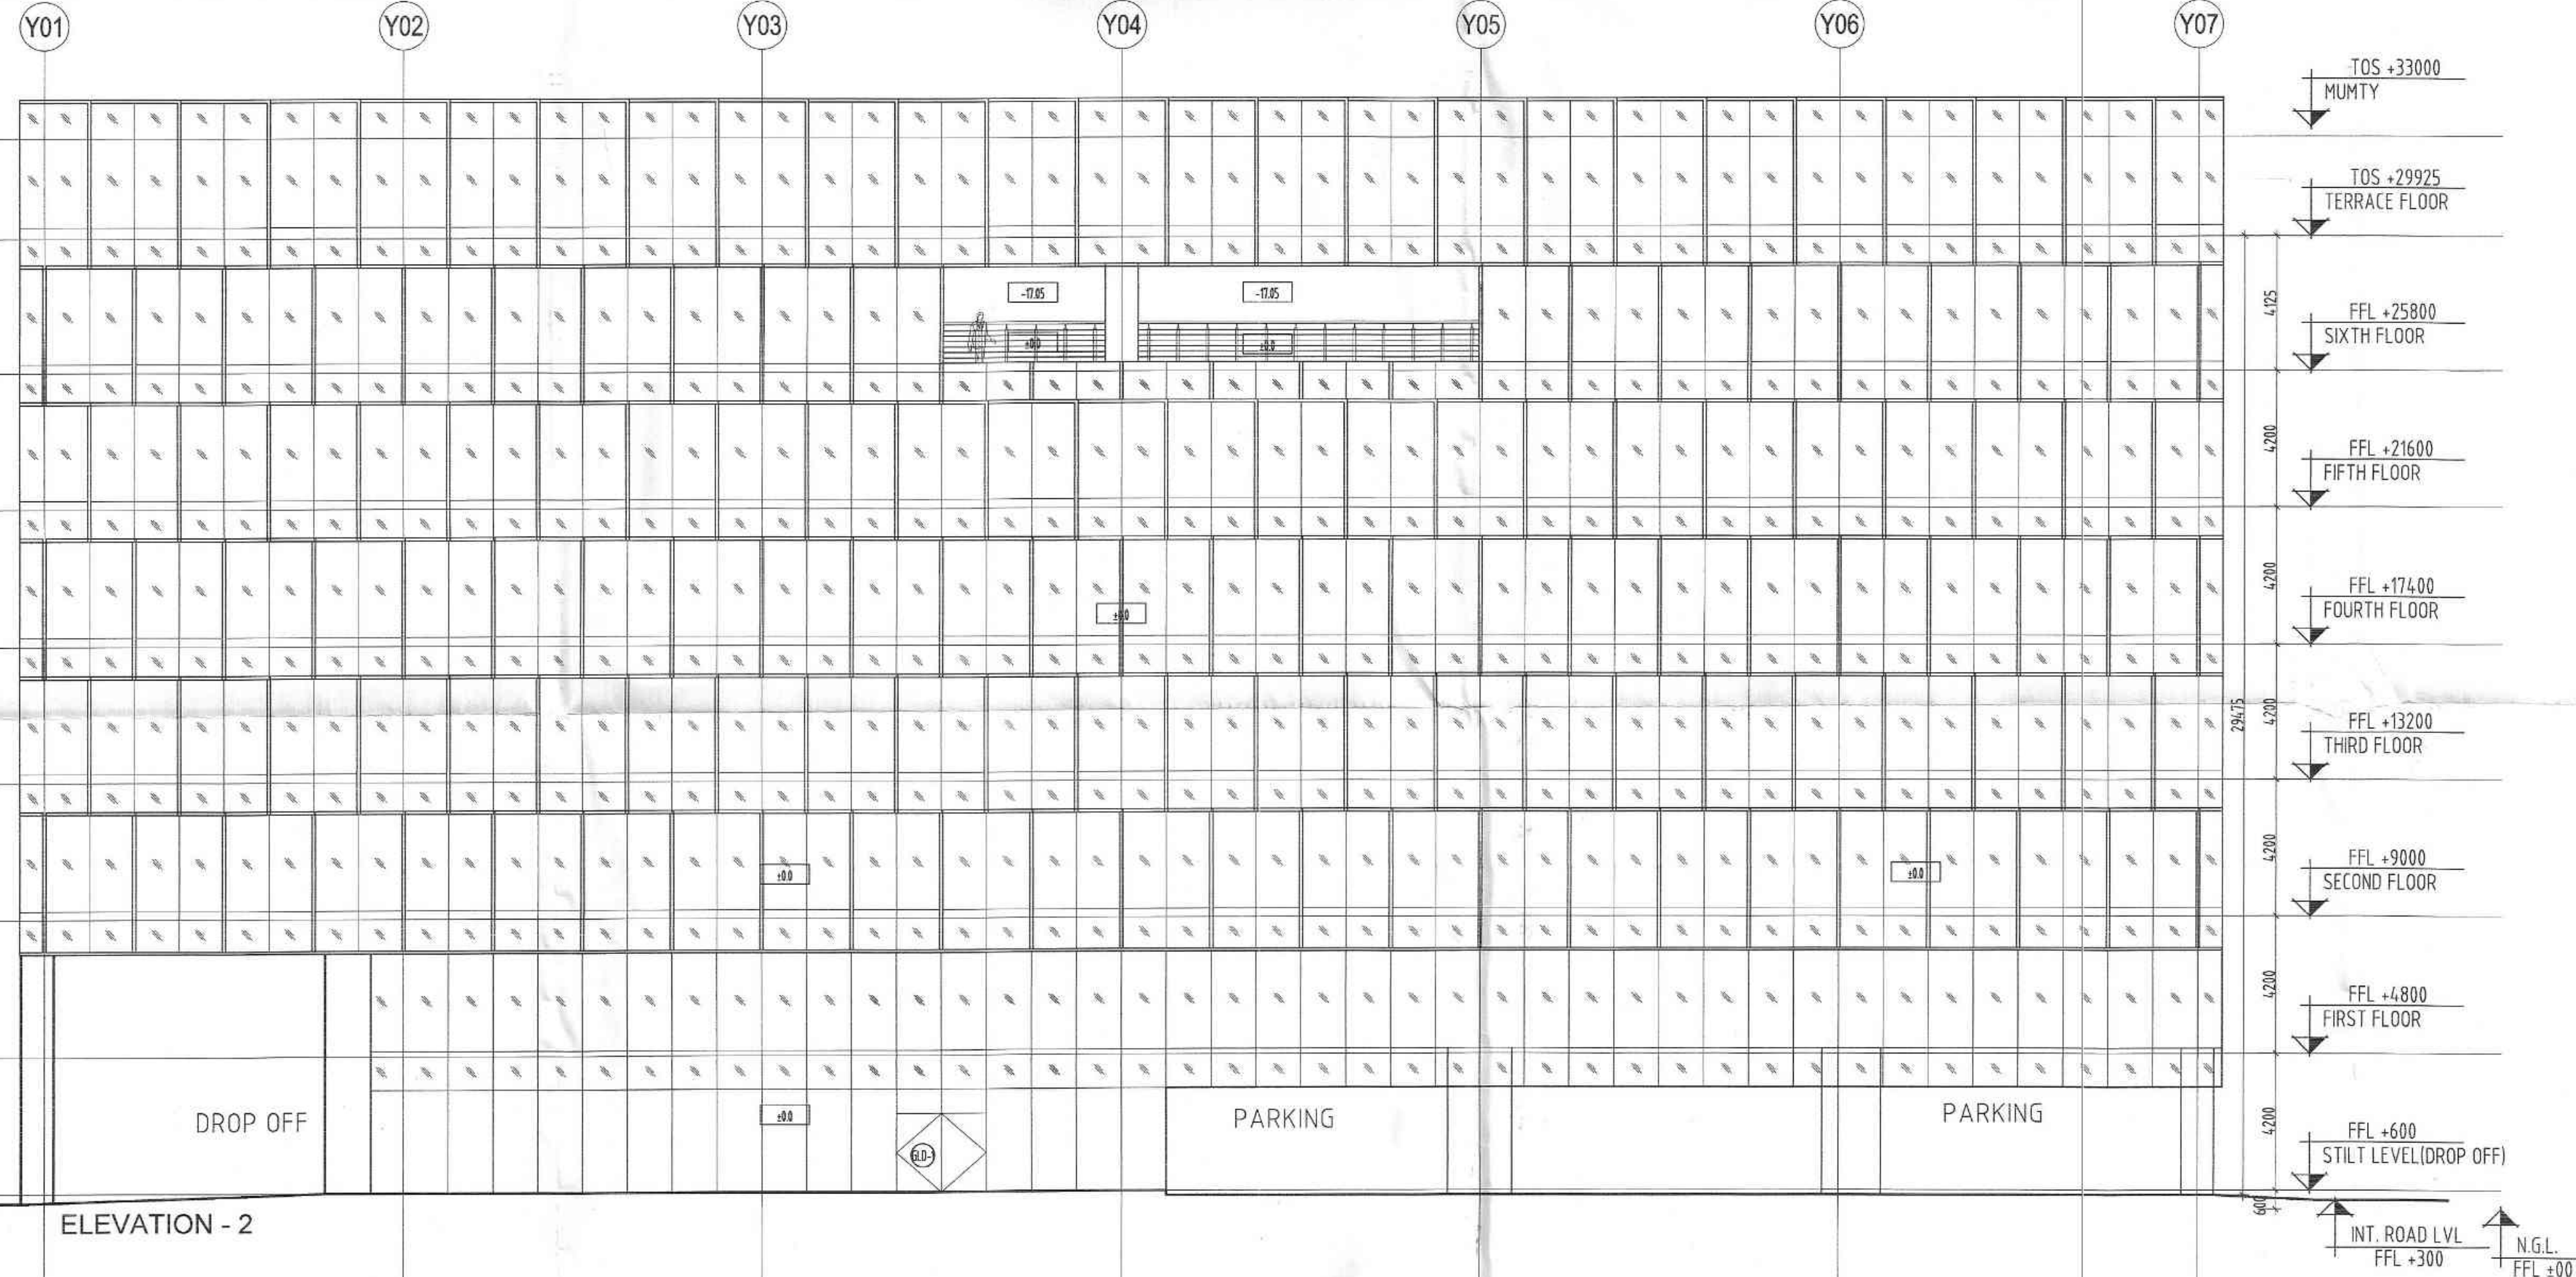

ELEVATION - 2

SHEET NO.- A/09

BLOCK - "A"
(STILT + 6)

SUBMISSION DRAWING

SHEET TITLE

ELEVATION 1 & 2

OWNER:

URVASI INFRATECH PVT. LTD.

THROUGH :

AUTHORISED SIGNATORY

CONSULTANT

R.N.Gupta & Associates
Consulting Engineers, Architects & Valuers
E - 1, Sector-55, Noida
Phones - (+120) 4321556
email-info@rngcorp.com

PROJECT : PROPOSED I.T. SEZ PARK,
NOIDA
PLOT NO - 01, SECTOR - 143 A
GAUTAM BUDDHA NAGAR , NOIDA (U.P)

SCALE 1:100 DATE 26-03-2021

ARCHITECT'S SIGNATURE

OWNER'S SIGNATURE

Map for proposed Building is as per Eys
Lands submitted for approval Please.

PC/12-720/720/26-11-21

Map for proposed Building is as per Eys
Lands submitted for approval Please.

PC/12-720/720/26-11-21

SHEET NO.- A/10

BLOCK - "A"
(STILT + 6)

BC/1720/720/26-11-21

As per proposed Building is as per D/S
And submitted for approval Please.

PL Asst. Archt. Archt.

X08

X07

X06


X05

X04

X03

X02

X01

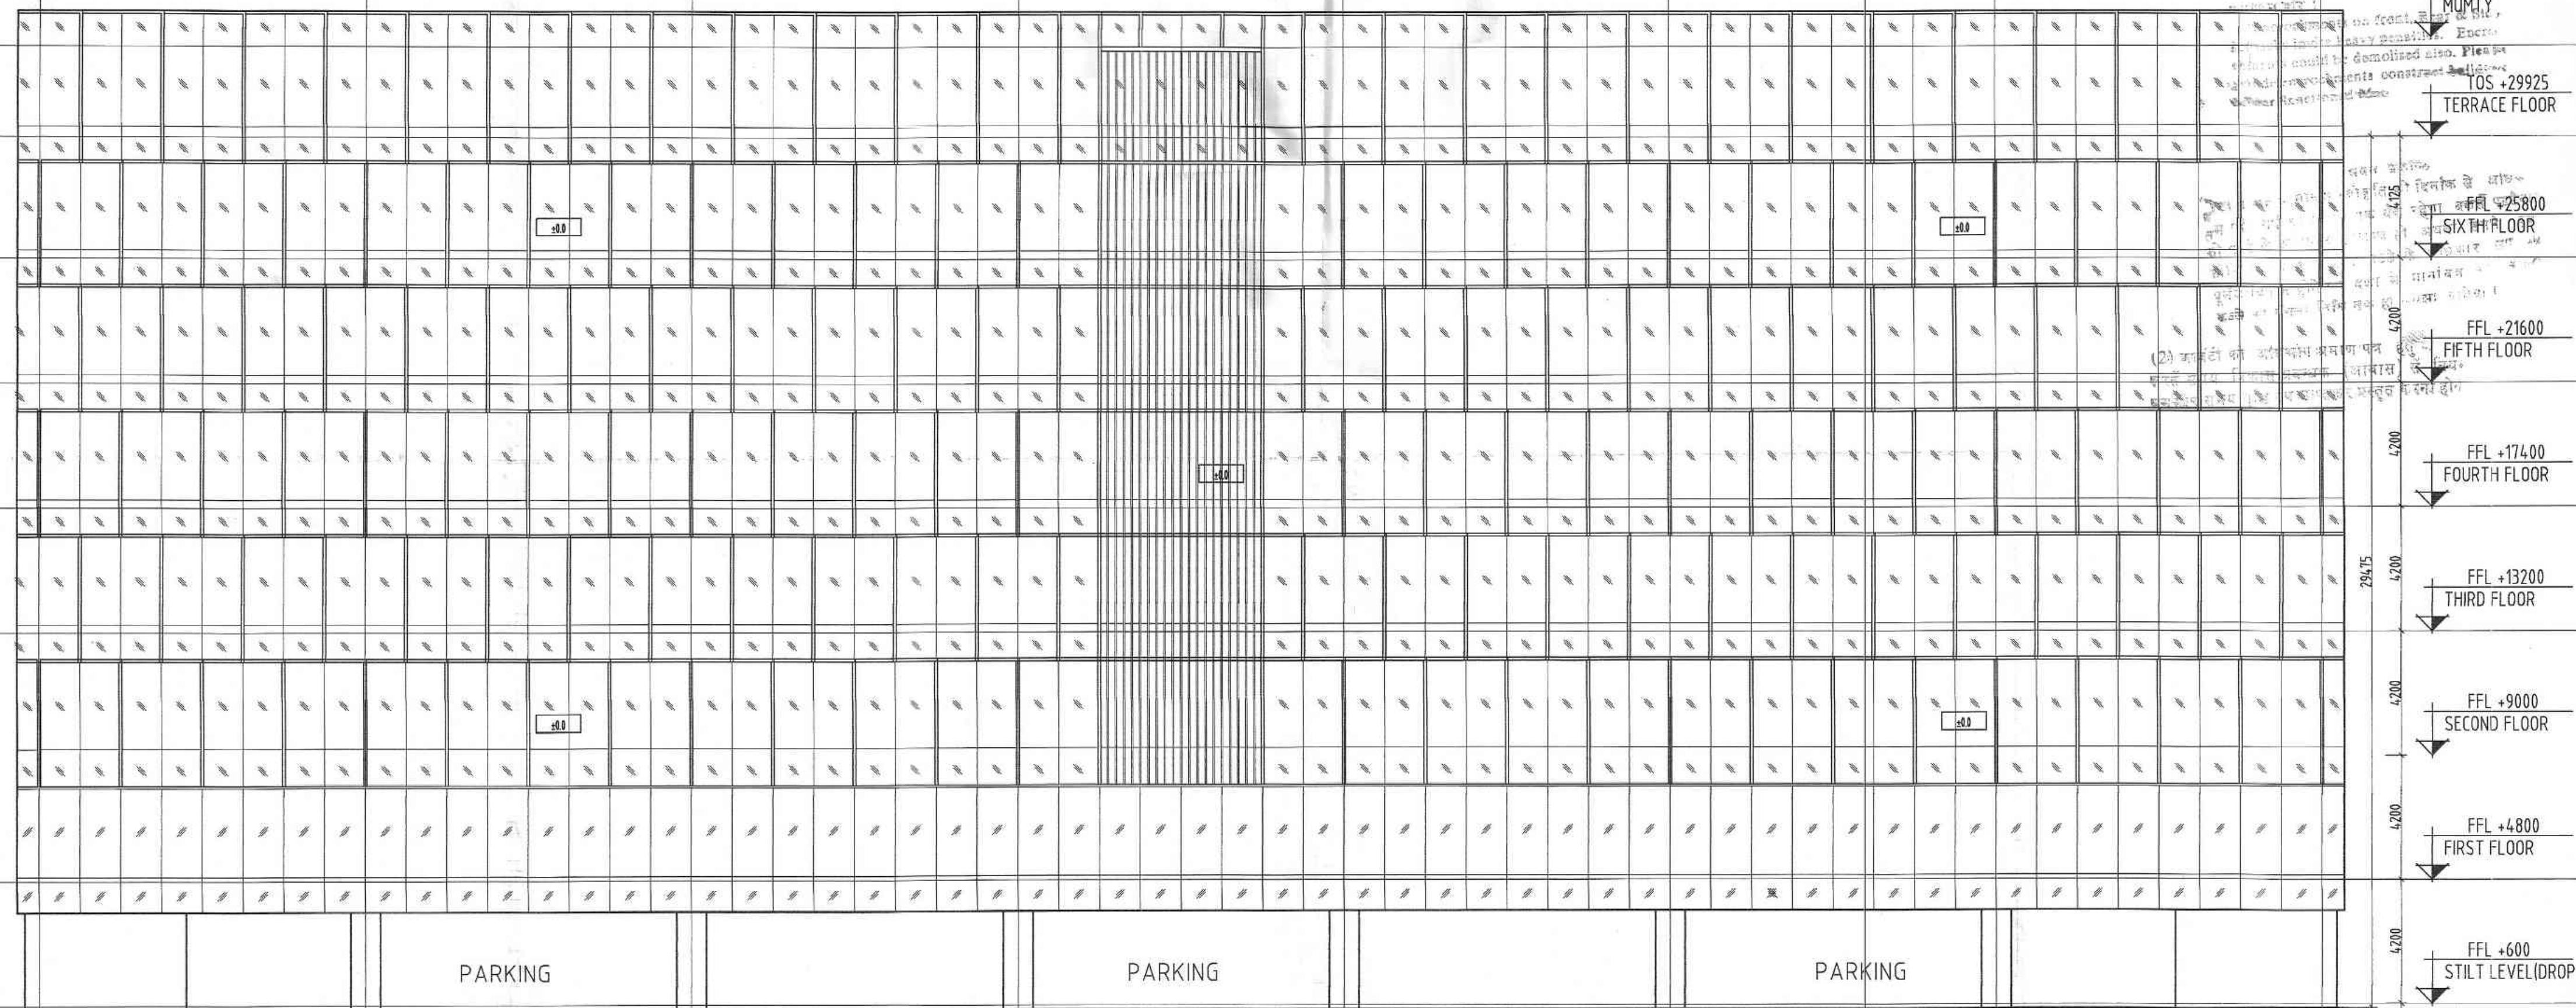

ELEVATION - 3

Y07

Y06


Y05

Y04

Y03

Y02

Y01

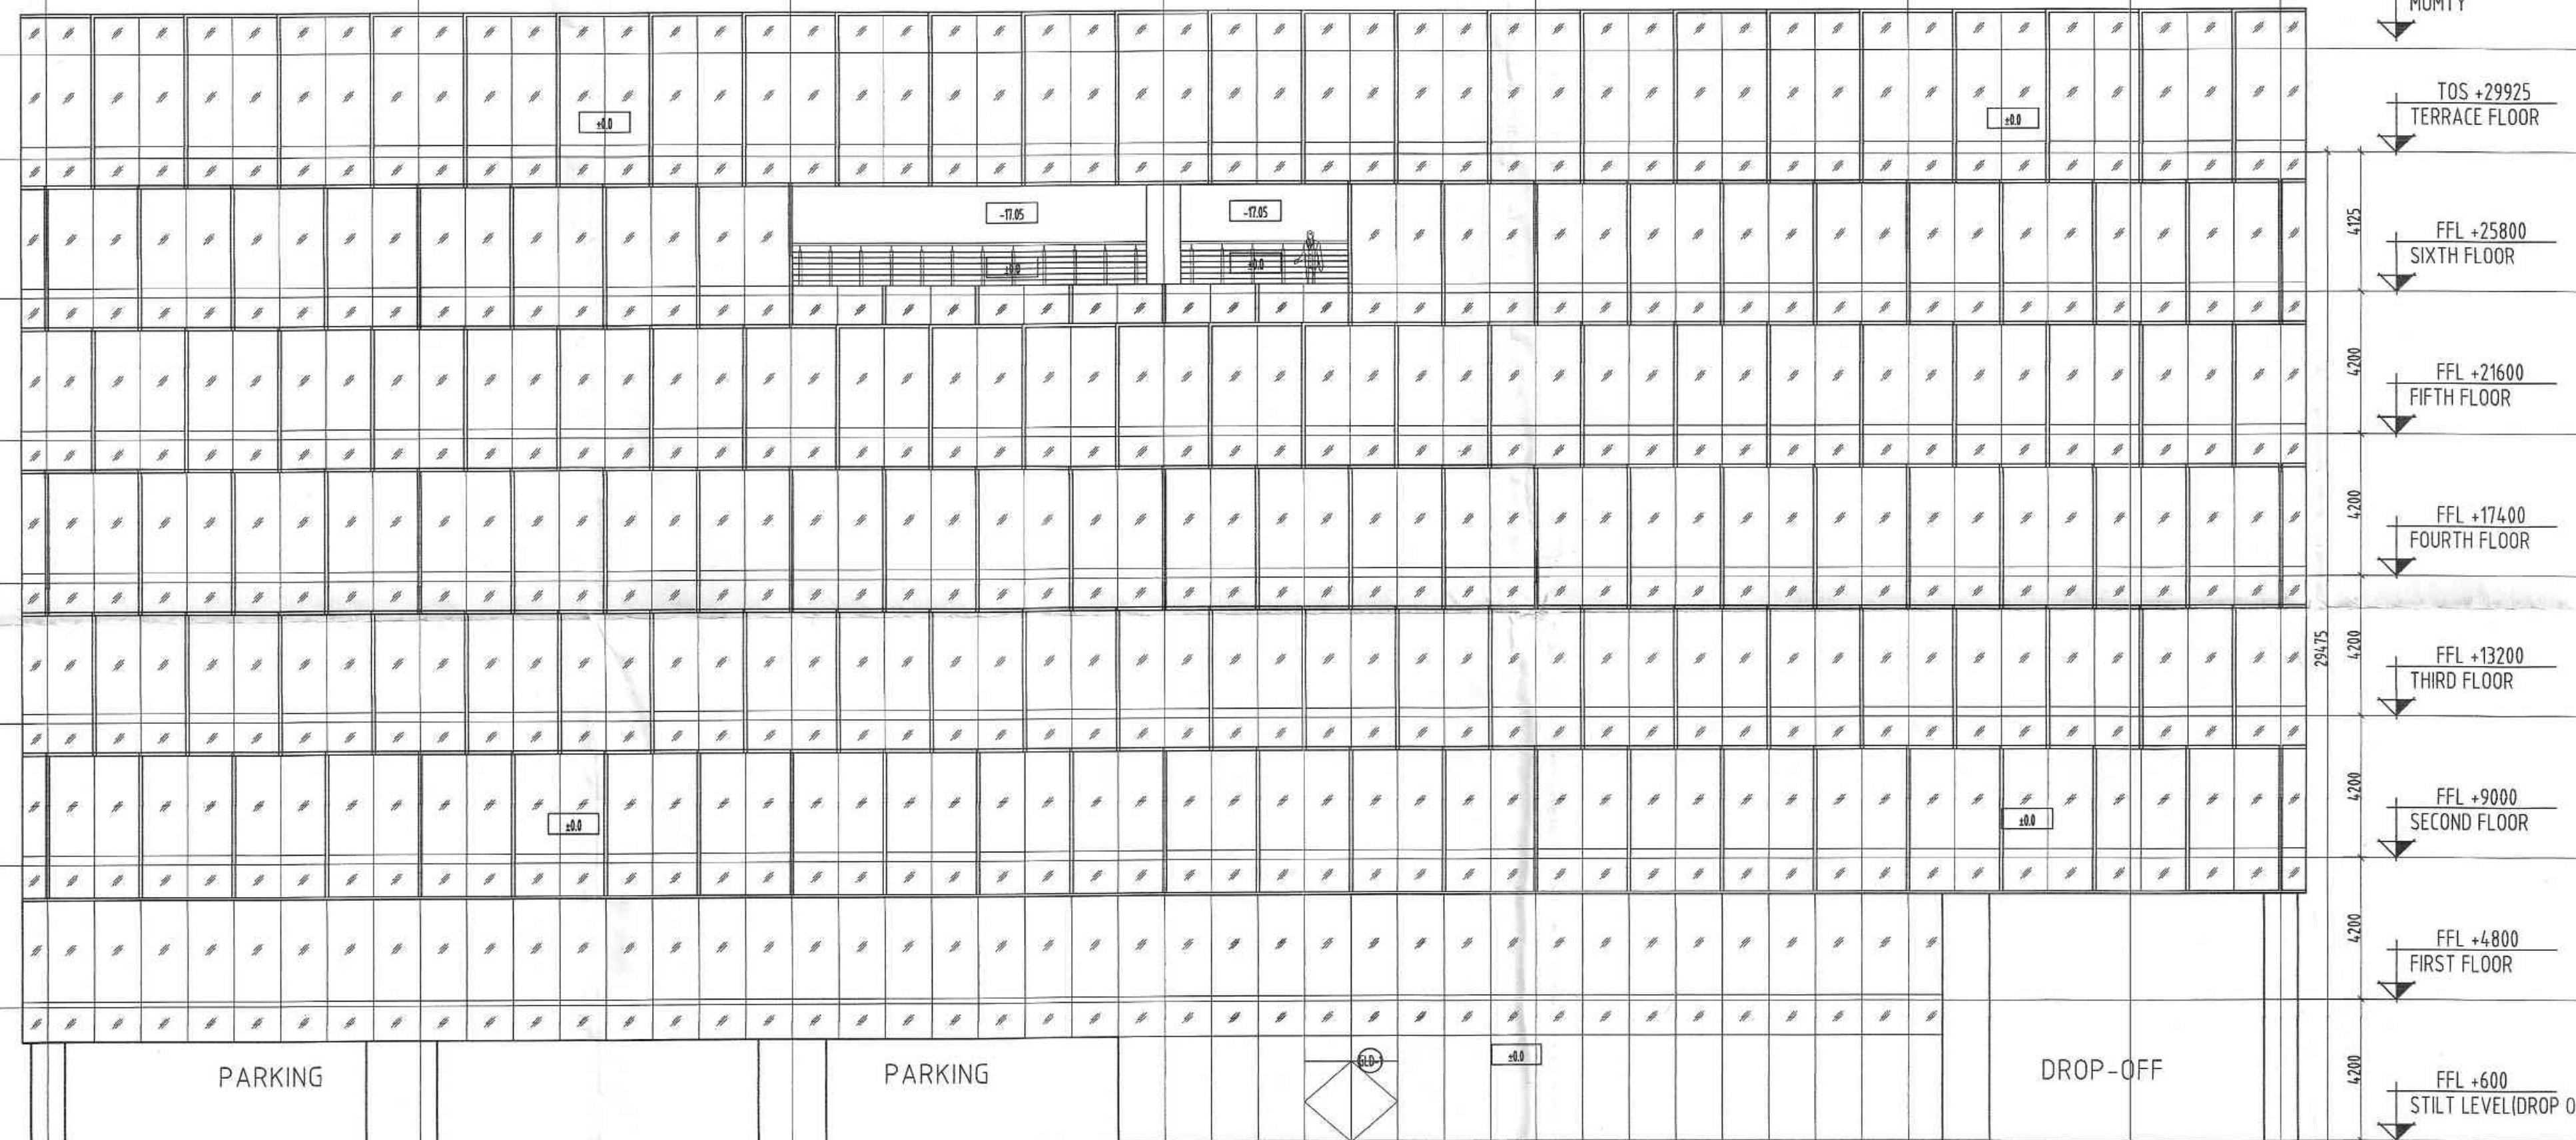

ELEVATION - 4

ELEVATION - 2

SUBMISSION DRAWING

SHEET TITLE

ELEVATION 3 & 4

OWNER:

URVASI INFRATECH PVT. LTD.

THROUGH :

AUTHORISED SIGNATORY

CONSULTANT

R.N.Gupta & Associates
Consulting Engineers, Architects & Valuers
E - 1, Sector-55, Noida
Phones - (+120) 4321556
email - info@rngcorp.com

PROJECT : PROPOSED I.T. SEZ PARK,
NOIDA

PLOT NO - 01, SECTOR - 143 A
GAUTAM BUDDHA NAGAR, NOIDA (U.P.)

SCALE 1:100

DATE 26-03-2021

ARCHITECT'S SIGNATURE

OWNER'S SIGNATURE



SHEET NO.- A/07
BLOCK - "A" (STILT + 6)

SHEET NO.- A/07
BLOCK - "A" (STILT + 6)

[illegible]


१. राजा का नाम क्या है ?	राजा रामचन्द्र
२. राजा का राज्य कहाँ है ?	मिथिला
३. राजा का नाम क्या है ?	राजा रामचन्द्र
४. राजा का राज्य कहाँ है ?	मिथिला
५. राजा का नाम क्या है ?	राजा रामचन्द्र
६. राजा का राज्य कहाँ है ?	मिथिला
७. राजा का नाम क्या है ?	राजा रामचन्द्र
८. राजा का राज्य कहाँ है ?	मिथिला
९. राजा का नाम क्या है ?	राजा रामचन्द्र
१०. राजा का राज्य कहाँ है ?	मिथिला

Floor plan of the second floor showing three rooms:

- MUMTY** (Left): Dimensions 1524 mm HIGH PARAPET (top), 1524 mm HIGH PARAPET (bottom), 1524 mm HIGH PARAPET (left), 1524 mm HIGH PARAPET (right).
- MACHINE ROOM** (Center): Dimensions 1524 mm HIGH PARAPET (top), 1524 mm HIGH PARAPET (bottom).
- MUMTY** (Right): Dimensions 1524 mm HIGH PARAPET (top), 1524 mm HIGH PARAPET (bottom), 1524 mm HIGH PARAPET (left), 1524 mm HIGH PARAPET (right).

(2) आबतों को क्षीयमान प्रमाण पत्र देना बंद करके समय विनाश प्रवणक (आबात) से निवृत्त मतदार समय कुटिल प्रमाण प्रस्तुत न हो।

OVER HEAD TANK AREA DETAIL							
LEGEND	BREADTH (B)	AREA		NOS.	TOTAL AREA	SPACE USGAE	
A	7.100	9.850	X	2	= 139.870	SQM	
TOTAL AREA					=	139.870	SQM

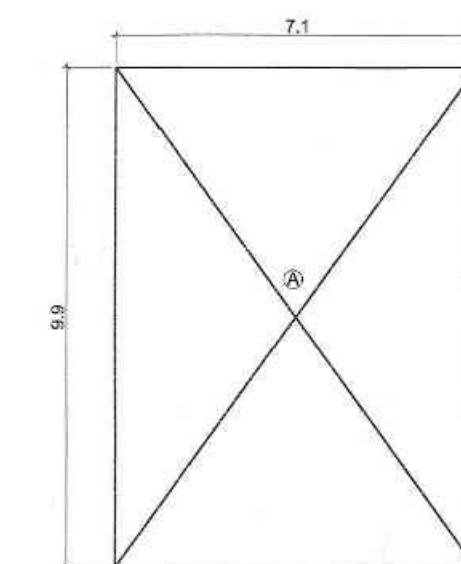

O.H. TANK AREA

SUBMISSION DRAWING

SHEET TITLE	
-------------	--

MACHINE ROOM / MUMTY LEVEL PLAN

OWNER:

URVASI INFRATECH PVT. LTD.

THROUGH : AUTHORISED SIGNATORY

CONSULTANT

R.N.Gupta & Associates
Consulting Engineers, Architects & Valuers
E - 1, Sector-55, Noida
Phones - (+120) 4321556
email-info@rngcorp.com

PROJECT :	
-----------	--


PROPOSED I.T. SEZ PARK, NOIDA
PLOT NO - 01, SECTOR - 143 A
GAUTAM BUDDHA NAGAR , NOIDA (U.P)



SCALE 1:100	DATE 26 - 03 - 2021
-------------	---------------------

SCALE 1:100	DATE 26 - 03 - 2021
-------------	---------------------

ARCHITECT'S SIGNATURE _____


OWNER'S SIGNATURE _____

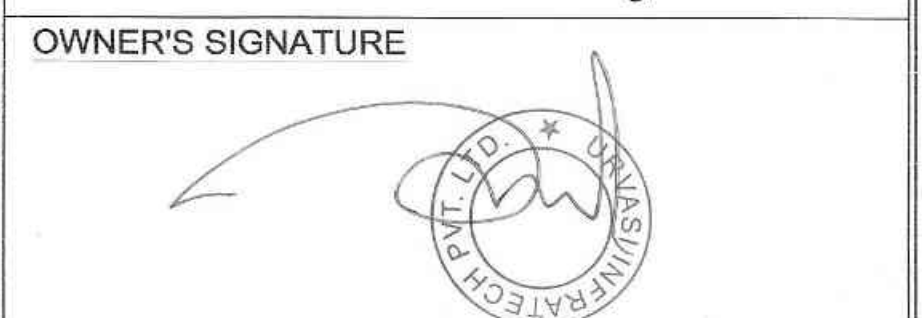

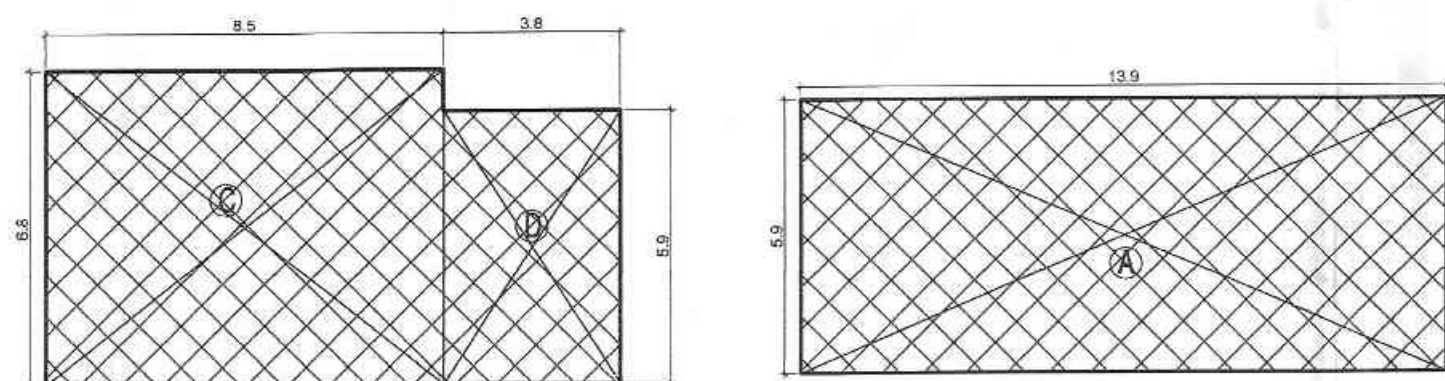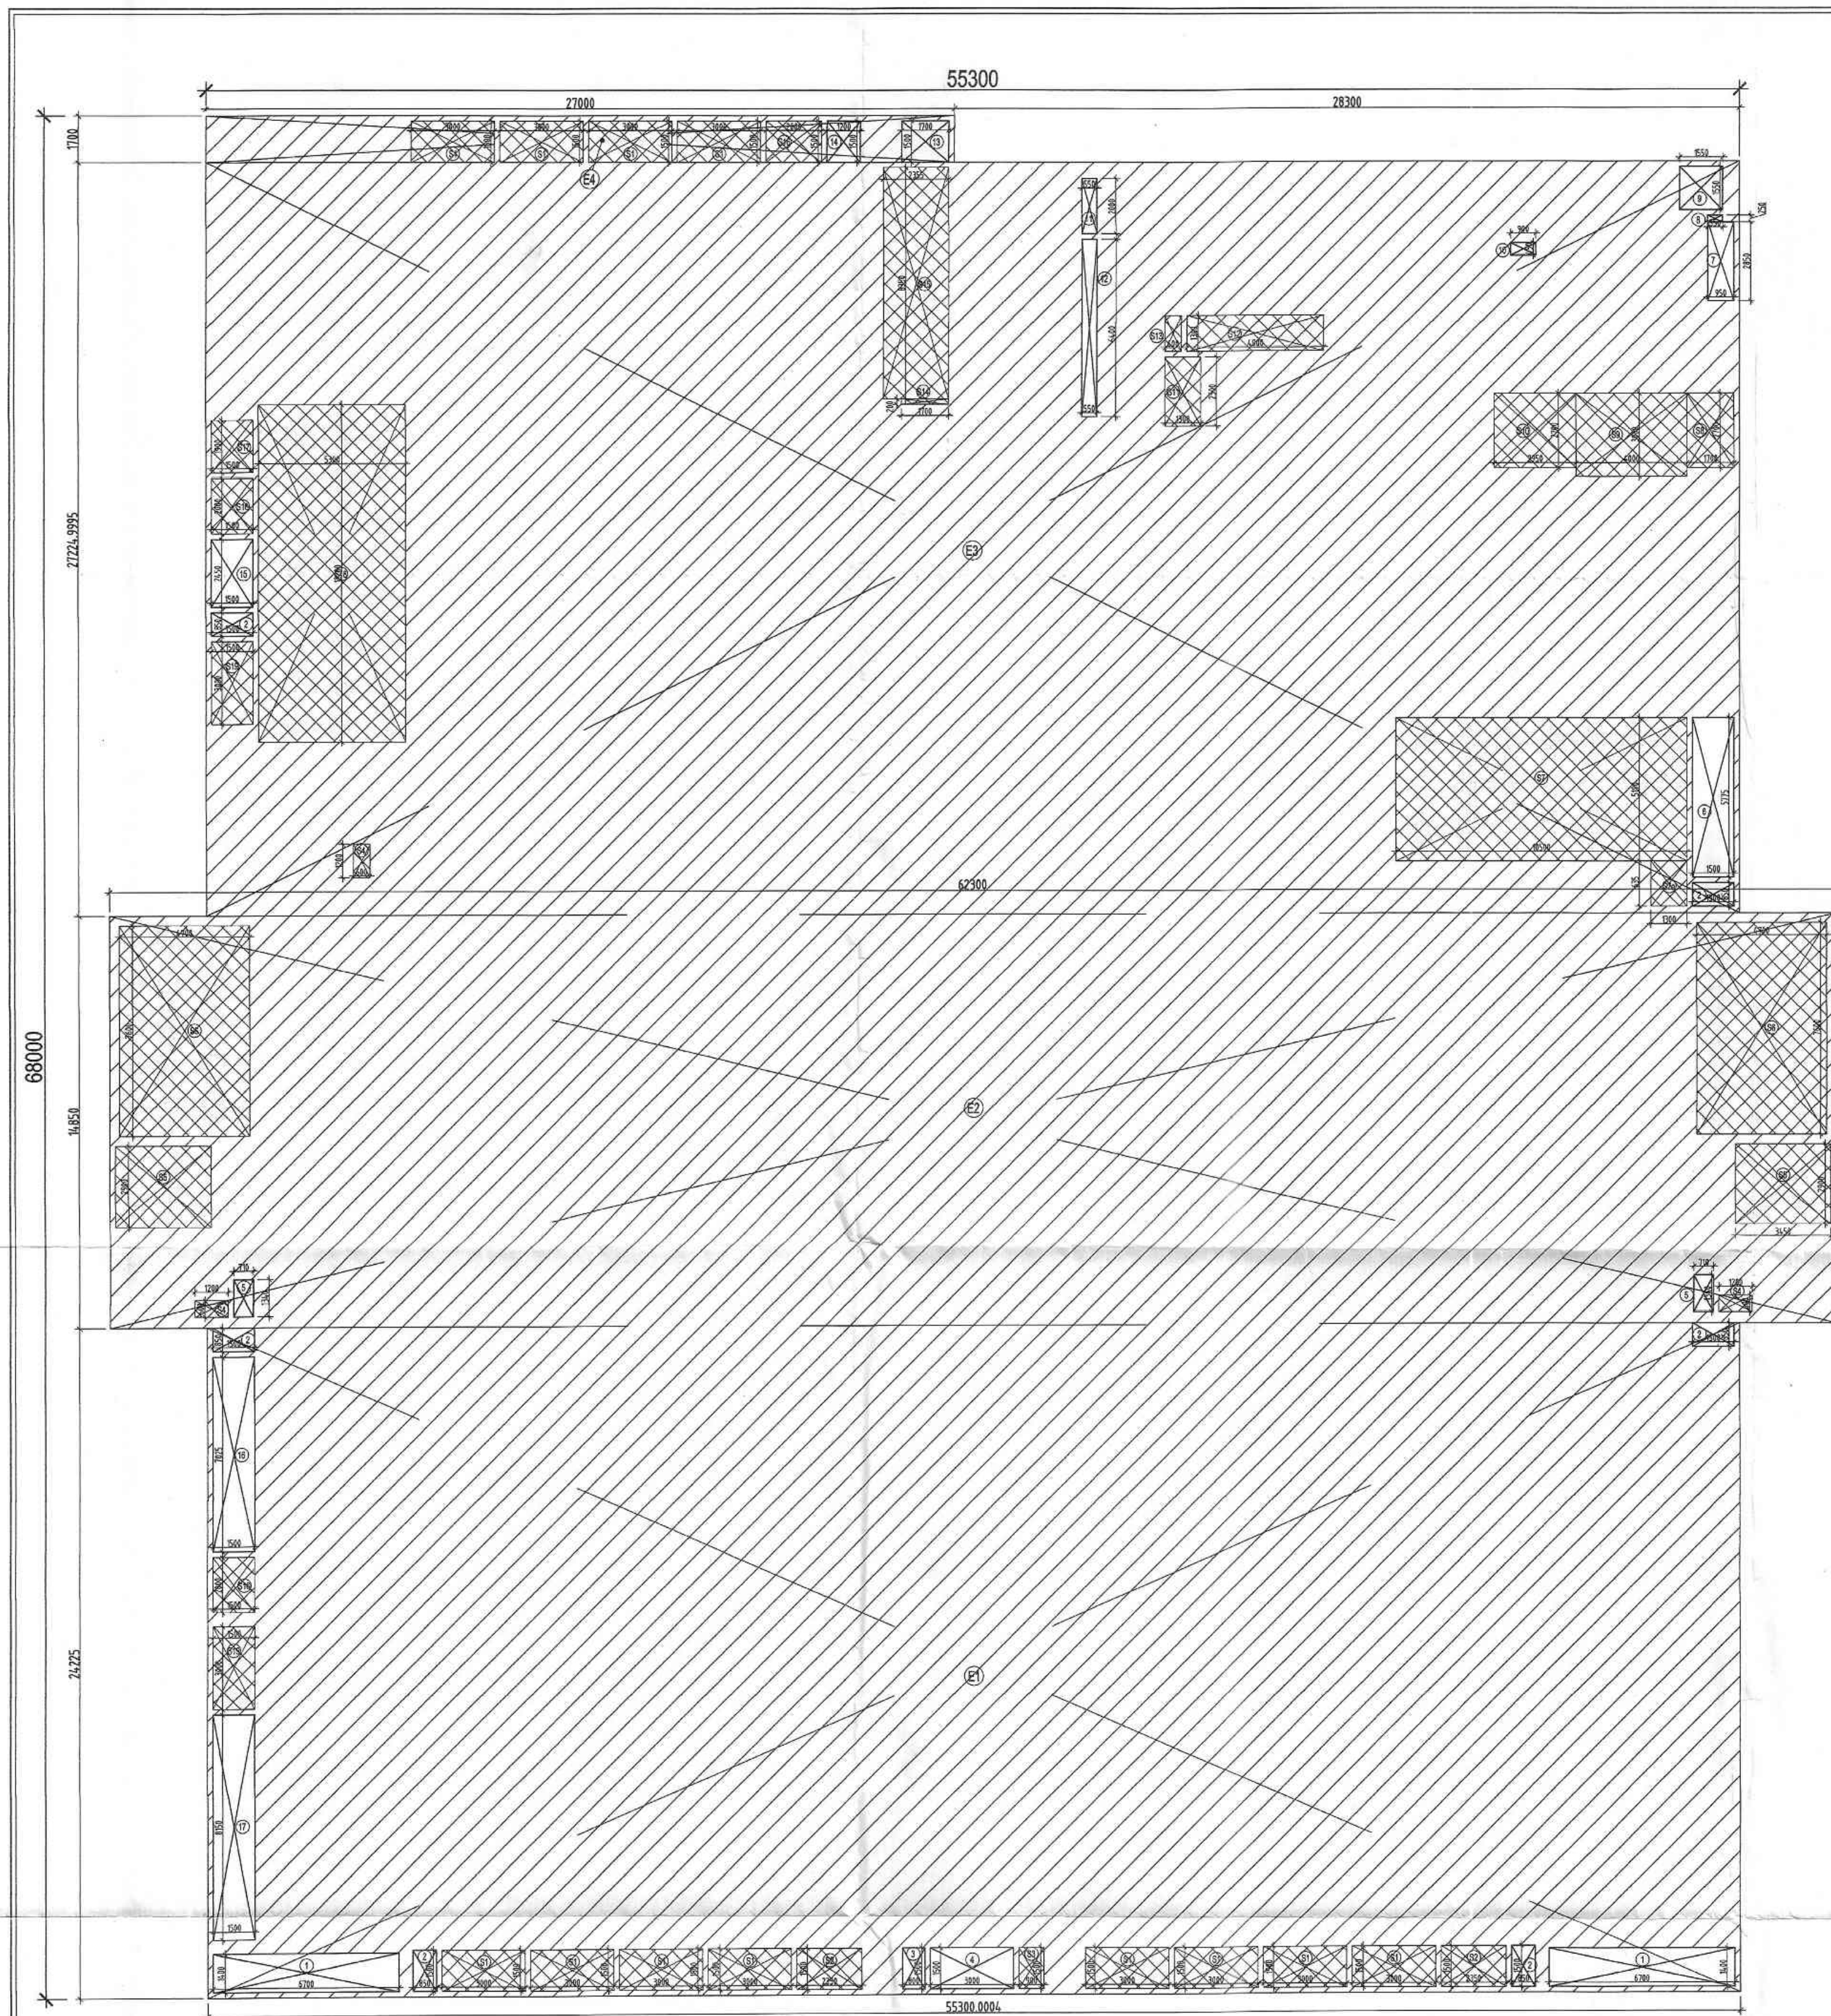

ADDITIONAL SERVICES					
A	13.90	X	5.90	X	1 = 82.010
C	8.550	X	6.800	X	1 = 58.140
D	3.800	X	5.900	X	1 = 22.430
F1	15.325	X	23.145	X	1 = 354.697
F2	6.600	X	9.680	X	1 = 63.888
G	14.300	X	18.900	X	1 = 270.270
TOTAL SERVICES					= 851.425
NET SERVICES (III) + (IV)					= 1204.525

GROUND FLOOR PLAN AREA DETAIL						
LEGEND	BREADTH (B)	LENGTH (L)	NOS.	AREA IN SQM	SPACE USGAE	
E1	55.300	X	24.225	X 1 =	1339.643	
E2	62.300	X	14.850	X 1 =	925.155	
E3	55.300	X	27.225	X 1 =	1505.543	
E4	27.000	X	1.700	X 1 =	45.9	
ENVELOPE AREA				=	3816.241	(I)
CUTOUTS						
1	6.700	X	1.400	X 2 =	18.760	DATA / MEP SHAFT
2	0.850	X	1.500	X 6 =	7.650	PL. SHAFT
3	0.800	X	1.500	X 1 =	1.200	PL. SHAFT
4	3.000	X	1.500	X 1 =	4.500	INERGEN PIPE SHAFT
5	0.710	X	1.340	X 2 =	1.903	LIFT LOBBY PRESS. SHAFT
6	1.500	X	5.775	X 1 =	8.683	HVAC SHAFT
7	0.950	X	2.850	X 1 =	2.708	VENT. SHAFT
8	0.550	X	0.250	X 1 =	0.138	VENT. SHAFT
9	1.550	X	1.550	X 1 =	2.403	PL. SHAFT
10	0.900	X	0.450	X 1 =	0.405	PL. SHAFT
11	0.550	X	2.000	X 1 =	1.100	STAIRCASE PRESS. SHAFT
12	0.550	X	6.400	X 1 =	3.520	SHAFT
13	1.700	X	1.500	X 1 =	2.550	LIFT LOBBY PRESS. SHAFT
14	1.200	X	1.500	X 1 =	1.800	PL. SHAFT
15	1.500	X	2.450	X 1 =	3.675	HVAC SHAFT
16	1.500	X	7.025	X 1 =	10.538	HVAC SHAFT
17	1.500	X	8.150	X 1 =	12.225	SHAFT
TOTAL CUTOUTS				=	83.738	(II)
SERVICES						
S1	3.000	X	1.500	X 12 =	54.000	ELE. SHAFT
S2	2.350	X	1.500	X 2 =	7.050	ELE. / ELV. SHAFT
S3	0.900	X	1.500	X 1 =	1.350	FHC
S4	1.200	X	0.600	X 3 =	2.160	FHC
S5	3.450	X	2.900	X 2 =	20.010	F. LIFT LOBBY
S6	4.700	X	7.600	X 1 =	35.720	FIRE STAIRCASE
S7	10.500	X	5.190	X 1 =	54.495	FIRE CONTROL RM.
S7a	1.300	X	1.635	X 1 =	2.126	FIRE CONTROL RM.
S8	1.700	X	2.700	X 1 =	4.590	LIFT LOBBY
S9	4.000	X	3.000	X 1 =	12.000	LIFT LOBBY
S10	2.950	X	2.700	X 1 =	7.965	LIFT LOBBY
S11	1.300	X	2.500	X 1 =	3.250	ELECTRICAL PANEL
S12	4.900	X	1.300	X 1 =	6.370	ELE. SHAFT
S13	0.600	X	1.300	X 1 =	0.780	FHC
S14	1.700	X	0.200	X 1 =	0.340	FR. LIFT LOBBY
S15	2.355	X	8.350	X 1 =	19.664	FR. LIFT LOBBY
S16	2.000	X	1.500	X 3 =	9.000	ELE. / ELV. SHAFT
S17	1.500	X	1.900	X 1 =	2.850	DATA SHAFT
S18	5.300	X	12.200	X 1 =	64.660	ELECTRICAL ROOM
S19	1.500	X	3.000	X 2 =	9.000	ELE. SHAFT
TOTAL SERVICES				=	317.380	(III)
TOTAL F.A.R. AREA ON FLOOR (I) - (II) - (III)				=	3415.123	SQM

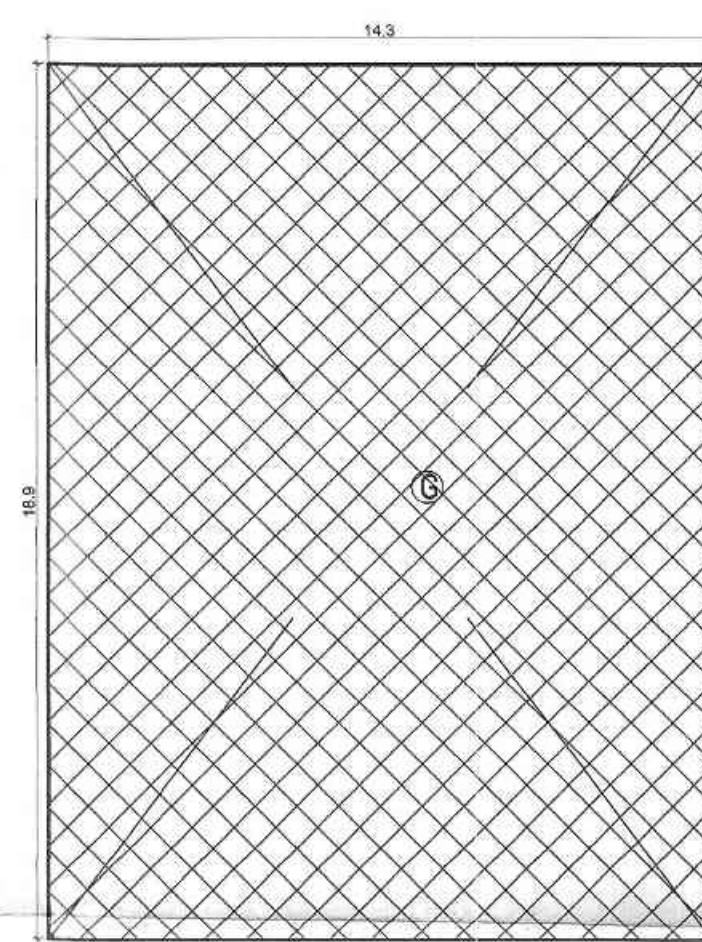

SHEET NO.- B/02A

BLOCK - "A"
(STILT + 6)

130/1720/2011/22

Map for proposed Building is as per Bye Laws submitted for approval. Please.

SUBMISSION DRAWING

SHEET TITLE

GROUND FLOOR AREA DETAIL

OWNER:

URVASI INFRATECH PVT. LTD.

THROUGH: AUTHORISED SIGNATORY

CONSULTANT

R.N.Gupta & Associates
Consulting Engineers, Architects & Valuers
E - 1, Sector-55, Noida
Phones - (+120) 4321556
email-info@rngcorp.com

PROJECT: PROPOSED I.T. SEZ PARK,
NOIDA
PLOT NO - 01, SECTOR - 143 A
GAUTAM BUDDHA NAGAR, NOIDA (U.P.)

SCALE 1:100 DATE 26 - 03 - 2021

ARCHITECT'S SIGNATURE

OWNER'S SIGNATURE



BLOCK - "A"
(STILT + 6)

हमारी
(अवध प्रकोष्ठ)

Pl. Archt. Archt. Archt.






Map for proposed Building is as per Bye
Laws submitted for approval Please.

BLOCK - "A"
(STILT + 6)


हमारी
(अद्वय प्रकोष्ठ)

Pl. Archt. Archt. Archt.



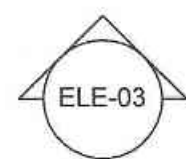

जाबटा का आध्यात्म प्रमाण पत्र धनु -
 तें समय विकास प्रयत्नक (आवास) से निद-
 वसार समय वृद्धि पत्र प्राप्तकर मनुष्य कल्या होय।

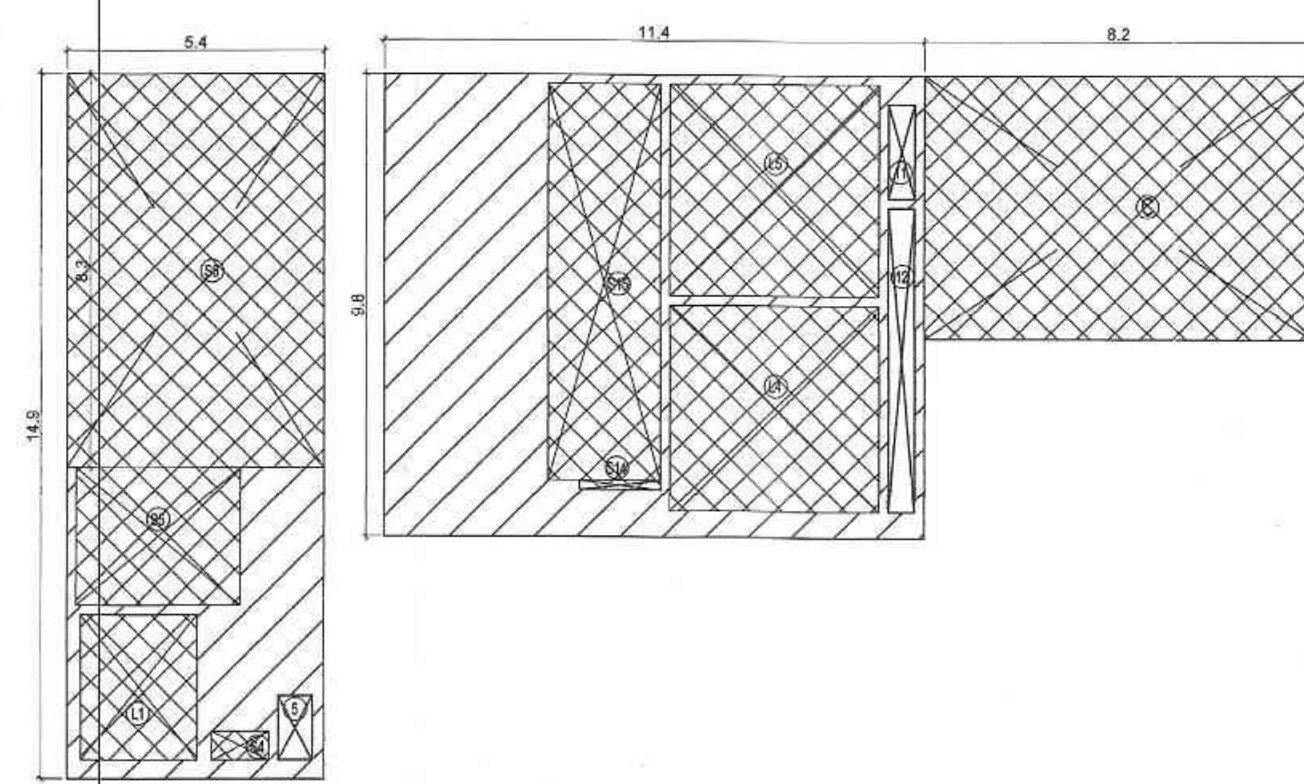

TERRACE AREA DETAIL						
LEGEND	BREADTH (B)	LENGTH (L)	NOS.	AREA IN SQM	SPACE USAGE	
A	5.400	X 14.850	X 2	=	160.380	
B	11.380	X 9.750	X 1	=	110.955	
C	8.150	X 5.550	X 1	=	45.233	
TOTAL AREA				=	316.568	(I)
CUTOUTS						
5	0.710	X 1.340	X 2	=	1.903	LIFT LOBBY PRESS. SHAFT
11	0.550	X 2.000	X 1	=	1.100	STAIRCASE PRESS. SHAFT
12	0.550	X 6.400	X 1	=	3.520	SHAFT
TOTAL CUTOUTS				=	6.523	(II)
SERVICES						
C	8.150	X 5.550	X 1	=	45.233	MUMTY
S5	3.450	X 2.900	X 2	=	20.010	F. LIFT LOBBY
S6	5.400	X 8.300	X 2	=	89.640	MUMTY
S14	1.700	X 0.200	X 1	=	0.340	FR. LIFT LOBBY
S15	2.355	X 8.350	X 1	=	19.664	FR. LIFT LOBBY
L1	2.450	X 3.050	X 2	=	14.945	FIRE LIFT
L4	4.400	X 4.350	X 1	=	19.140	FR. LIFT
L5	4.400	X 4.450	X 1	=	19.580	FR. LIFT
TOTAL SERVICES				=	228.552	(III)
TOTAL F.A.R AREA ON FLOOR (I) - (II) - (III)				=	81.493	SQM

MUMTY & LIFT LOBBY AREA

Map for proposed Building is as per Bye
Laws submitted for approval Please.

Bar
Pl. Asstt.

[Signature]
Asstt. Arch



[Signature]
Architect

OWNER'S SIGNATURE



SHEET NO.- B/09

BLOCK - "A"
(STILT + 6)

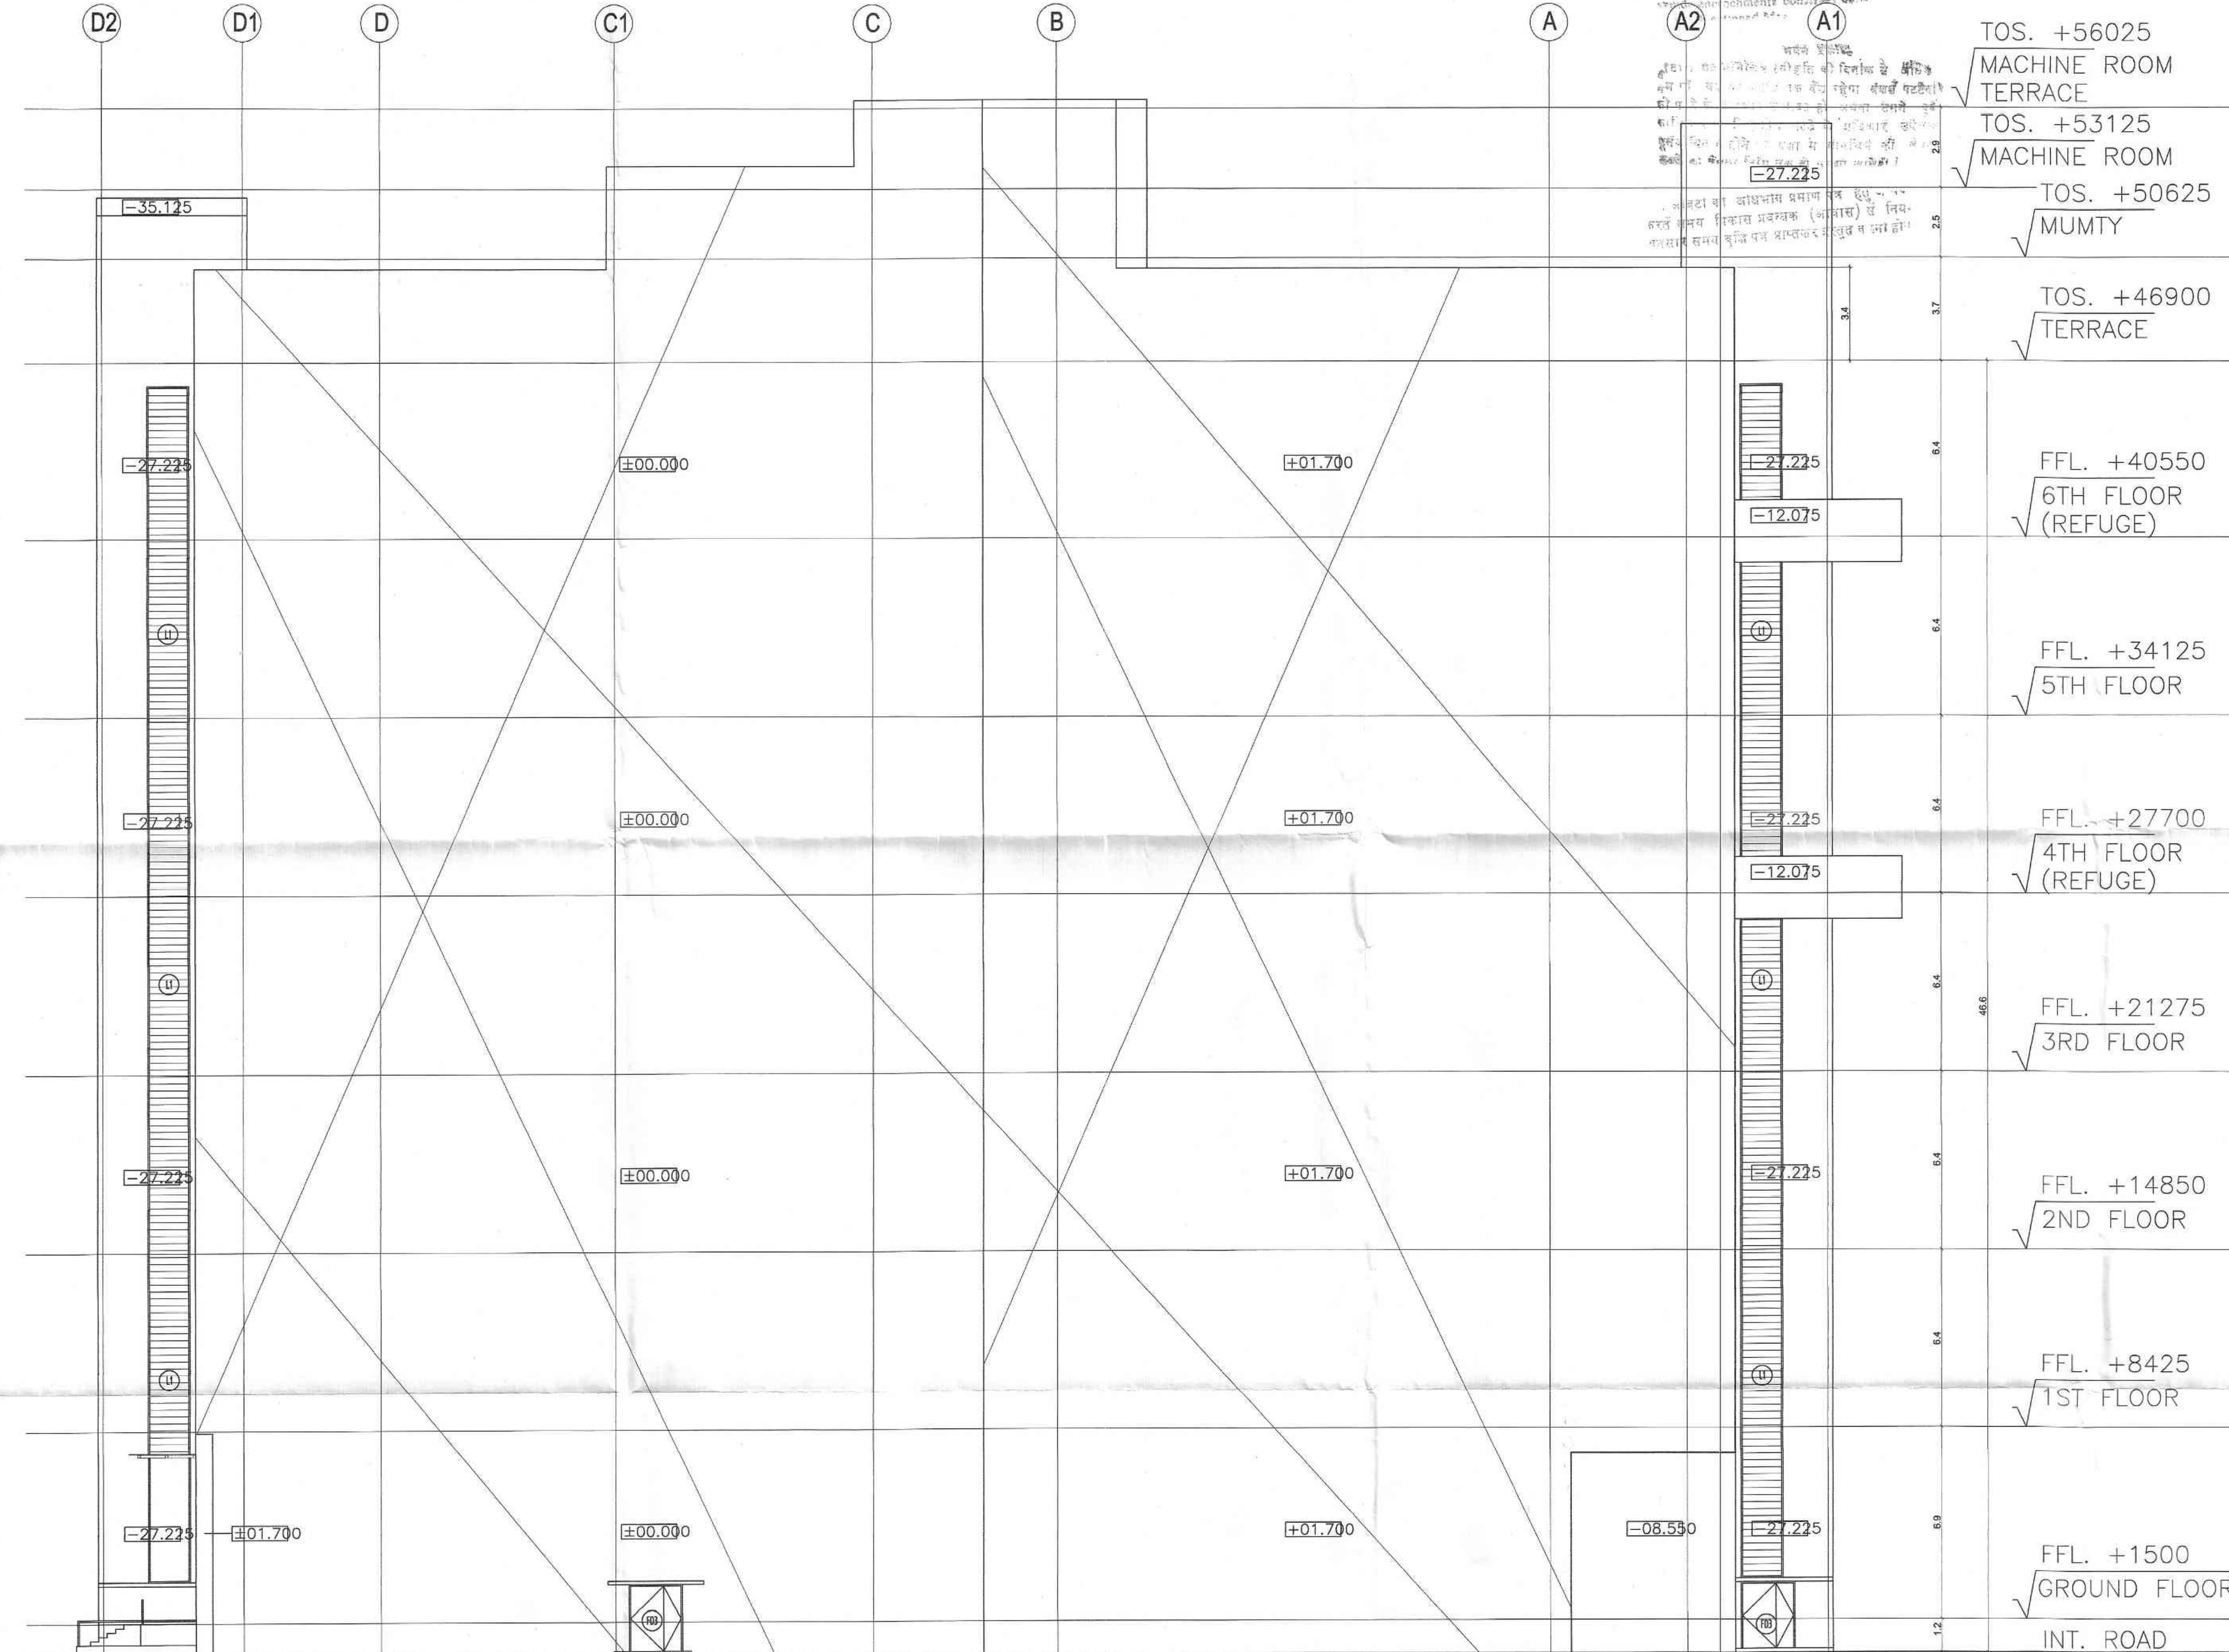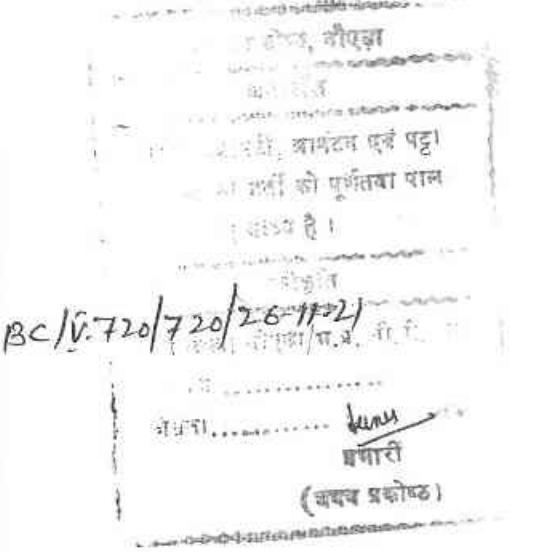

ELEVATION - 01

SUBMISSION DRAWING

SHEET TITLE

ELEVATION - 01

OWNER:

URVASI INFRATECH PVT. LTD.

THROUGH : AUTHORISED SIGNATORY

CONSULTANT

R.N.Gupta & Associates
Consulting Engineers, Architects & Valuers
E - 1, Sector-55, Noida
Phones - (+120) 4321556
email-info@rngcorp.com

PROJECT : PROPOSED I.T. SEZ PARK,
NOIDA
PLOT NO - 01, SECTOR - 143 A
GAUTAM BUDDHA NAGAR, NOIDA (U.P)

SCALE 1:100

DATE 26-03-2021


ARCHITECT'S SIGNATURE

OWNER'S SIGNATURE

BLOCK - "A"
(STILT + 6)

भयम प्रशस्ति, गीतिका
निर्देश-आनंदी, आभयन एवं पट्टा
अनेक की शक्ति की पूर्णता प्राप्त
करने हेतु अग्रिम है।
रजिस्ट्रार
दिनांक 1/12/1971, प. नं. 31, भा.
मैथिली
अभ्यर्थी
(वाचक प्रतीक)

Map for proposed Building is as per Eye
Views submitted for approval Please.

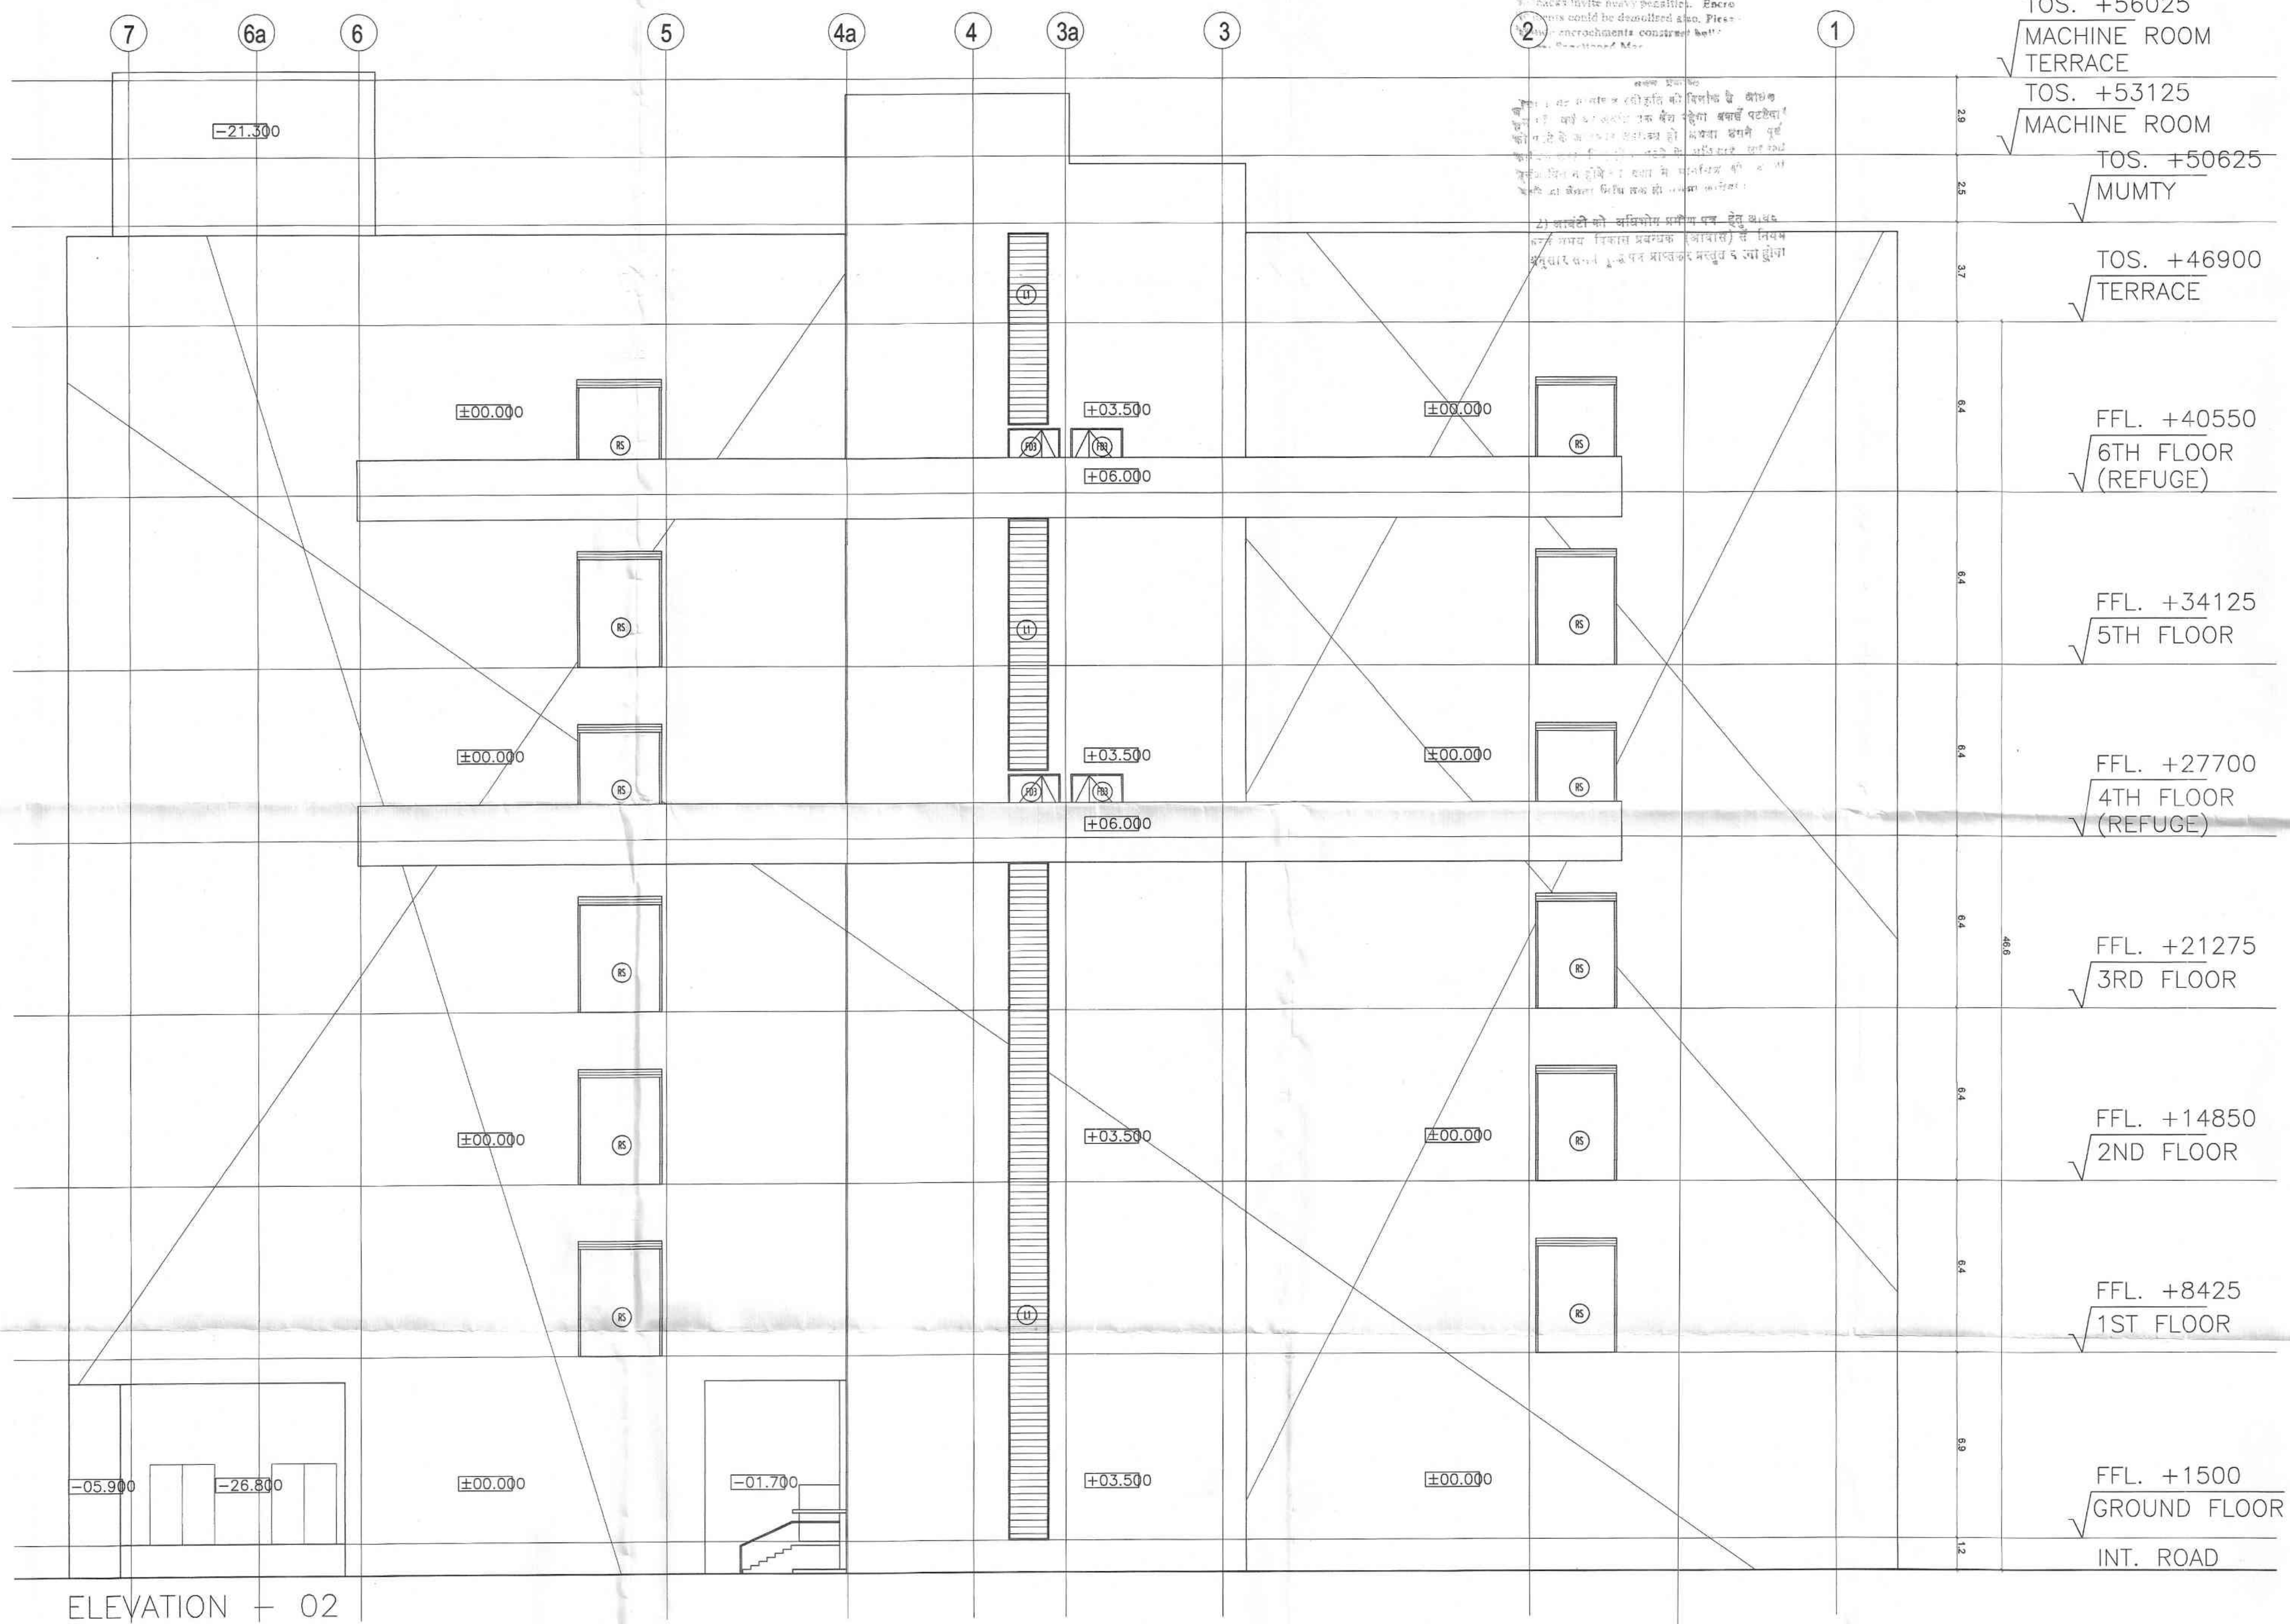

SHEET TITLE

ELEVATION - 02

OWNER:

URVASI INFRATECH PVT. LTD.

THROUGH : AUTHORISED SIGNATORY

CONSULTANT

R.N.Gupta & Associates
Consulting Engineers, Architects & Valuers
E - 1, Sector-55, Noida
Phones - (+120) 4321556
email-info@rngcorp.com

PROJECT : PROPOSED I.T. SEZ PARK,
NOIDA
PLOT NO - 01, SECTOR - 143 A
GAUTAM BUDDHA NAGAR , NOIDA (U.P)

SCALE	1:100	DATE	26 - 03 - 2021
-------	-------	------	----------------

ARCHITECT'S SIGNATURE

OWNER'S SIGNATURE




BLOCK - "A"
(STILT + 6)

Map for proposed Building is as per Dya
Laws submitted for approval. Please.



SHEET NO.- B/12

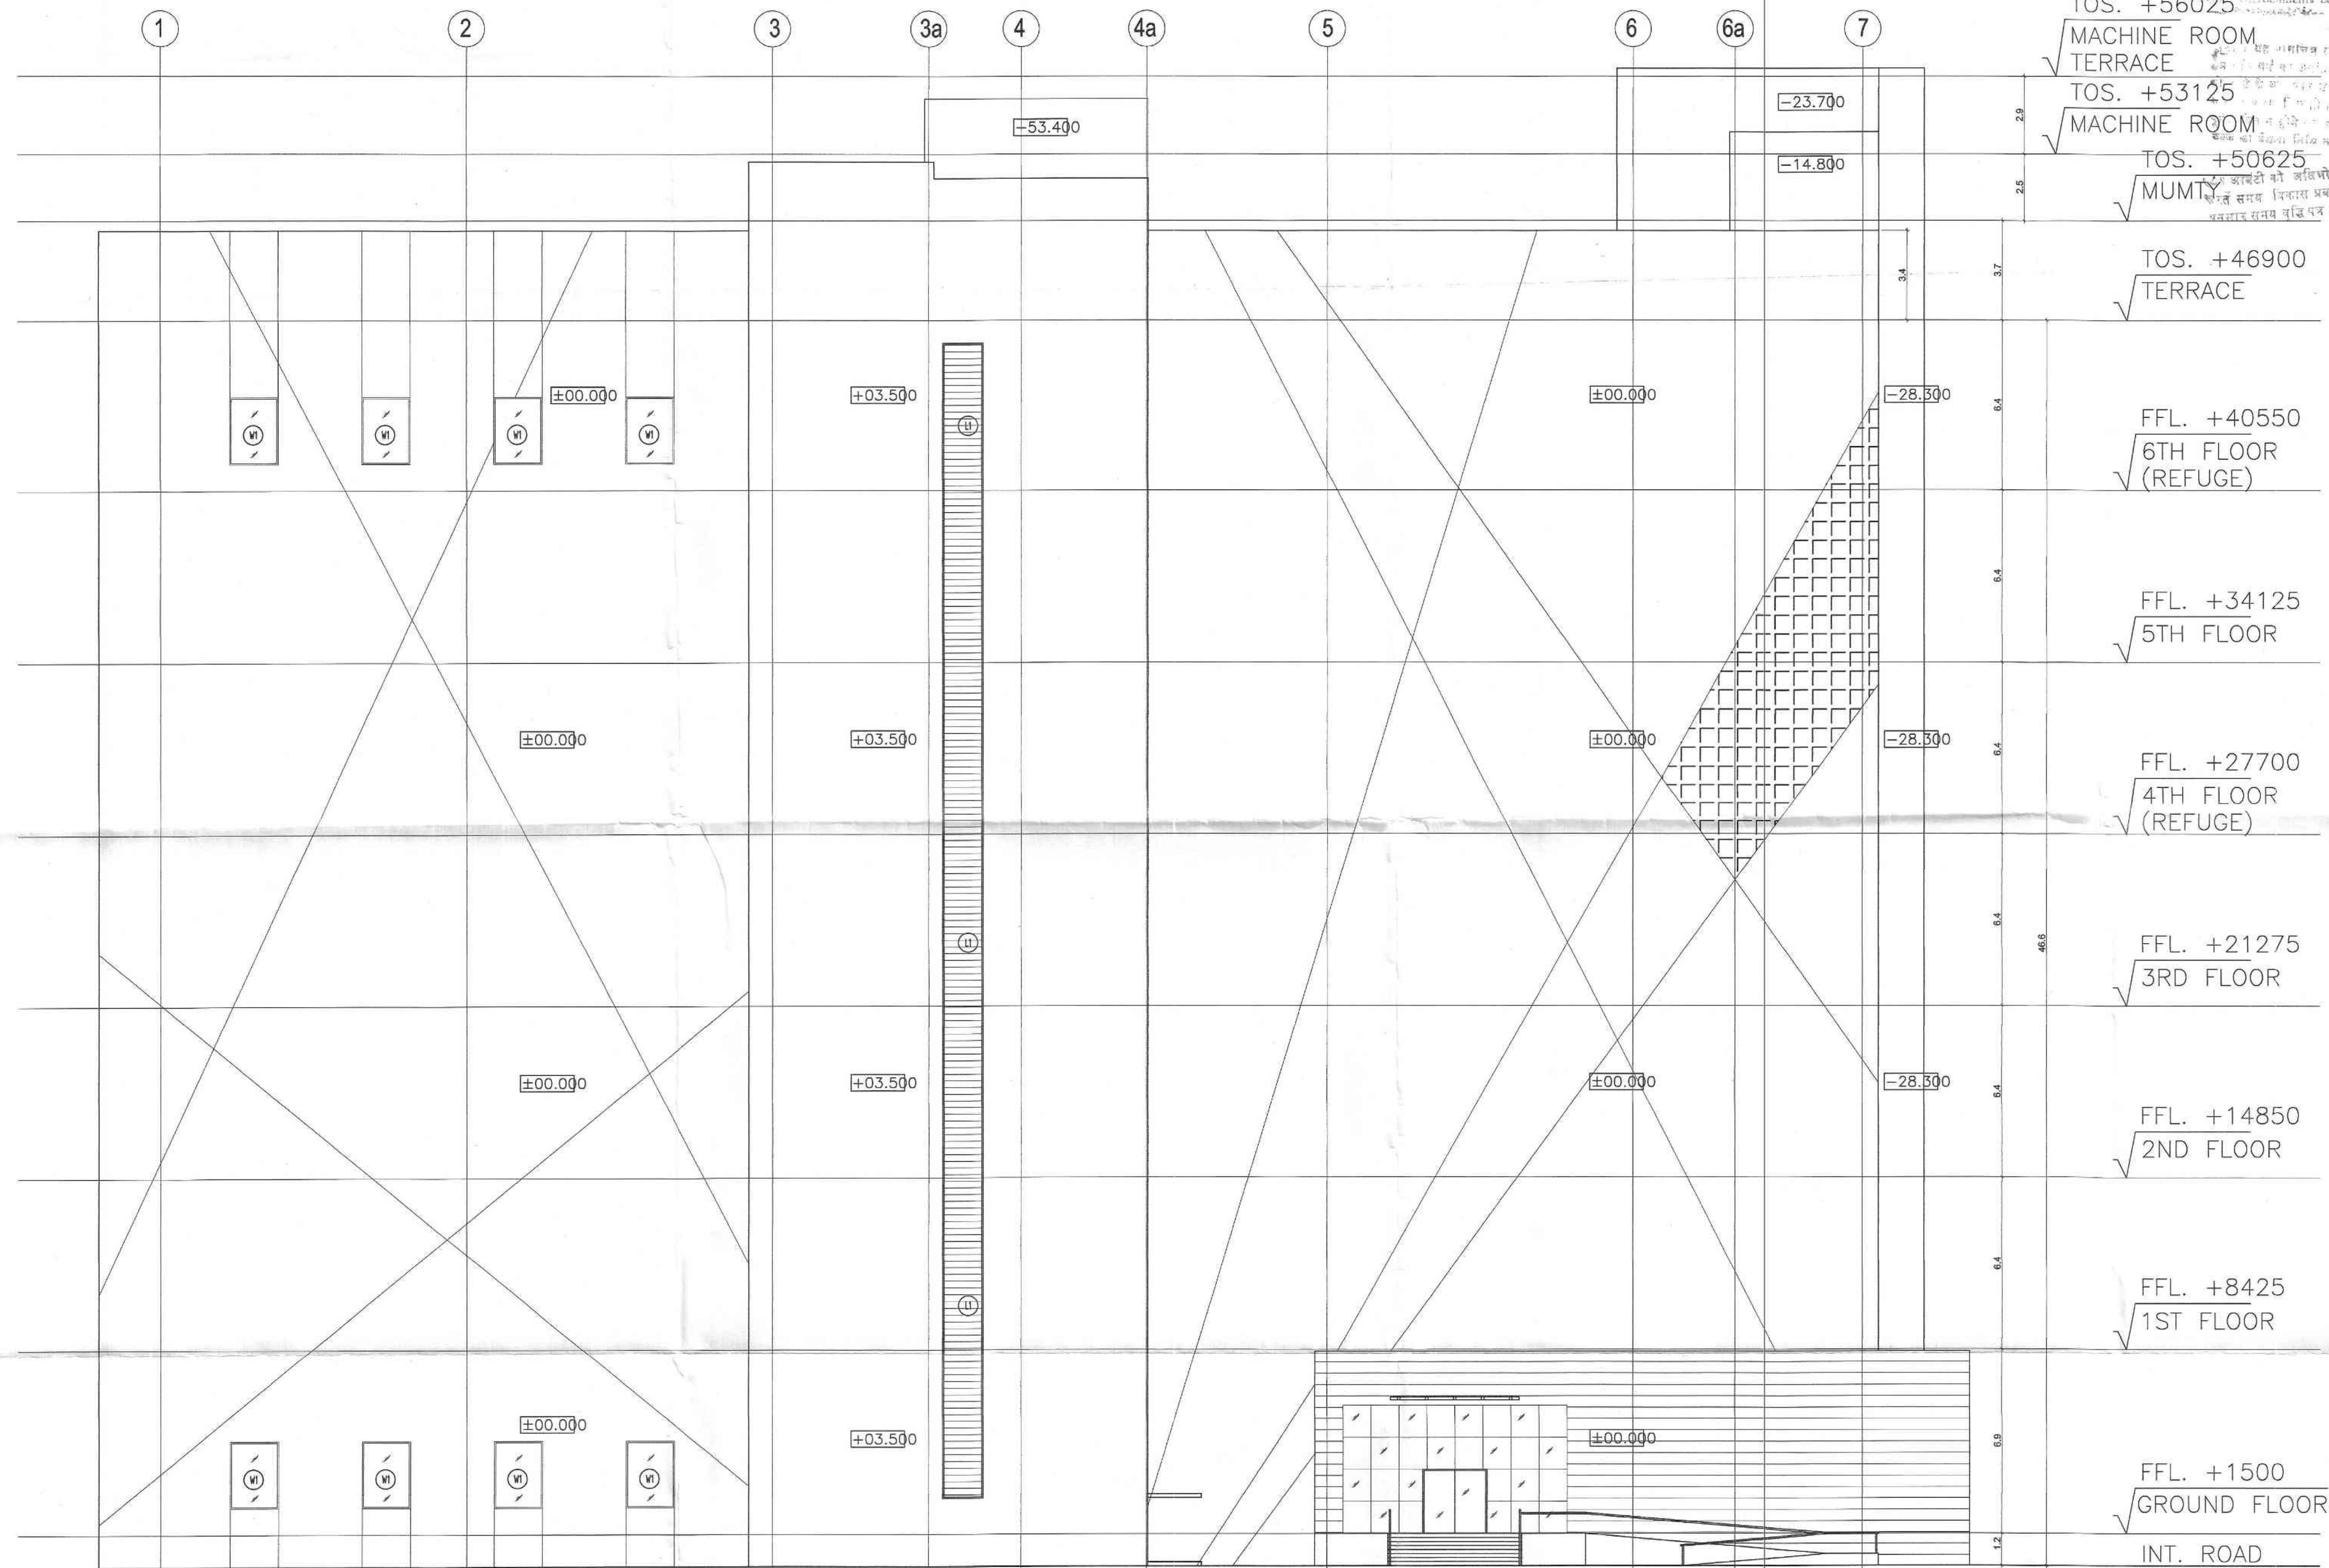BLOCK - "A"
(STILT + 6)

ELEVATION - 04

SUBMISSION DRAWING

SHEET TITLE

ELEVATION - 04

OWNER:

URVASI INFRA TECH PVT. LTD.

THROUGH : AUTHORISED SIGNATORY

CONSULTANT

R.N.Gupta & Associates
Consulting Engineers, Architects & Valuers
E - 1, Sector-55, Noida
Phones - (+120) 4321556
email-info@rngcorp.com

PROJECT : PROPOSED I.T. SEZ PARK,
NOIDAPLOT NO - 01, SECTOR - 143 A
GAUTAM BUDDHA NAGAR, NOIDA (U.P.)

SCALE 1:100



DATE 26 - 03 - 2021

ARCHITECT'S SIGNATURE

OWNER'S SIGNATURE

Map for proposed Building as per Byo
Laws submitted for approval. Please
B. N. Gupta
P. N. Gupta
A. N. Gupta
A. N. Gupta

BLOCK - "A"
(STILT + 6)

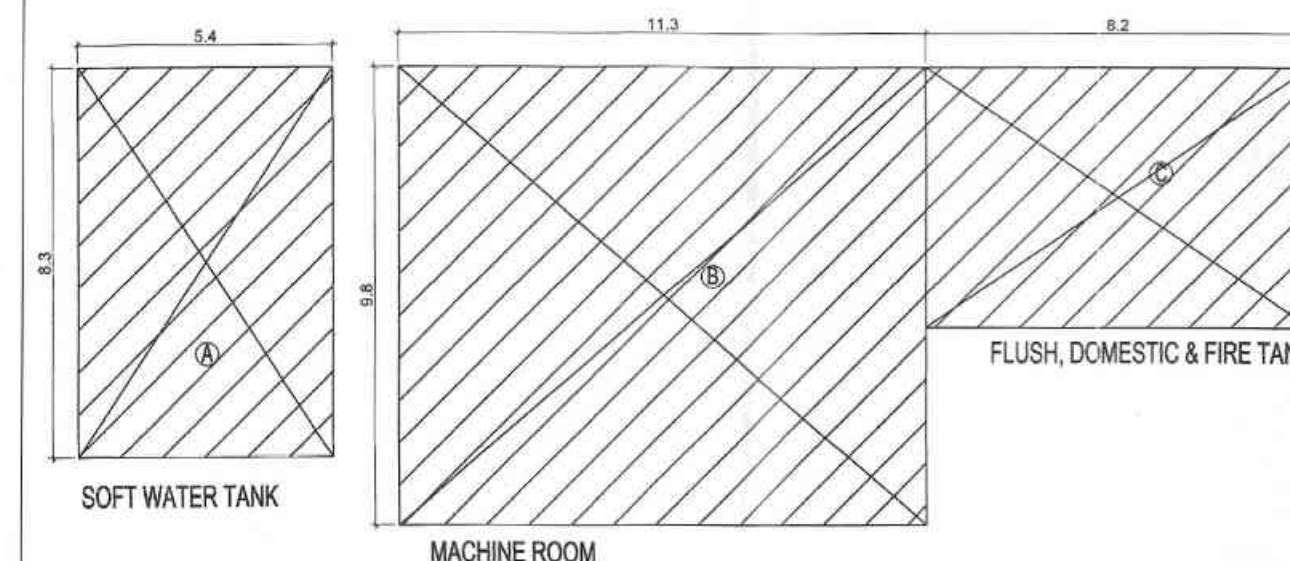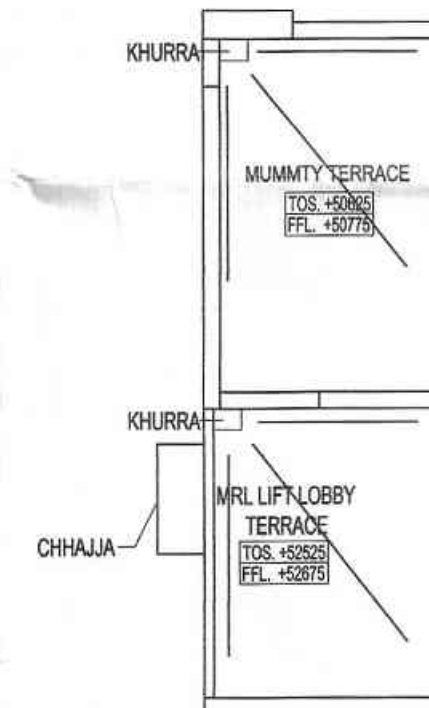

DOOR WINDOW SCHEDULE						
TYPE	DOOR SIZE	CILL LVL	LINTEL LVL		LOCATION	FIRE RATING
FIRE DOORS						
FD1	600X1500	900	2400	PL. SHAFT		2HR
FD2	900X1500	900	2400	ELECTRICAL SHAFT, ELV SHAFT, DATA SHAFT & HVAC SHAFT		2HR
FD3	1530X2400	0	2400	STAIRCASE,	FIRE STAIRCASE, MACHINE ROOM	2HR
FD3A	1530X2400	0	2400	FIRE TOWER		2HR
FD3B	1530X2100	0	2100	STAIRCASE,	FIRE STAIRCASE, MACHINE ROOM	
FD4	2400X2800	0	2800	FR. LIFT LOBBY (G.FLOOR)		2HR
FD5	1800X2800	800	3600	FR. LIFT LOBBY		2HR
FD5A	1800X2800	0	2800	ELECTRICAL ROOM		
FD6	2000X2400	0	2400	ENTRANCE	LOBBY	2HR
FD7	1000X2100	0	2100	ELECTRICAL PANEL		2HR
FD8	1800X2400	0	2400	LIFT LOBBY		2HR
FD9	1000X2400	0	2400	FIRE CONTROL ROOM		2HR
NORMAL DOORS						
D1	750X2100	0	2100	JANITOR		NA
D2	1000X2100	0	2100	TOILET		NA
D3	1050X2100	0	2100	HANDICAP	TOILET	NA
D4	1000X2100	0	2100	ROOM		NA
FHD	900X2025	75	2100	FHC		NA
GLASS DOORS						
GSLD	2000X2400	0	2400	ENTRANCE	LOBBY	NA
WINDOW						
W1	1800X2500	900	3400	HALL		NA
ROLLING SHUTTER						
RS1	3000X4000	-	4000	HALL, LOADING / UNLOADING		2HR
RS2	3000X4000	-	4000	INERGEN PIPES SHAFT		2HR
LOUVERS						
L1	-	-	-	FST-1 & FST2		NA

SHEET TITLE
MUMTY & MACHINE ROOM PLAN

THROUGH : AUTHORISED SIGNATORY

CONSULTANT	
------------	--

R.N.Gupta & Associates
Consulting Engineers, Architects & Valuers
E - 1, Sector-55, Noida
Phones - (+120) 4321556
email-info@rngcorp.com

PROJECT : PROPOSED I.T. SEZ PARK,
NOIDA
PLOT NO - 01, SECTOR - 143 A
GAUTAM BUDDHA NAGAR , NOIDA (U.P)

SCALE	1:100	DATE	26 - 03 - 2021
-------	-------	------	----------------

ARCHITECT'S SIGNATURE

OWNER'S SIGNATURE



अतिरिक्त कार्य पर सभी सम्मानित
मित्रों से प्रार्थना है कि वे अपने अधिकारों का
उपयोग करके ही कार्य करें, और
समय न हरे।

Enrichments on front, floor & side
panels invite heavy penalties. En-
richments could be demolished also. Plea
wide enrichments construct built

को भी। यह समझें कि इसी दृष्टि की दृष्टि से वा-
 र्ता में वरुण की दृष्टि से वा-
 की पदों की दृष्टि से वा-
 कादिका का दृष्टि से वा-
 दृष्टि से वा-
 दृष्टि से वा-

6) आक्टों को अधिभोग प्रमाण पत्र हेतु ५-५६
करते समय विक्रय प्रत्यक्ष (आवास) से नियम
अनसार समय वृत्ति पत्र प्राप्तकर प्रस्तुत करना होगा

ELE-C

SEC-YY

ELE-02

SEC-XX

ELE-03