


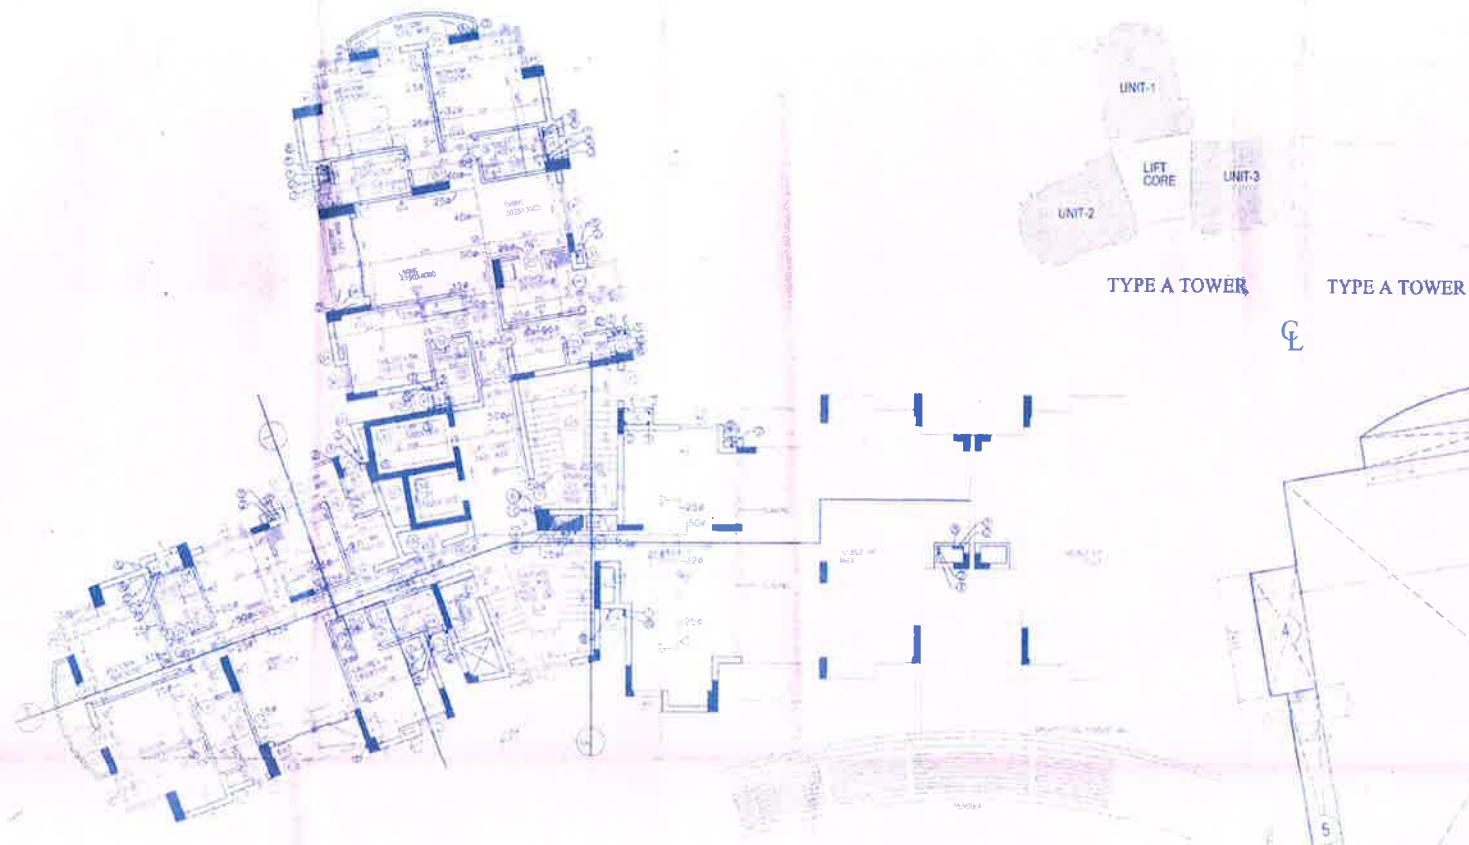

FIRST FLOOR PLAN

Sl. No.	Room No.	Area (sq.m)	Volume (cu.m)
1	101	10.00	10.00
2	102	10.00	10.00
3	103	10.00	10.00
100	200	10.00	10.00

Sl. No.	Room No.	Area (sq.m)	Volume (cu.m)
1	201	10.00	10.00
2	202	10.00	10.00
3	203	10.00	10.00
100	300	10.00	10.00

UNIT 2 AREA = 14.65+2.45+13.21 SQ.M

LOBBY AREA ON FIRST FLOOR = 52.15+43.753 SQ.M
= 95.903 SQ.M


AREA ON GROUND FLOOR = AREA UNIT 1+AREA UNIT 2+AREA LIFT LOBBY+AREA ENTRANCE LOBBY

AREA ON FIRST FLOOR = 139.98+133.14+514.93+367.41+350.08 SQ.M

FINAL AREA ON FIRST FLOOR = 357.497 SQ.M

= 357.497 SQ.M

Sl. No.	Room No.	Area (sq.m)	Volume (cu.m)
1	301	10.00	10.00
2	302	10.00	10.00
3	303	10.00	10.00
92	392	10.00	10.00

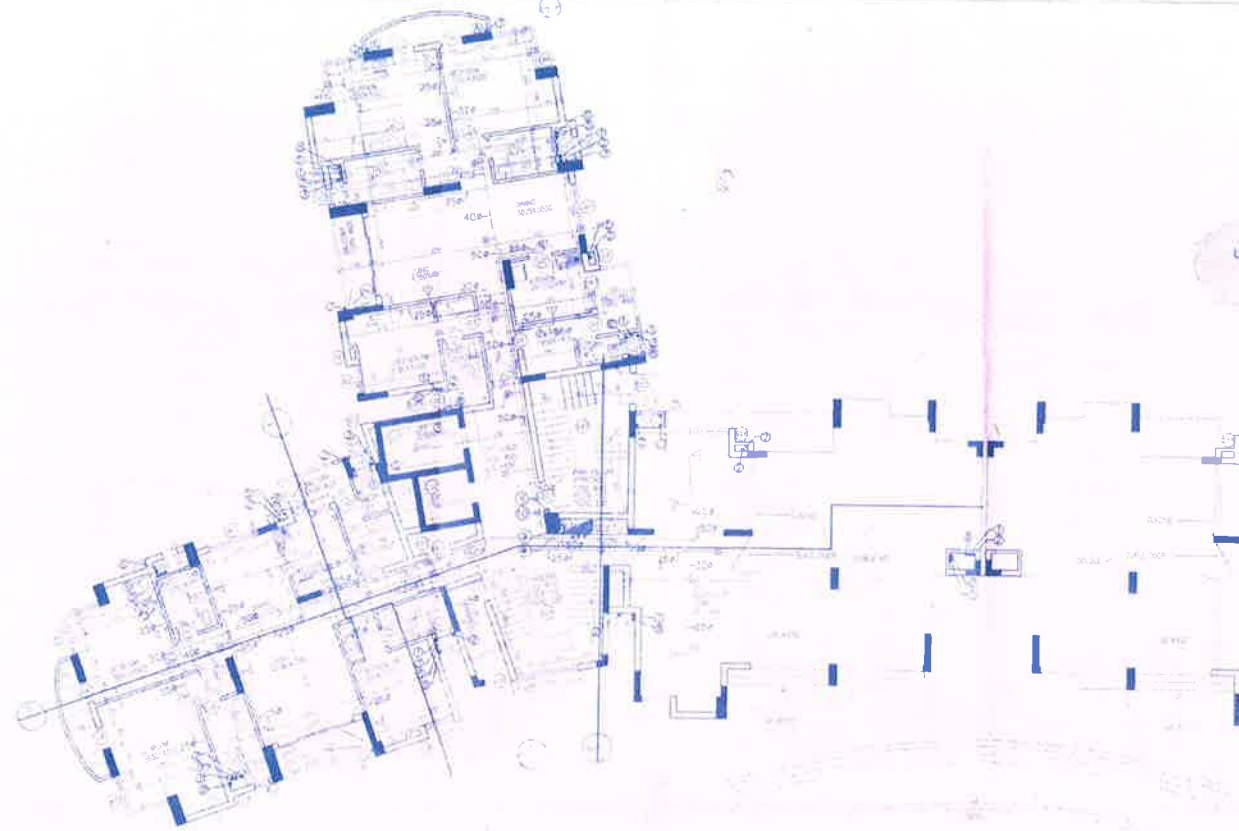


GROUND FLOOR PLAN

NO.	DESCRIPTION	QTY	UNIT	REMARKS
1	100mm SOIL PIPE	1		
2	100mm WASTE PIPE	1		
3	75mm A.S.P. VENT PIPE	1		
4	65mm C.W.S. RISER	1		
5	C.W.S. DN TAKE	1		
6	150mm FIRE RISER	1		
7	80mm PIPE (FOR BALCONY R.W.F)	1		
8	100mm RWP PIPE	1		
9	50mm AC DRAIN P.P.E	1		
10	50mm SPRINKLER RISER	1		
11	KHURRA	1		
12	CUTOUT 100x100	1		

NO.	DESCRIPTION	QTY	UNIT	REMARKS
1	100mm SOIL PIPE	1		
2	100mm WASTE PIPE	1		
3	75mm A.S.P. VENT PIPE	1		
4	65mm C.W.S. RISER	1		
5	C.W.S. DN TAKE	1		
6	150mm FIRE RISER	1		
7	80mm PIPE (FOR BALCONY R.W.F)	1		
8	100mm RWP PIPE	1		
9	50mm AC DRAIN P.P.E	1		
10	50mm SPRINKLER RISER	1		
11	KHURRA	1		
12	CUTOUT 100x100	1		

AREA ON GROUND FLOOR = 423.17 SQ.M
 AREA ON GROUND FLOOR = 423.17 SQ.M (FIRE ES: APE STAIR CASE)
 FINAL AREA ON GROUND FLOOR = 423.17 SQ.M

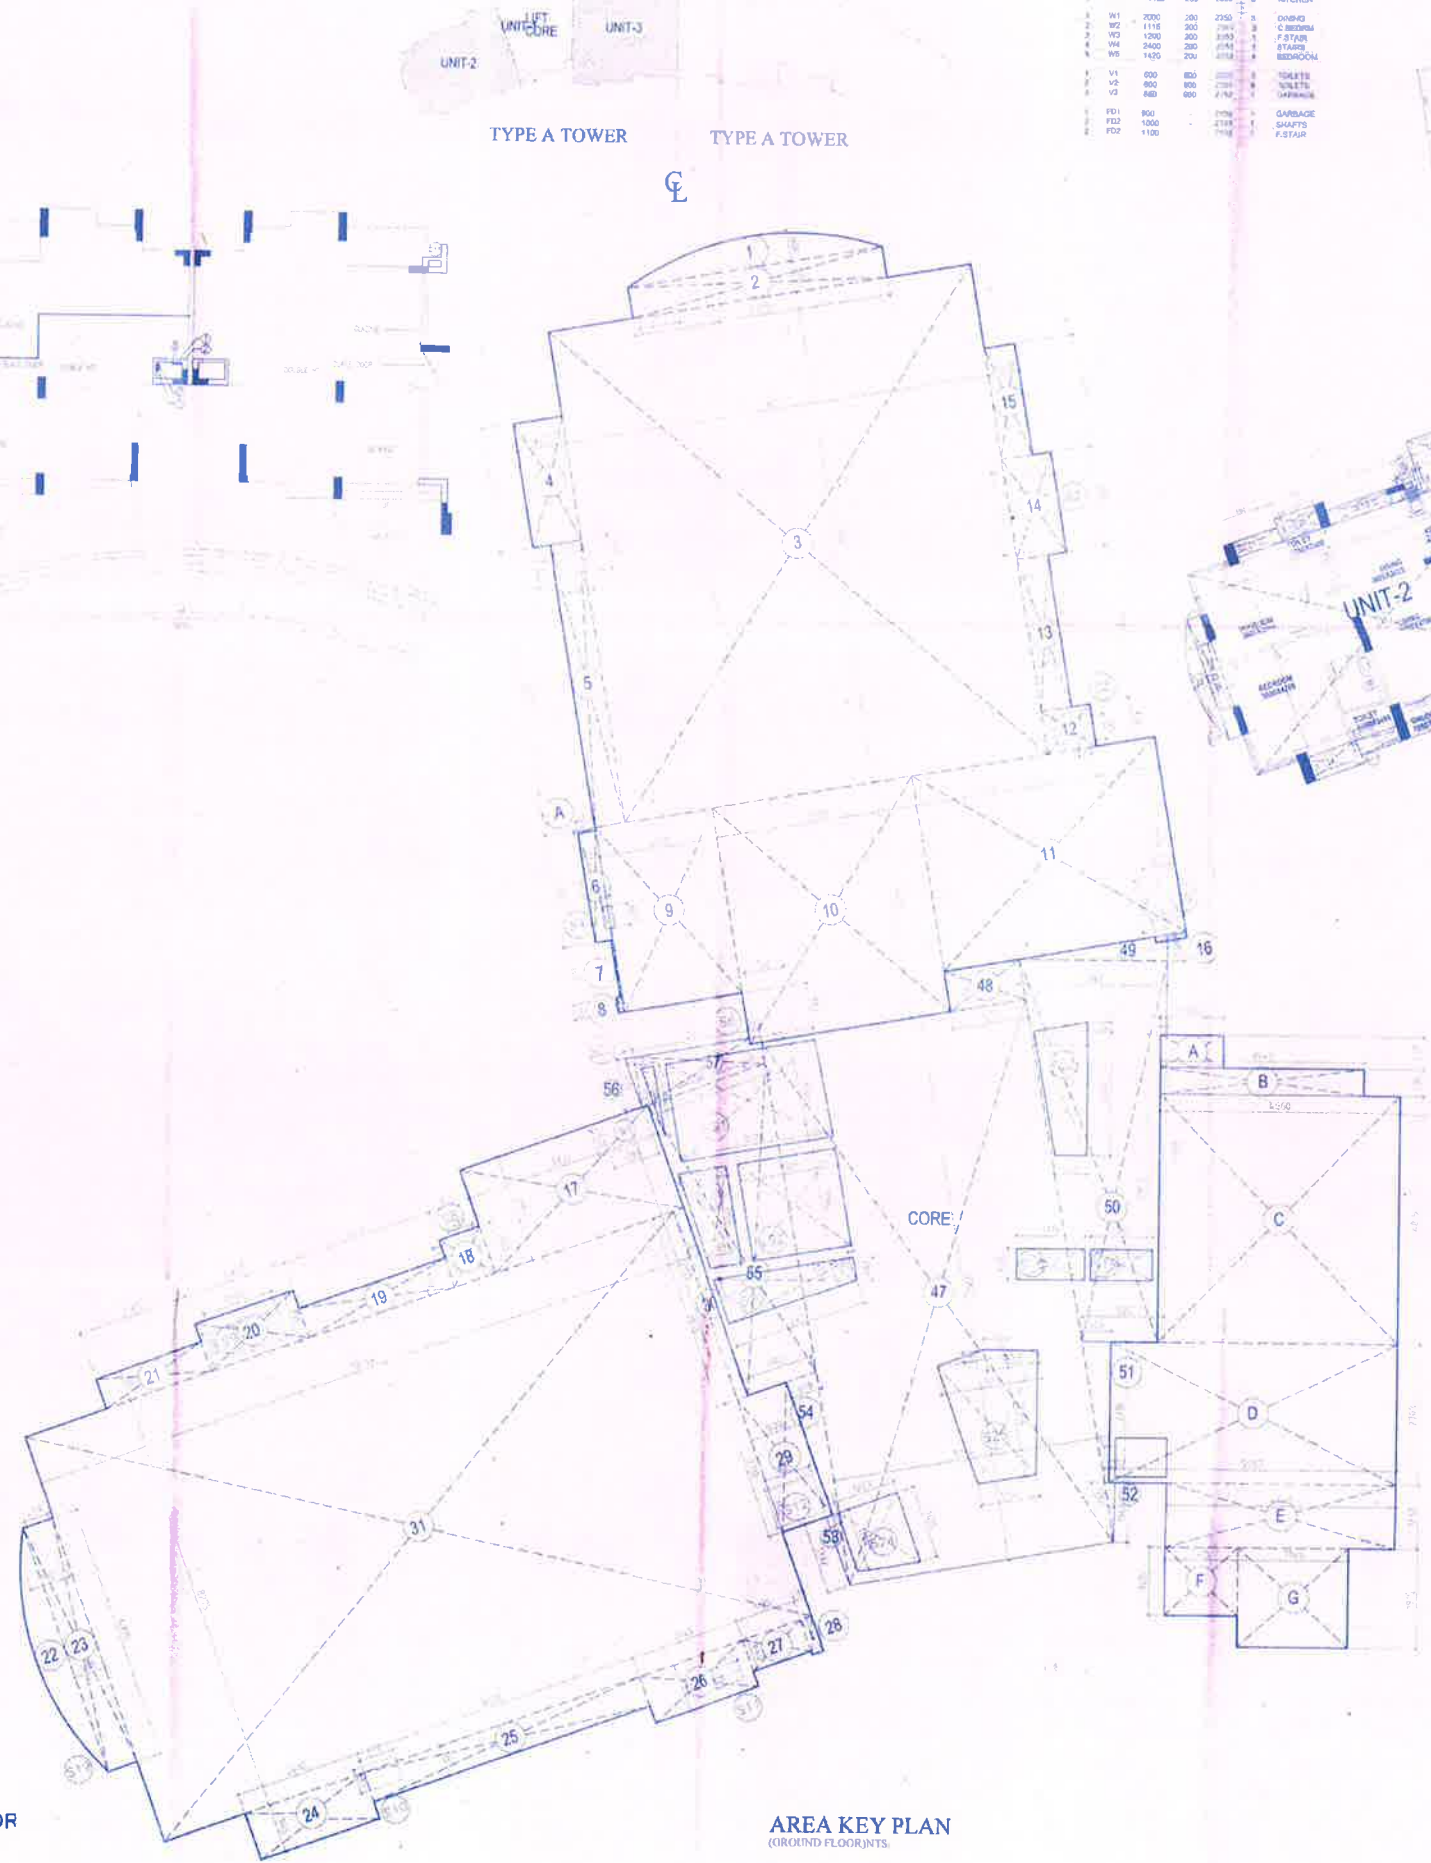

AREA KEY PLAN (GROUND FLOOR)


DOOR-WINDOW SCHEDULE

NO.	TYPE	WIDTH	HEIGHT	LOCATION
D1	1000	2100	3	ENTRANCE
D2	1000	2100	3	ENTRANCE
D3	800	2100	3	BALCONY
D4	800	2100	3	BALCONY
D5	800	2100	3	BALCONY
D6	800	2100	3	BALCONY
D7	1200	2100	3	BALCONY
W1	1000	2100	3	ENTRANCE
W2	1000	2100	3	ENTRANCE
W3	800	2100	3	BALCONY
W4	800	2100	3	BALCONY
W5	800	2100	3	BALCONY
W6	800	2100	3	BALCONY
W7	1200	2100	3	BALCONY
W8	1000	2100	3	ENTRANCE
W9	1000	2100	3	ENTRANCE
W10	800	2100	3	BALCONY
W11	800	2100	3	BALCONY
W12	800	2100	3	BALCONY
W100	800	2100	3	BALCONY

NOTES & REFERENCES

LEGEND

NO	DESCRIPTION
(1)	100mm SOIL PIPE
(2)	100mm WASTE PIPE
(3)	75mm A.S.P. VENT PIPE
(4)	65mm C.W.S. RISER
(5)	C.W.S. DN TAKE
(6)	150mm FIRE RISER
(7)	80mm PIPE (FOR BALCONY R.W.F)
(8)	100mm RWP PIPE
(9)	50mm AC DRAIN P.P.E
(10)	50mm SPRINKLER RISER
(11)	KHURRA
(A)	CUTOUT 100x100

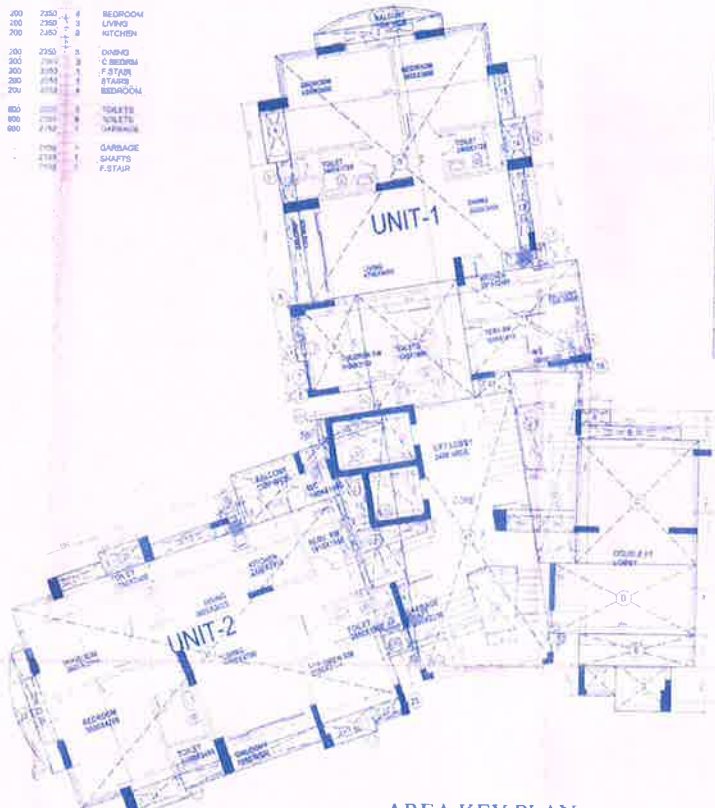

AREA KEY PLAN (GROUND FLOOR)

EXTINGUISHER

10-L ABC TYPE	10-L WATER CO2
4-L ABC TYPE	4-L WATER CO2
SPRINKLER PIPE	STW WALL SPRINKLER
ROUNDOUT SPRINKLER	

PROJECT
 PARSYNATH PRIVILEGE
 PROPOSED GROUP HOUSING
 AT PLOT NO-11, SECTOR P1-01, G-02
 GREATER NOIDA

CLIENT'S NAME
 PARSYNATH
 DEVELOPERS LIMITED
 8th FLOOR, ARUNACHAL BUILDING
 7A, BRAHMPUR, NO. 10, DELHI-110001



CLIENT'S SIGNATURE

ARCHITECT'S SIGNATURE
 J.B. KARAMCHANDANI
 ARCHITECT
 CA/78/4302

STATUS
 SUBMISSION DRAWING
 (REVISED)

DRAWING TITLE
 GROUND FLOOR PLAN AND
 AREA CALCULATIONS
 TYPE A1, A2, A3 TOWER

DEALT BY: Dwg No. 100(A0) Dated: 29 MARCH 2007
 STATUS: SUBMISSION DRAWING
 Dwg No. 100(A0) Rev No. 100(A0)

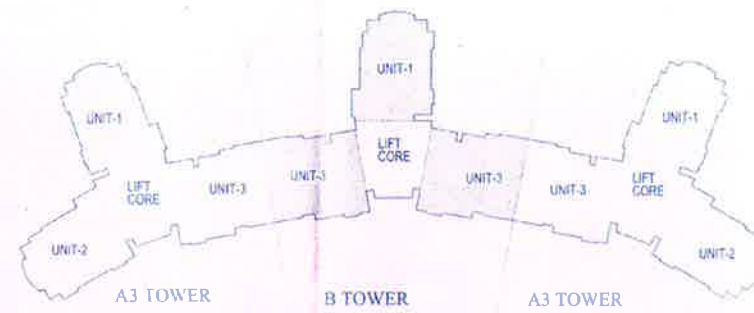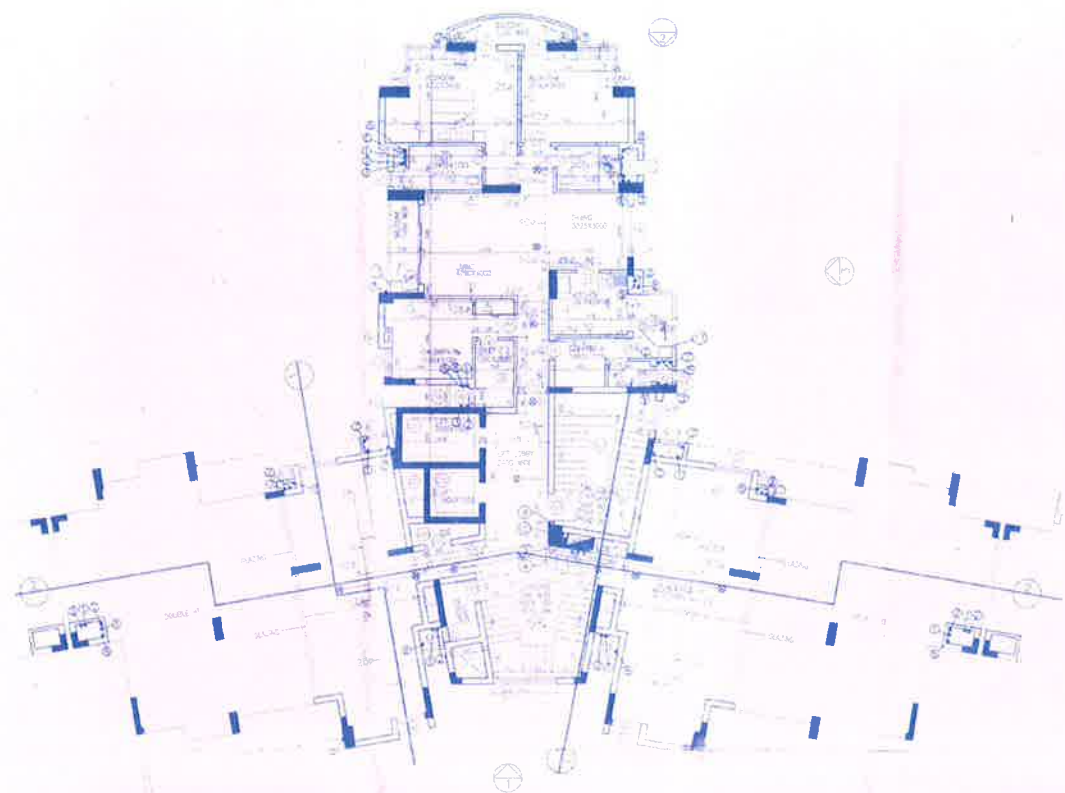


DAILY WORKING SCHEDULE						
Slr.	TYPE	W/H/T	CELL	UNIT/L	NO. OF PL	LOCATION
1	01	11:00		2100	3	ENTRANCE
2	02	9:00		2100	4	8 ROOMS
3	03	9:00		2100	4	8 ROOMS
4	04	9:00		2100	5	8 ROOMS
5	05	9:00		2100	5	8 ROOMS
6	06	9:00		2100	5	8 ROOMS
100	100	9:00		2100	5	8 ROOMS

NOTES & REFERENCES

<u>LEGEND</u>	
NO	DESCRIPTION
(1)	100# SOIL PIPE
(2)	100# WASTE P.PE
(3)	75# A.S.P. VENT P.PE
(4)	65# C.W.S RISER
(5)	C.W.S DN. TAKE
(6)	150# FIRE RISER
(7)	80# PIPE(FOR BALCONY R.W.P)
(8)	100# RWP PIPE
(9)	50# AC DRAIN PIPE
(10)	150# SPRINKLER RISER
(11)	KHJRA
(A)	C/JOINT 100x100

AREA CALCULATION ON FIRST FLOOR				
S NO	NO.	LENGTH	WIDTH	AREA
1	1	4.93	2.03	9.99
2	1	2.75	1.95	5.36
3	1	30.66	2.47	75.84
4	1	8.75	3.98	34.64
5	1	0.99	2.19	2.16
6	1	2.55	3.95	10.09
7	1	0.55	0.95	0.52
8	1	6.65	1.95	12.95
9	1	4.25	3.95	16.79
10	1	0.55	1.45	0.79
11	0.5	16.74	3.95	33.12
12	1	2.45	1.45	3.55
13	1	2.45	2.95	7.22
14	1	1.44	1.95	2.81
15	1	2.45	2.95	7.22
16	2.5	1.05	0.55	0.57
17	2	2.85	0.55	1.56
18	2	1.45	2.95	4.28
19	2	1.15	2.95	3.37
20	2	2.25	2.95	6.64
21	2	2.45	2.95	7.17
22	2	1.95	1.15	2.23
23	2	1.15	3.55	4.08
24	2	1.75	2.95	5.14
25	2	1.55	7.35	11.42
26	2	1.55	1.95	3.02
TOTAL				
EVOLUTION ON FIRST FLOOR				
S NO	NO.	LENGTH	WIDTH	AREA
1	1	2.85	3.55	10.17
2	1	2.85	3.55	10.17
3	1	2.15	3.55	7.63
4	1	1.15	3.55	4.08
5	1	5.55	3.45	19.05
6	1	2.85	3.55	10.17
7	1	1.05	3.15	3.30
8	1	4.85	3.25	15.77
9	1	2.85	3.55	10.17
10	1	2.85	3.55	10.17
11	1	2.85	3.55	10.17
100	1	2.85	3.55	10.17
TOTAL				
FIRE ESCAPE STAIR AREA				
S NO	NO.	LENGTH	WIDTH	AREA
1	1	3.5	4.5	15.75
2	1	3.5	4.5	15.75
TOTAL				
EVOLUTION				
1	1	3.5	4.5	15.75
2	1	3.5	4.5	15.75
TOTAL				
FIRE ESCAPE STAIR AREA				
S NO	NO.	LENGTH	WIDTH	AREA
1	1	3.5	4.5	15.75
2	1	3.5	4.5	15.75
TOTAL				
FINAL AREA ON FIRST FLOOR = 155.35+15.75+15.75				

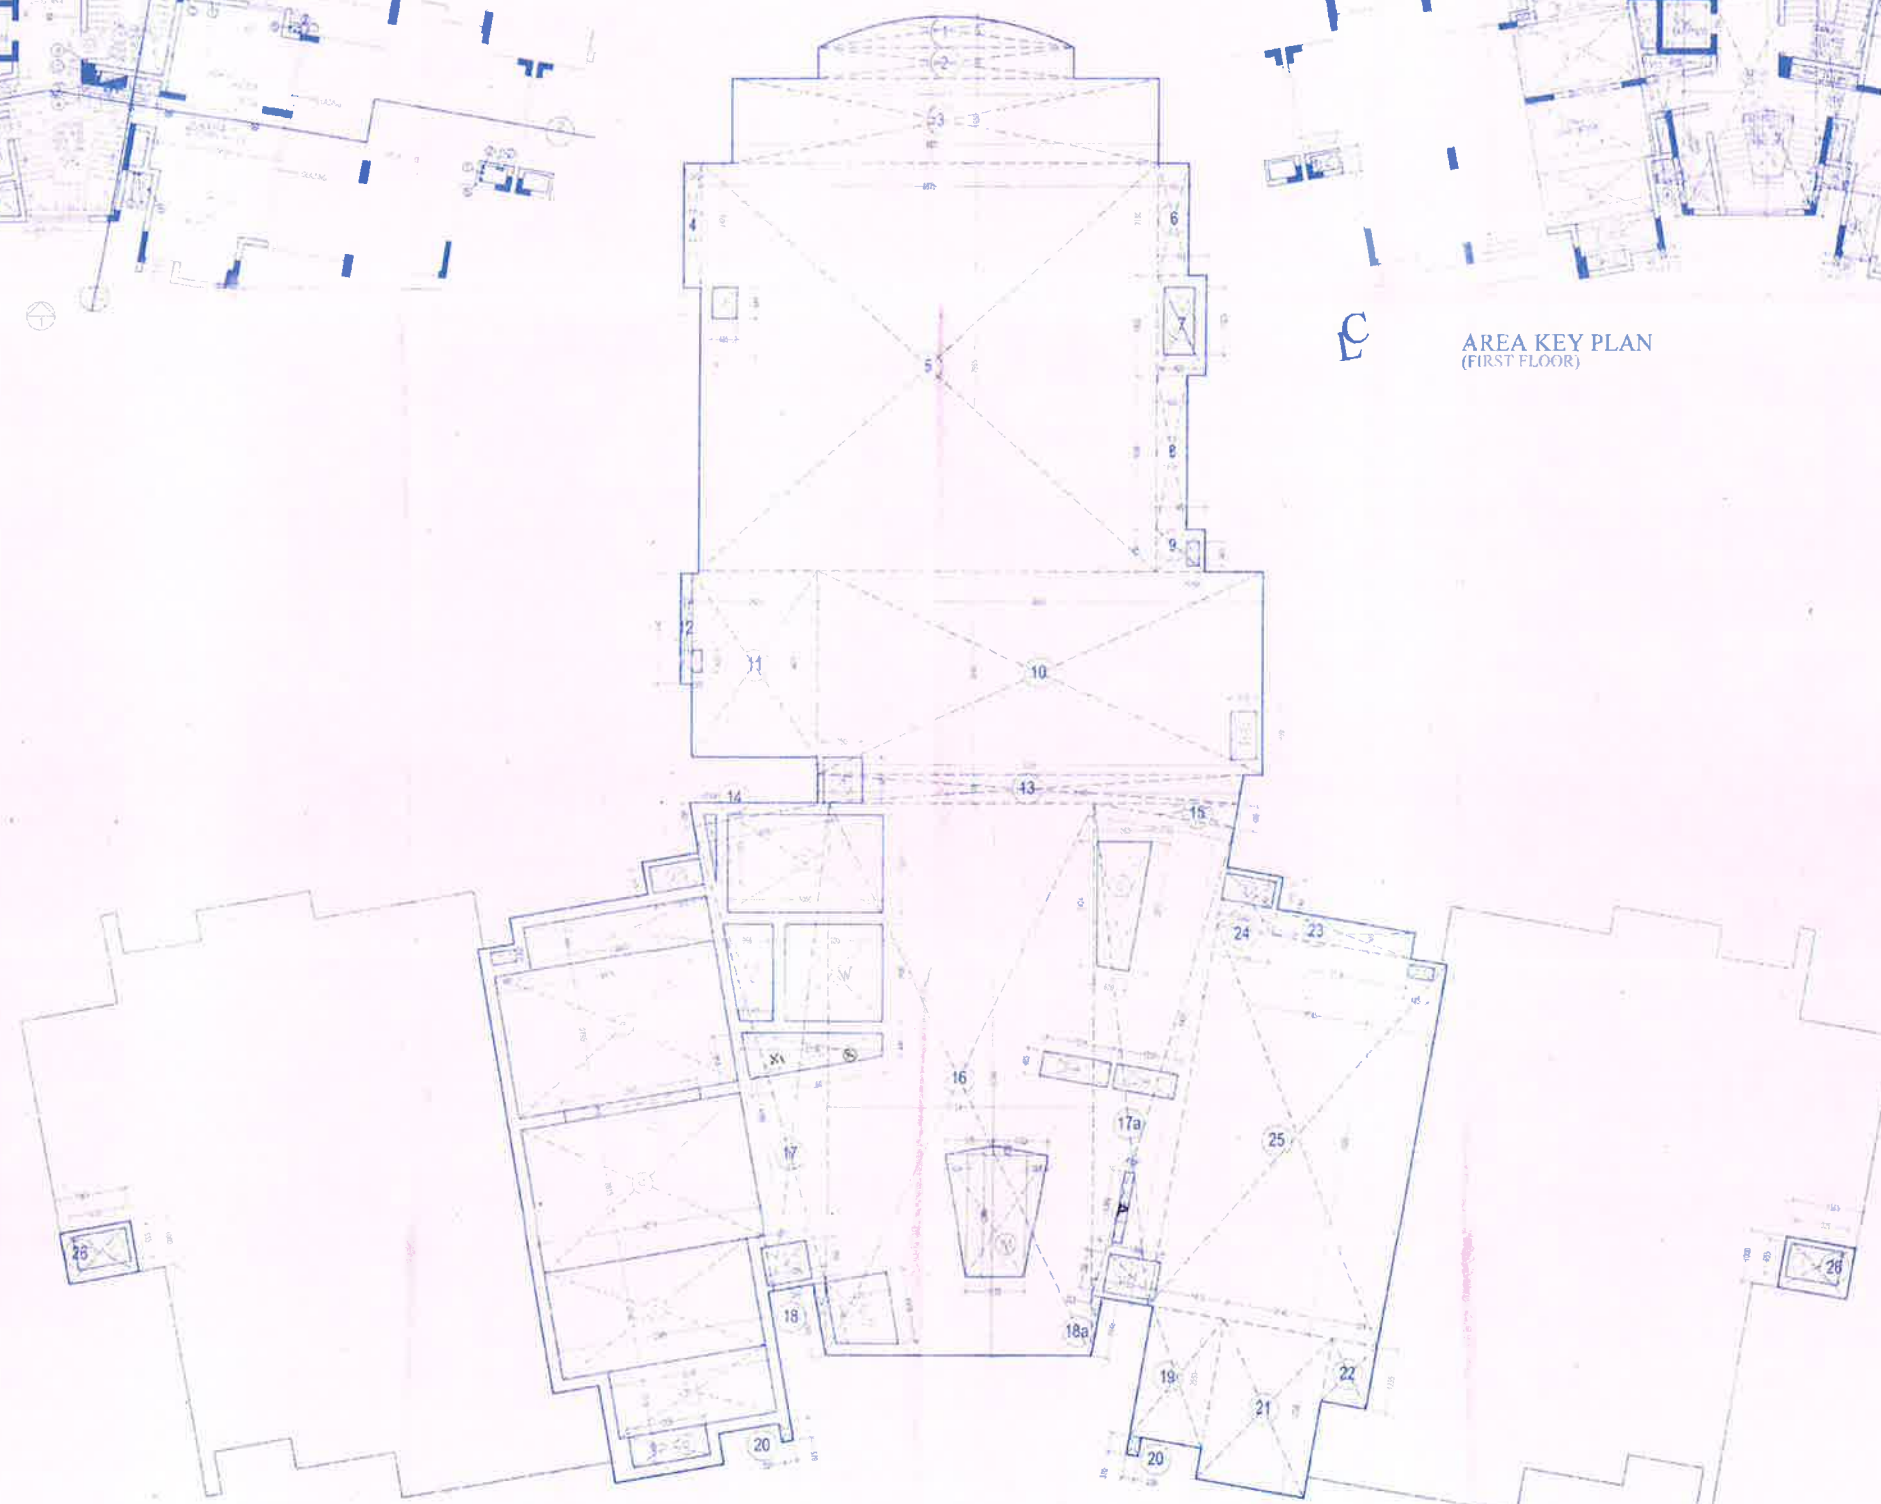

PARSYNATH PRIVILEGE PROPOSED GROUP HOUSING AT PLT NO.11,SECTOR PL-01&02 GREATER NOIDA	
CLIENT'S NAME - PARSYNATH DEVELOPERS LIMITED. 4/19 FLOOR, ANANDKUMAR BUILDING 16, Subhashnagar Rd. Noida (U.P.) - 201001.	
	
CLIENT'S SIGNATURE 	
J.B. KARAMCHANDANI ARCHITECT CA/78/4302 ARCHITECT'S SIGNATURE	
STATUS: SUBMISSION DRAWING (REVISED)	
DRAWING TITLE: FIRST FLOOR PLAN AND AREA CALCULATIONS TYPE B TOWER	
Scale 1:100(A0)	Dated 2007
DEALT BY	STATUS SUBMISSION DRAWING
Dwg No.	Rev No
MUN-B-02	