



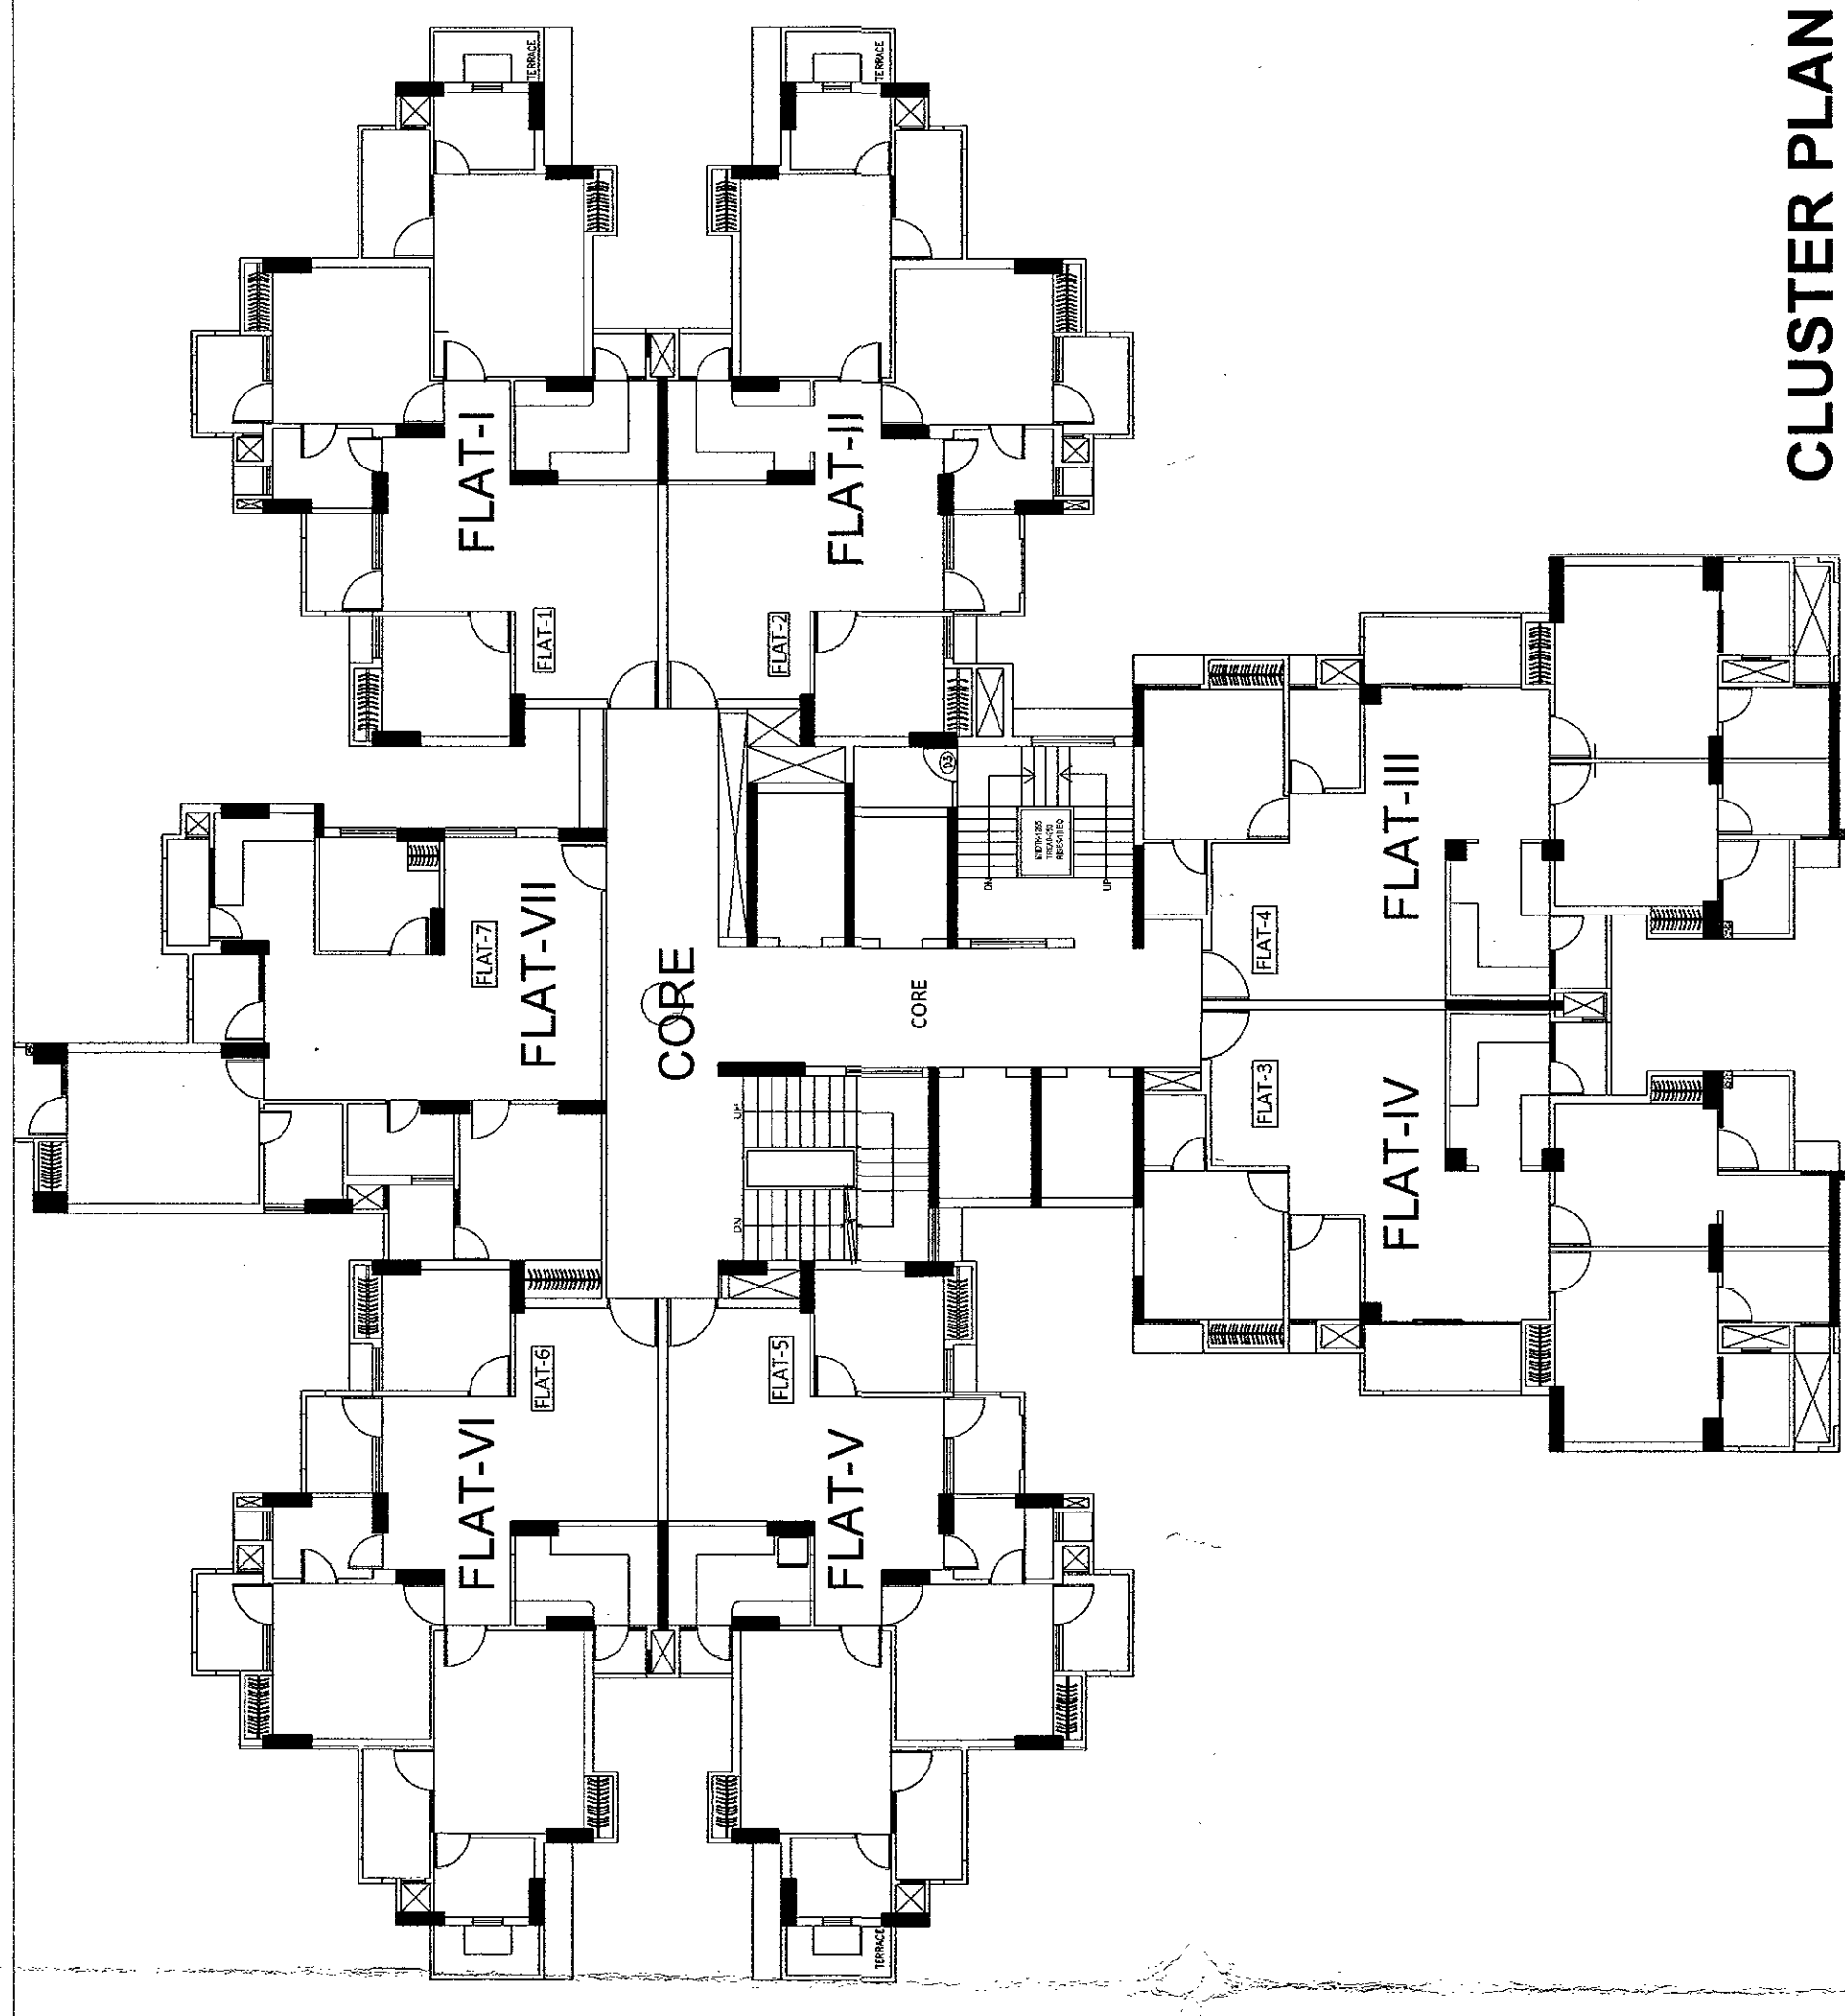

CLUSTER PLAN

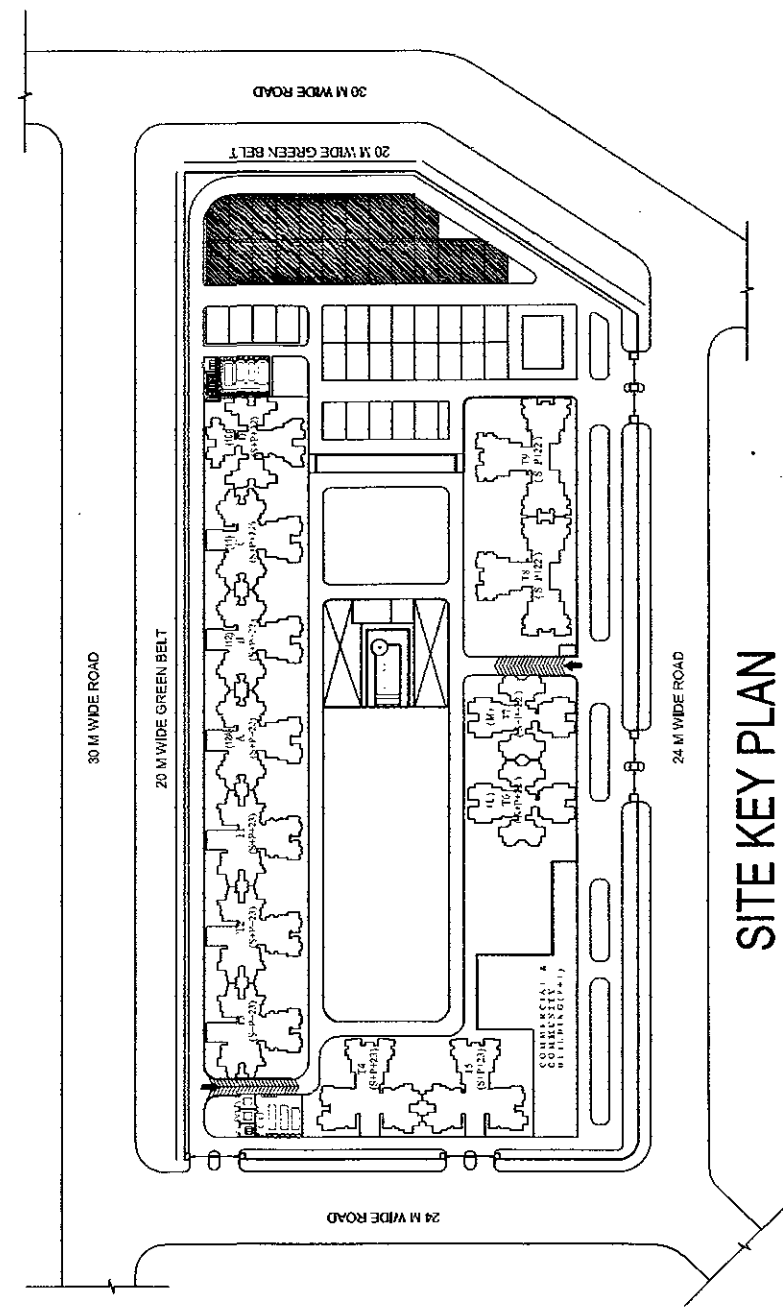

SITE KEY PLAN

KEY PLAN

SUBMISSION DRAWING	
NOTES. 1. ALL DIMS. ARE IN MM. & LEVELS ARE IN METER. 2. DIMS. ARE NOT TO BE SCALED.	
APPLICANT	M/S IVRCL ARANYA PROJECTS PVT. LTD.
PROJECT	THE ARANYA GROUP HOUSING ON PLOT No. GH-02, Sector-119, NOIDA Dist. G. Nagar (UP)
DRAWING TITLE	TOWER A.B.C 4TH-19TH & 20TH-22ND FLOOR PLAN, KEY PLAN, UNIT KEY PLAN
SCALE	DEALT: SANJEEV 1:100
DATE	07-11-2015
ARCHITECT	ARCHITECT NEXUS PLUS CONSULTANTS PVT. LTD. B-116, SECTOR-50, NOIDA
APPLICANT	ARCHITECT IVRCL ARANYA PROJECTS PVT. LTD. Plot No. GH-02, Sector-119, Noida Dist. G. Nagar (UP)
ARCHITECTS	ARCHITECT NEXUS PLUS CONSULTANTS PVT. LTD. B-116, SECTOR-50, NOIDA

11/15/16
18.2.16
547
10/15/16


11/15/16
18.2.16
547
10/15/16

20th - 22nd FLOOR PLAN



ELE-AA

ELE-BB

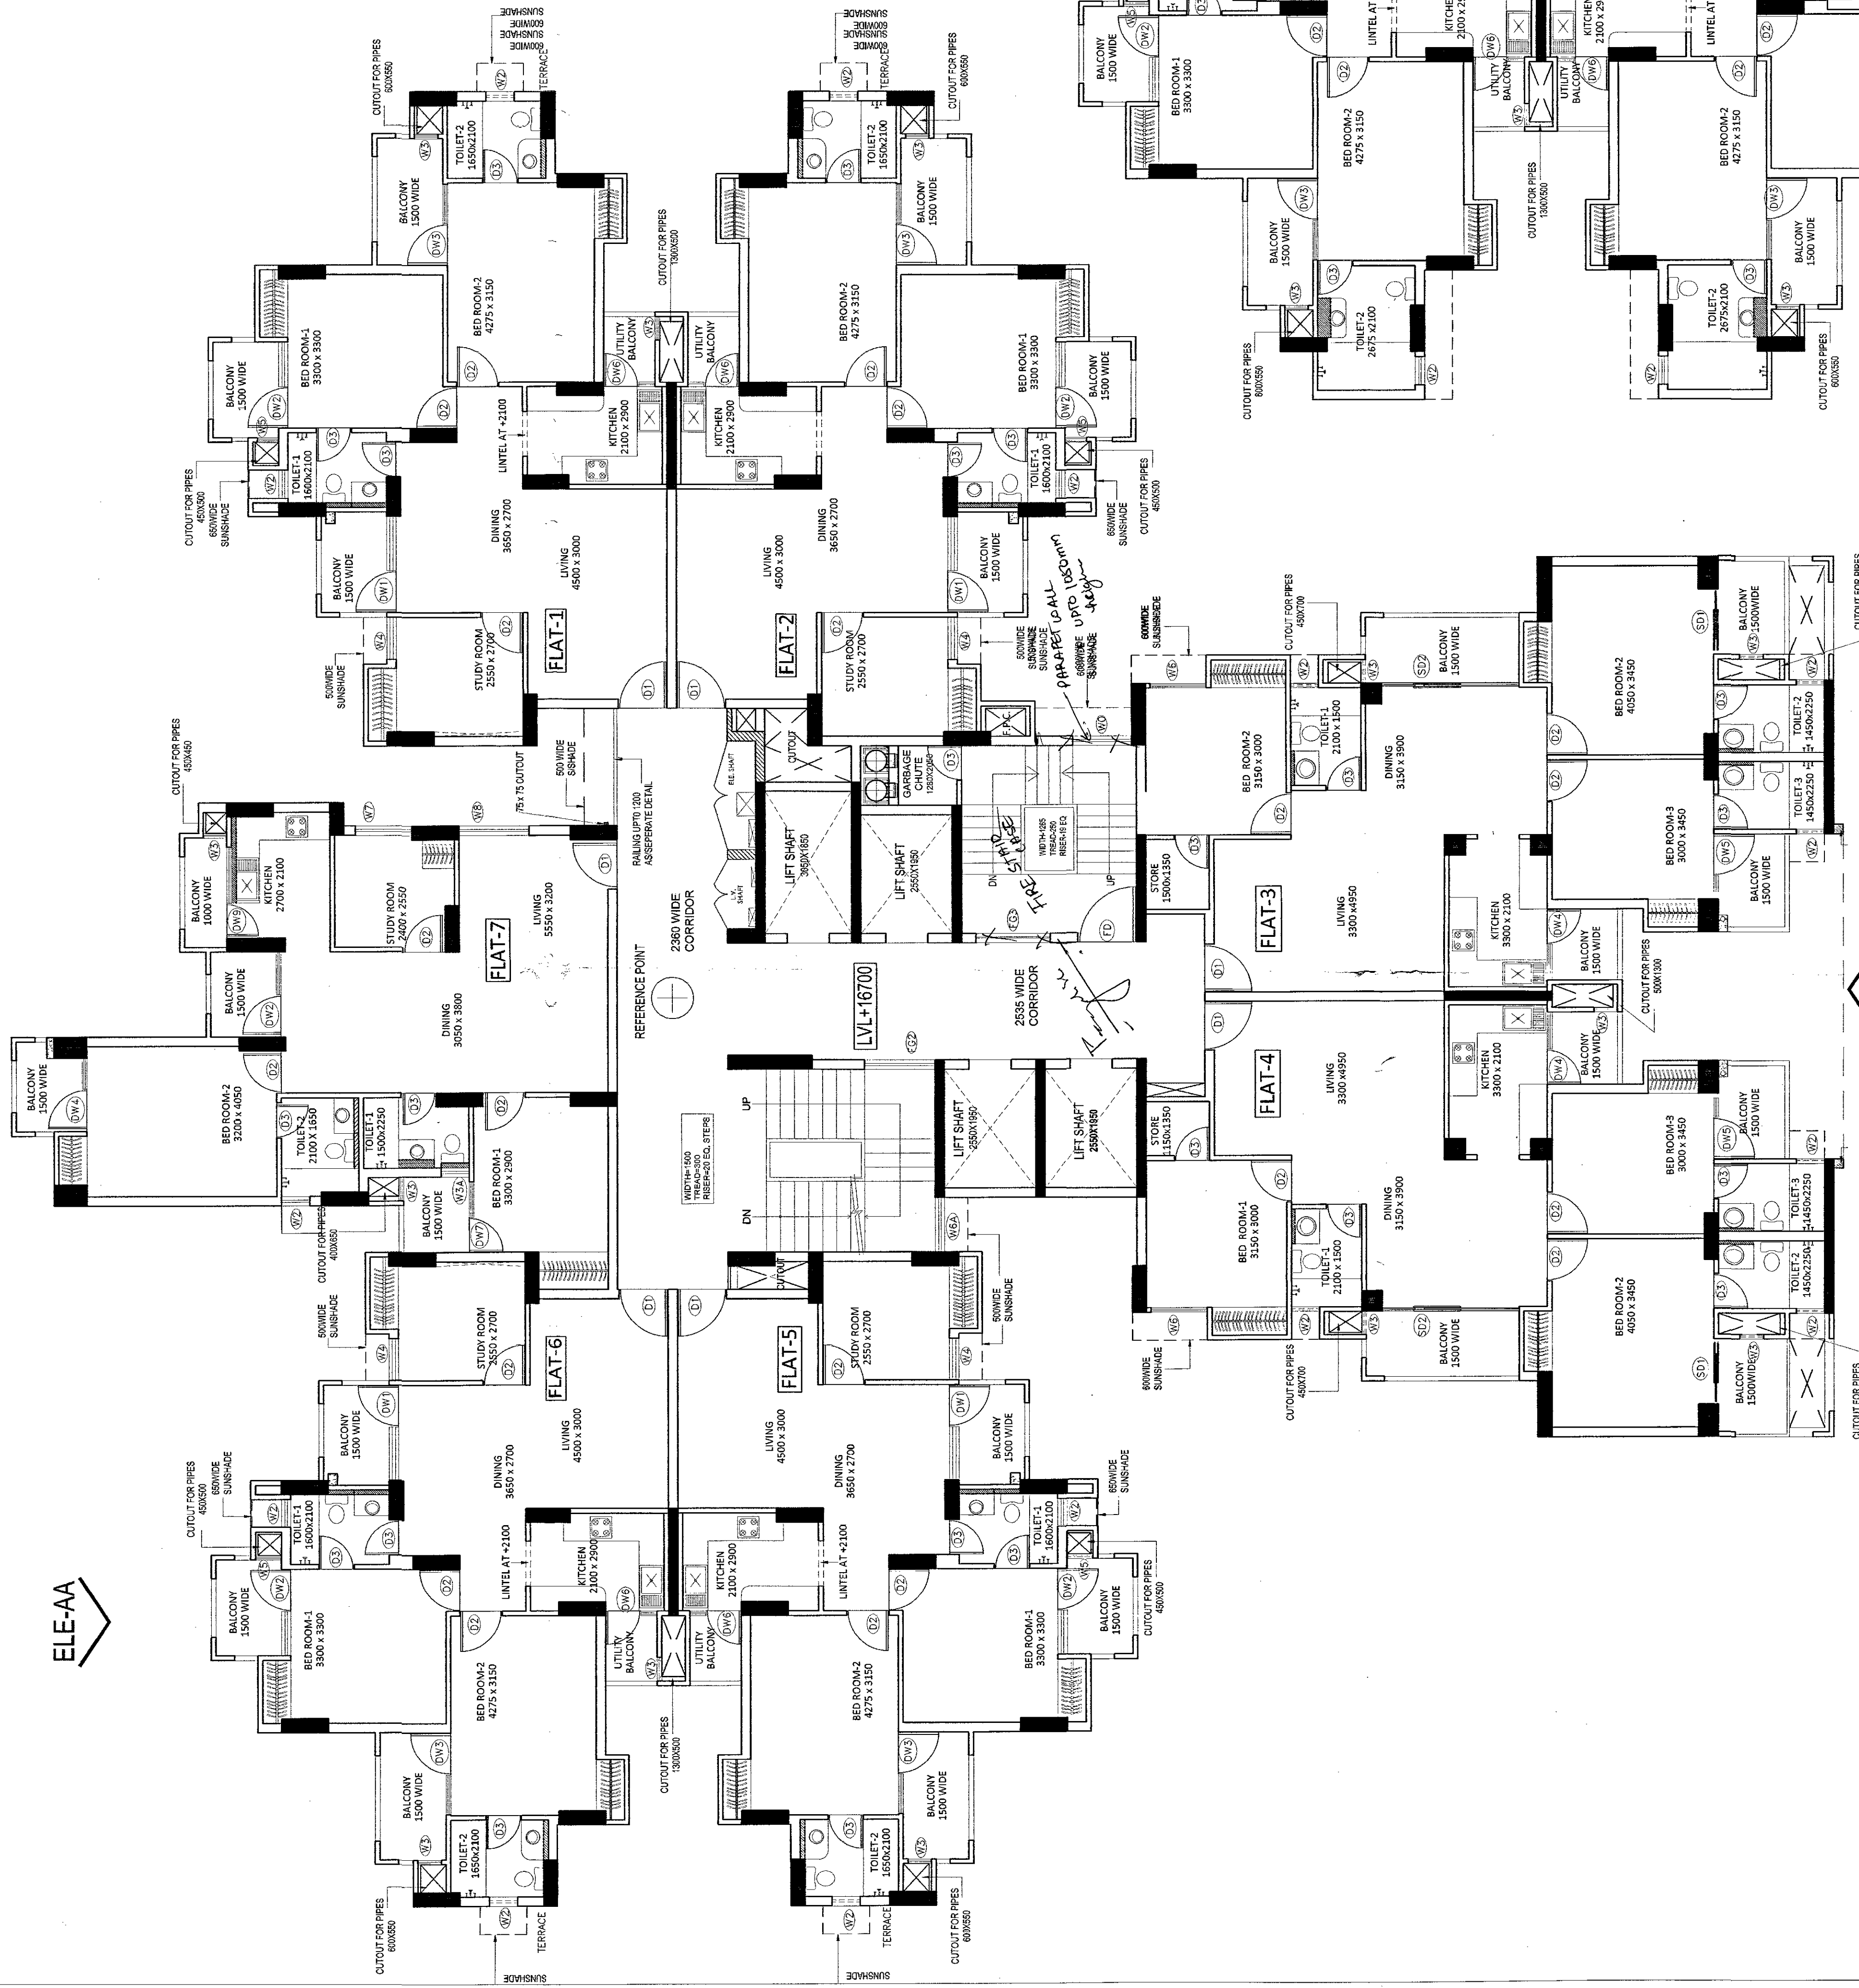

ELE-AA

4th - 19th FLOOR PLAN

ELE-RR