 

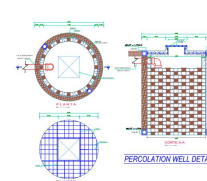


[illegible][illegible]

BUILDING NAME	WIND	LENGTH	HEIGHT	WIDE
A-CLIMATE-AND-REGIO	1	1.20	1.20	02
A-CLIMATE-AND-REGIO	2	1.80	1.20	08
A-CLIMATE-AND-REGIO	3	2.10	1.80	08

[illegible][illegible][illegible]

Total Plot Area :-	1002.45	Total FAR Area :-	3330.09	Kanapath Yenna (Junior Engineer)
Total Coverage Area :-	913.40	Total BUA Area :-	3369.82	Rakesh, Mohi (Assistant Engineer/ AEP)

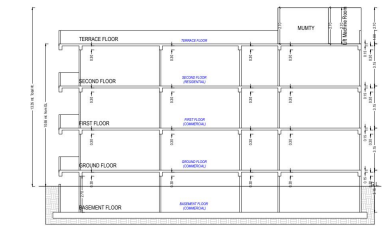

Total Plot Area: - 1092.45	Total FAR Area: - 3339.09	Ranagati Verma (Junior engineer)
Total Coverage Area: - 913.40	Total BUA Area: - 3369.82	Rakesh Shahi (Assistant Engineer/ ATP)

FIRST FLOOR PLAN
(Proposed)
(SCALE 1:100)


SECOND FLOOR PLAN
(Proposed)
(SCALE 1:100)

TERRACE FLOOR PLAN
(SCALE 1:100)




ISO A0 (841,00 x 1189,00 MM)

Total Plot Area:- 1992.45	Total FAR Area:- 3339.09	Ranapati, Verna (Junior engineer)
Total Coverage Area:- 913.40	Total BUA Area:- 3369.82	Rakesh, Mohi (Assistant Engineer/ STP)

The construction and accuracy of Personal Information and it usage is a responsibility of POFB member. Accuracy of LinkedIn, Email is subject to privacy of user provided data. No party software/business/connections, etc. Soft Skills/Engagement LM is not liable for any damages which may arise from use or misuse or use of the Application. Text posted in Email and Your (chat) are case study which are not verified and not guaranteed in writing unless otherwise stated.

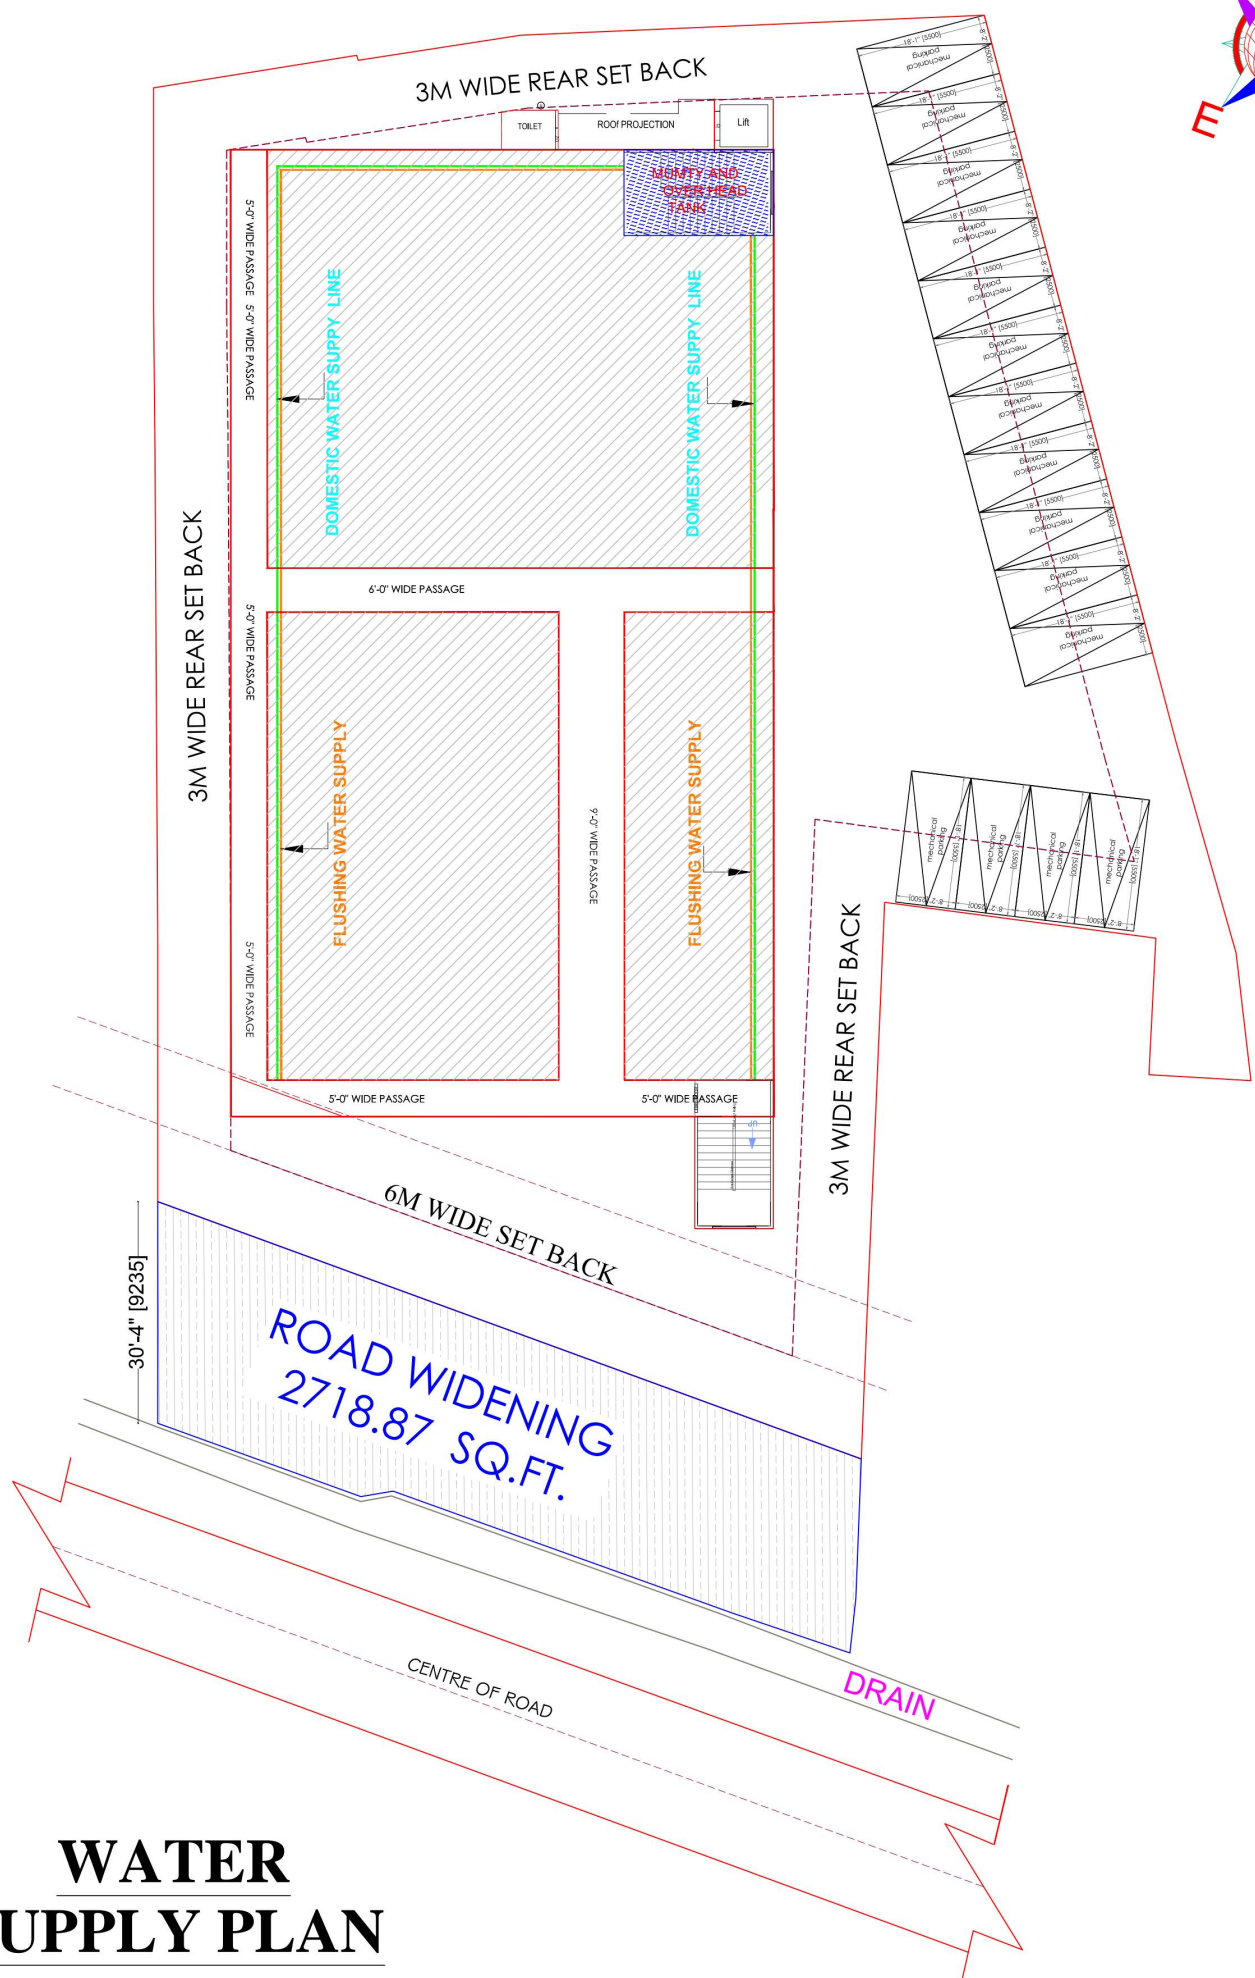



WATER SUPPLY PLAN

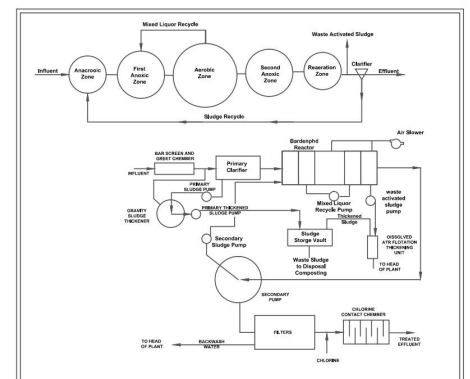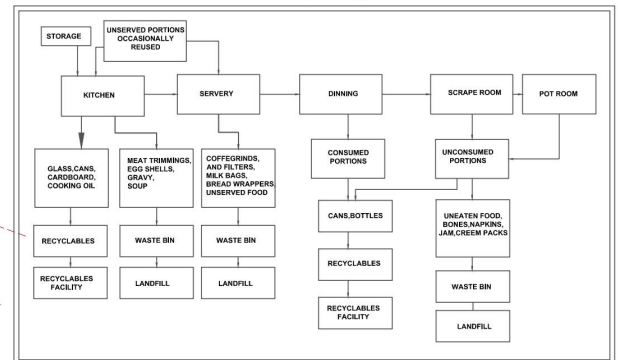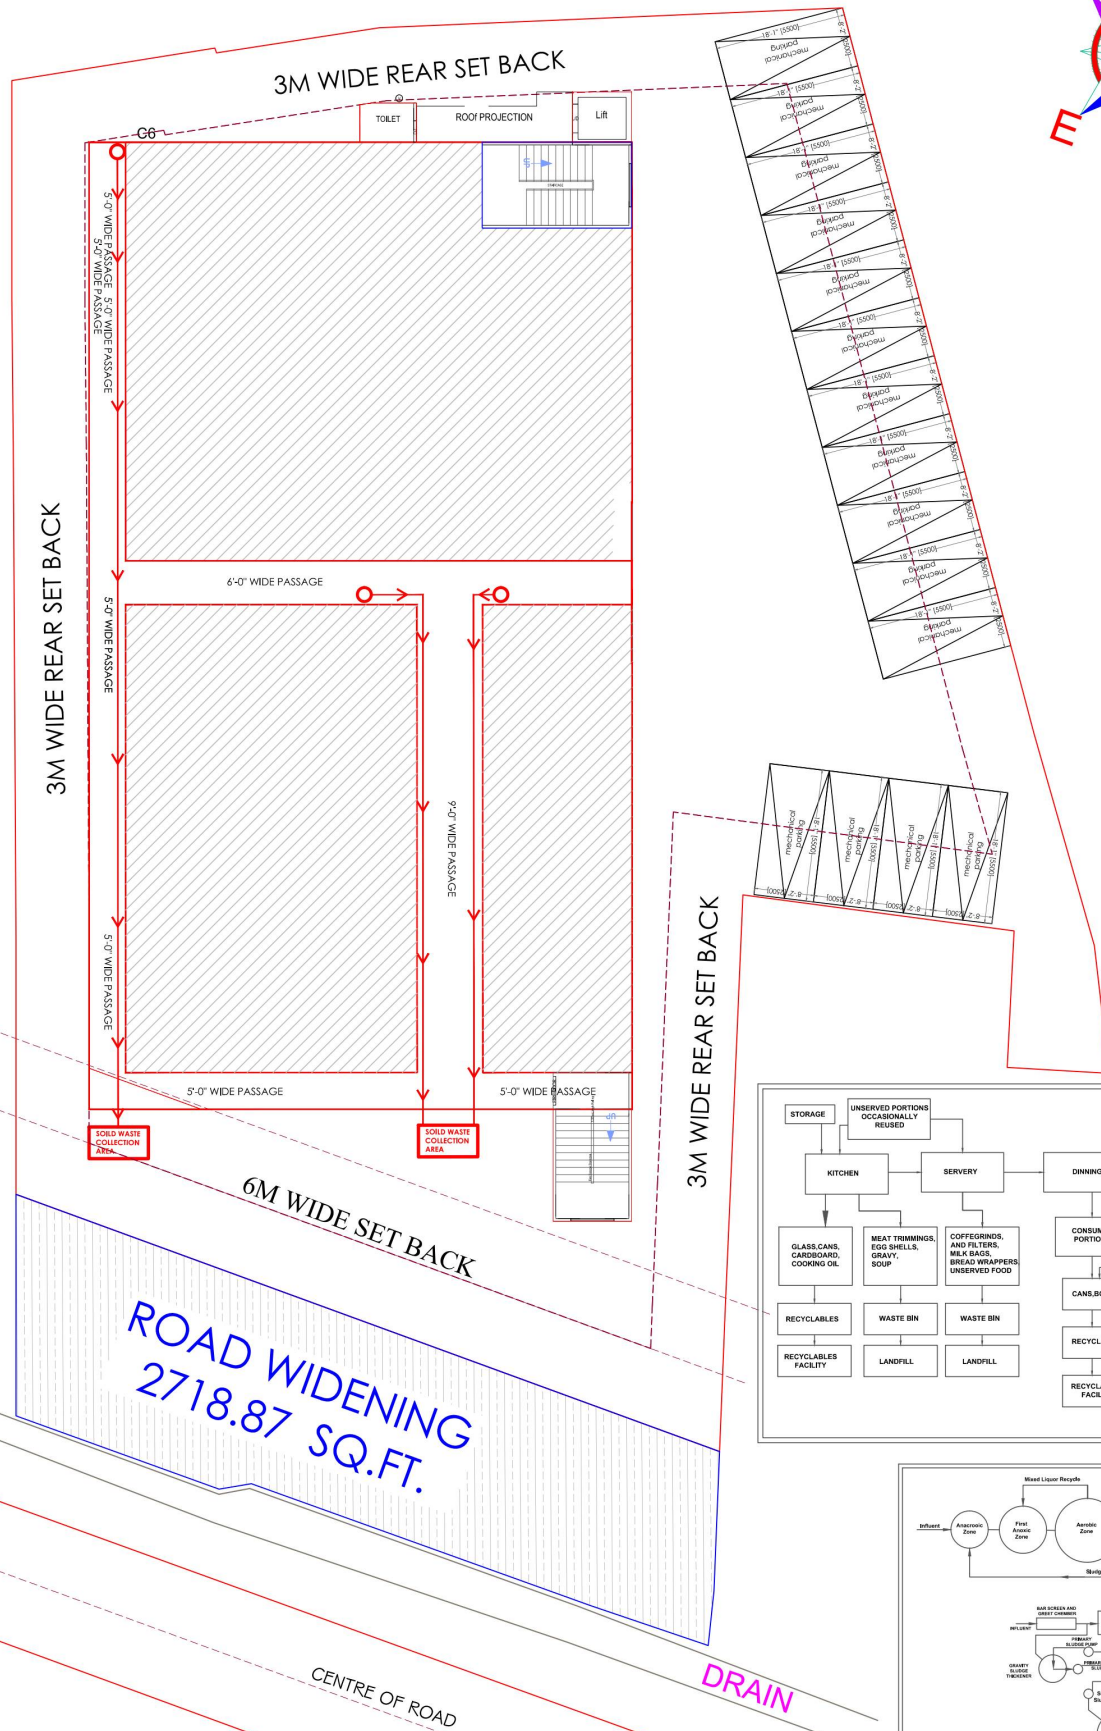

LEGEND :



	DUSTBIN ON EACH FLOOR(TYPICAL)
	WASTE EXIT PATH

SOLID WASTE MANAGEMENT PLAN

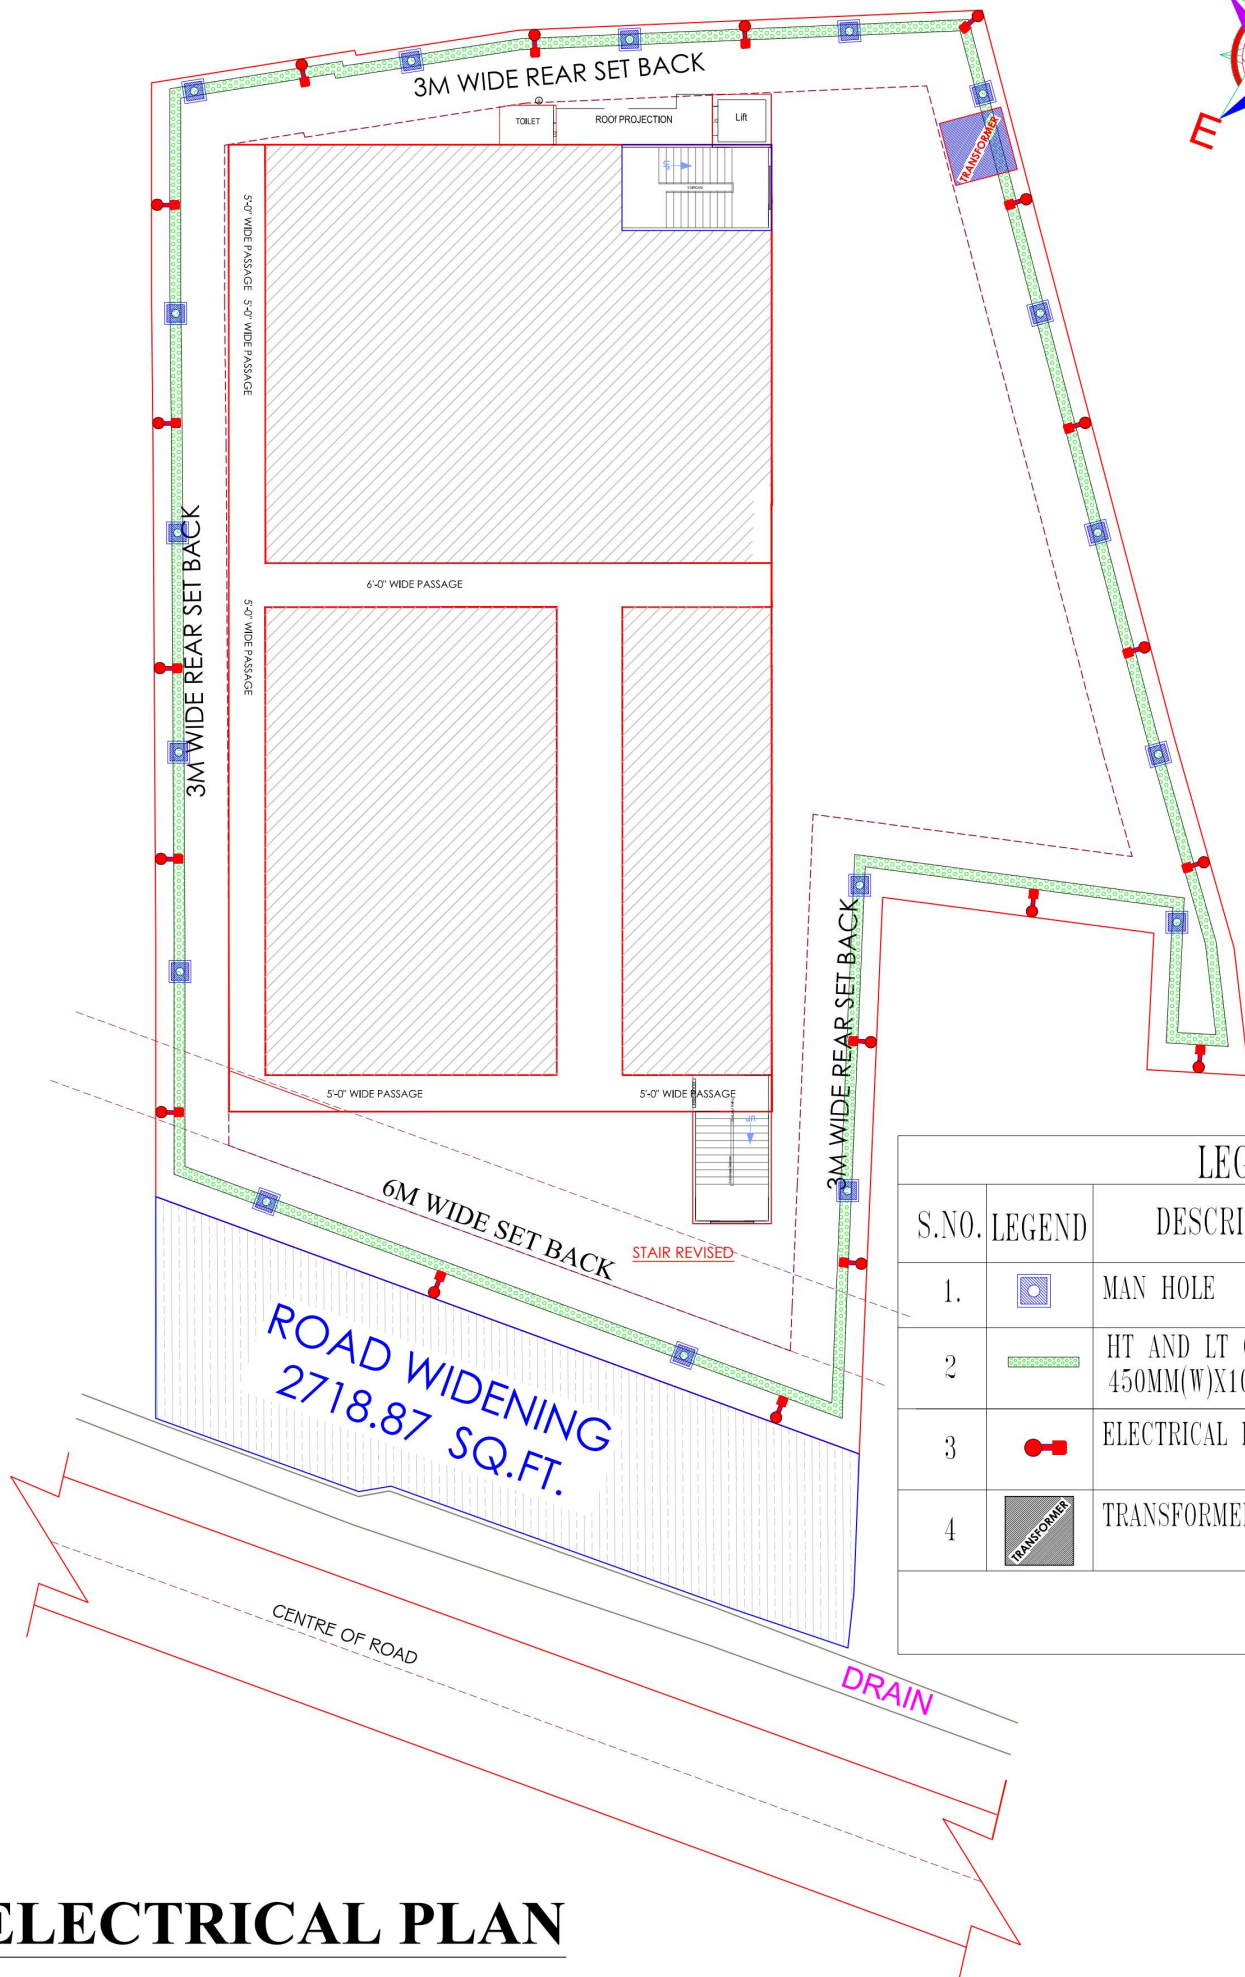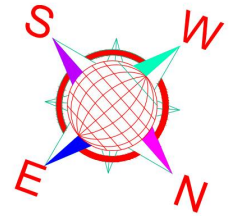

LEGEND		
S.NO.	LEGEND	DESCRIPTION
1.		MAN HOLE
2		HT AND LT CABLE TRENCH 450MM(W)X1000MM(D)
3		ELECTRICAL POLE
4		TRANSFORMER

ELECTRICAL PLAN

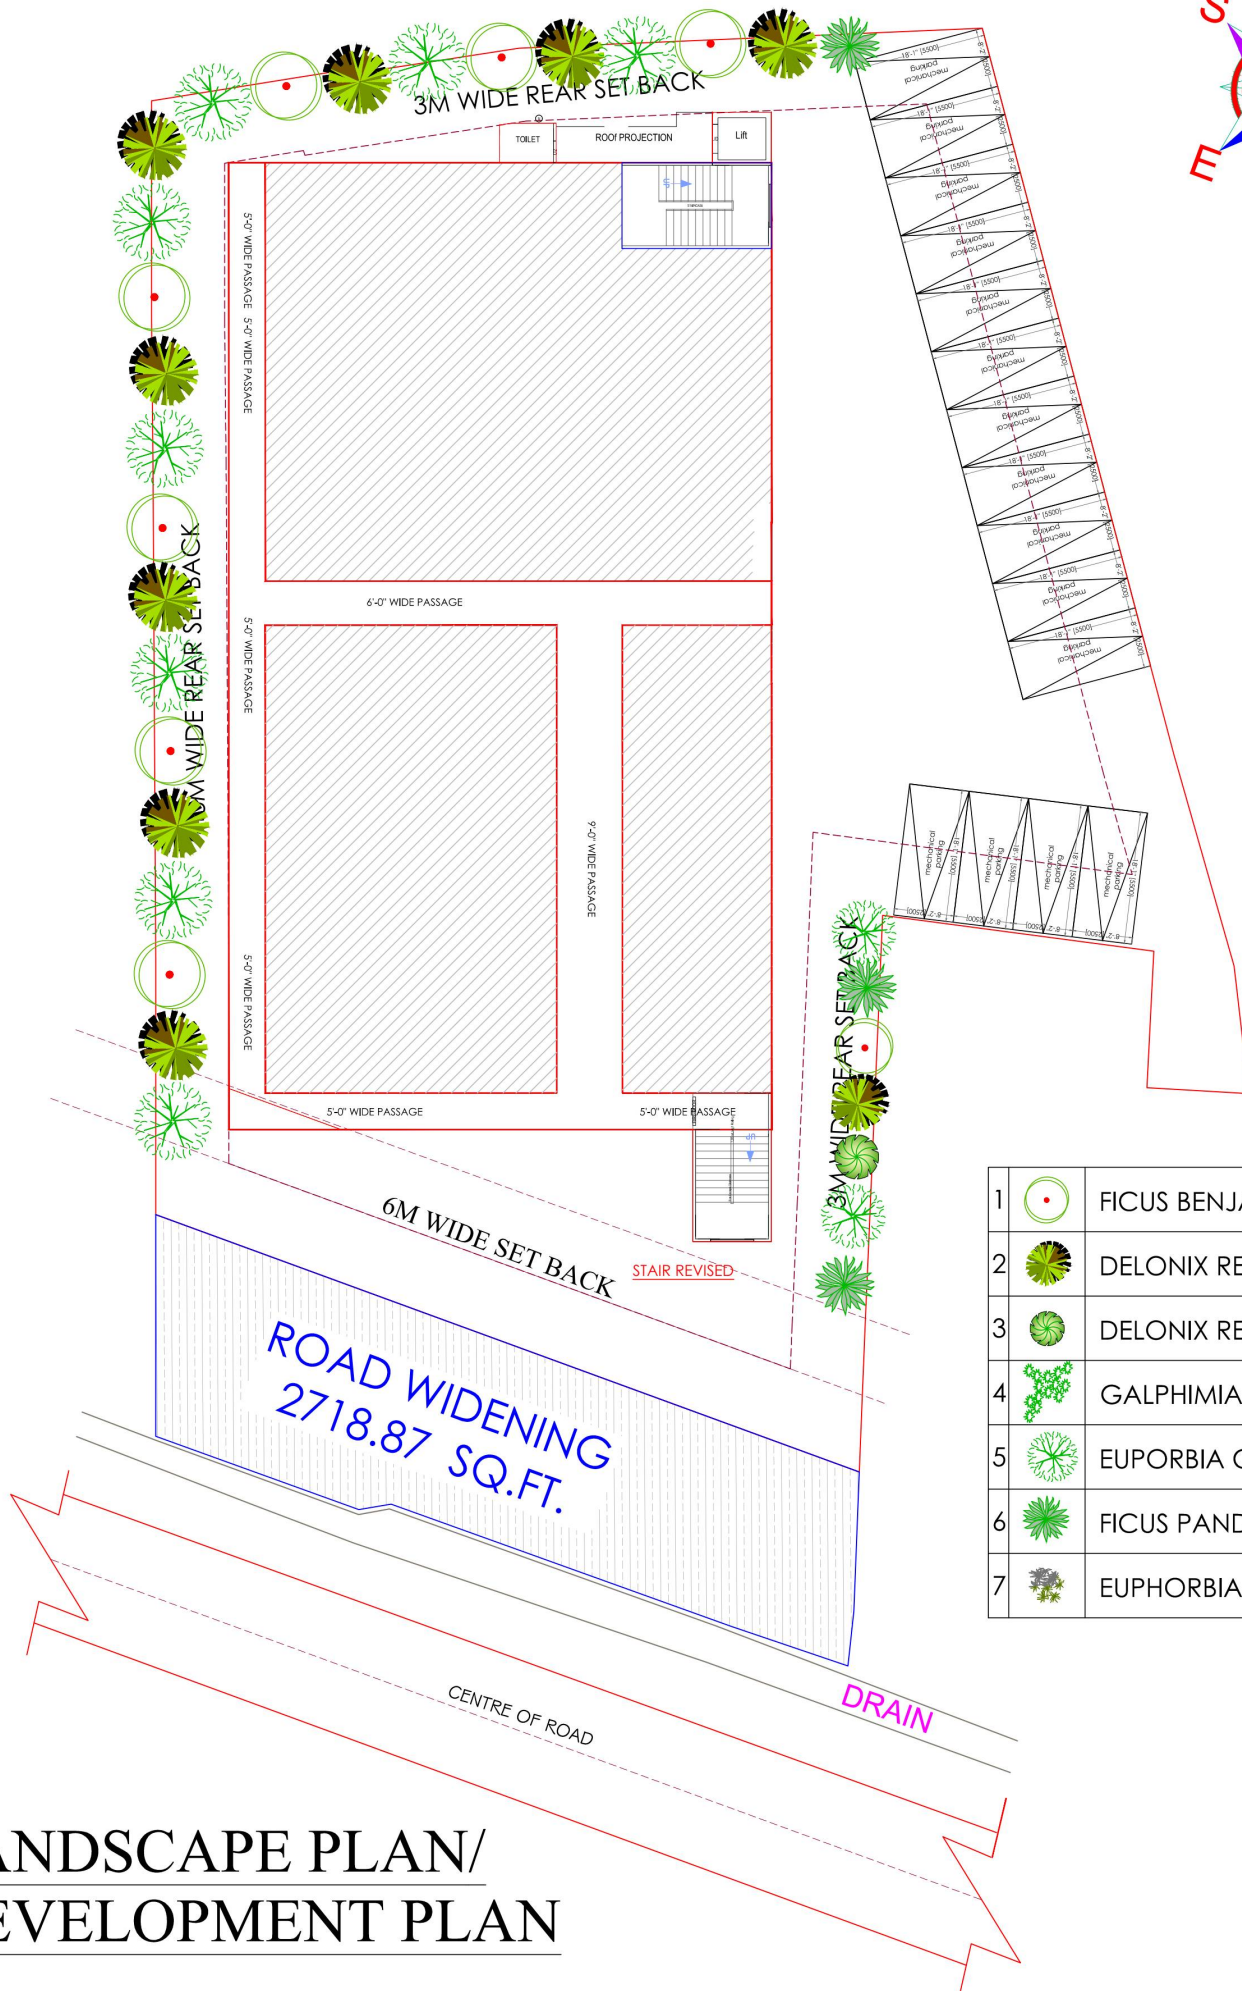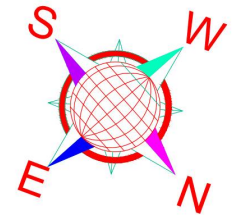

1		FICUS BENJAMINA-2
2		DELONIX REGIA
3		DELONIX REGIA-YELLOW
4		GALPHIMIA GRACILIS
5		EUPORBIA COTONIFOLIA
6		FICUS PANDA BALL
7		EUPHORBIA MILI

LANDSCAPE PLAN/ DEVELOPMENT PLAN