



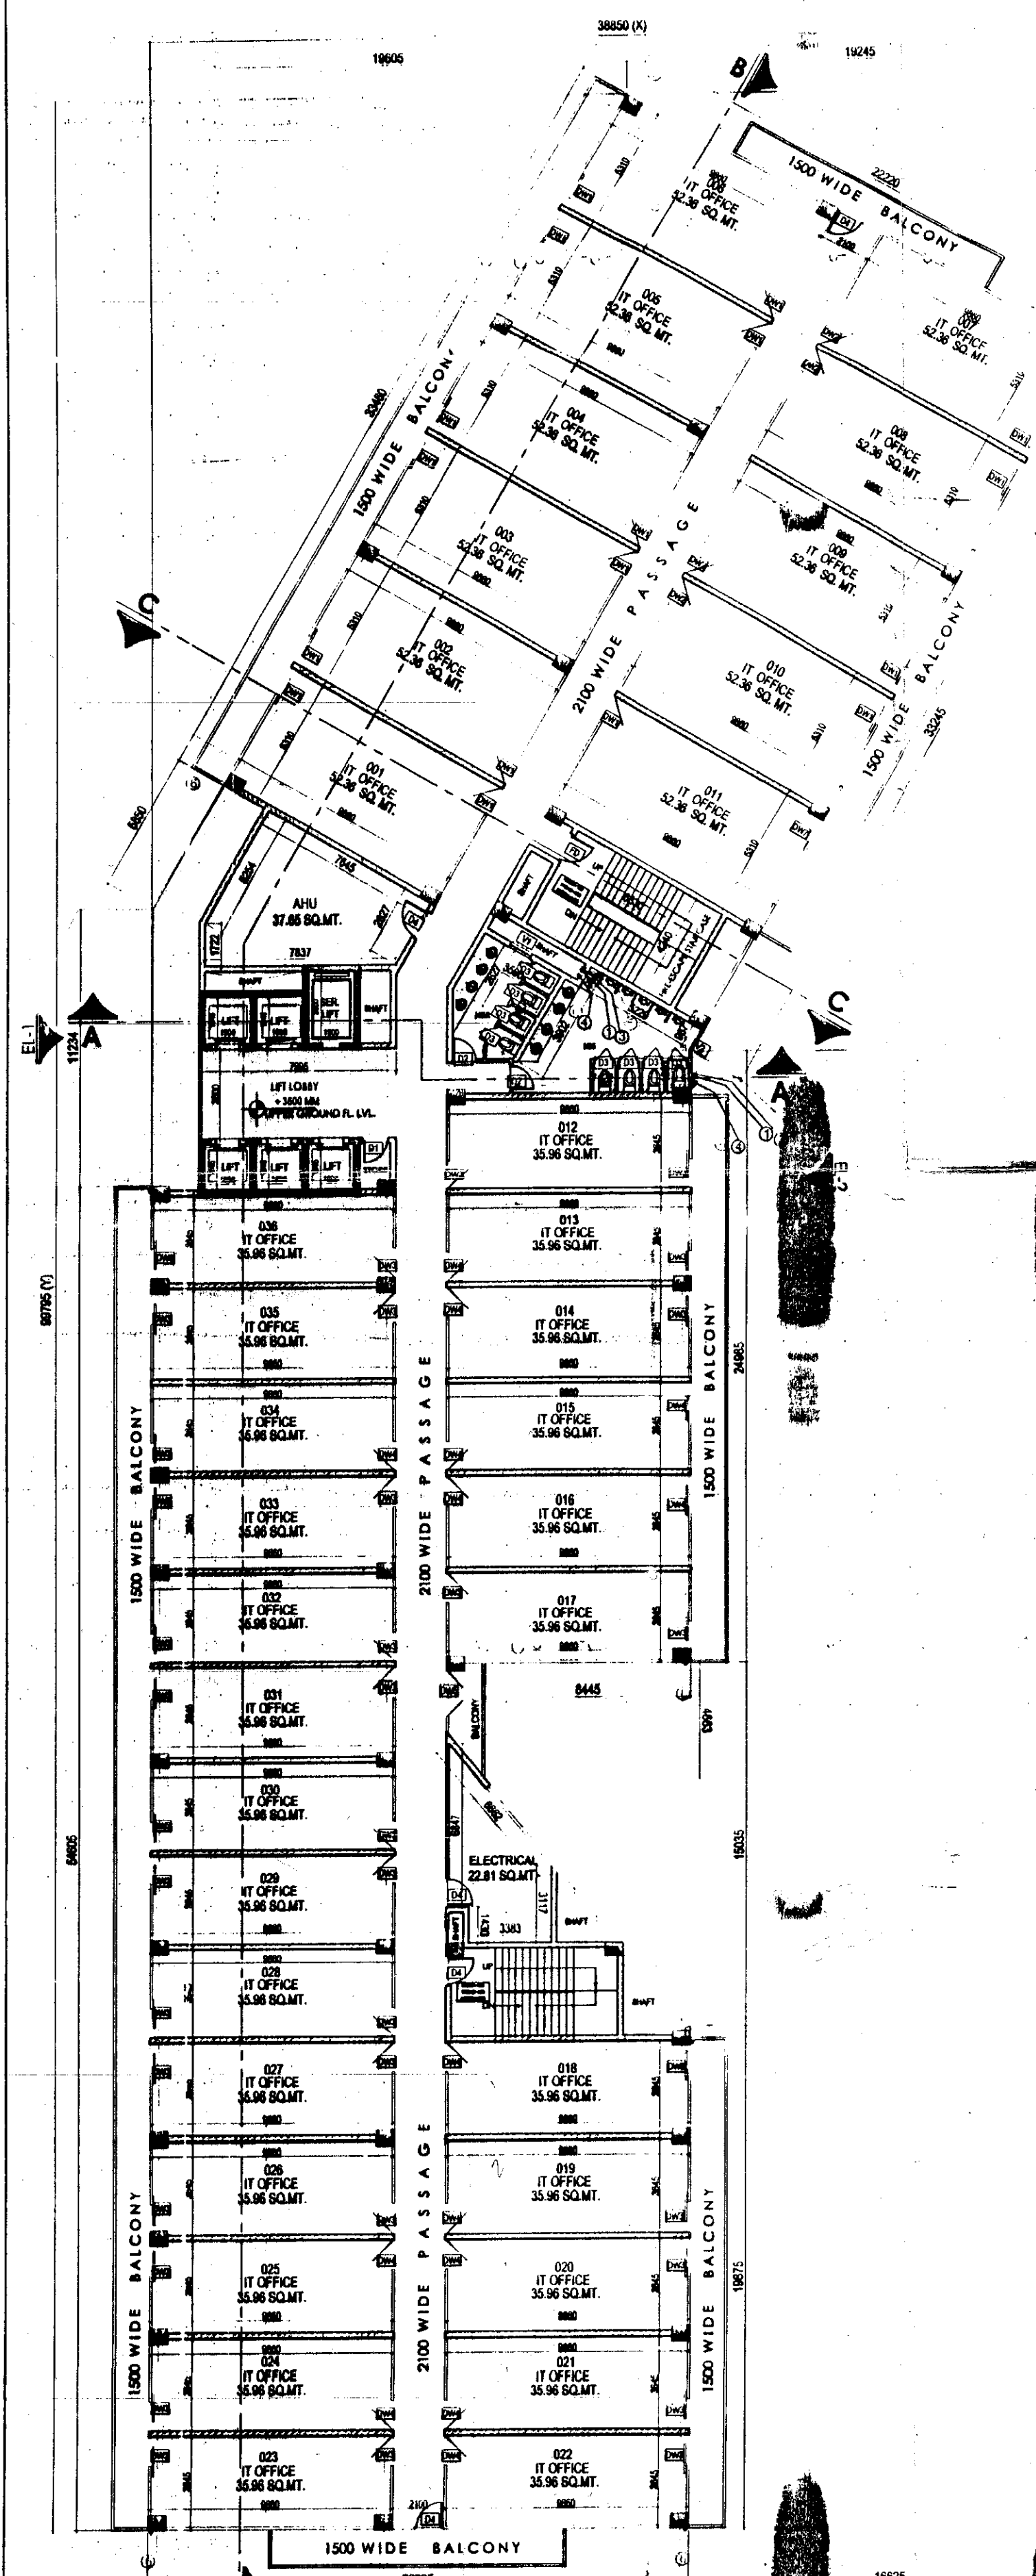

TYPICAL 1ST, 2ND, 3RD, 8TH, 9TH & 10TH FLOOR PLAN

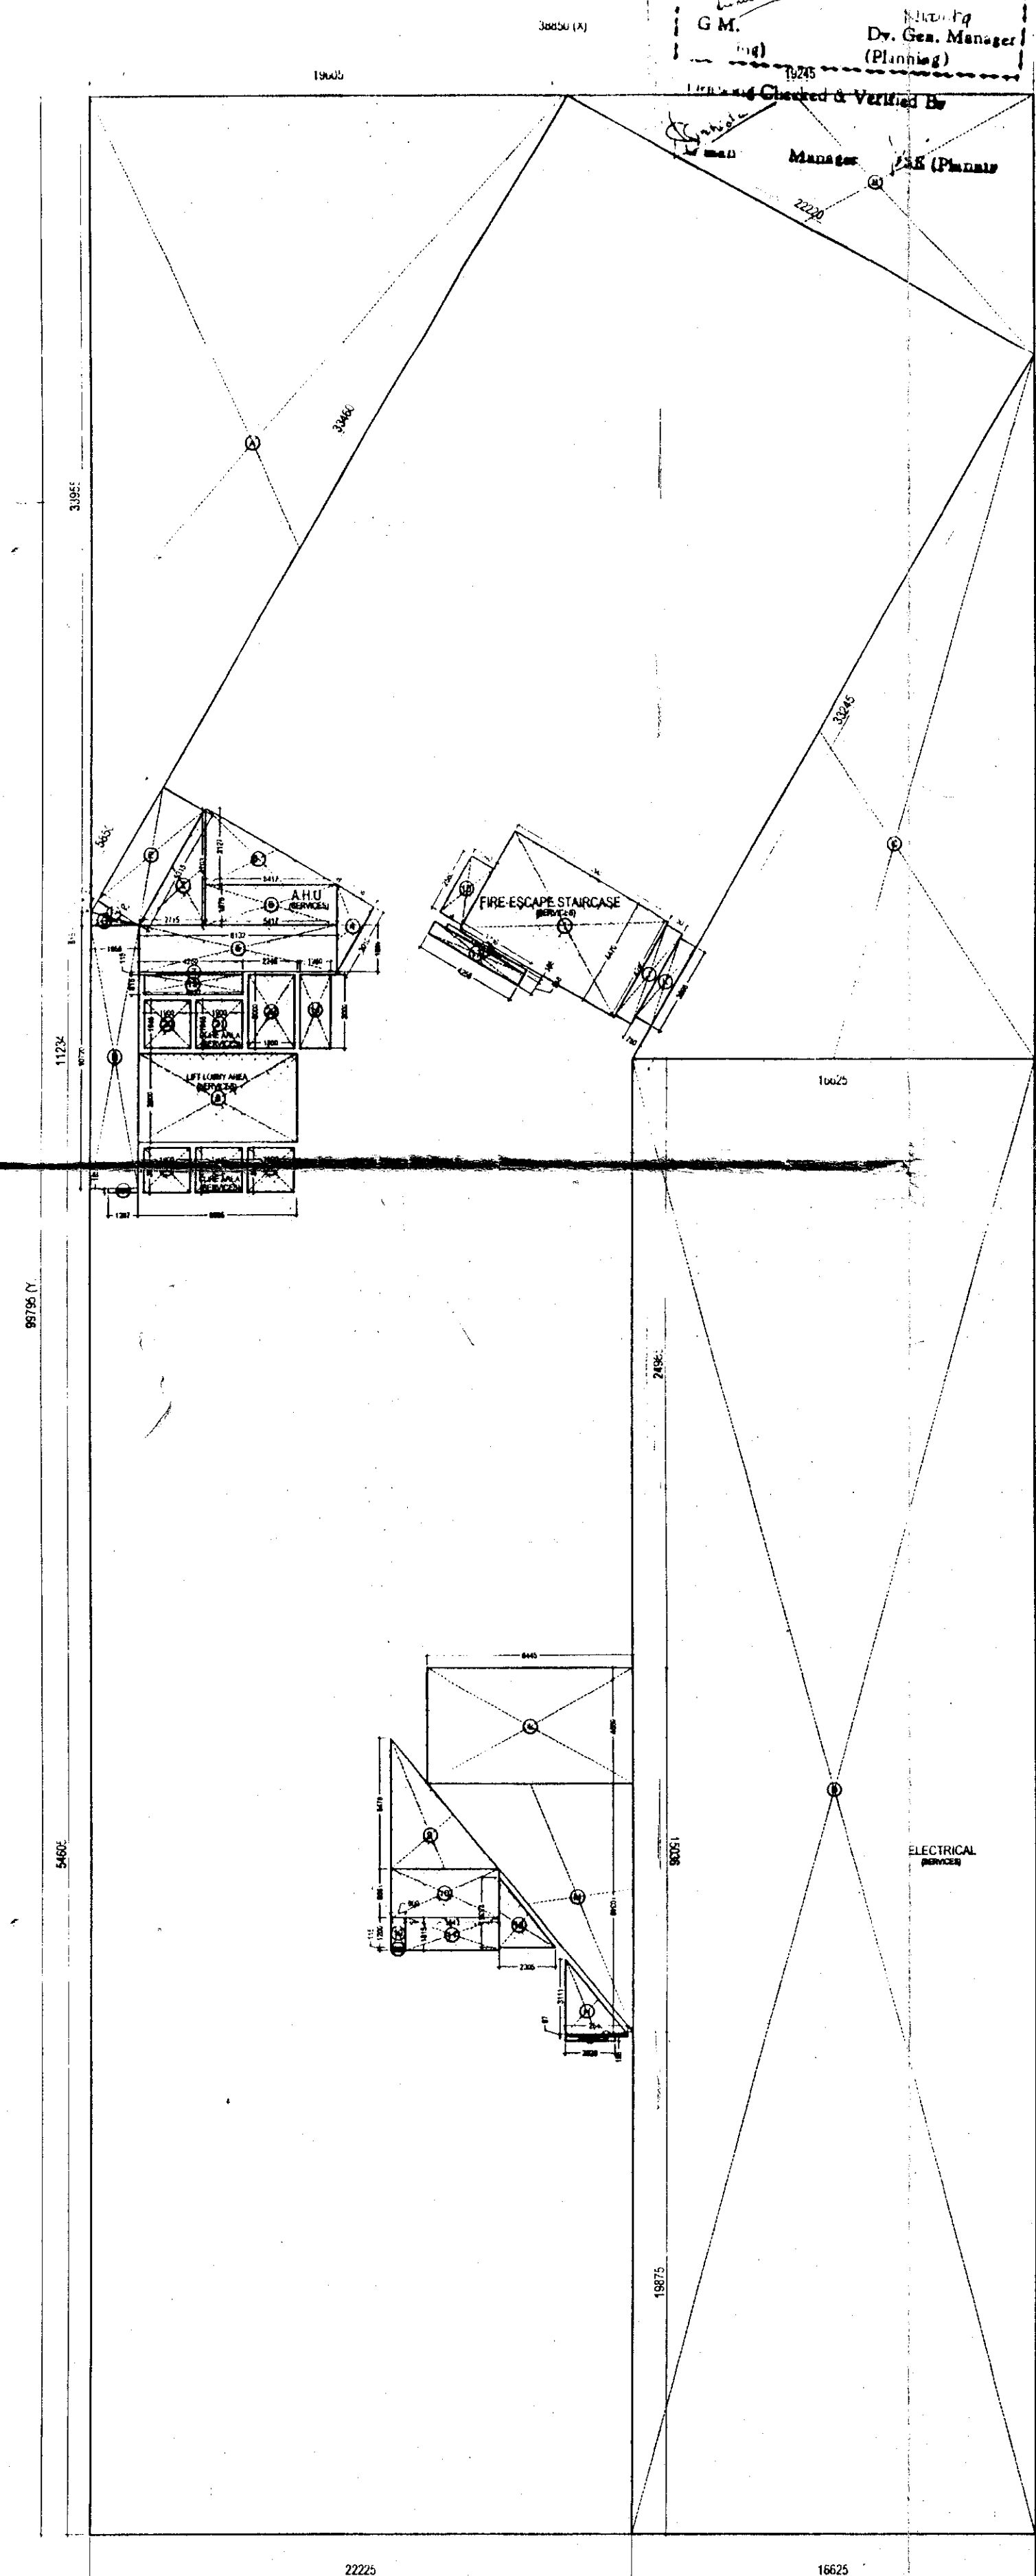

TYPICAL 1ST, 2ND, 3RD, 8TH, 9TH & 10TH FLOOR AREA DIG.

Greater Noida Industrial Dev. Authority
APPROVED
Date: 18/11/2015
By: Dr. Gen. Manager (Planning)
G.M.
Manager

TYPICAL 1ST, 2ND, 3RD, 8TH, 9TH & 10TH FLOOR AREA CHART
 $X \times Y = 38.850 \times 99.795 = 3877.0357$

DEDUCTIONS				
SR.NO.	L1	L2	DIVIDED BY	AREA (SQ.MT.) L1X L2
A	19.605	33.955	2	332.8439
B	19.245	11.110	2	106.9060
C	16.625	28.790	2	239.3169
D	16.625	59.895		995.7544
E	1.952	5.315		10.375
F	1.952	0.534	2	0.521
G	1.956	0.515	2	0.504
H	1.956	10.720		20.968
I	1.207	0.185		0.223
J	4.240	0.750		3.18
K	3.698	0.750		2.774
L	8.445	4.689		39.599
M	8.445	10.349	2	43.699
N	2.540	3.111	2	3.951
O	2.540	0.097		0.246
P	2.020	0.185		0.374
TOTAL DEDUCTION 'Z'				1801.2343

TYPICAL 1ST, 2ND, 3RD, 8TH, 9TH & 10TH FLOOR AREA
 $= (X \times Y) - 'Z'$
 $(3877.0357 - 1801.2343) = 2075.8014$ SQ.MT.

TOTAL AREA = 2075.8014 - (A)
 $= 2075.8014 - 164.403$
 $= 1911.3984$ SQ.MT.

TOTAL SERVICE AREA

SR.NO.	L1	L2	DIVIDED BY	AREA (SQ.MT.) L1X L2
1	4.470	7.290		32.586
2	2.715	4.703	2	6.384
3	5.417	1.576		8.537
4	1.738	3.010	2	2.616
5	8.132	1.899		15.443
6	3.127	5.417	2	8.469
7	4.260	0.115		0.490
8	6.505	3.500		22.768
9	4.443	5.478	2	12.169
10	4.443	1.998		8.877
11	3.843	1.315		5.054
12	0.600	0.115		0.069
13	4.032	0.815		3.286
14	1.260	3.000		3.78
15	2.580	1.040		2.683
16	0.186	3.736		0.695
17	0.548	4.256		2.332
18	2.305	2.835	2	3.267
19	0.600	1.200		0.720
20	1.900	1.945		3.696
21	1.900	1.945		3.696
22	1.900	3.000		5.700
23	1.900	1.945		3.696
24	1.900	1.945		3.696
25	1.900	1.945		3.696
TOTAL SERVICE AREA (A)				164.403

TOWER - 1

DOORS/WINDOWS SCHEDULE


SR. NO.	TYPE	WIDTH	LINTEL	CILL
1	D1	1000	2400	00
2	D2	990	2400	00
3	D3	750	2400	00
4	D4	1200	2400	00
5	D5	1799	2400	00
6	FD	1200	2400	00
7	DW1	4825	3250	00/00
8	DW2	5310	3250	00/00
9	DW3	3465	3250	00/00
10	DW4	3645	3250	00/00
11	DW5	2415	3250	00/00
12	DW6	3240	3250	00/00
13	DW7	4940	3250	00/00
14	V1	1000	2400	1200
14	V2	840	2400	1200

PLUMBING LEGENDS

- 1 - 100 MM DIA SOIL WASTE PIPE
- 2 - 100 MM DIA UPPIPE
- 3 - 75 MM DIA UPPIPE
- 4 - 50 MM DIA UPPIPE
- 5 - 65.50 MM DIA DOWN PIPE
- 6 - 150 MM DIA RAIN WATER PIPE

PROJECT
PROPOSED DEVELOPMENT FOR PLOT
MEASURING 24.715 ACRES IN SECTOR-
TECH ZONE - 4, PLOT NO.-17
GREATER NOIDA.
BEING DEVELOPED BY M/S S.P.Sai IT
Pvt. Ltd.

KEY PLAN

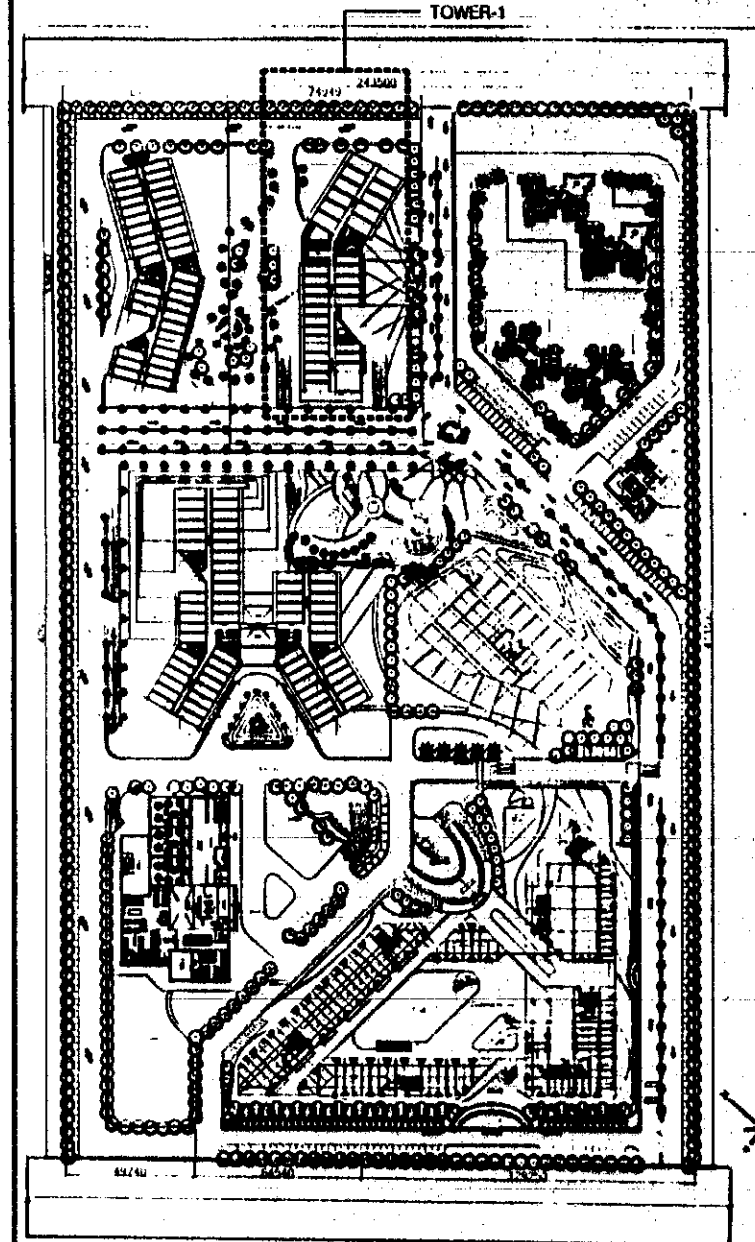

REVISION	SCALE	NORTH
R3	1:150	

DRAWING NO.
1039/60/SUB/IT-T1/PLAN/02

FOR SP SAI IT PVT. LTD.
Authorised Signatory

OWNER'S SIGNATURE
ASOK KUMAR BANSAL
PRAJNATI ARCHITECT
25/5/15461

ARCHITECT'S SIGNATURE

DRAWING
TYPICAL 1ST, 2ND, 3RD, 8TH, 9TH & 10TH FLOOR PLAN
& AREA CALCULATION
IT - T 1

DRAWN BY: DOLLY SINGH

ACPL ISO 9001:2008
Architecture
Management
Planning
ACPL Design Ltd
J-103 South Extension-I
New Delhi-110048 India
T: +91 11 26422100
F: +91 11 26422100
E: dolly@acpldesign.com
www.acpldesign.com