
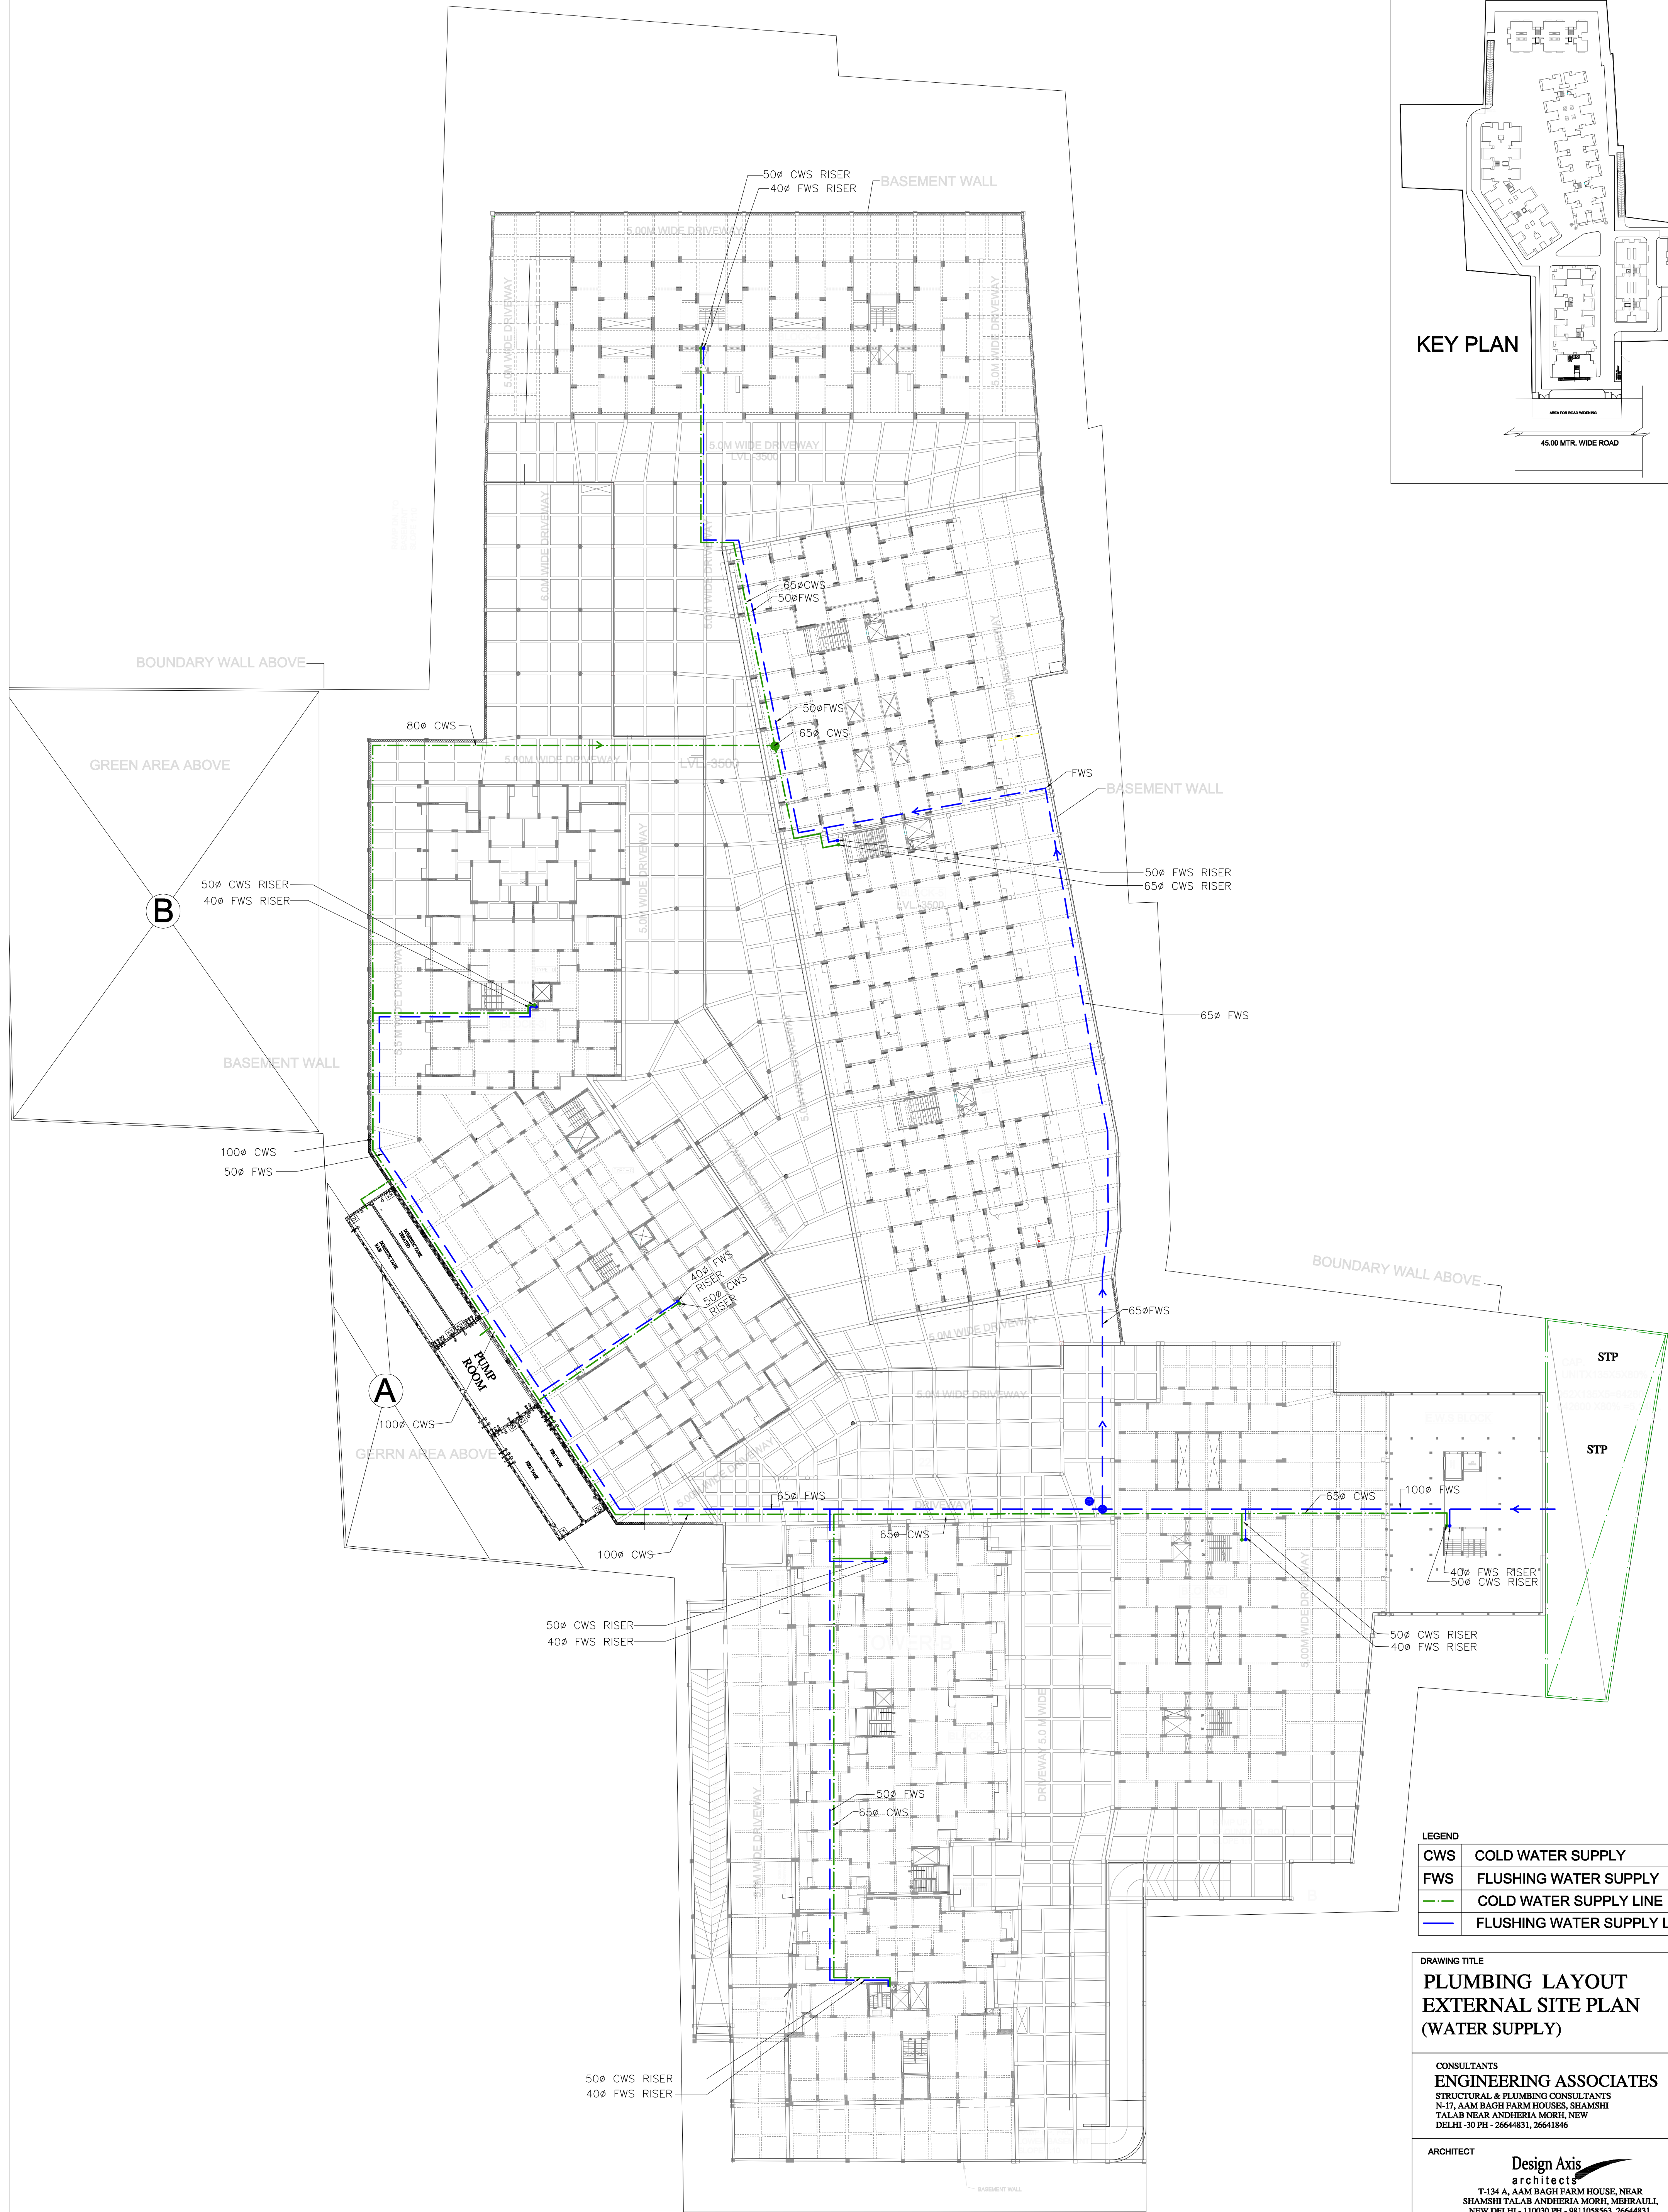


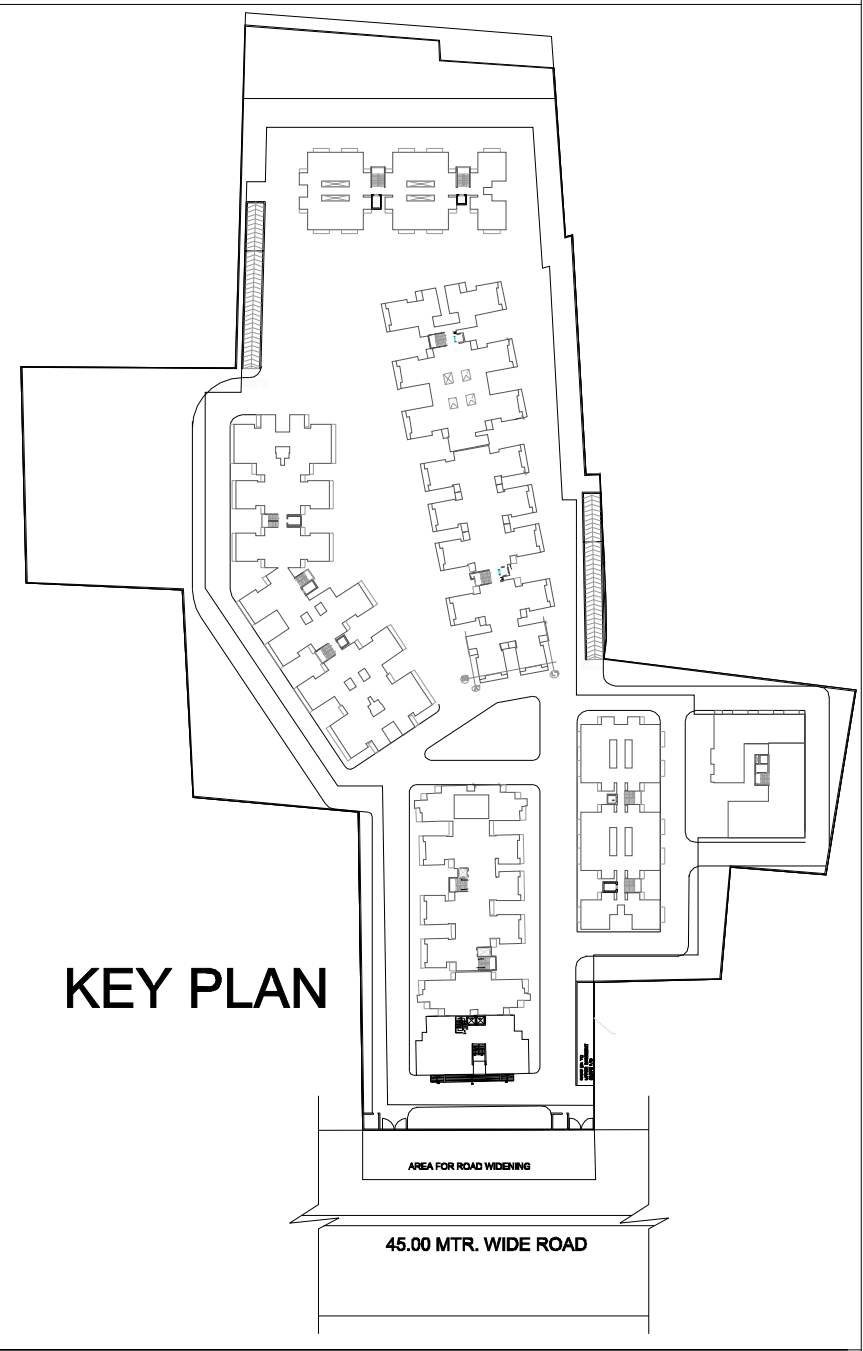

LEGEND	
CWS	COLD WATER SUPPLY
FWS	FLUSHING WATER SUPPLY
—	COLD WATER SUPPLY LINE
—	FLUSHING WATER SUPPLY LINE

DRAWING TITLE
**PLUMBING LAYOUT
EXTERNAL SITE PLAN
(WATER SUPPLY)**

CONSULTANTS
ENGINEERING ASSOCIATES
STRUCTURAL & PLUMBING CONSULTANTS
N-17, AAM BAGH FARM HOUSES, SHAMSHI
TALAB NEAR ANDHERIA MORH, NEW
DELHI - 50 PH - 26644831, 26641846

ARCHITECT
Design Axis
architects
T-134 A, AAM BAGH FARM HOUSE, NEAR
SHAMSHI TALAB ANDHERIA MORH, MEHRAULI,
NEW DELHI - 110030 PH - 9811058563, 26644831,
26648146 EMAIL - vitresh@hotmail.com

SCALE	NTS	DRG. NO.
DATE	APRIL, 2018	PL/EXT/WS/02
DEALT	Abinash	CHECKED P.K