

WATER TANK BELOW

S.T.P BELOW

ESS

PLUMBING LEGEND:-	
	SEWER MANHOLE WITH 5600 MANHOLE COVER
	STORM WATER MANHOLE WITH 5600 PERFORATED MANHOLE COVER.
	STORM WATER CATCH BASIN SIZE=(600x600)MM
	STORM WATER CATCH BASIN SIZE=(800x900)MM
	EXTERNAL FIRE HYDRANT



PLUMBING LEGEND:-	
	GARDEN HYDRANT
	EXTERNAL SEWER LINE
	EXTERNAL STORM WATER LINE
	DOMESTIC WATER SUPPLY LINE FROM MUNICIPAL / TANKER LINE.
	IRRIGATION WATER SUPPLY LINE

	TUBE WELL WATER SUPPLY LINE
	EXTERNAL FIRE HYDRANT LINE
	R.P. RECHARGE PIT (3000 MM DIA)
	D.C. DESILTING CHAMBER (1000 x 2000 MM DIA)
	VALVE WITH CHAMBER
	NON RETURN VALVE WITH CHAMBER

PLUMBING LEGEND:-

RAIN WATER HARVESTING

SPACE FOR SOLAR PANEL

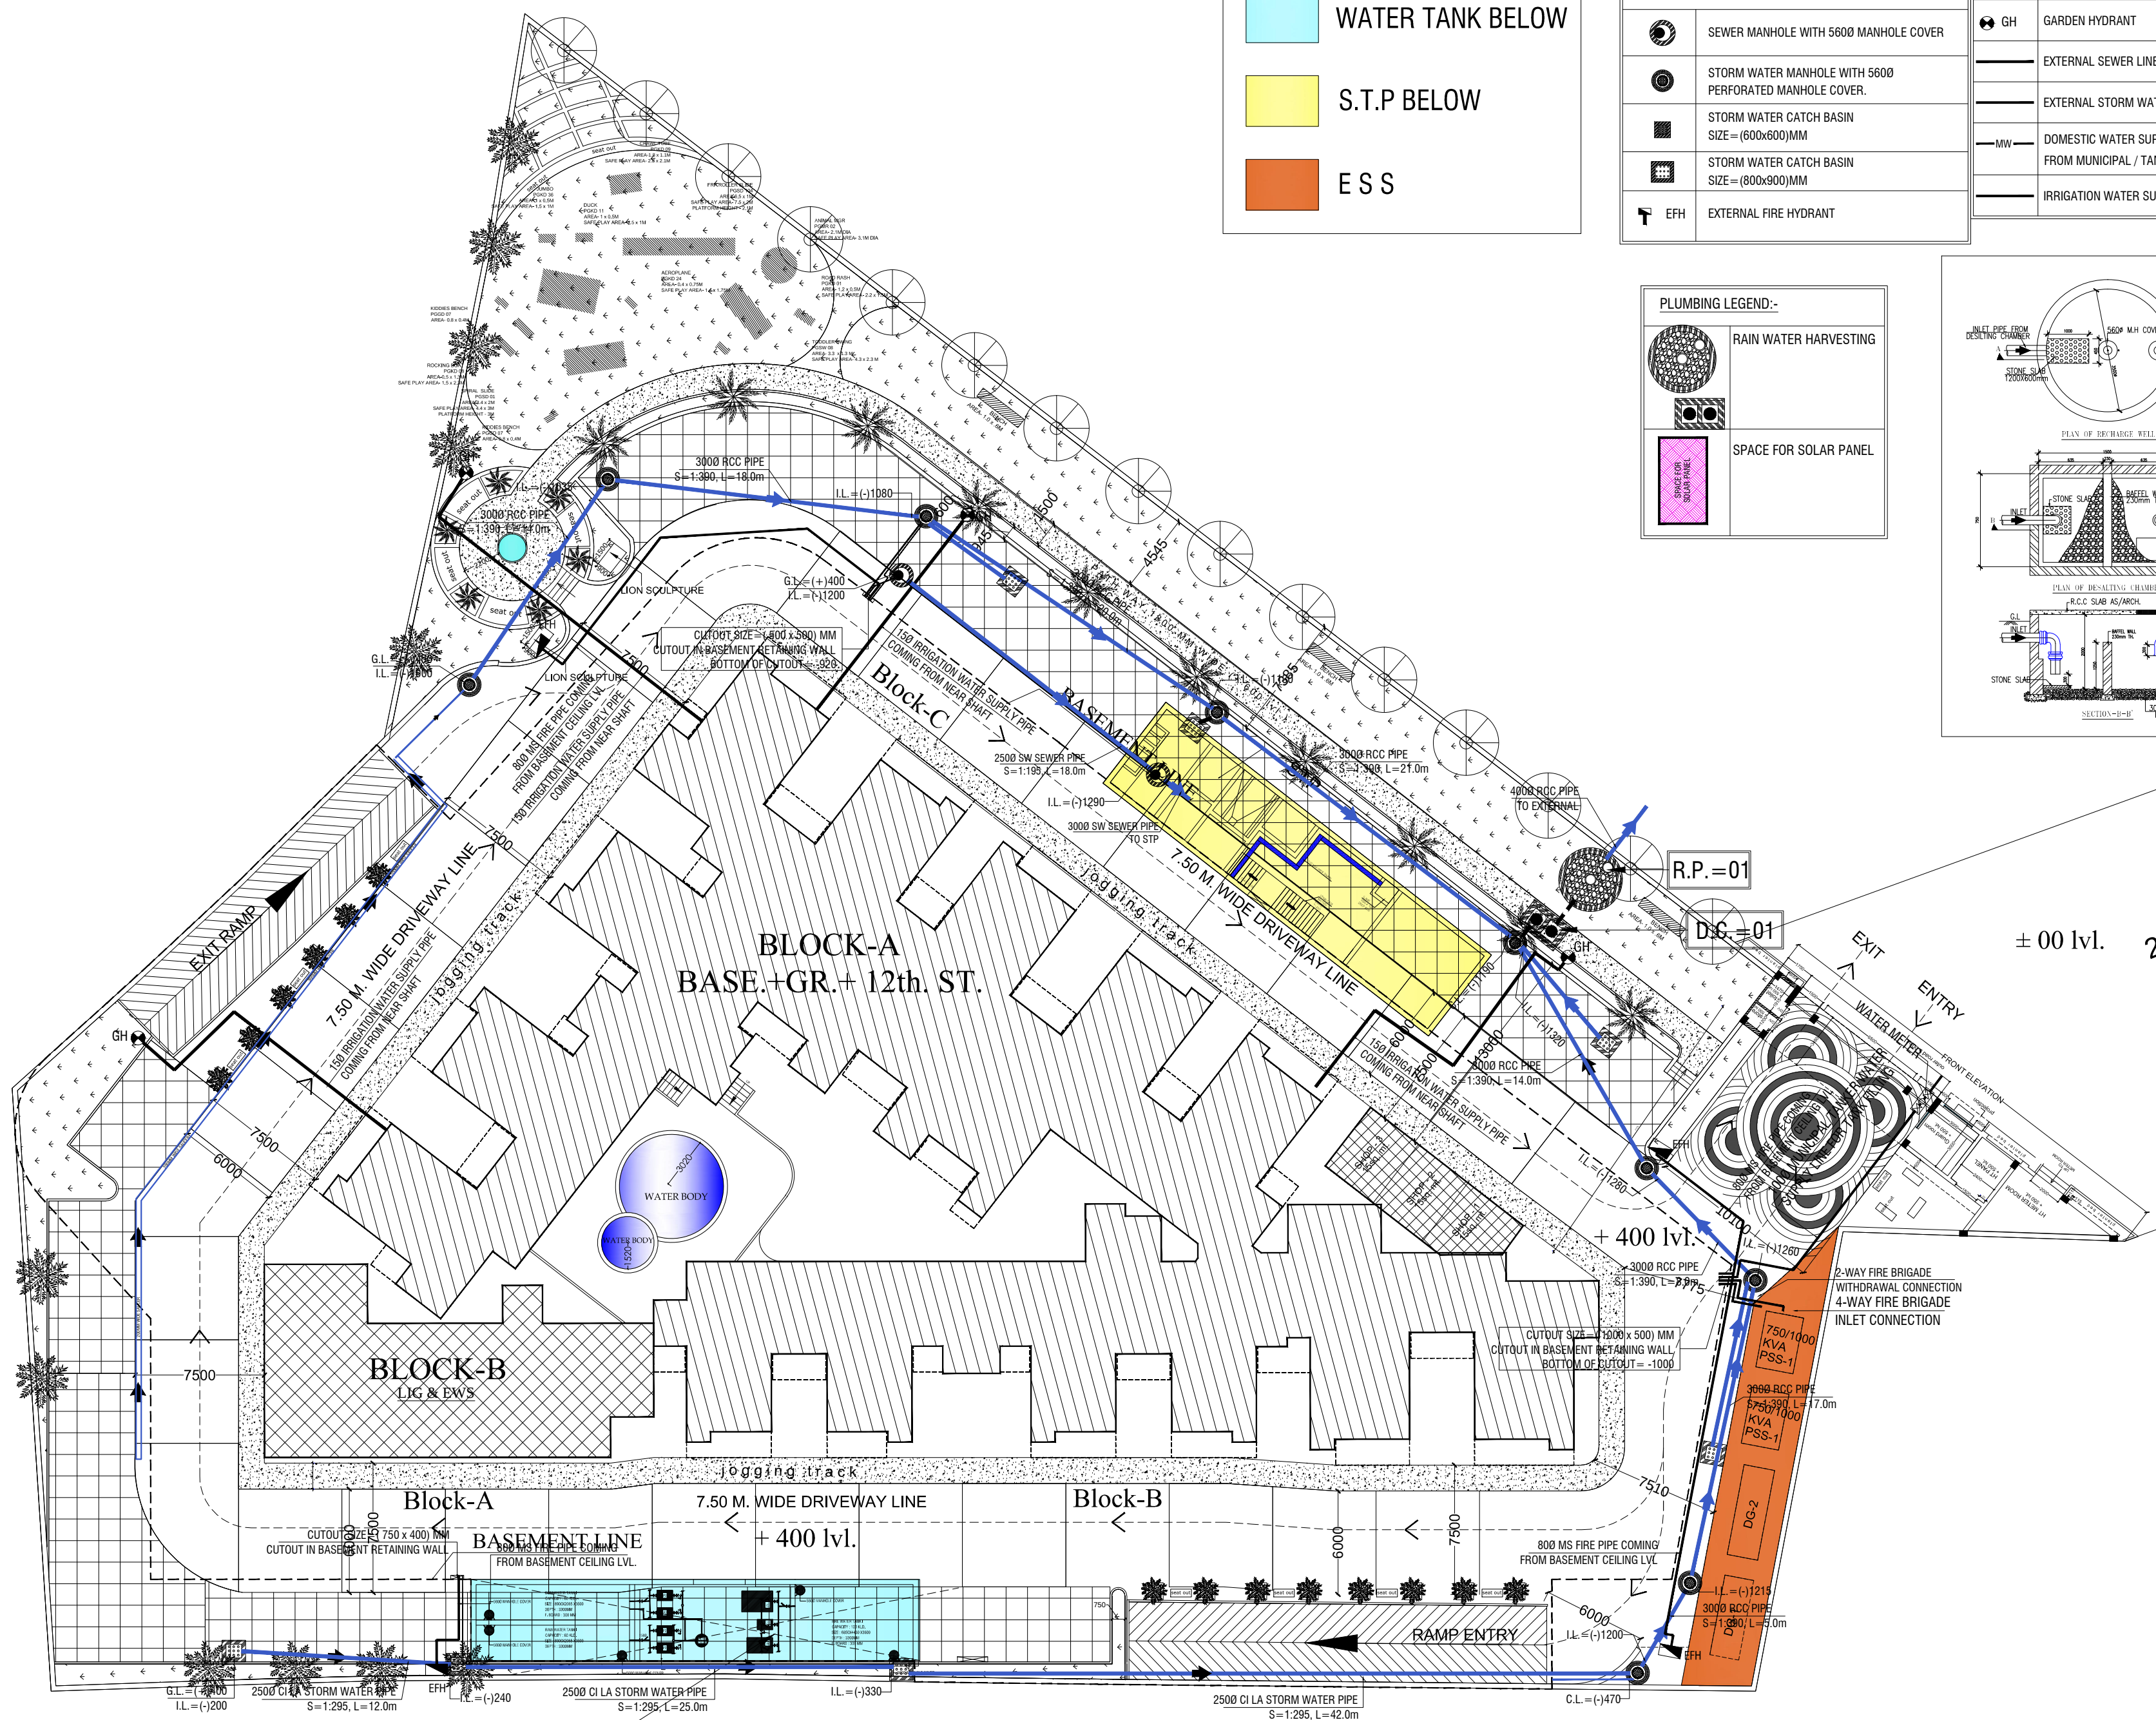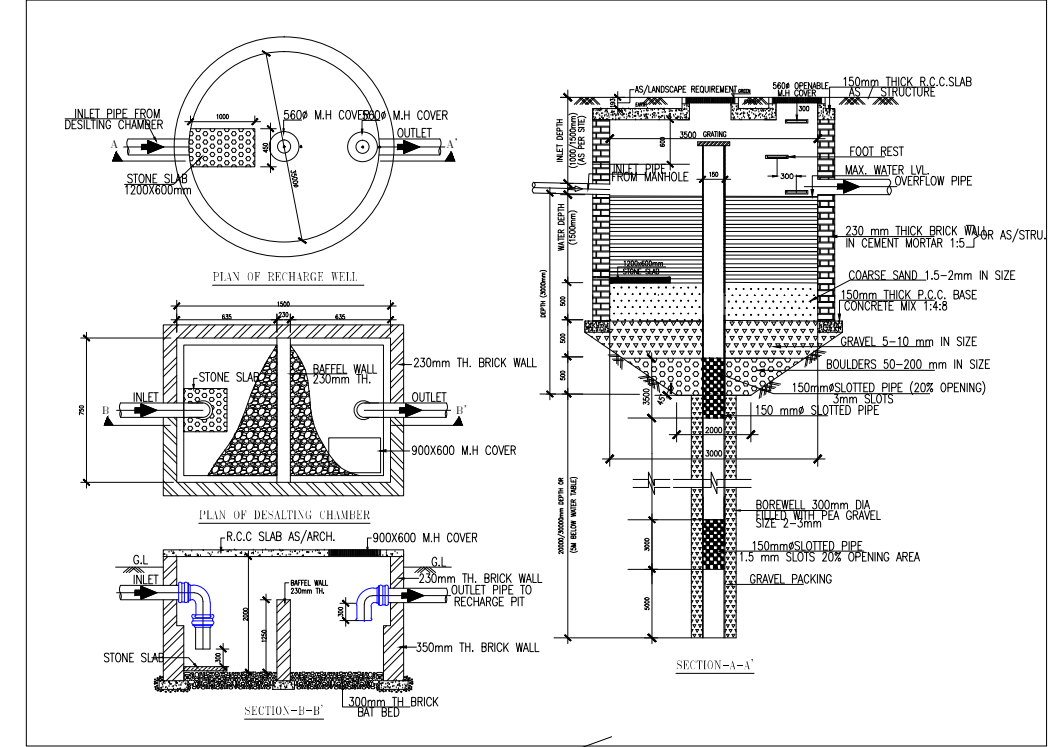

PROJECT:-
DRAWINGS FOR AFFORDABLE GROUP HOUSING
AT KHASRA NO. 1140,1142,1166 & 1167 AT VILLAGE DASNA
PARGANA DASNA TEHSIL GHAZIABAD (U. P.)

OWNER:-
M/s. A.P.G. MACHINES & METAL TRADING P. LTD.
SIGN. AUTHORITY:
DEVENDAR SINGH

DRAWING TITLE:-
EXTERNAL SERVICE PLAN

OWNER'S SIGN

ARCHITECT'S SIGN.

ANUJ AGARWAL ARCHITECTS
OFFICE:- A-244 KAUSHAMBI GHAZIABAD (U.P.)
Ph:-0120 - 6454182 , 4165712, TEL. FAX - 2773592
e-mail : arch.anujagarwal@gmail.com

SCALE	N.T.S.	DEALT BY	DATE
DESIGN BY	CHECKED BY	DRG. No.	DG-02