


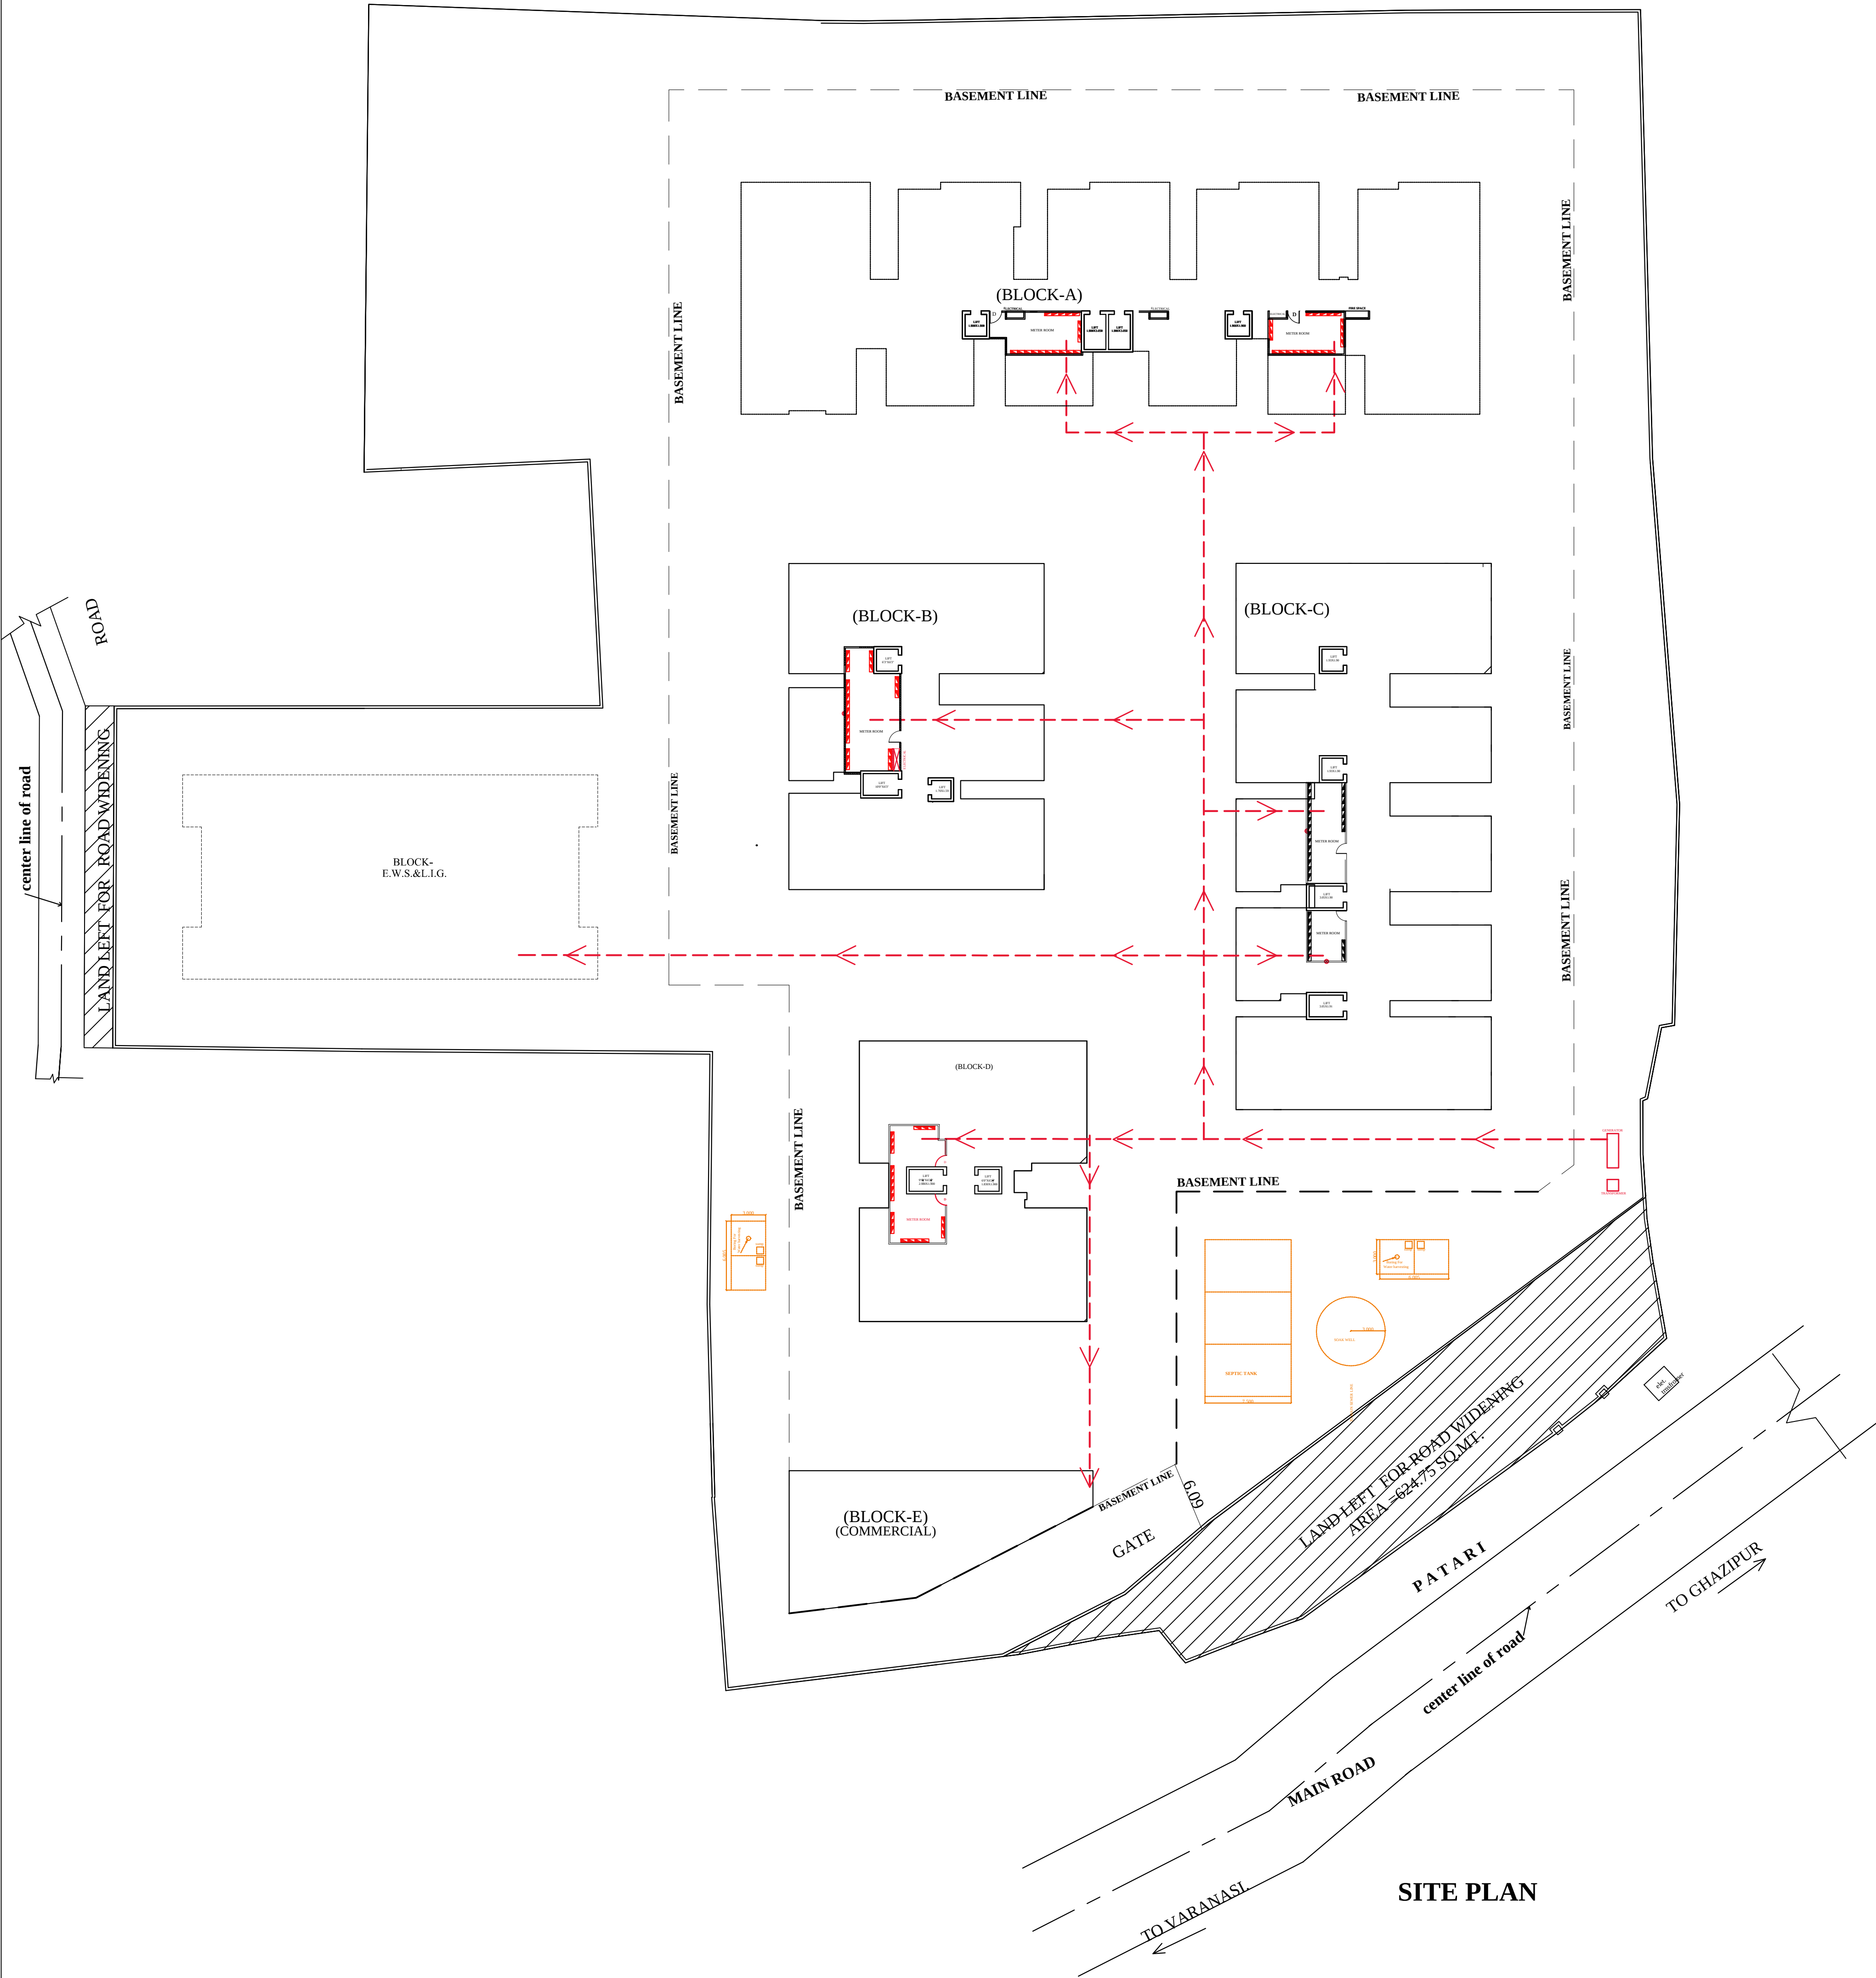

PROPOSED ORBIT CITY PLAN FOR ASHAPUR
MAUZA- HIRAMANPUR, PARGANA- SHIVPUR,
TEHSIL & DISTT.-VARANASI.

It is hereby certified that the structural and foundation design of the building for which map and plans are submitted for approval satisfy the safety requirements as stipulated in the relevant Indian Standard Codes, National Building Code, guidelines and documents specified in Annexure - 2 of Housing Department of Government of Uttar Pradesh vide G.O. No. 5709-A-1-Bhookamp Rodhi (A.B.) dated February 3, 2001.

Note:
THIS DRAWING IS THE PROPERTY OF M.S. SRISHTI AND IS NOT TO BE COPIED OR REPRODUCED WITHOUT THEIR PERMISSION

Note : All dimensions are in meters

(1) SHREE BALAJI BUILDTECH THROUGH ITS PARTNERS
(1) SHALABI GUPTA
(2) SAMEER GUPTA BOTH SO DR. S.P GUPTA
(2) GANPATI BUILDERS & DEVELOPERS THROUGH ITS PARTNERS
(3) M/S NP HOUSING CREDIT DEVELOPMENT LTD THROUGH ITS DIRECTOR
ALOK ROY SO LATE DR. T.N ROY
(3) ARJUN KAPOOR SO SHIRANI KAPOOR

OWNER'S SIGN

(3) ALOK ROY SO LATE DR. T.N ROY
(4) ARJUN KAPOOR SO SHIRANI KAPOOR
(5) AJAY TRIVEDI SO LATE SATYA NARAYAN TRIVEDI
(6) AMIT PANDEY SO SHRI SHYAM NARAYAN PANDEY
(7) RISHI KUMAR JAINWAL SO SHRI VIJAY KUMAR JAINWAL
(8) KEDAR NATH PARIKH SO SHRI RAM GOPAL PARIKH
(9) NEEL KANT GUPTA SO LATE BIKLA NATH GUPTA

MAX-1 INFRA TECH
THROUGH ITS PARTNERS
(1) M/S NP HOUSING CREDIT & DEVELOPMENT LTD THROUGH ITS DIRECTOR
AJIT KUMAR SRIVASTAVA
SO LATE KAMALA PRASAD SRIVASTAVA
(2) ARJUN KAPOOR SO SHIRANI KAPOOR
BUILDER'S SIGN

DRG. TITLE:- ELECTRICAL PLAN
Scale: 1:100
Drawn By: RAM SAIJAN
Chd By: S.P. Dharwan
ARCHITECT'S SIGN

Project No: A.SRL/2001/2019
Dwg. No. F-7



S R I S H T I
S. CHANDRA GROUP, VARANASI - 221 002
PHONE NO. - 220000