


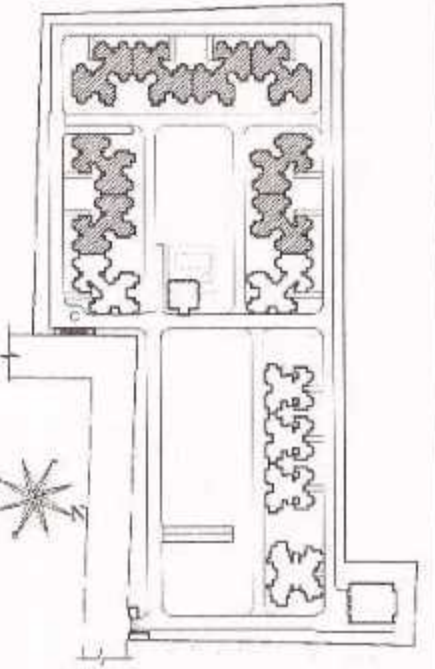

P.LIVING LEGEND:-

- ① 110mm UPVC SOIL & VENT PIPE
 ② 110mm UPVC WASTE & VENT PIPE
 ③ 50mm UPVC ANTI-SIPHONAGE PIPE
 ④ DOMESTIC WATER ON TAKE
 ⑤ FLUSHING WATER ON TAKE PIPE
 ⑥ DOMESTIC WATER RISER TO O.U.T.
 ⑦ FLUSHING WATER RISER TO O.U.T.
 ⑧ 110mm OD UPVC DRAIN PIPE FOR BALCONY & TERRACE
 ⑨ 110mm OD UPVC DRAIN PIPE FOR TERRACE

FD FLOOR DRAIN

FT FLOOR TRAP

NOTES ON FIRE-FIGHTING:-

1. EVERY FIRE FIGHTING FOLLOWING AS PER IS STANDARDS:-
 (A) 150MM FIRE HYDRANT PIPE
 (B) 150 MM SPRINKLER PIPE
 (C) 150 MM DRAIN PIPE

ARCHITECTS:

GIAN P. MATHUR & ASSOCIATES PVT.LTD.
 ARCHITECTS, ENGINEERS & PLANNERS
 C-55, EAST OF KALASH, NEW DELHI-110065
 PH:011-46599599 FAX:011-46599512
 EMAIL: gpm@aimail.in

ARCHITECT SIGNATURE:

GIAN P. MATHUR
 B. Arch., M. C. E. I. A.
 CA No. 80/5769

CLIENT:

M/S IITL- NIMBUS THE EXPRESS PARK VIEW,
 313-315, VIKAS DEEP BUILDING, DIST.
 CENTER, LAXMI NAGAR, DELHI-92

OWNER SIGNATURE:

For IITL-Nimbus The Express Park View

 Authorised Signatory

JOB TITLE:

SUBMISSION DRAWING

PROJECT:
 THE EXPRESS PARK VIEW-II
 PLOT NO- GH-03, SECTOR - CH-I-V,
 GREATER NOIDA. (U.P.)

DRAWING TITLE:
 TOWER-JJ1, K.K1, L.L1, M & M1
 20TH & 21TH FLOOR PLAN

JOB NO. 2064

SCALE: 1:100

DATE: 05-06-2012

DEALT: YASHPAL

CHECKED BY:




REVISION NO.

GREATER NOIDA AUTHORITY:-

ASSOCIATE ARCHITECT

ARCHITECT

CHIEF ARCHITECT

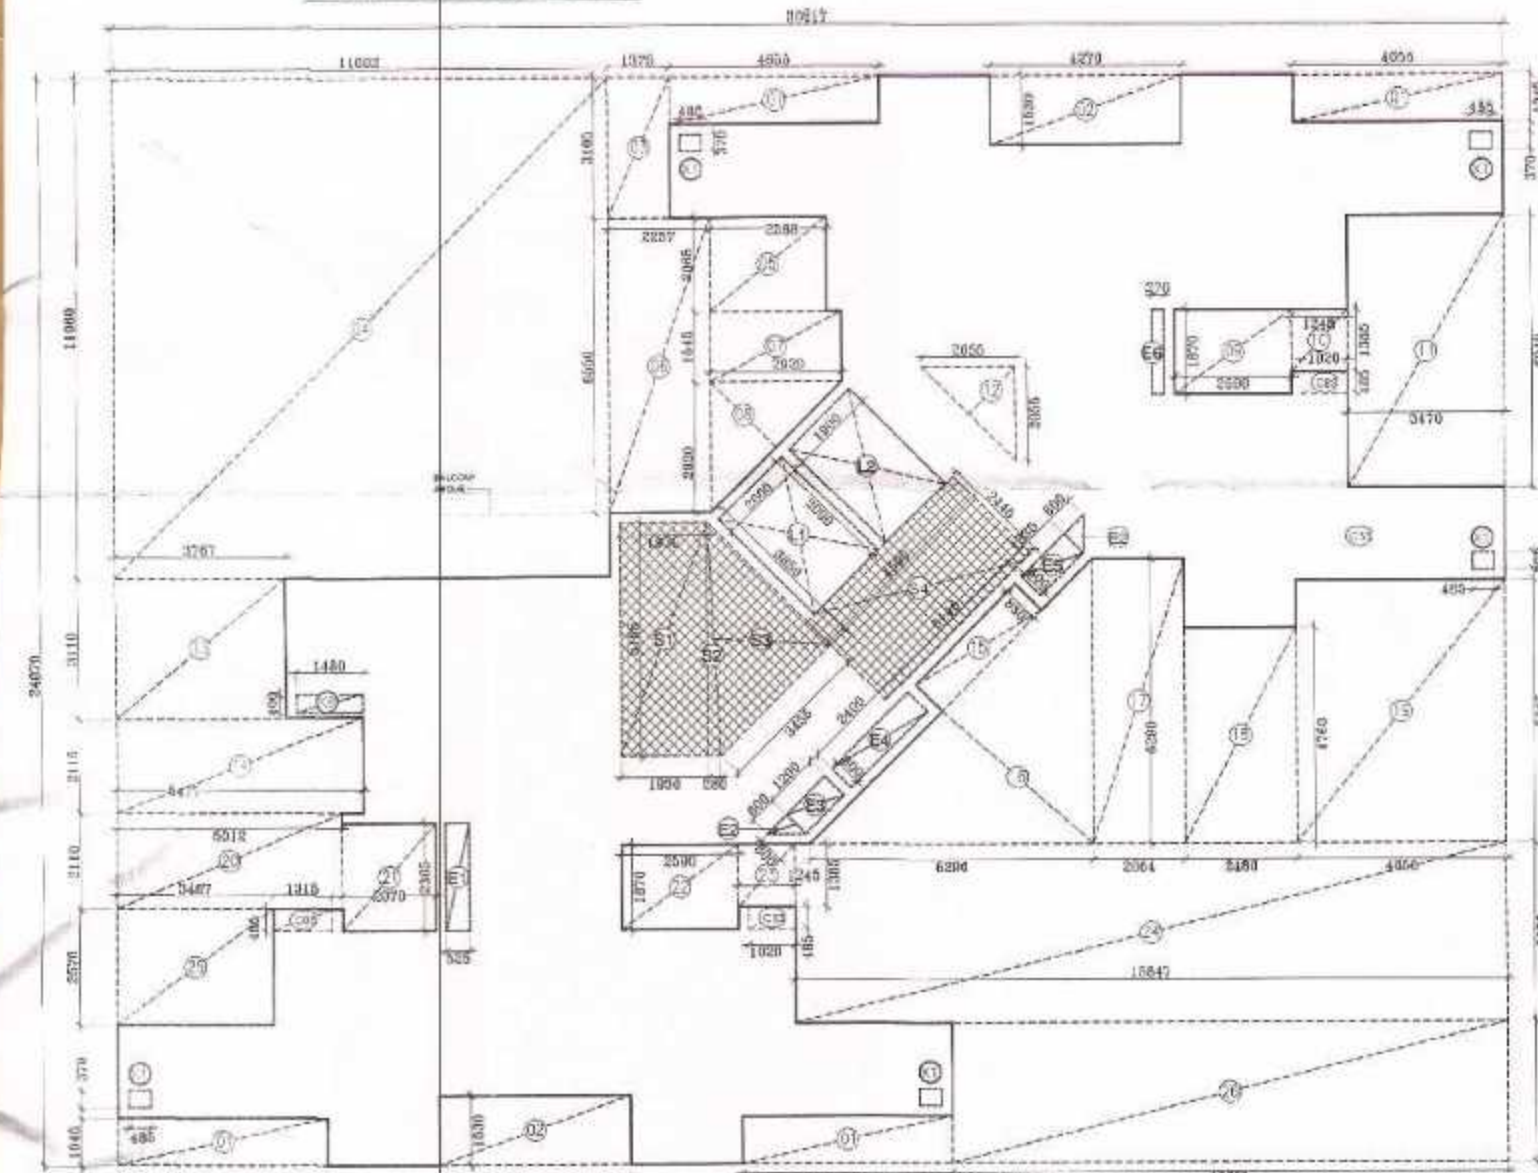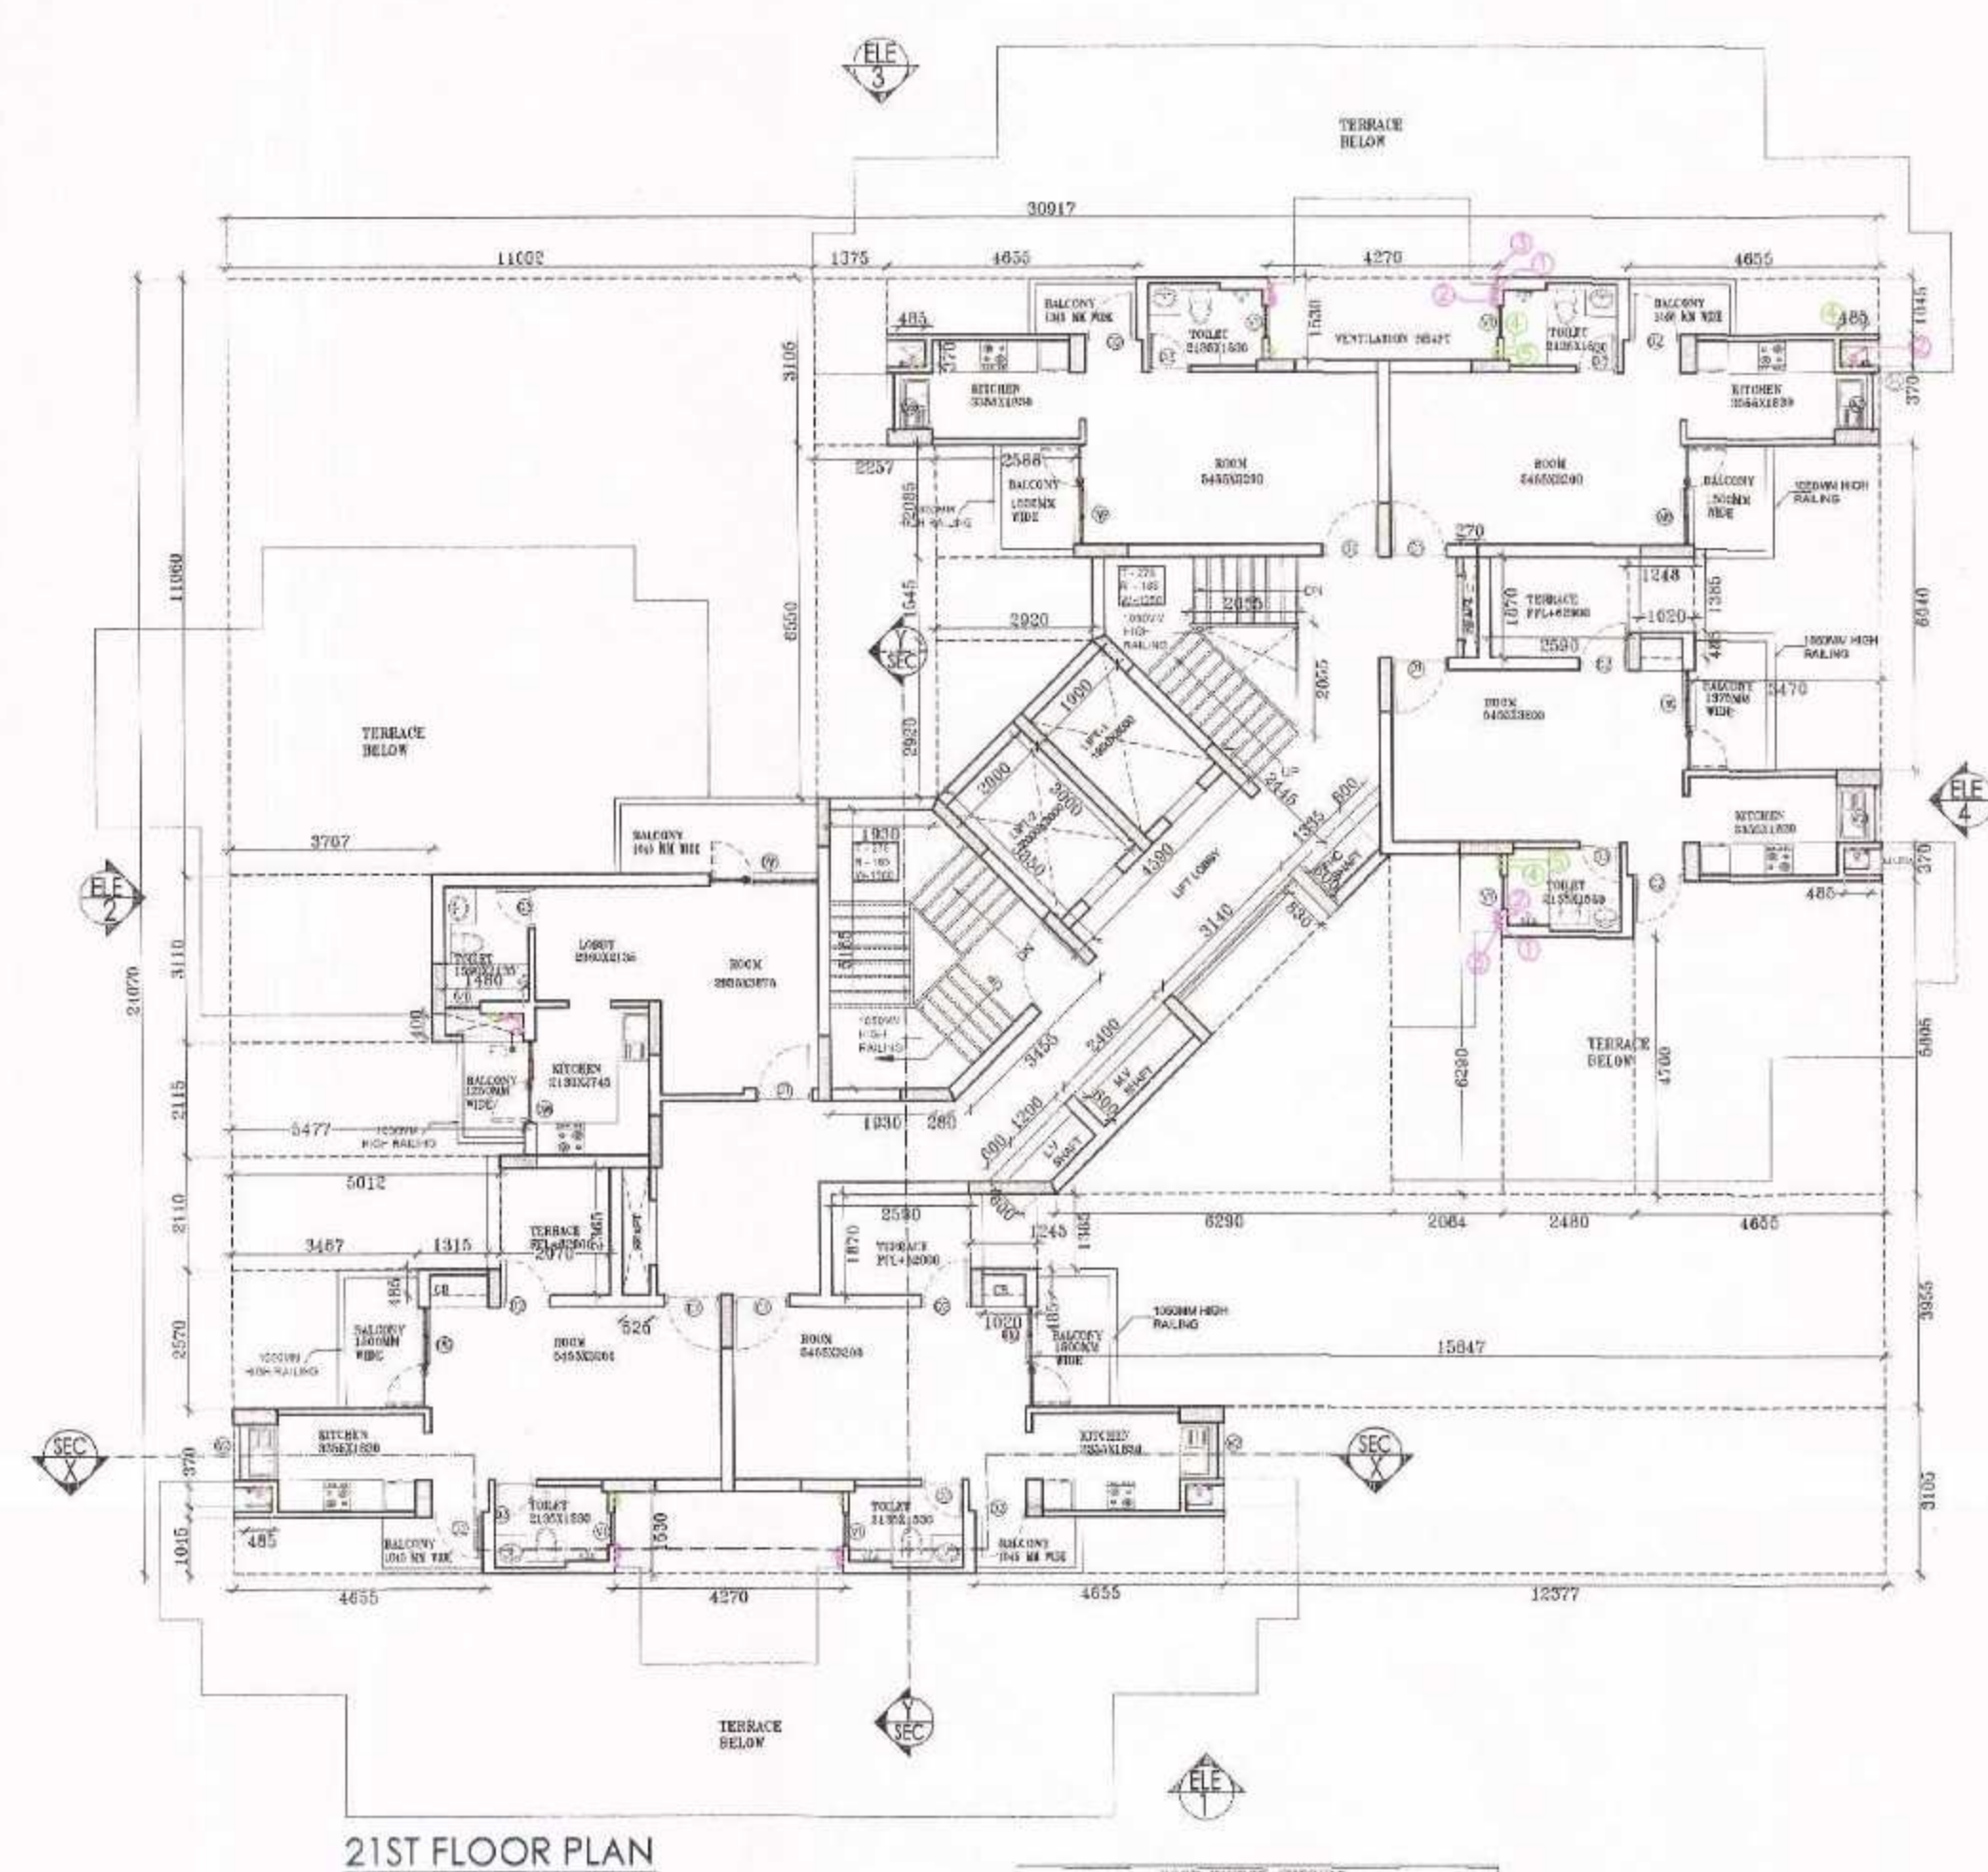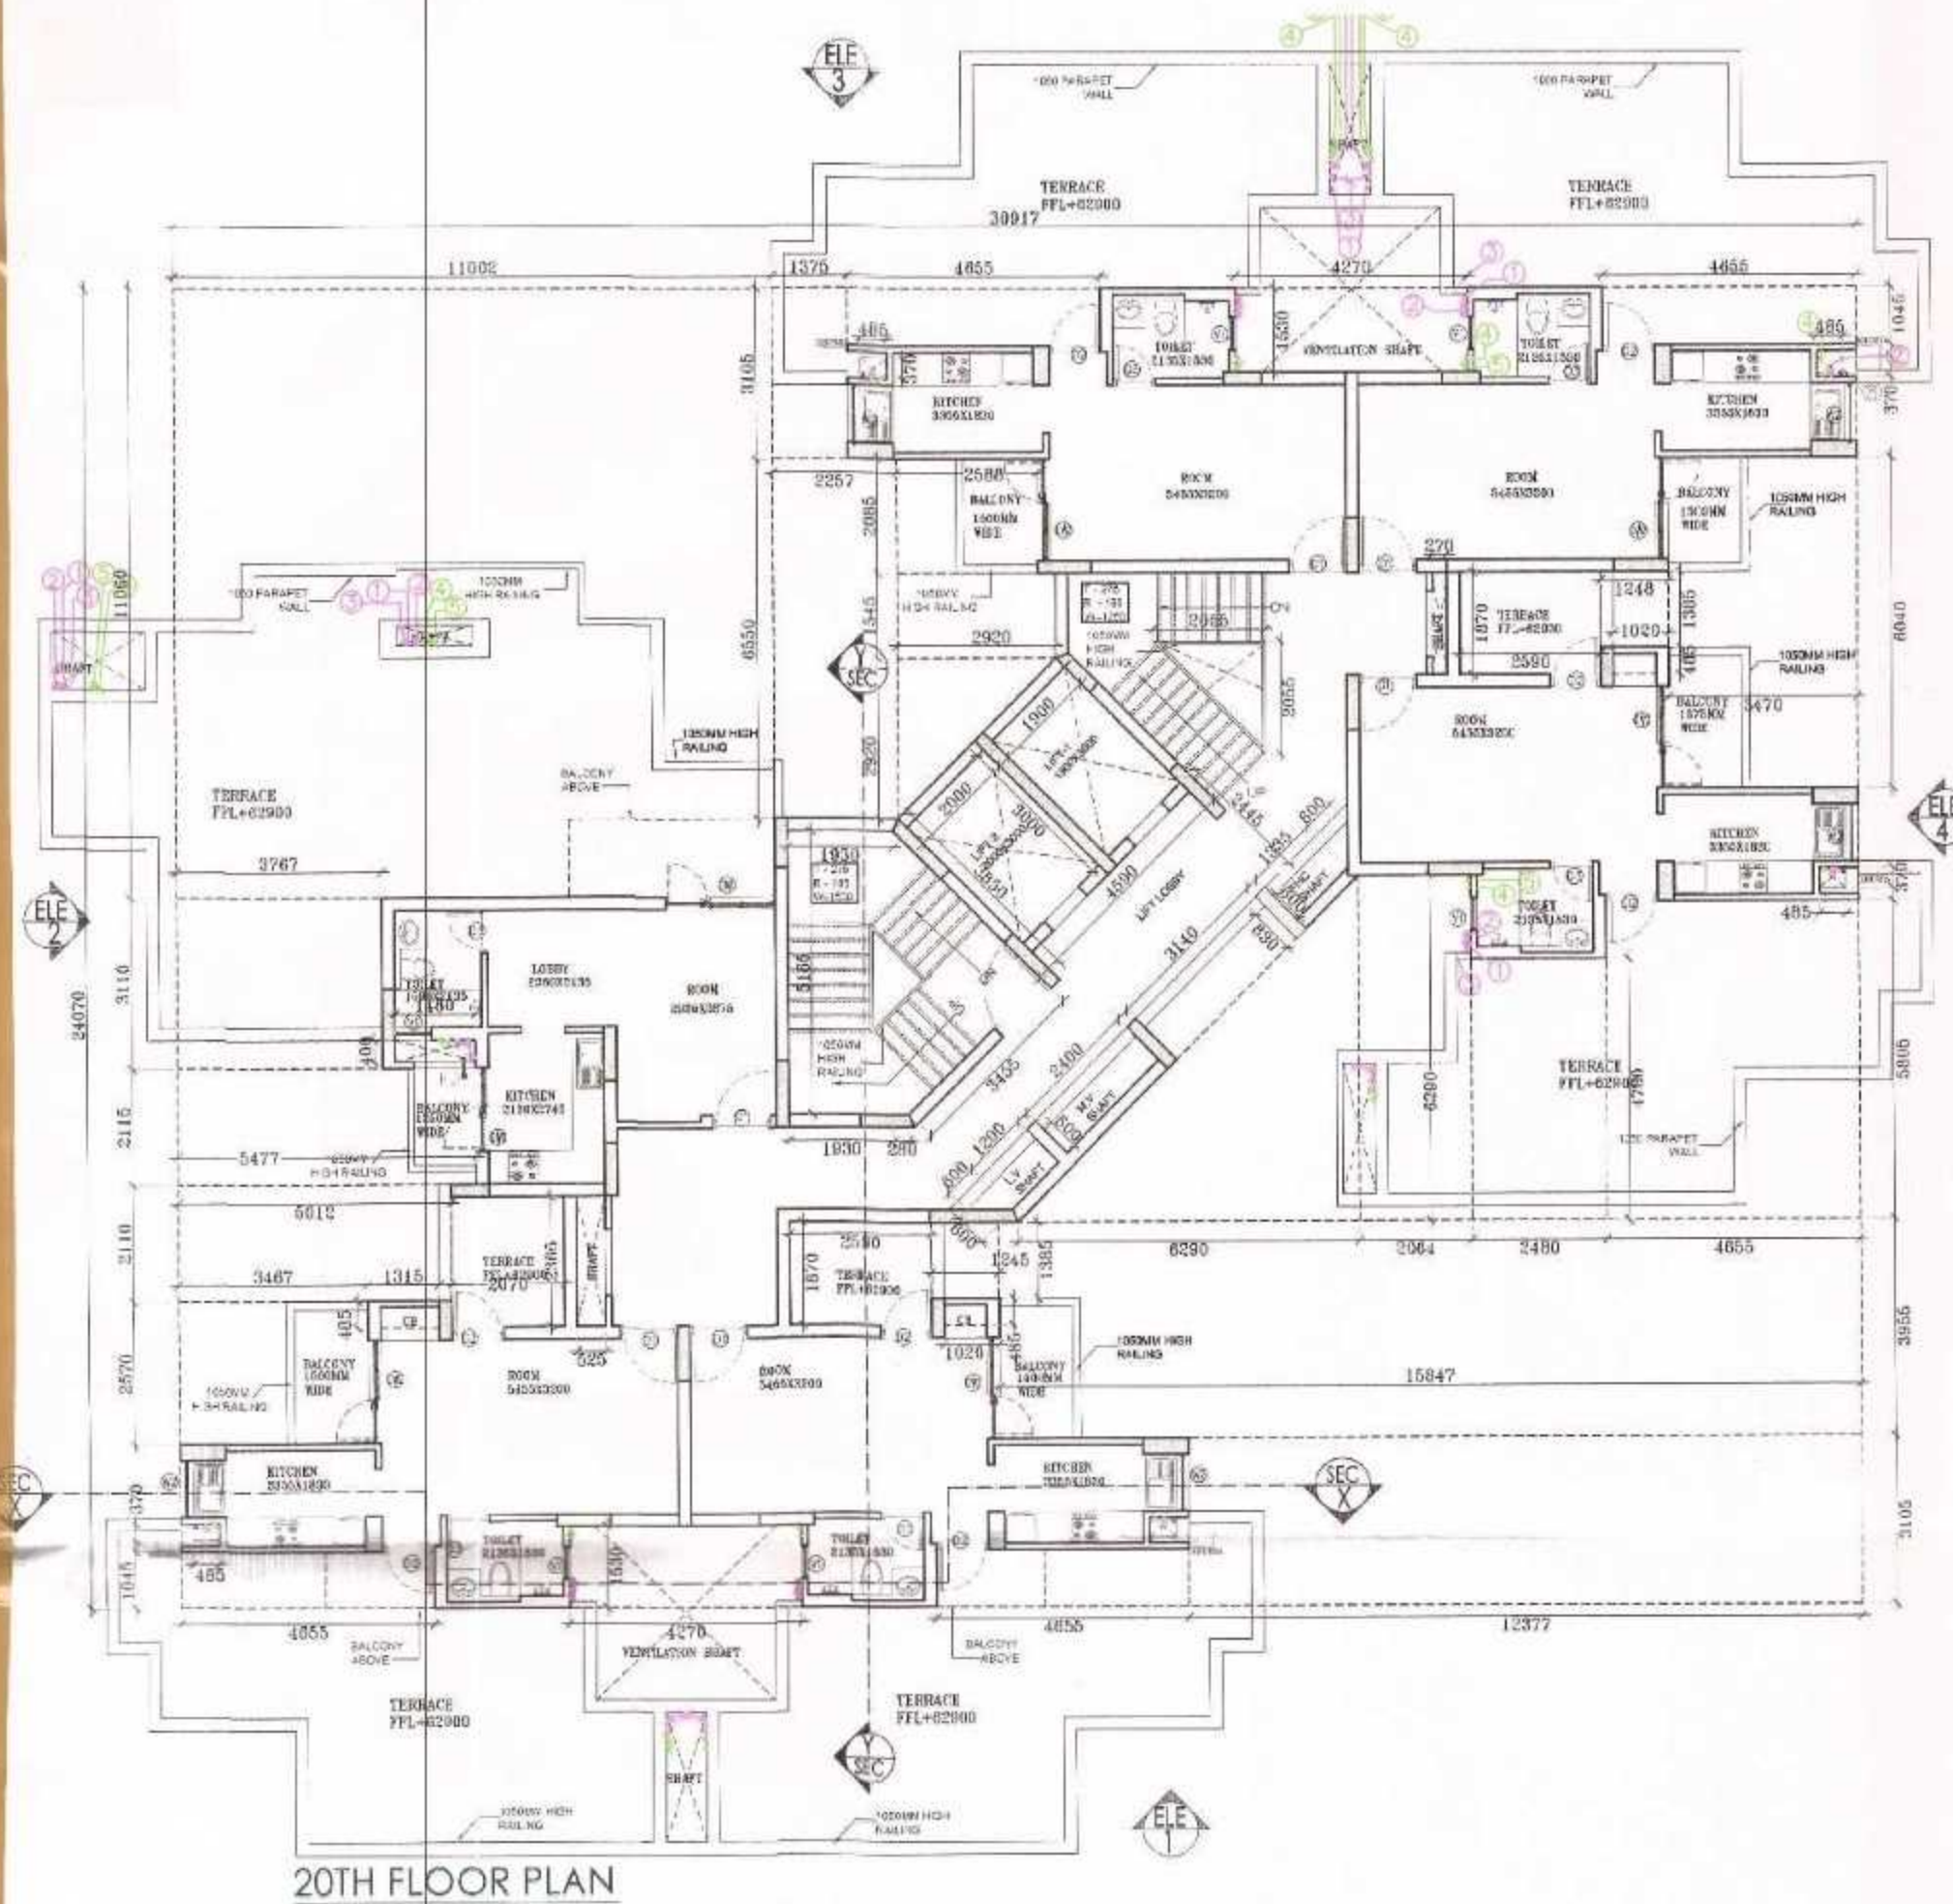

FAR AREA-TOP Floor					(All Distances				
ADDITIONS (A) = 30.917 x 24.070					744.172 SQ.M ADDITIONS (A)				
SUBTRACTIONS					SERVICE AREA (Additional 15% of FAR) CUP				
OPEN AREAS (B)					BOARDS (CB)				
TYPE	LENGTH	WIDTH	NOS	AREA	TYPE	LENGTH	WIDTH	NOS	AREA
1	4.655	1.045	4	19.458	15	3.140	0.830	1	2.606
2	4.270	1.530	2	13.066	16	6.290	6.290	1	19.782
3	1.375	3.105	1	4.289	17	2.084	6.290	1	12.983
4	11.002	11.090	1	121.682	18	2.480	4.760	1	11.805
5	2.588	2.085	1	5.389	19	4.655	5.806	1	27.022
6	2.257	6.550	1	14.783	20	5.012	2.110	1	10.575
7	3.920	1.545	1	4.511	21	2.070	2.385	1	4.896
8	3.920	2.920	1	4.283	22	2.590	1.870	1	4.843
9	2.590	1.870	1	4.843	23	1.245	1.355	1	1.724
10	1.248	1.355	1	1.726	24	15.847	3.955	1	62.675
11	3.470	8.040	1	20.959	25	3.467	2.570	1	8.910
12	2.055	2.055	1	2.112	26	12.377	3.105	1	38.431
13	3.767	3.110	1	11.715	L1	2.000	3.000	1	6.000
14	5.477	2.115	1	11.584	L2	1.900	3.000	1	5.700
Total (B) =				458.323	SERVICE AREA (Additional 15% of FAR) Lift				
SUMMARY					Lobby, Fire Exit Stair & Service Shafts				
TOTAL FAR AREA AT TOP FLOOR = (A) - (B) - (CB) - (C) =					E1	0.525	2.365	1	1.242
TOTAL FAR AREA AT TOP FLOOR =					E2	0.800	0.800	2	0.360
SERVICE AREA (Additional 15% of FAR) = (CB) + (C) =					E3	1.200	0.800	1	0.720
SERVICE AREA (Additional 15% of FAR) =					E4	2.400	0.800	1	1.440
					E5	1.335	0.800	1	0.891
					E6	0.270	1.870	1	0.595
					S1	1.930	3.165	1	9.988
					S2	0.280	5.165	1	0.723
					S3	3.455	3.850	1	6.651
					S4	4.590	2.445	1	11.223
					X1	0.485	0.370	5	0.897
					X8	1.480	0.400	1	0.592
					TOTAL (C)				35.122

DOOR WINDOW SCHEDULE				
S.NO	TITLE	LENGTH	WIDTH	CHILL
1	MAIN DOOR (MD)	2900	2100	-
2	D1	1050	2100	-
3	D2	930	2100	-
4	D3	780	2100	-
5	DW1	2800	2100	-
6	DW2	1855	2100	-
7	DW3	1829	2100	-
8	DW4	1755	2100	-
9	DW5	1665	2100	-
10	DW6	1515	2100	-
11	W1	1450	900	900
12	W2	1180	900	900
13	W3	1045	900	1050
14	W4	850	900	2100
15	W5	600	900	2100

Greater Noida Industrial Dev. Authority
 Approved
 28/06/2012
 27/06/2012
 16/06/2012
 05/06/2012