




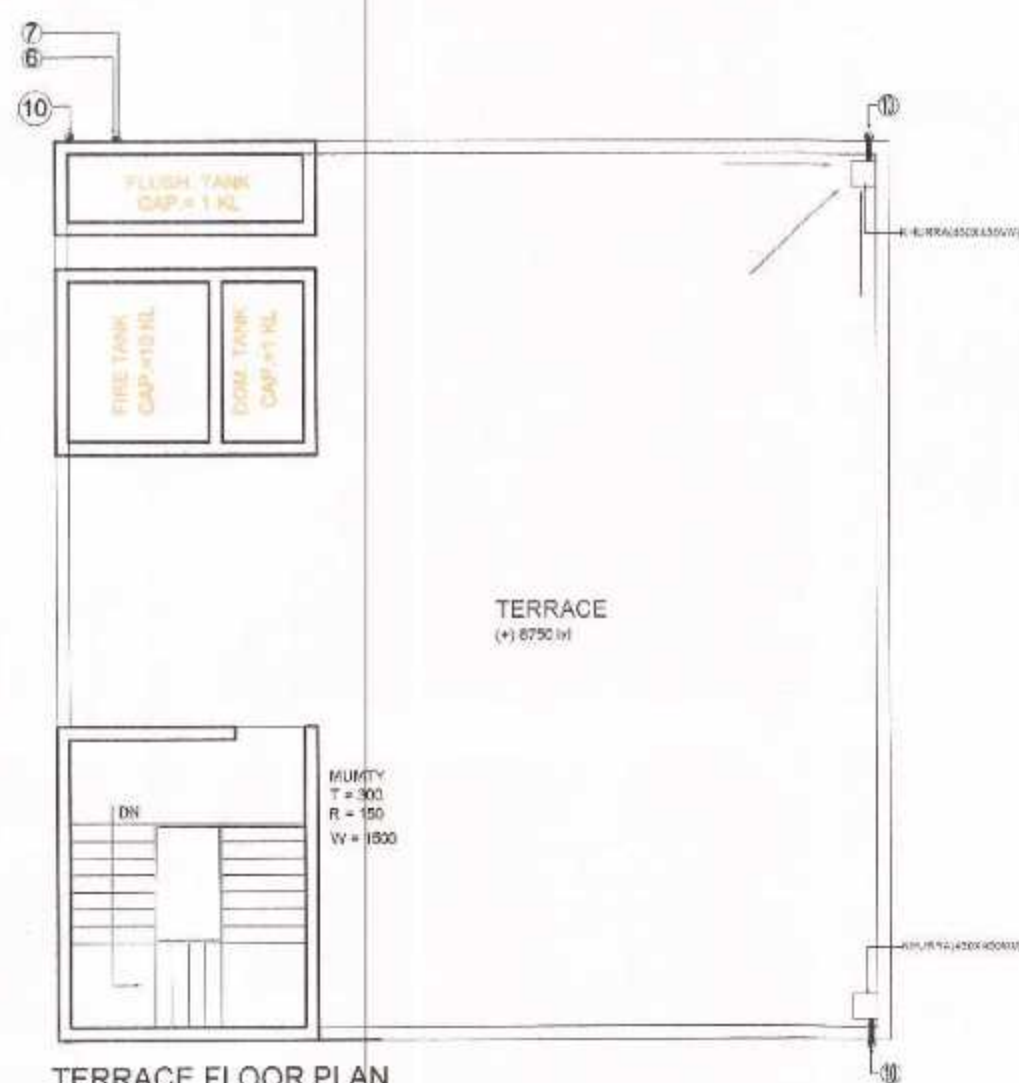


TERRACE FLOOR PLAN

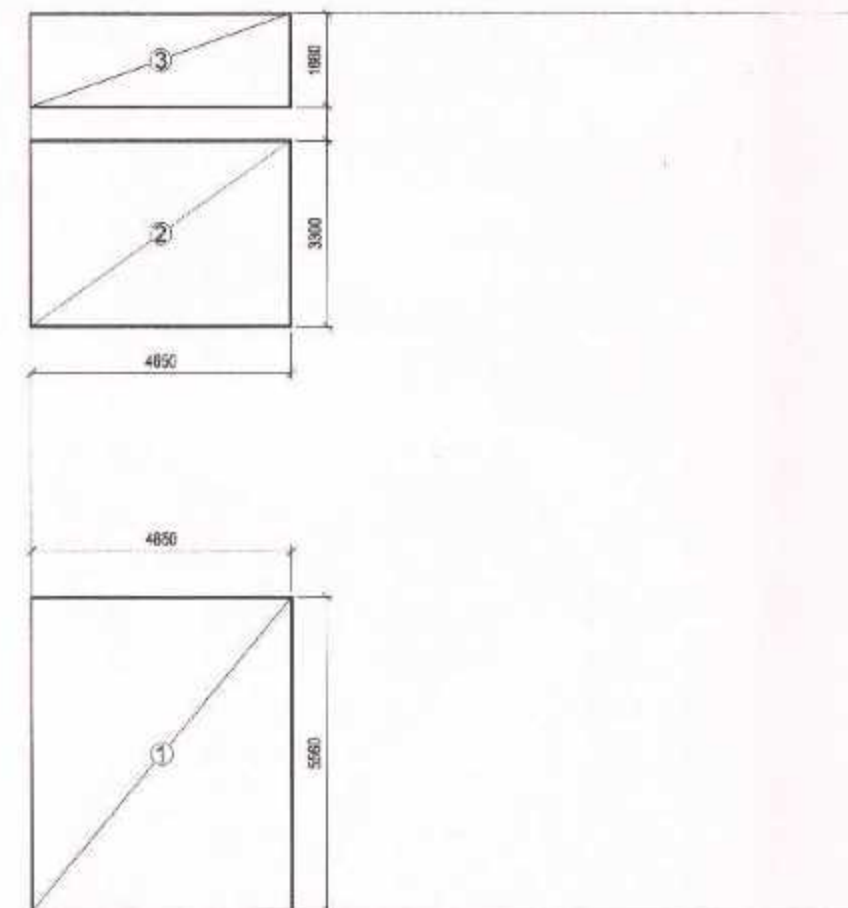


AREA DIAGRAM-TERRACE LEVEL

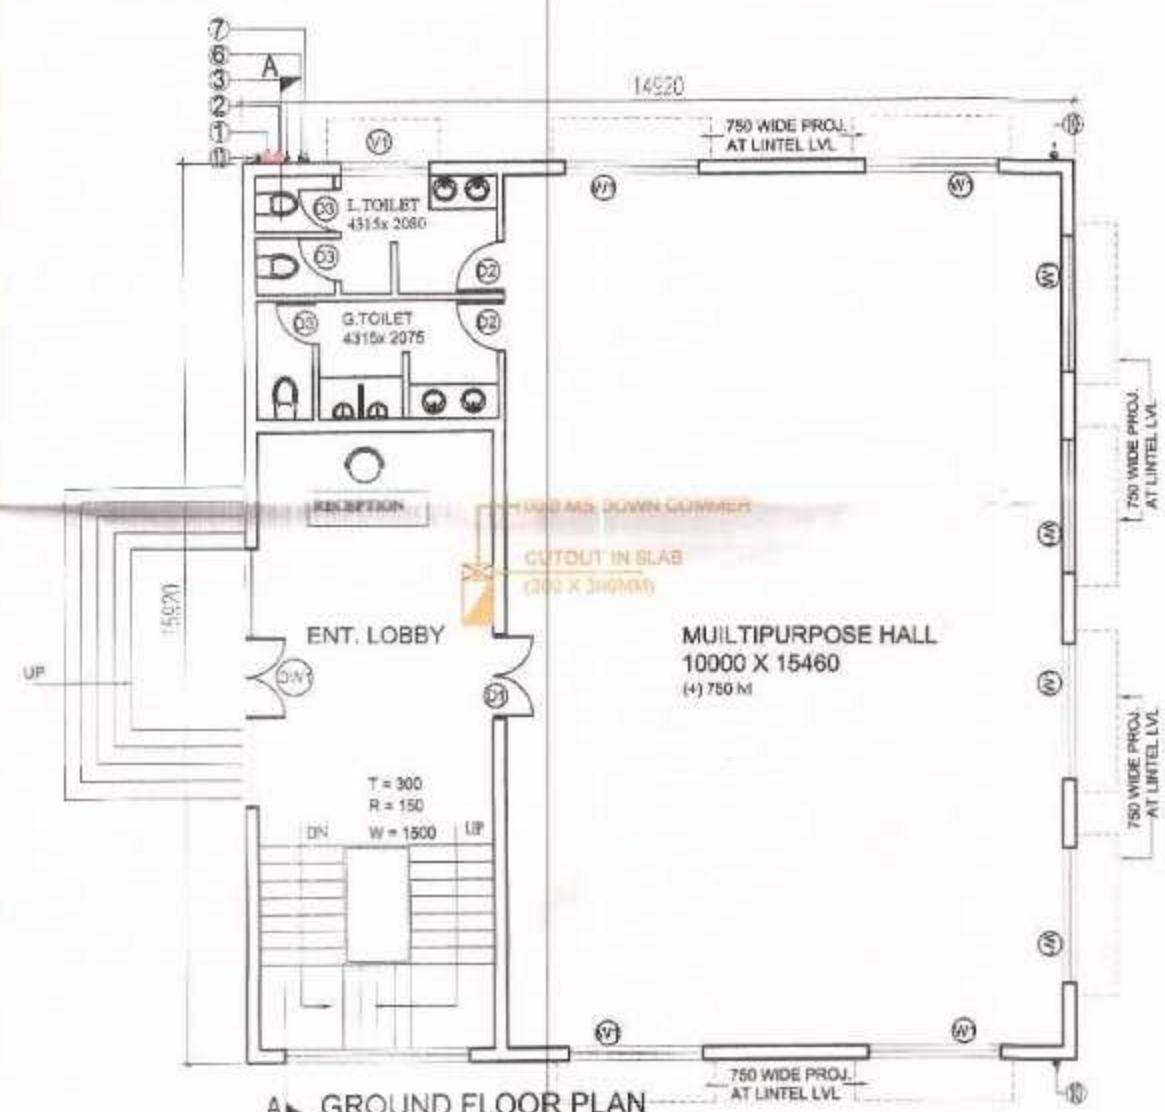

GROUND FLOOR PLAN

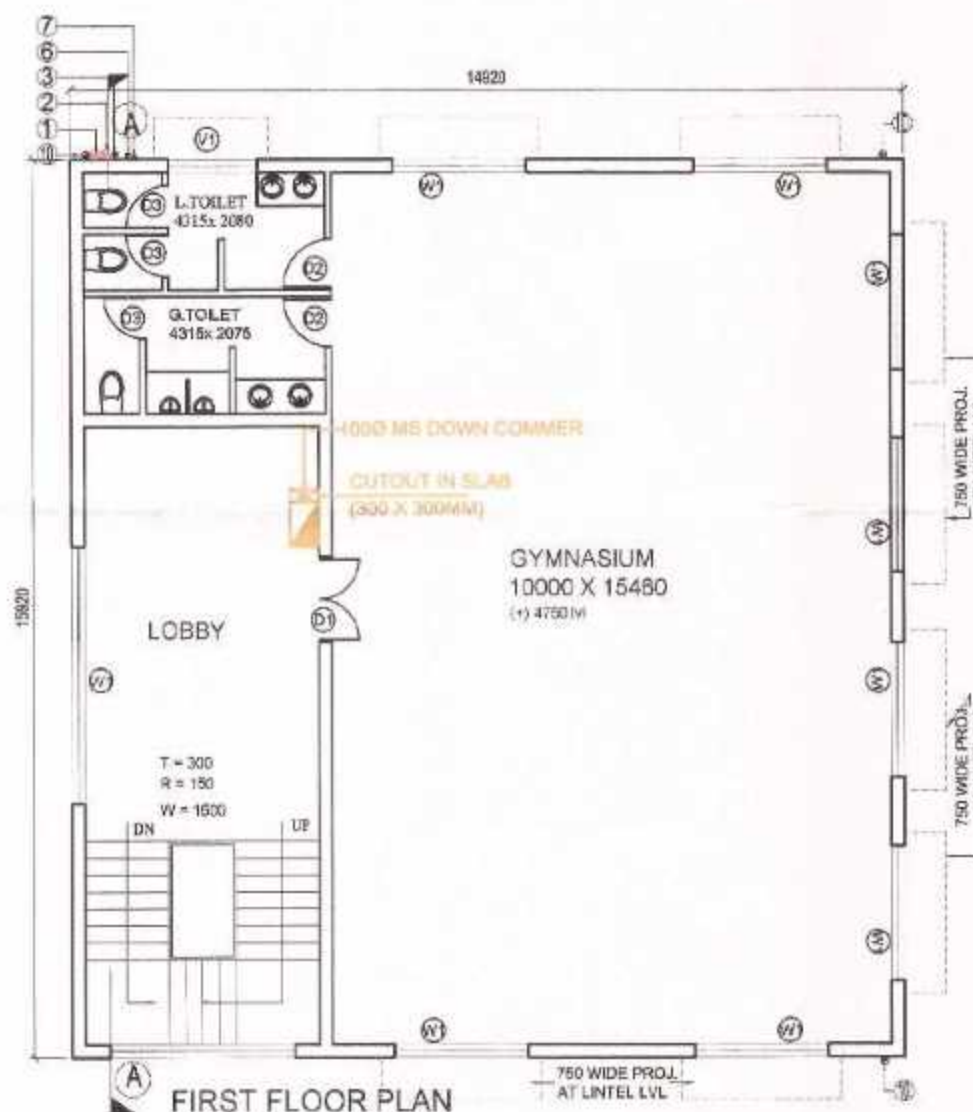

FIRST FLOOR PLAN

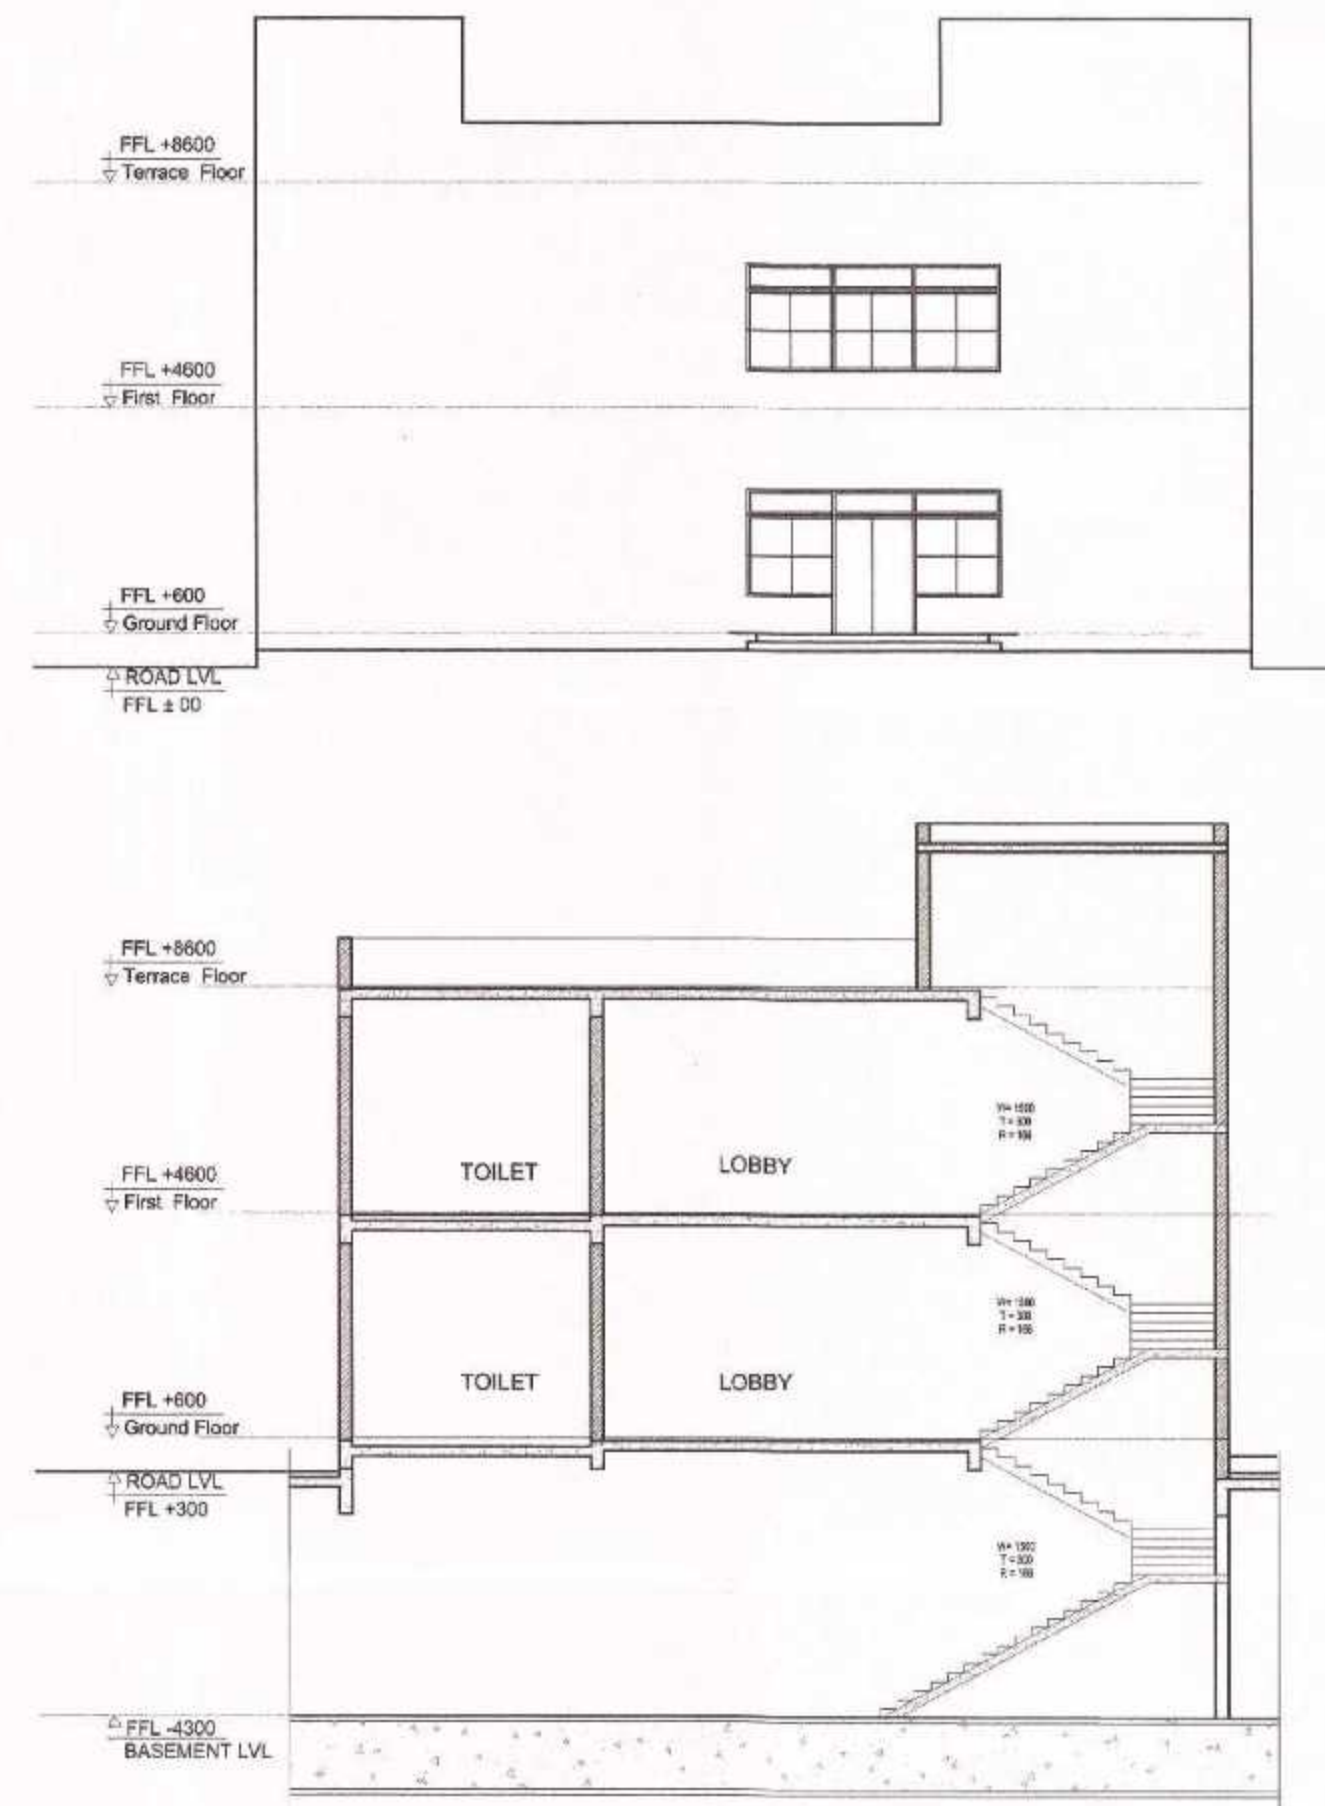

SECTION AA

FIRE HYDRANT CABINET (FHC) COMPRISES OF -
 100 MM DIA. FIRE FIGHTING CUM DOWNCOMER WITH FOLLOWING:
 a) 63 MM DIA. SINGLE HEADED HYDRANT VALVE
 b) ONE NO. 20 MM DIA. 30 M. LONG HOSE REEL
 c) 2 NOS. 63 MM DIA. 15 M. LONG FIRE HOSE PIPES
 d) ONE BRANCH PIPE WITH NOZZLE


DOORS & WINDOWS SCHEDULE

TYPE	WIDTH	HEIGHT
D1	900	2100
D2	750	2100
DW1	2100-450	2600
DW2	1490-1800-1490	2600
W1	2400X1850	2600
W2	1500X1850	2600
V1	600X600	1800

PLUMBING LEGEND:

TAG NO.	DISCRIPTION
①	110 OD UPVC SP STACK
②	110 OD UPVC WF STACK
③	75 OD UPVC A.S.P. STACK
④	DOMESTIC DOWN TAKE (UPPER TWO FLOOR)
⑤	FLUSHING DOWN TAKE (UPPER TWO FLOOR)
⑥	40# DWS RISER TO FILL OH
⑦	25# FWS RISER TO FILL OH
⑧	90 OD UPVC DRAIN PIPE (UTIL. BALCONY)
⑨	90 OD UPVC DRAIN PIPE (BALCONY)
⑩	110 OD UPVC RWP PIPE (TERRACE)

KEY PLAN

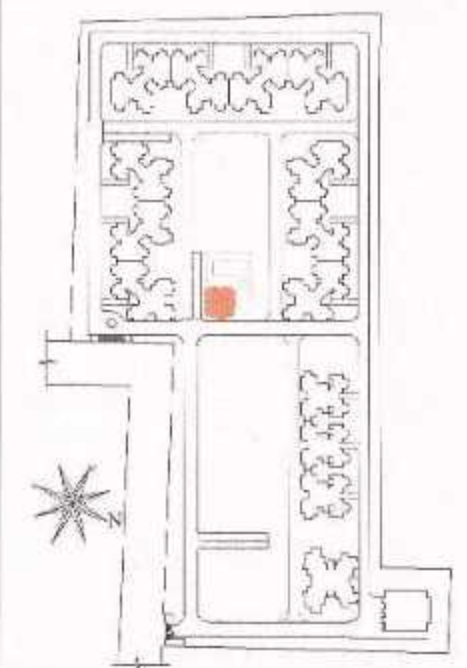

ARCHITECTS:

GIAN P. MATHUR & ASSOCIATES PVT. LTD.
 ARCHITECTS, ENGINEERS & PLANNERS
 C-55, EAST OF KAILASH, NEW DELHI - 110065
 PH: 011-46595999 FAX: 011-46595912
 EMAIL: gpma@airtelmail.in

ARCHITECT SIGNATURE:

GIAN P. MATHUR
 ARCHITECT
 B. Arch., M.C.A., A.I.A.
 CA No. 80/5769

CLIENT:

M/S IITL- NIMBUS THE EXPRESS PARK VIEW,
 313-315, VIKAS DEEP BUILDING, DIST.
 CENTER, LAXMI NAGAR, DELHI-92

OWNER SIGNATURE:

For IITL-Nimbus The Express Park View
Authorised Signatory

JOB TITLE:

SUBMISSION DRAWING

PROJECT:

THE EXPRESS PARK VIEW-II
 PLOT NO. GH-03, SECTOR - CH-V,
 GREATER NOIDA, (U.P.)

DRAWING TITLE:

COMMUNITY BLOCK DETAILS
 PLAN, ELEVATION, SECTION & AREA CHART

JOB NO. 2064 DRAWING NO.

SCALE: 1:150


DATE: 05-06-2012

DEALT-AMAAAN CHECKED BY: REVISION NO.


GREATER NOIDA AUTHORITY:

ASSOCIATE ARCHITECT ARCHITECT CHIEF ARCHITECT


FAR AREA-COMMUNITY HALL				
(All Distances are in Meter & Areas in Sqm)				
GROUND FLOOR				
TYPE	LENGTH	WIDTH	NOS	AREA
A	14.920	15.920	1.000	237.526
TOTAL FAR AREA AT GROUND FLOOR				= 237.526 Sqm
FIRST FLOOR				
TYPE	LENGTH	WIDTH	NOS	AREA
A	14.920	15.920	1.000	237.526
TOTAL FAR AREA AT FIRST FLOOR				= 237.526 Sqm
MUMTY LEVEL (SERVICE AREA)				
TYPE	LENGTH	WIDTH	NOS	AREA
1	4.650	3.560	1	16.554
2	4.650	3.300	1	15.345
3	4.650	1.660	1	7.715
SERVICE AREA (Additional 15% of FAR) AT MUMTY LEVEL				= 48.918 Sqm
SUMMARY				
FLOOR	FAR AREA		SERVICE AREA (Additional 15% of FAR)	
GROUND FLOOR	237.526		0.000	
FIRST FLOOR	237.526		0.000	
MUMTY LEVEL	0.000		48.918	
TOTAL	475.053		48.918	
TOTAL FAR AREA OF COMMERCIAL BLOCK				= 475.053 Sqm
TOTAL SERVICE AREA OF COMMERCIAL BLOCK				= 48.918 Sqm
GROUND COVERAGE-COMMUNITY HALL				
(All Distances are in Meter & Areas in Sqm)				
TYPE	LENGTH	WIDTH	NOS	AREA
A	14.920	15.920	1.000	237.526
TOTAL GROUND COVERAGE OF COMMUNITY HALL				= 237.526 Sqm

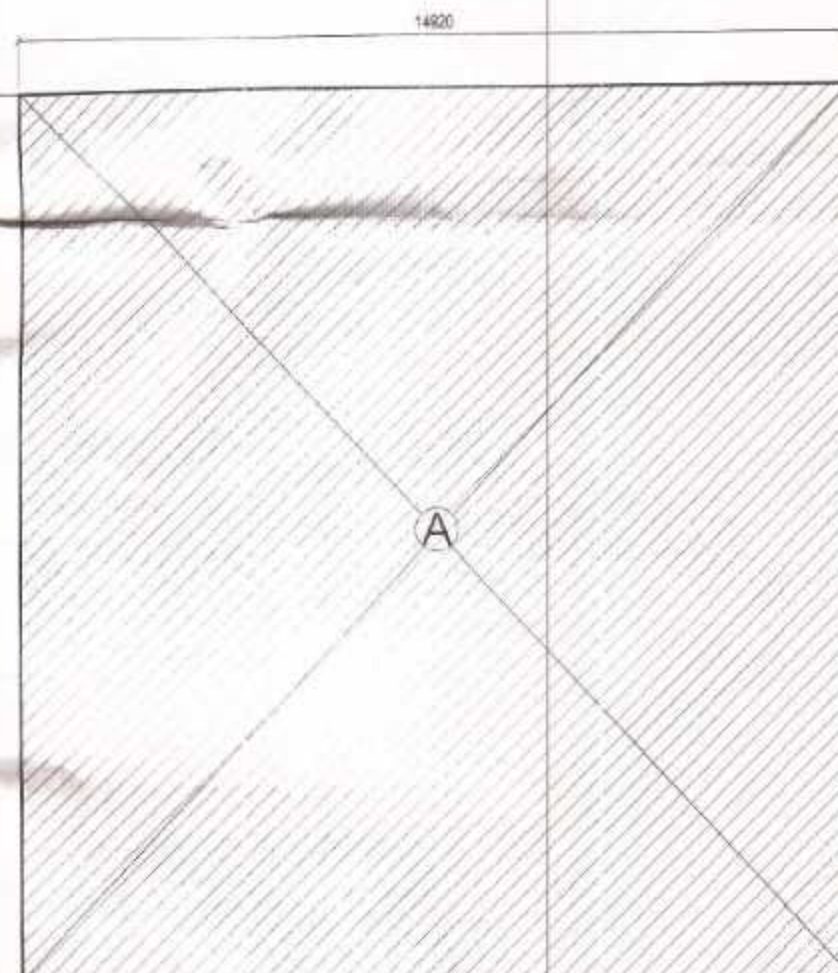

AREA DIAGRAM-GROUND FLOOR

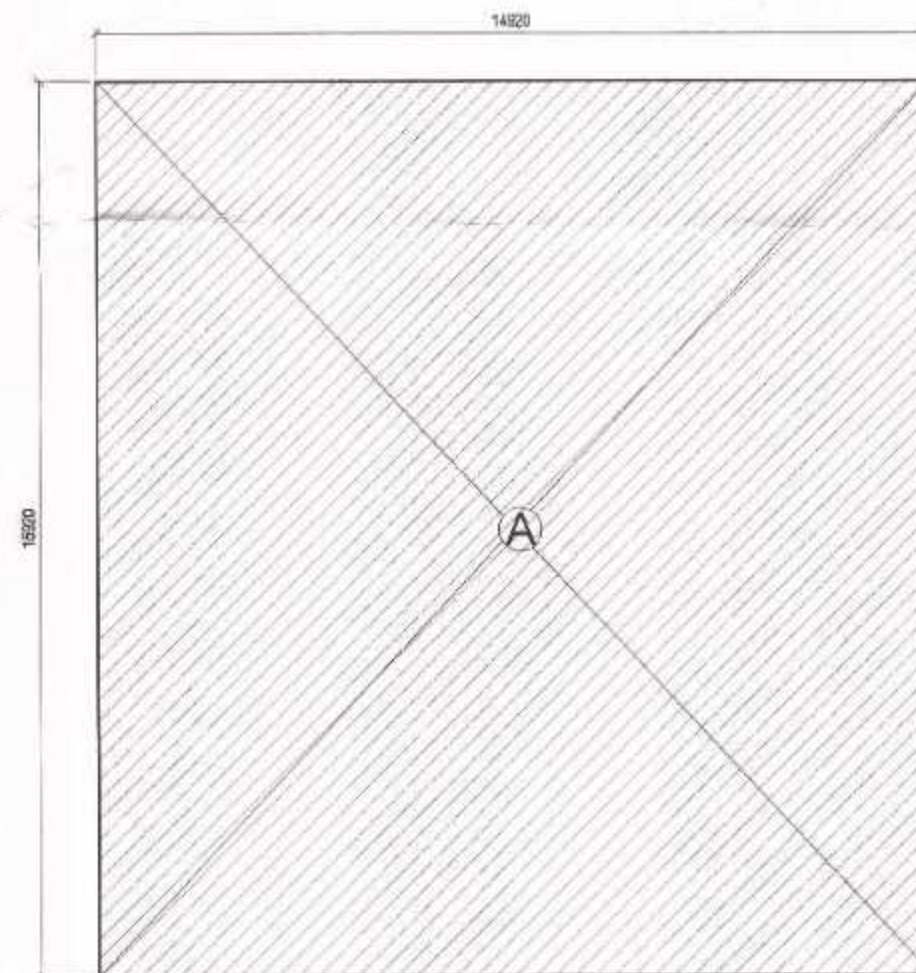

AREA DIAGRAM-FIRST FLOOR

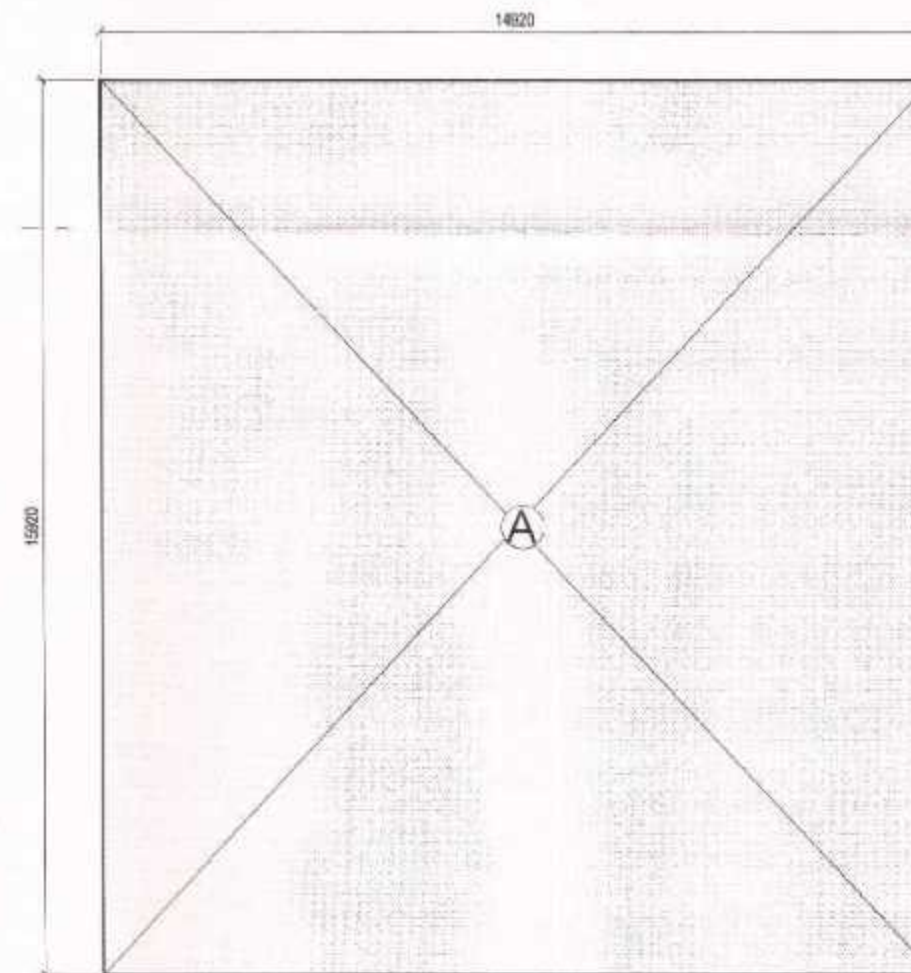

AREA DIAGRAM-GROUND COVERAGE