



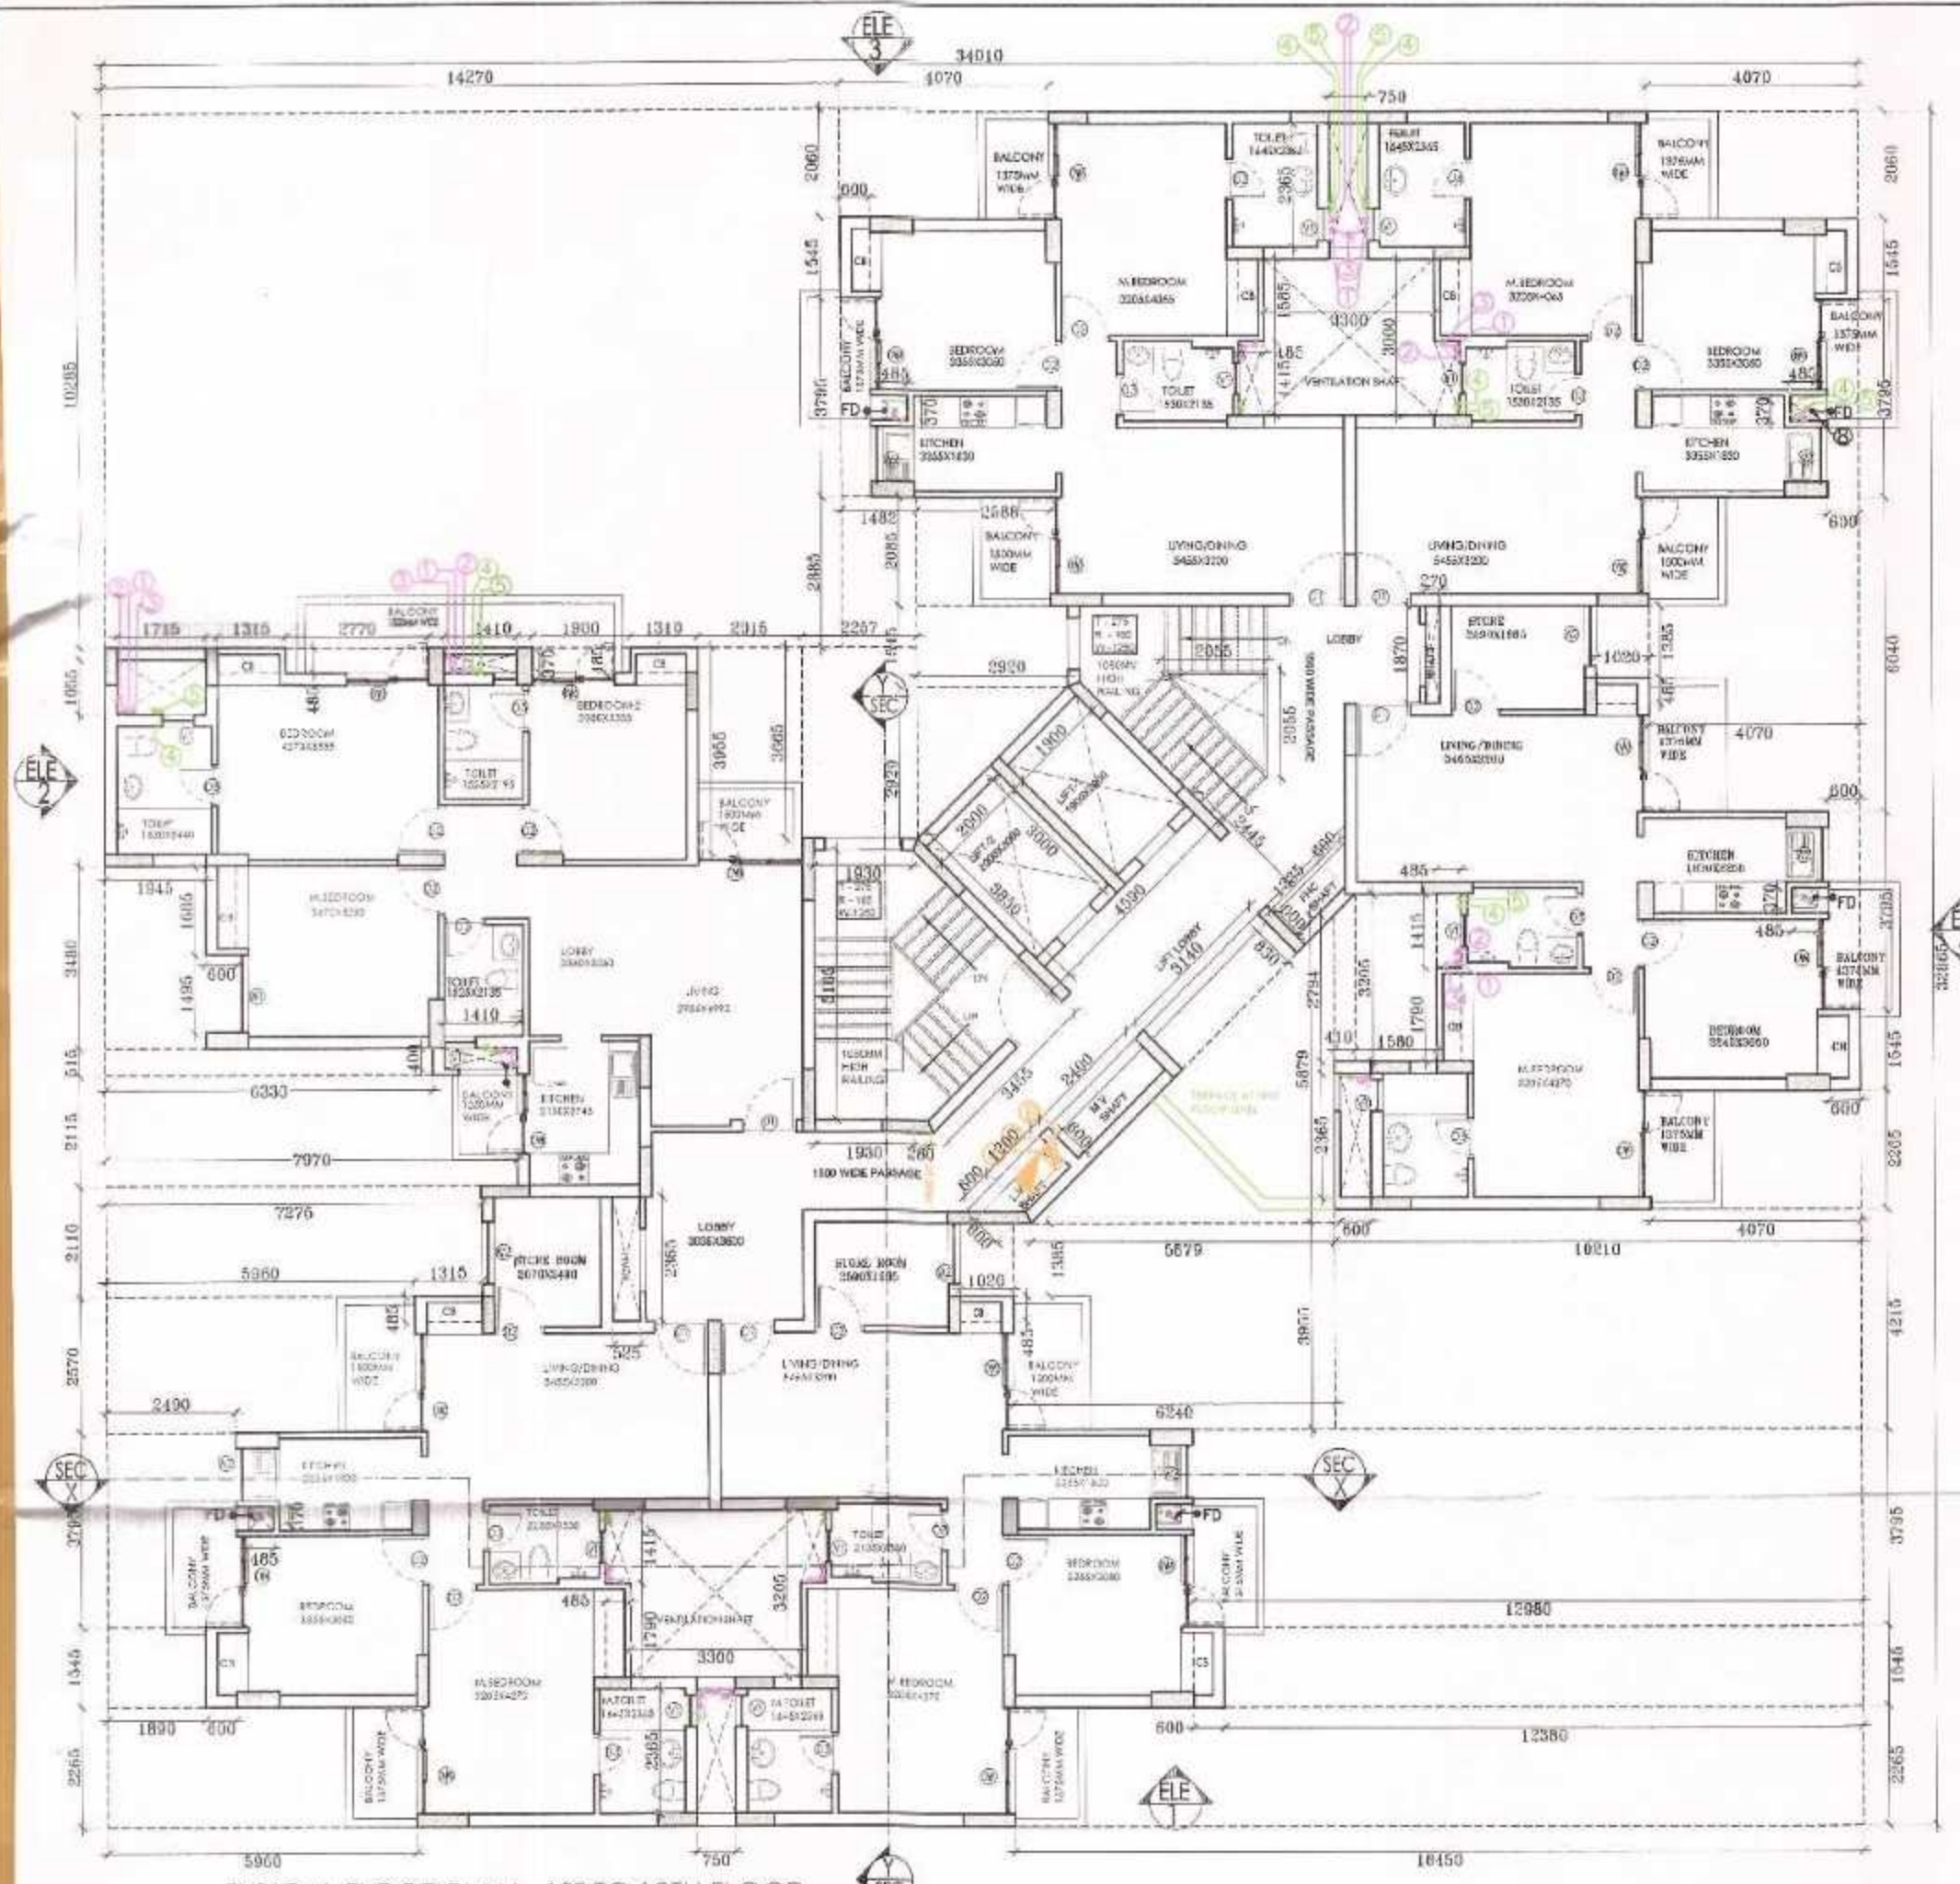

TYPICAL FLOOR PLAN - 1ST TO 19TH FLOOR

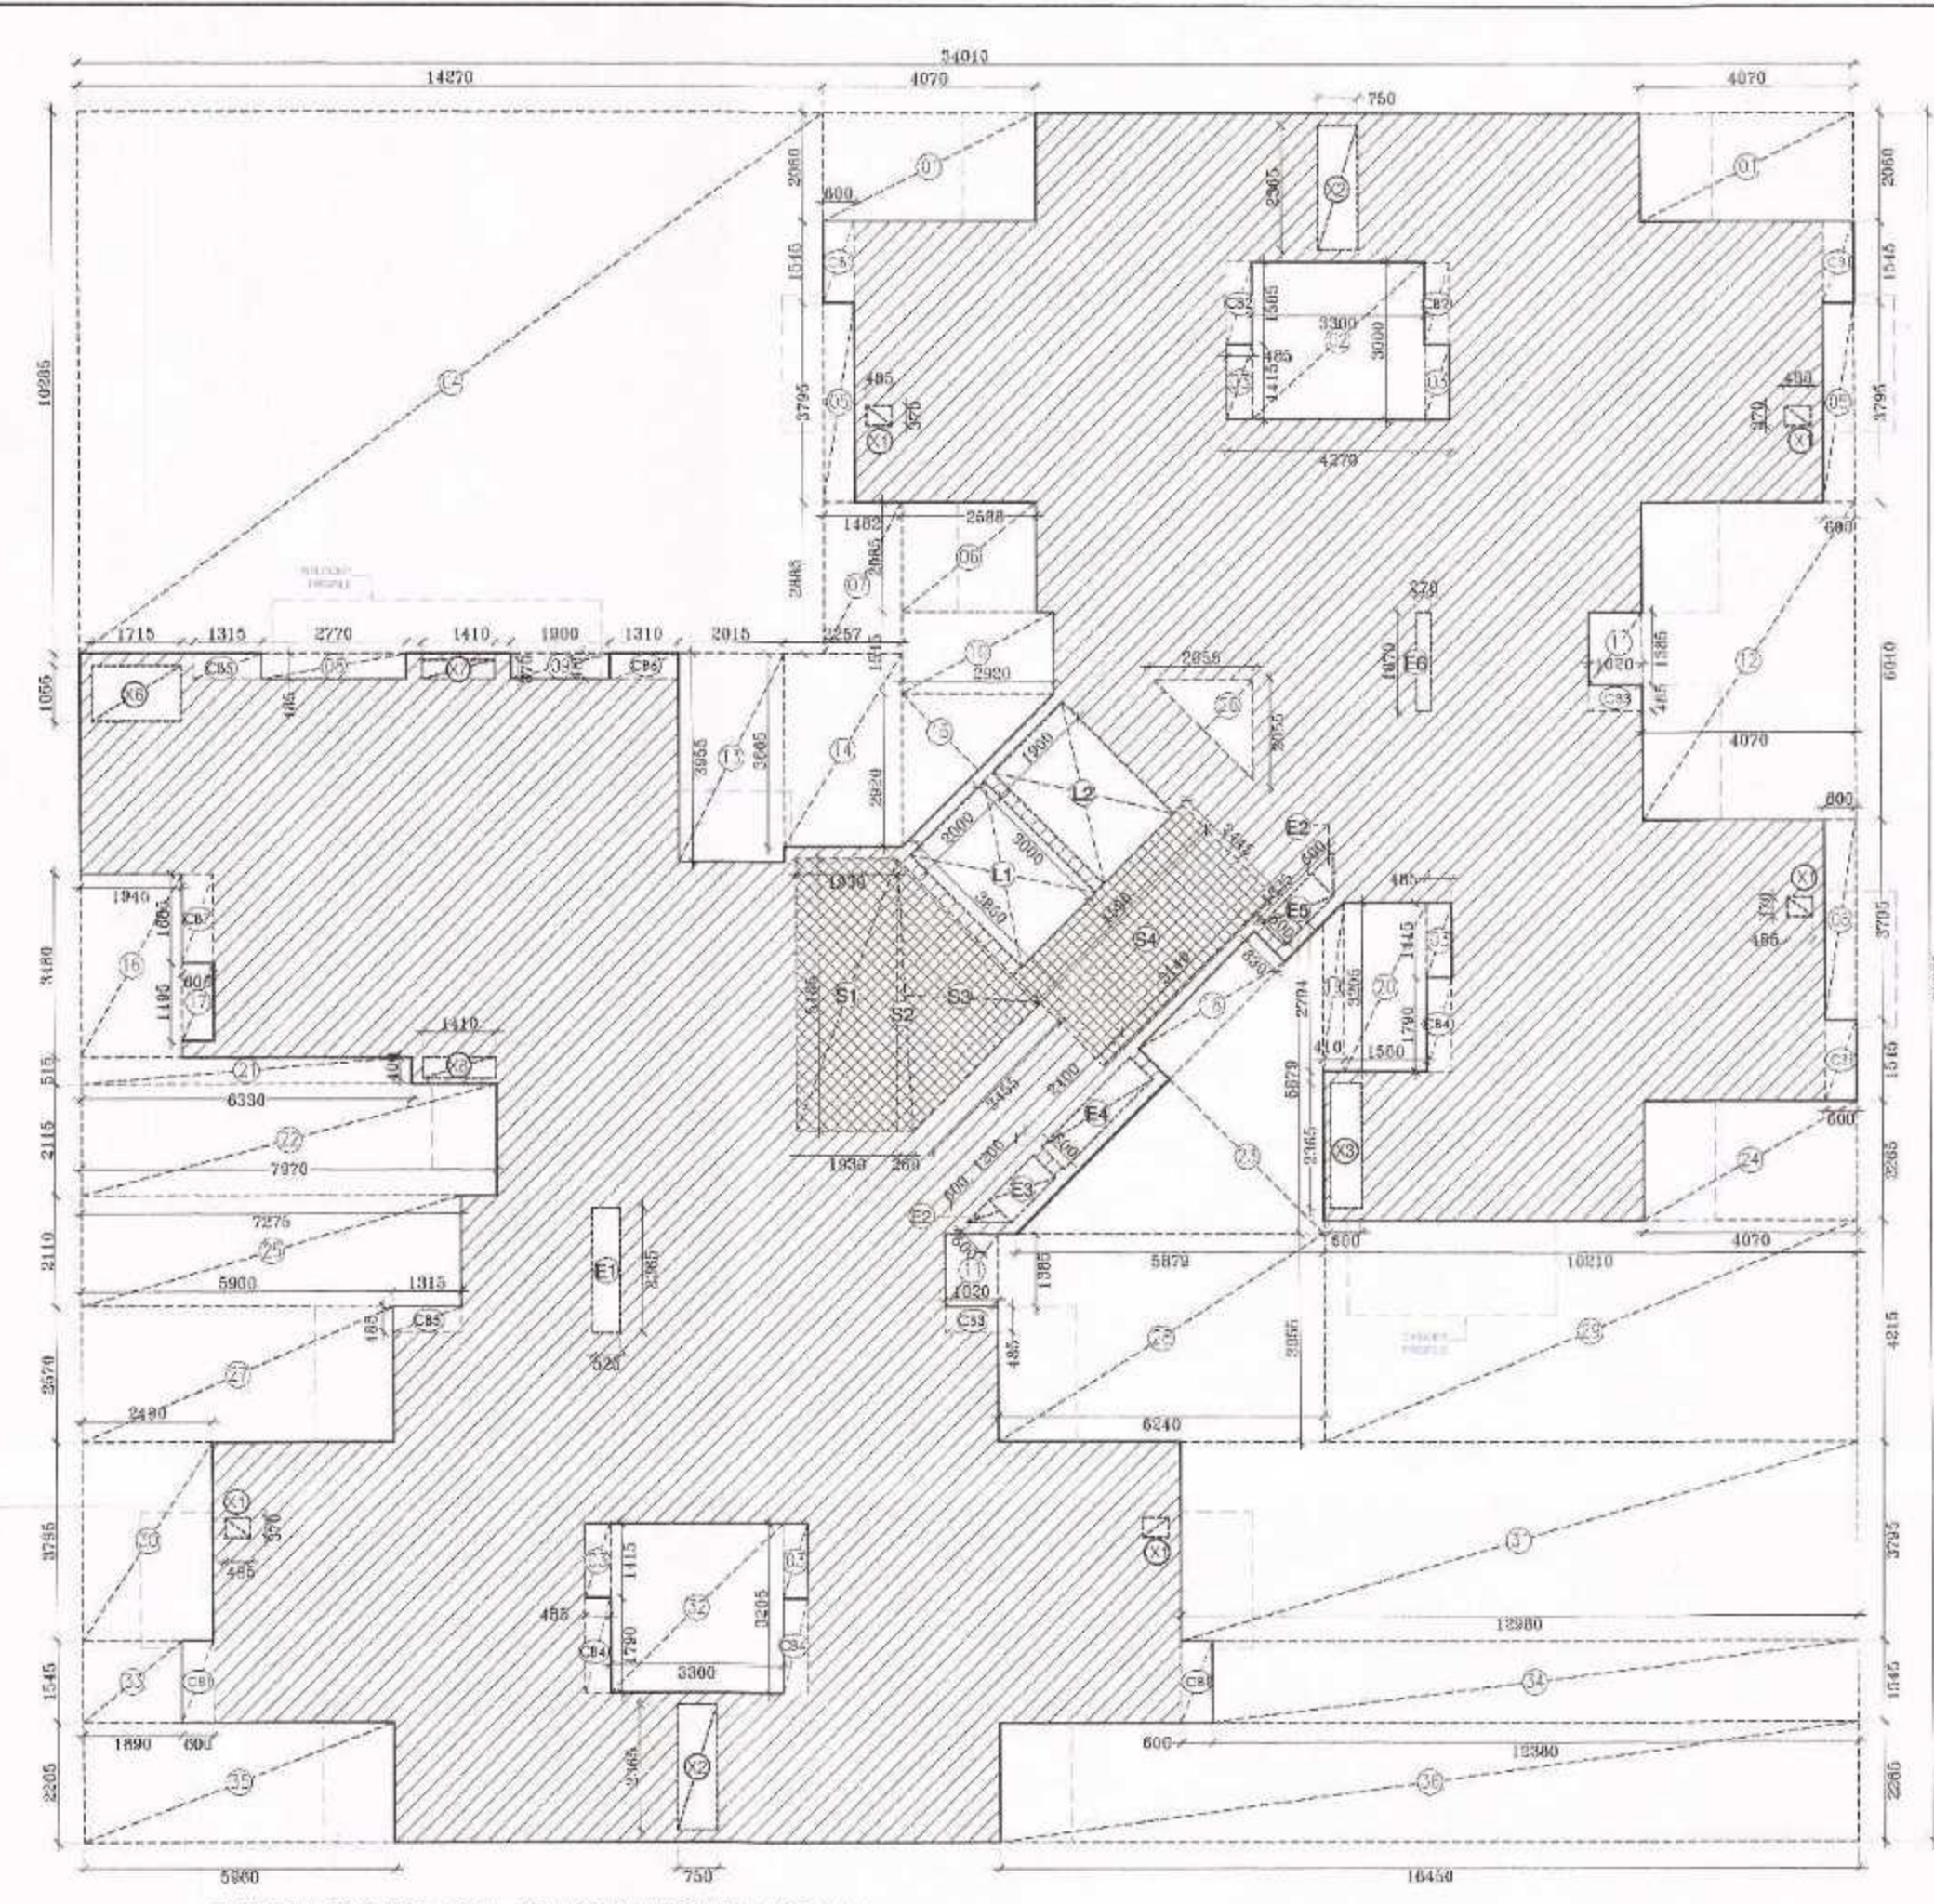


TYPICAL FLOOR AREA CALCULATION DIAGRAM

FAR AREA-Typical Floor (All Distances are in Meter & Areas in Sqm)										
ADDITIONS (A) =		34.010		x	32.865		1117.739 S.Q.M			ADDITIONS (A)
SUBTRACTIONS										
OPEN AREAS (B)										
TYPE	LENGTH	WIDTH	NOS	AREA	TYPE	LENGTH	WIDTH	NOS	AREA	
1	4.070	2.060	2	16.768	20	1.980	3.205	1	5.064	
2	3.300	3.000	1	9.900	21	8.330	0.515	1	3.260	
3	0.485	1.415	5	3.431	22	7.970	2.115	1	16.857	
4	14.270	10.285	1	146.767	23	5.679	5.679	1	17.281	
5	0.600	3.765	3	6.831	24	4.070	2.285	1	9.219	
6	2.588	2.085	1	5.398	25	7.275	2.110	1	15.330	
7	1.482	2.885	1	4.278	28	2.055	2.055	1	2.112	
8	2.770	0.485	1	1.343	27	5.960	2.670	1	15.917	
9	1.900	0.485	1	0.922	28	8.240	3.955	1	24.679	
10	2.920	1.545	1	4.511	29	10.210	4.215	1	43.035	
11	1.020	1.385	2	2.825	30	2.490	3.795	1	9.450	
12	4.070	6.040	1	24.583	31	12.980	3.795	1	49.259	
13	2.015	3.955	1	7.969	32	3.300	3.205	1	10.577	
14	2.287	3.665	1	8.372	33	1.890	1.545	1	2.920	
15	2.920	2.920	1	8.463	34	12.380	1.545	1	19.127	
16	1.945	3.480	1	6.769	35	5.960	2.265	1	13.499	
17	0.600	1.495	1	0.897	36	16.450	2.265	1	37.259	
18	3.140	0.830	1	2.608	L1	2.000	3.000	1	6.000	
19	0.410	3.000	1	1.230	L2	1.900	3.000	1	5.700	
Total (B) =									566.525	
SUMMARY (A) - (B) - (C) 497.314 Sqm										
TOTAL FAR AREA AT TYPICAL FLOOR 497.314 Sqm										
SERVICE AREA (Additional 15% of FAR) = (CB) + (C)										
SERVICE AREA (Additional 15% of FAR) = 54.900 Sqm										

SERVICE AREA (Additional 15% of FAR) CUP BOARDS (CB)					CUP
TYPE	LENGTH	WIDTH	NOS	AREA	
CB1	0.500	1.545	5	4.635	
CB2	0.485	1.585	2	1.537	
CB3	1.320	0.485	2	0.969	
CB4	0.485	1.790	3	2.604	
CB5	1.315	0.485	2	1.276	
CB6	1.310	0.485	1	0.635	
CB7	0.800	1.685	1	1.011	
Total Cupboards Area (CB) =					12.688
SERVICE AREA (Additional 15% of FAR) Lift Lobby, Fire Exit Stair & Service Shafts					
E1	0.525	2.365	1	1.242	
E2	0.600	0.600	2	0.360	
E3	1.200	0.600	1	0.720	
E4	2.400	0.600	1	1.440	
E5	1.335	0.600	1	0.801	
E6	0.270	1.670	1	0.505	
S1	1.830	5.165	1	9.468	
S2	0.280	5.165	1	0.723	
S3	3.455	3.850	1	6.651	
S4	4.590	2.445	1	11.223	
X1	0.485	0.370	4	0.718	
X2	0.750	2.365	2	3.548	
X3	0.600	2.365	1	1.419	
X8	1.715	1.055	1	1.809	
X7	1.410	0.370	1	0.522	
X8	1.410	0.400	1	0.564	
TOTAL (C)					42.212

DOOR WINDOW SCHEDULE				
S.NO	TITLE	LENGTH	WIDTH	LINTEL
1	MAIN DOOR (MD)	2000	2100	2100
2	D1	1050	2100	2100
3	D2	930	2100	2100
4	D3	780	2100	2100
5	DW1	2030	2100	2100
6	DW2	1855	2100	2100
7	DW3	1630	2100	2100
8	DW4	1736	2100	2100
9	DW5	1685	2100	2100
10	DW6	1515	2100	2100
11	W1	1459	900	900
12	W2	1180	900	900
13	W3	1645	900	1050
14	W4	850	900	900
15	W5	600	900	2100

Key Plan-EXPRESS PARK VIEW II

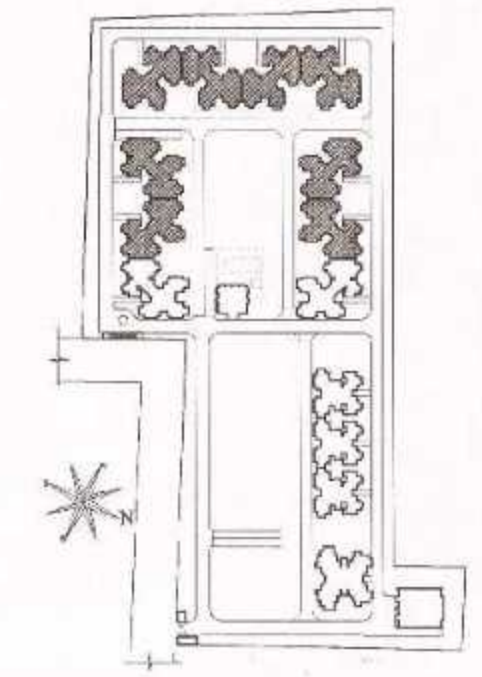

- PLUMBING LEGEND:-
- ① 110mm UPVC SOIL & VENT PIPE
 - ② 110mm UPVC WASTE & VENT PIPE
 - ③ 50mm UPVC AIR-SPRINTING PIPE
 - ④ DOMESTIC WATER IN, TAP
 - ⑤ FLUSHING WATER IN, TAP
 - ⑥ DOMESTIC WATER RISE TO G.H.T.
 - ⑦ FLUSHING WATER RISE TO G.H.T.
 - ⑧ 110mm OD UPVC DRAIN PIPE FOR BALCONY & TERRACE
 - ⑨ 110mm OD UPVC DRAIN PIPE FOR TERRACE
 - FD FLOOR DRAIN
 - FT FLOOR TRAP

- NOTES ON FIRE FIGHTING:
- 1. REFER THE SLL FOR EXISTING AS PER IS STANDARDS:-
 - (A) 100MM PIPE HYDRANT PIPE
 - (B) 100 MM SPRINKLER PIPE
 - (C) 80 MM DRAIN PIPE

ARCHITECTS:
GIAN P. MATHUR & ASSOCIATES PVT.LTD.
ARCHITECTS, ENGINEERS & PLANNERS
C-55, EAST OF KAILASH, NEW DELHI-110065
PH: 011-46599597 FAX: 011-46599512
EMAIL: gpma@satyam.net.in

ARCHITECT SIGNATURE:
GIAN P. MATHUR
B. Arch., M.C.A., A.I.T.A.
CA No. 80/5769

CLIENT:
M/S IITL- NIMBUS THE EXPRESS PARK VIEW,
313-315, VIKAS DEEP BUILDING, DIS-1,
CENTER, LAXMI NAGAR, DELHI-92

OWNER SIGNATURE:
[Signature]
Authorised Signatory

JOB TITLE:
SUBMISSION DRAWING

PROJECT:
THE EXPRESS PARK VIEW,
PLOT NO. GH-03, SECTOR - CH-V,
GREATER NOIDA, (U.P.)

DRAWING TITLE:
TOWER-J, K, L, M, N, O, P, Q, R, S, T, U, V, W, X, Y, Z
TYPICAL FLOOR PLAN-1ST TO 19TH FLOORS

JOB NO. 2364
SCALE: 1:100
DATE: 05-06-2012
DEALT - YASHPAL
CHECKED BY: REVISION NO.

GREATER NOIDA AUTHORITY :-

ASSOCIATE ARCHITECT ARCHITECT CHIEF ARCHITECT