

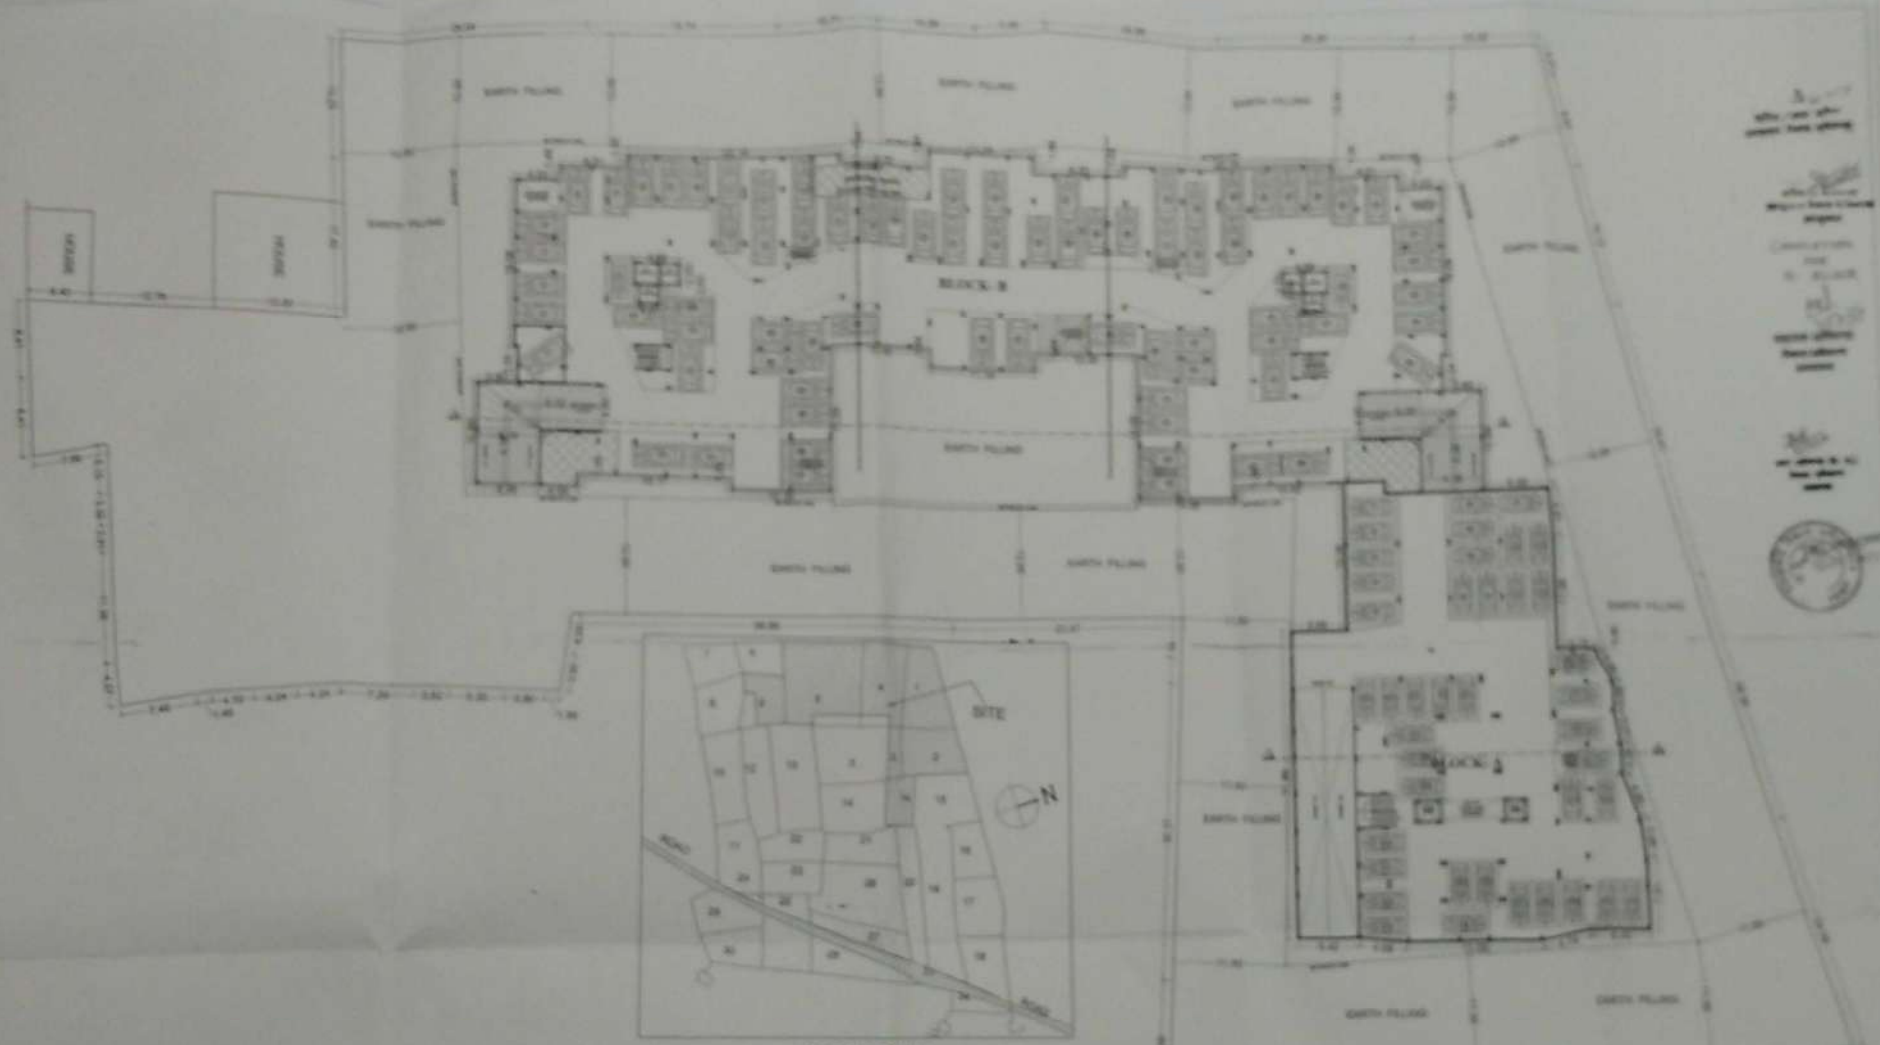


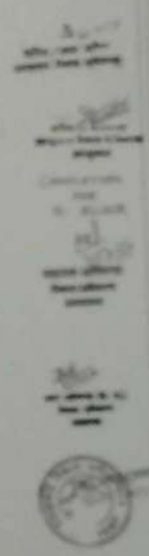

PROJECT INFORMATION PROJECT NAME: [illegible] PROJECT LOCATION: [illegible] PROJECT NO.: [illegible] DATE: [illegible]	
DESIGNER INFORMATION DESIGNER: [illegible] DESIGNER ADDRESS: [illegible] DESIGNER PHONE: [illegible] DESIGNER FAX: [illegible] DESIGNER EMAIL: [illegible]	
CLIENT INFORMATION CLIENT: [illegible] CLIENT ADDRESS: [illegible] CLIENT PHONE: [illegible] CLIENT FAX: [illegible] CLIENT EMAIL: [illegible]	
APPROVALS DESIGNER: [illegible] CLIENT: [illegible]	

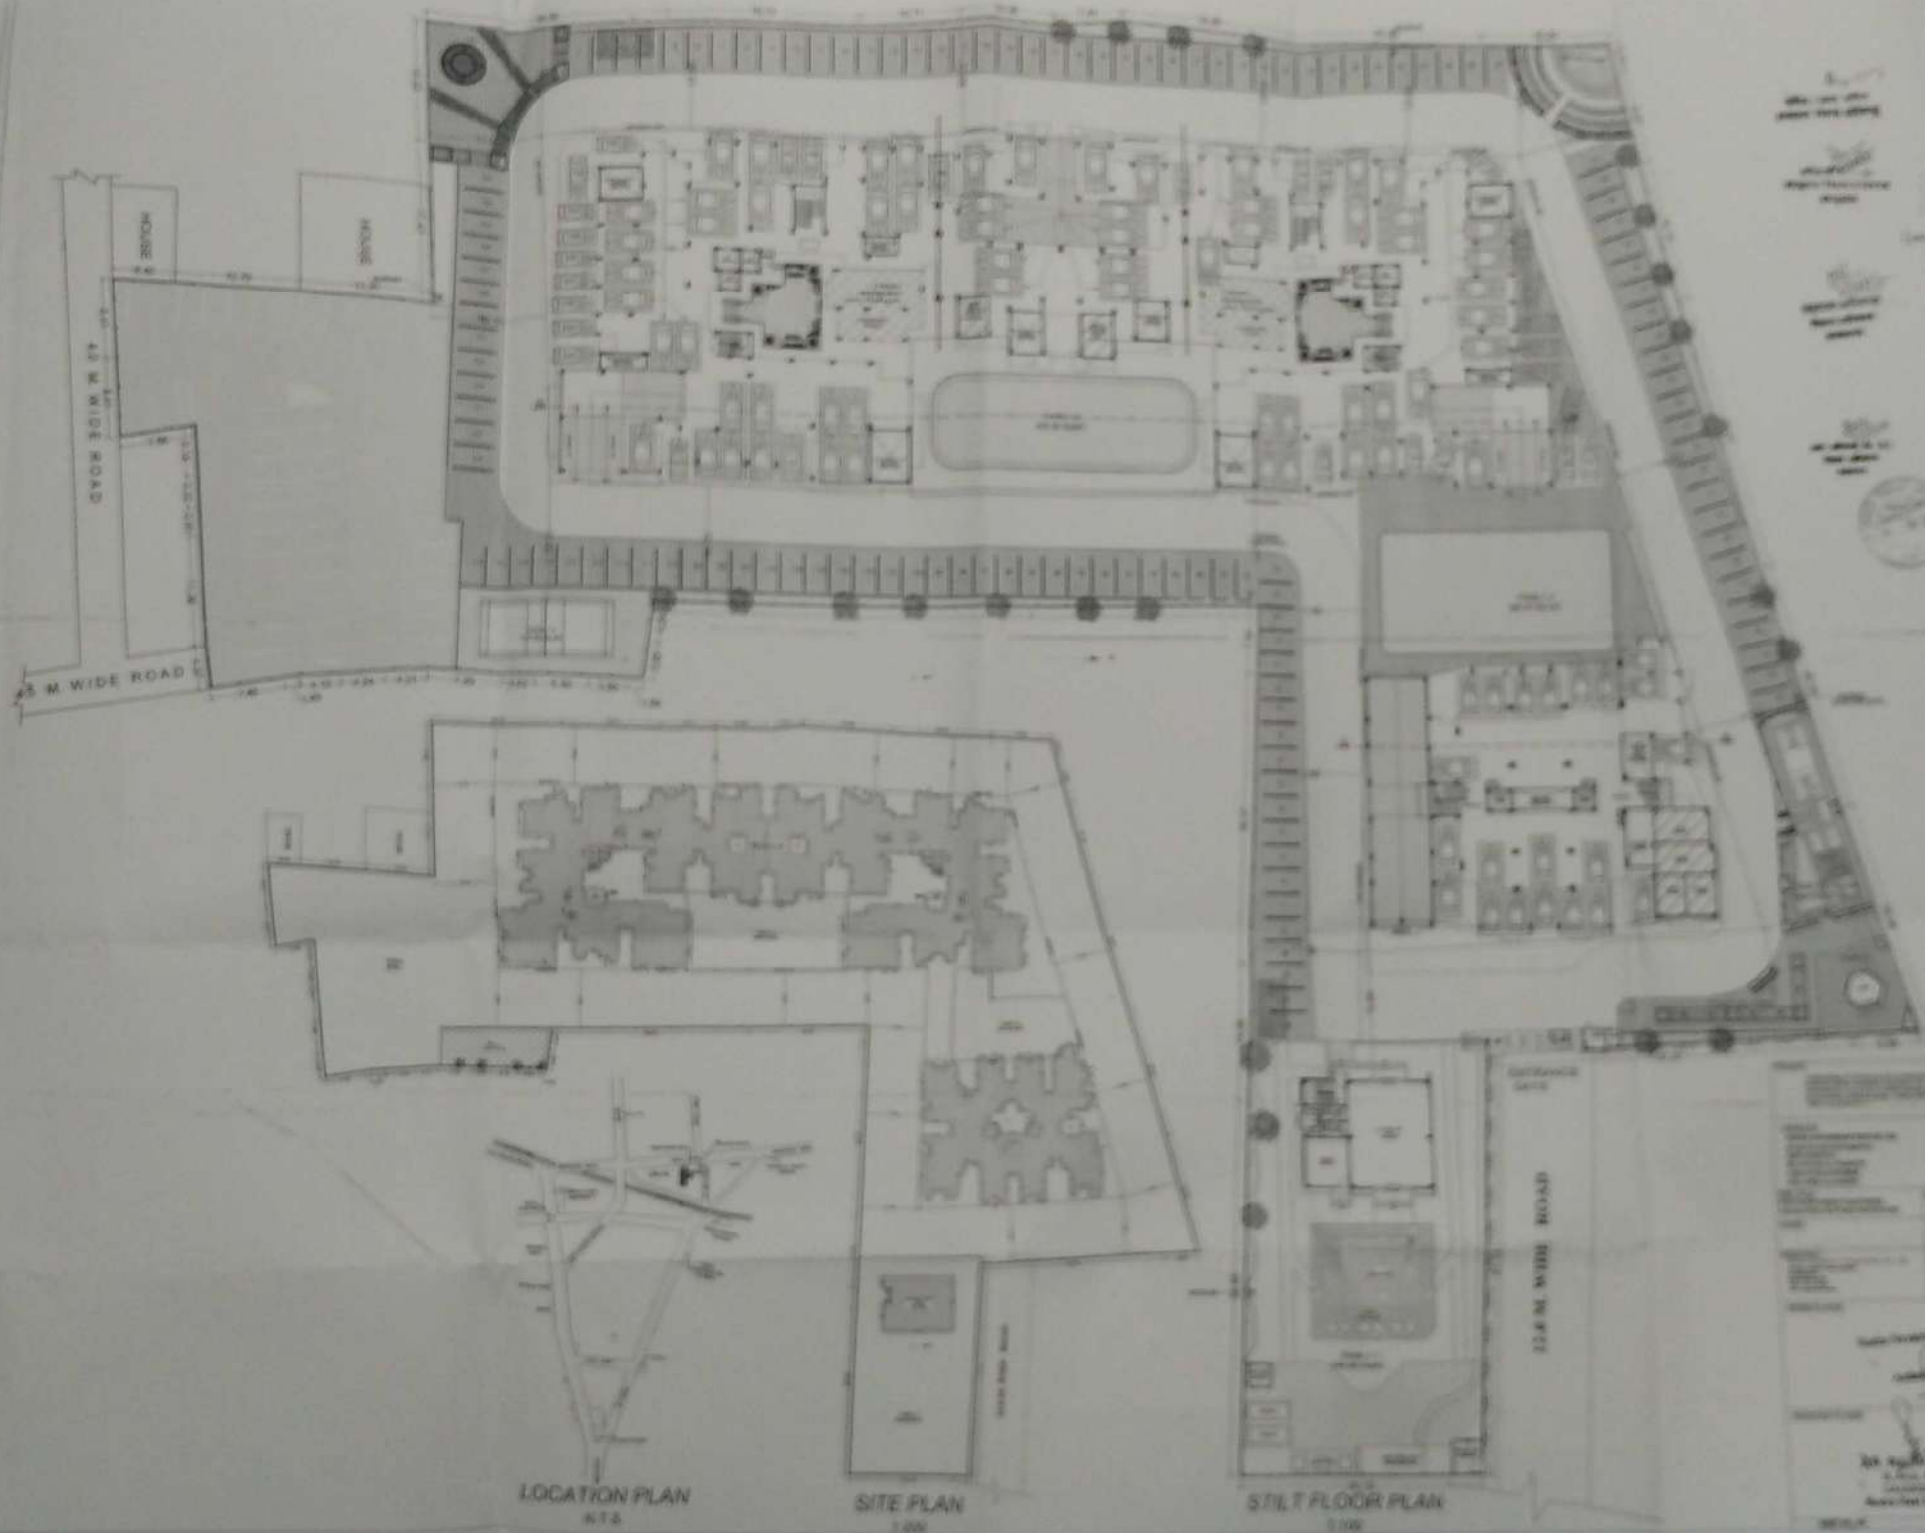


LOCATION PLAN
N.T.S.

SITE PLAN
1:500

STILT FLOOR PLAN
1:100

DR. NGUYEN VAN PHU
ARCHITECT
10/10/2010


B. Black Completion

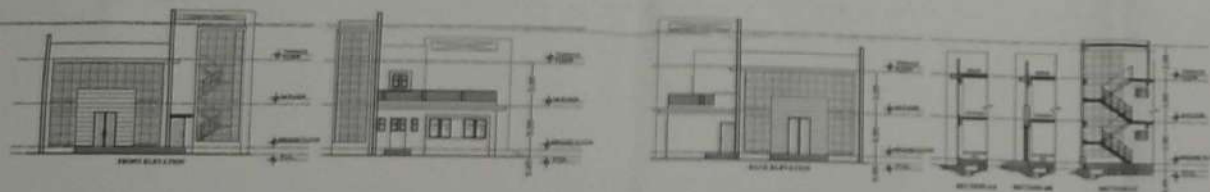

COMMUNITY CENTER AREA
CALCULATION SUMMARY
ONE THOUSIT FIVE HUNDRED

[illegible]

EXISTING AREA STATEMENT (IN F.A.R.)

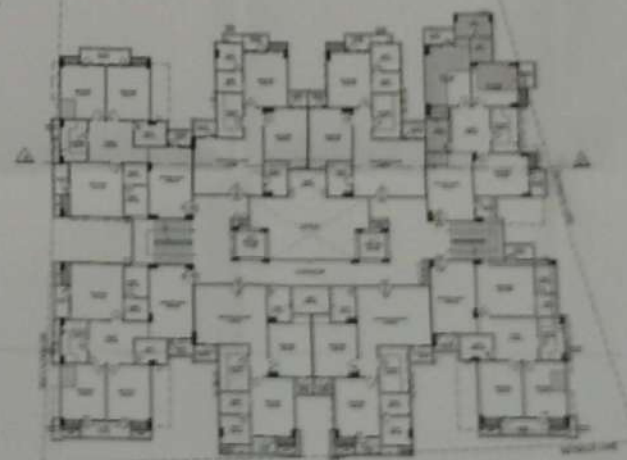
[illegible]

BLOCK-A
EXISTING 1st TO 6th
FLOOR AREA PLAN
PROPOSED - 0102 - 14' wide

Source: U.S. Census Bureau, *Marriage, Divorce, Remarriage in the 1990s* (Washington, D.C.: U.S. Government Printing Office, 1996), p. 10.


APR 20 1986

1. 1st Floor Plan
 2. 2nd Floor Plan
 3. 3rd Floor Plan
 4. 4th Floor Plan
 5. 5th Floor Plan
 6. 6th Floor Plan
 7. 7th Floor Plan
 8. 8th Floor Plan
 9. 9th Floor Plan
 10. 10th Floor Plan
 11. 11th Floor Plan
 12. 12th Floor Plan
 13. 13th Floor Plan
 14. 14th Floor Plan
 15. 15th Floor Plan
 16. 16th Floor Plan
 17. 17th Floor Plan
 18. 18th Floor Plan
 19. 19th Floor Plan
 20. 20th Floor Plan
 21. 21st Floor Plan
 22. 22nd Floor Plan
 23. 23rd Floor Plan
 24. 24th Floor Plan
 25. 25th Floor Plan
 26. 26th Floor Plan
 27. 27th Floor Plan
 28. 28th Floor Plan
 29. 29th Floor Plan
 30. 30th Floor Plan
 31. 31st Floor Plan
 32. 32nd Floor Plan
 33. 33rd Floor Plan
 34. 34th Floor Plan
 35. 35th Floor Plan
 36. 36th Floor Plan
 37. 37th Floor Plan
 38. 38th Floor Plan
 39. 39th Floor Plan
 40. 40th Floor Plan
 41. 41st Floor Plan
 42. 42nd Floor Plan
 43. 43rd Floor Plan
 44. 44th Floor Plan
 45. 45th Floor Plan
 46. 46th Floor Plan
 47. 47th Floor Plan
 48. 48th Floor Plan
 49. 49th Floor Plan
 50. 50th Floor Plan
 51. 51st Floor Plan
 52. 52nd Floor Plan
 53. 53rd Floor Plan
 54. 54th Floor Plan
 55. 55th Floor Plan
 56. 56th Floor Plan
 57. 57th Floor Plan
 58. 58th Floor Plan
 59. 59th Floor Plan
 60. 60th Floor Plan
 61. 61st Floor Plan
 62. 62nd Floor Plan
 63. 63rd Floor Plan
 64. 64th Floor Plan
 65. 65th Floor Plan
 66. 66th Floor Plan
 67. 67th Floor Plan
 68. 68th Floor Plan
 69. 69th Floor Plan
 70. 70th Floor Plan
 71. 71st Floor Plan
 72. 72nd Floor Plan
 73. 73rd Floor Plan
 74. 74th Floor Plan
 75. 75th Floor Plan
 76. 76th Floor Plan
 77. 77th Floor Plan
 78. 78th Floor Plan
 79. 79th Floor Plan
 80. 80th Floor Plan
 81. 81st Floor Plan
 82. 82nd Floor Plan
 83. 83rd Floor Plan
 84. 84th Floor Plan
 85. 85th Floor Plan
 86. 86th Floor Plan
 87. 87th Floor Plan
 88. 88th Floor Plan
 89. 89th Floor Plan
 90. 90th Floor Plan
 91. 91st Floor Plan
 92. 92nd Floor Plan
 93. 93rd Floor Plan
 94. 94th Floor Plan
 95. 95th Floor Plan
 96. 96th Floor Plan
 97. 97th Floor Plan
 98. 98th Floor Plan
 99. 99th Floor Plan
 100. 100th Floor Plan

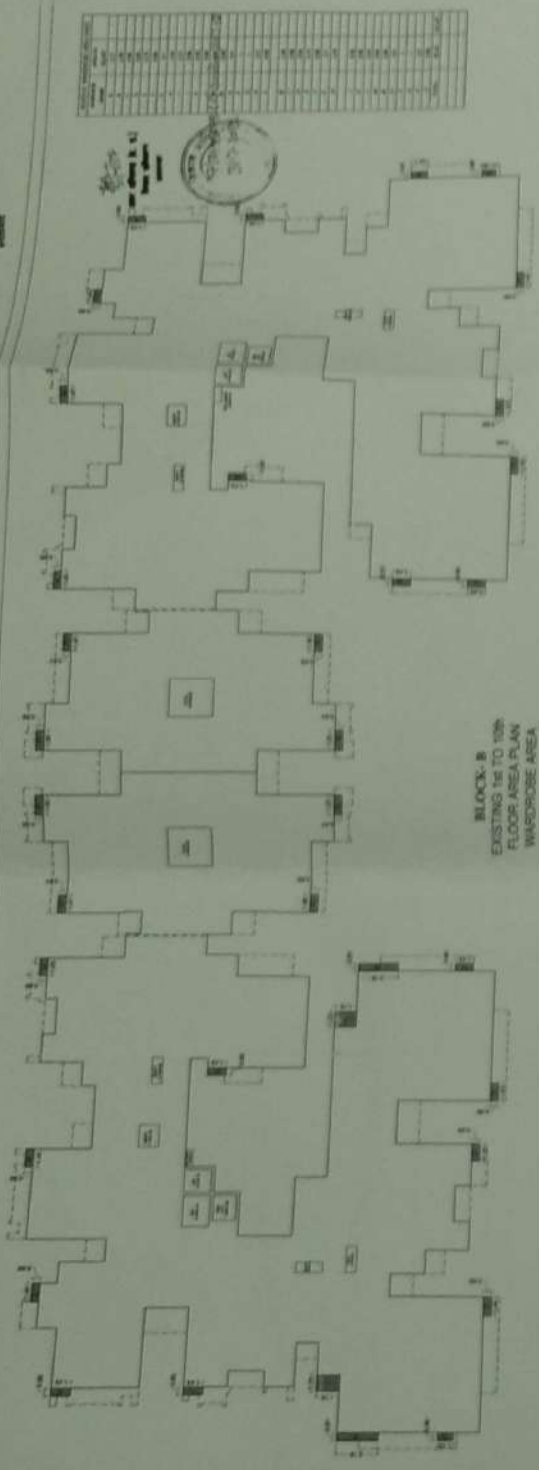


BLOCK B
 EXISTING 1st TO 10th
 FLOOR AREA PLAN
 WAREHOUSE AREA

B-BLOCK COMPLETION

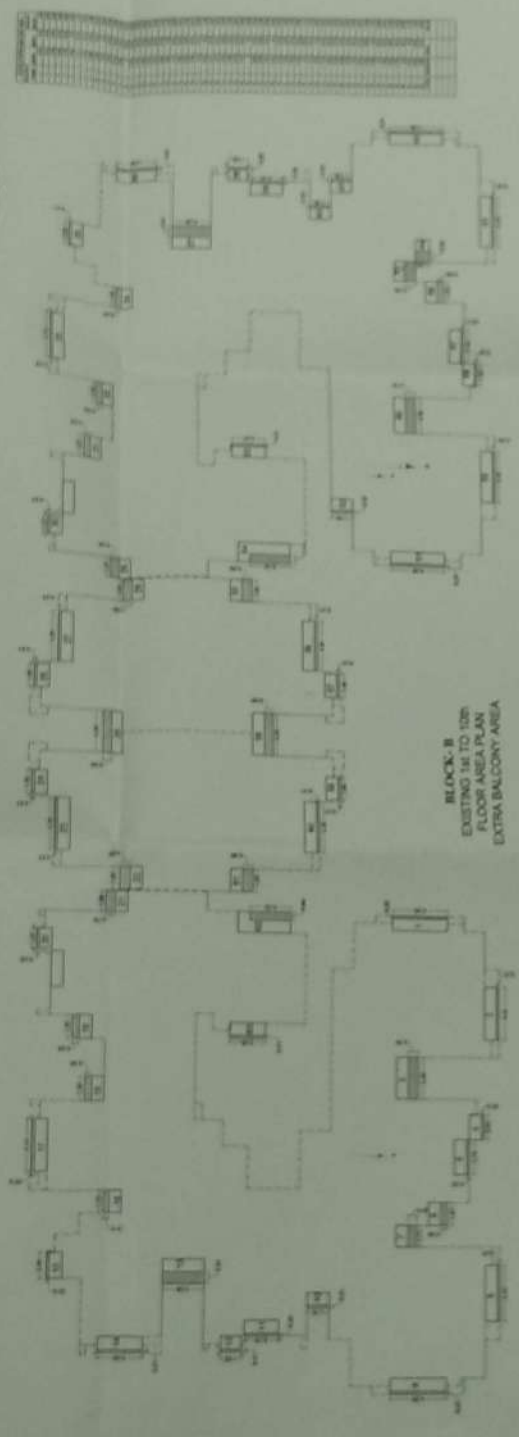






BLOCK B
 EXISTING 1st TO 10th
 FLOOR AREA PLAN
 EXTRA BALCONY AREA

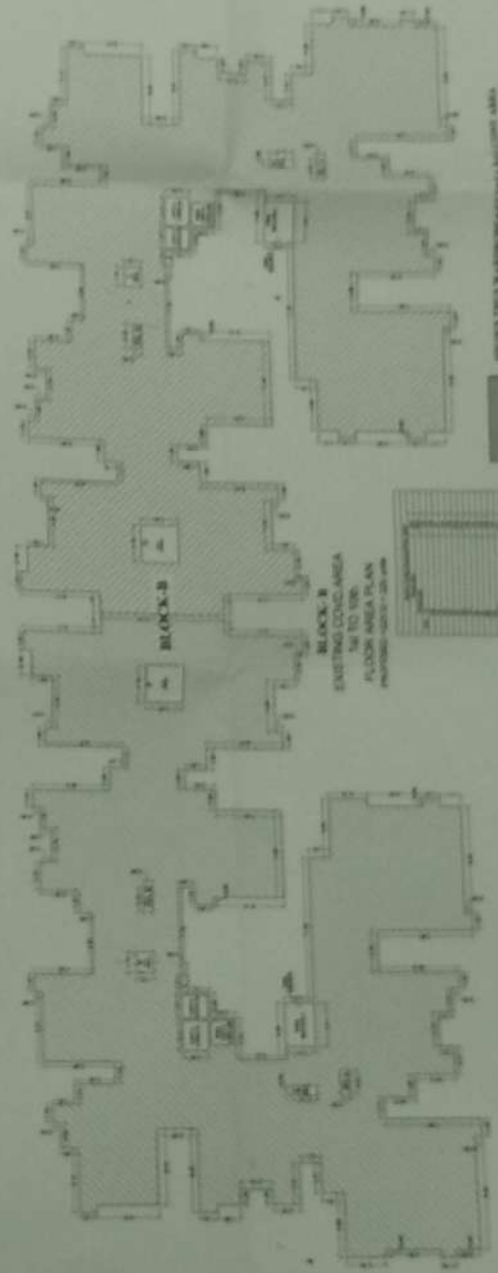


BLOCK B
 EXISTING CONCOURSE
 1st TO 10th
 FLOOR AREA PLAN
 PARKING AREA

BLOCKS 11-15 WAREHOUSE/STORAGE AREA
 BLOCKS 11-15 COMPLETION AREA

NO.	DESCRIPTION	UNIT	QTY	REMARKS
1	1st Floor Plan			
2	2nd Floor Plan			
3	3rd Floor Plan			
4	4th Floor Plan			
5	5th Floor Plan			
6	6th Floor Plan			
7	7th Floor Plan			
8	8th Floor Plan			
9	9th Floor Plan			
10	10th Floor Plan			
11	11th Floor Plan			
12	12th Floor Plan			
13	13th Floor Plan			
14	14th Floor Plan			
15	15th Floor Plan			
16	16th Floor Plan			
17	17th Floor Plan			
18	18th Floor Plan			
19	19th Floor Plan			
20	20th Floor Plan			
21	21st Floor Plan			
22	22nd Floor Plan			
23	23rd Floor Plan			
24	24th Floor Plan			
25	25th Floor Plan			
26	26th Floor Plan			
27	27th Floor Plan			
28	28th Floor Plan			
29	29th Floor Plan			
30	30th Floor Plan			
31	31st Floor Plan			
32	32nd Floor Plan			
33	33rd Floor Plan			
34	34th Floor Plan			
35	35th Floor Plan			
36	36th Floor Plan			
37	37th Floor Plan			
38	38th Floor Plan			
39	39th Floor Plan			
40	40th Floor Plan			
41	41st Floor Plan			
42	42nd Floor Plan			
43	43rd Floor Plan			
44	44th Floor Plan			
45	45th Floor Plan			
46	46th Floor Plan			
47	47th Floor Plan			
48	48th Floor Plan			
49	49th Floor Plan			
50	50th Floor Plan			
51	51st Floor Plan			
52	52nd Floor Plan			
53	53rd Floor Plan			
54	54th Floor Plan			
55	55th Floor Plan			
56	56th Floor Plan			
57	57th Floor Plan			
58	58th Floor Plan			
59	59th Floor Plan			
60	60th Floor Plan			
61	61st Floor Plan			
62	62nd Floor Plan			
63	63rd Floor Plan			
64	64th Floor Plan			
65	65th Floor Plan			
66	66th Floor Plan			
67	67th Floor Plan			
68	68th Floor Plan			
69	69th Floor Plan			
70	70th Floor Plan			
71	71st Floor Plan			
72	72nd Floor Plan			
73	73rd Floor Plan			
74	74th Floor Plan			
75	75th Floor Plan			
76	76th Floor Plan			
77	77th Floor Plan			
78	78th Floor Plan			
79	79th Floor Plan			
80	80th Floor Plan			
81	81st Floor Plan			
82	82nd Floor Plan			
83	83rd Floor Plan			
84	84th Floor Plan			
85	85th Floor Plan			
86	86th Floor Plan			
87	87th Floor Plan			
88	88th Floor Plan			
89	89th Floor Plan			
90	90th Floor Plan			
91	91st Floor Plan			
92	92nd Floor Plan			
93	93rd Floor Plan			
94	94th Floor Plan			
95	95th Floor Plan			
96	96th Floor Plan			
97	97th Floor Plan			
98	98th Floor Plan			
99	99th Floor Plan			
100	100th Floor Plan			

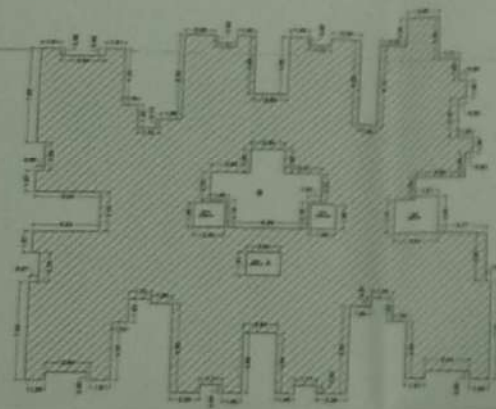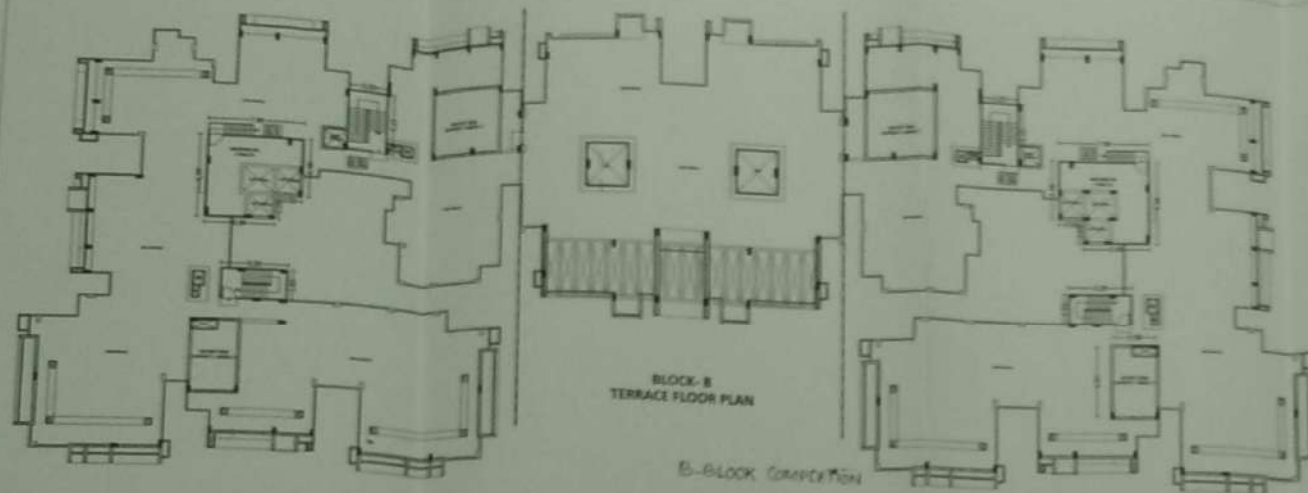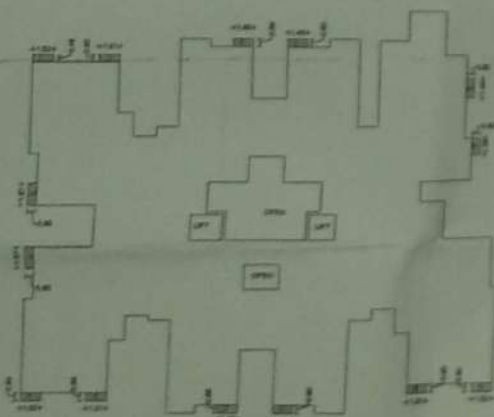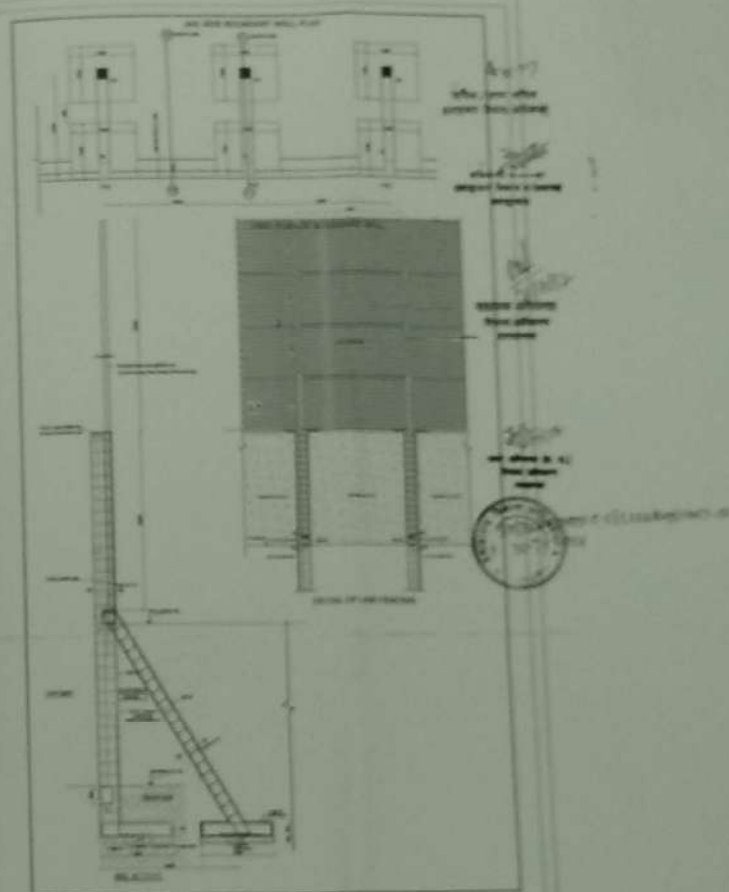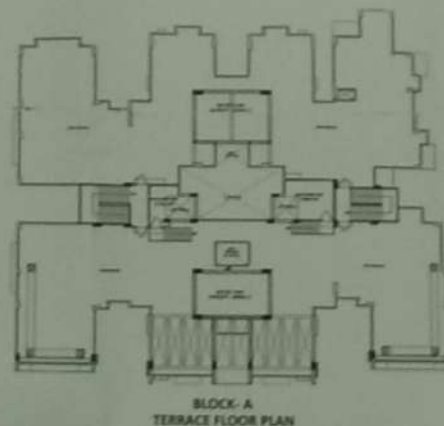[illegible]

SOUTH AFRICAN RAILWAYS			
Year	1990	1991	1992
1	1.0	1.0	1.0
2	1.0	1.0	1.0
3	1.0	1.0	1.0
100	1.0	1.0	1.0

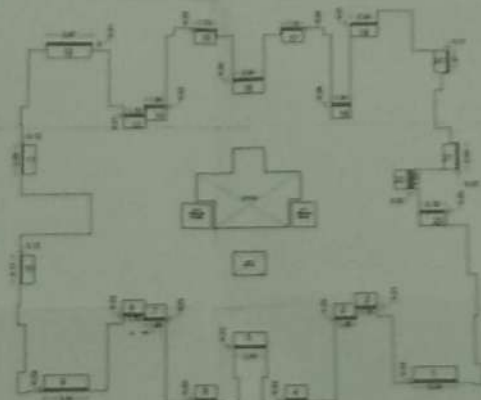

100


☐ SHOWN THIS WORKING/REACTING BALLOON AREA

☐ SHOWN THIS COMPOUNDING AREA

[illegible]

John H. Garvey, Jr., Editor

MR. RICHARD S. LIPSON
2 South Hill Ave.
Cambridge, Mass.
Boston Post Office 146

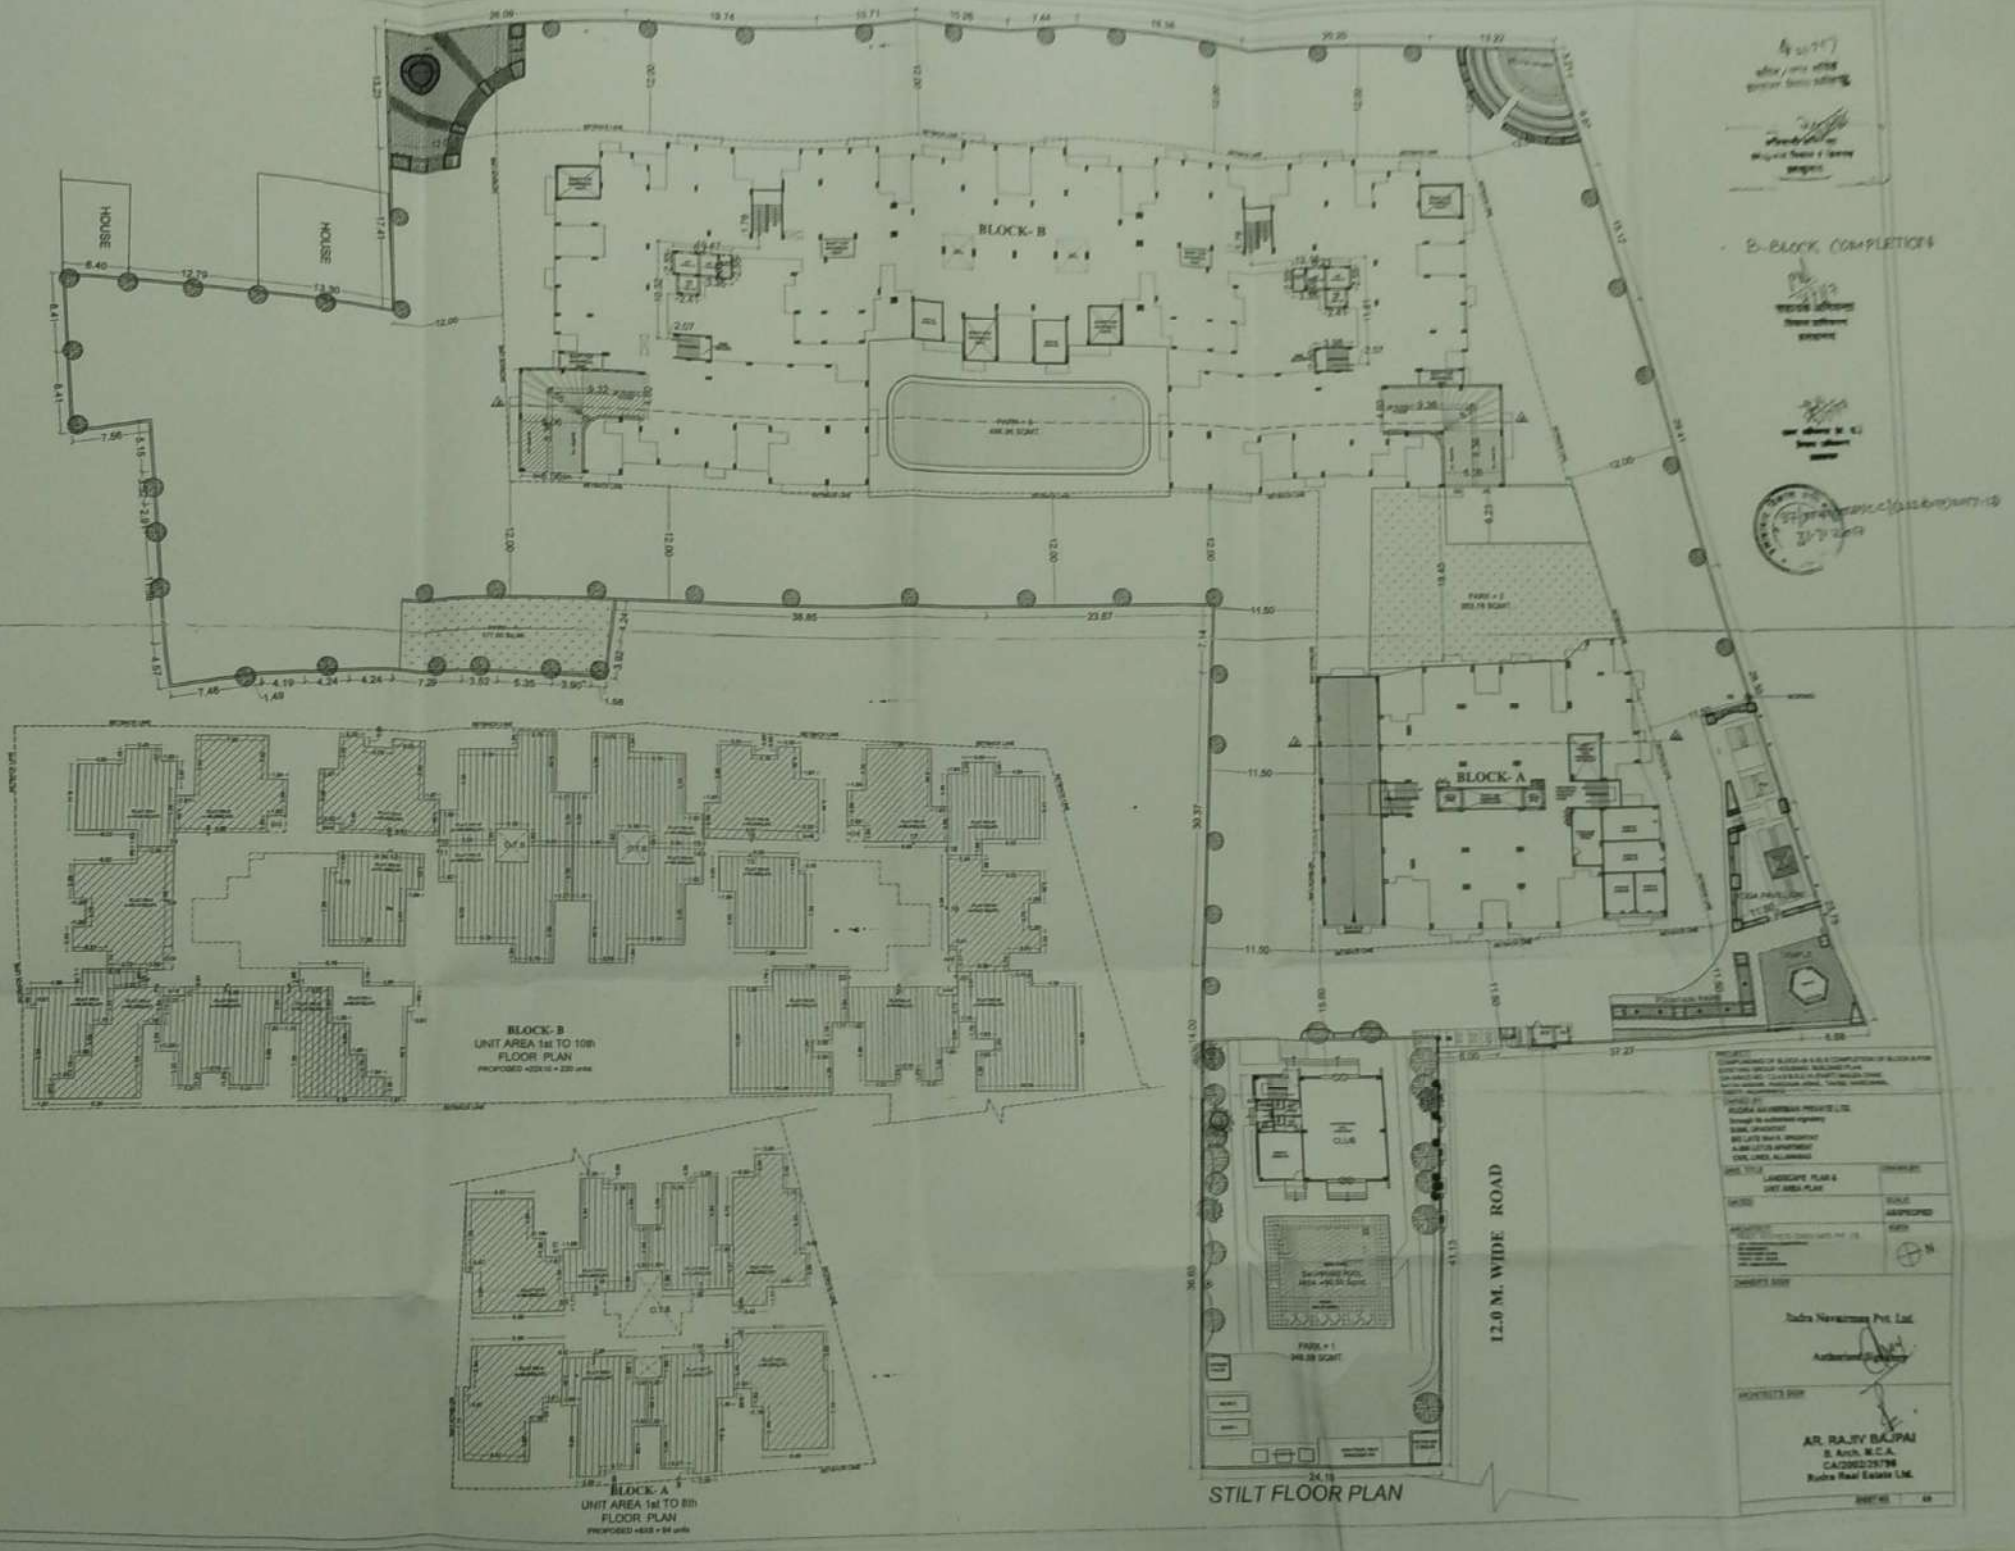

4-20-77
Office / Home Office
Executive / Senior Advisor

[Signature]
President / Director of Operations
[Signature]

B-BLOCK COMPLETIONS

सहायक अधीक्षक
विद्यालय अजमेर
अजमेर

1000
 1000
 1000

377209

[illegible]


NO. 001	LANDSCAPE PLAN & SITE AREA PLAN	SHEET NO.
DATE		SCALE
APPROVED BY: [Signature] [Name]		N
DRAWN BY: [Signature] [Name]		

Rafael N. Ramirez, P.E., Inc.


[Signature]

AR. RAJIV RAJPAI
B. Arch. M.C.A.
CA/2001/25796
Rudra Real Estate Ltd.

24848

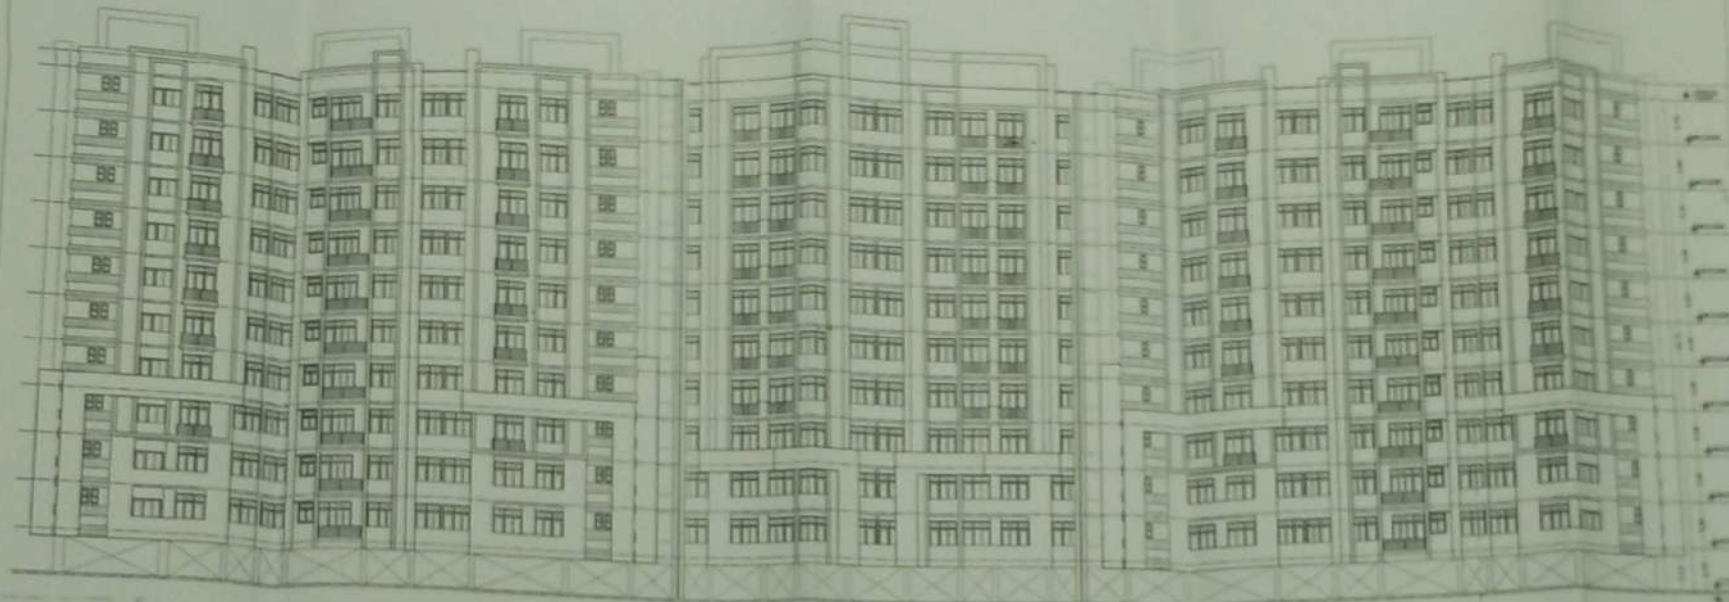

FRONT ELEVATION (BLOCK -B)

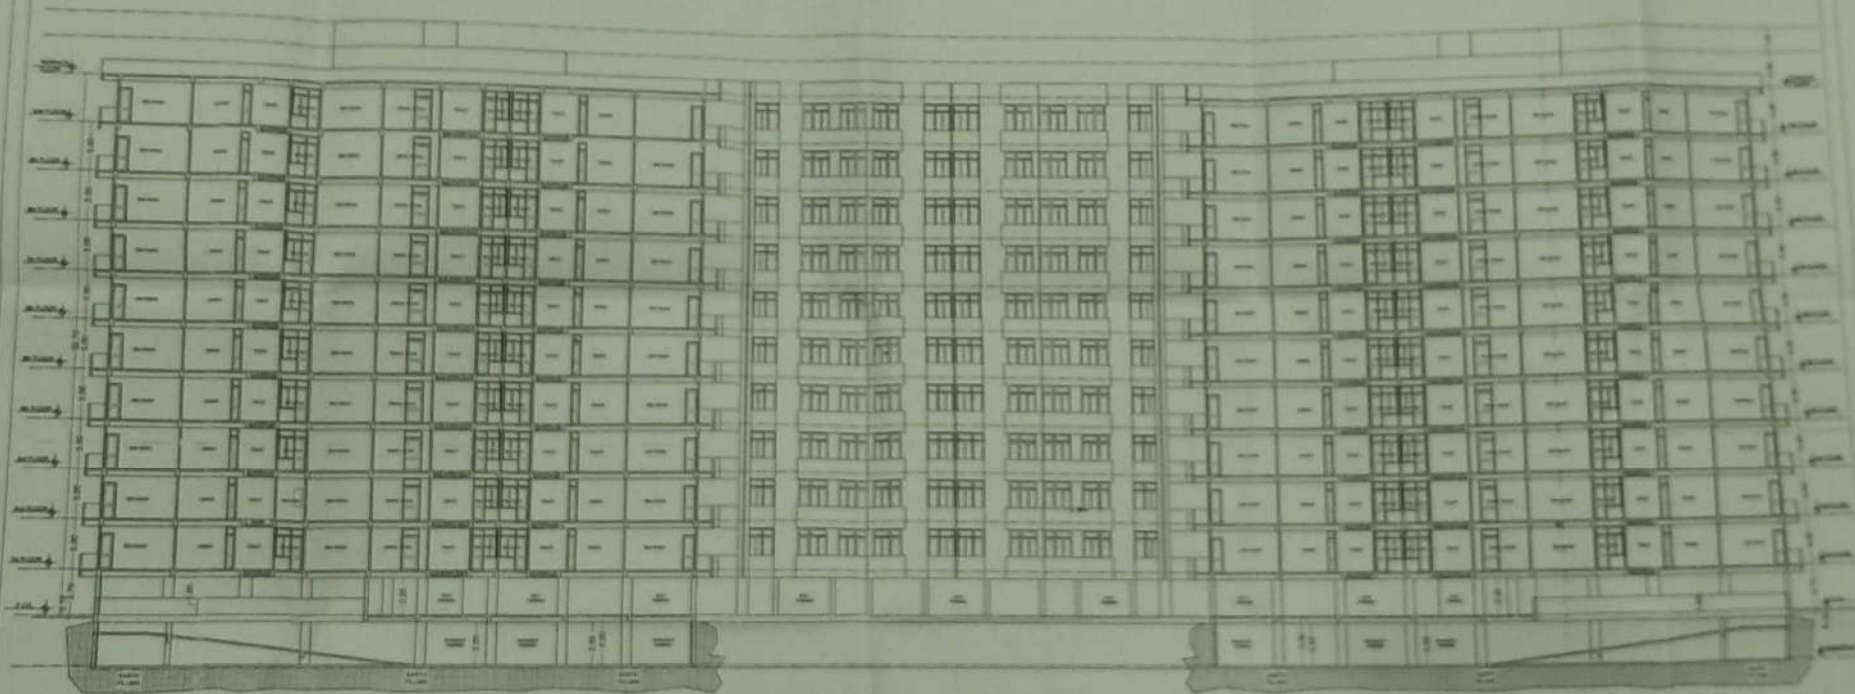

SECTION AT- BB' (BLOCK -B)

PROJECT: COMPLETION OF BLOCK (A & B) & COMPLETION OF BLOCK-B FOR EXISTING GROUP HOUSING BUILDING PLAN ON AREA NO. 1, 2, 3 & 9.3.14 (PART) MALWA CHAK, BATAI MISHRI, PARGANA ANAUL, TALUK KANHGAHA, DISTT. ALLAHABAD	OWNED BY: RUDRA NAVNIRMAN PRIVATE LTD. Through its authorized signatory SUNIL UPADHYAY S/O LATE SHRI H. UPADHYAY A-305 LOTUS APARTMENT CIVIL LINES, ALLAHABAD	DRG. TITLE ELEVATION & SECTION BLOCK - B DATED:	DRAWN BY: SCALE AS SPECIFIED	ARCHITECT DR. RAJIV RAJPAI 8, ANIL NAGAR, KANUNGI 221002, INDIA TEL: 0522-2210021 FAX: 0522-2210022 E-MAIL: RAJIV@RAJPAI.COM	NORTH 	OWNER'S SIGN Rudra Navnirman Pvt. Ltd. 	ARCHITECT'S SIGN DR. RAJIV RAJPAI 8, ANIL NAGAR, KANUNGI Rudra Navnirman Pvt. Ltd.	SHEET NO. 19
---	--	--	--	---	------------------	--	---	---------------------




1/100







Sl. No.	Room No.	Area (sq. m.)	Volume (cu. m.)	Height (m.)	Remarks
1	101	10.00	10.00	3.00	Room
2	102	10.00	10.00	3.00	Room
3	103	10.00	10.00	3.00	Room
4	104	10.00	10.00	3.00	Room
5	105	10.00	10.00	3.00	Room
6	106	10.00	10.00	3.00	Room
7	107	10.00	10.00	3.00	Room
8	108	10.00	10.00	3.00	Room
9	109	10.00	10.00	3.00	Room
10	110	10.00	10.00	3.00	Room
11	111	10.00	10.00	3.00	Room
12	112	10.00	10.00	3.00	Room
13	113	10.00	10.00	3.00	Room
14	114	10.00	10.00	3.00	Room
15	115	10.00	10.00	3.00	Room
16	116	10.00	10.00	3.00	Room
17	117	10.00	10.00	3.00	Room
18	118	10.00	10.00	3.00	Room
19	119	10.00	10.00	3.00	Room
20	120	10.00	10.00	3.00	Room

1/100

1/100

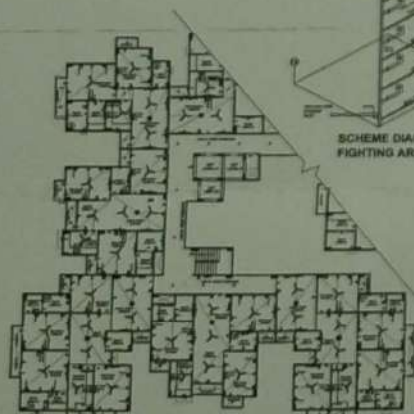

ELECTRICAL LAYOUT PLAN
(TYPICAL FLOOR)

    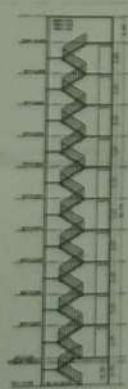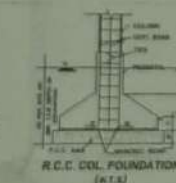

RAIN WATER HARVESTING

- NOTES (CONTINUED)
1. All dimensions are in meters.
 2. All areas are in square meters.
 3. All volumes are in cubic meters.
 4. All heights are in meters.
 5. All weights are in kilograms.
 6. All materials are as per specification.
 7. All work is to be done as per drawing.
 8. All work is to be done as per specification.
 9. All work is to be done as per drawing.
 10. All work is to be done as per specification.

STILT FLOOR PLAN

1/100

12.0 M. WIDE ROAD

Sl. No.	Room No.	Area (sq. m.)	Volume (cu. m.)	Height (m.)	Remarks
1	101	10.00	10.00	3.00	Room
2	102	10.00	10.00	3.00	Room
3	103	10.00	10.00	3.00	Room
4	104	10.00	10.00	3.00	Room
5	105	10.00	10.00	3.00	Room
6	106	10.00	10.00	3.00	Room
7	107	10.00	10.00	3.00	Room
8	108	10.00	10.00	3.00	Room
9	109	10.00	10.00	3.00	Room
10	110	10.00	10.00	3.00	Room
11	111	10.00	10.00	3.00	Room
12	112	10.00	10.00	3.00	Room
13	113	10.00	10.00	3.00	Room
14	114	10.00	10.00	3.00	Room
15	115	10.00	10.00	3.00	Room
16	116	10.00	10.00	3.00	Room
17	117	10.00	10.00	3.00	Room
18	118	10.00	10.00	3.00	Room
19	119	10.00	10.00	3.00	Room
20	120	10.00	10.00	3.00	Room

1/100

1/100

1/100

1/100

1/100

1/100

1/100