


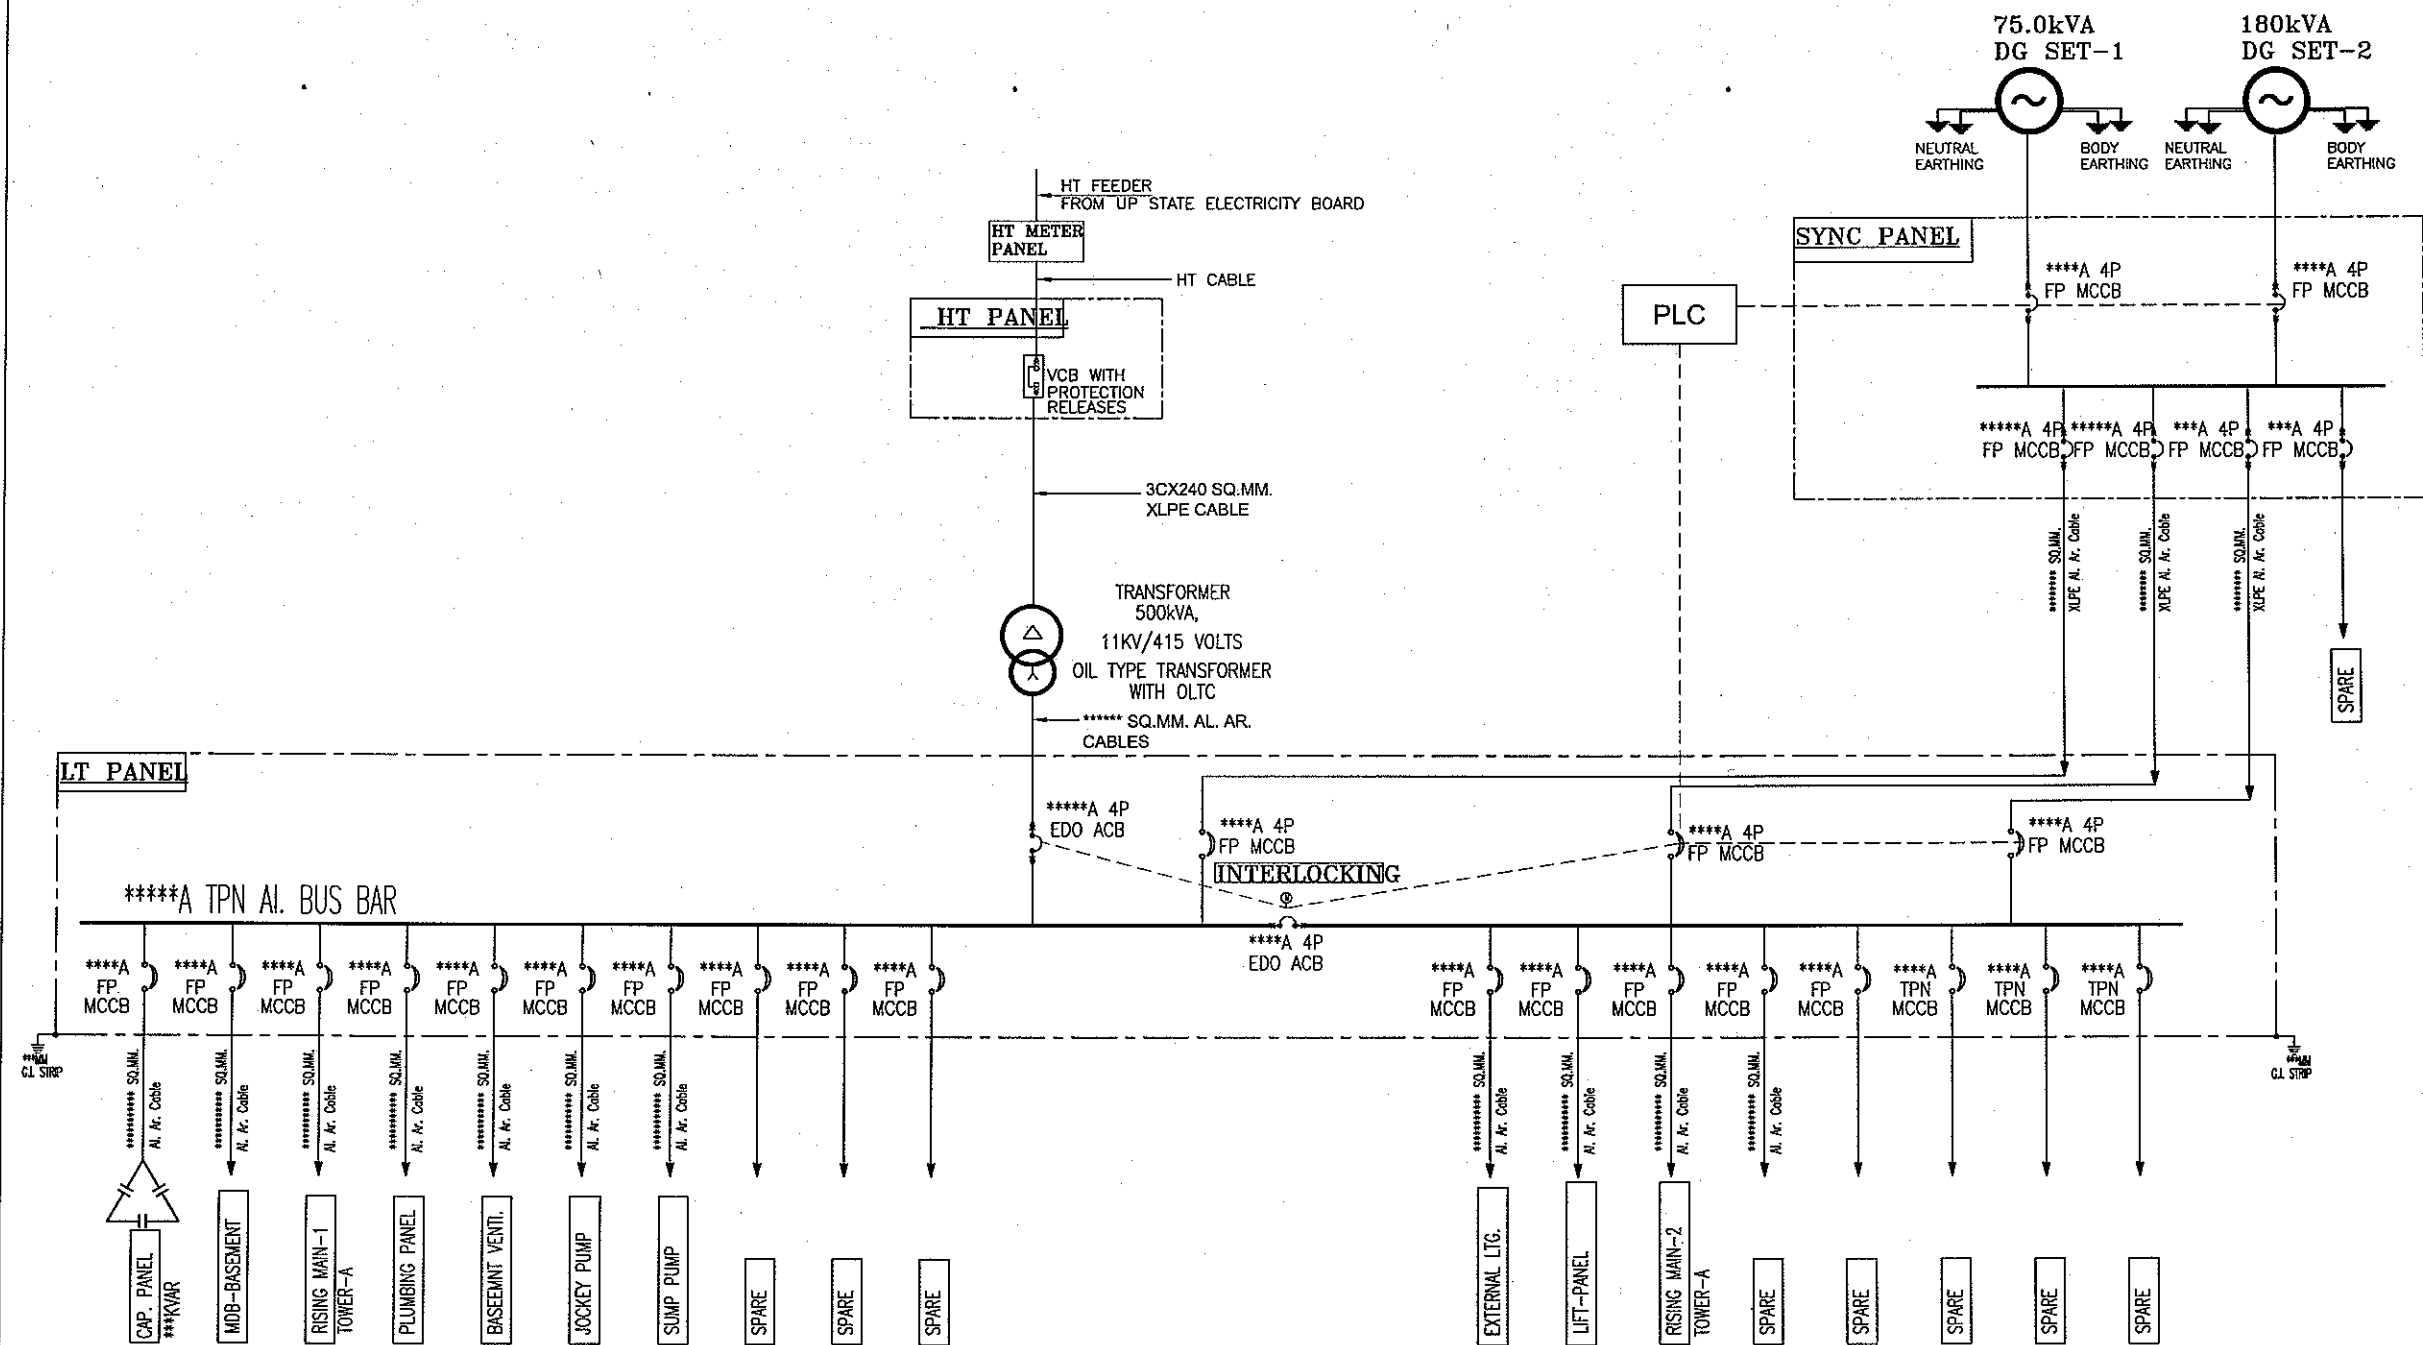

CONCEPTUAL SUB-STATION

NOTE:- ALL DIMENSION ARE IN MM

OWNER:-

RAM SHYAM BUILDERS PVT. LTD.
Durga Plaza, S-3, IInd Floor,
10, Sanjay Nagar
District Centre, Ghaziabad.

ARCHITECT'S SIGNATURE :-

OWNER'S SIGNATURE :-

PROJECT :-

APRAMEYA RESIDENCY
APARTMENTS AT
NOOR NAGAR , Ghaziabad

PROJECT CONSULTANTS :-

HOLISTICS URBAN INNOVATIONS PVT. LTD.
PLANNING & ARCHITECTURE EPC & KEPC ACTIVITIES
GREEN & ENERGY SERVICES BUILDING TECH. SERVICES.
THE CORETHUM, TOWER- A-41, SEC.- 62, NOIDA 201 301
PH.- 0120-4527777, FAX- 0120-4527788

HOLISTICS
URBAN INNOVATIONS

ELECTRICAL CONSULTANTS :-

NATURE OF DRAWING:-

SINGLE LINE DIAGRAM

DRG. NO.	EL-01	DATE	12-08-2017	NORTH :-
DRG. TITLE	SLD	SCALE	N.T.S.	N
REMARKS				
A				0 0 0 2

