


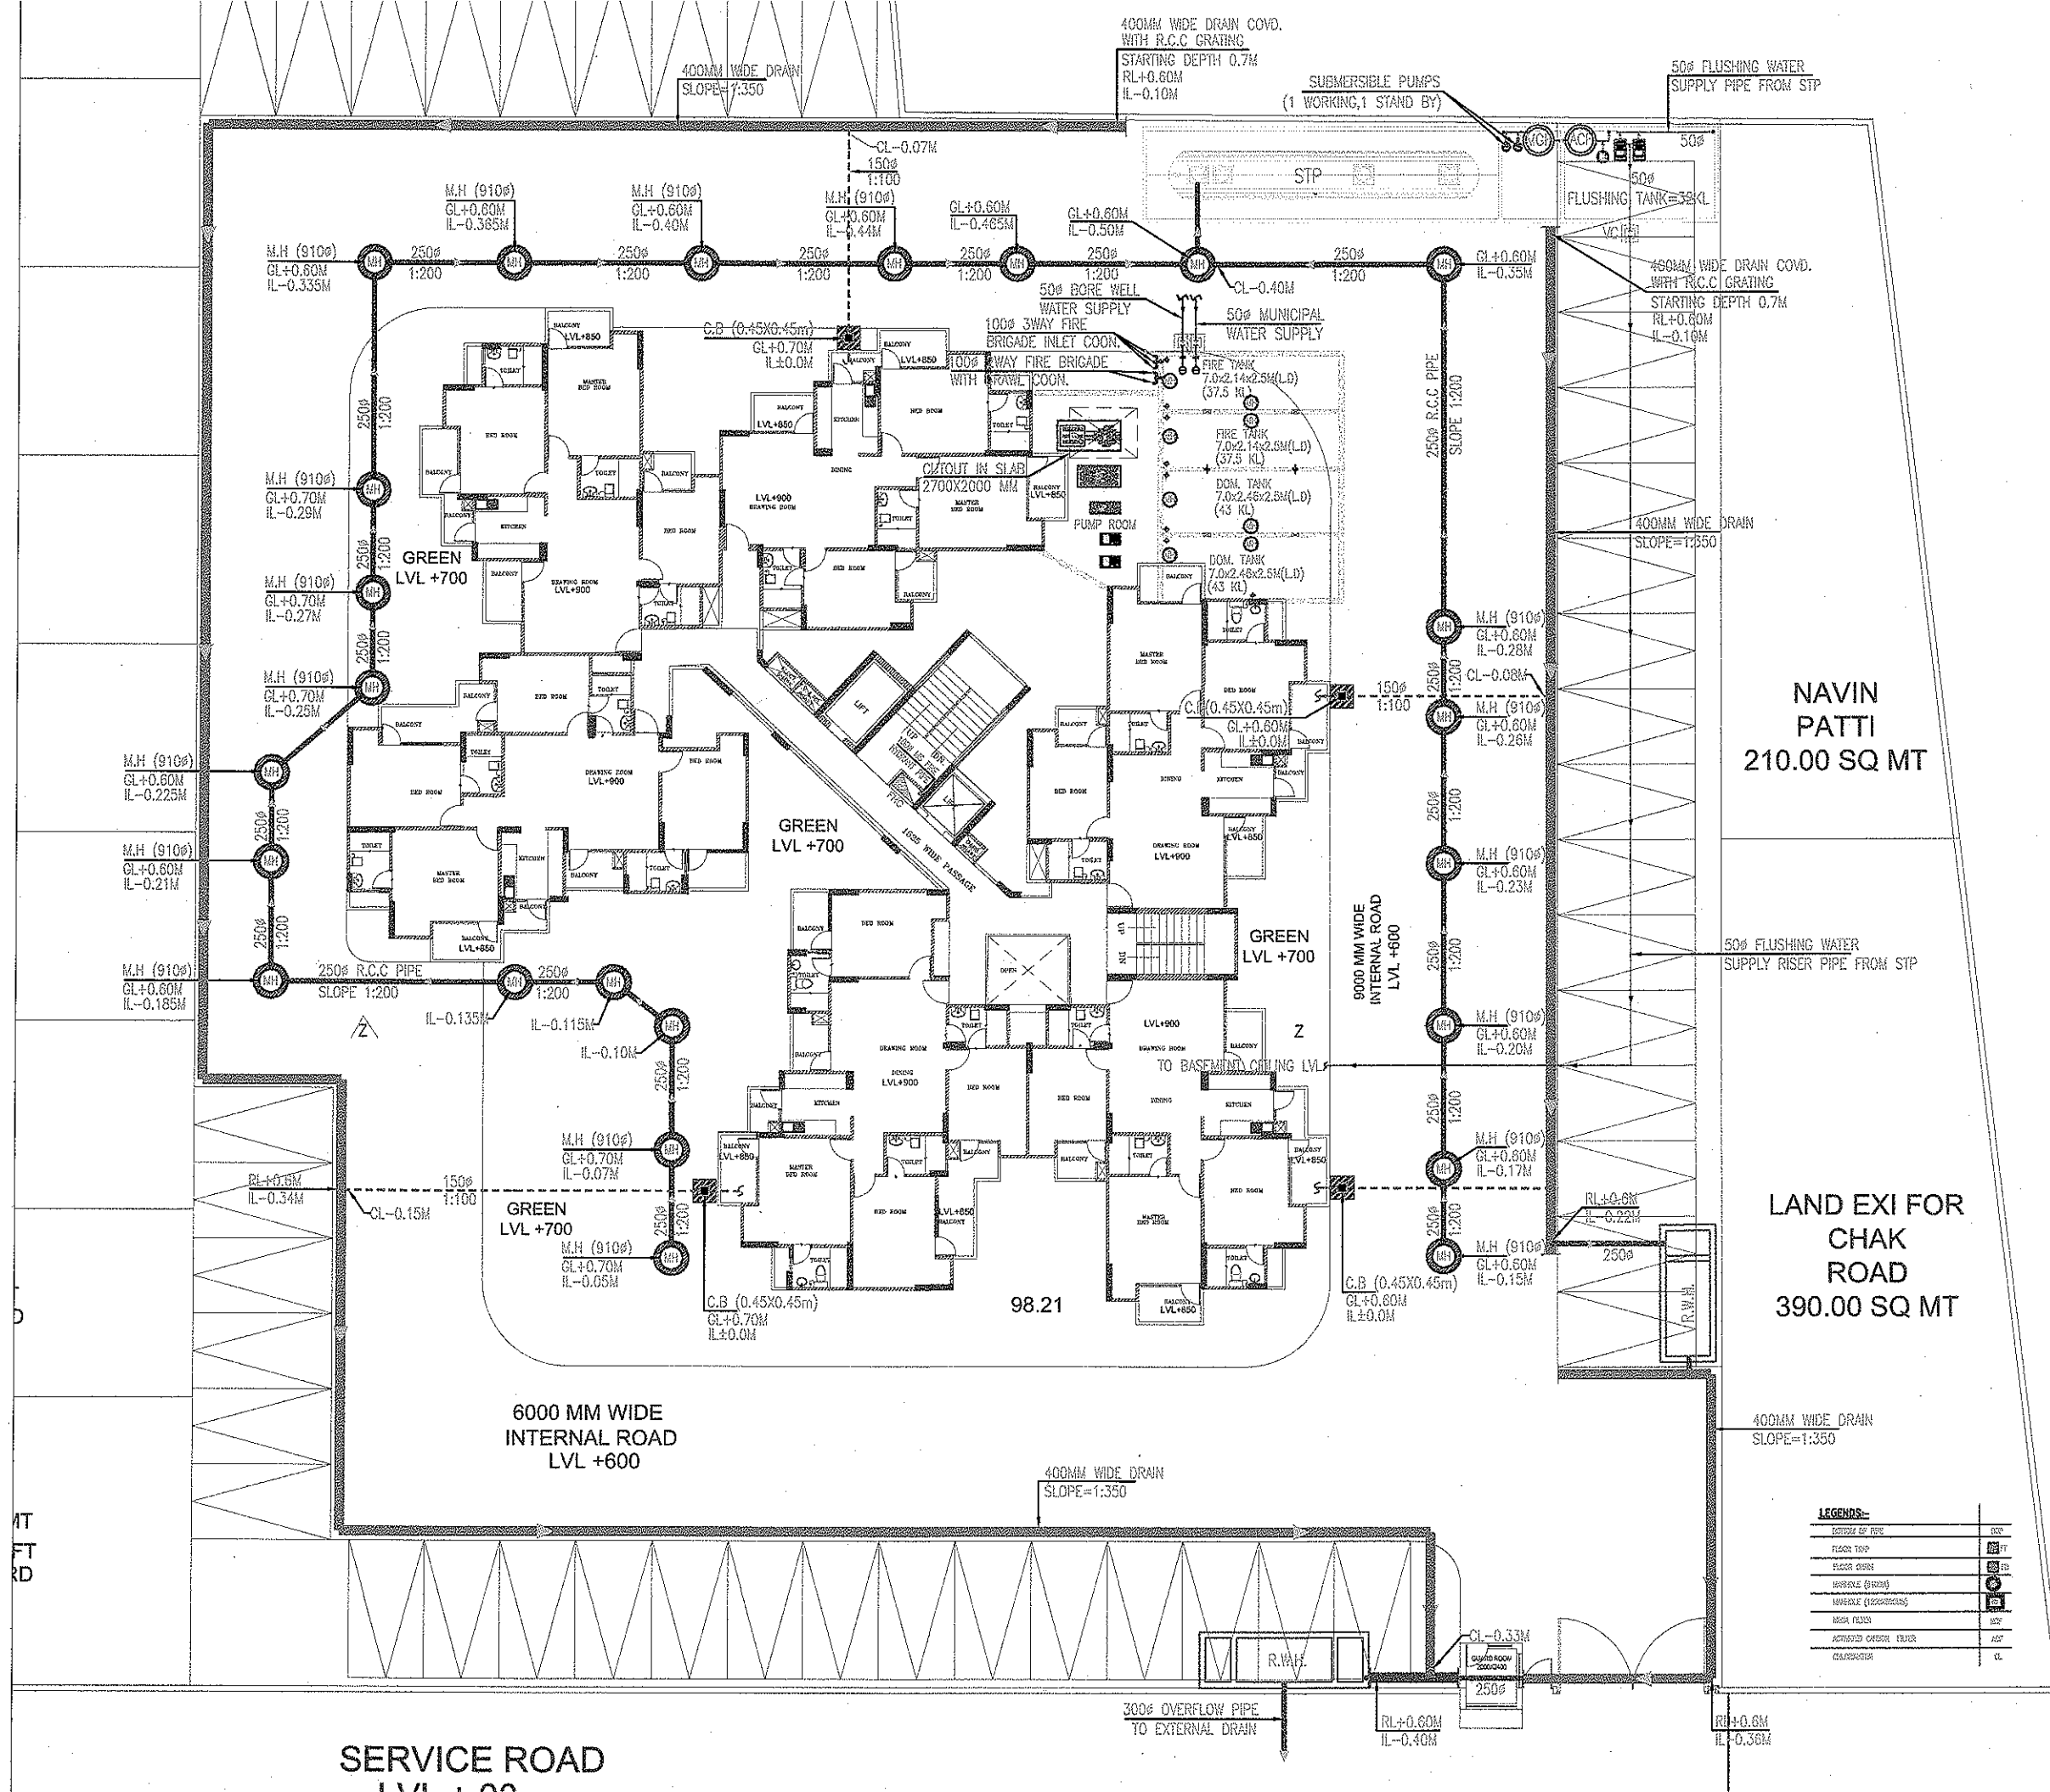

GENERAL NOTES -

1. ALL DIMENSIONS ARE IN MILLIMETERS.
2. DIMENSIONS ARE TO BE READ AND NOT TO BE SCALED
3. THE CONTRACTORS MUST VERIFY ALL DIMENSIONS ON SITE AND REFER THE RELEVANT STRUCTURAL AND OTHER CONSULTANT'S DRAWINGS BEFORE COMMENCING ANY WORK OR PREPARING ANY SHOP DRAWING, AND IN CASE ANY DISCREPANCY IS NOTICED THE SAME SHALL BE BROUGHT TO THE NOTICE OF THE ARCHITECT AND SHALL BE CLARIFIED BEFORE EXECUTION OF WORK.

REFER THIS DRAWING ALONG WITH THE OTHER RELEVANT ARCHITECTURAL, STRUCTURAL AND THE OTHER SERVICES DRAWINGS BEFORE THE EXECUTION OF WORK RELATED TO THIS DRAWING AT SITE.

NOTES:-

1. THIS DRAWING IS TO BE READ IN CONJUNCTION WITH ALL OTHER RELEVANT ARCHITECTURAL, STRUCTURAL & ELECTRICAL DRAWINGS.
2. ALL DIMENSION & LEVELS ARE IN MM.
3. ALL SOIL, WASTE, VENT & RW PIPES ARE UPVC.
4. ALL INTERNAL WATER SUPPLY PIPES ARE CPVC PIPES.
5. ALL WATER SUPPLY DROPS & RISER GI PIPES.
6. WATER SUPPLY PIPES DROPS & RISER SIZES REF. WATER SUPPLY SYSTEM DIAGRAM

LEGENDS:-	
1.	110 OD UPVC SOIL & VENT PIPE
2.	110 OD UPVC WASTE & VENT PIPE
3.	75 OD UPVC ANTISIPHONAGE PIPE
4.	COLD WATER DOWN TAKE PIPE
5.	FLUSHING WATER DOWN TAKE PIPE
6.	COLD WATER RISER PIPE
7.	FLUSHING WATER RISER PIPE
8.	75 OD UPVC RAIN WATER PIPE FROM BALCONY

STATUS: GOOD FOR CONSTRUCTION

CLIENT: KRISHNA REALTY PVT. LTD
D-6, SECTOR - 61, NOIDA - 201301

PROJECT: APRAMEYA RESIDENCY
APARTMENT AT
NODE NAGAR, GHAZIABAD

ARCHITECT SIGN **CLIENT SIGN**

ARCHITECTS:

Blushan Kumar

M/S. Krishna Estate Development Pvt. Ltd.

DSR ENGINEERING SERVICES
Plumbing & Fire Fighting Consultant
28-D, Pocket -6,
MIG Flats, Mayur Vihar -Phase - III, Delhi -96
Ph- 9910349454
Email- dsrengg46@gmail.com

BUILDING TYPE: Residential

DRAWING TITLE: SITE PLAN PLUMBING LAYOUT BLOCK-A

DRG. NO. - API/PL/2013/AR_TD_02			
Date	17.07.17	Rev.	R-2
Design by		Scale	1:175@A2
Drawn by		Approved by	