


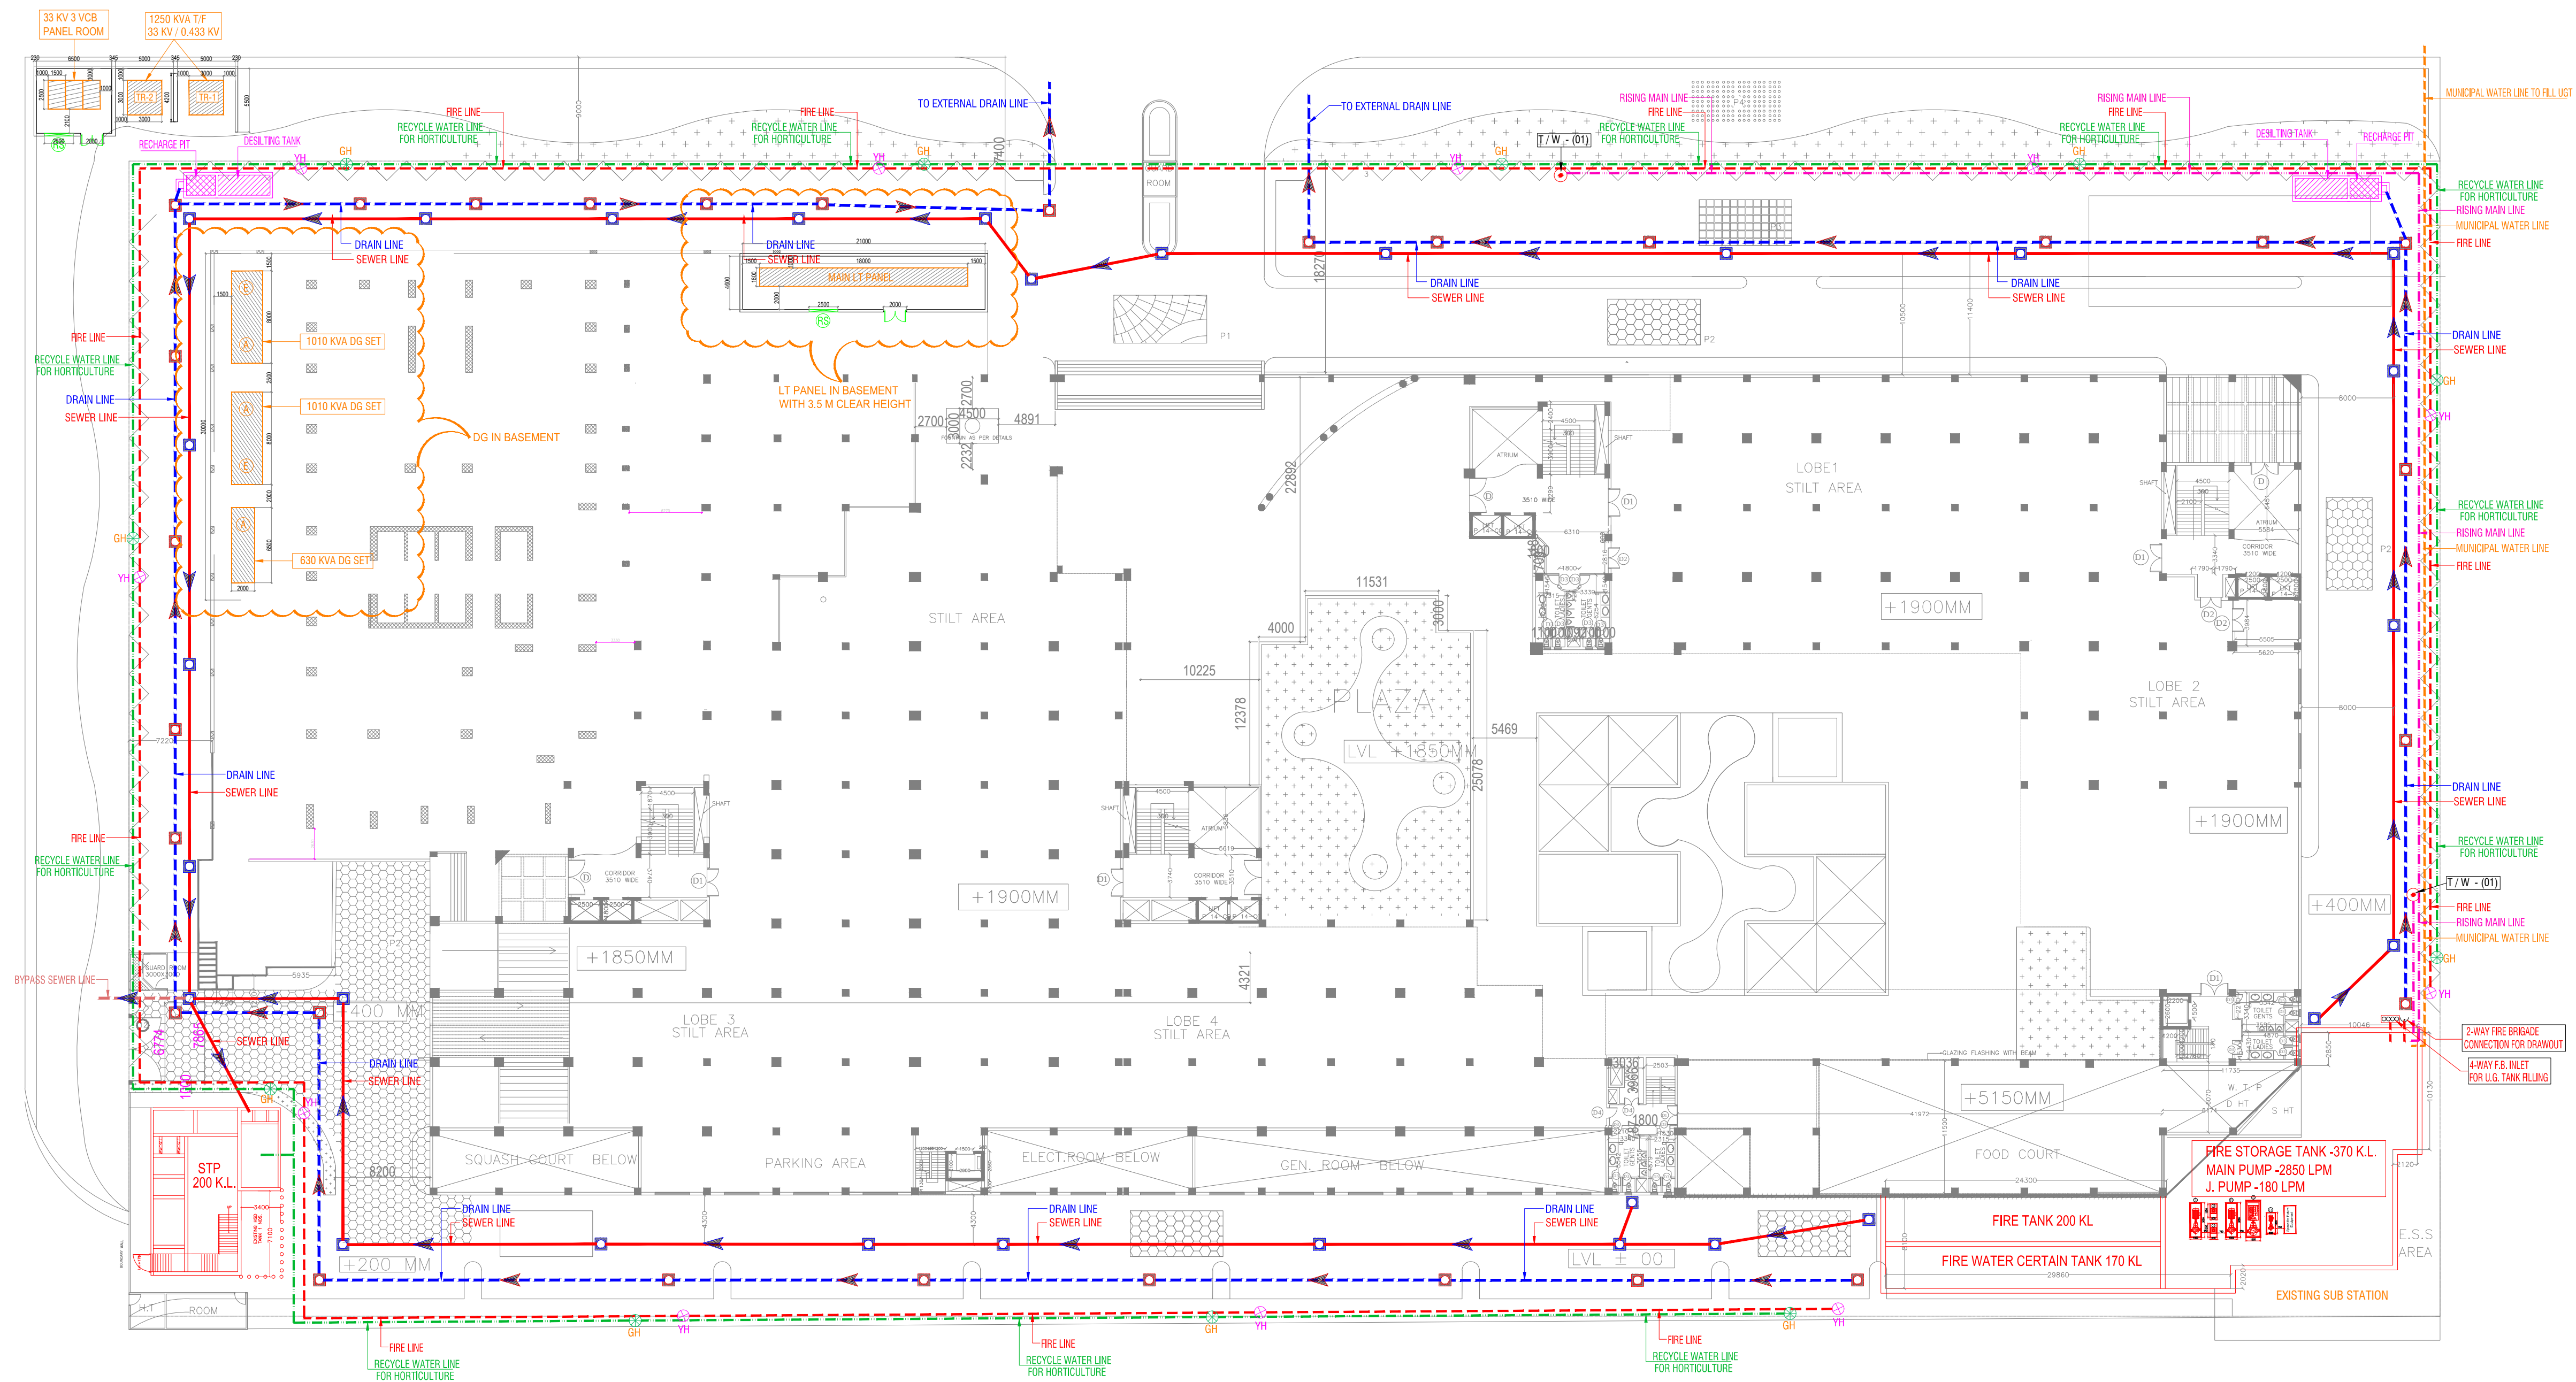

LEGEND :		
S. No.	SYMBOL	DESCRIPTION
1.	M.H. □	MANHOLE
2.	—■—	SEWER LINE
3.	□	BYPASS MANHOLE
4.	- - - □ - - -	BYPASS SEWER LINE
5.	C.P. □	CATCH PIT
6.	- - - □ - - -	UNDER GROUND DRAIN
7.	■	RAIN WATER HARVESTING
8.	—■—	RECYCLED WATER SUPPLY PIPE LINE.
9.	—■—	RISING MAIN WATER PIPE LINE.
10.	- - - □ - - -	MUNICIPAL WATER SUPPLY PIPE LINE.
11.	—■—	ISOLATING VALVE
12.	○	PROPOSED TUBE WELL
13.	GH	GARDEN HYDRANT

LEGEND : FIRE SYSTEM		
S. No.	SYMBOL	DESCRIPTION
1.	—■—	FIRE LINE
2.	YH	YARD HYDRANT 63 M.M. DIA. SINGLE HEADED HYDRANT VALVE WITH 2 NOS. 15 M LONG 63 M.M. DIA. FIRE HOSE PIPE & 1 NO. BRANCH PIPE WITH NOZZLE
3.	□	FIRE BRIGADE CONNECTION
4.	□	BUTTERFLY VALVE
5.	□	NONRETURN VALVE (CHECK VALVE)
6.	—■—	ISOLATING VALVE WITH MASONRY CHAMBER

Rev. no.	Date	Revision
..	..	..

Project
PROPOSED CORPORATE OFFICE FOR
Beaver International (India) Pvt. Ltd.
PLOT NO. A - 41 SECTOR - 62, NOIDA (U.P)

Title
SITE PLAN

Subtitle
EXTERNAL SERVICES CO-ORDINATION PLAN

Drawing released for
☐ APPROVAL ☒ SUBMISSION
☐ ADVANCE COPY ☐ CONSTRUCTION

Drg. no. CORPORATE / EX / S-05 Drawn by Kulwant

Scale 1 : 350 Designed by R.K.

Date Aug. 2017 Checked by Anand Havela

Architects
HOLISTIC CONSULTANCY CONSORTIUM
ARCHITECTURE, TOWN PLANNING, PMS, INDUSTRIAL DESIGN, EPC,
SARITA VIHAR, NEW DELHI.

Services Consultant
Consummate Engineering Services (P) Ltd.
Noida Office : B - 67, Sector - 67, Noida - 201 301
Tel : (0120)6943500 (23 Lines)
Lko. Office : R 006, Rohtas Plumeria, Gomti Nagar, Lucknow
e mail : mail@cespl.in, website : www.cespl.in