


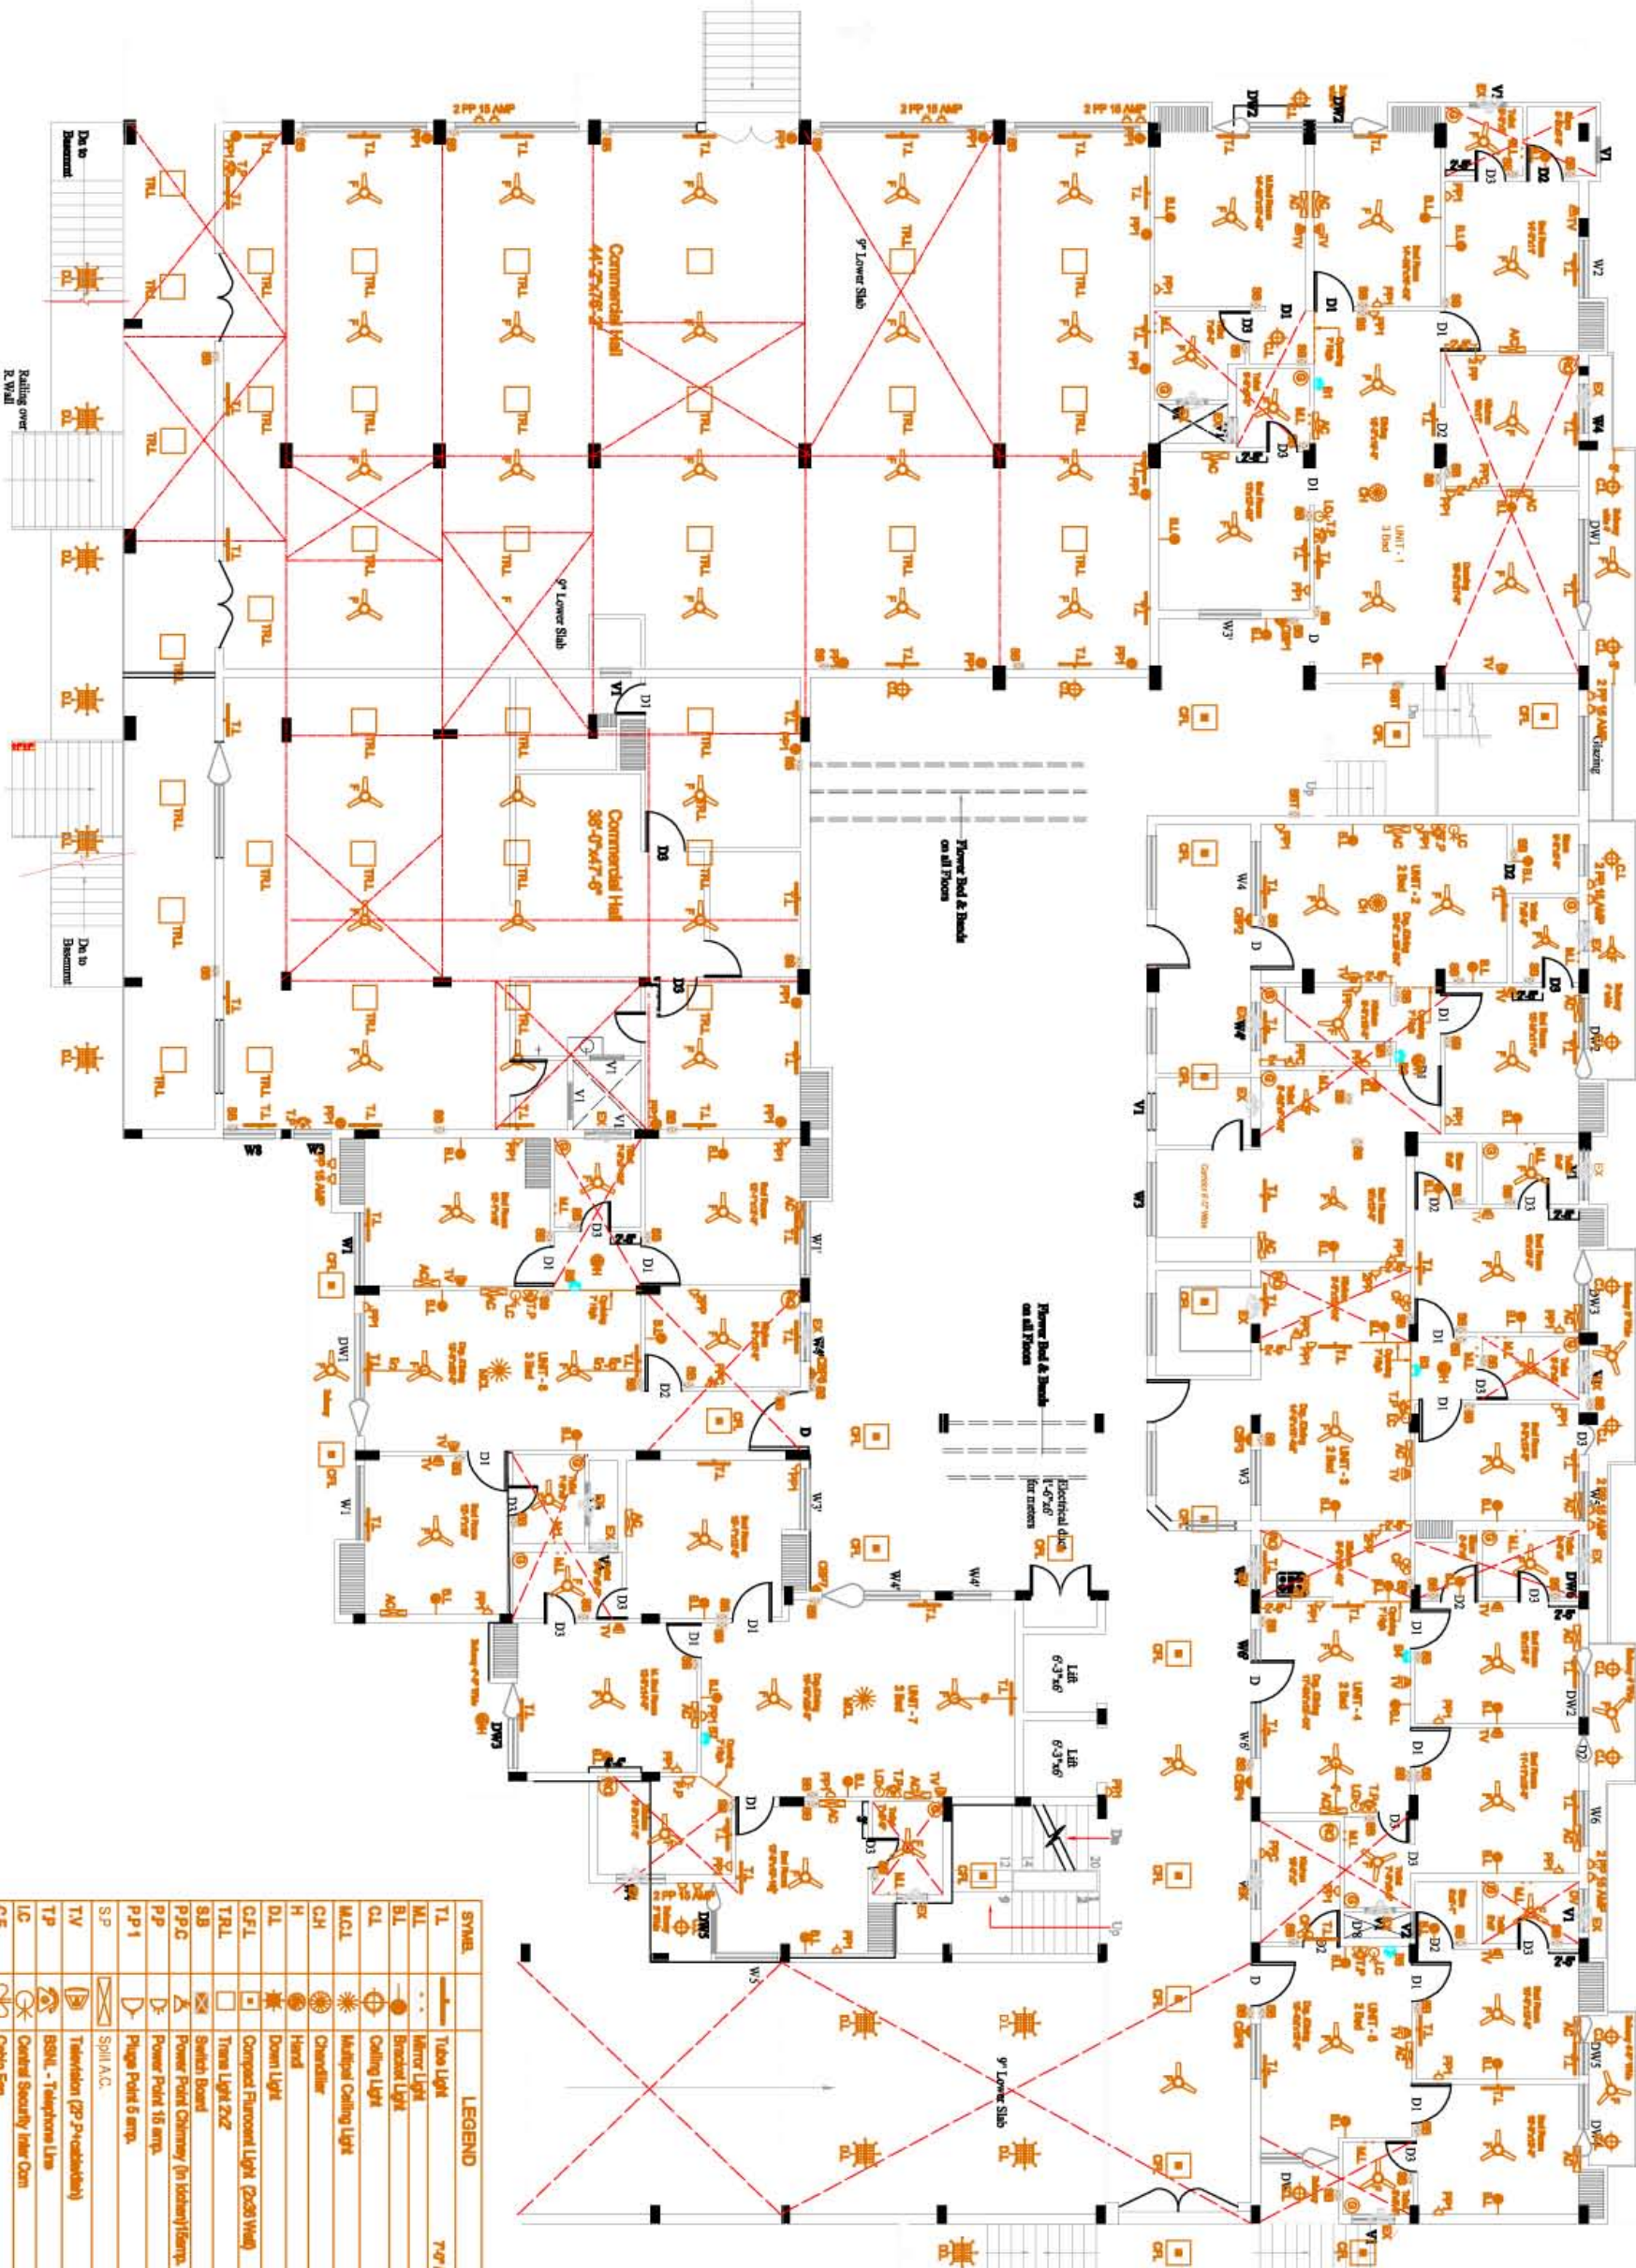

Drg. No.:- Na/1595/03/C5/11
Date:- 14 - 07 - 2012

TITLE:
Main Floor Electrical Plan
LVL:- 7-1½"

Proposed Sapphire - Atari Informatics Ltd.
At Pilibhit Bye Pass Bareilly

ARCHITECT
THE NOVARCH
88, Avas Vikas, Civil Lines Bareilly

SYMB.	LEGEND	HL
TL	Tube Light	7'4" / Room Light
ML	Minor Light	7'4"
BL	Branch Light	7'4"
CL	Ceiling Light	
MCL	Multiple Ceiling Light	
CH	Chandelier	
H	Hand	
DL	Down Light	
CFL	Compact Fluorescent Light (2x20 Wt)	
TRL	Track Light 2x2	
SB	Switch Board	34"
P.P.G	Power Point Guttering (in kitchen) 16amp.	7'4"
P.P.1	Power Point 16 amp.	1'4"
P.P.1	Power Point 5 amp.	12'3'4"
S.P	Split A.C.	8'4"
TV	Television (22" Private)	1'4"
TP	BSNL - Telephone Line	1'4"
LC	Central Security Inter Com	7'4"
CF	Ceiling Fan	
CF	Ceiling Fan	
EX	Exhaust Fan	
9	Daycare Point	Along 7'4"
81/82	Buzzer (Call Bell)	8'4"
CAP.1/23	Call Bell Push in SB	

NOTE:-
1- Use Energy Efficient lights viz. CFL, LED, etc.
2- Provision of generator, Inverter Circuits.
3- Use split A.C. Preferably.
4- Provision of Extra lights in store ceiling and design and detail.
5- Central Security Intercom to be Connected from Society Office in Basement.
6- All Entrance CCTV to be Connected from Society Office.