


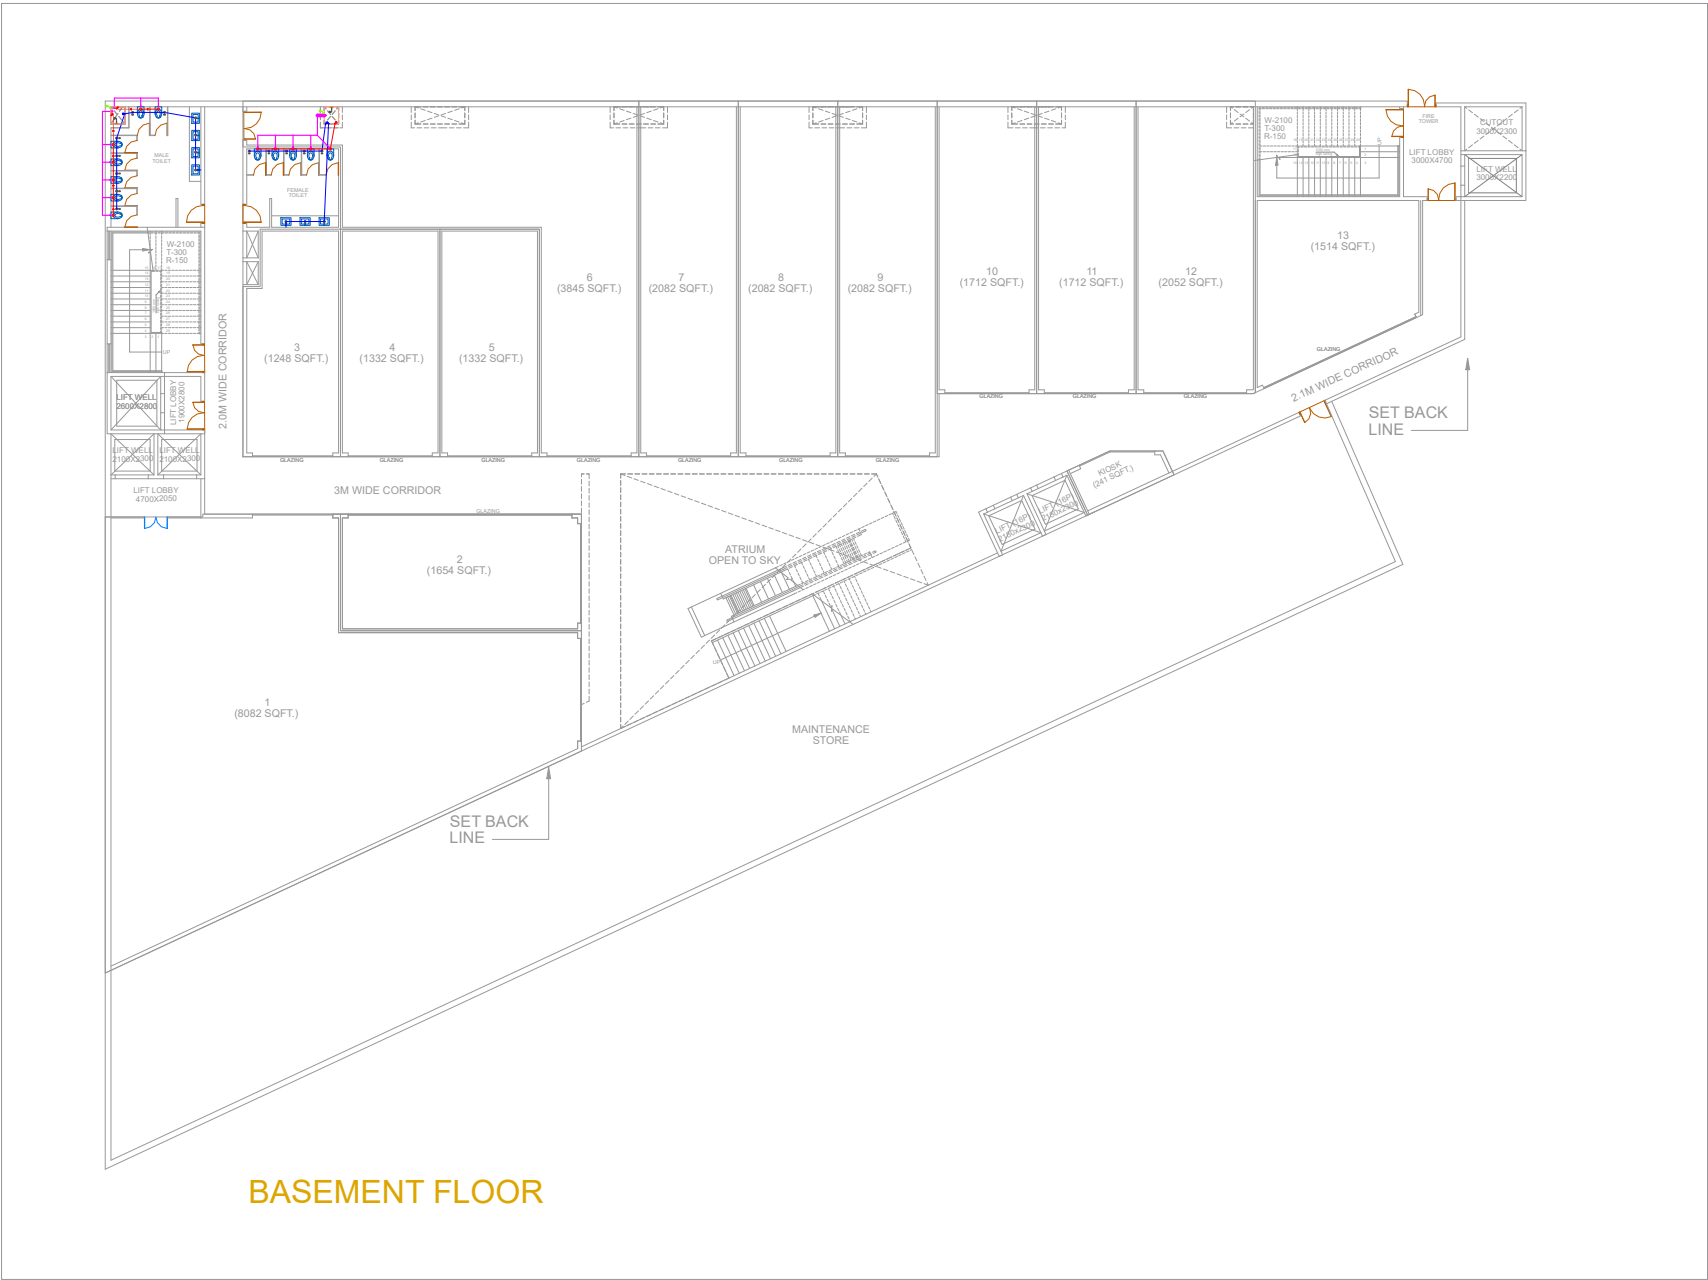

BASEMENT FLOOR



GROUND FLOOR



FIRST & SECOND FLOOR



THIRD FLOOR



| PLUMBING LEGEND: |                               |
|------------------|-------------------------------|
| ①                | 110 OD SOIL PIPE              |
| ②                | 110 OD WASTE PIPE             |
| ③                | DOMESTIC WASTE SUPPLY DN TAKE |
| ④                | FLUSHING WATER SUPPLY DN TAKE |
| ⑤                | DOMESTIC WATER SUPPLY RISER   |
| ⑥                | FLUSHING WATER SUPPLY RISER   |
| Ⓑ                | 75 OD RAINWATER PIPE(BALCONY) |
| Ⓘ                | 110 OD RAIN WATER PIPE        |

PROJECT TITLE:-

NOIDA CYBER HUB,  
SECTOR-62, NOIDA  
FOR NOIDA CYBER PARK PVT. LTD.

DRAWING TITLE:-

SUBMISSION DRAWING

WASTE DISPOSAL PLANS  
(BASEMENT, GROUND, 1ST, 2ND & 3RD  
FLOOR)

| DATE       | SCALE    |
|------------|----------|
| 05/09/2022 |          |
| JOB NO.    | NORTH    |
|            |          |
| DRN. BY    | CHKD. BY |
|            |          |

ARCHITECT'S SIGN

*Kapil Razdan*  
AR. KAPIL RAZDAN  
CA/2019/110796

OWNER'S SIGN

CONSULTANT