


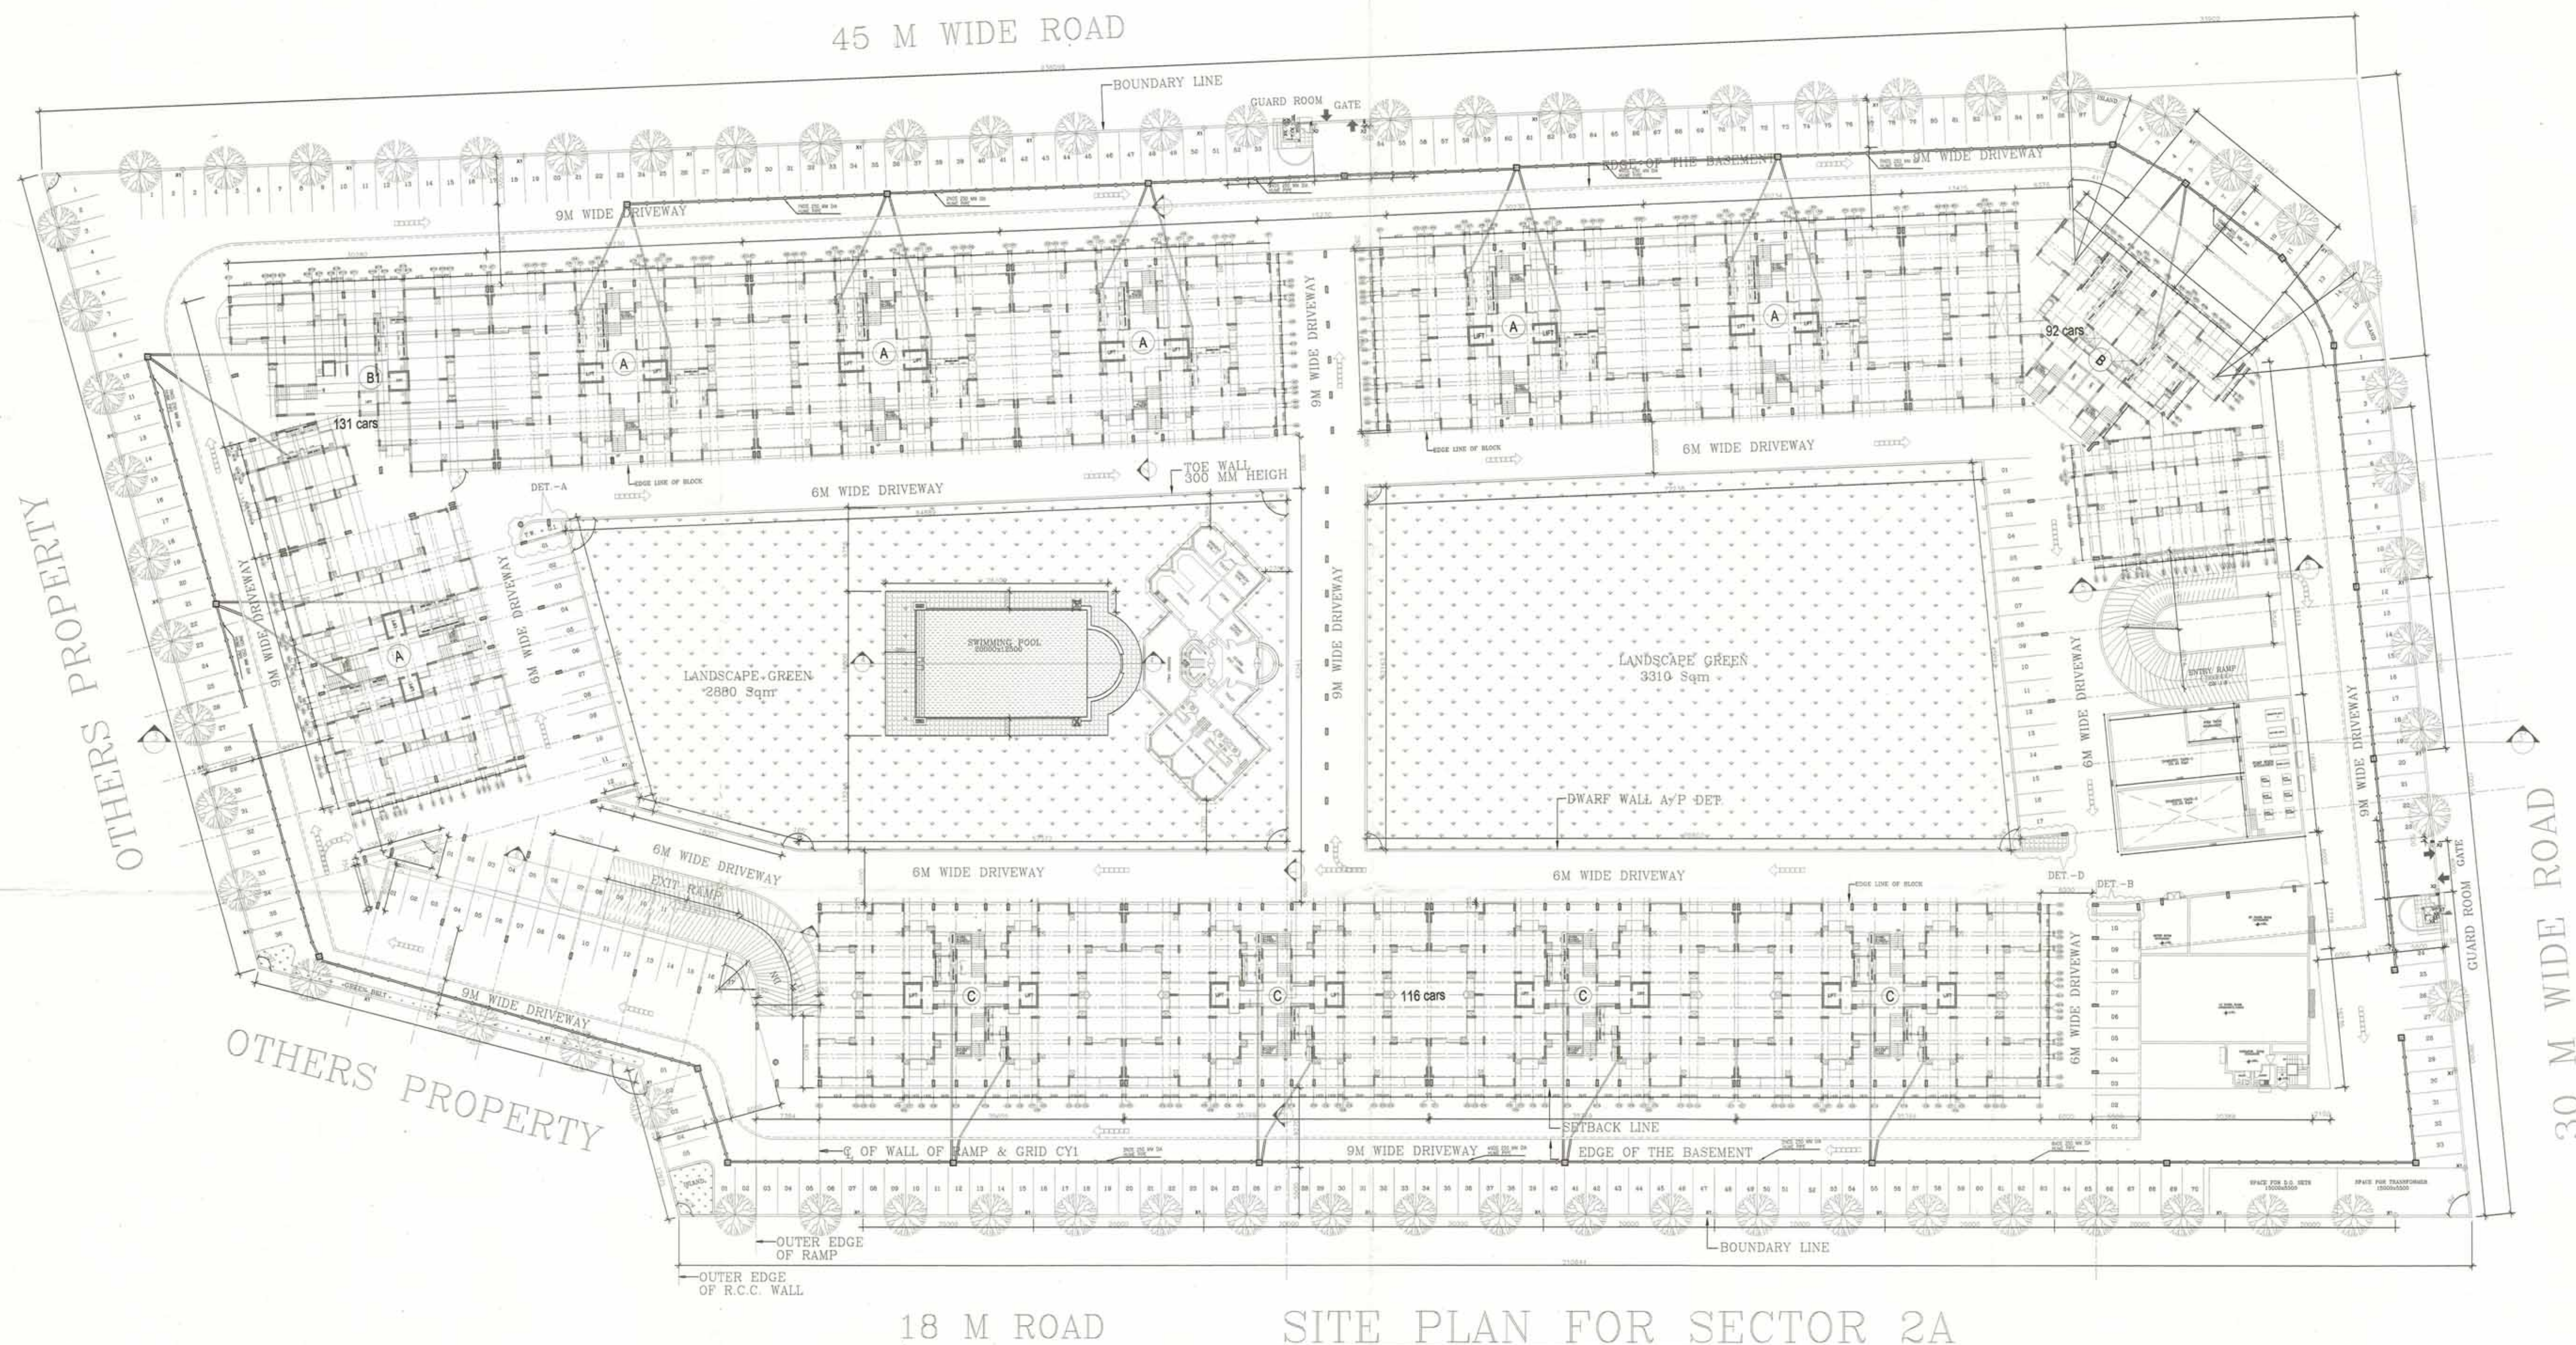

SITE PLAN FOR SECTOR 2A

LEGEND

S.NO	DESCRIPTION	SYMBOL
1.	7.5 M HIGH POLE	⊕
2.	GATE LIGHT	⊙
3.	MAN HOLE	MH
4.	RCC HUME PIPE	—
5.	CABLE TRAY	—

GOOD FOR EXECUTION

Dr. No. S.E. (H)

Vivek Sahni
B. TECH. (I.I.T. DELHI)

UPAVP
ARCHITECTURE AND PLANNING UNIT-3
NEELGIRI COMPLEX, LUCKNOW.

DRG. NO.

FILE NO.

NOTES:-

- 1) The blocks shall be in the format of the b+s+16 storeys.
- 2) The site staff should coordinate this Arch. drwg. with the relevant Services drwg. before the start of the work.
- 3) In case any discrepancy is found in the drwg. the same shall be brought to the notice of the arch. division / consultant. the work shall not be carried out without clarification.

DATE NO ISSUED TO INITIAL

10.7.13 0

DATE REV. NO. BRIEF RECORD INITIAL

REVISION

CONSULTANTS:
SAJAG CONSULTANTS
C-146 KILOKRI
NEAR MAHARANI BAGH CROSSING
NEW DELHI-110014
TELEPHONE-26343059,9868848054

DIVISION	DRAWN	CHECKED	UNIT
ELECT	ABULAIKH	VIVEK	M.M.

DRG. NO. : 193.5.7.00.01

SCHEME:
AWADH VIHAR YOJNA, LUCKNOW.

DRG. TITLE:

SITE, STILT PLAN (EXTERNAL LIGHTING & PANEL LAYOUT)

PROJECT: GROUP HOUSING IN MANDAKINI (SECT-2A.)

DATE: 20.10.13

SCALE: N.T.S

VIKAS SINGH
DIP-ARCH.
ARCH. ASSTT.

ARVIND DEO ARYA
B.Arch., A.I.I.T., M.A., M.B.A. (P.M.)
ASSTT. ARCH. PLANNER

VIJAY PANDEY
ARCHITECT PLANNER

G.S. GOYAL
B.Arch.
CHIEF ARCH. PLANNER

M.K.S. SANI DASHY
LAS
AVAS AYUKT