
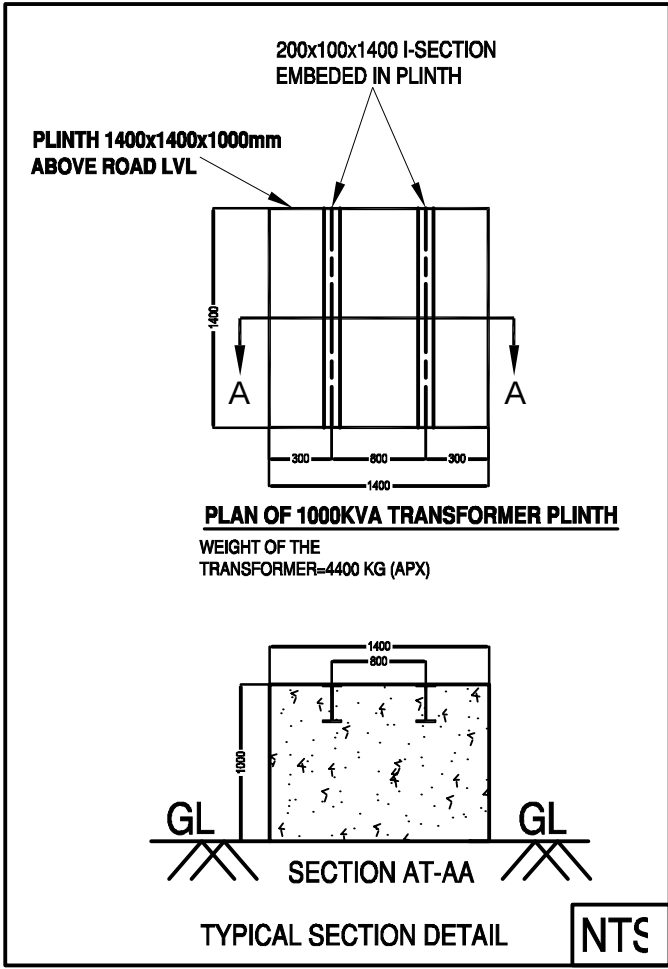
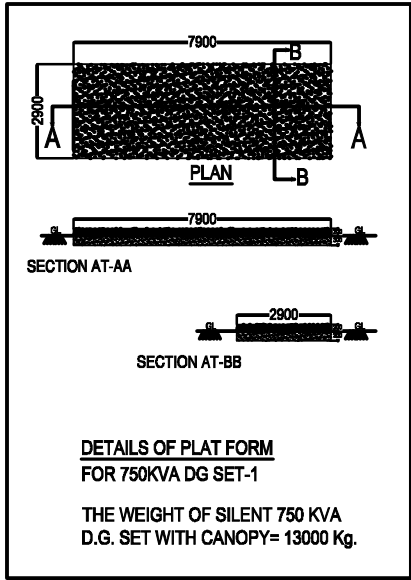


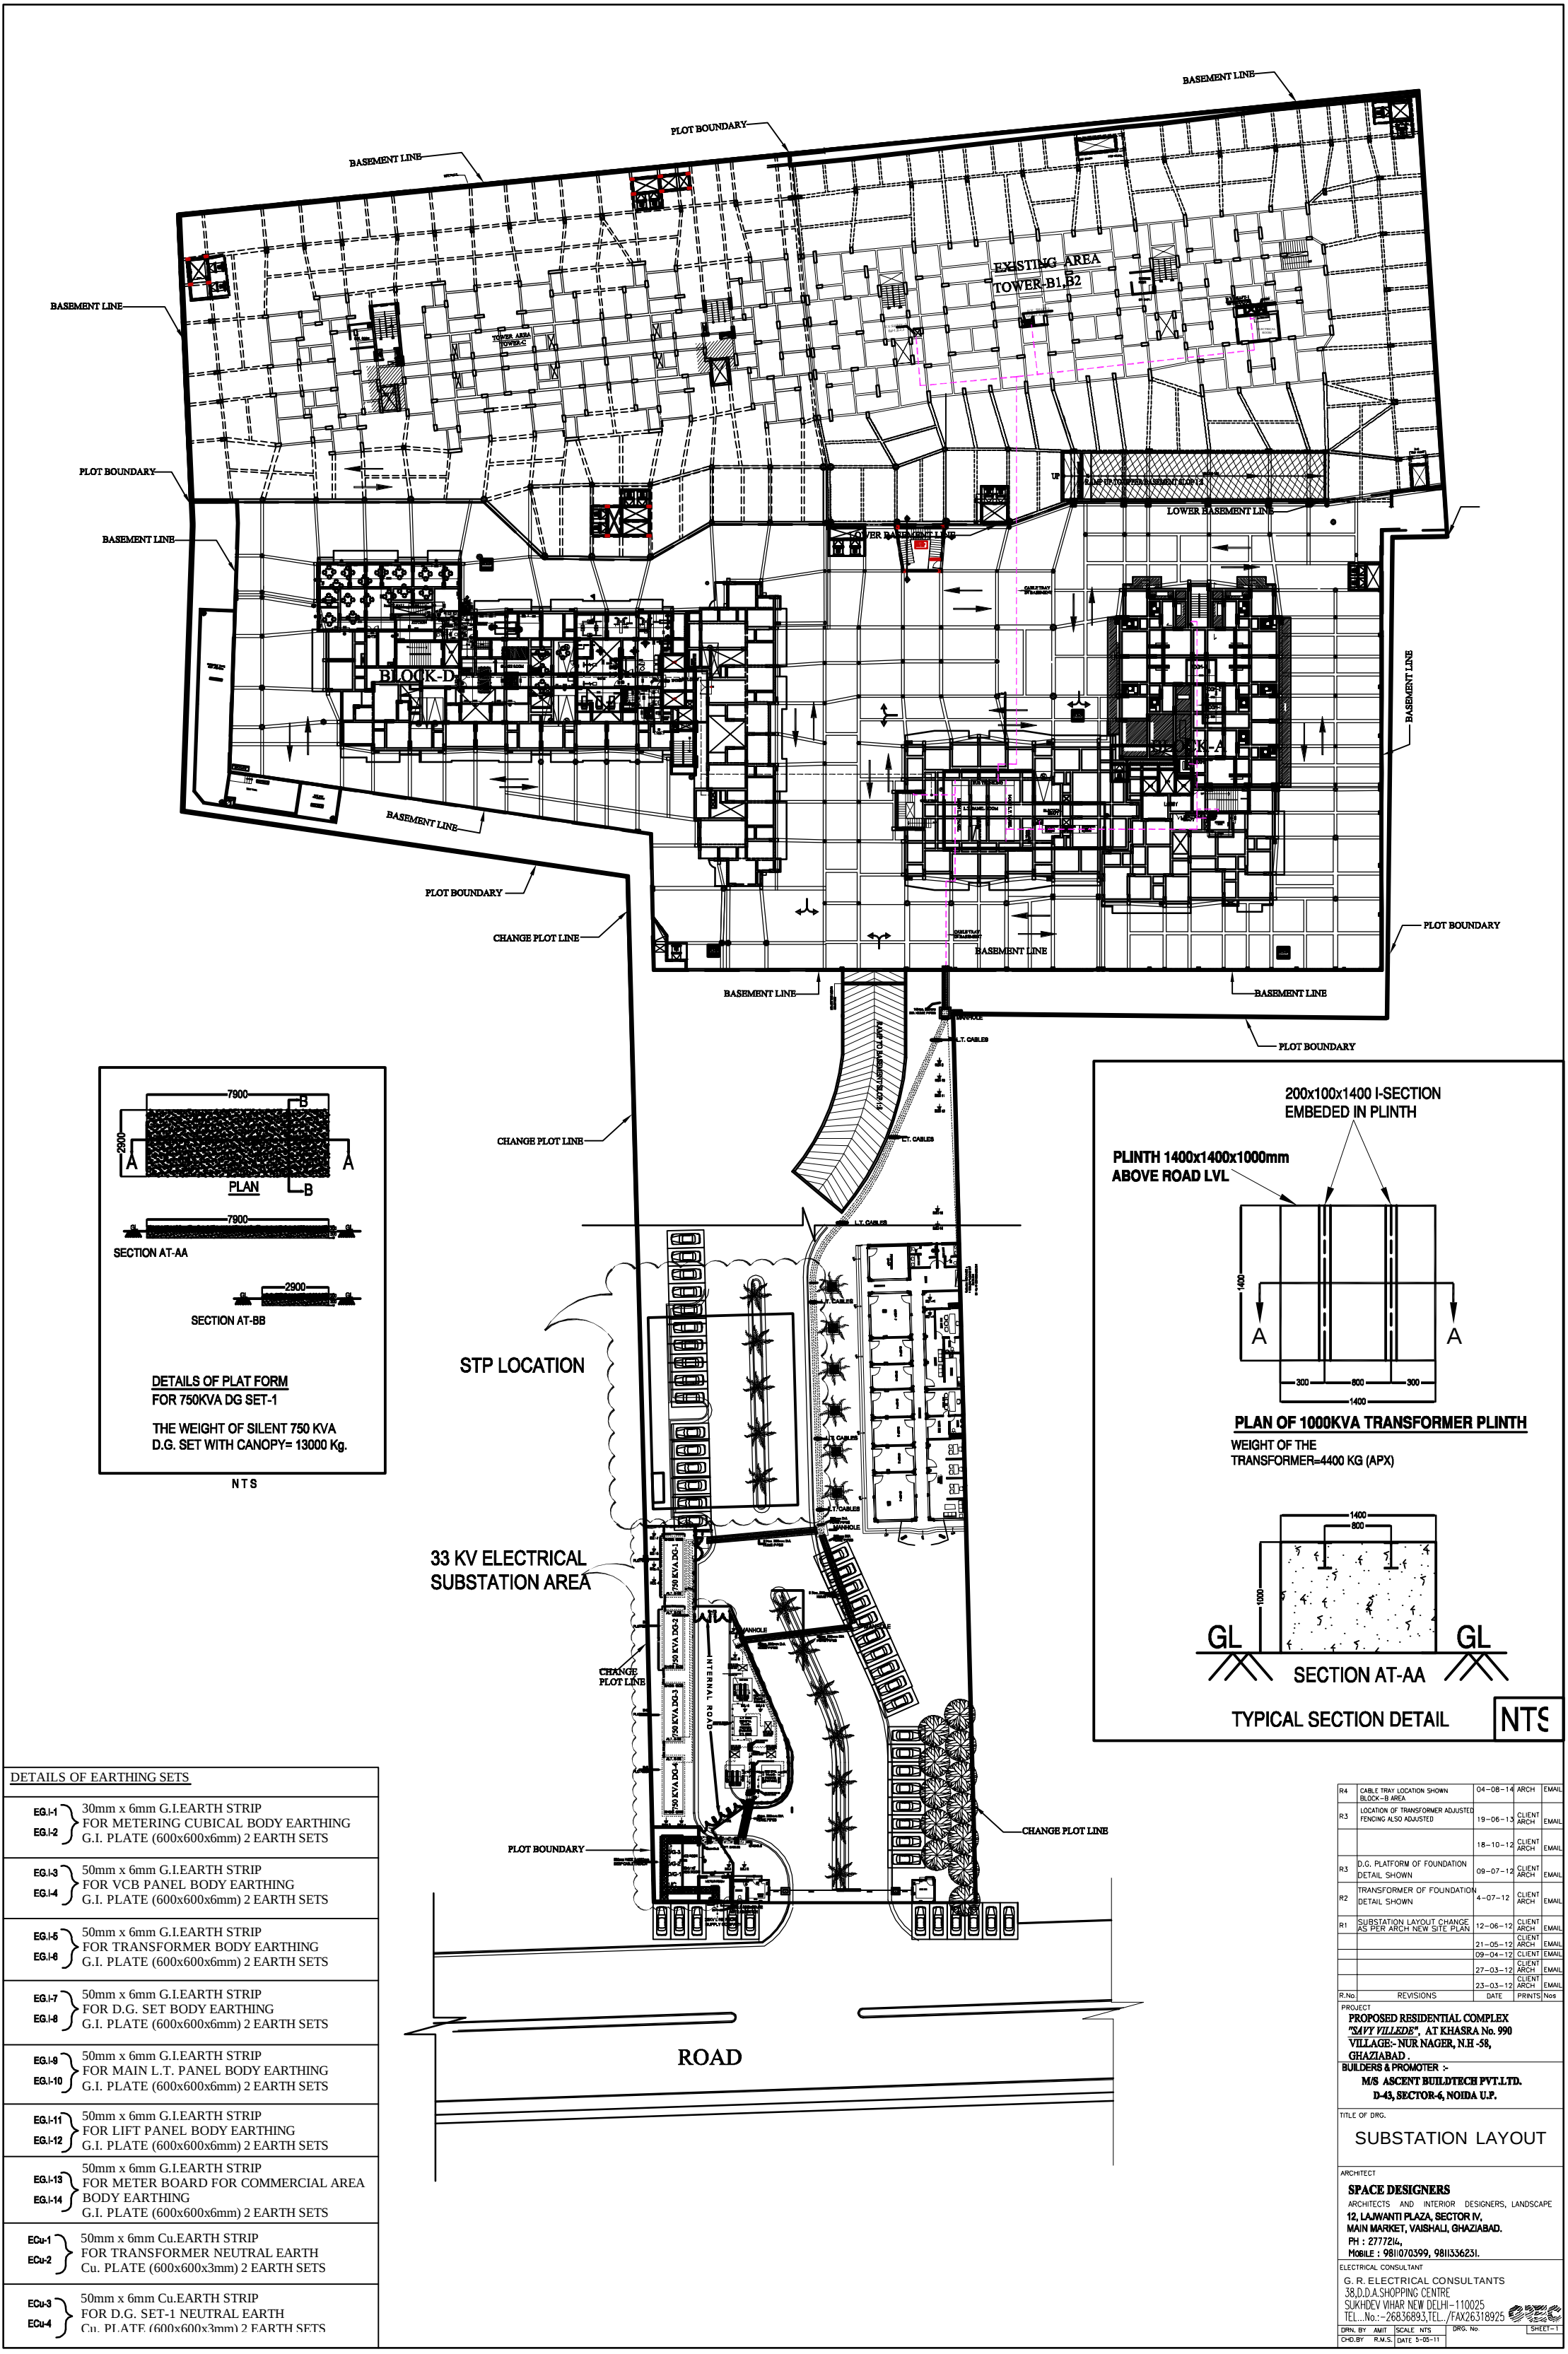

DETAILS OF EARTHING SETS	
EG-I-1 EG-I-2	30mm x 6mm G.I.EARTH STRIP FOR METERING CUBICAL BODY EARTHING G.I. PLATE (600x600x6mm) 2 EARTH SETS
EG-I-3 EG-I-4	50mm x 6mm G.I.EARTH STRIP FOR VCB PANEL BODY EARTHING G.I. PLATE (600x600x6mm) 2 EARTH SETS
EG-I-6 EG-I-8	50mm x 6mm G.I.EARTH STRIP FOR TRANSFORMER BODY EARTHING G.I. PLATE (600x600x6mm) 2 EARTH SETS
EG-I-7 EG-I-8	50mm x 6mm G.I.EARTH STRIP FOR D.G. SET BODY EARTHING G.I. PLATE (600x600x6mm) 2 EARTH SETS
EG-I-9 EG-I-10	50mm x 6mm G.I.EARTH STRIP FOR MAIN L.T. PANEL BODY EARTHING G.I. PLATE (600x600x6mm) 2 EARTH SETS
EG-I-11 EG-I-12	50mm x 6mm G.I.EARTH STRIP FOR LIFT PANEL BODY EARTHING G.I. PLATE (600x600x6mm) 2 EARTH SETS
EG-I-13 EG-I-14	50mm x 6mm G.I.EARTH STRIP FOR METER BOARD FOR COMMERCIAL AREA BODY EARTHING G.I. PLATE (600x600x6mm) 2 EARTH SETS
ECu-1 ECu-2	50mm x 6mm Cu.EARTH STRIP FOR TRANSFORMER NEUTRAL EARTH Cu. PLATE (600x600x3mm) 2 EARTH SETS
ECu-3 ECu-4	50mm x 6mm Cu.EARTH STRIP FOR D.G. SET-1 NEUTRAL EARTH Cu. PLATE (600x600x3mm) 2 EARTH SETS

R4	CABLE TRAY LOCATION SHOWN BLOCK-B AREA	04-08-14	ARCH	EMAIL
R3	LOCATION OF TRANSFORMER ADJUSTED FENCING ALSO ADJUSTED	19-05-13	CLIENT	EMAIL
		18-10-12	CLIENT	EMAIL
R3	D.G. PLATFORM OF FOUNDATION DETAIL SHOWN	09-07-12	CLIENT	EMAIL
R2	TRANSFORMER OF FOUNDATION DETAIL SHOWN	4-07-12	CLIENT	EMAIL
R1	SUBSTATION LAYOUT CHANGE AS PER ARCH NEW SITE PLAN	12-06-12	CLIENT	EMAIL
		21-05-12	CLIENT	EMAIL
		09-04-12	CLIENT	EMAIL
		27-03-12	CLIENT	EMAIL
		23-03-12	CLIENT	EMAIL
R.No	REVISIONS	DATE	PRINTS	Nor
PROJECT				
PROPOSED RESIDENTIAL COMPLEX "RAVY VILLES", AT KHASRA No. 990 VILLAGE- NUR NAGER, N.H -58, GHAZIABAD.				
BUILDERS & PROMOTER :- M/S ASCENT BUILDTECH PVT.LTD. D-43, SECTOR-6, NOIDA U.P.				
TITLE OF DRG.				
SUBSTATION LAYOUT				
ARCHITECT				
SPACE DESIGNERS				
ARCHITECTS AND INTERIOR DESIGNERS, LANDSCAPE				
12, LAJWANTI PLAZA, SECTOR IV, MAIN MARKET, VAISHALI, GHAZIABAD.				
PH : 2777216, MOBILE : 9810703999, 9811336231.				
ELECTRICAL CONSULTANT				
G. R. ELECTRICAL CONSULTANTS				
38,D.D.A SHOPPING CENTRE SUKHDEV VIHAR NEW DELHI -110025				
TEL.No.:-26836893,TEL./FAX26318925				
DRN. BY: AMIT SCALE: NTS DRG. NO: SHEET-1				
CHKD BY: RM/S, DATE 5-08-11				