



PROPOSED GROUP HOUSING,
GH-01+GH-02 AT VIRAJ
KHAND, GOMTI NAGAR-
LUCKNOW

THIS DRAWING AND THE INFORMATION CONTAINED HEREIN SHALL NOT BE REPRODUCED, REPROCESSED OR USED FOR ANY PURPOSE BY ANY PERSON WITHOUT THE EXPRESS WRITTEN CONSENT OF M/F MURARAJE. THIS DRAWING IS PROTECTED UNDER COPYRIGHT LAW AND ANY COPYING OR REPRODUCTION HEREOF IS PROHIBITED. UNAUTHORIZED PERSONS FOUND OBSERVING THIS DRAWING OR ANY PART OF THIS DOCUMENT OF THIS DRAWING FOR ANY PURPOSE SHALL BE SUBJECT TO LEGAL ACTION.

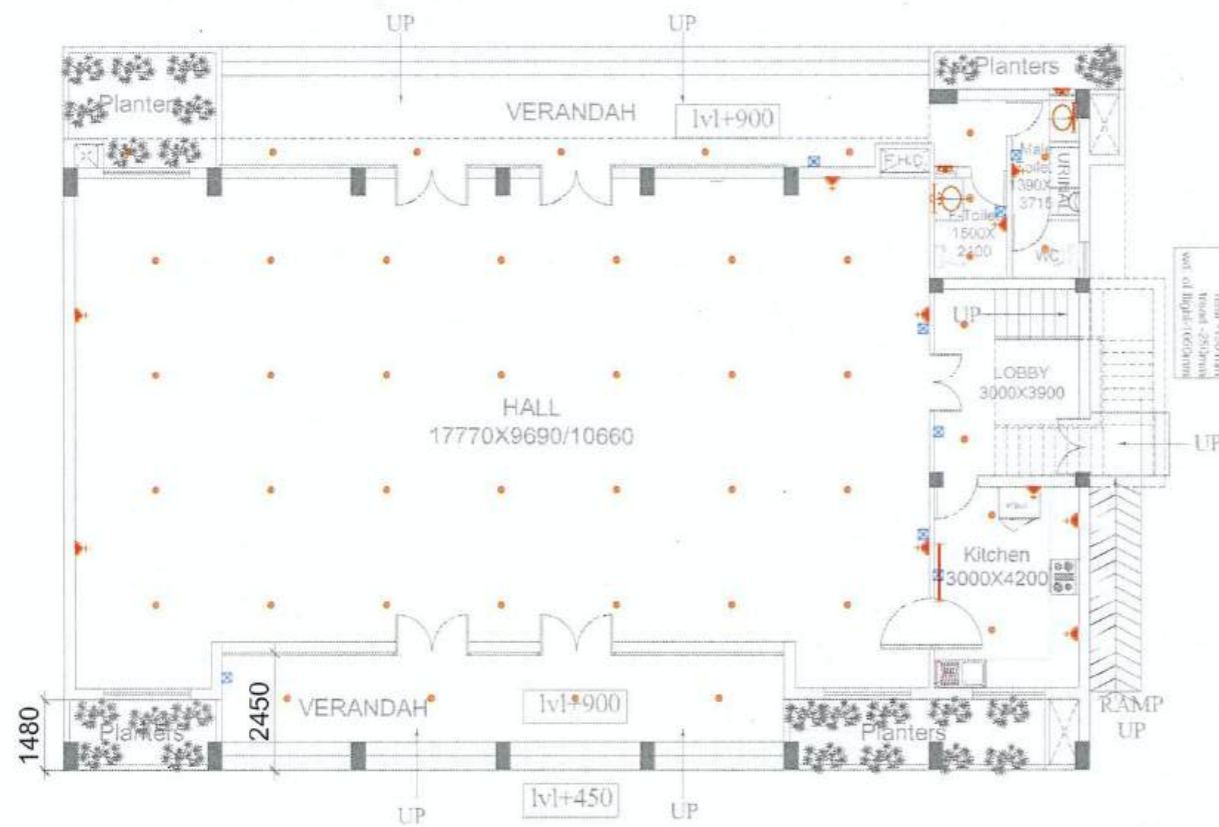


GROUND FLOOR PLAN OF CLUB BUILDING
Total Area = 274.42 sq.mt.

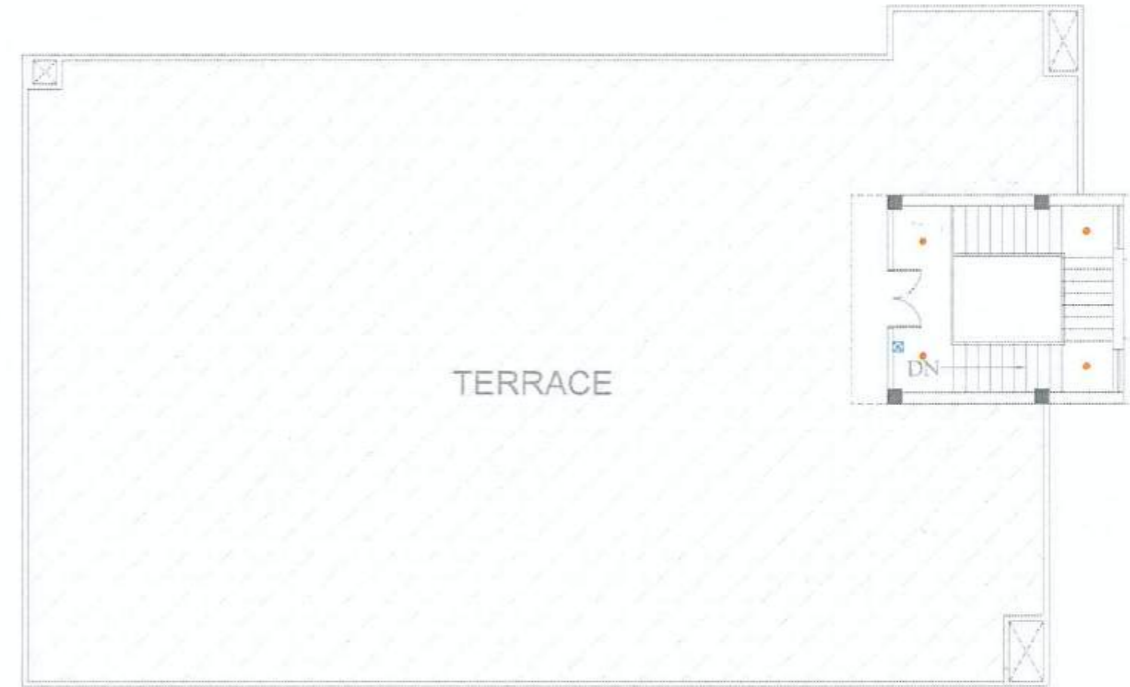

TERRACE FLOOR PLAN OF CLUB BUILDING

ELECTRICAL LEGEND			HEIGHT FROM F.F.
S.NO.	SYMBOL	DESCRIPTION	
1		CEILING FAN (1225MM)	CEILING
2		LED TUBE LIGHT 1425 WATT (1200MM)	2250 MM
3		OCCUPANCY SENSOR LED TUBE LIGHT 16 WATT (1200MM)	CEILING
4		16-18 W LED ROUND LIGHT SURFACE MOUNTED	CEILING
5		8-12 W LED ROUND LIGHT SURFACE MOUNTED	CEILING
6		BATTEN HOLDER LIGHT	2250 MM
7		LED BRACKET LIGHT	2250 MM
8		CENDULER POINT	CEILING
9		LED MIRROR LIGHT	2050 MM
10		LED BULK HEAD LIGHT	2100 MM
11		EX-FAN 230MM	AT VENT.
12		LIGHT SWITCH BOARD	1500 MM
13		TWO WAY LIGHT SWITCH BOARD	
14		BUZZER & CALL BELL OUTLET BOARD	1200 MM
15		TELEPHONE SOCKET OUTLET	
16		DATA SOCKET OUTLET	
17		TV OUTLET	
18		6 AMP PLUS SWITCH BOARD	
19		16 AMP POWER PLUS SWITCH BOARD	
20		20 AMP MCB POWER PLUS SWITCH BOARD	
21		LIGHT & POWER DISTRIBUTION BOARD	1400 MM
22		DISTRIBUTION PANEL	

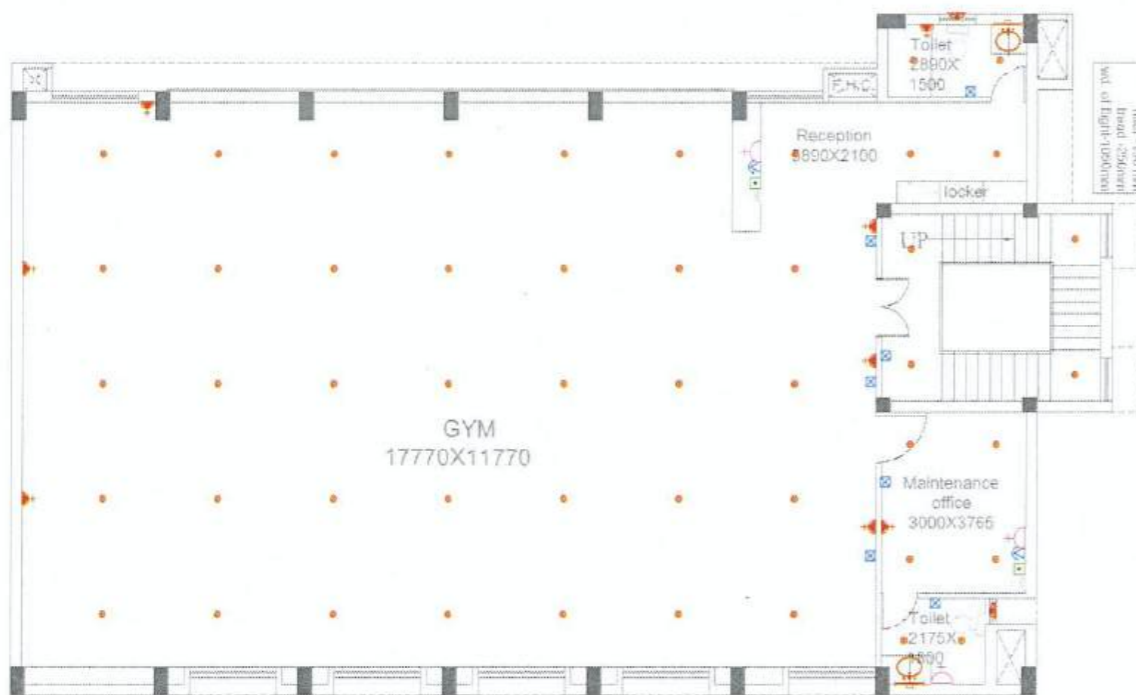

FIRST FLOOR PLAN OF CLUB BUILDING
Total Area = 277.12 sq.mt.

WORKING DRAWING

CLUB BUILDING
ELECTRICAL LAYOUT

	REFERENCE NO- L-115
	SHEET NO- 01
	SCALE NTS
	DATE Jan' 2026
	Drawn By DINESH
REV:	

File No. LD/8P/25-26/3370

CONTRACTOR ARCHITECT



architects
m u r a r a j e
architecture master planning interior design
conservation landscaping project management
A-3/269, viraj khand, gome nagar, lucknow
phone no. 2980135 2326715

शुभ अमिदन्व
आ. वि. प्र. ०; लखनऊ वि. प्र. ०, लखनऊ

**PROPOSED GROUP HOUSING,
GH-01+GH-02 AT VIRAJ
KHAND, GOMTI NAGAR-
LUCKNOW**

THIS DRAWING AND THE INFORMATION CONTAINED HEREIN SHALL NOT BE REPRODUCED, REPRODUCED OR USED FOR ANY PURPOSE BY ANY PERSON WITHOUT THE WRITTEN CONSENT OF HIS OR HER. THIS DRAWING IS PROTECTED UNDER APPLICABLE LAW AND ANY COPIES OR REPRODUCTION HEREOF IS PROHIBITED. UNAUTHORIZED PERSONS FOUND COPYING THIS DRAWING OR ANY PART OF THIS DOCUMENT OR USING THE SAME FOR ANY PURPOSE SHALL BE SUBJECT TO LEGAL ACTION.

	9.0MTR NORMAL LED STREET LIGHT
	AUTOMATIC STREET LIGHT CONTROL PANEL
	OUTDOOR FEEDER PANEL
	HUME PIPE (FOR ROAD CROSSINGS)
	BOOM BARRIER (6.0MTR)
	HT CABLE ROUTE
	LT CABLE ROUTE
	12.5 MTR HIGH MAST WITH LED FLOOD LIGHT
	HIGH MAST LIGHT CONTROL PANEL
	DECORATIVE POST TOP POLE



WORKING DRAWING

SITE PLAN
ELECTRICAL LAYOUT

	REFERENCE NO- L-118
	SHEET NO- 01
	SCALE- NTS
	DATE- Jan. 2020
	Drawn By- DINESH
REV:	

File No. LDA/BP/25-26/3370

CONTRACTOR	ARCHITECT


architects
m u r a l a g e
architecture · master planning · interior design
conservation · landscaping · project management
A-3269 · viraj khand gomti nagar lucknow
phone no. 2980139, 2320715

अवर अभियन्ता
सहायक अभियन्ता
लखनऊ विकास प्राधिकरण, लखनऊ

Copyright © Muralage 2023. All rights reserved.

**PROPOSED GROUP HOUSING,
GH-01+GH-02 AT VIRAJ
KHAND, GOMTI NAGAR-
LUCKNOW**

THIS DRAWING AND THE INFORMATION CONTAINED HEREIN SHALL NOT BE LOANED, REPRODUCED OR USED FOR ANY PURPOSE BY ANY PERSON WITHOUT THE EXPRESS WRITTEN CONSENT OF M/S MURALAGE. THIS DRAWING IS PROTECTED UNDER COPYRIGHT LAW AND ANY COPYING OR REPRODUCTION WITHOUT THE WRITTEN PERMISSION OF M/S MURALAGE IS PROHIBITED. UNAUTHORIZED REPRODUCTION OF THIS DOCUMENT OR USING THE SAME FOR ANY PURPOSE SHALL BE SUBJECT TO LEGAL ACTION.

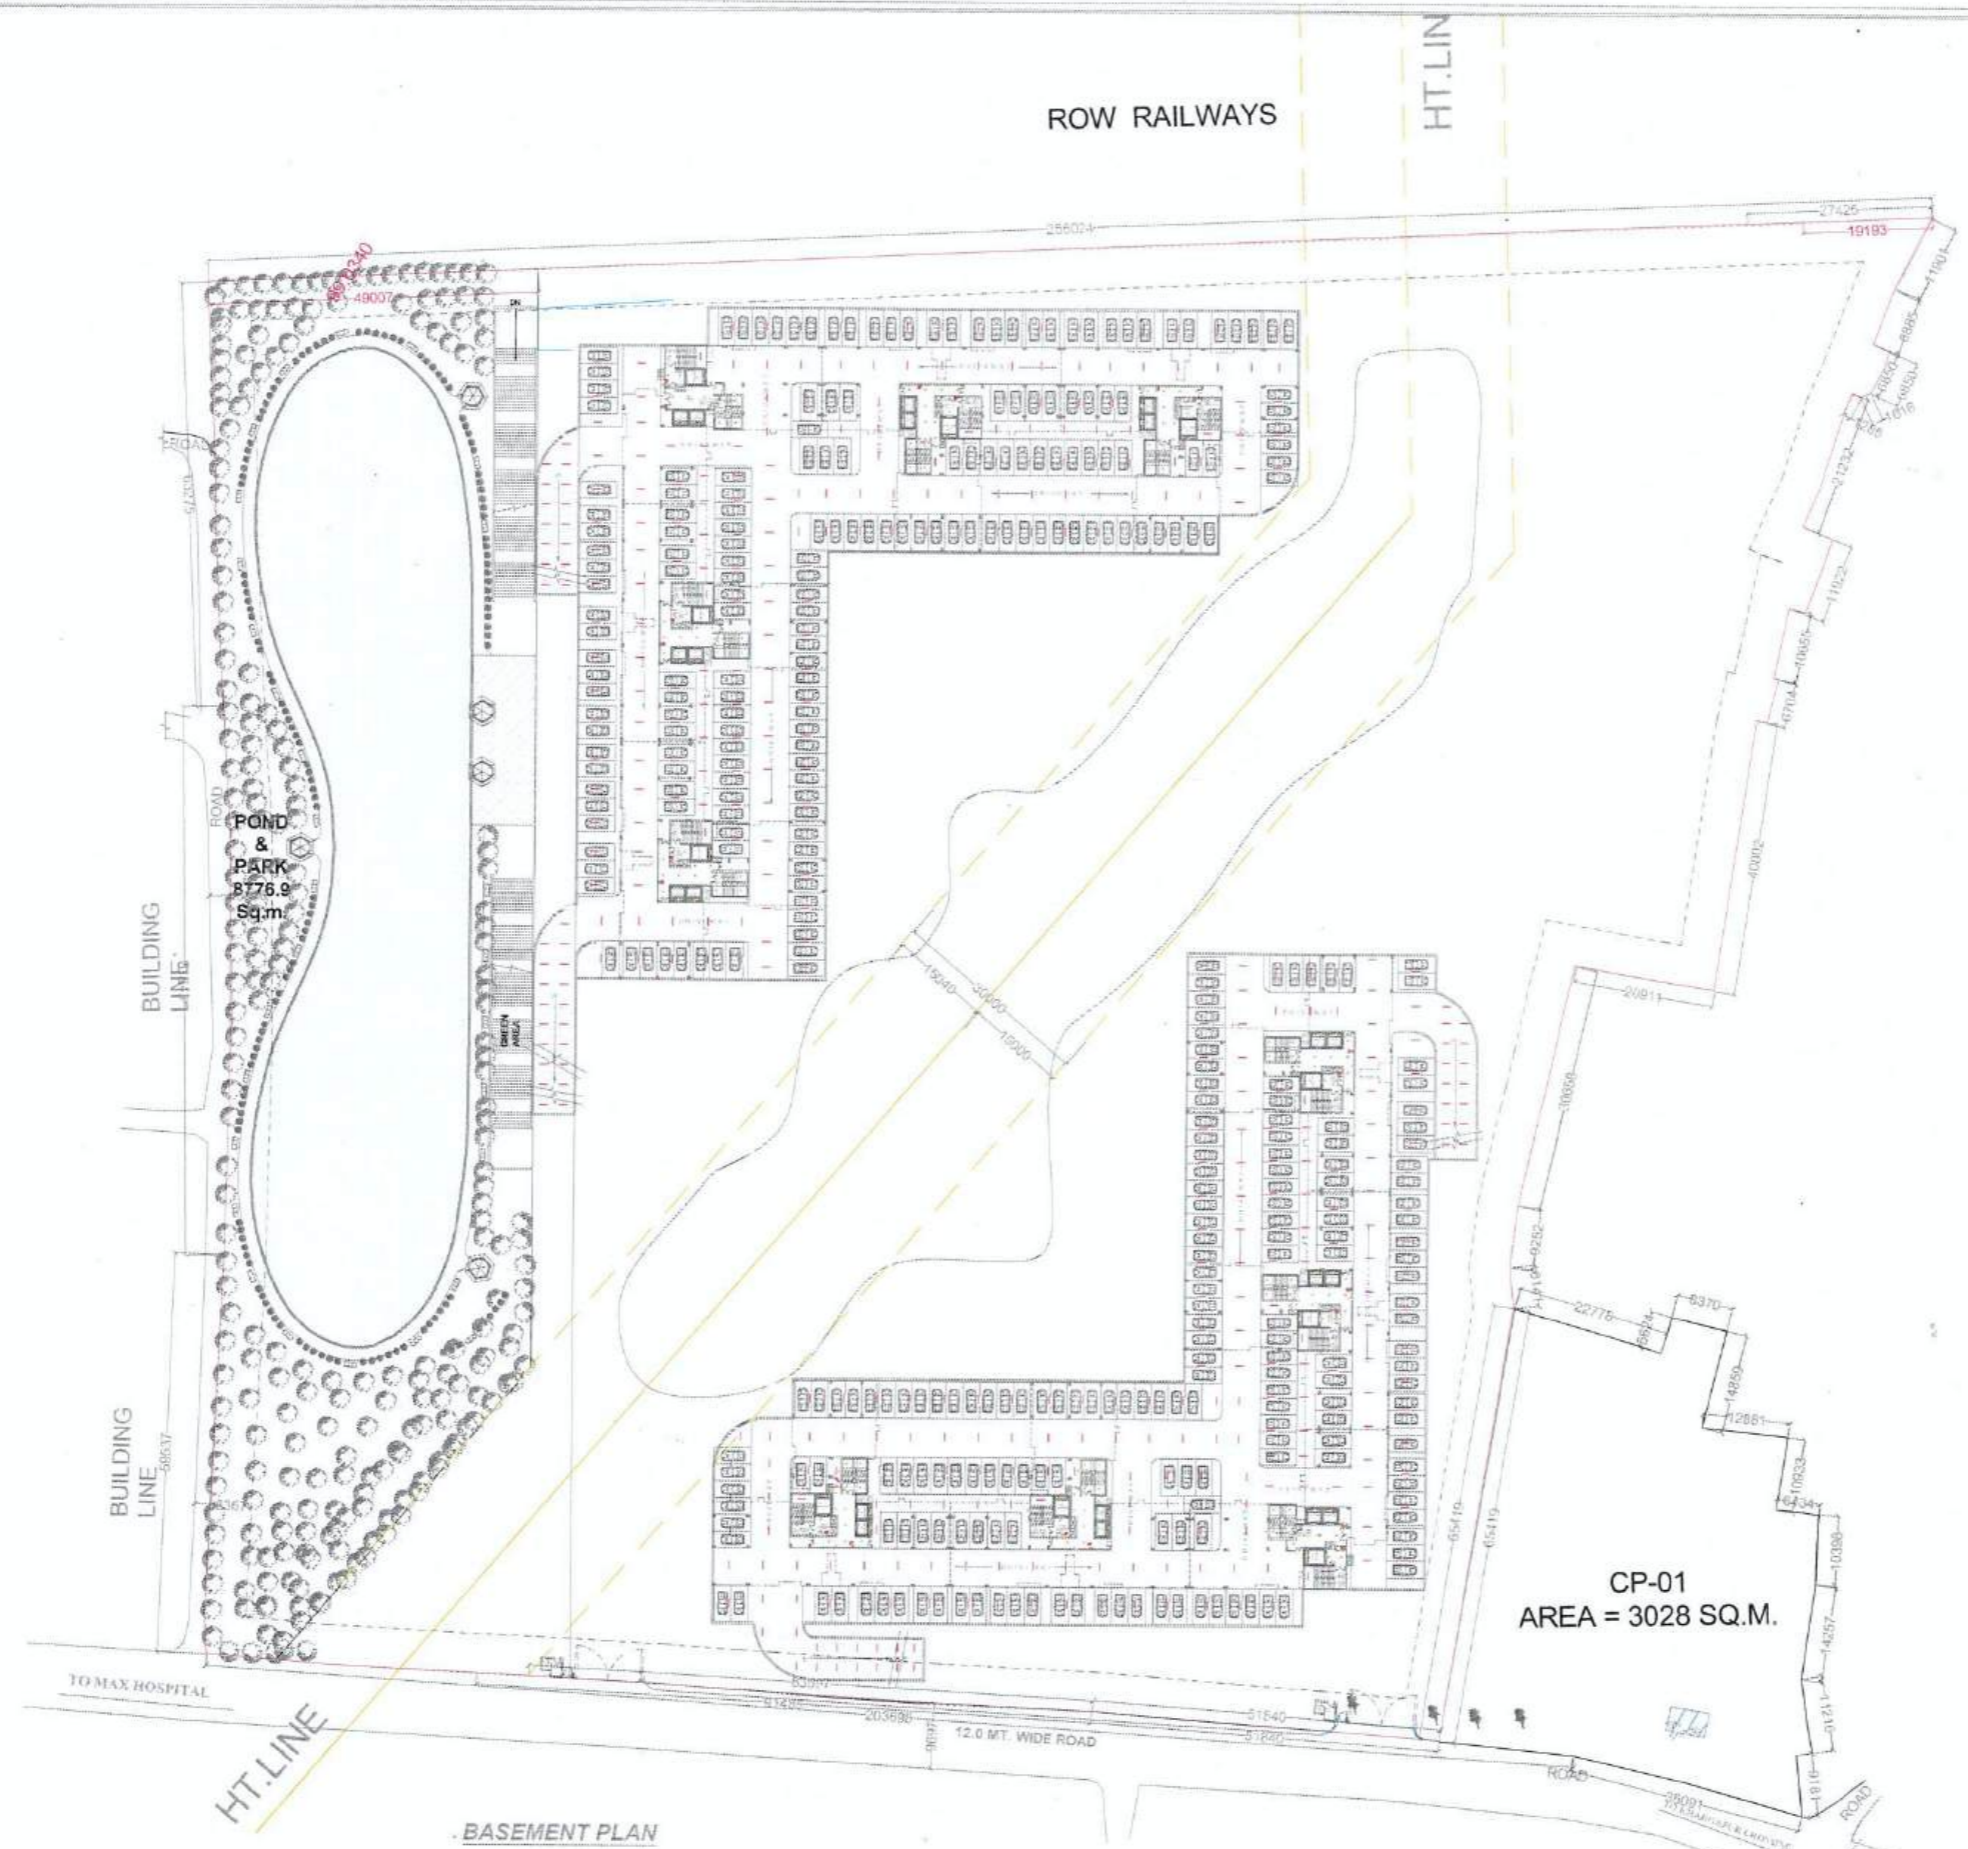

ELECTRICAL LEGEND	
SYMBOL	DESCRIPTION
1	CONCRETE WALL
2	CONCRETE COLUMN
3	CONCRETE BEAM
4	CONCRETE SLAB
5	CONCRETE STAIR
6	CONCRETE LIFT SHAFT
7	CONCRETE LIFT MACHINE ROOM
8	CONCRETE LIFT MOTOR ROOM
9	CONCRETE LIFT ELECTRICAL ROOM
10	CONCRETE LIFT ELECTRICAL ROOM
11	CONCRETE LIFT ELECTRICAL ROOM
100	CONCRETE LIFT ELECTRICAL ROOM

BASEMENT PLAN

**CP-01
AREA = 3028 SQ.M.**

WORKING DRAWING

**BASEMENT FLOOR PLAN
ELECTRICAL LAYOUT**

ORIENTATION	REFERENCE NO- L-118
	SHEET NO- 01
	SCALE NTS
	DATE Jan '2025
	Drawn By: DINESH
	REV

File No. LDA/BP/25-26/3370

CONTRACTOR: ARCHITECT



(Signature)
ARCHITECT
DINESH

architects
m u r a l a g e
architecture master planning interior design
conservation landscaping project management
A-32009, viraj khand, gomti nagar, lucknow
phone no. 2580139 2320711


(Handwritten signatures and stamps)
अवर अभियन्ता
सहायक अभियन्ता
ल० वि० प्रा०, लखनऊ विकास प्र०, लखनऊ

Copyright © Muralage 2023. All rights reserved.

PROPOSED GROUP HOUSING,
GH-01+GH-02 AT VIRAJ
KHAND, GOMTI NAGAR-
LUCKNOW

THIS DRAWING AND THE INFORMATION CONTAINED HEREIN SHALL NOT BE DISCLOSED, REPRODUCED OR USED FOR ANY PURPOSE BY ANY PERSON WITHOUT THE EXPRESS WRITTEN CONSENT OF M/S MURALAGE. THIS DRAWING IS PROTECTED UNDER COPYRIGHT LAW AND ANY COPYING OR REPRODUCTION HEREOF IS PROHIBITED. UNAUTHORIZED PERSONS FOUND COPYING THIS DRAWING OR ANY PART OF THIS DOCUMENT OR USING THE SAME FOR ANY PURPOSE SHALL BE SUBJECT TO LEGAL ACTION.

ELECTRICAL LEGEND			
SYMBOL	DESCRIPTION	SYMBOL	DESCRIPTION
[Symbol]	MAIN SWITCH	[Symbol]	SWITCH
[Symbol]	MINI CIRCULAR BREAKER	[Symbol]	SWITCH
[Symbol]	DIFFERENTIAL SWITCH	[Symbol]	SWITCH
[Symbol]	1-POLE SWITCH	[Symbol]	SWITCH
[Symbol]	2-POLE SWITCH	[Symbol]	SWITCH
[Symbol]	3-POLE SWITCH	[Symbol]	SWITCH
[Symbol]	4-POLE SWITCH	[Symbol]	SWITCH
[Symbol]	5-POLE SWITCH	[Symbol]	SWITCH
[Symbol]	6-POLE SWITCH	[Symbol]	SWITCH
[Symbol]	7-POLE SWITCH	[Symbol]	SWITCH
[Symbol]	8-POLE SWITCH	[Symbol]	SWITCH
[Symbol]	9-POLE SWITCH	[Symbol]	SWITCH
[Symbol]	10-POLE SWITCH	[Symbol]	SWITCH
[Symbol]	11-POLE SWITCH	[Symbol]	SWITCH
[Symbol]	12-POLE SWITCH	[Symbol]	SWITCH
[Symbol]	13-POLE SWITCH	[Symbol]	SWITCH
[Symbol]	14-POLE SWITCH	[Symbol]	SWITCH
[Symbol]	15-POLE SWITCH	[Symbol]	SWITCH
[Symbol]	16-POLE SWITCH	[Symbol]	SWITCH
[Symbol]	17-POLE SWITCH	[Symbol]	SWITCH
[Symbol]	18-POLE SWITCH	[Symbol]	SWITCH
[Symbol]	19-POLE SWITCH	[Symbol]	SWITCH
[Symbol]	20-POLE SWITCH	[Symbol]	SWITCH

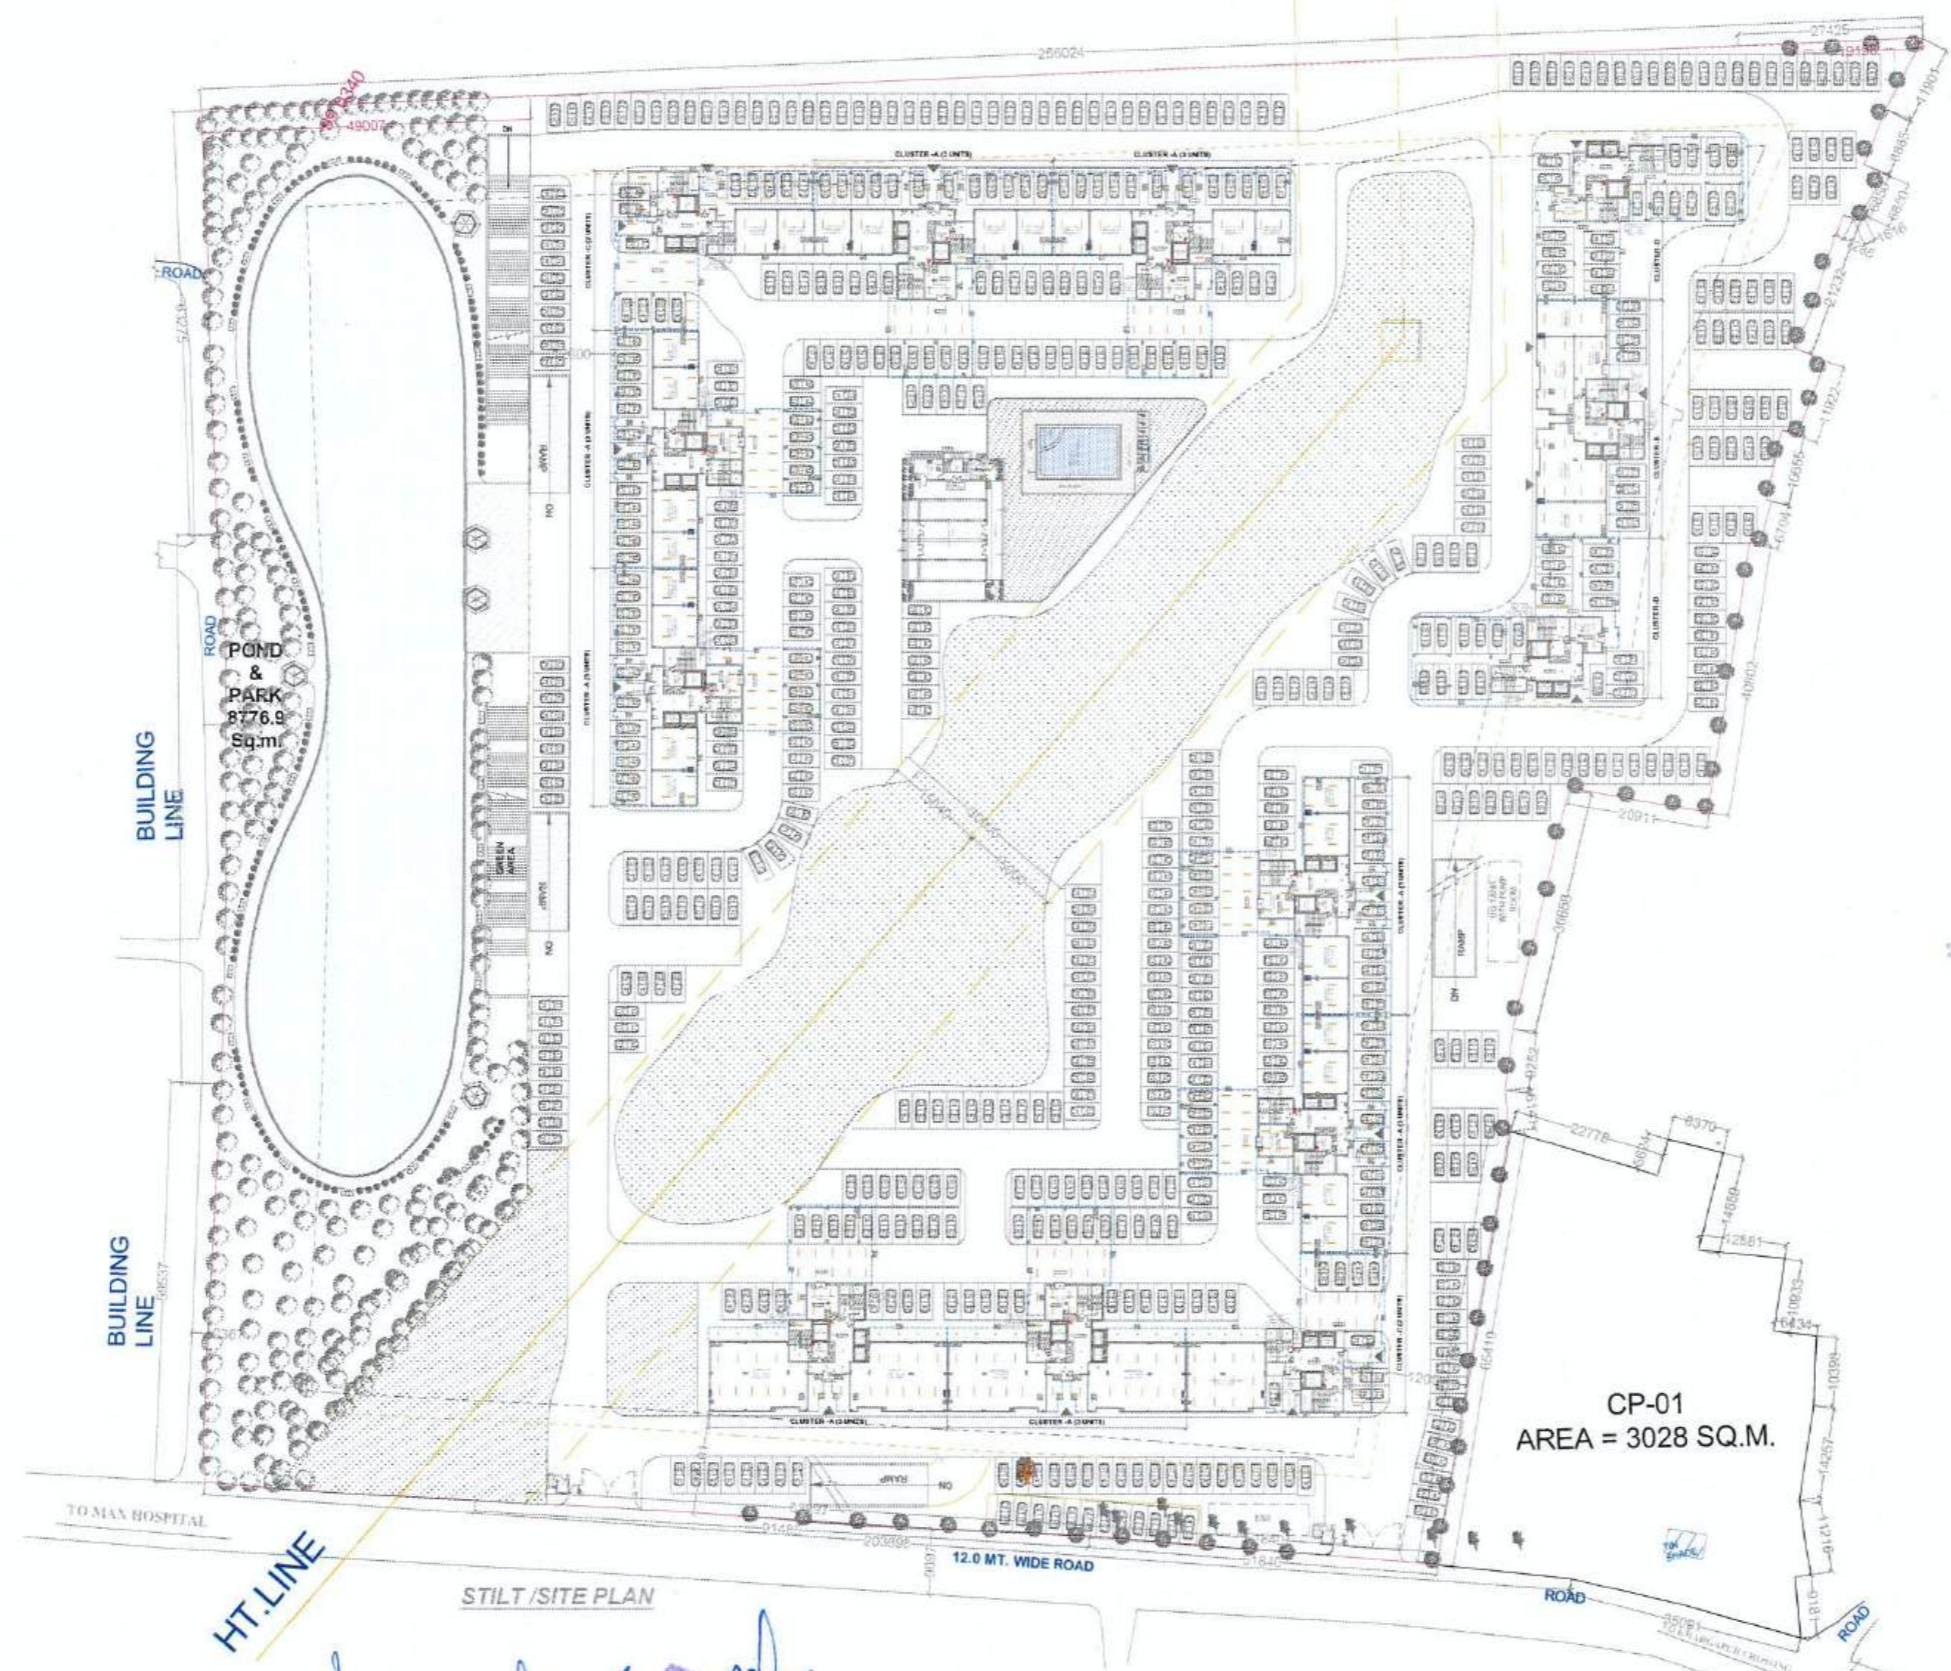

STILT / SITE PLAN

भवद अभियन्ता
सहायक अभियन्ता
वि. प्र. लखनऊ

अधिका
अभियन्ता
लखनऊ

मुरालागे

WORKING DRAWING

STILT FLOOR PLAN
ELECTRICAL LAYOUT

ORIENTATION	REFERENCE NO- L-119
	SHEET NO- 02
	SCALE NTS
	DATE Jan '2026
	Drawn By: DINESH
	REV:

File No. LDA/BP/25-26/3370


CONTRACTOR:	ARCHITECT

architects
m u r a l a g e
architecture, master planning, interior design
conservation, landscaping, project management
A-3/289 vibhav khand, gomti nagar, lucknow
phone no. 2580139, 2520715

Copyright © Muralage 2023. All rights reserved

PROPOSED GROUP HOUSING,
GH-01+GH-02 AT VIRAJ
KHAND, GOMTI NAGAR-
LUCKNOW

THIS DRAWING AND THE INFORMATION CONTAINED HEREIN SHALL NOT BE DISCLOSED, REPRODUCED OR USED FOR ANY PURPOSE BY ANY PERSON WITHOUT THE EXPRESS WRITTEN CONSENT OF M/S MURALAGE. THIS DRAWING IS PROTECTED UNDER COPYRIGHT LAW AND ANY COPIING OR REPRODUCTION HEREOF IS PROHIBITED. UNAUTHORIZED PERSONS FINDING THIS DRAWING OR ANY PART OF THIS DOCUMENT OR USING THE SAME FOR ANY PURPOSE SHALL BE SUBJECT TO LEGAL ACTION.

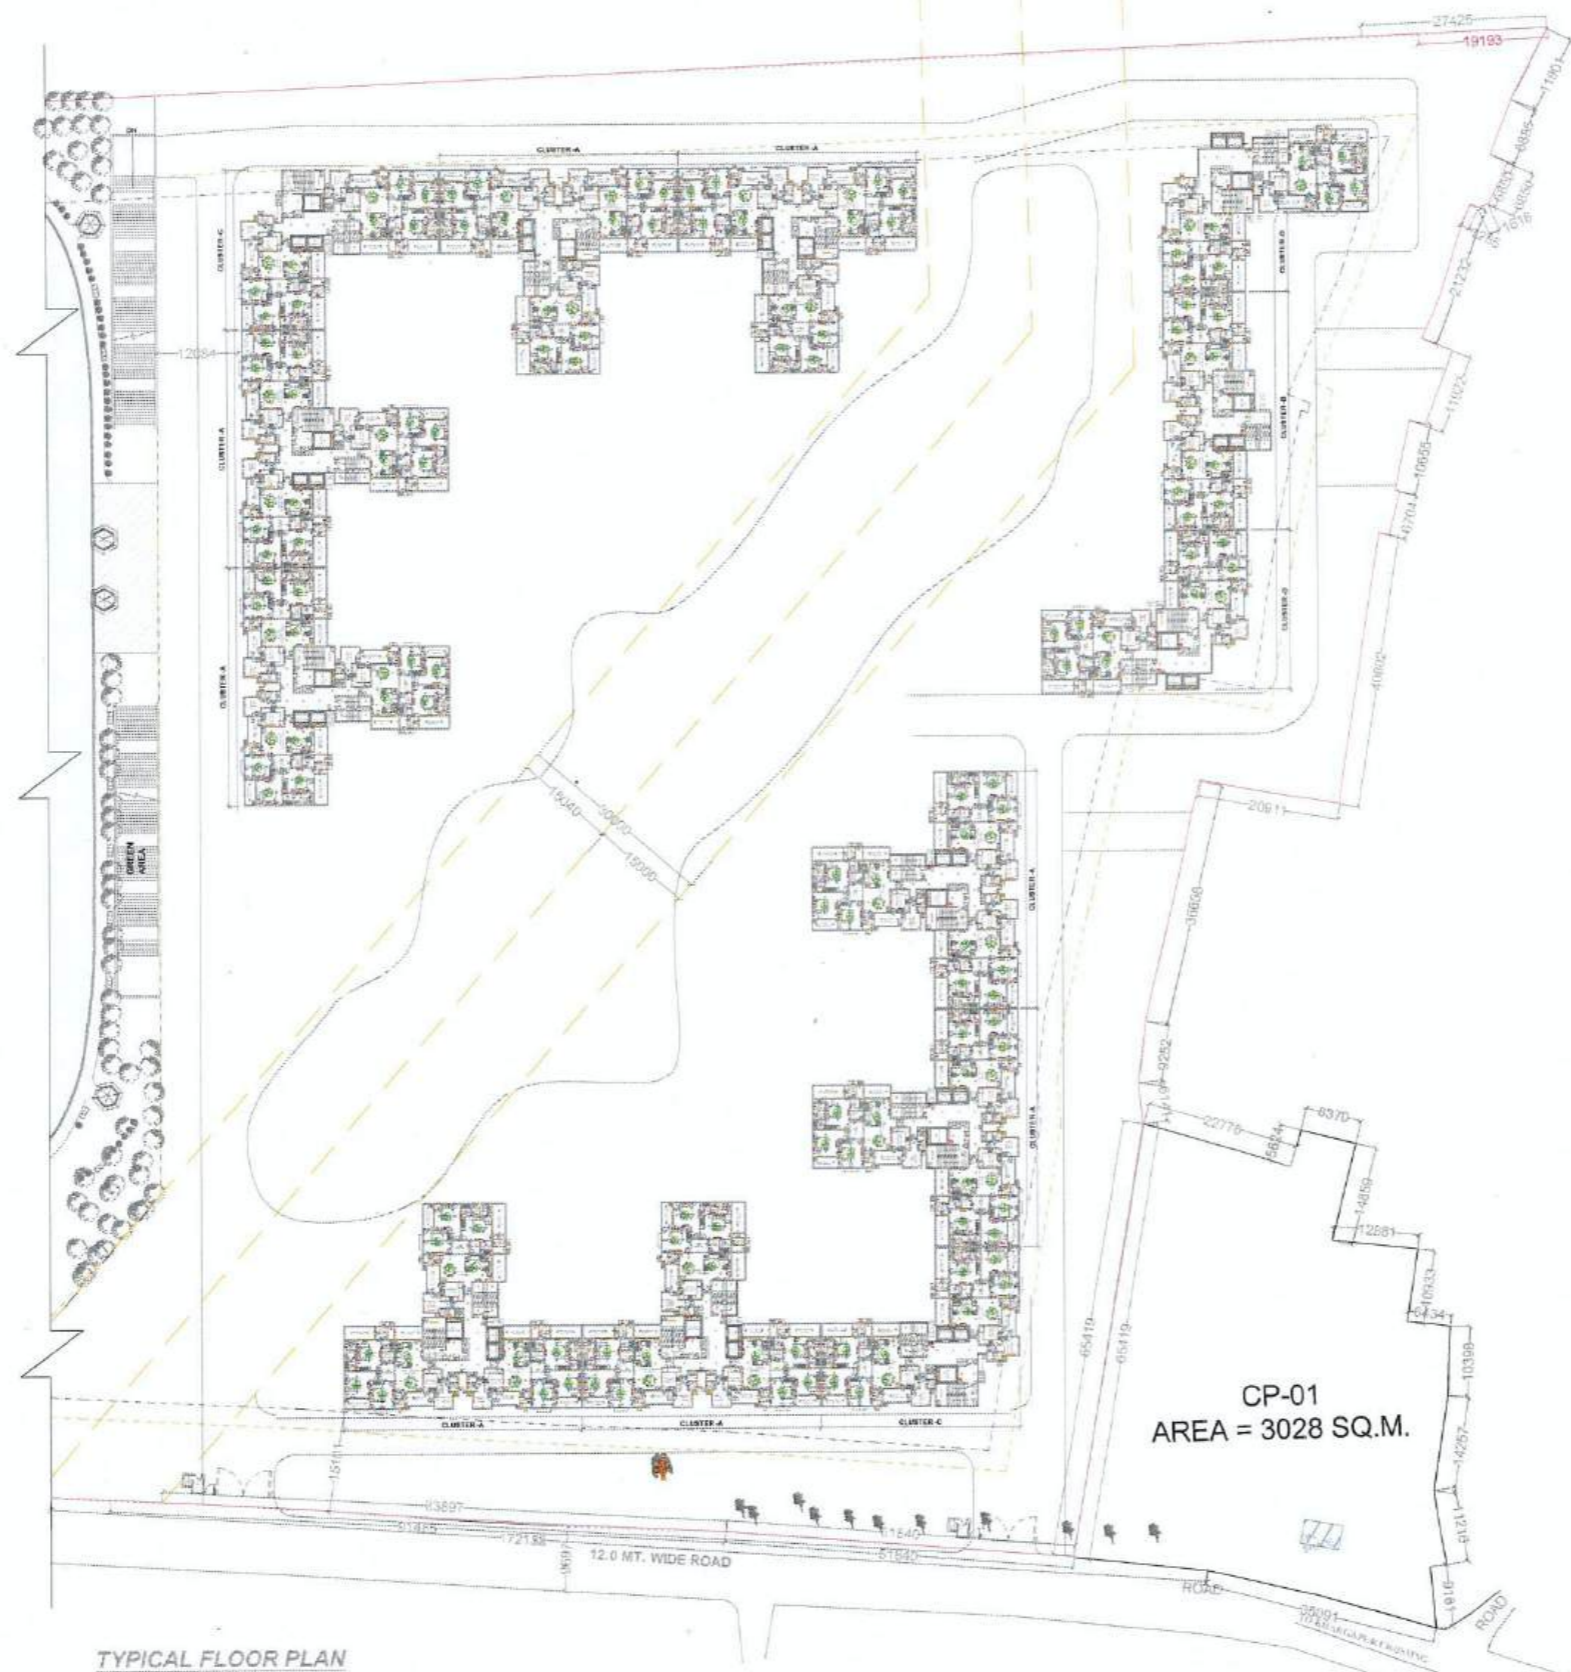

TYPICAL FLOOR PLAN

NO.	SYMBOL	DESCRIPTION
1	(Symbol)	MAIN ELECTRICAL PANEL
2	(Symbol)	CONSUMER UNIT
3	(Symbol)	WATER HEATER
4	(Symbol)	WATER TANK
5	(Symbol)	WATER TREATMENT PLANT
6	(Symbol)	WATER PUMP
7	(Symbol)	WATER DISTRIBUTION NETWORK
8	(Symbol)	WATER STORAGE TANK
9	(Symbol)	WATER TREATMENT PLANT
10	(Symbol)	WATER PUMP
11	(Symbol)	WATER DISTRIBUTION NETWORK
12	(Symbol)	WATER STORAGE TANK
13	(Symbol)	WATER TREATMENT PLANT
14	(Symbol)	WATER PUMP
15	(Symbol)	WATER DISTRIBUTION NETWORK
16	(Symbol)	WATER STORAGE TANK
17	(Symbol)	WATER TREATMENT PLANT
18	(Symbol)	WATER PUMP
19	(Symbol)	WATER DISTRIBUTION NETWORK
20	(Symbol)	WATER STORAGE TANK

WORKING DRAWING

TYPICAL FLOOR PLAN
ELECTRICAL LAYOUT

ORIENTATION	REFERENCE NO- L-119
	SHEET NO- 03
	SCALE NTS
	DATE: Jan '2020
	Drawn By: DINESH
	REV:

File No LDA/25-26/3370

CONTRACTOR ARCHITECT



architects
m u r a l a g e
architecture . master planning . interior design
conservation . landscaping . project management
A-3205 . vibhvee khand . gomti nagar . lucknow
phone no. : 2960139 . 2320715

अधिसासि अभियन्ता
सहायक अभियन्ता जोन-
लखनऊ
अ. वि. प्रा. संस्थान विकास प्रकल्प

