


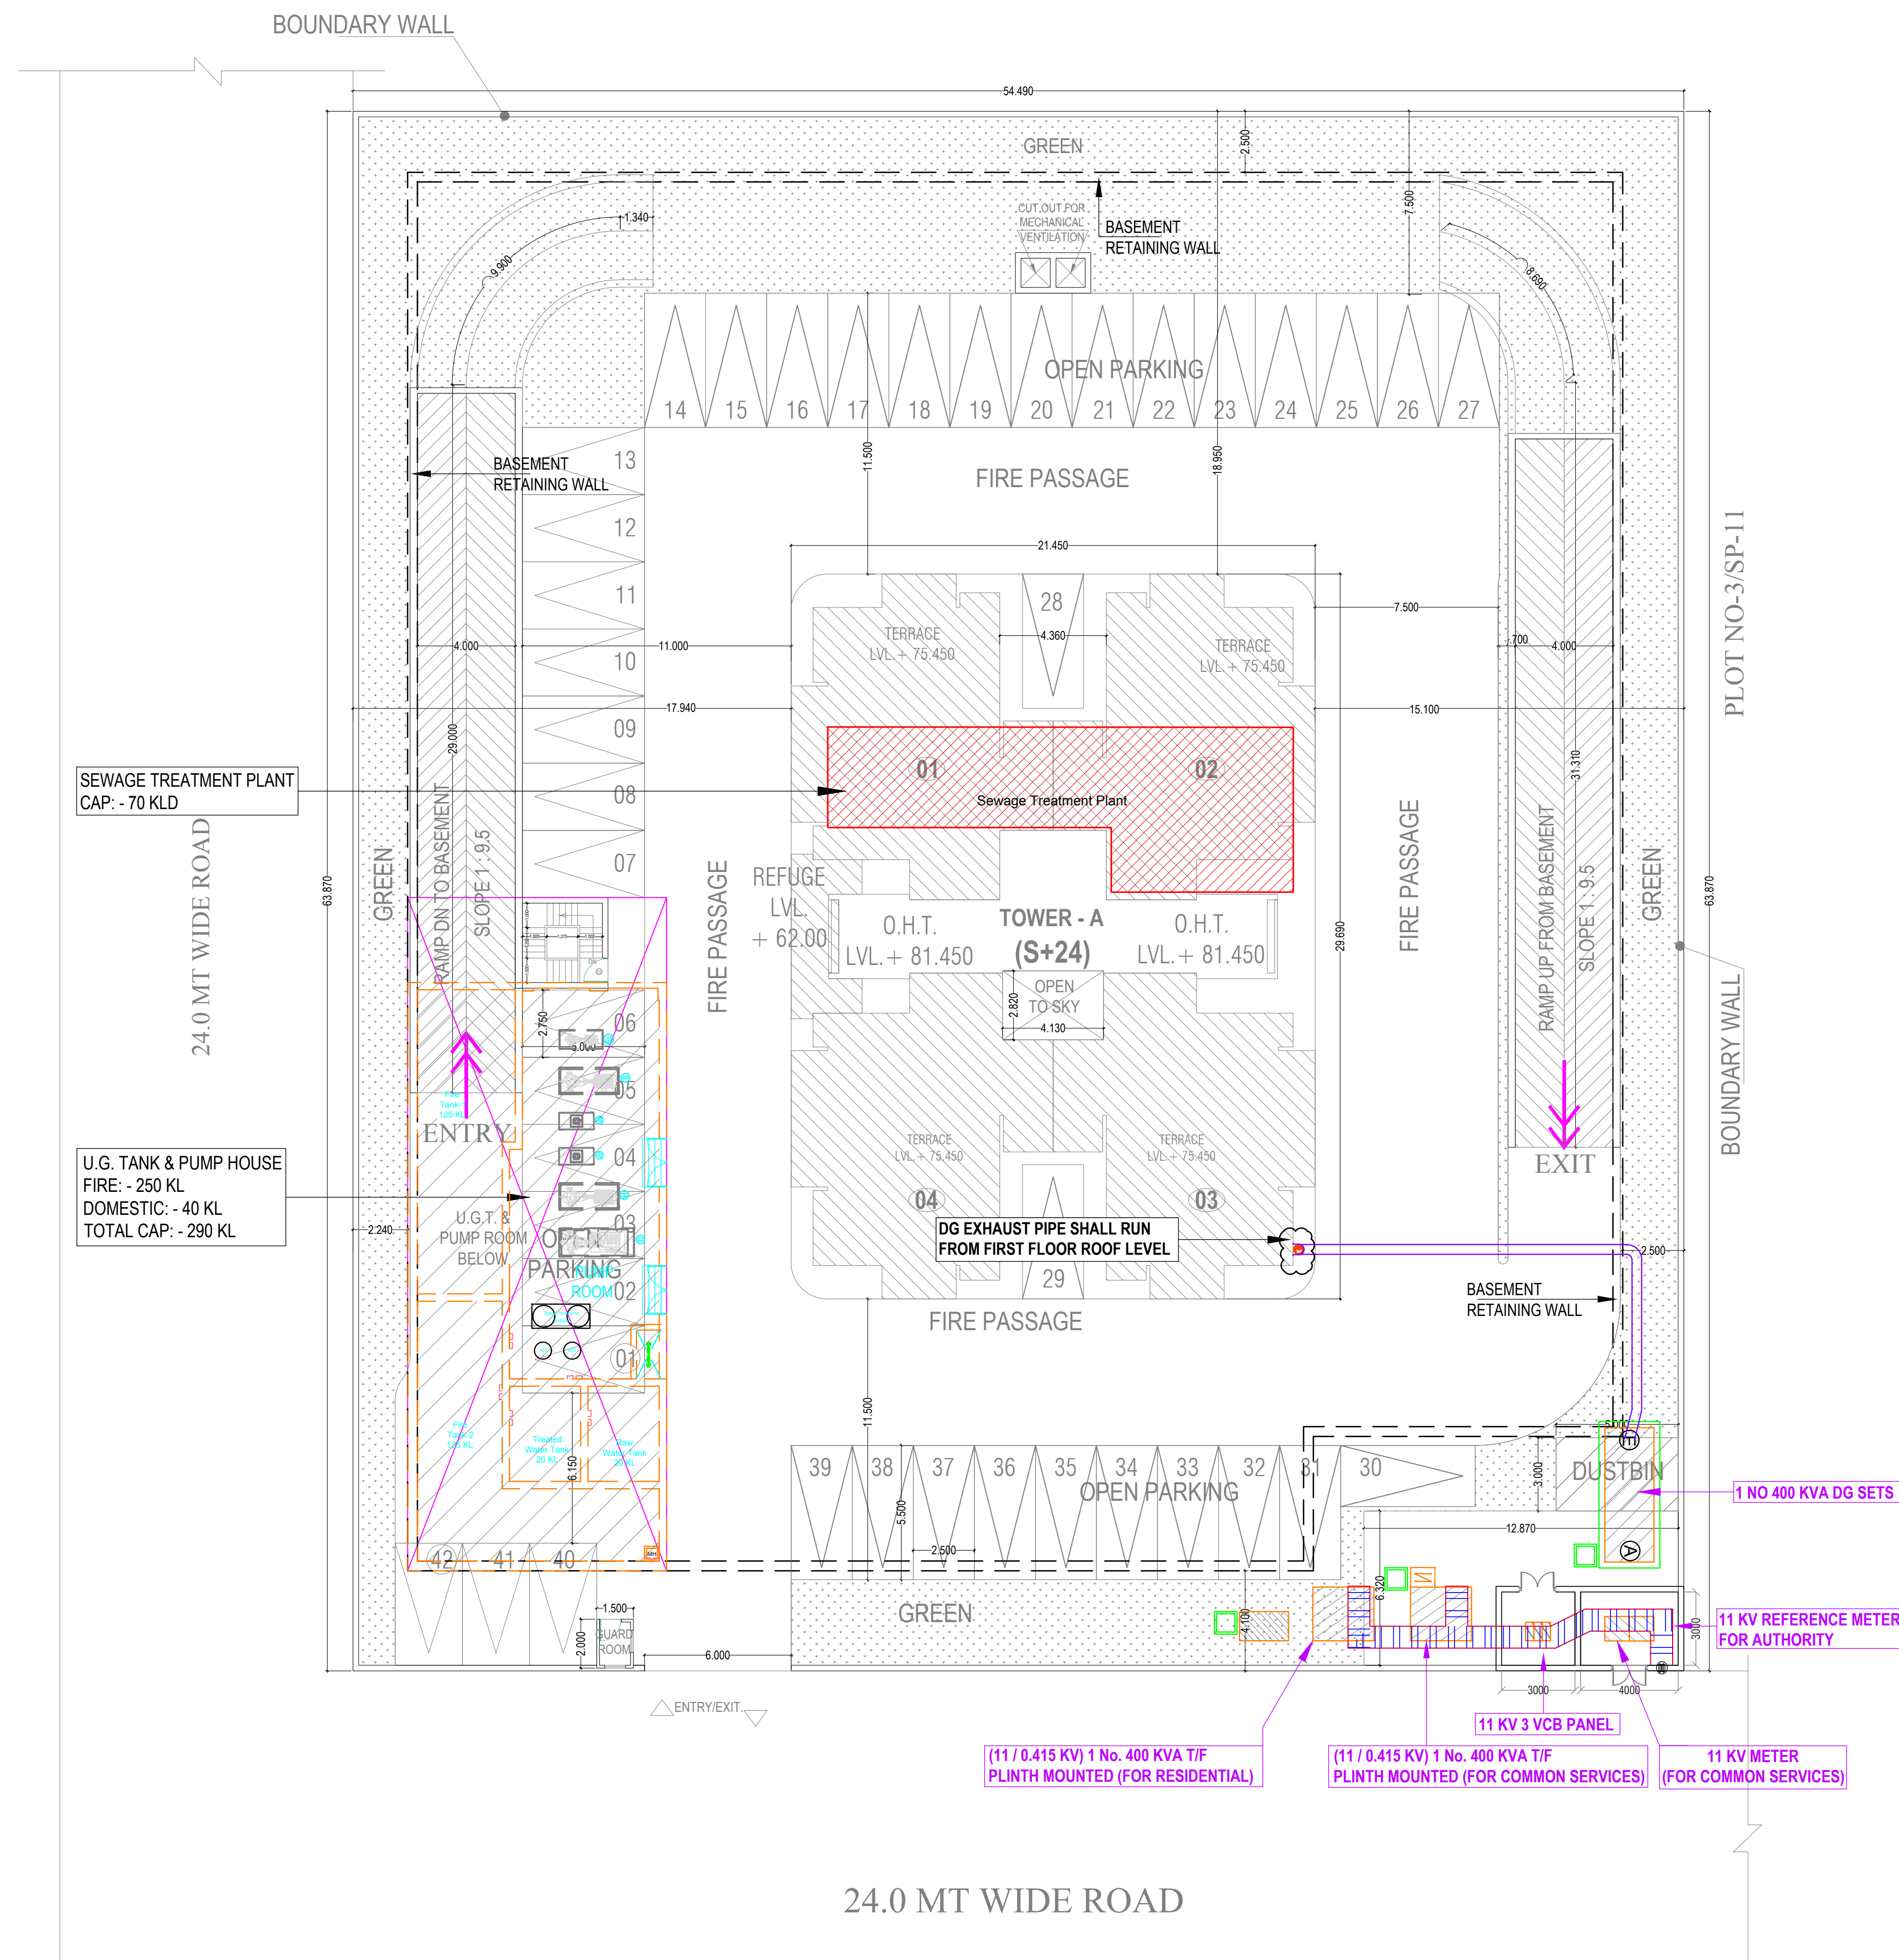

Rev. No.	Date	Revision
..	..	..

Project :
PROPOSED PLAN FOR LOKSABHA
KARMCHARI SAHKARI AWAS SAMITI PLOT NO-03/SP-09,
SIDDHARTH VIHAR YOJNA, GHAZIABAD.
FOR- M/S LOK SABHA EMPLOYEES CO-OPERATIVE
HOUSING SOCIETY LTD.

Title :
LAYOUT PLAN

Subtitle :
**ELECTRICAL DRAWING
SETTING-OUT PLAN SITE PLAN**

Drawing Released For :
☐ APPROVAL ☒ RERA SUBMISSION
☐ ADVANCE COPY ☐ CONSTRUCTION

Drg. No : LOK SABHA / ELEC / EXT. / 01

Scale : 1:225 Drawn By : Surjeet

Date : January 2021 Design By : Ateeq Ur Rehman

Ckd By : Anand Havelia

Architects :
DEEPAK MEHTA & ASSOCIATES
ARCHITECTS, PLANNERS, VALUERS, LANDSCAPE & INTERIORS
1st & 2nd FLOOR, PLOT NO. 16, ABHISHEK PLAZA, L.S.C., MAYUR VIHAR PH - II,
DELHI - 110091, INDIA TEL.(O) : +91-11-22770180, +91-9999219713,
E-mail : deepakmehta1962@gmail.com , Website : www.indianarchitect.co.in

Services Consultant :
Consummate Engineering Services (P) Ltd.
Noida Office : B - 67, Sector - 67, Noida - 201 301
Tel : (0120) 6613500 (24 Lines)
Lko. Office : R 006, Rohtas Plumeria, Gomti Nagar, Lucknow
e mail : mail@cespl.in, website : www.cespl.in

