
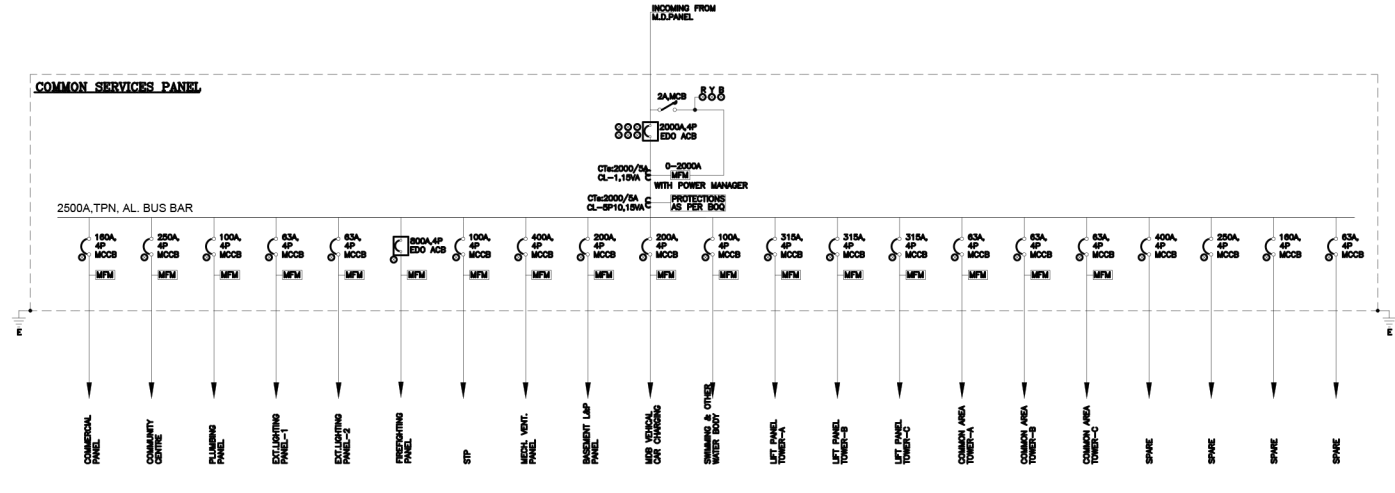
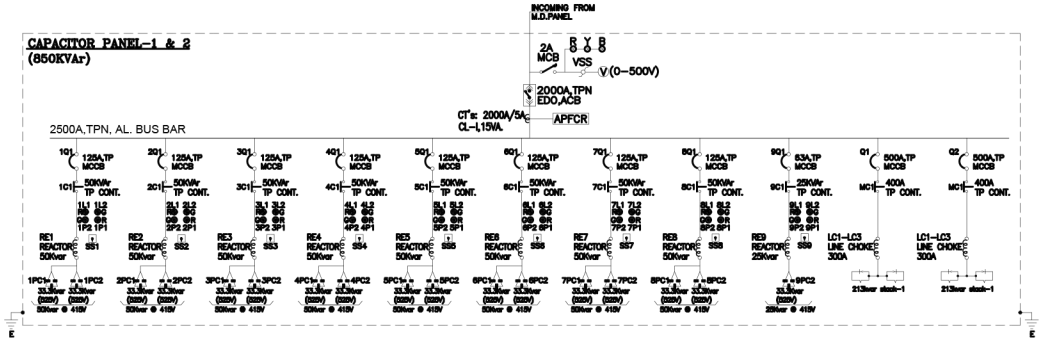


For Gulshan Homz Pvt. Ltd.
For Gulshan Homz Pvt. Ltd.
Authorised Signatory

LEGEND:-	
	AIR CIRCUIT BREAKER (ACB)
	VACUUM CIRCUIT BREAKER (VCB)
	CURRENT TRANSFORMER (CT)
	MOULDED CASE CIRCUIT BREAKER (MCCB)
	MINIATURE CIRCUIT BREAKER (MCB)
	TRANSFORMER
	INTER LOCKING
	D.G. SET
	EARTHING
	MULTI FUNCTIONAL METER WITH POWER MANAGER
	CONTACTOR
	LED INDICATING LAMP
	ELECTRICAL OPERATED
	DEMAND LOAD
	WORKING LOAD
	NON DIRECTIONAL 2 O/C & 1 E/F IDMT RELAY
	MAXIMUM DEMAND
	POWER FACTOR METER
	KILO WATT METER
	ON LOAD TAP CHANGER CONTROL
	ELECTRICALLY DRAW OUT
	MANUALLY DRAW OUT
	MASTER TRIP RELAY
	TRANSFORMER BUCHHOLZ RELAY(Alarm&Trip)
	OLTC SURGE RELAY
	OIL TEMPERATURE RELAY(Alarm & Trip)
	WINDING TEMPERATURE RELAY(Alarm & Trip)
	STAR-DELTA STARTER
	DIRECT ON LINE STARTER

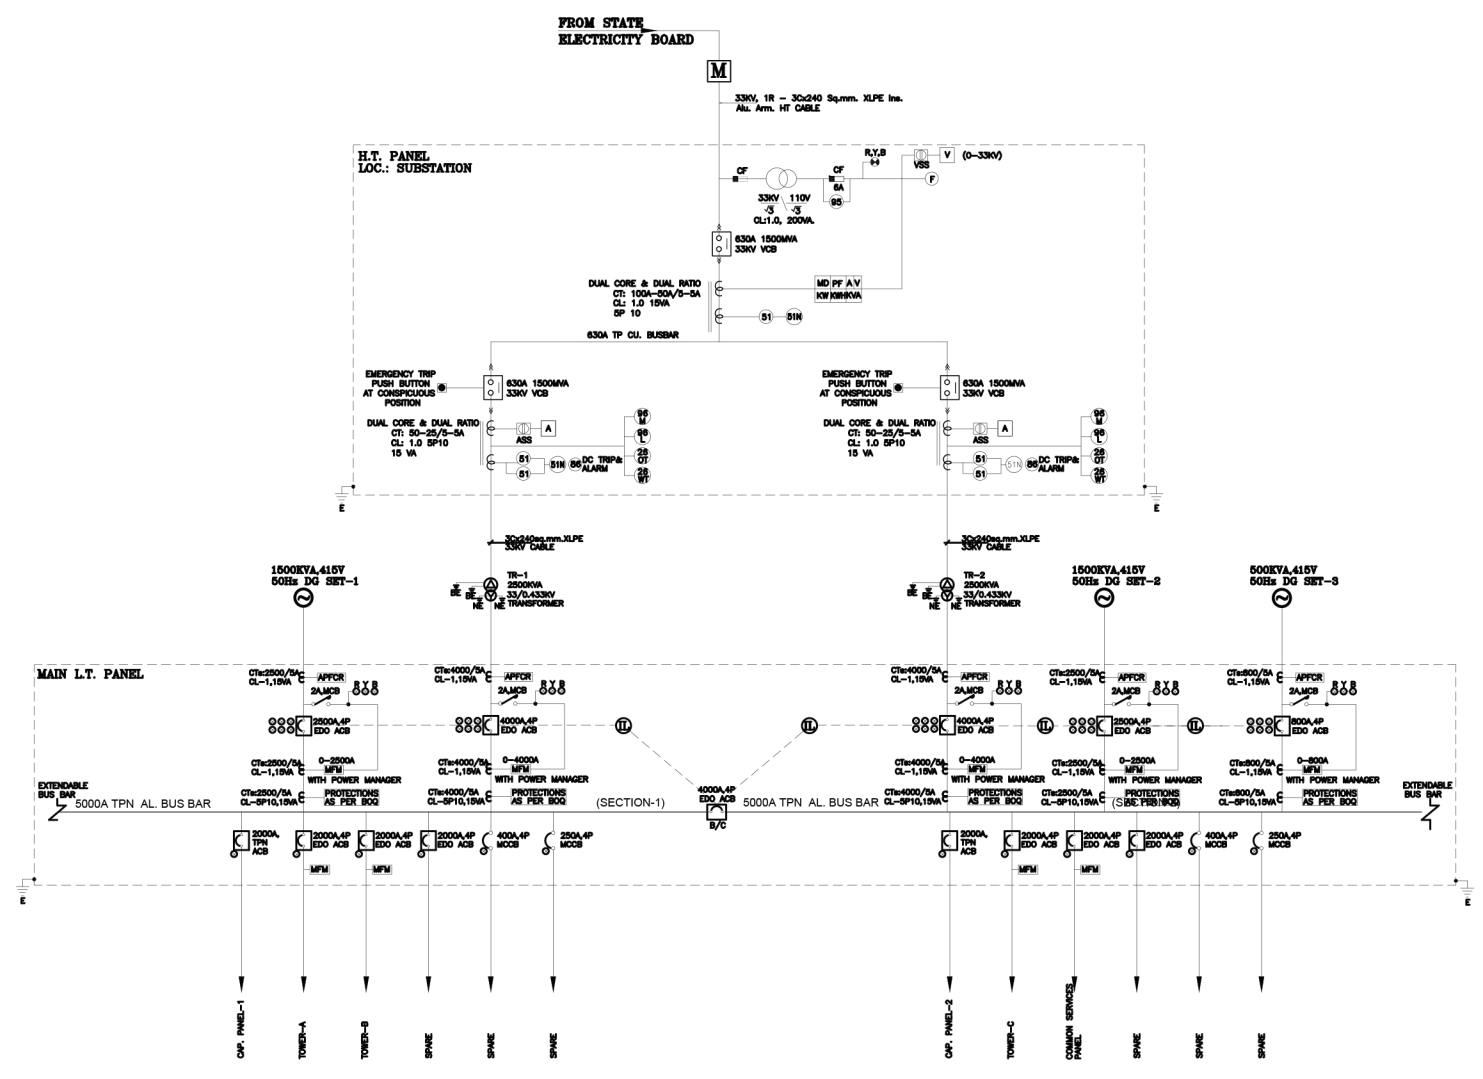

DATE	REVISION	DESCRIPTION	BY

B-50, Basement, Soami Nagar
New Delhi-110017
Tel No: 011-49848197 & 49849205
Email: info@vconsulting.co.in

ARCHITECT	
B-421, NFC N.D-65, INDIA architecture urban design Ph: +91-11-46130690 Ph: +91-11-43864788 www.confluence.com hospitality Member of IGBIC ISO - 9001:2000 Interiors	
CLIENT:	
GULSHAN HOMZ	
PROJECT:	
PROPOSED GROUP HOUSING FOR GULSHAN HOMZ AT PLOT NO-GH-03D SECTOR-144, NOIDA, UP	
DRAWING TITLE:-	
SINGLE LINE DIAGRAM	
SUB TITLE:	
MAIN LT PANEL	
DATE	03-09-2019
SCALE	N.T.S.
DRAWN	ANKUR
CHKD.BY	ROHIT BISLA
DRG.NO:- A/GUH/EL/SLD-100	