
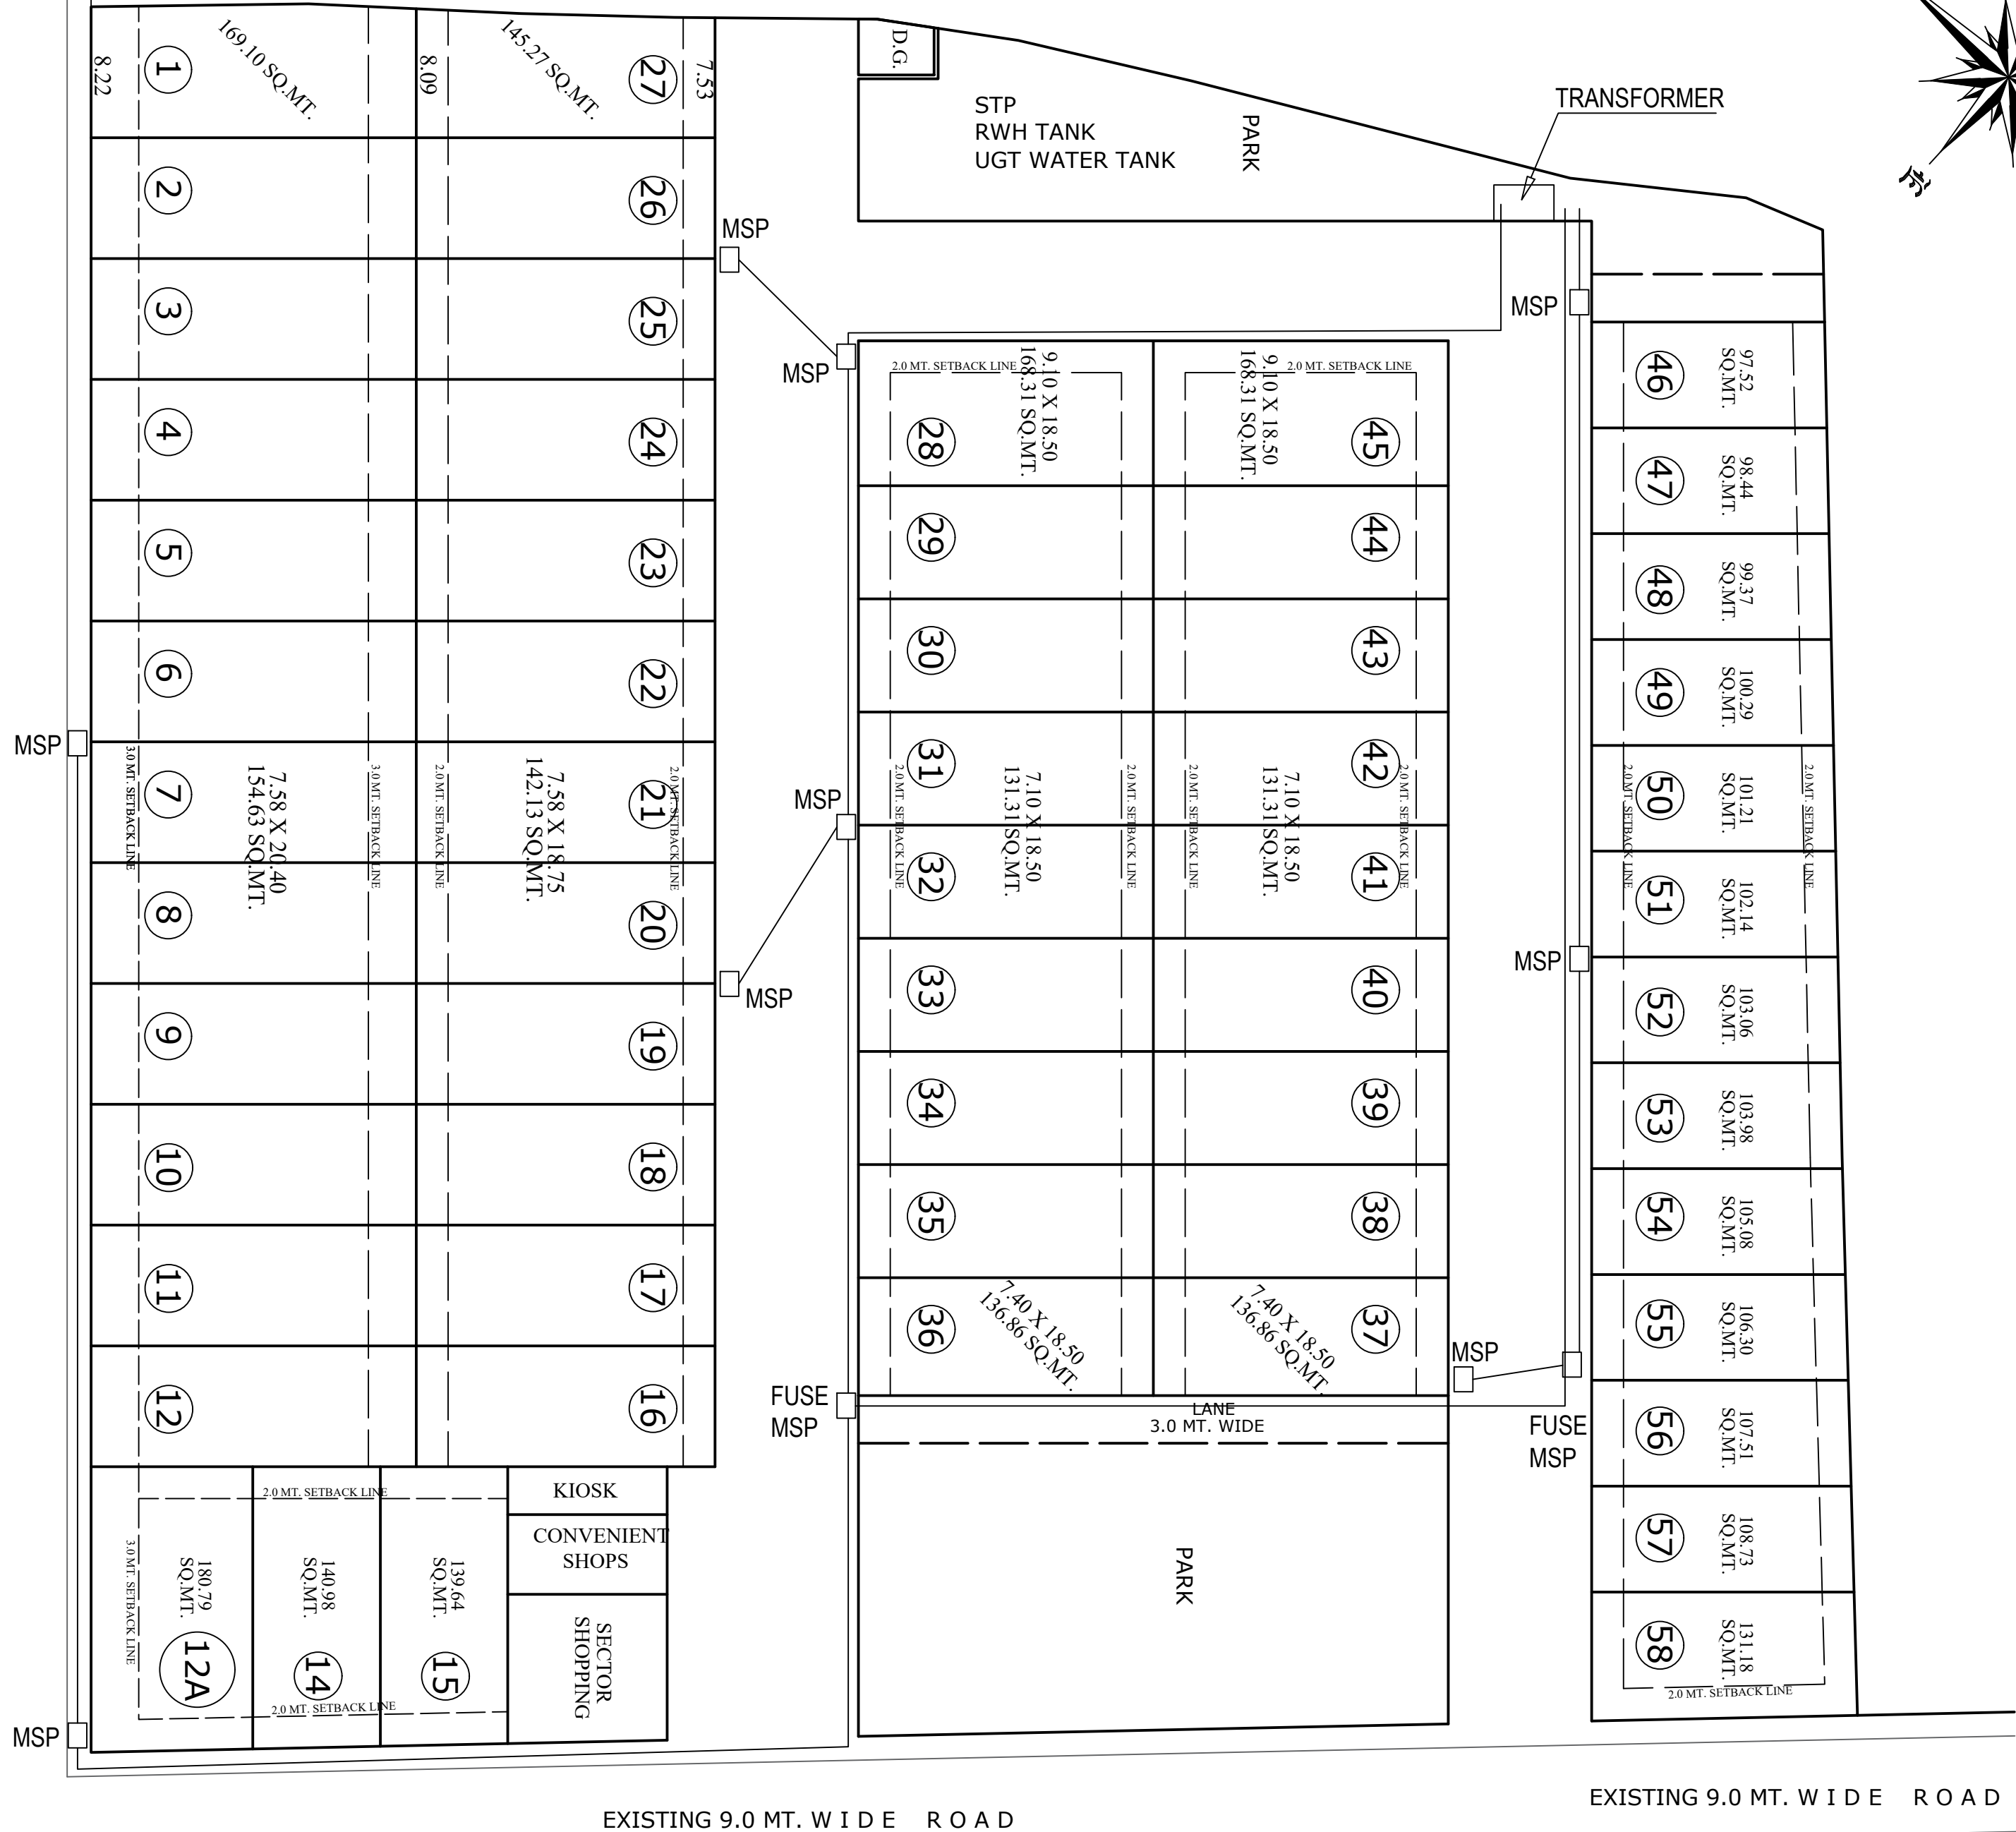


E | studioarchrok@gmail.com

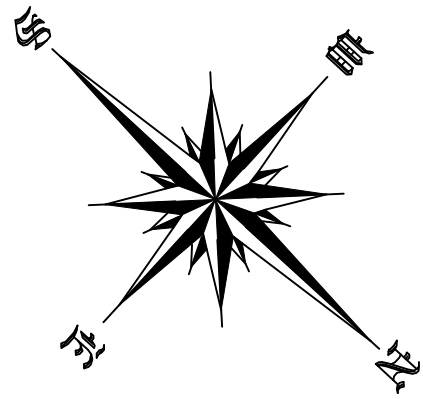

| ISSUES | | | | |
|--------|---------|-------|-----------------|----------|
| NO. | DATE | BY | SEND TO | |
| 1. | 18/4/23 | email | Bibhab Builders | Khushboo |
| 2. | | | | |
| 3. | | | | |
| 4. | | | | |
| 5. | | | | |
| 6. | | | | |

| | | |
|-----|------|-------------|
| 6. | | |
| 5. | | |
| 4. | | |
| 3. | | |
| 2. | | |
| 1. | | |
| NO. | DATE | DESCRIPTION |

CLIENT
BIBHAB BUILDERS

PROJECT

BIBHAB GARDEN CITY

DWG TITLE
ELECTRICAL LAYOUT

| | | |
|-------------------------|------|-----------------------|
| DWG NO. EL-01 | TYPE | REV. NO. 00 |
|-------------------------|------|-----------------------|

☐ FOR TENDER/ MOCK UP ☐ FOR EXECUTION
☐ FOR INFORMATION ☐ FOR APPROVAL

| | | | |
|------------|----|-------|--------|
| DEALT BY | KH | SCALE | N.T.S. |
| CHECKED BY | RK | DATE | |

1. THIS DRAWING IS THE PROPERTY OF M/S studio archRoK and SHALL NOT BE COPIED OR USED IN ANYWAY WITHOUT THEIR PRIOR PERMISSION.
2. ALL DIMENSIONS ARE IN METERS, UNLESS MENTIONED OTHERWISE.
3. DRAWING NOT TO BE SCALED, WRITTEN DIMENSIONS TO BE FOLLOWED.
4. ALL DISCREPANCIES TO BE BROUGHT TO THE NOTICE OF ARCHITECT BEFORE EXECUTION AND HIS DECISION TO BE FINAL.
5. THIS DRAWING TO BE READ IN CONJUNCTION WITH DETAILS, LARGE SCALE DRAWINGS, STRUCTURAL, SERVICES AND OTHER RELEVANT DRAWINGS.
6. THIS DRAWING SHOULD BE READ IN CONJUNCTION WITH ALL RELEVANT STRUCTURAL, ARCHITECTURAL SERVICES AND LANDSCAPE DRAWINGS.