


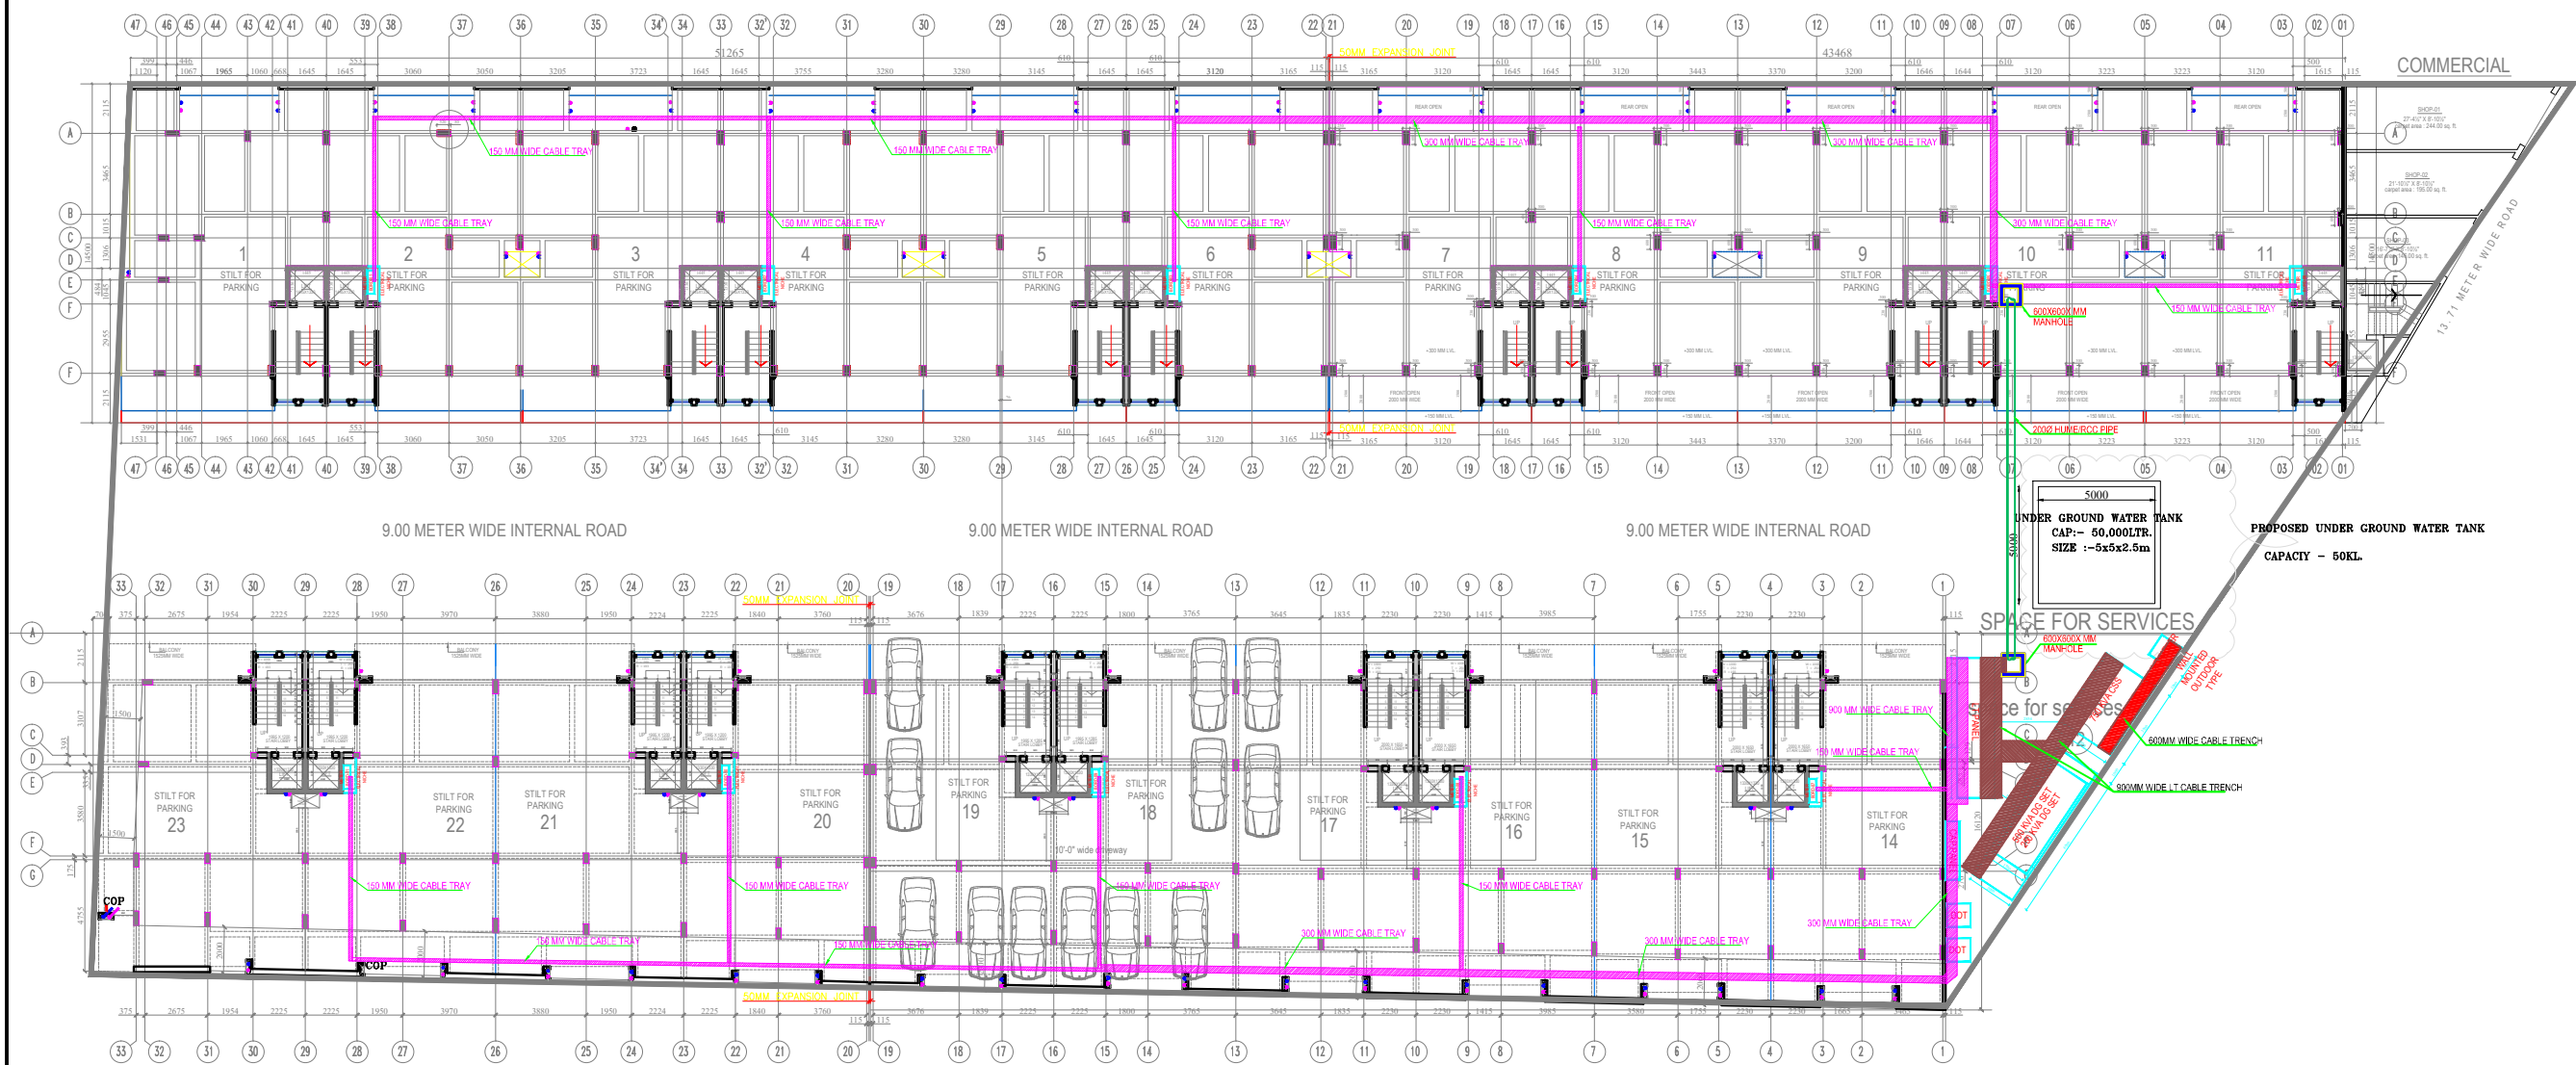

PAWAN KUMAR
ARCHITECT
Regn. No.-CA/2012/58184

STILT FLOOR PLAN

Rev. No.	Date	Revision
..	..	..

Project :
**PROPOSED ROW HOUSING AT
"ROYCE VAISHALI"**
PLOT NO.18B,SECTOR-3,
VAISHALI, GHAZIABAD

Title :
WORKING DRG. ELECTRICAL LAYOUT

Subtitle :
**WORKING DRG.
STILT FLOOR PLAN**

Drawing Released For :
☒ APPROVAL ☐ SUBMISSION
☐ ADVANCE COPY ☐ CONSTRUCTION

Drg. No :
WD. S.P. - 02

Scale :

Date : 24th Apr. 2019

Ckd By :

Drawn By : Deepak

Design By : Dushyant Kumar

Pawan Kumar

Architects :
D+P ASSOCIATES
DESIGNERS & PLANNERS
architects,engineers,interior designers,landscape & vastu consult.
L-11, HIMALAYA LEGAND, F.F., NYAY KHAND-1,
INDIRAPURAM, GHAZIABAD Mobile: 98 10 88 89 16 , 9 87 33 26 24 1
Email Id:dpassociates2015@gmail.com,dparchitects2015@gmail.com

