


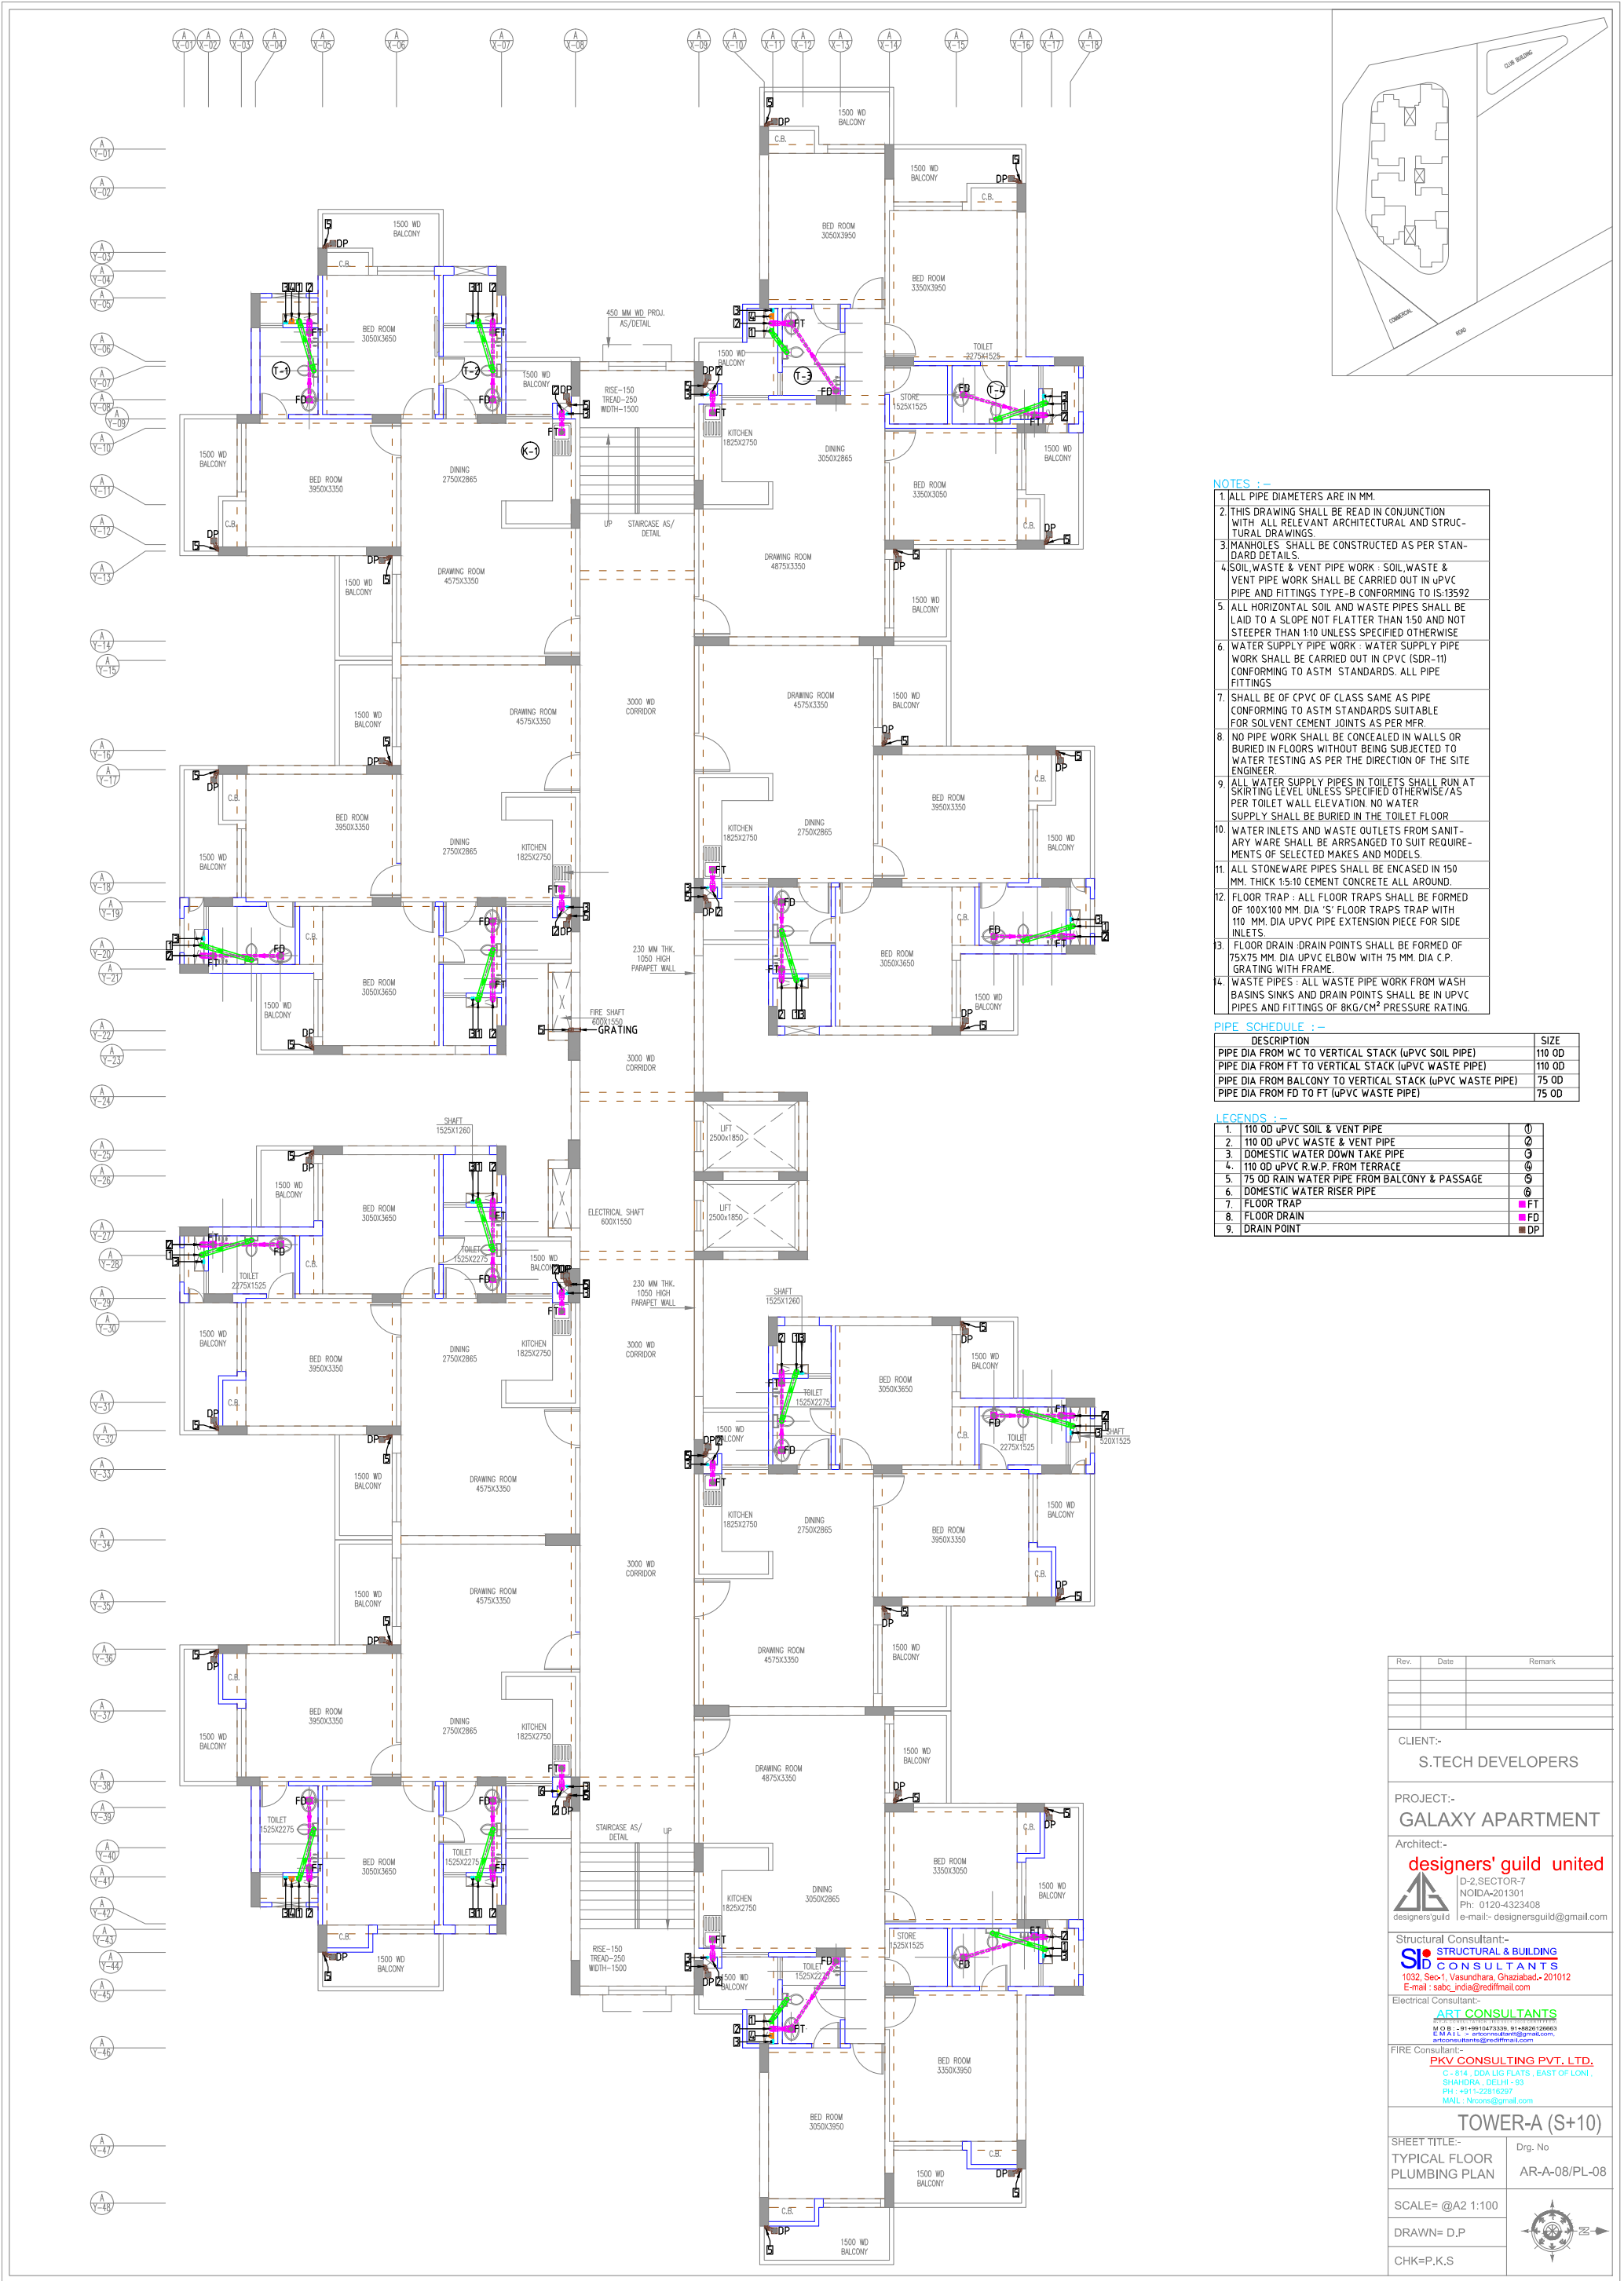

- NOTES :-**
1. ALL PIPE DIAMETERS ARE IN MM.
 2. THIS DRAWING SHALL BE READ IN CONJUNCTION WITH ALL RELEVANT ARCHITECTURAL AND STRUCTURAL DRAWINGS.
 3. MANHOLES SHALL BE CONSTRUCTED AS PER STANDARD DETAILS.
 4. SOIL, WASTE & VENT PIPE WORK : SOIL, WASTE & VENT PIPE WORK SHALL BE CARRIED OUT IN UPVC PIPE AND FITTINGS TYPE-B CONFORMING TO IS:13592
 5. ALL HORIZONTAL SOIL AND WASTE PIPES SHALL BE LAID TO A SLOPE NOT FLATTER THAN 1:50 AND NOT STEEPER THAN 1:10 UNLESS SPECIFIED OTHERWISE
 6. WATER SUPPLY PIPE WORK : WATER SUPPLY PIPE WORK SHALL BE CARRIED OUT IN CPVC (SDR-11) CONFORMING TO ASTM STANDARDS. ALL PIPE FITTINGS
 7. SHALL BE OF CPVC OF CLASS SAME AS PIPE CONFORMING TO ASTM STANDARDS SUITABLE FOR SOLVENT CEMENT JOINTS AS PER MFR.
 8. NO PIPE WORK SHALL BE CONCEALED IN WALLS OR BURIED IN FLOORS WITHOUT BEING SUBJECTED TO WATER TESTING AS PER THE DIRECTION OF THE SITE ENGINEER.
 9. ALL WATER SUPPLY PIPES IN TOILETS SHALL RUN AT SKIRTING LEVEL UNLESS SPECIFIED OTHERWISE/AS PER TOILET WALL ELEVATION. NO WATER SUPPLY SHALL BE BURIED IN THE TOILET FLOOR
 10. WATER INLETS AND WASTE OUTLETS FROM SANITARY WARE SHALL BE ARRANGED TO SUIT REQUIREMENTS OF SELECTED MAKES AND MODELS.
 11. ALL STONEWARE PIPES SHALL BE ENCASED IN 150 MM. THICK 1:5:10 CEMENT CONCRETE ALL AROUND.
 12. FLOOR TRAP : ALL FLOOR TRAPS SHALL BE FORMED OF 100X100 MM. DIA 'S' FLOOR TRAPS TRAP WITH 110 MM. DIA UPVC PIPE EXTENSION PIECE FOR SIDE INLETS.
 13. FLOOR DRAIN : DRAIN POINTS SHALL BE FORMED OF 75X75 MM. DIA UPVC ELBOW WITH 75 MM. DIA C.P. GRATING WITH FRAME.
 14. WASTE PIPES : ALL WASTE PIPE WORK FROM WASH BASINS SINKS AND DRAIN POINTS SHALL BE IN UPVC PIPES AND FITTINGS OF 8KG/CM² PRESSURE RATING.

PIPE SCHEDULE :-

DESCRIPTION	SIZE
PIPE DIA FROM WC TO VERTICAL STACK (UPVC SOIL PIPE)	110 OD
PIPE DIA FROM FT TO VERTICAL STACK (UPVC WASTE PIPE)	110 OD
PIPE DIA FROM BALCONY TO VERTICAL STACK (UPVC WASTE PIPE)	75 OD
PIPE DIA FROM FD TO FT (UPVC WASTE PIPE)	75 OD

LEGENDS :-

1. 110 OD UPVC SOIL & VENT PIPE	①
2. 110 OD UPVC WASTE & VENT PIPE	②
3. DOMESTIC WATER DOWN TAKE PIPE	③
4. 110 OD UPVC R.W.P. FROM TERRACE	④
5. 75 OD RAIN WATER PIPE FROM BALCONY & PASSAGE	⑤
6. DOMESTIC WATER RISER PIPE	⑥
7. FLOOR TRAP	■ FT
8. FLOOR DRAIN	■ FD
9. DRAIN POINT	■ DP

Rev.	Date	Remark
CLIENT:- S.TECH DEVELOPERS		
PROJECT:- GALAXY APARTMENT		
Architect:- designers' guild united D-2,SECTOR-7 NOIDA-201301 Ph: 0120-4323408 E-mail: designersguild@gmail.com		
Structural Consultant:- STRUCTURAL & BUILDING SID CONSULTANTS 1032, Sec-1, Vasundhara, Ghaziabad-201012 E-mail: sabc_india@rediffmail.com		
Electrical Consultant:- ART CONSULTANTS M O B : +91-9910473339, 91-8820129963 E-MAIL : artconsultants@gmail.com artconsultants@rediffmail.com		
FIRE Consultant:- PKV CONSULTING PVT. LTD. C - 614, DDA LIG FLATS, EAST OF LONI, SHAHNURA, DELHI - 93 PH : +91-11-22810297 MAIL : Nroons@gmail.com		
TOWER-A (S+10)		
SHEET TITLE:- TYPICAL FLOOR PLUMBING PLAN		Drg. No AR-A-08/PL-08
SCALE= @A2 1:100		
DRAWN= D.P		
CHK=P.K.S		