


NOTES:

- BRICK MASONRY CIRCULAR TYPE MANHOLE 0.91 M INTERNAL DIA AT BOTTOM AND 0.56 M DIA AT TOP.
- 0.90 M DEEP WITH S.F.R.C. COVER AND FRAME (HEAVY DUTY, HD-20 GRADE DESIGNATION) 560 MM INTERNAL DIAMETER CONFORMING TO I.S. 12592, TOTAL WEIGHT OF COVER AND FRAME TO BE NOT LESS THAN 182 KG.


LEGEND:-

	HUME PIPE
	SOIL PIPE (SP)
	WASTE PIPE (WP)
	MANHOLE Ø900 (M.H.)
	CHAMBER (C.H) 600X600X600
	FLOW DIRECTION

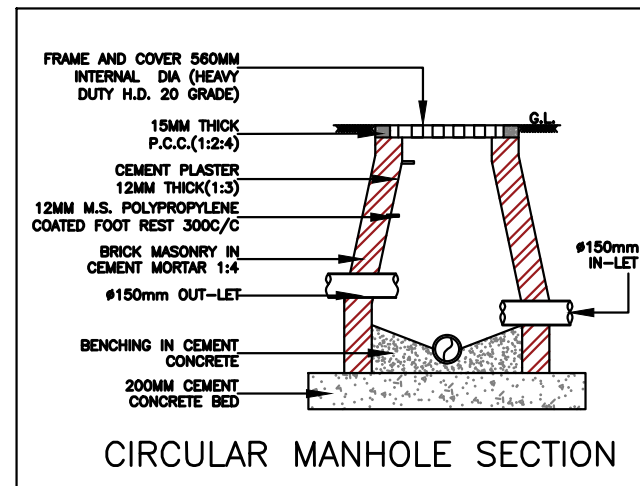

MANHOLE SCHEDULE

MANHOLE NUMBER.	MANHOLE INVERT LEVEL (MM)	MANHOLE SIZE (MM)	COVER (MM)
MH-1	-905	Ø900	Ø560
MH-2	-1000	Ø900	Ø560
MH-3	-1095	Ø900	Ø560
MH-4	-905	Ø900	Ø560
MH-5	-980	Ø900	Ø560
MH-6	-1164	Ø900	Ø560
MH-7	-1264	Ø900	Ø560
MH-8	-1339	Ø900	Ø560
MH-9	-1414	Ø900	Ø560
PIPE	-1454	Ø900	Ø560

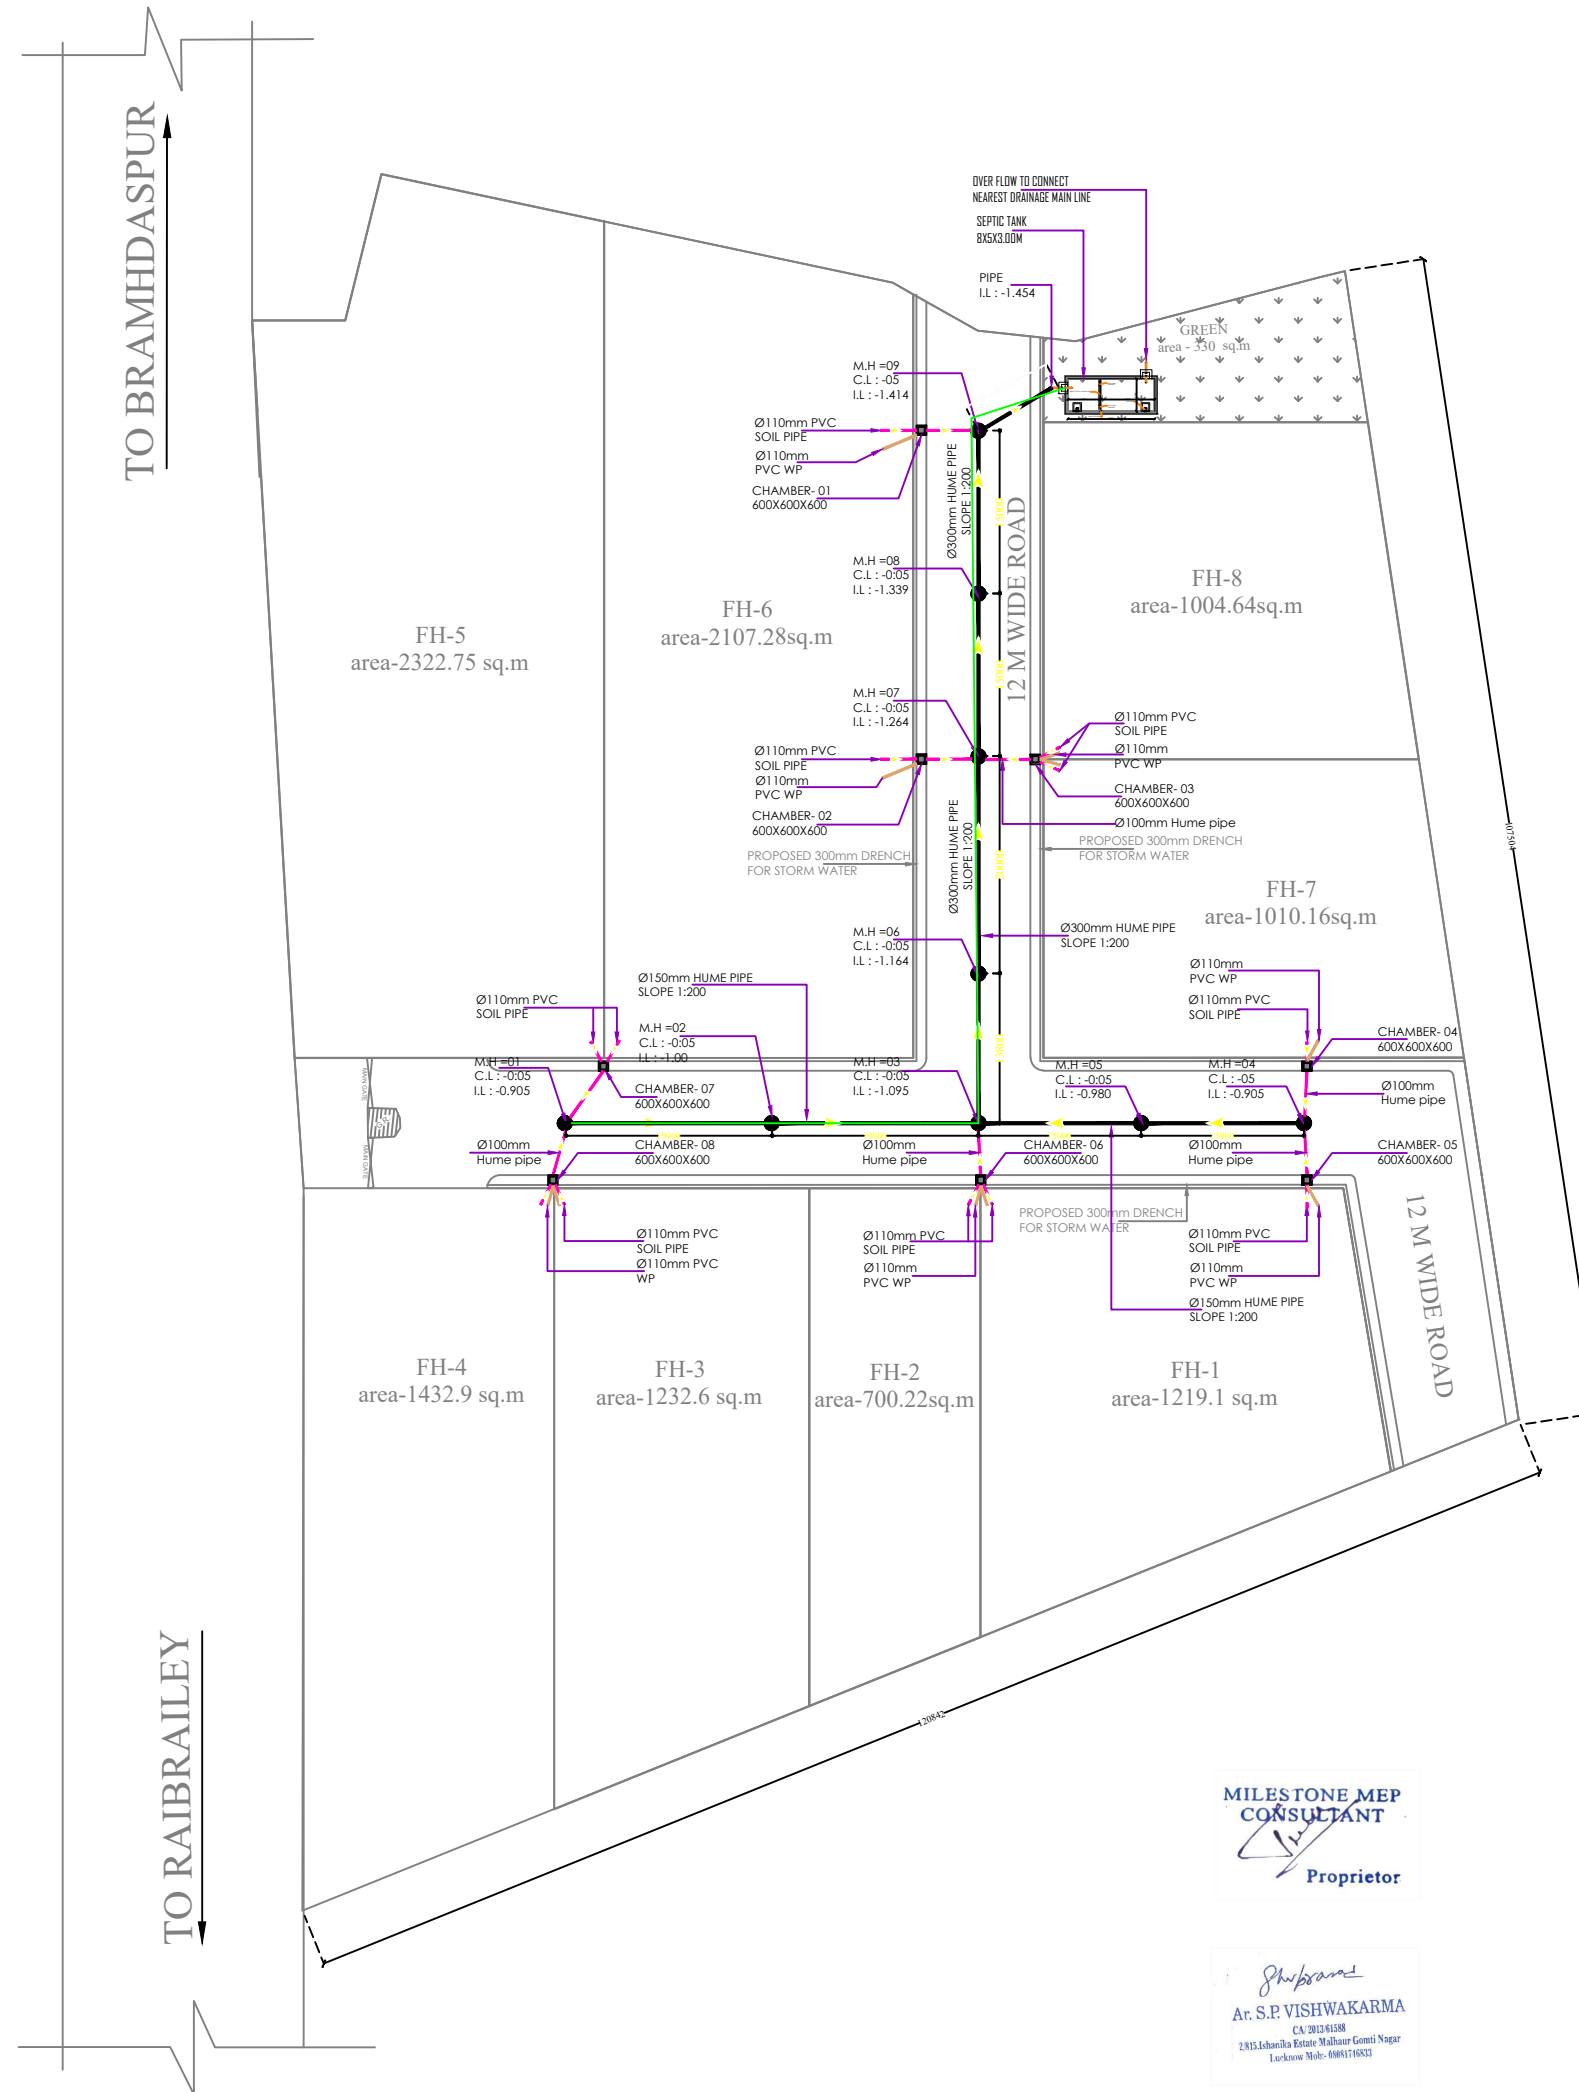

- NOTES:**
- ALL DIMENSIONS ARE IN FT.
 - NO DIMENSIONS TO BE SCALED OFF THE DRAWING. ONLY WRITTEN DIMENSIONS TO BE FOLLOWED.
 - DISCREPANCIES IN DIMENSIONS OR OTHERWISE SHOULD BE BROUGHT TO THE NOTICE OF CONSULTANT BEFORE STARTING THE WORK.
 - ANY DISCREPANCY FOUND IN THE DRAWING TO BE IMMEDIATELY GOT CLARIFIED WITH THE ARCHITECT.
 - ALL DRAWINGS ARE INTER RELATED AND SHALL BE READ IN CONJUNCTION WITH OTHER DRAWINGS.

GENRE-	NORTH
	FOR DISCUSSION
	FOR STRUCTURE
	FOR EXECUTION

PROJECT
FARM HOUSE LAYOUT AT MOHANLAL GANJ, LUCKNOW

CLIENT
JMD GREEN

DRAWING TITLE
DRAINAGE LAYOUT

DRAWING NO.

REVISION NO.	DATE OF ISSUE.
R-1	11/DEC/2025

EXECUTING AGENCY

SCALE- NTS	SHEET SIZE- A3
DRAWN BY- KAMRAN	CHECKED BY- ER. TARIQ

Milestone MEP Consultant
D2-3D, Vibhuti khand, Gomti Nagar, Lucknow, U.P.
Web: milestonemep.com
Email: milestonemep1@gmail.com
Ph: +91-9035506164

MILESTONE MEP CONSULTANT
Proprietor

Shubram
Ar. S.P. VISHWAKARMA
CA/2013/1188
2815 Lakshika Estate, Malhar Gomti Nagar
Lucknow. Mob: 9885116533

MARCHMANIA
Architects, Interior Designer & Landscaping
2/815, esanika state (near armita university), Gate No-03, malhar gomti nagar
Lucknow, (UP)
Email: arshiv1989@gmail.com
Mob: 08081746833