

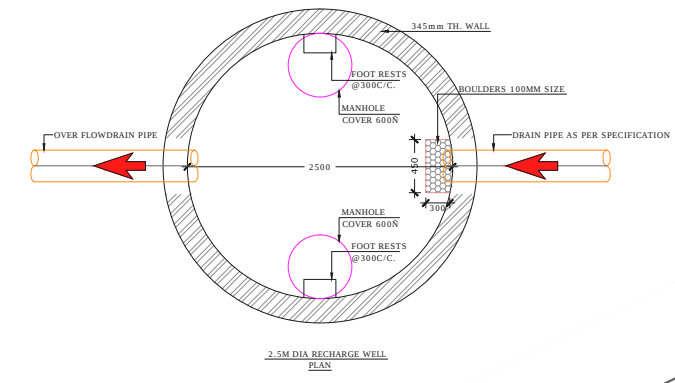


| SCHEDULE OF PIPES |                                         |
|-------------------|-----------------------------------------|
| PIPE NO.          | DESCRIPTION                             |
| 1                 | 110 OD uPVC SOIL PIPE                   |
| 2                 | 110 OD uPVC WASTE PIPE                  |
| 3                 | 90 OD uPVC ANTI-SYPHONIC PIPE           |
| 4                 | WATER SUPPLY D/N TAKE PIPE              |
| 5                 | 90 OD uPVC RAIN WATER PIPE FOR BALCONY  |
| 6                 | 110 OD uPVC RAIN WATER PIPE FOR TERRACE |
| 7                 | WATER SUPPLY RISER                      |

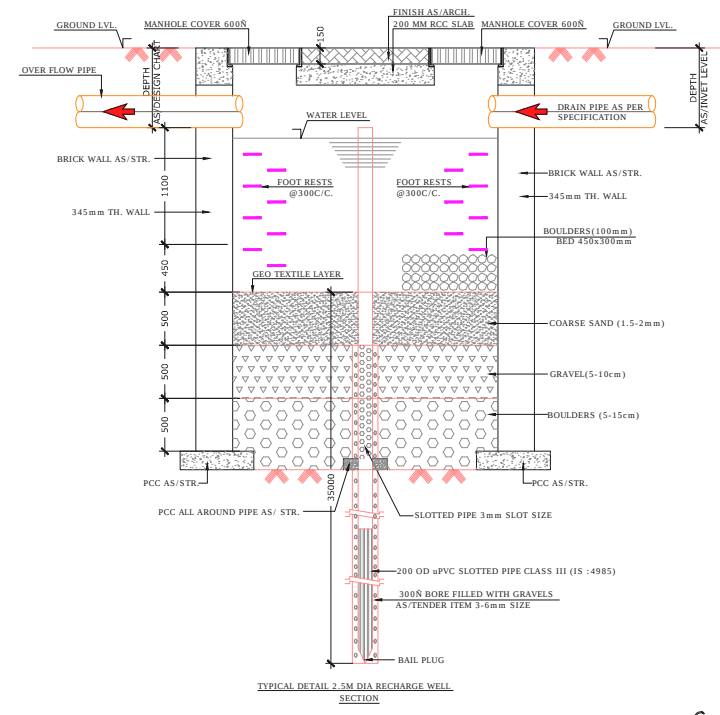

OPEN MECHANICAL  
(FROM M-01 TO M-04)

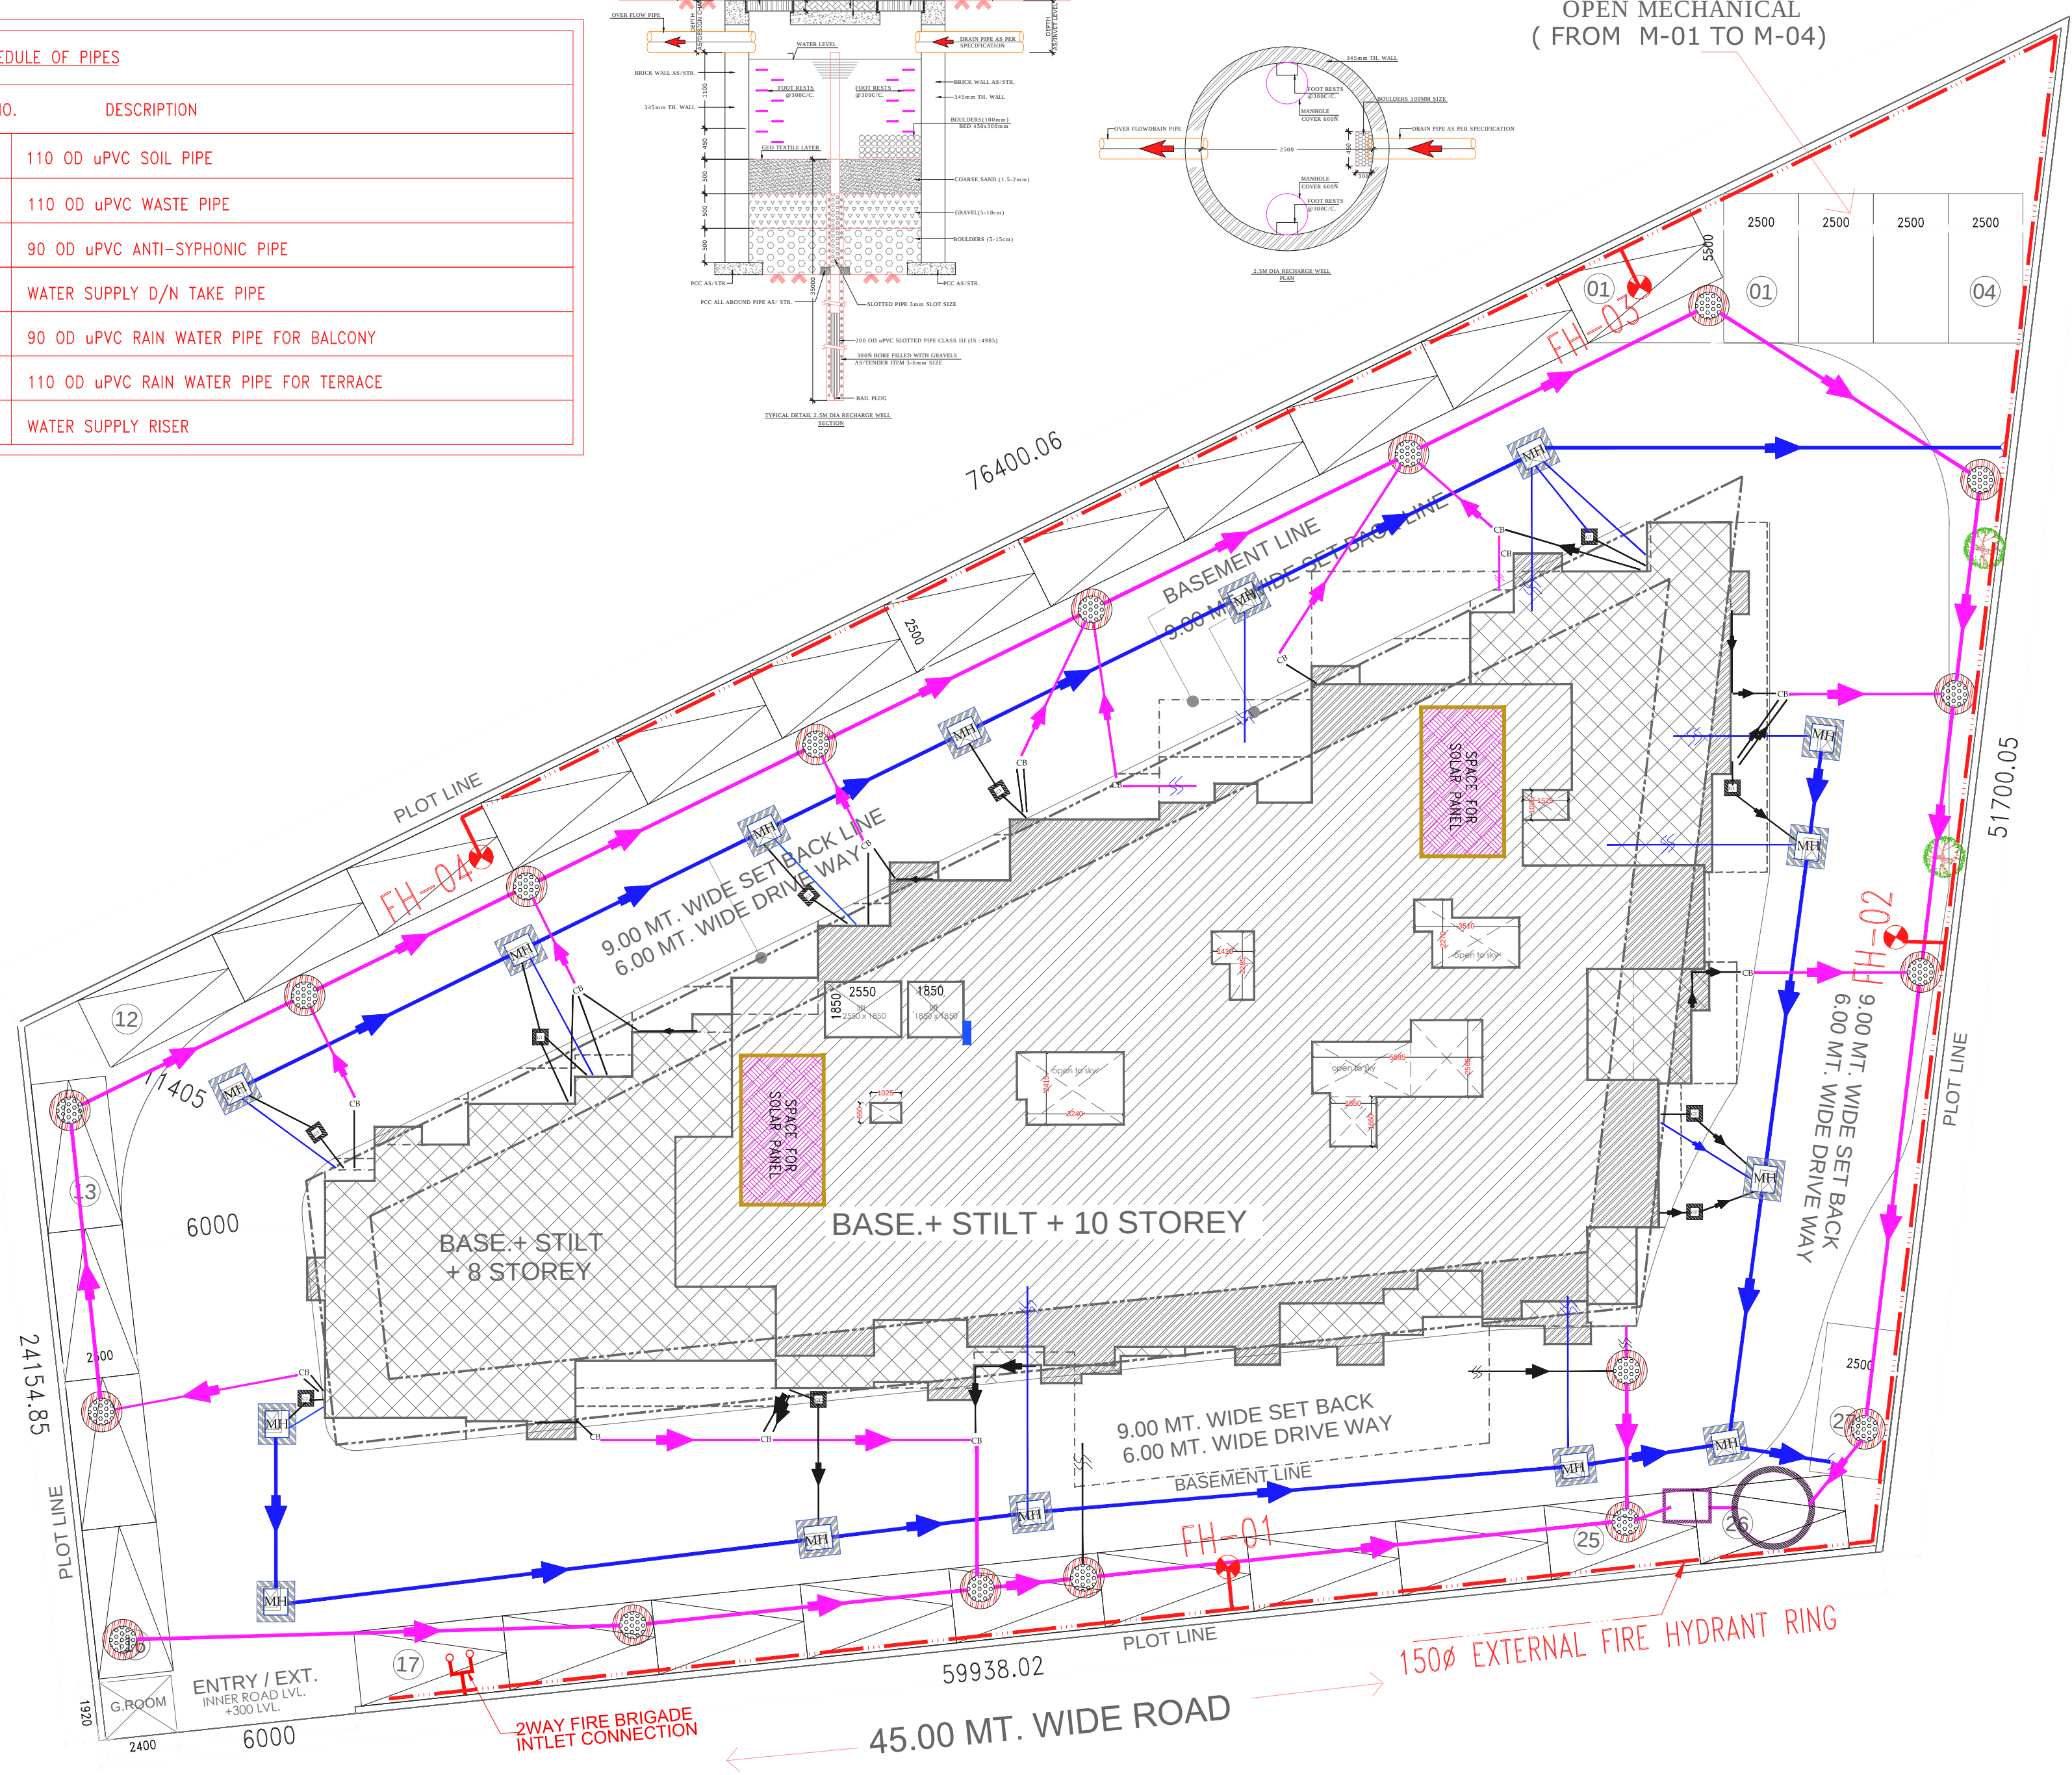

| LEGEND |                             |
|--------|-----------------------------|
| SYMBOL | DESCRIPTION                 |
|        | EXTERNAL STORM LINE         |
|        | EXTERNAL SEWER LINE         |
|        | EXTERNAL FIRE HYDRANT RING  |
|        | EXTERNAL SEWER LINE MANHOLE |
|        | EXTERNAL STORM LINE MANHOLE |
|        | FIRE HYDRANT (80mm TO FH)   |

| PLUMBING LEGEND:- |                       |
|-------------------|-----------------------|
|                   | RAIN WATER HARVESTING |
|                   | SPACE FOR SOLAR PANEL |

PROJECT:  
DRAWING FOR THE GROUP  
HOUSING AT PLOT NO. GH - 08 AHINSA  
KHAND INDIRAPURAM GHAZIABAD (U.P.)

OWNER:  
M/s. VISHAL PRODUCTS PVT. LTD.  
DIRECTOR- PAWAN AGGARWAL

DRAWING TITLE:  
**SERVICES PLAN**  
(SEWERAGE, DRAINAGE, SOLAR, RAIN WATER  
HARVESTING,  
FIRE & WATER SUPPLY)

OWNER'S SIGN

ARCHITECT'S SIGN

architects. engineers. landscape & interior designers  
ANUJ AGARWAL ARCHITECTS P. LTD.  
A-244 KAUSHAMBI GHAZIABAD (U.P.)  
Ph: +91 120 6454184 , 6454182  
e-mail : arch.anujagarwal@gmail.com

SCALE  
DESIGN BY

DEALT BY  
CHECKED BY

DATE  
DRG. No.  
DG-02