


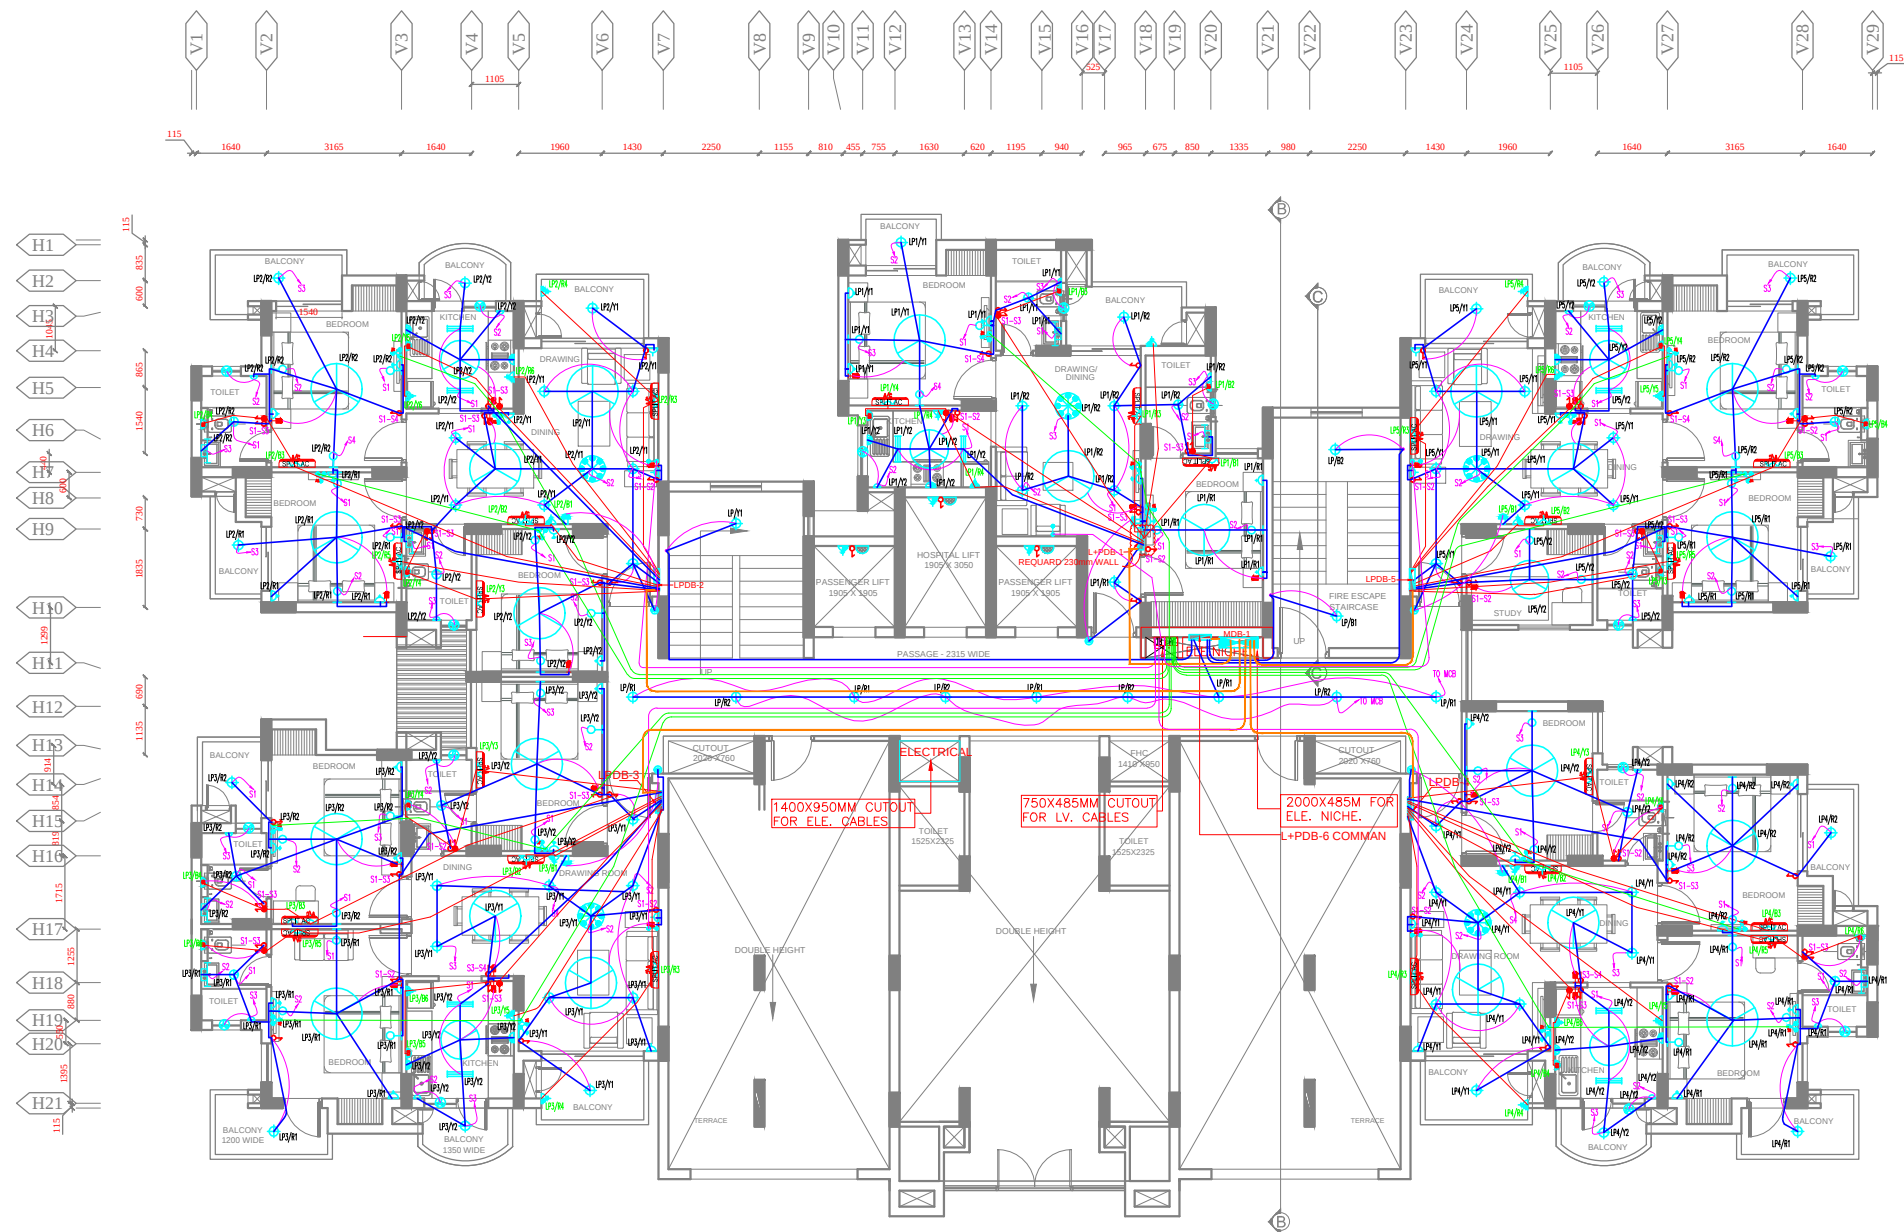

UNIT - 2B+2T(TYPE-2)

UNIT - 2B+2T(TYPE-2)

NOTES	
SL	SPECIFICATION
1	DRAWING AND DIMENSIONS ARE ONLY TO BE READ AND NOT SCALED.
2	UNLESS OTHERWISE MENTIONED, ALL DIMENSIONS ARE GIVEN IN MILLIMETERS.
3	THIS DRAWING SHALL BE READ IN CONJUNCTION WITH RELEVANT ARCHITECTURAL, STRUCTURAL, AND SERVICES DRAWINGS.
4	ALL LEVELS GIVEN IN DRAWING ARE WITH REFERENCE TO THE N.G.L. AS BENCHMARKED AT SITE.
5	ANY DISCREPANCY BETWEEN THE ARCHITECTURAL/STRUCTURAL OR SERVICES DRAWINGS MUST BE BROUGHT TO THE ATTENTION OF THE ARCHITECT BY THE CONTRACTOR OR PROJECT MANAGER, BEFORE EXECUTION OF THE SAME.

	NAME	PHONE. NO.

SYMBOL	DESCRIPTION	HEIGHT
	SWITCH FOR GEYSER	1050 MM
	ONE WAY SWITCH	1050 MM
	FAN REGULATOR	1050 MM
	2nos. 6A SOCKET CONTROLLED BY 1 Nos. SWITCH (FOR T.V)	300 F.F.L.
	WATER PURIFIER	AS/PER SITE
	6A SWITCH SOCKET OUTLET(FOR CHIMNEY)	1450 MM
	6A PLUG POINT	300 F.F.L.
	6/16A POWER POINT	300 F.F.L.
	25AMP SWITCH SOCKET FOR AC	300 F.F.L.
	16A SWITCH SOCKET (KITCHEN GEYSER)	1500 F.F.L.
	16A SWITCH SOCKET (TOILET GEYSER)	1500 F.F.L.
	6A PLUG POINT (BED SIDE)	300 F.F.L.
	6A, SOCKET FOR EXHAUST FAN	AS/DWG
	6/16A SOCKET WITH SWITCH FOR FRIDGE	300 F.F.L.
	EXHAUST FAN	AS/PER SITE
	TELEPHONE (BED SIDE)	300 F.F.L.
	FINAL DISTRIBUTION BOARD	1500 MM
	CALL BELL BUZZER	2250 MM
	DOOR CALL BELL SWITCH	1050 MM
	1X22W LED LIGHT	2100 MM
	BULKHEAD LIGHT FOR LIFT	
	TV OUTLET	600 F.F.L.
	1200mm DIA CEILING FAN	CEILING
	1X11W LED LIGHT	CEILING
	1X14W LED LIGHT	CEILING
	1X36W LED LIGHT	CEILING
	CHANDLER LIGHT	CEILING
	MIRROR LIGHT	ABOVE MIRROR
	25mm DIA LIGHT CONDUIT	
	25mm DIA POWER CONDUIT	
	25mm DIA TV CONDUIT	
	25mm DIA TELEPHONE CONDUIT	
	32mm DIA SUB MAIN CONDUIT	

REV.NO.	REVISION
	PURPOSE OF DRAWING
G.F.C	F.I.O
	TENDER

CLIENT :-
M/S SHRI LAXMI ARCHCON PVT.LTD
NEW DELHI

PROJECT :-
GROUP HOUSING AT
2B/INS-6,
VASUNDHARA,GAZIABAD (U.P.)
AS
SHRI LAXMI CELEBRATION
RESIDENCY

SHEET TITLE
GROUND ELECTRICAL FLOOR PLAN

DRG. NO.
AR-04

DATE - 25/06/2016	REV. NO	NORTH
SCALE - 1/8"=1'-0"		
PREPARED BY -		
CHECKED BY - CMS		
QUALITY CELL -		
ARCHITECTS -		

DESIGN CHAIN
E-83 BASEMENT,
EAST OF KAILASH, NEW DELHI - 65