


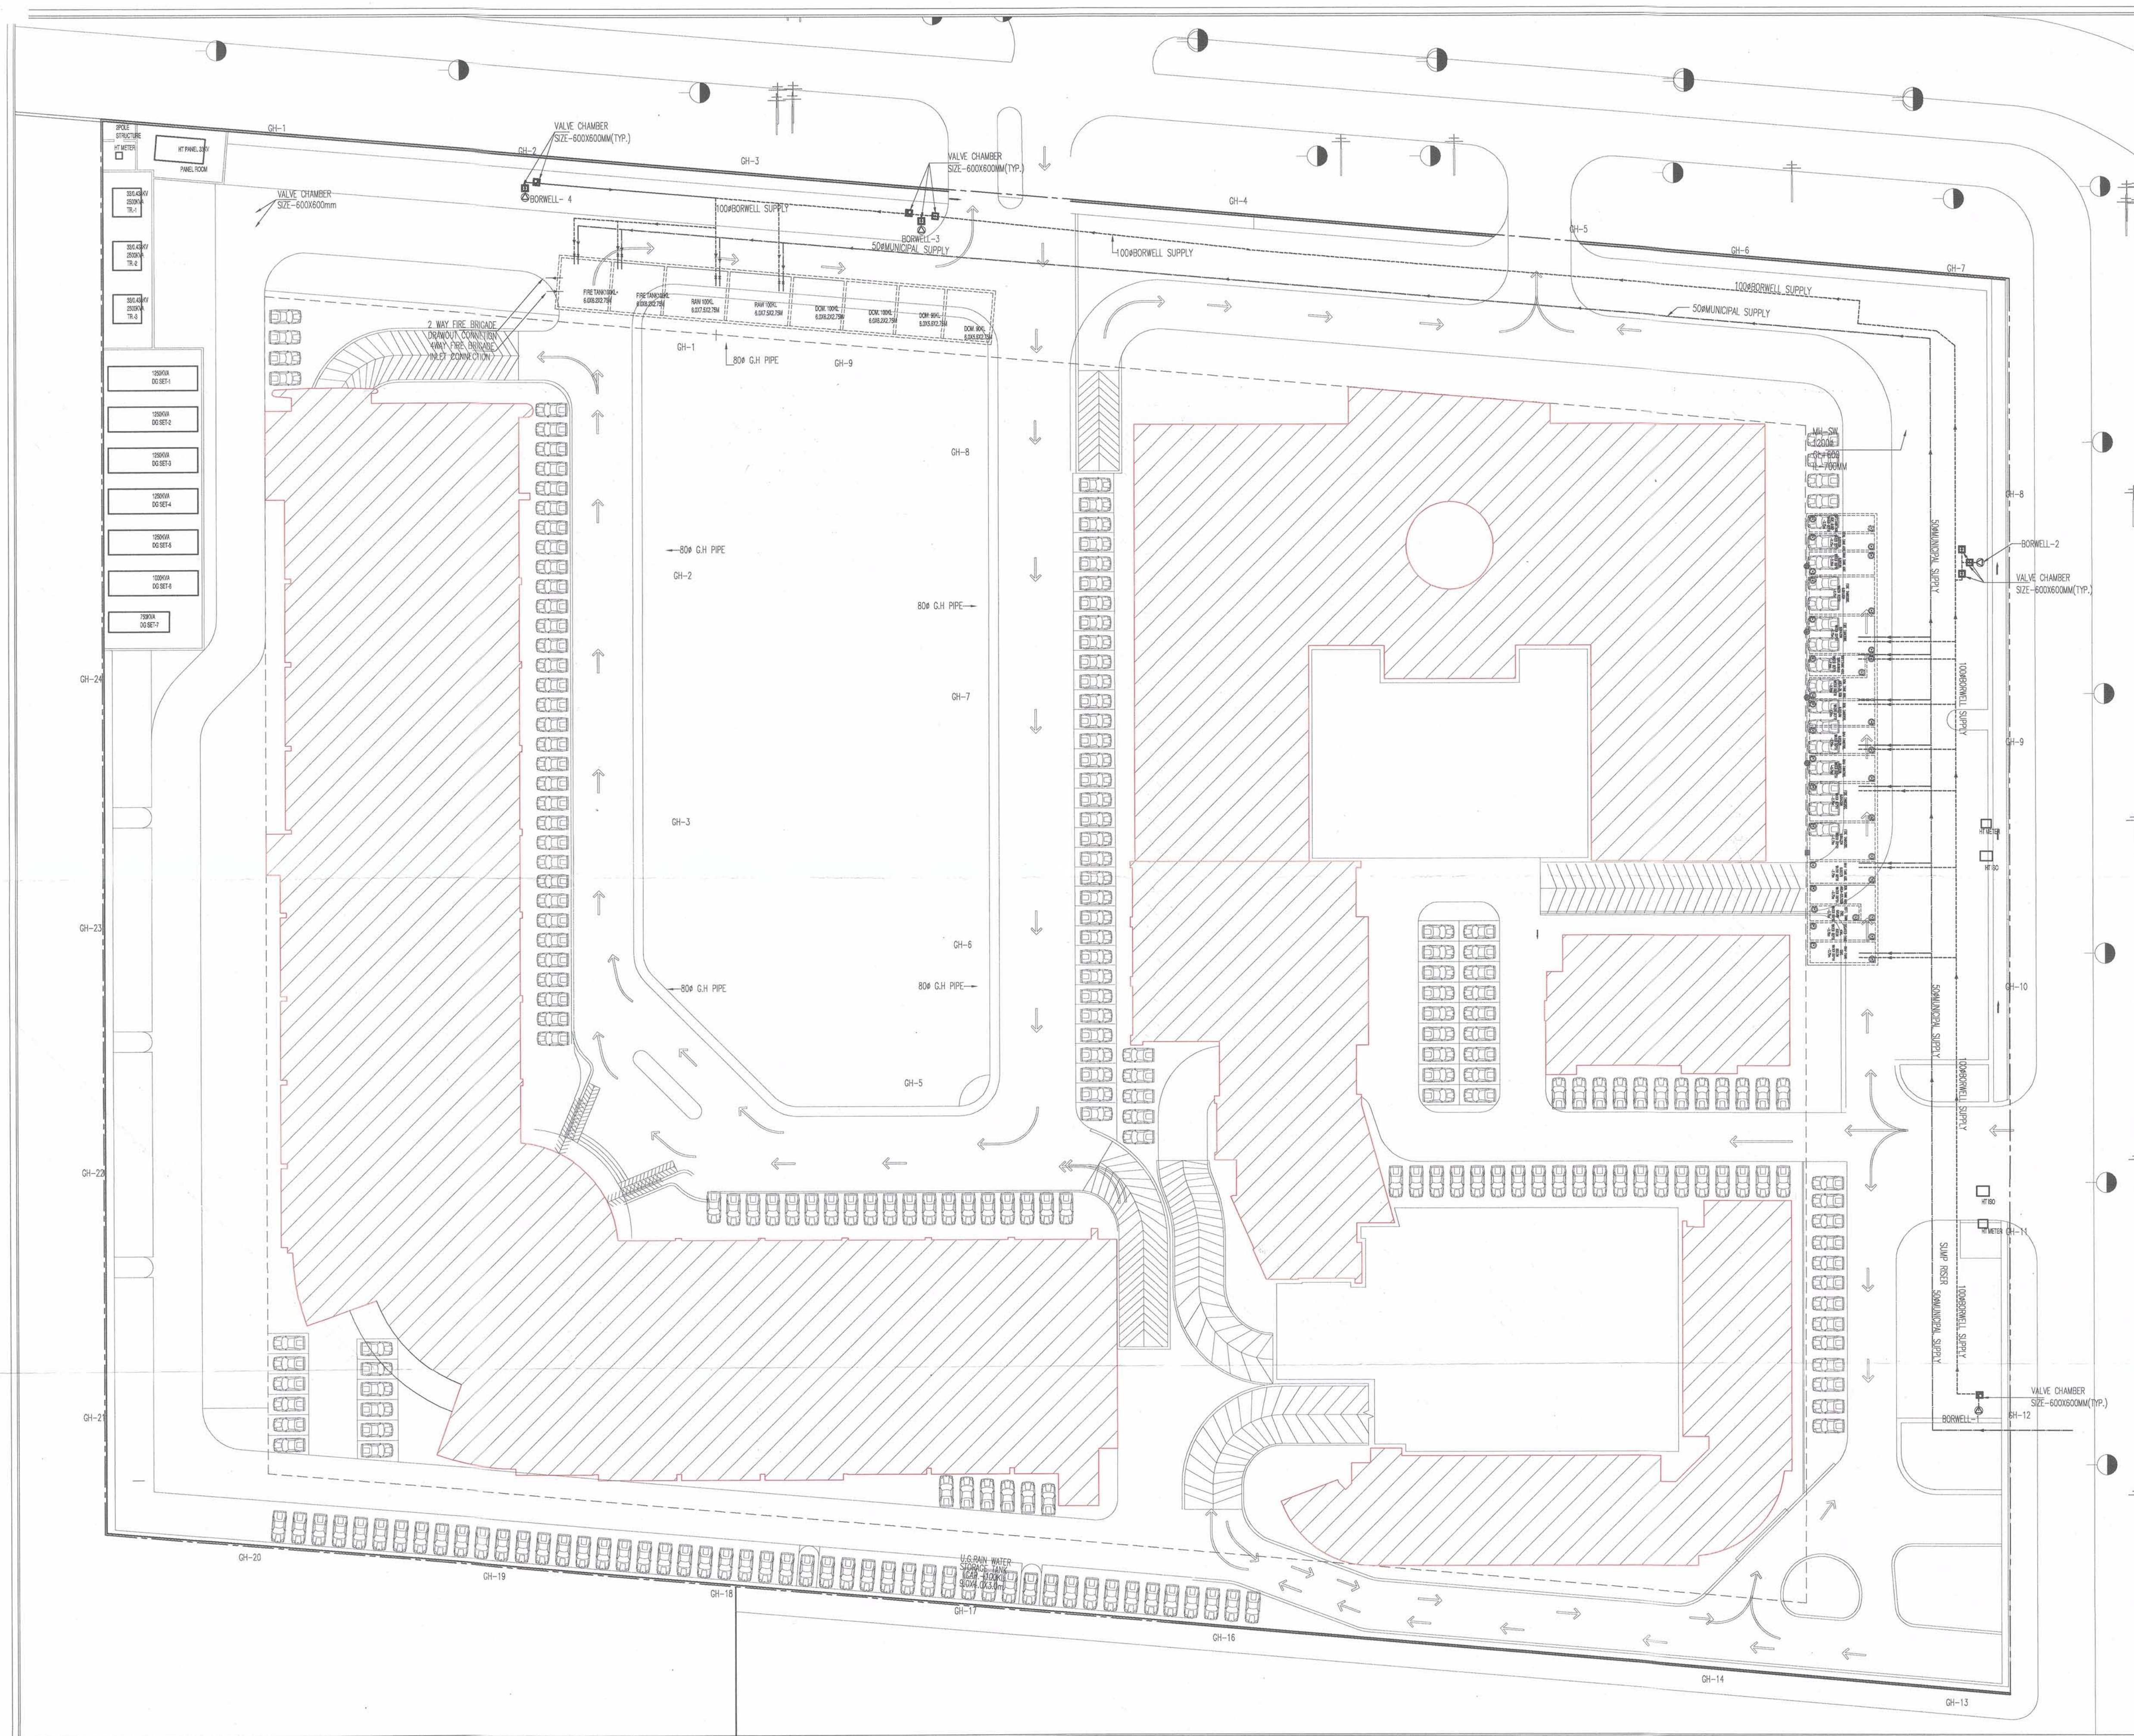

Greater Noida Industrial Dev. Authority

APPROVED

1908-2013-2017

20-08-2013

Vide Letter No. 2013-2017 Dated 20-08-2013

Valid upto Date FIVE YEARS

G.M.
(Planning)

Schwabe
Kumar

 Dr. *Gen. Menasari*
(Planning)

 Verified By *SE (Planning)*

Drawing Checked *SE (Planning)*

EXTERN

Manager *R.V.MH/RAIN*

LEGEND	
	Dr. Sew. Manhole (Planning)
	EXTERNAL FIRE HYDRANT
	(R.W.MH) RAIN WATER MANHOLE
	(M.M.H) SEWER MANHOLE
	(C.B) CATCH BASIN (450X450MM)
	(RCC PIPE)
	uPVC PIPE
	50ø MUNICIPAL SUPPLY
	4 WAY FIRE BRIGADE INLET CONNECTION
	2 WAY FIRE BRIGADE DRAWDOUT CONNECTION
	(G.T) 350X350MM
	GARDEN HYDRANT

LEGEND	
	WATER PIPE
	DRAIN PIPE
	SEWER PIPE

SUBMISSION DRAWING

[illegible]

SHASHANK SHARMA
BARCH
C.O.A. Regn. No. CA/97/22034

Consultants:-

 **SPC Engineers Pvt. Ltd.**
Design Consultancy & Project Management
79, Samrat Enclave, Delhi-110034
Tel.-91-011-2710 6705,-2719 5456,-2719 5457,-Fax.- 91-011-27152522
E-Mail: spca@vsnl.com, website : www.spcdelhi.org

Architects:-

4TH DIMENSION
ARCHITECTURE INTERIORS PLANNING
<http://www.4d-arch.com>

C-17, Basement, ANAND NIKETAN,
New Delhi - 110 021 India
PHONES : +91.11.41661137 +91.9810861137
FAX : +91.11.42705425 E MAIL : mail@4d-arch.com

Project PROPOSED PLAN OF I.T PARK FOR,
M/s ZESTHA PROJECTS (P) LTD.
ON PLOT NO. 26/1, SECTOR K.P.-III,
GREATER NOIDA, U.P.

Drawing Title			
PLUMBING DRAWING			
WATER SUPPLY SITE PLAN			
BARCH			
C/7722034			
Dated :	08/05/09	Drawn :	UMESH
Dwg No	PL/SITE PLAN-01	Checked :	Amit Joughary
Rev	04	Approved :	Amit Joughary
Sheet size	600x900	Scale	1:375

THIS DRAWING IS THE PROPERTY OF S.P.C. ENGINEERS Pvt. Ltd.
AND MAY NOT BE COPIED OR USED FOR ANY OTHER PURPOSE
OTHER THAN, FOR WHICH IT IS ISSUED.