
 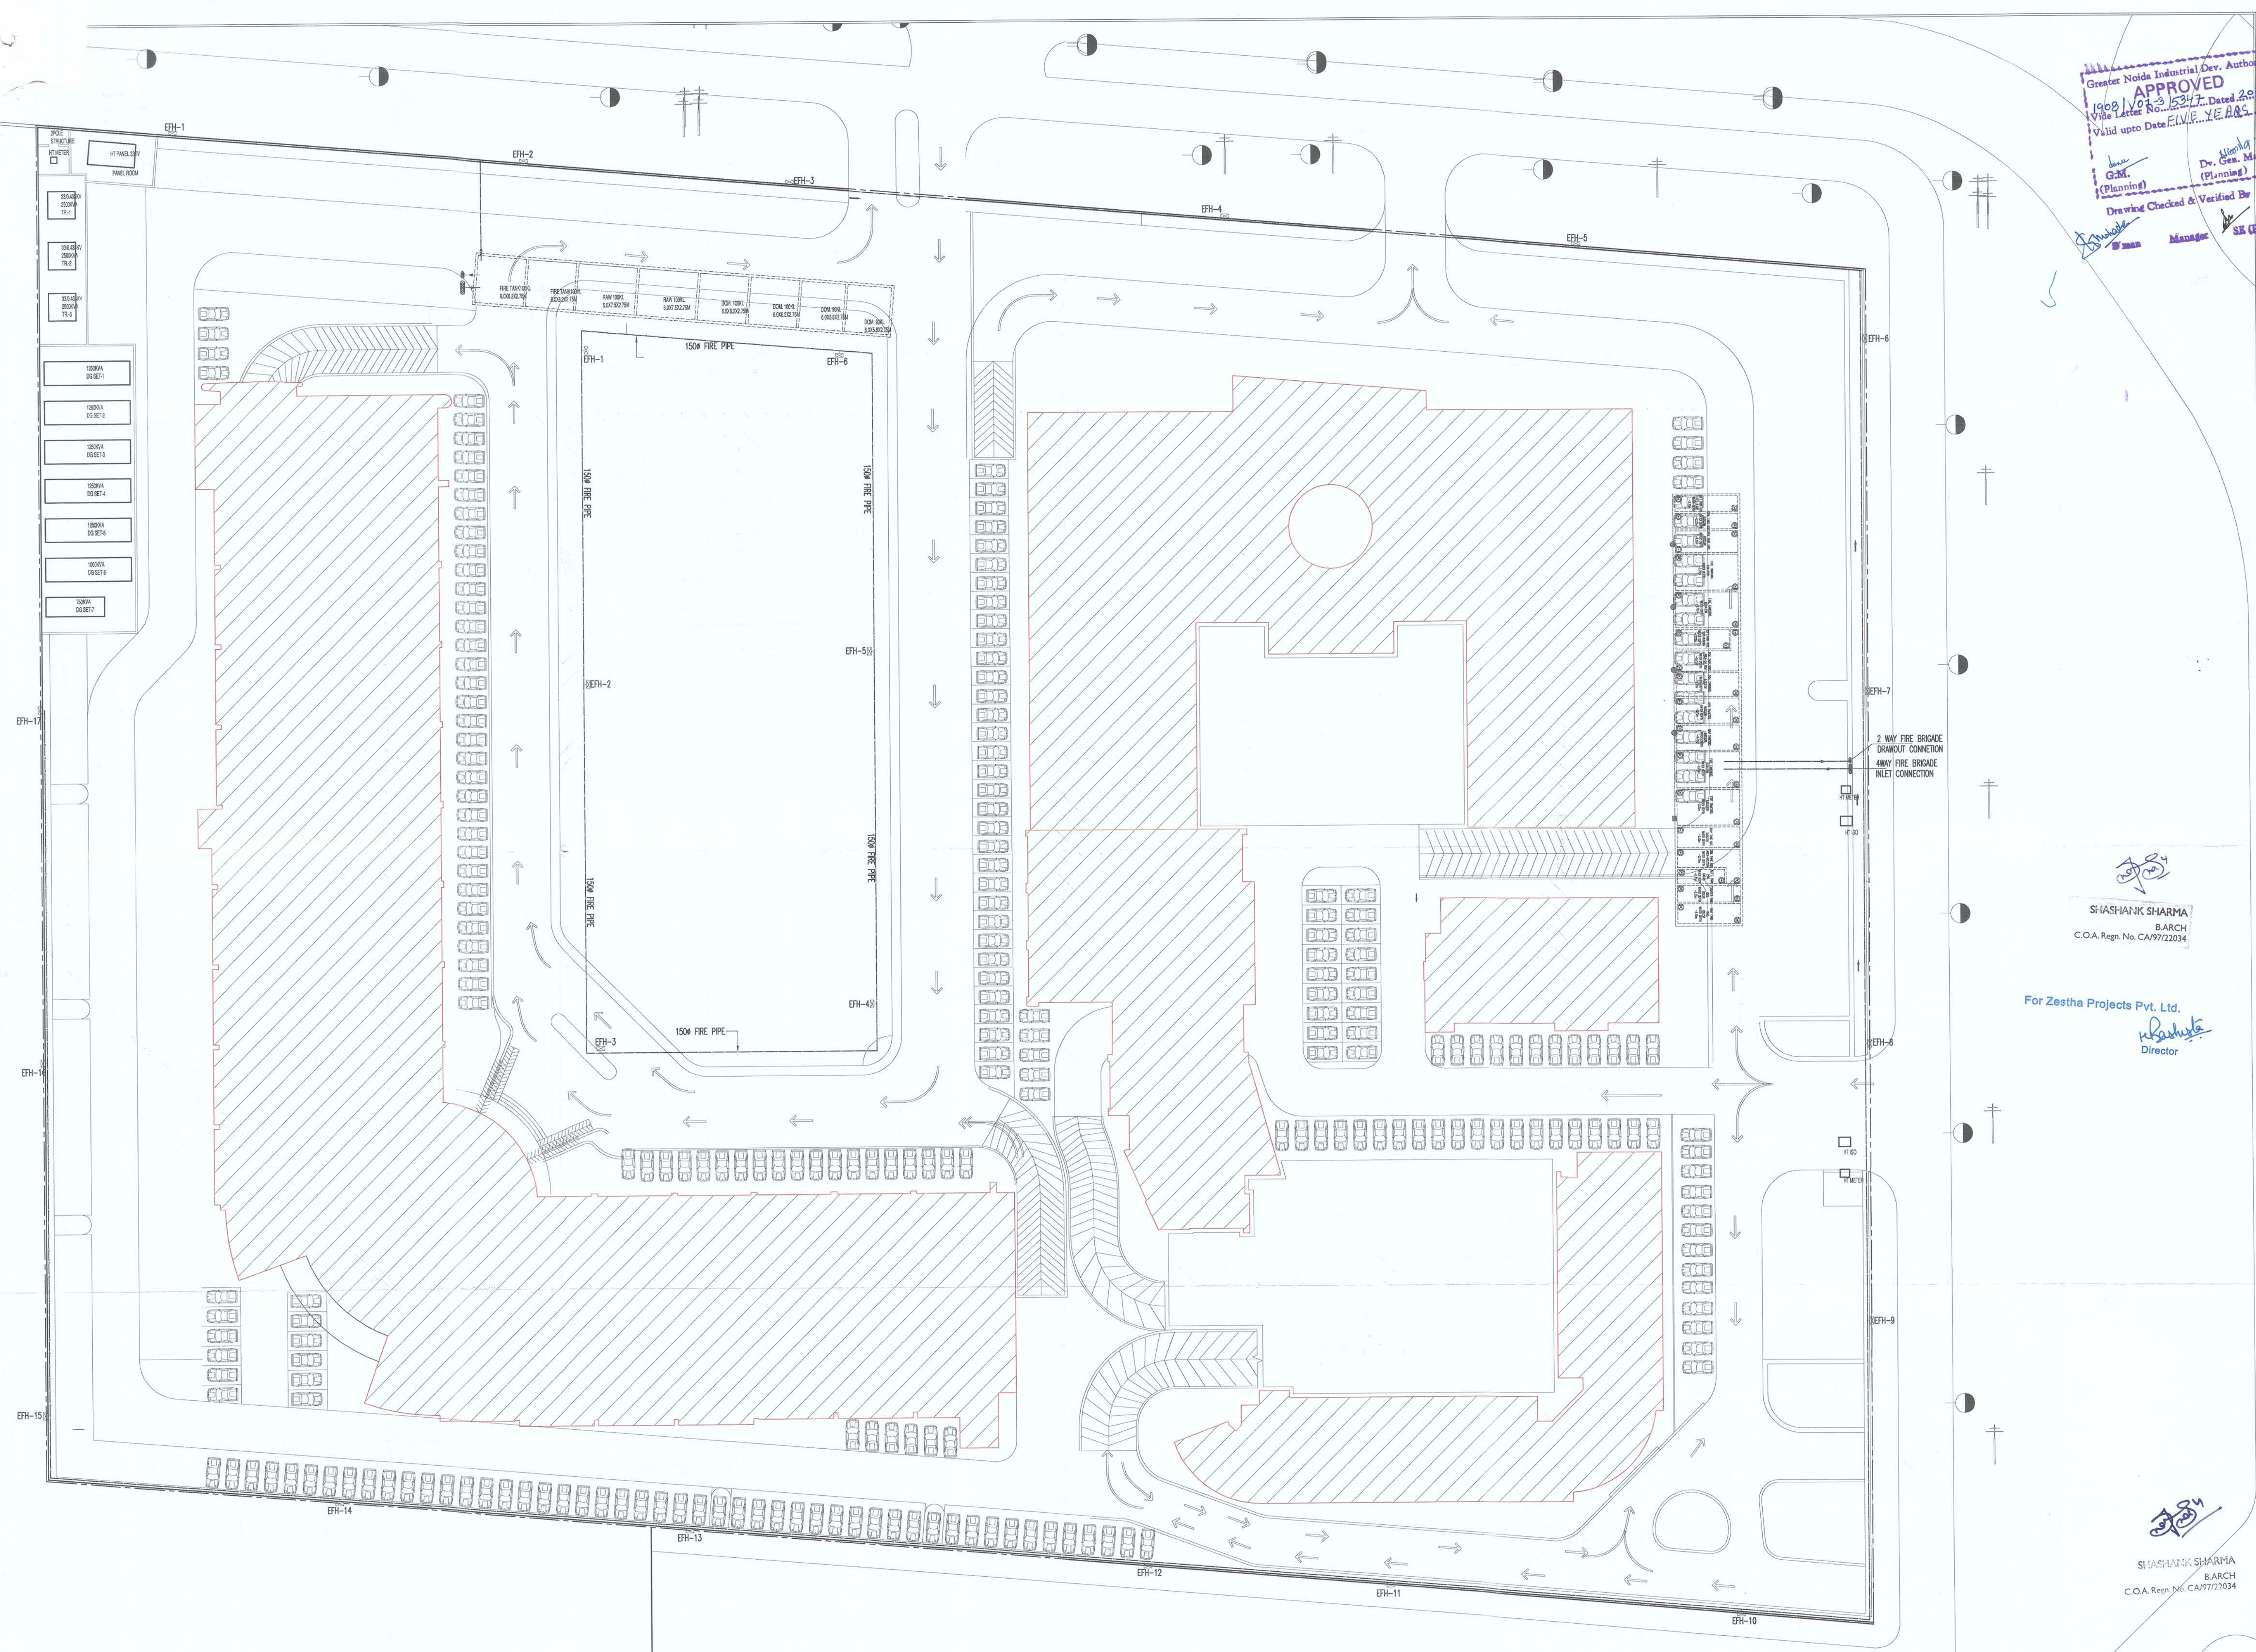
 




Greater Noida Industrial Dev. Authority
APPROVED
 1908 VOT-3 15417. Dated 22-08-17
 Valid upto Date **FIVE YEARS**
 Issued by
G.M.
 (Planning)
 Dr. Gen. Manager
 (Planning)
 Drawing Checked & Verified By
S. Shrivastava *Man* *Manager* *SE (Planning)*

	<u>LEGEND</u>
	BOREWELL
	(E.F.H) EXTERNAL FIRE HYDENT
	(R.W.MH)RAIN WATER MANHOL
	(M.H) SEWER MANHOLE
	(C.B) CATCH BASIN (450X450MM)
	(RCC PIPE)
	uPVC PIPE
	50ø MUNICIPAL SUPPLY
	4 WAY FIRE BRIGADE INLET CONNECTION
	2 WAY FIRE BRIGADE DRAWOUT CONNECTION
	(G.T) 350X350MM
	GARDEN HYDRANT

LEGEND	
	WATER PIPE
	DRAIN PIPE
	SEWER PIPE

SUBMISSION DRAWING

[illegible]

Consultants:-

 **SPC Engineers Pvt. Ltd**
Design Consultancy & Project Management
79, Samrat Enclave, Delhi-110034
Tel.-91-011-2710 6705, 2719 5456, 2719 5457, Fax- 91-011-27152522
E-Mail: spca@vsnl.com, website : www.spcdelhi.org

Architects:-

4TH DIMENSION
ARCHITECTURE INTERIORS PLANNING
<http://www.4d-arch.com>

C-17, Basement, ANAND NIKETAN,
New Delhi - 110 021 India
PHONES : +91.11.41661137 +91.9810861137
FAX: +91.11.42705425 E MAIL: mail@4d-arch.com

Project PROPOSED PLAN OF I.T PARK FOR,
M/s ZESTHA PROJECTS (P) LTD.
ON PLOT NO. 26/1, SECTOR K.P.-III,
GREATER NOIDA, U.P.

Drawing Title	Plumbing Drawing EXTERNAL FIRE HYDRANT SITE PLAN
---------------	---

Dated : 08/05/09	Drawn : UMESH
Dwg No PL/SITE PLAN-01	Checked : Amit Jough
Rev : 04	Approved : Amit Jough
Sheet size 600x900	Scale 1:375

THIS DRAWING IS THE PROPERTY OF S.P.C. ENGINEERS Pvt. Ltd.
AND MAY NOT BE COPIED OR USED FOR ANY OTHER PURPOSE
OTHER THAN, FOR WHICH IT IS ISSUED.