

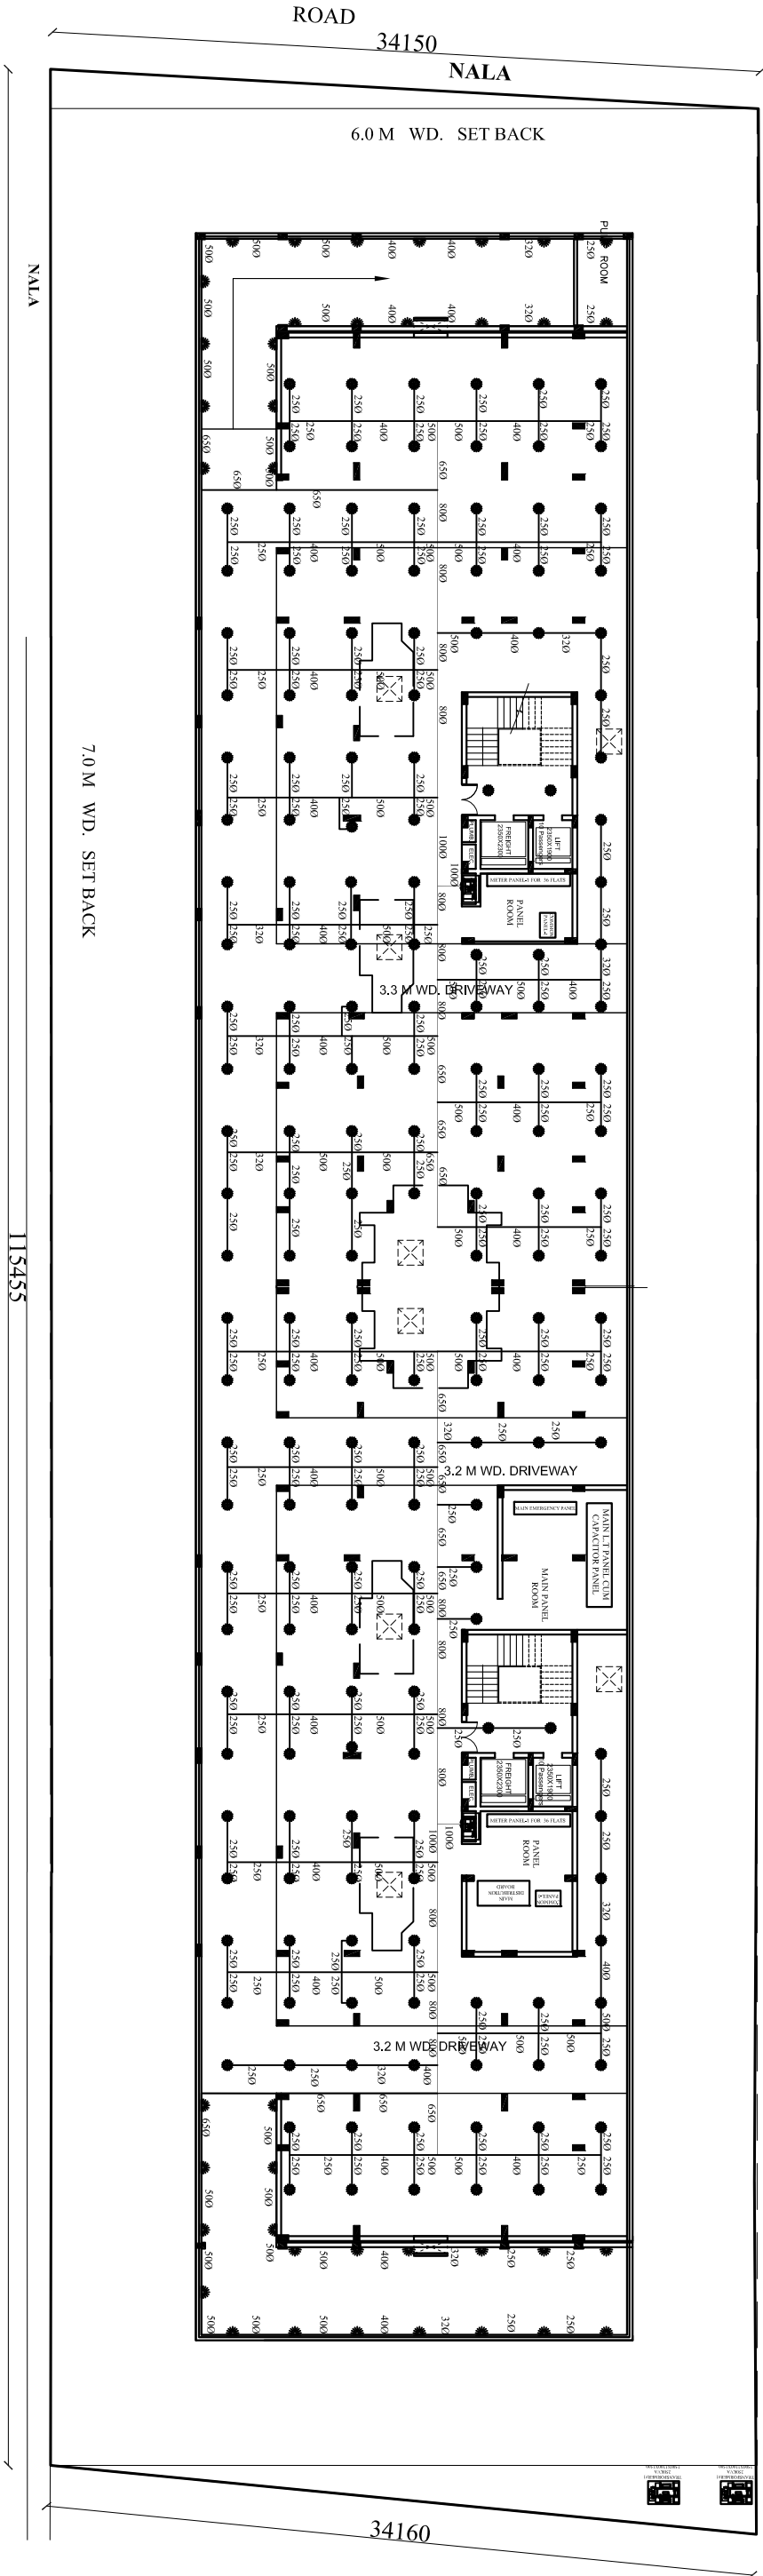


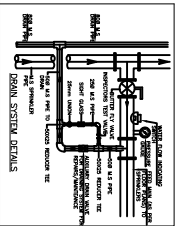

BASEMENT SPRINKLER LAYOUT PLAN

- NOTES:-
1. Fire protection system shall be ERW heavy grade piping as per IS:1239 Part-I/S: 3589
 2. Alarm valve shall be located near vertical sprinkler Riser at ground floor level.
 3. Minor changes shall be done as per site condition.
 4. Butterfly valve, flows with & 50NM drain valve shall be located in all branches (At every floor) from sprinkler riser.
 5. How Switch from indivisual branches at every floor (Near fire duct) shall be connected to the sprinkler annunciation located at ground floor.
 6. All exposed pipelines and fittings should be painted with one coat of Red Oxide primer and 2 coats of Synthetic red enamel painted of fire red in colour.

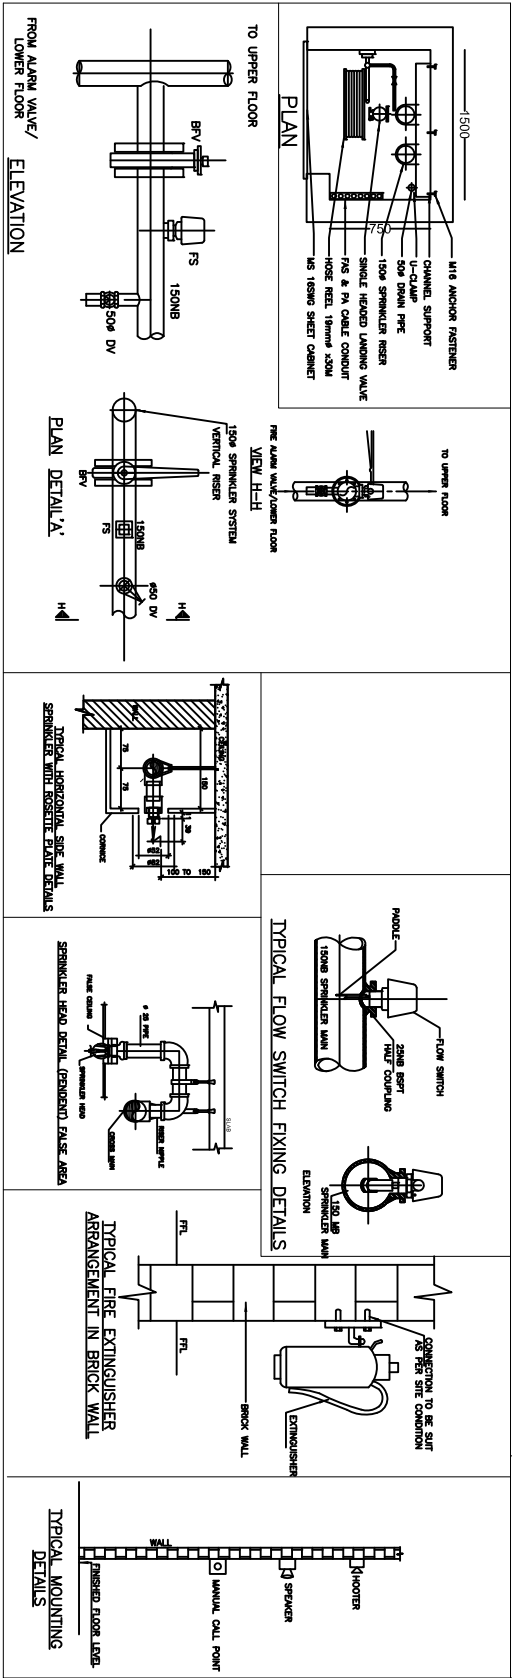

PROPOSED GROUP HOUSING AT PLOT NO. C1, SECTOR O, MANSAROVAR YOJNA, KANPUR ROAD, LDA, LUCKNOW		BUILDING MAP CONSULTANT: TRIVENI CONSULTING ENGINEERS FLAT-D, AVON RESIDENCY, A1/8, SECTOR-H, ALGANI, LUCKNOW. EMAIL: triveniconsultantslko@gmail.com MO: 09794931199	
OWNER	ARCHITECT	ORIENTATION	
m u r a l a g e architects , interior decorators & muralists B-1/29 , sector - a , aliganj , lucknow phone no. : 2321590, 2320715		Ira-sunil namit Ref No - L-79(AE-979(1)) Date - DEC'16 Drawn By- MOHIT JAISWAL	
Sheet No - 16		SERVICES DRAWING BASEMENT SPRINKLER LAYOUT PLAN SCALE - 1:200	