


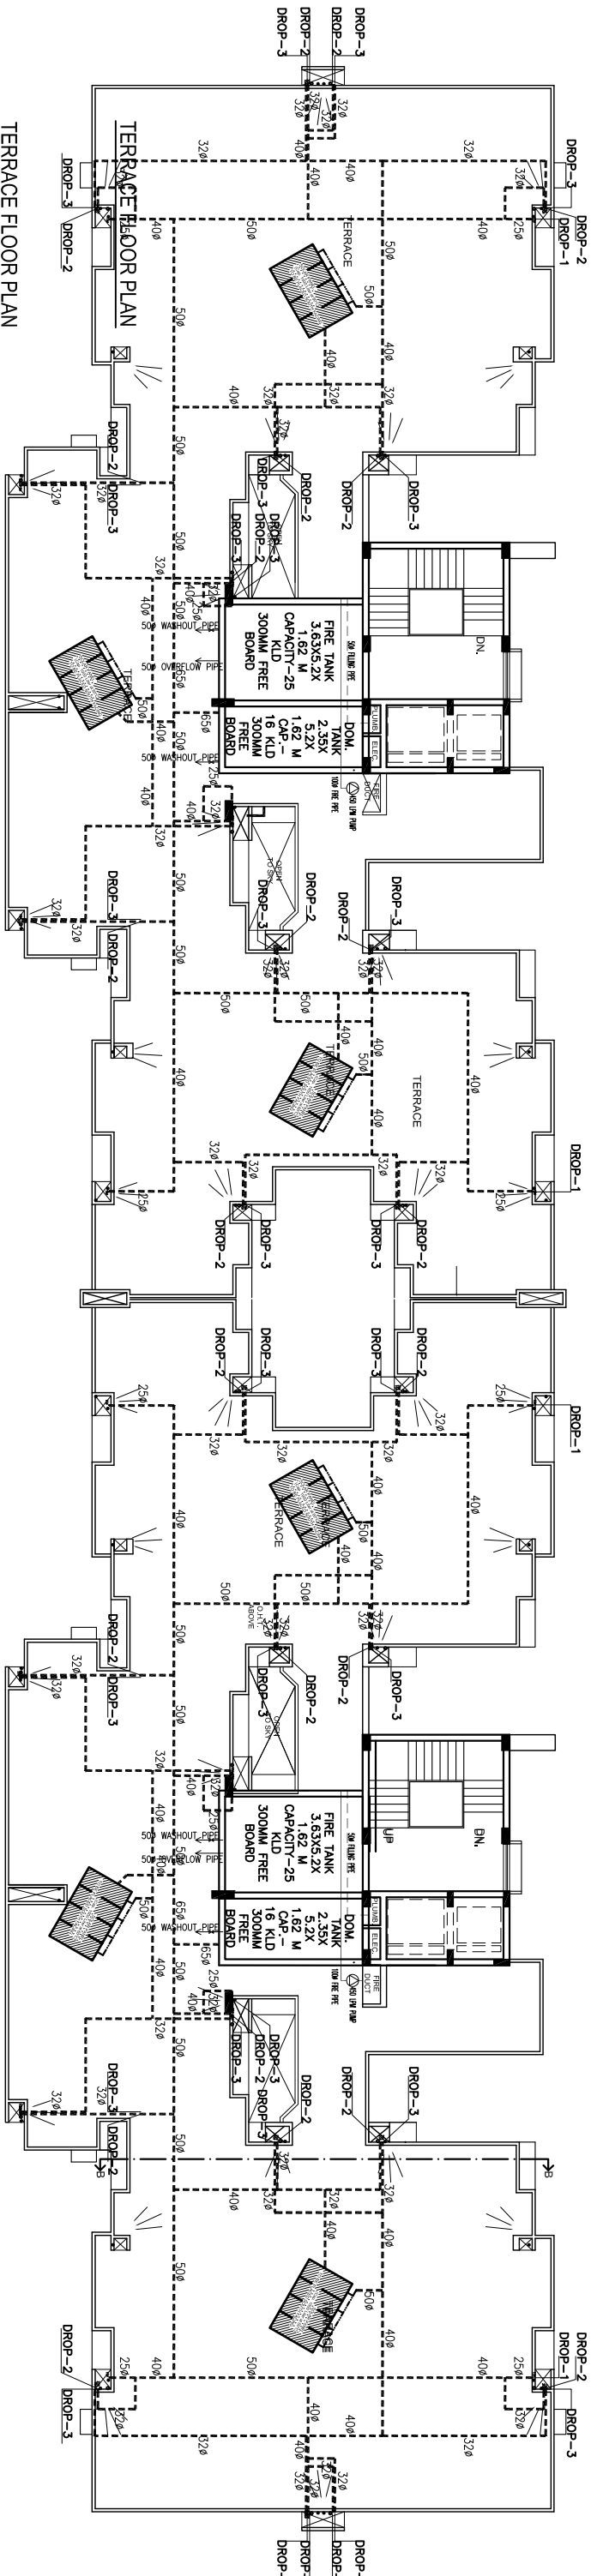

TERRACE FLOOR PLAN

LEGEND		
1.	1	100Ø RWP
2.	2	150Ø RWP
3.		KHURRA

TYPICAL DROP DETAIL-1

TYPICAL DROP DETAIL-2


TYPICAL DROP DETAIL-3

DOMESTIC SUPPLY PIPE

DOMESTIC SUPPLY PIPE

DOMESTIC SUPPLY PIPE

OVERFLOW PIPE

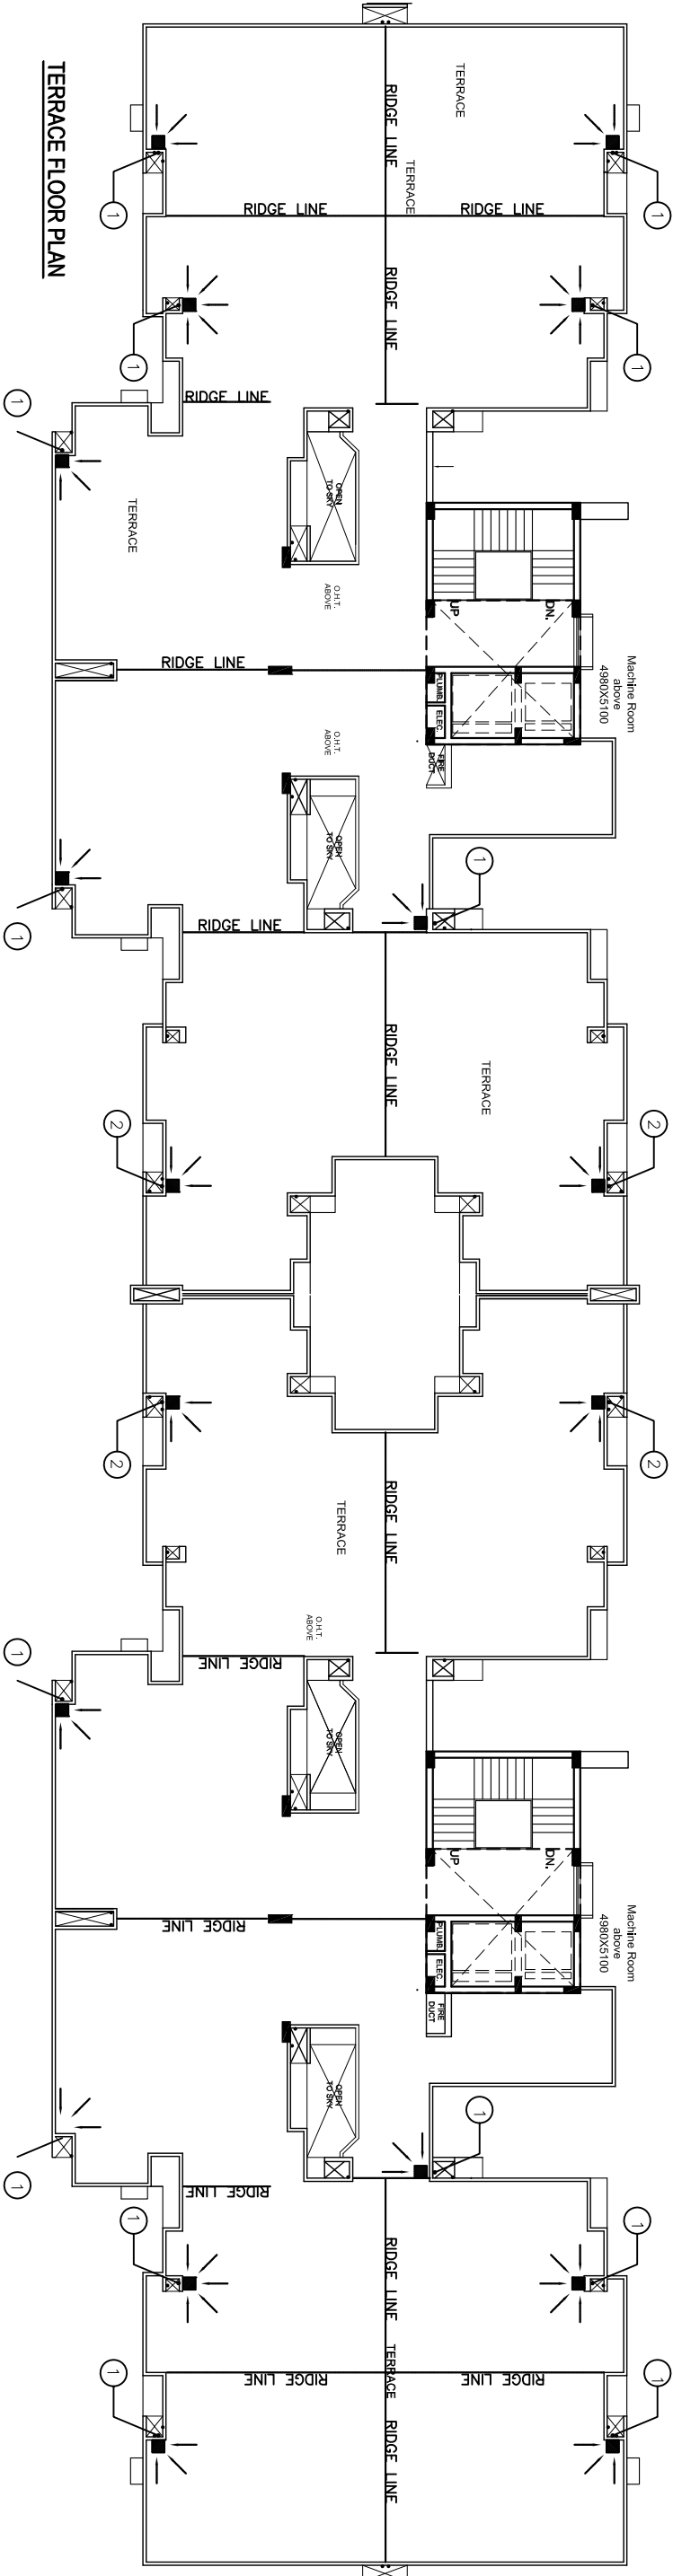

TERRACE FLOOR PLAN

PROPOSED GROUP HOUSING AT PLOT NO. C1, SECTOR O,
MANSAROVAR YOJNA, KANPUR ROAD ,LDA,LUCKNOW

1	25-03-17	OHT Revised	12(a)
Sno.	Date	Description	Dwg no.

TRIVENI CONSULTING ENGINEERS
FLAT NO.-D AVON RESIDENCY
A1/8, SECTOR-H ALIGANJ
LUCKNOW

ORIENTATION

architects
m u r a l i a g e
architects , interior decorators & muralists
B-1/29 , sector - a , aliganj lucknow
phone no. : 2321590.

sayita-rohit ira-sumit namit
Ref No - L-79 -AF-979(1)
Sheet No - 12
Date - 25-03-17
Drawn by - Mohit Jaiswal

SERVICES DRAWING
TERRACE PLUMBING &
RAINWATER PLAN
SCALE - 1:200