



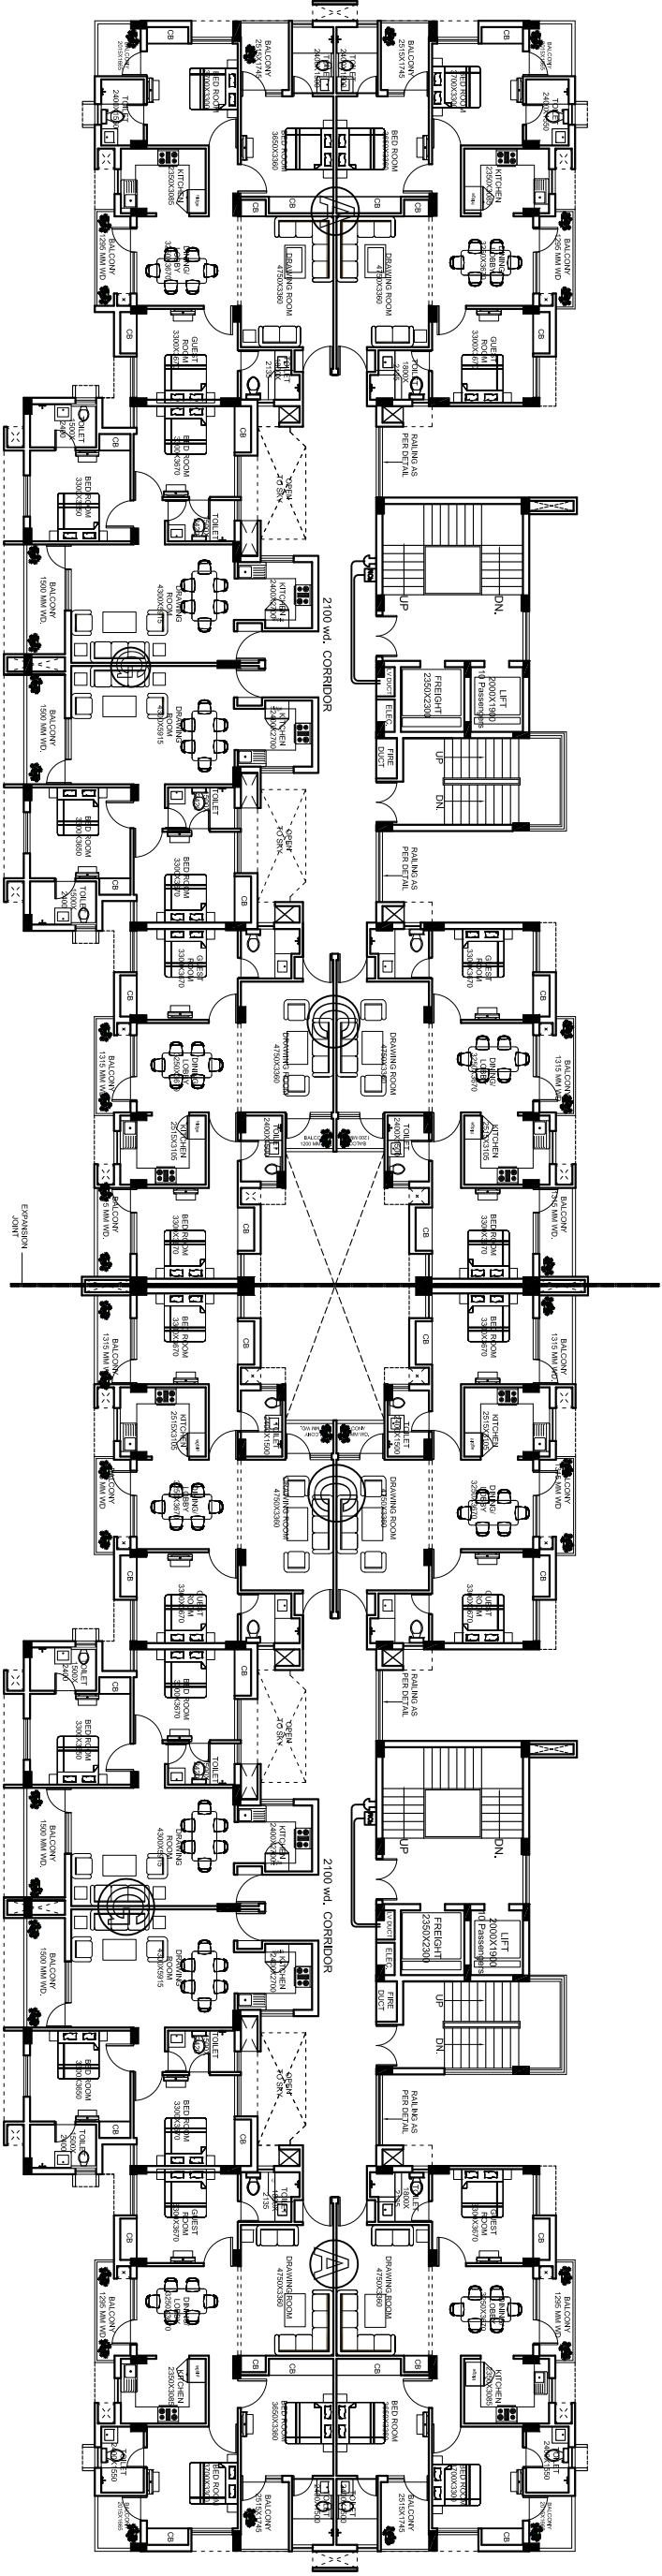

TYPICAL FLOOR FIRE ALARM LAYOUT (1ST TO 6TH FLOOR)

- GENERAL NOTES:-
1. FIRE ALARM CONTROL CABLE SHALL BE 2CX1.5 SQ.MM UNARMORED FRLS OUTER SHEATHED, PVC INSULATED COPPER CONDUCTOR CABLE LAID IN CONCEALED MEDIUM CLASS PVC CONDUIT.
 2. PUBLIC ADDRESS CONTROL CABLE SHALL BE 2CX1.0 SQ.MM UNARMORED FRLS OUTER SHEATHED, PVC INSULATED COPPER CONDUCTOR CABLE LAID IN CONCEALED MEDIUM CLASS PVC CONDUIT.
 3. 20MM Ø MEDIUM CLASS PVC CONDUIT SHALL BE CONCEALED IN SLAB/WALL, FOR FIRE ALARM & PA CABLING IN CONCEALED CONDUIT TYPE. PVC CONDUIT SHALL BE USED WHERE IN FIRE SHAFT VERTICAL RISER AND EXPOSED BELOW CEILING.
 4. THE FIRE ALARM SYSTEM DESIGNED AS PER IS: 2189 – 1999.

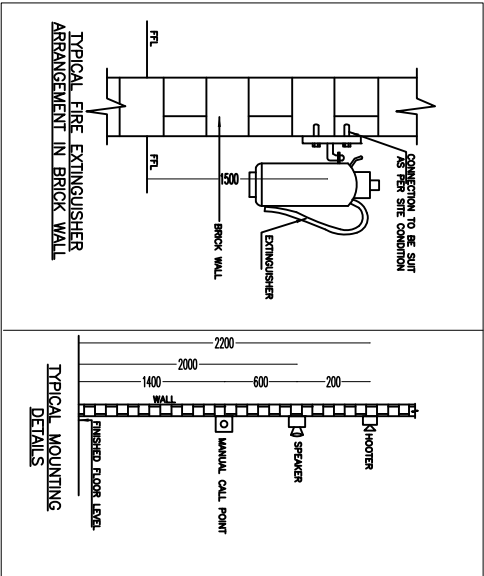

ELECTRICAL LEGEND :-		
S.NO.	SYMBOL	DESCRIPTION
1		MANUAL CALL POINT
2		BURZER

PROPOSED GROUP HOUSING AT PLOT NO. C1,SECTOR O, MANSAROVAR YOJNA, KANPUR ROAD ,LDA, LUCKNOW		BUILDING MEP CONSULTANT TRIVENI CONSULTING ENGINEERS FLAT NO.-D, GF, AVON RESIDENCY A1/8, SEC-H,ALIGANJ, LUCKNOW EMAIL:triveniconsultants.lko@gmail.com PH:5224108651, 09794991199		OWNER		ARCHITECT		ORIENTATION		m u r a l a g e architects , interior decorators & muralists B-1/29 , sector - a , no.. : 2321590, 2320715		Sheet No - 8 Ref No - L-80(AF-979) Date - DEC'16 Drawn By-MOHIT JAISWAL		SERVICES DRAWING TYPICAL FLOOR FIRE ALARM LAYOUT SCALE - 1:100	
---	--	---	--	-------	--	-----------	--	-------------	--	---	--	--	--	--	--