


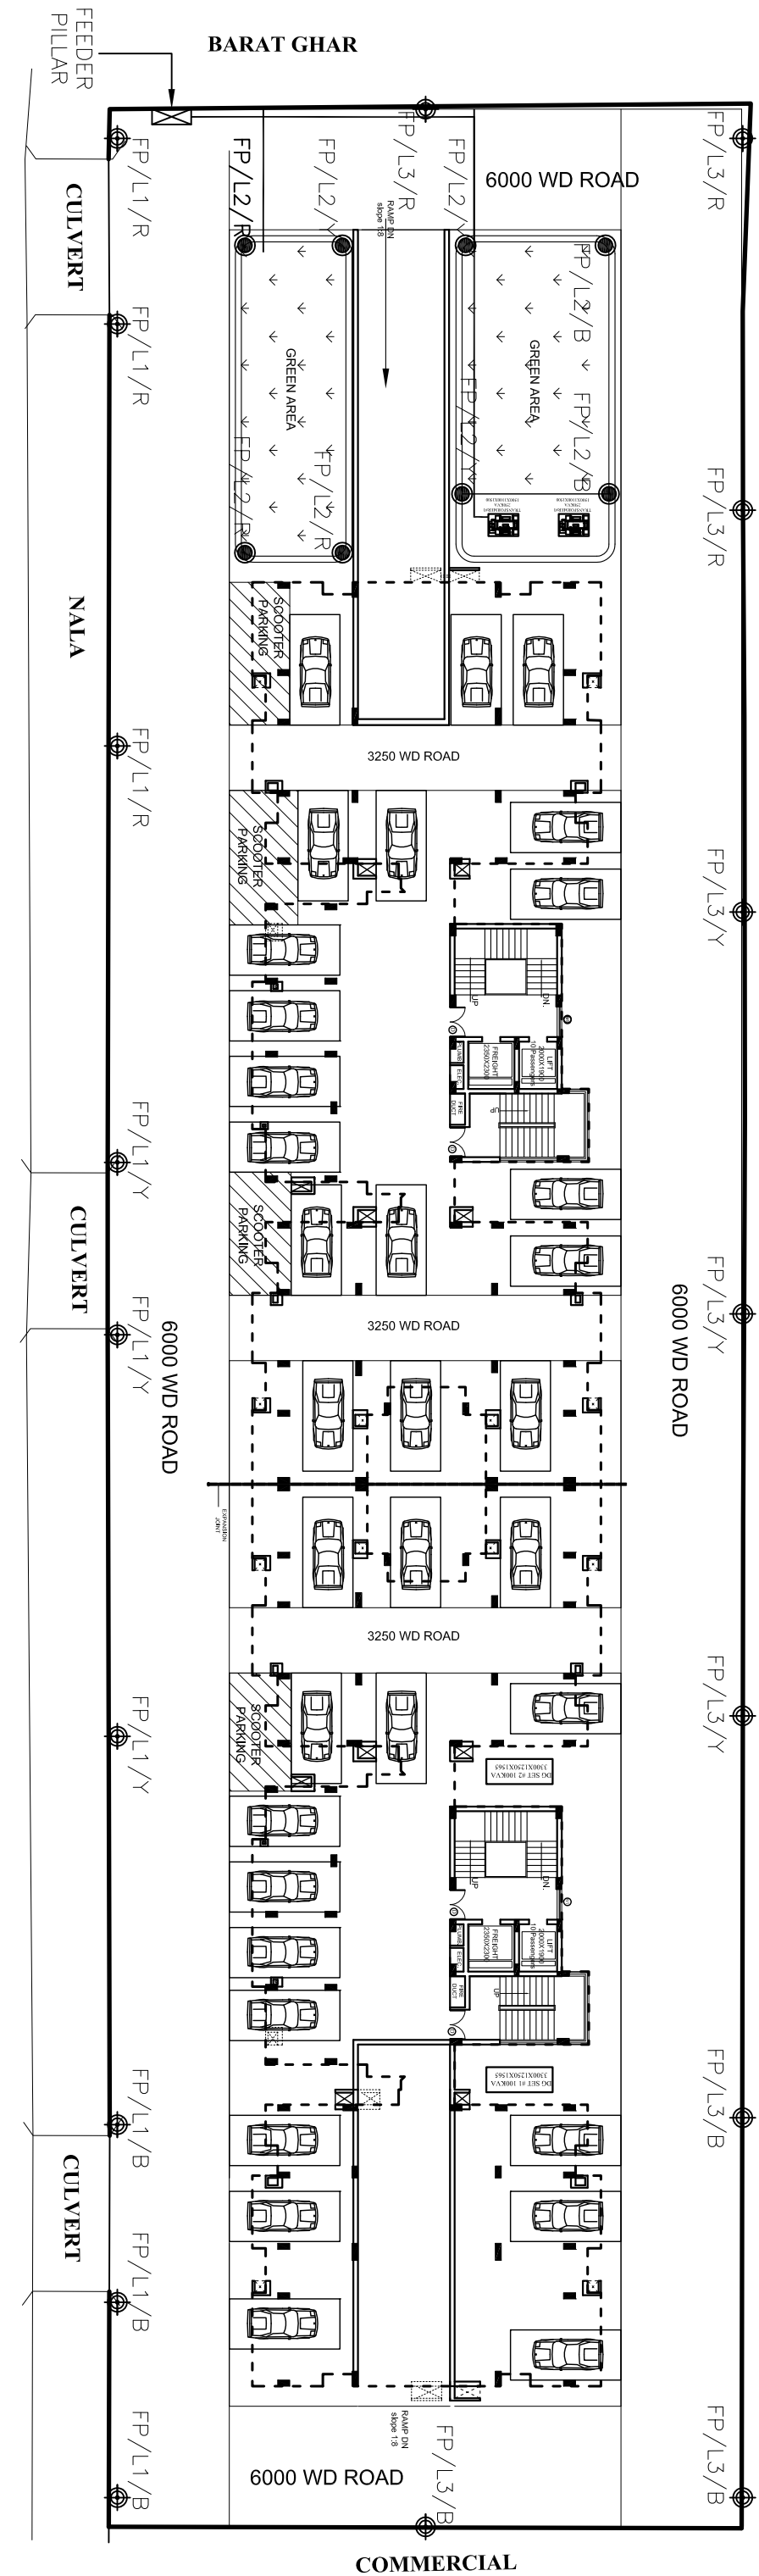

STILT LAYOUT PLAN

ROAD

ELECTRICAL LEGEND :-		
S.NO.	SYMBOL	DESCRIPTION
1		7M SINGLE ARM POLE
2		FEEDER PILLAR
3		3M POST TOP LANTERN
4		100MM DIA ROAD CROSSING

PROPOSED GROUP HOUSING - BHARNEE APARTMENTS
AT PLOT NO. C3,SECTOR O, MANSAROVAR YOJNA,
KANPUR ROAD ,LDA, LUCKNOW

BUILDING MEP CONSULTANT
TRIVENI CONSULTING ENGINEERS
FLAT NO.-D, GF, AVON RESIDENCY
A1/8, SEC.-H, ALIGANJ,
LUCKNOW
EMAIL:triveniconsultants_lko@gmail.com
DH:5224108651, 09794991199

OWNER

ARCHITECT



ira-sum
nam
m u r a l a g e
architects , interior decorators & muralists
A-3/269 , vibhav khand , gomti nagar , lucknow
phone no. : 2980139, 2320715

Sheet No - 2
Ref No - L-80(AF-979)
Date - November'16
Drawn By-MOHIT JAISWAL

ELECTRICAL DRAWING

EXTERNAL ELECTRICAL